


○ KEY NOTES

1. LIGHTING IN ELEVATOR PIT SHOWN ON POWER PLAN SHEET E3.1

GENERAL NOTES


- A. SEE SHEET E2.2 FOR FIXTURE SCHEDULE AND ADDITIONAL INFORMATION.

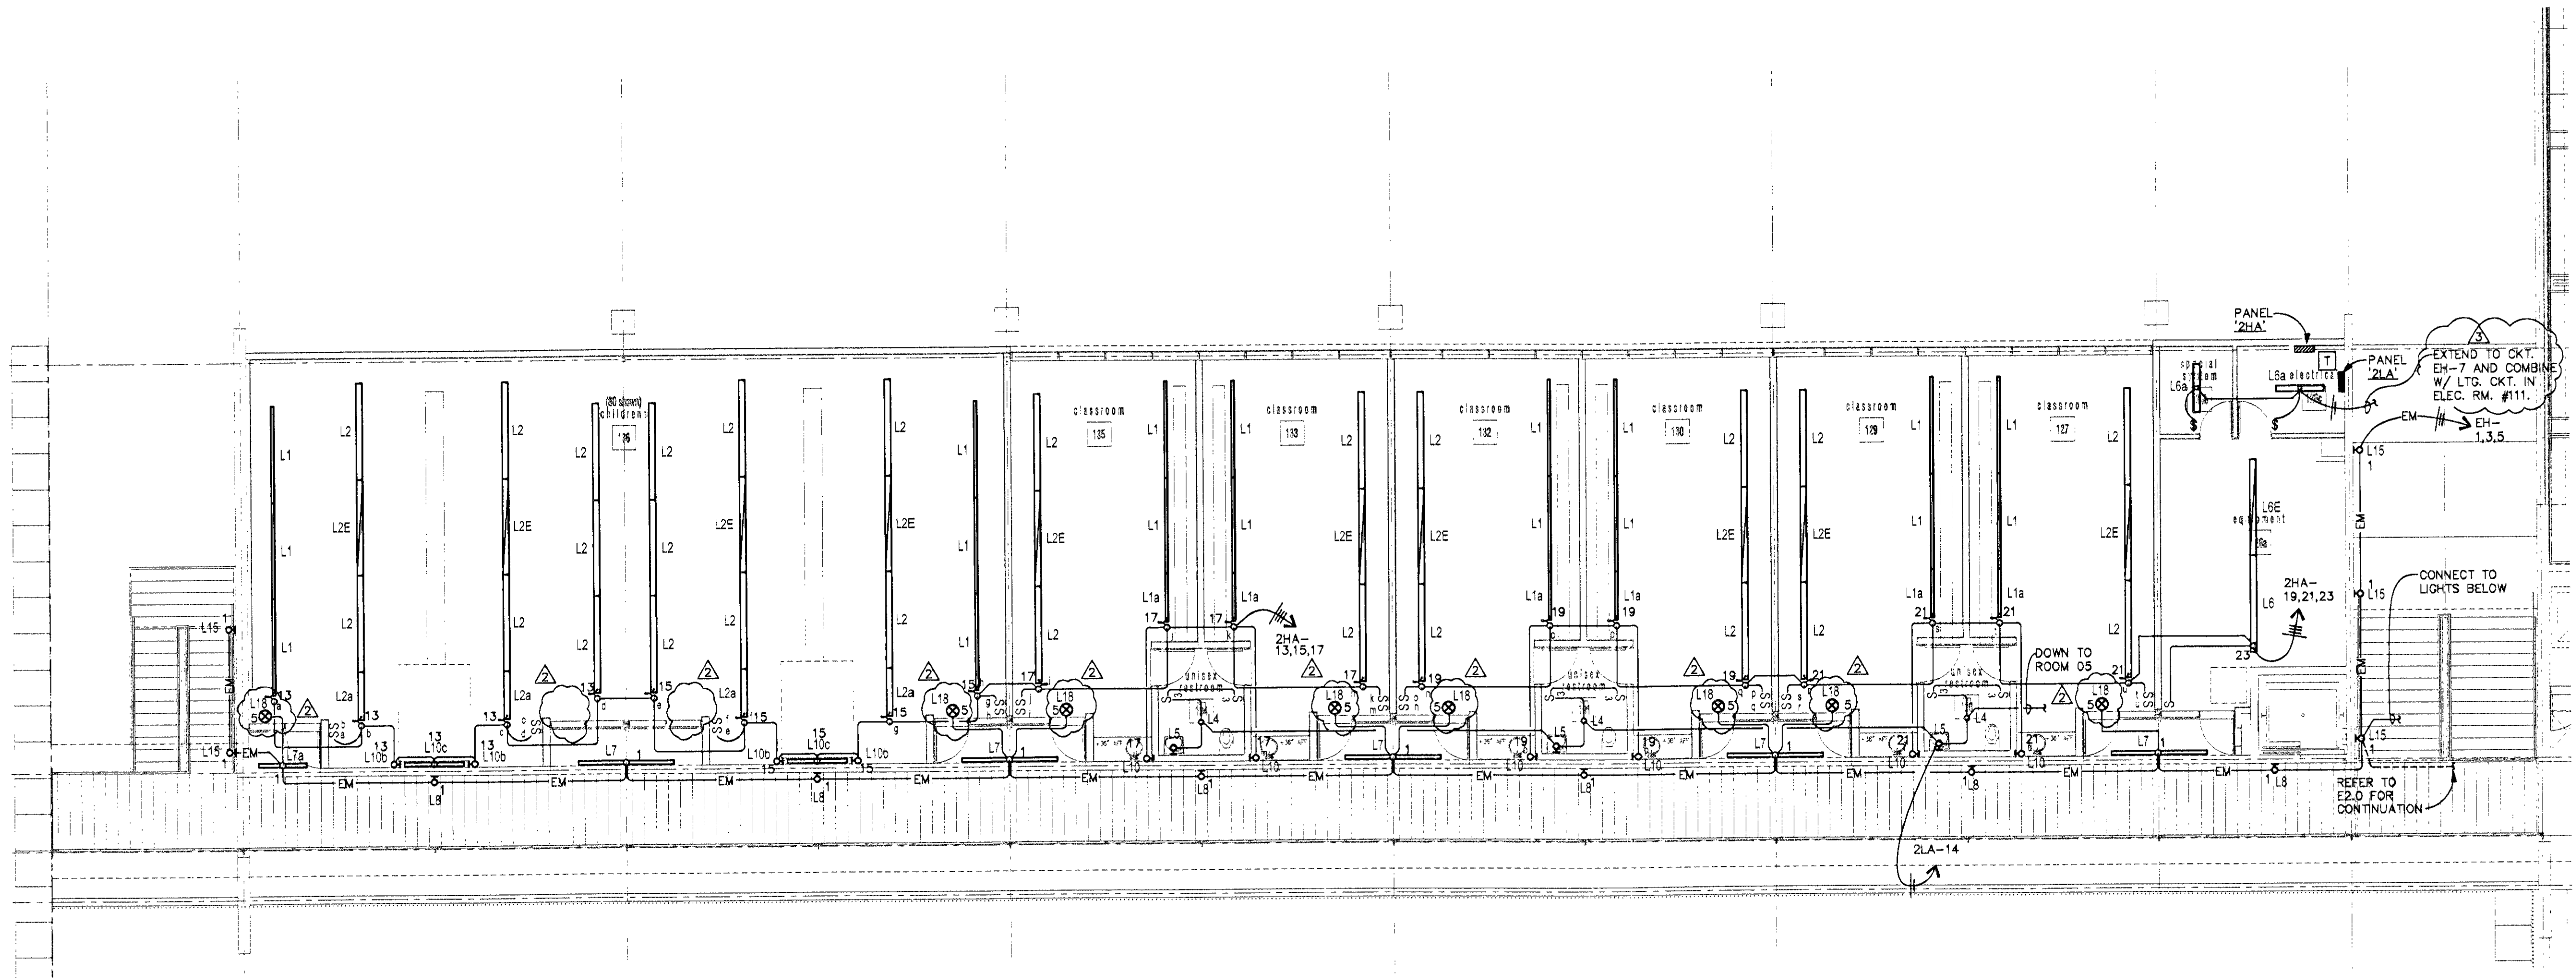

1 main level classroom lighting plan
E2.1 SCALE: 1/8" = 1'-0"

E2.1

classroom lighting plans
1/8" = 1'-0"
scottsdale first assembly
DREAM CENTER
28700 north pima road
scottsdale, arizona
APN: 216-70-008

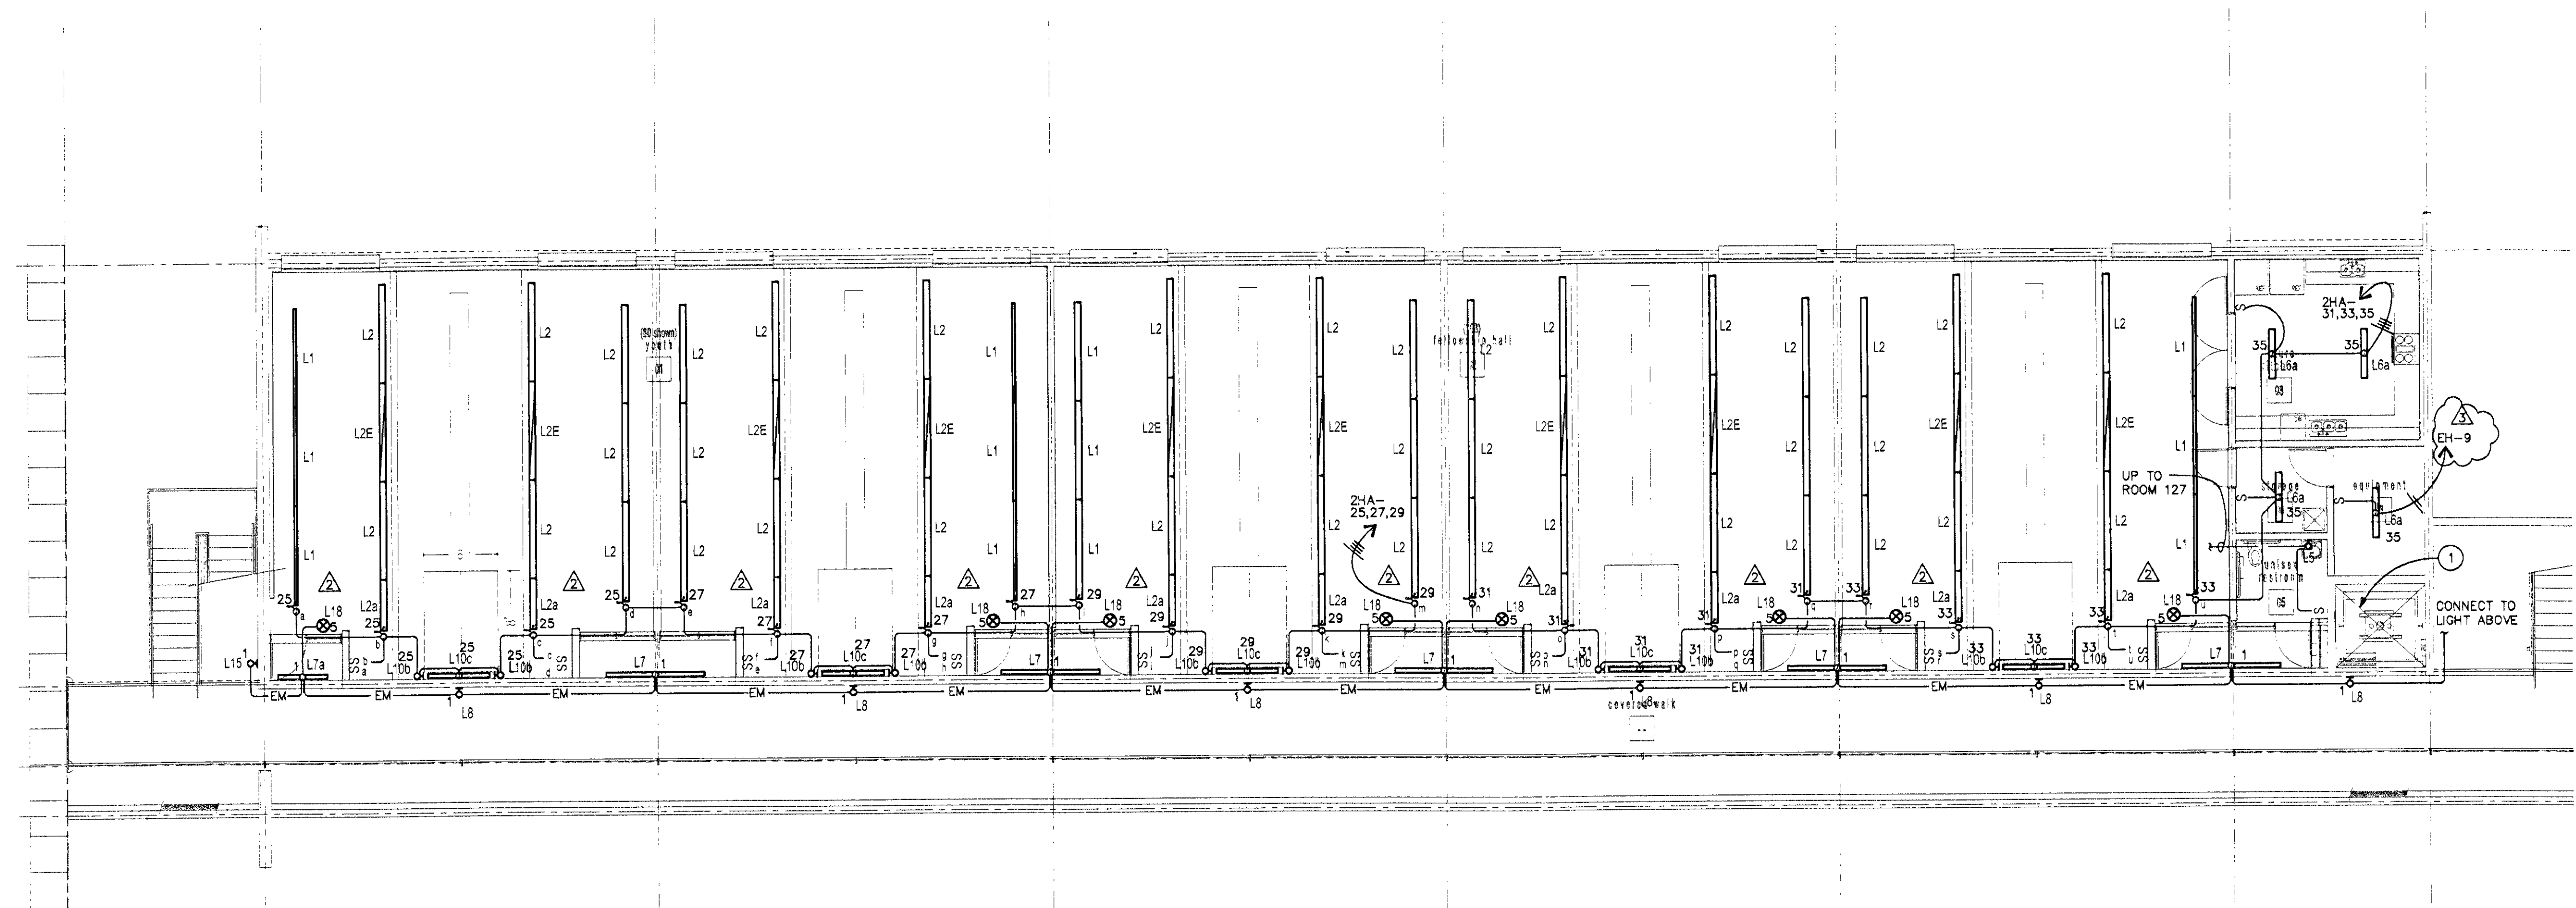

2 lower level classroom lighting plan
E2.1 SCALE: 1/8" = 1'-0"

25 JUNE 2004
© copyright 2004
0142
DeBARTOLO architects
4450 north twelfth street
number 268
phoenix, arizona 85014
tel 602.264.6617
fax 602.264.0891
sullivan designs incorporated
7878 north 16th street
suite 270
phoenix, arizona 85020
tel 602.943.8424
fax 602.943.7931
sdi proj. # 22106

Q.C. REVIEW 9/03/04
CITY COMMENTS 7-07-04

DRB case 4642.01.3
36.DR.2003
plan check