



EXISTING PARKING

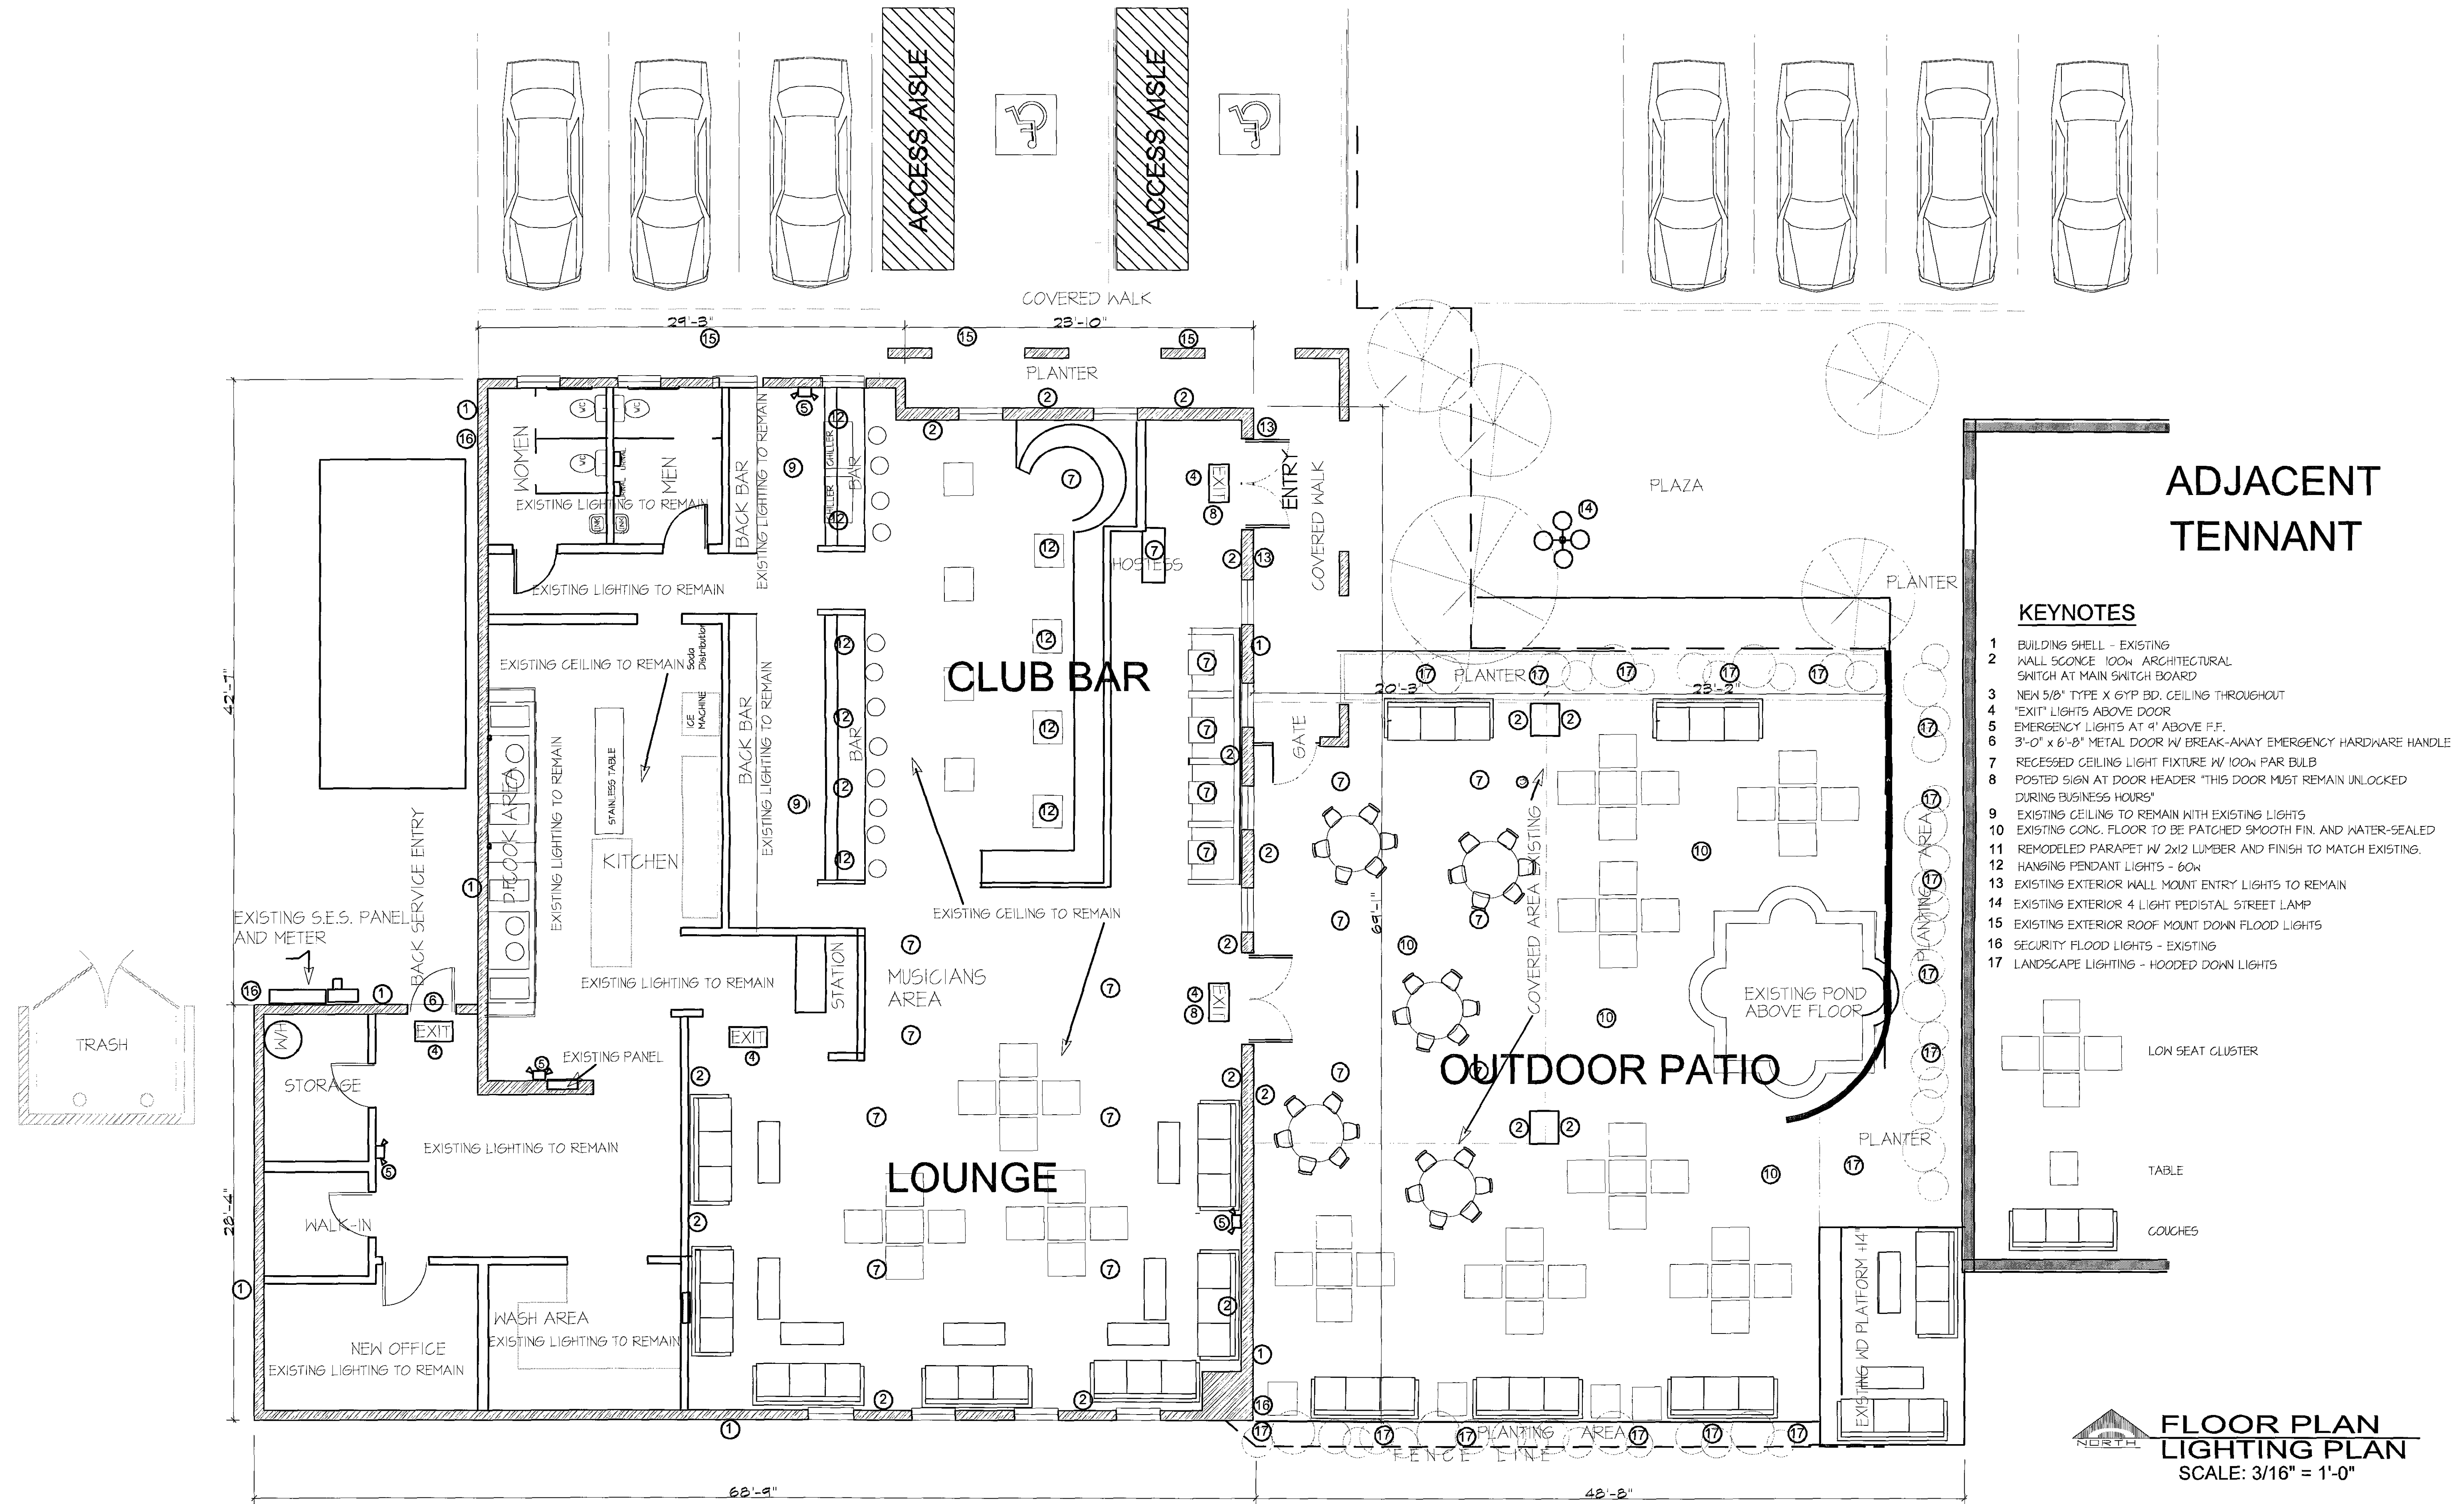

ADJACENT
TENNANT

KEYNOTES

- 1 BUILDING SHELL - EXISTING
- 2 WALL SCONCE 100W ARCHITECTURAL SWITCH AT MAIN SWITCH BOARD
- 3 NEW 5/8" TYPE X 6YP BD. CEILING THROUGHOUT
- 4 "EXIT" LIGHTS ABOVE DOOR
- 5 EMERGENCY LIGHTS AT 9' ABOVE F.F.
- 6 3'-0" X 6'-8" METAL DOOR W/ BREAK-AWAY EMERGENCY HARDWARE HANDLE
- 7 RECESSED CEILING LIGHT FIXTURE W/ 100W PAR BULB
- 8 POSTED SIGN AT DOOR HEADER "THIS DOOR MUST REMAIN UNLOCKED DURING BUSINESS HOURS"
- 9 EXISTING CEILING TO REMAIN WITH EXISTING LIGHTS
- 10 EXISTING CONG. FLOOR TO BE PATCHED SMOOTH FIN. AND WATER-SEALED
- 11 REMODELED PARAPET W/ 2X12 LUMBER AND FINISH TO MATCH EXISTING.
- 12 HANGING PENDANT LIGHTS - 60W
- 13 EXISTING EXTERIOR WALL MOUNT ENTRY LIGHTS TO REMAIN
- 14 EXISTING EXTERIOR 4 LIGHT PEDISTAL STREET LAMP
- 15 EXISTING EXTERIOR ROOF MOUNT DOWN FLOOD LIGHTS
- 16 SECURITY FLOOD LIGHTS - EXISTING
- 17 LANDSCAPE LIGHTING - HOODED DOWN LIGHTS

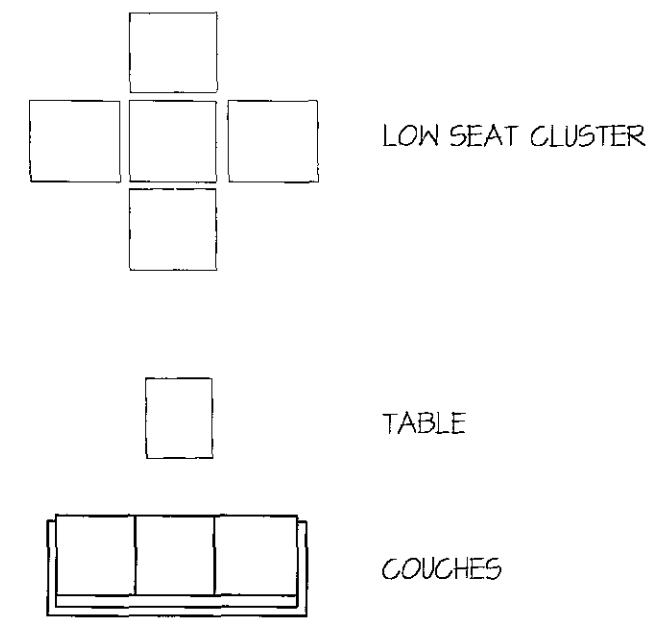

**FLOOR PLAN
LIGHTING PLAN**
SCALE: 3/16" = 1'-0"

CONTRACTOR

ARCHITECTURE ENGINEERING

Peter Owens Designs
Architectural Designs
PH: (480) 422-4864 Mob: (480) 238-4404
1611 E. PLEASANT RUN • SCOTTSDALE, ARIZONA 85253

FOR: LADMAN & ASSOCIATES
SHEA BOULEVARD
SCOTTSDALE, ARIZONA

SCALE: 1-22-06
DATE: -
DRAWN: -
CHK BY: -
JOB NO: -

REVISIONS

1	
2	
3	

A-2

LIGHTING PLAN

S H E A B O U L E V A R D