
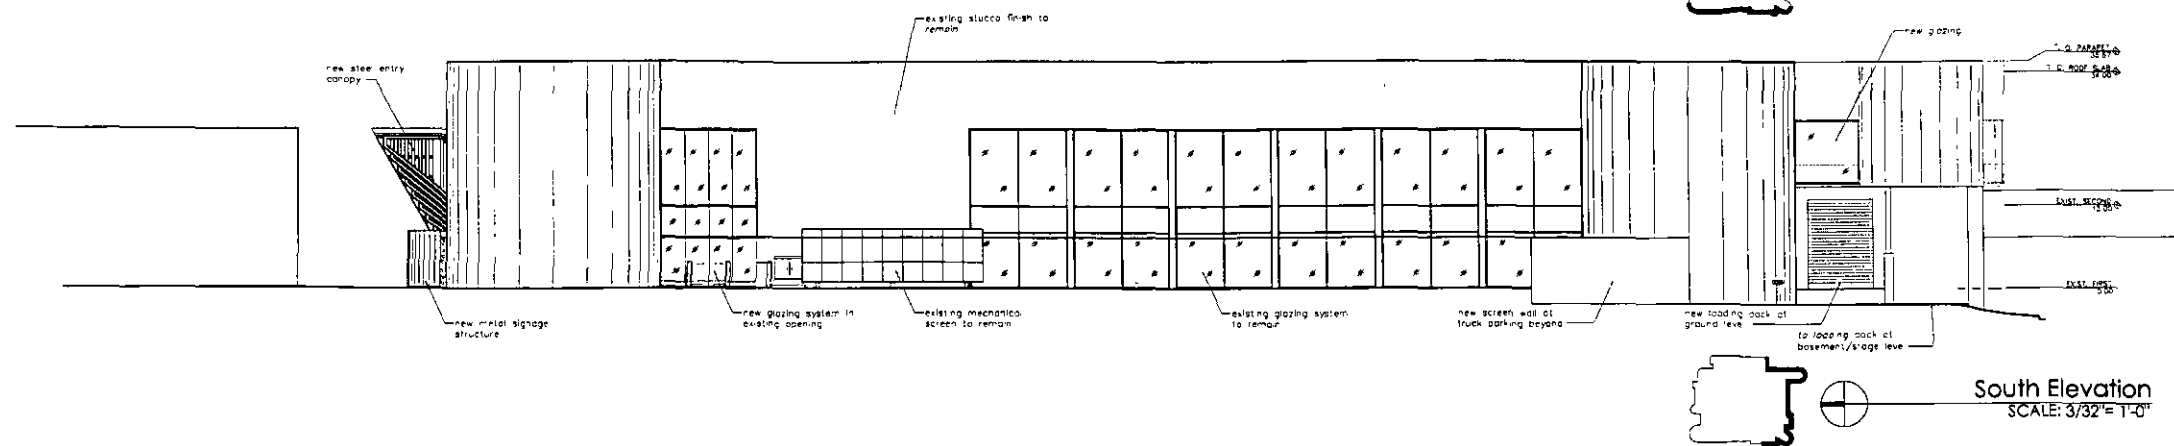
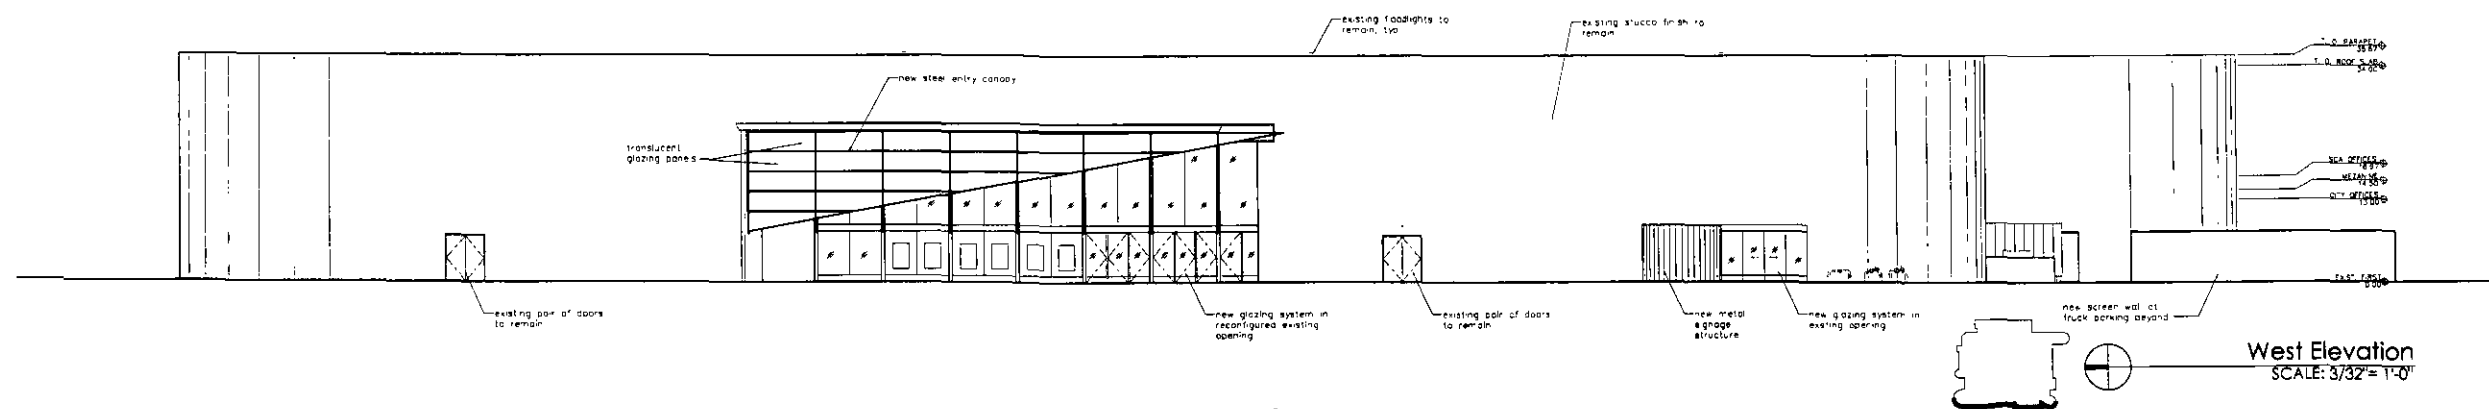
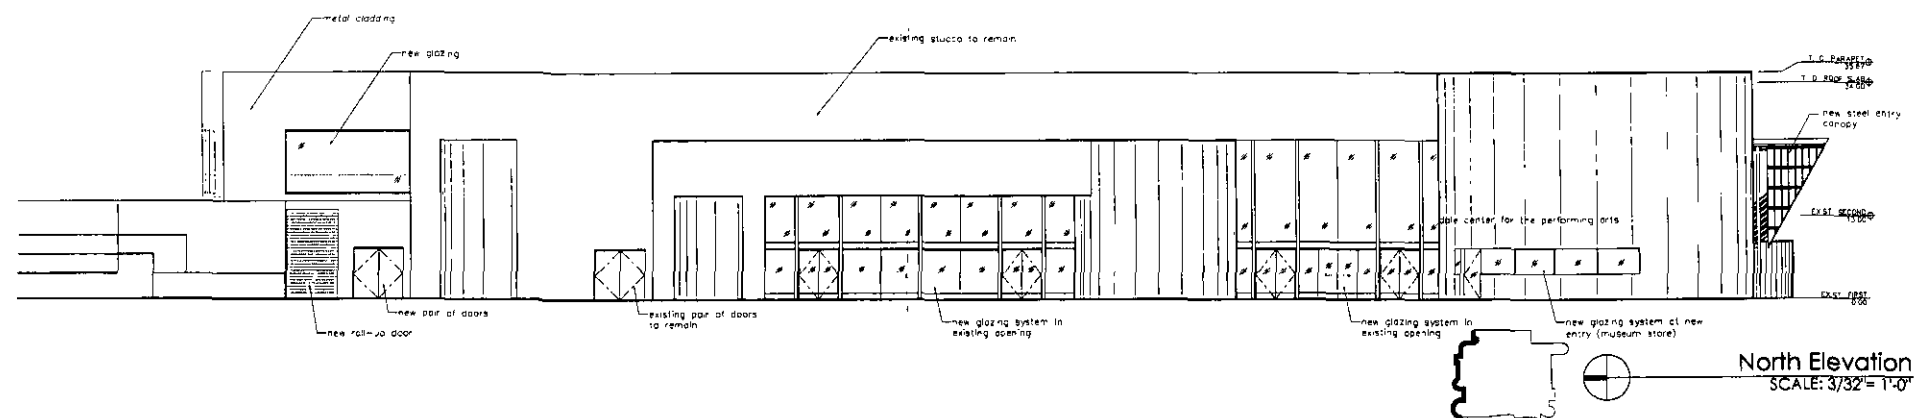


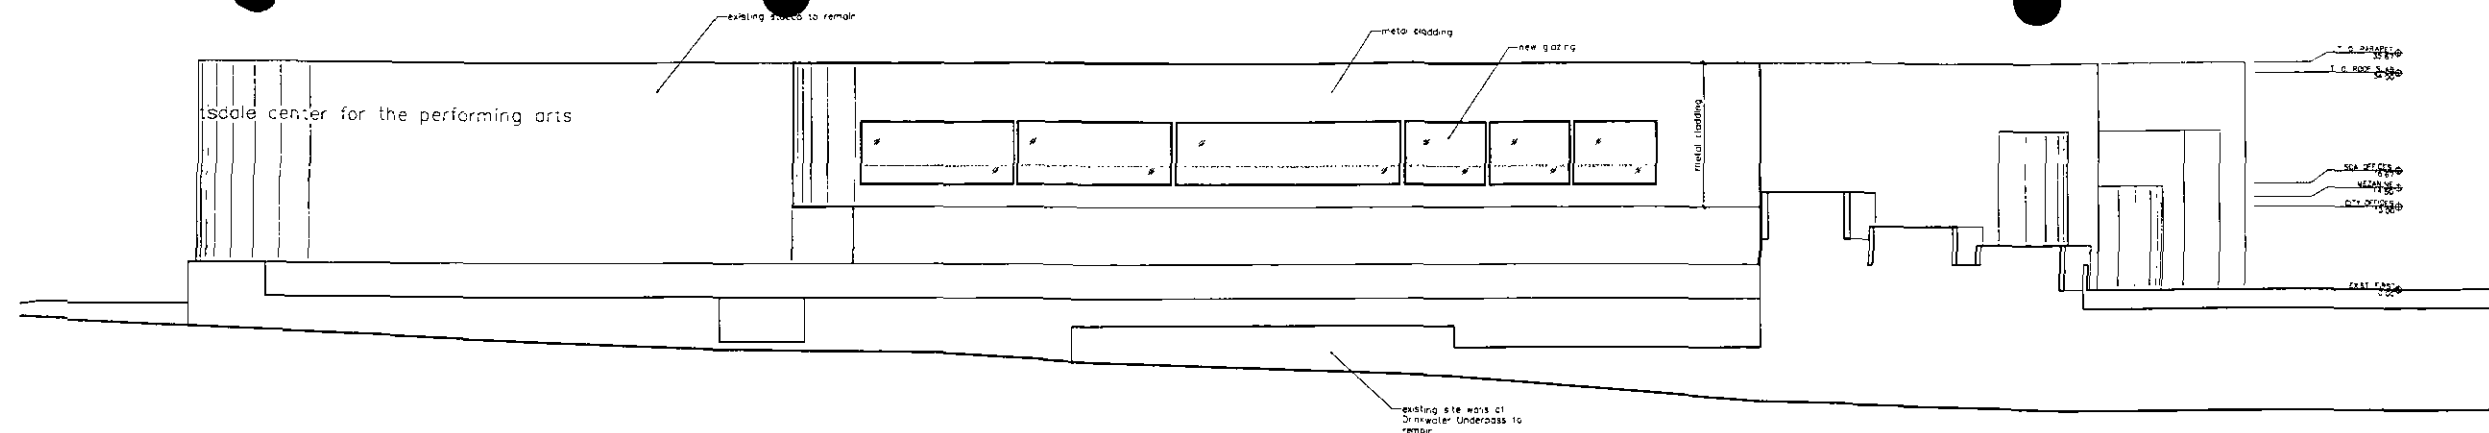

DOUGLAS
Architecture and Planning, P.C.
7522 East McDonald Drive, Scottsdale, Arizona 85250


Project: **Scottsdale Center for the Performing Arts**
Schematic

Sheet Content: **Exterior Elevations**

Job No.: 0304

Date: 10/7/06

Stamp: **A-510**
Sheet No.:

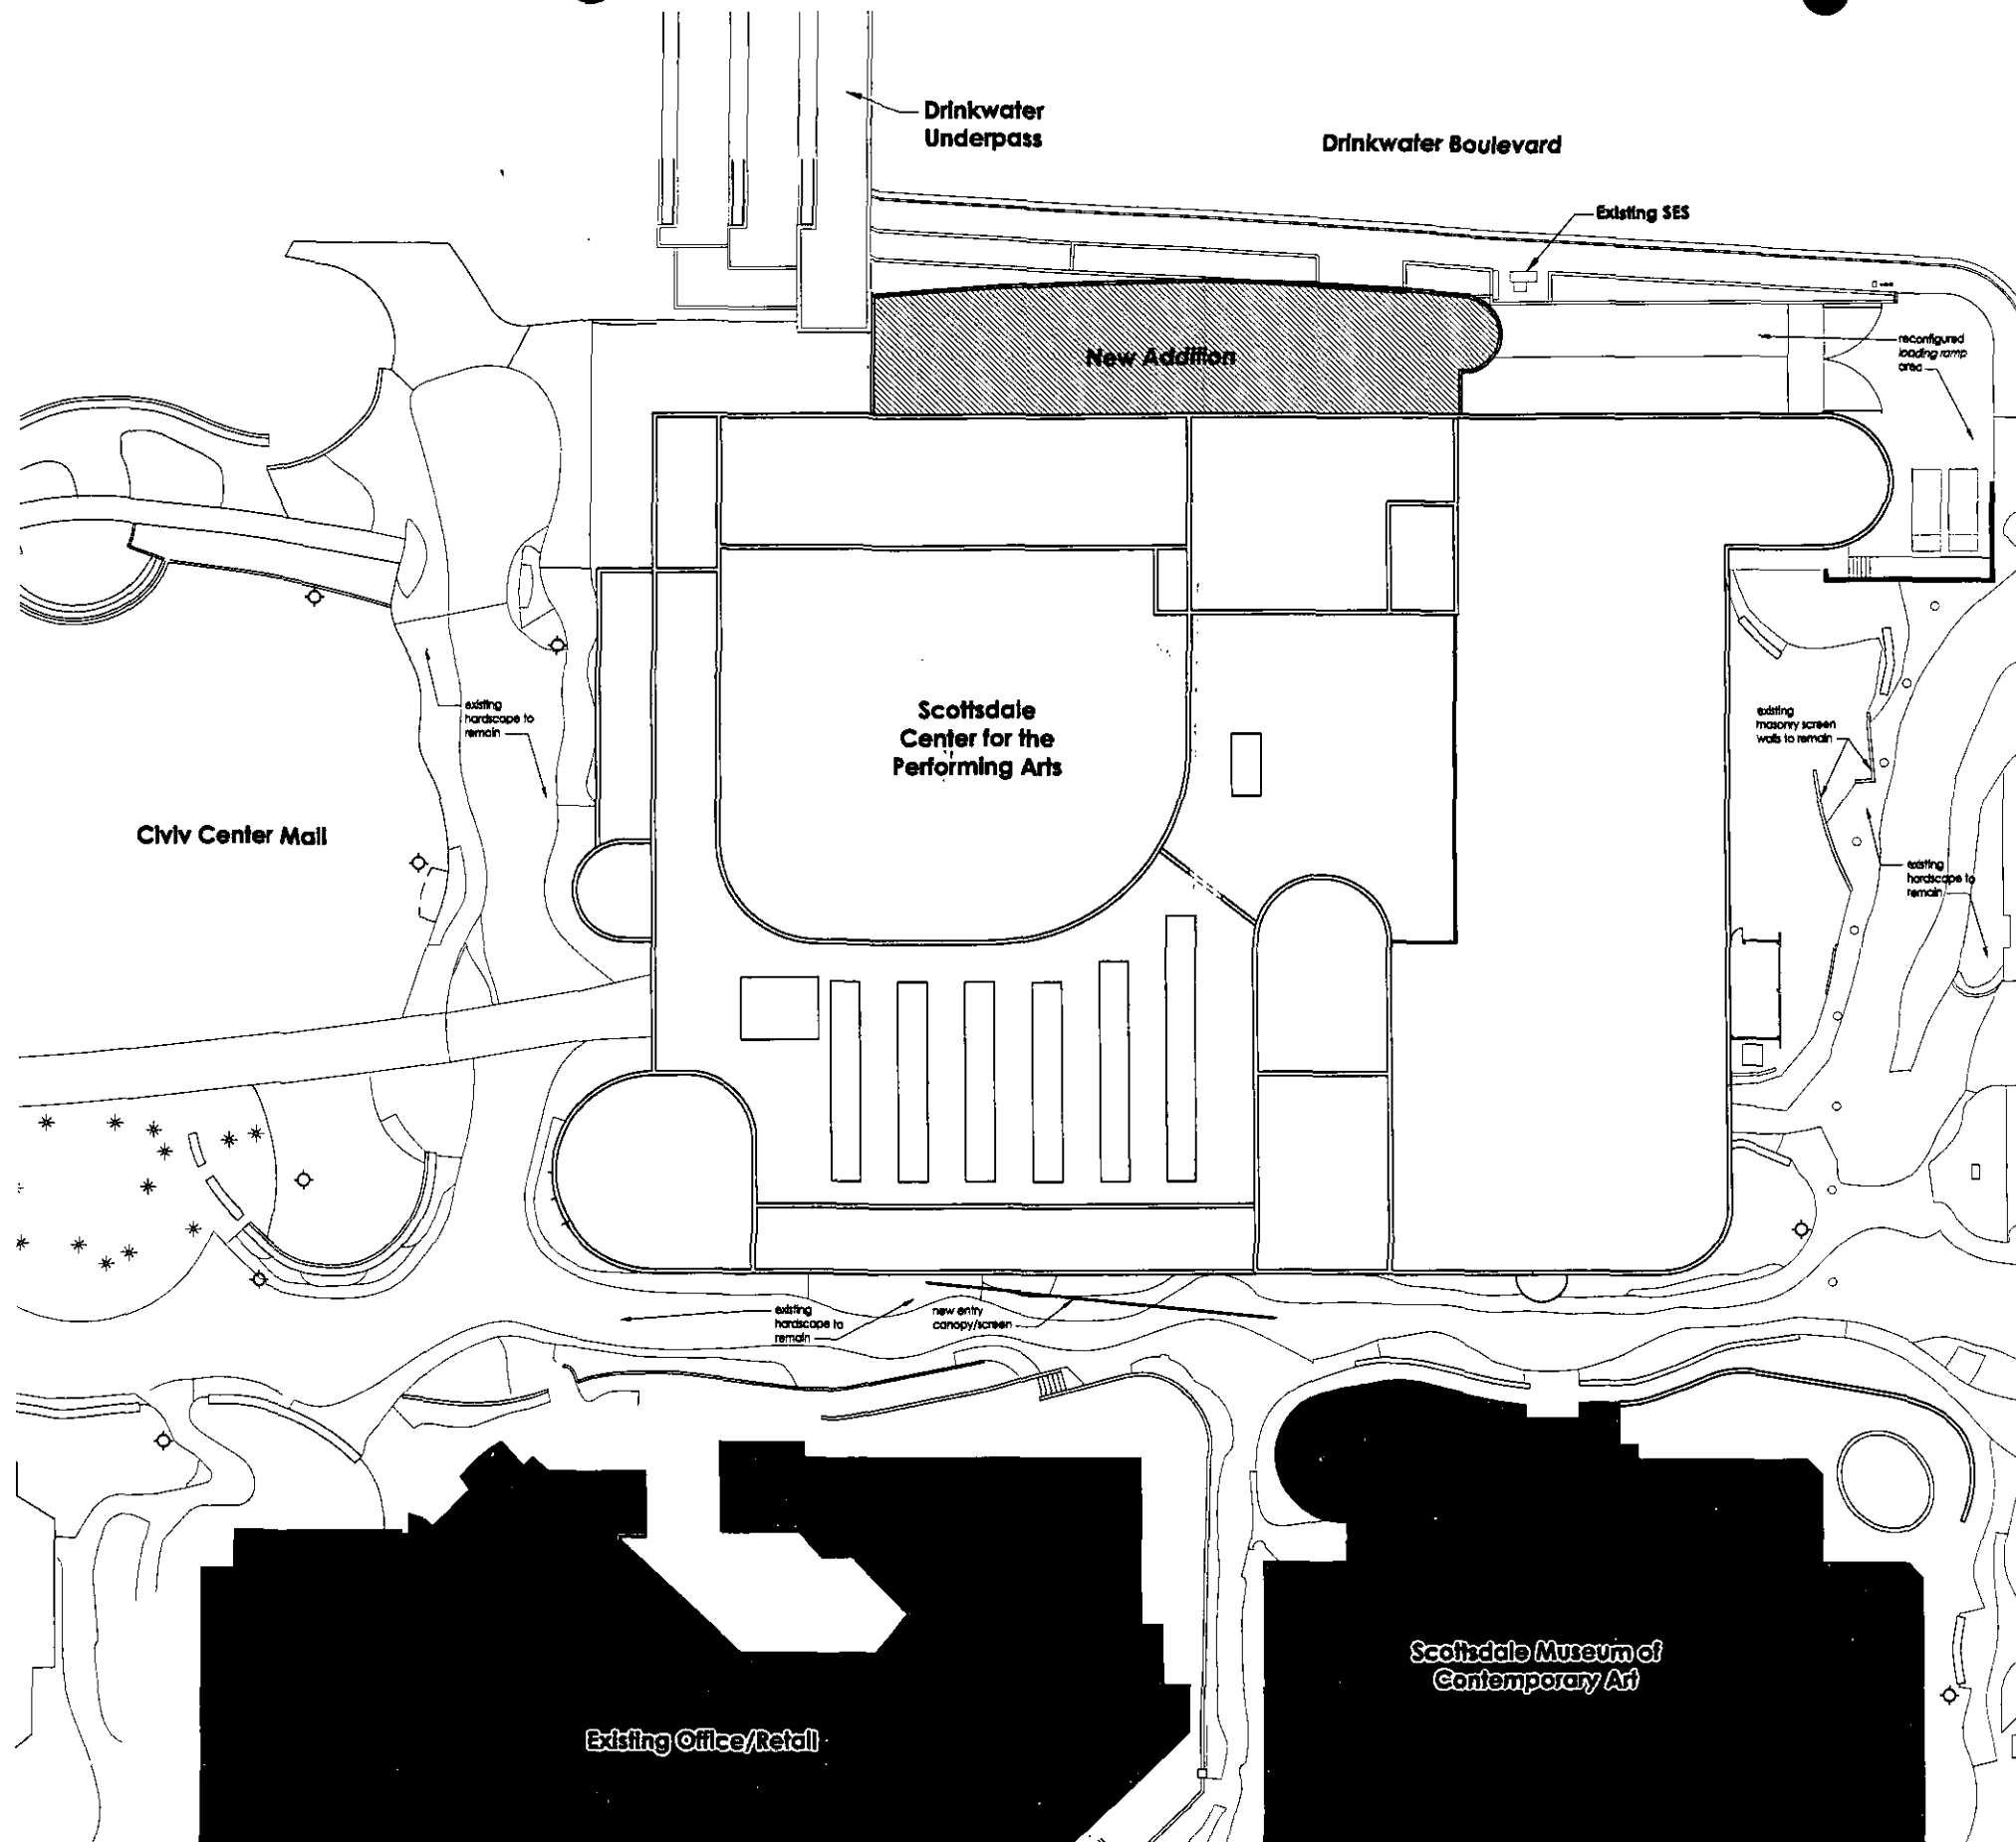

Second Street

DOUGLAS
Architecture and Planning, P.C.
7522 East McDonald Drive, Scottsdale, Arizona 85250

Project: **Scottsdale Center for the Performing Arts**
SCHEMATIC

Sheet Content: **Site Plan**
Job No.: 0804
Date: 10.7.05

Proposed Site Plan
SCALE: 1/16" = 1'-0"

Sheet No.: **A-200**

EXTERIOR ELEVATIONS 1. DIFFERENCE LIGHTING PLAN KEYNOTES

- 1 PAINT
 - * EXISTING TBC
 - * MANUFACTURER MATCH EXISTING
 - * MODEL NUMBER MATCH EXISTING
 - * FINISH MATCH EXISTING
 - * COLOR PAINT TBC

- 2 STUCCO
 - * MANUFACTURER
 - * MODEL NUMBER
 - * FINISH MATCH EXISTING
 - * COLOR PAINT TBC

- 3 MASONRY
 - * FINISH AT EXISTING OPENING
 - * MANUFACTURER
 - * MODEL NUMBER
 - * FINISH MATCH EXISTING
 - * COLOR PAINT TBC



- 4 DOORS
 - * AT NEW OPENING
 - * MANUFACTURER
 - * MODEL NUMBER
 - * MATERIAL STAINLESS STEEL
 - * FINISH RAUGHED
 - * HARDWARE STAINLESS STEEL

- 5 DOORS
 - * AT EXISTING OPENING
 - * MANUFACTURER
 - * MODEL NUMBER
 - * MATERIAL STAINLESS STEEL
 - * FINISH RAUGHED
 - * HARDWARE STAINLESS STEEL

- 6 WINDOWS TYPE 1
 - * MANUFACTURER
 - * MODEL NUMBER
 - * MATERIAL STAINLESS STEEL
 - * FINISH RAUGHED
 - * HARDWARE STAINLESS STEEL

EXTERIOR ELEVATIONS DEMOLITION SEE DEMOLITION PLANS KEYNOTES

- D1 REMOVE LIGHTING
 - * REMOVE + SALVAGE PER DIRECTION OF COG

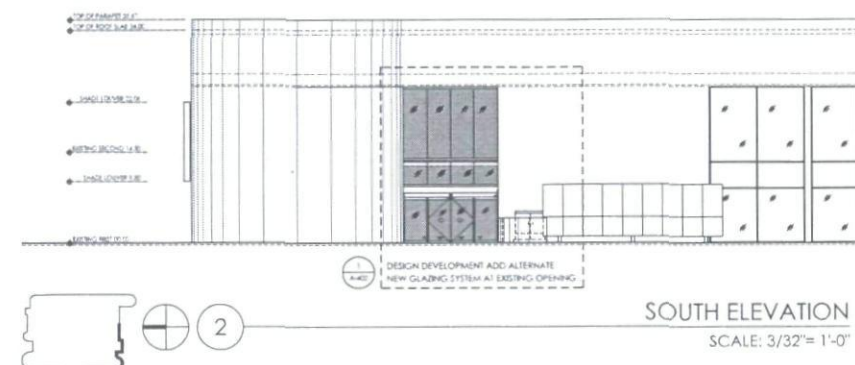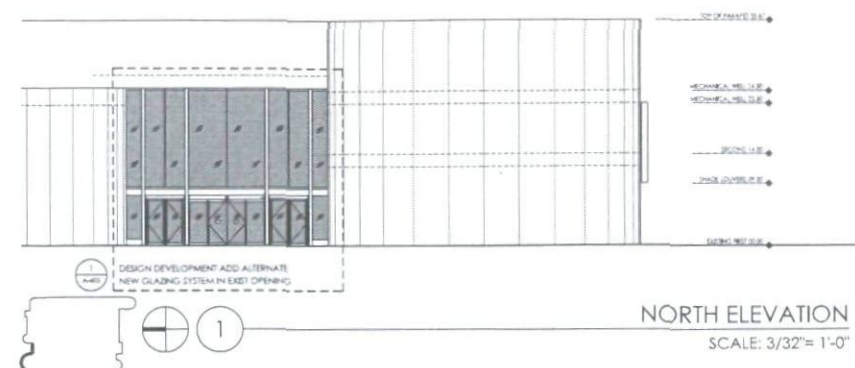

Handwritten signature: D. Staff
 APPROVED
 3-20-08

DOUGLAS
 Architecture and Planning, P.C.
 7522 East McDowell Drive, Scottsdale, Arizona 85250


Project: **Scottsdale Center for the Performing Arts**

DESIGN DEVELOPMENT PHASE 1
 NOT FOR CONSTRUCTION
 ELEVATIONS


Sheet Content: _____
 Job No: 0304
 Date: 02.11.08

Stamp: _____
 Street No: **A-400**


5-DR-2006
 4th: 2/28/08

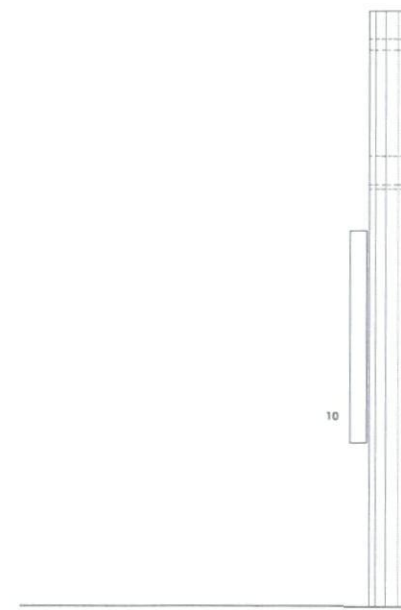


SOUTH - CANOPY ELEVATION
SCALE: 1/4"= 1'-0"

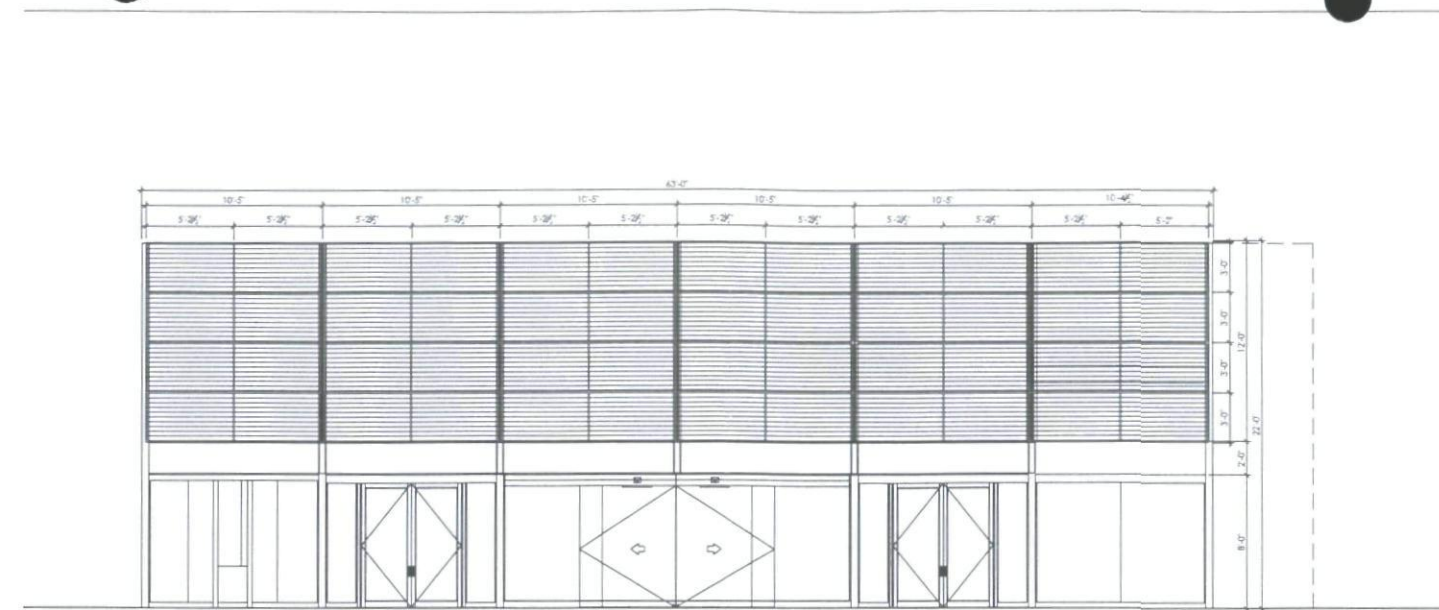

WEST - CANOPY ELEVATION
SCALE: 1/4"= 1'-0"

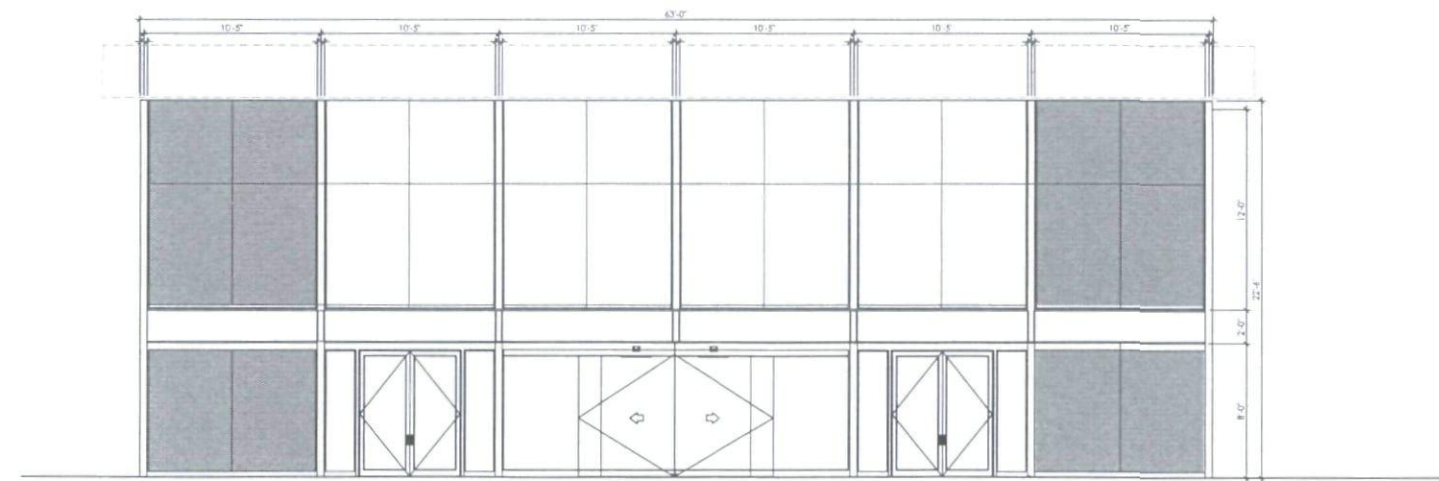

NORTH CANOPY ELEVATION
SCALE: 1/4"= 1'-0"

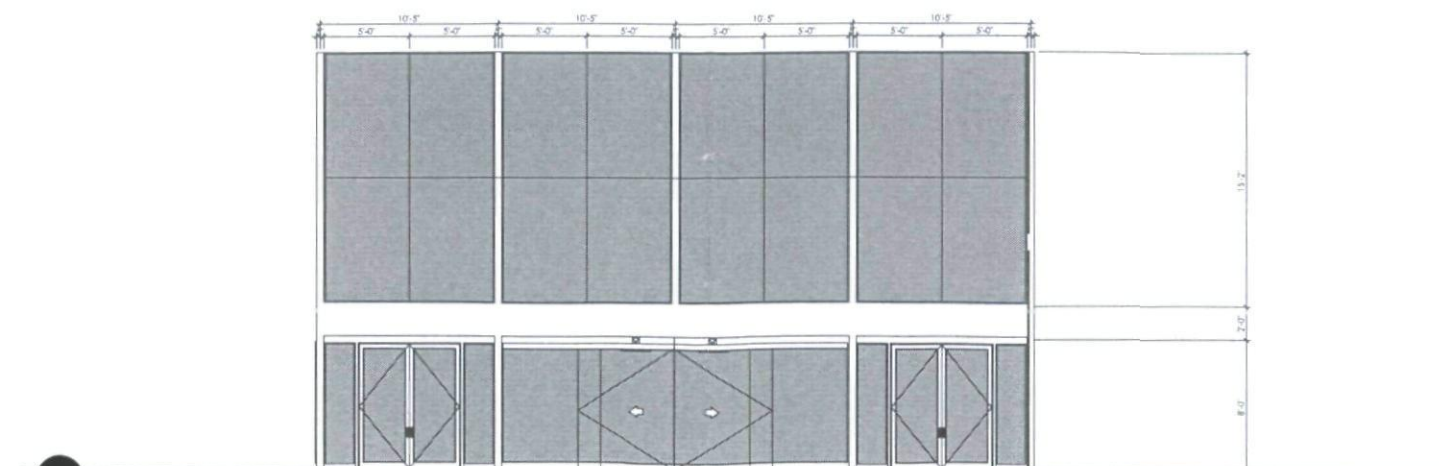

5-DR-2006
4th: 2/28/08

EXTERIOR ENLARGED ELEVATIONS 1. REFERENCE: LAYOUT PLAN KEYNOTES

- NOT USED x
- NOT USED x
- GLASS PANEL SYSTEM 2
 - MANUFACTURER: TBD
 - MODEL NUMBER: TBD
 - DUAL PANE INSULATED GLASS
 - COLOR: CLEAR
 - CONNECTORS: TBD
 - FINISH: TBD
 - NOTE: CURVED LAMINATED PANELS AT TICKET WINDOW WITH 20' DISPLAY BEYOND
- GLASS PANEL SYSTEM 2
 - MANUFACTURER: TBD
 - MODEL NUMBER: TBD
 - DUAL PANE INSULATED GLASS
 - COLOR: TRANSLUCENT
 - CONNECTORS: TBD
 - FINISH: TBD
 - NOTE: CURVED LAMINATED PANELS AT TICKET WINDOW WITH 20' DISPLAY BEYOND
- DOORS
 - MANUAL
 - MANUFACTURER
 - MODEL NUMBER
 - MATERIAL: GLASS + STAINLESS STEEL
 - FINISH: CLEAR + BRUSHED
 - HARDWARE: TBD STAINLESS STEEL BRUSHED
- DOORS
 - AUTOMATIC / ADA COMPLIANT
 - MANUFACTURER
 - MODEL NUMBER
 - MATERIAL: GLASS + STAINLESS STEEL
 - FINISH: CLEAR + BRUSHED
 - HARDWARE: TBD OPERATORS + ACTUATORS
 - SIGNAGE: TBD
- NOT USED x
- STEEL STRUCTURE
 - SEE STRUCTURAL
 - MATERIAL: STEEL
 - FINISH: FULL WELD + GROUND SMOOTH + PAINT
 - COLOR: TBD
- STEEL STRUCTURAL DECK
 - SEE STRUCTURAL
 - MATERIAL: STEEL
 - FINISH: PAINT
 - COLOR: TBD
- SUN CONTROL
 - STEEL FRAME + FRIB + COVER
 - MATERIAL: STEEL
 - FINISH: PAINT
 - COLOR: TBD
- TICKET WINDOW ASSEMBLY
 - MANUFACTURER: C & LAURENCE
 - MODEL: FAN SCW-122
 - MATERIAL: STAINLESS STEEL
 - FINISH: BRUSHED
 - COLOR: CLEAR
- TICKET WINDOW SURROUND
 - MATERIAL: STAINLESS STEEL
 - FINISH: BRUSHED
 - COLOR: CLEAR
- NOT USED x
- NOT USED x
- MARQUEE SYSTEM (FUTURE)
 - EXTERIOR MOUNTED ELECTRONIC / DIGITAL
 - MANUFACTURER: TBD
 - MODEL: TBD
 - MATERIAL: TBD
 - FINISH: TBD
 - COLOR: TBD
- MARQUEE SYSTEM
 - INTERIOR MOUNTED BEHIND CURVED GLASS PANELS
 - 2 DIMENSIONAL DISPLAY
 - MANUFACTURER: TBD
 - MODEL: TBD
 - MATERIAL: TBD
 - FINISH: TBD
 - COLOR: TBD

DOUGLAS
ARCHITECTURE AND PLANNING, P.C.
7522 East McDONALD DRIVE, SCOTTSDALE, ARIZONA 85250

Project: **Scottsdale Center for the Performing Arts**


DESIGN DEVELOPMENT PHASE 1
NOT FOR CONSTRUCTION

Sheet Content: **ELEVATION ENLARGED WEST**

Job No: CS04

Date: 02.11.08

Stamp: **A-401**

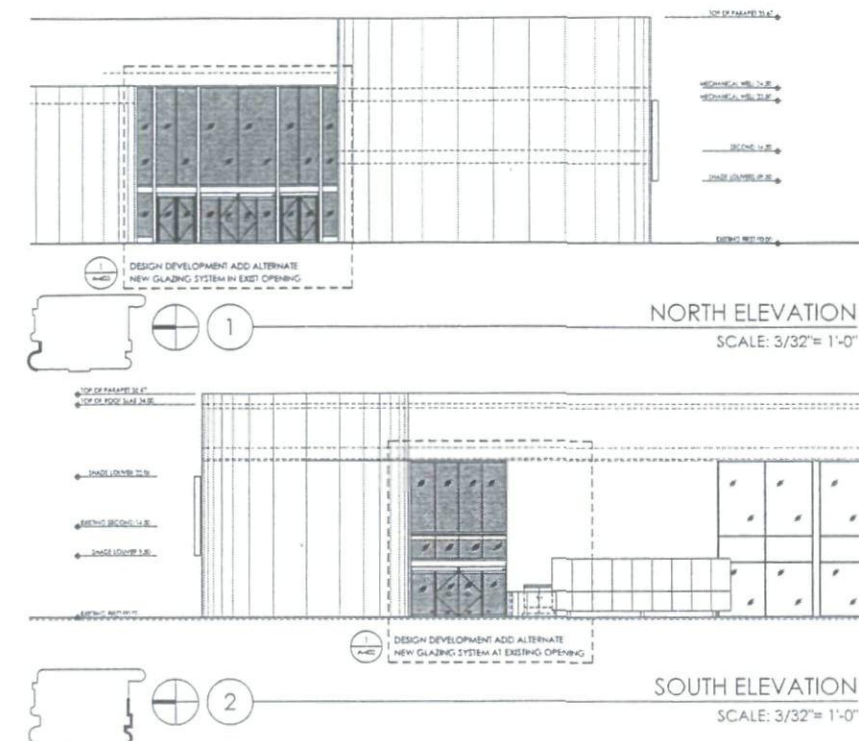

EXTERIOR ELEVATIONS 1.1 REFERENCE LIGHTING PLAN KEYNOTES

- PAINT**
 - EXTERIOR
 - MANUFACTURER: MATCH EXISTING
 - MODEL NUMBER: MATCH EXISTING
 - FINISH: MATCH EXISTING
 - COLOR: PAINT: TRG
- STUCCO**
 - MANUFACTURER
 - MODEL NUMBER
 - FINISH: MATCH EXISTING
 - COLOR: PAINT: TRG
- MASONRY**
 - SMALL AT EXISTING OPENING
 - MANUFACTURER
 - MODEL NUMBER
 - FINISH: MATCH EXISTING
 - COLOR: PAINT: TRG
- DOORS**
 - AT NEW OPENING
 - MANUFACTURER
 - MODEL NUMBER
 - MATERIAL: STAINLESS STEEL
 - FINISH: BRUSHED
 - HARDWARE: STAINLESS STEEL
- DOORS**
 - AT EXISTING OPENING
 - MANUFACTURER
 - MODEL NUMBER
 - MATERIAL: STAINLESS STEEL
 - FINISH: BRUSHED
 - HARDWARE: STAINLESS STEEL
- WINDOWS TYPE 1**
 - MANUFACTURER
 - MODEL NUMBER
 - MATERIAL: STAINLESS STEEL
 - FINISH: BRUSHED
 - HARDWARE: STAINLESS STEEL

EXTERIOR ELEVATIONS DEMOLITION SEE DEMOLITION PLANS KEYNOTES

- REMOVE LIGHTING**
 - REMOVE - SALVAGE PER DIRECTION OF CDD



Dasch
APPROVED
3.20.08
SITE INITIALS

DOUGLAS

Architecture and Planning, P.C.
7522 East McDowell Drive, Scottsdale, Arizona 85260

Project: Scottsdale Center for the Performing Arts

DESIGN DEVELOPMENT PHASE 1
NOT FOR CONSTRUCTION
ELEVATIONS

Sheet Content

Job No.


Date:

02.11.08


Stamp:
Sheet No.

A-400


5-DR-2006
4th: 2/28/08

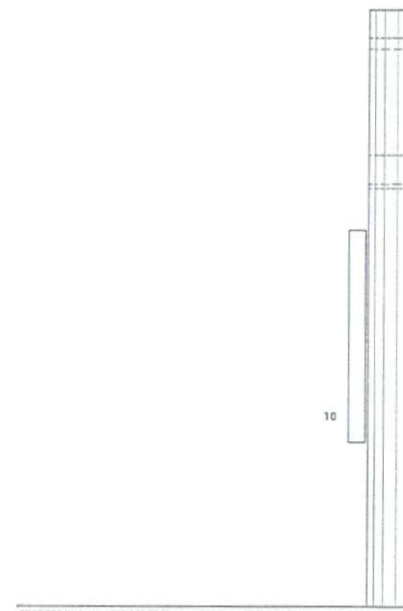


SOUTH - CANOPY ELEVATION
SCALE: 1/4" = 1'-0"

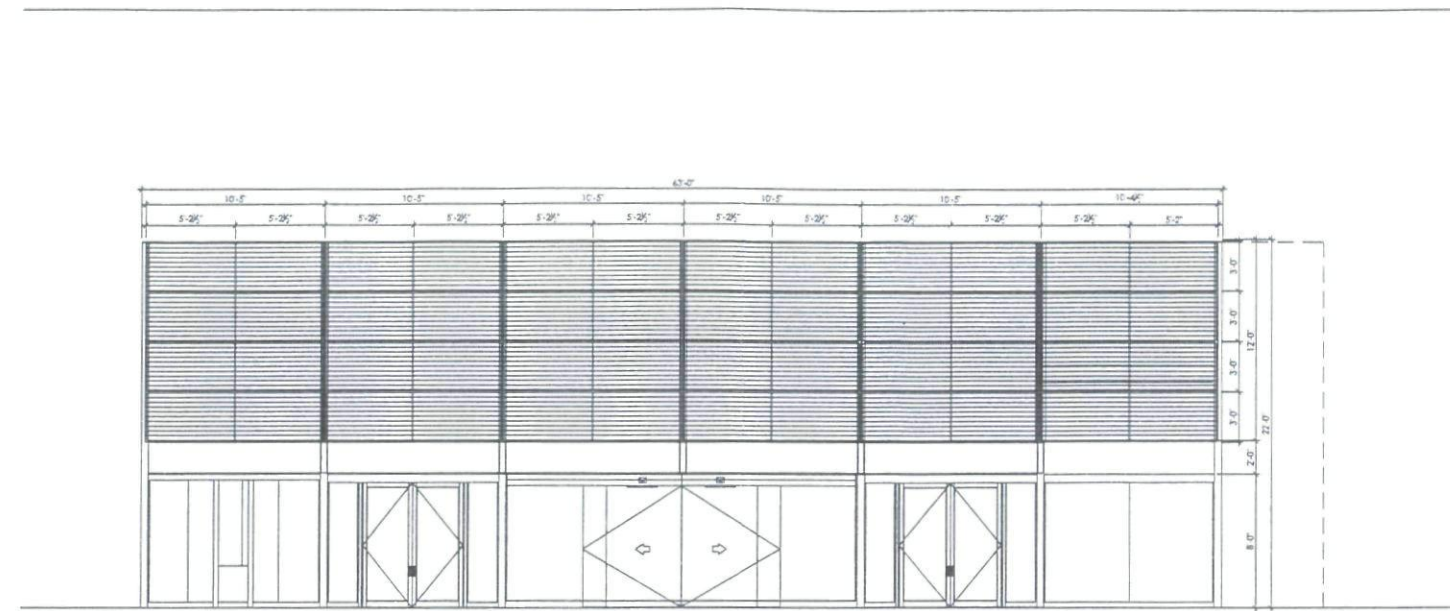

WEST - CANOPY ELEVATION
SCALE: 1/4" = 1'-0"

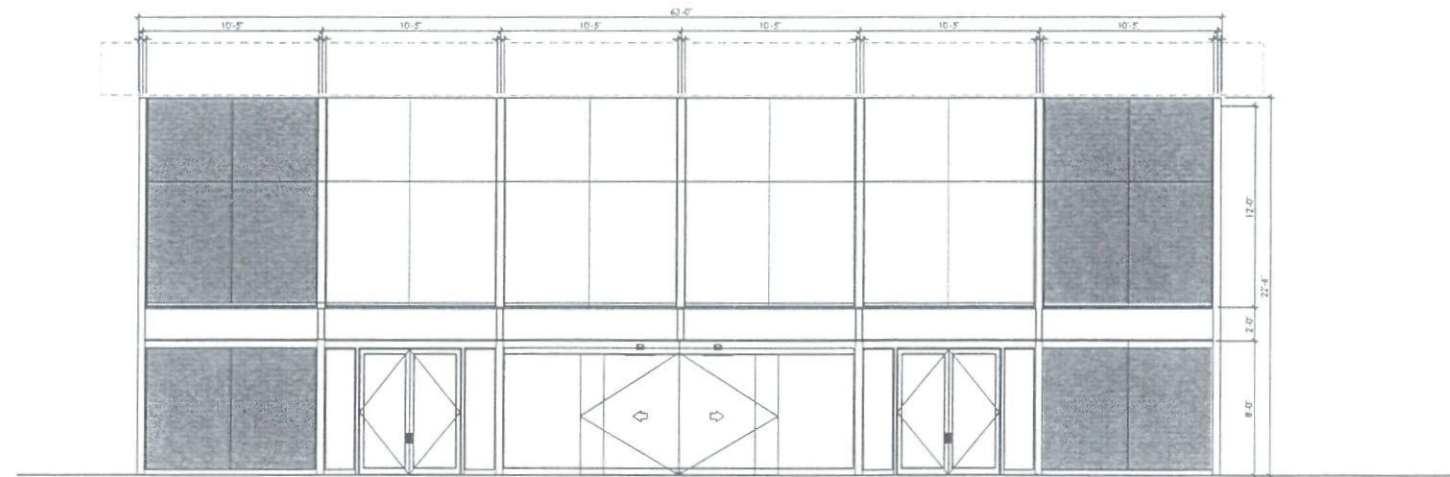

NORTH CANOPY ELEVATION
SCALE: 1/4" = 1'-0"

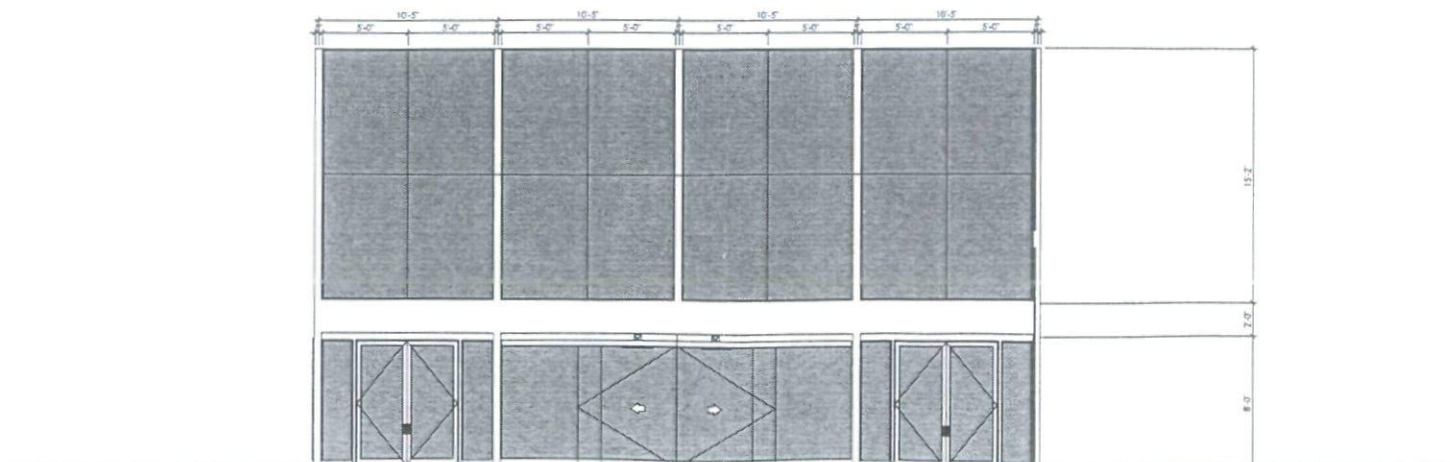

EXTERIOR ENLARGED ELEVATIONS 1. REFERENCES LIGHTING PLAN KEYNOTES

- 1 NOT USED x
- 2 NOT USED x
- 3 GLASS PANEL SYSTEM 2
 - * MANUFACTURER: TBD
 - * MODEL NUMBER: TBD
 - * DUAL PANE INSULATED GLASS
 - * COLOR: CLEAR
 - * CONNECTORS: TBD
 - * FINISH: TBD
 - * NOTE: CURVED LAMPHARED PANELS AT TICKET WINDOW WITH 2D DISPLAY BEYOND
- 4 GLASS PANEL SYSTEM 2
 - * MANUFACTURER: TBD
 - * MODEL NUMBER: TBD
 - * DUAL PANE INSULATED GLASS
 - * COLOR: TRANSLUCENT
 - * CONNECTORS: TBD
 - * FINISH: TBD
 - * NOTE: CURVED LAMPHARED PANELS AT TICKET WINDOW WITH 2D DISPLAY BEYOND
- 5 DOORS
 - * MANUAL
 - * MANUFACTURER: TBD
 - * MATERIAL: GLASS + STAINLESS STEEL
 - * FINISH: CLEAR + BRUSHED
 - * HARDWARE: TBD STAINLESS STEEL BRUSHED
- 6 DOORS
 - * AUTOMATIC / ADA COMPLIANT
 - * MANUFACTURER: TBD
 - * MODEL NUMBER: TBD
 - * MATERIAL: GLASS + STAINLESS STEEL
 - * FINISH: CLEAR + BRUSHED
 - * HARDWARE: TBD OPERATORIES + ACTUATORS
 - * DISPLAY: TBD
- 7 NOT USED x
- 8 STEEL STRUCTURE
 - * SEE STRUCTURAL
 - * MATERIAL: STEEL
 - * FINISH: FULL WELDS + GROUND SAWTOOTH + PAINT
 - * COLOR: TBD
- 9 STEEL STRUCTURAL DECK
 - * SEE STRUCTURAL
 - * MATERIAL: STEEL
 - * FINISH: PAINT
 - * COLOR: TBD
- 10 SUN CONTROL
 - * STEEL FRAME + FIBER COVER
 - * MATERIAL: STEEL
 - * FINISH: PAINT
 - * COLOR: TBD
- 11 TICKET WINDOW ASSEMBLY
 - * MANUFACTURER: C.F. LAURENCE
 - * MODEL: PAN-TWIN-TD
 - * MATERIAL: STAINLESS STEEL
 - * FINISH: BRUSHED
 - * COLOR: CLEAR
- 12 TICKET WINDOW SURROUND
 - * MATERIAL: STAINLESS STEEL
 - * FINISH: BRUSHED
 - * COLOR: CLEAR
- 13 NOT USED x
- 14 NOT USED x
- 15 MARQUEE SYSTEM (FUTURE)
 - * BRUSHED ANODIZED ALUMINUM / DIGITAL
 - * MANUFACTURER: TBD
 - * MODEL: TBD
 - * MATERIAL: TBD
 - * FINISH: TBD
 - * COLOR: TBD
- 16 MARQUEE SYSTEM
 - * INTERIOR ANODIZED BRUSHED CURVED GLASS PANELS
 - * 2 DIMENSIONAL DISPLAY
 - * MANUFACTURER: TBD
 - * MODEL: TBD
 - * MATERIAL: TBD
 - * FINISH: TBD
 - * COLOR: TBD

DOUGLAS
Architecture and Planning, P.C.
7522 East McDowell Drive, Scottsdale, Arizona 85250

APPROVED
3.20.08
DATE
INITIALS

Project: Scottsdale Center for the Performing Arts
DESIGN DEVELOPMENT PHASE 1
NOT FOR CONSTRUCTION
ELEVATION ENLARGED WEST
Job No: 0364
Date: 02.11.08

Stamp:
Sheet No: A-401

© 2000

© 2000

82.03.197

35.8

Note: All officer and number is non-certificated

Note: building outlines on aerial are slightly skewed from actual conditions, including property lines. Property lines are to be verified.

Drinkwater Boulevard

Existing SES

Existing Loading Ramp

Civic Center Mall

—Existing Building

Scottsdale
Center for the
Performing Arts

Zoning: C-2 DO

Existing Building

Zoning: C-2 DO

— New Entrance
Canopy

Zoning: D/RS-1

Existing Office/Rail

Zoning: C-3 DO

Scottsdale Museum of Contemporary Art

DOUGLAS
Architecture and Planning P.C.
7522 First McDowell Drive, Scottsdale, Arizona 85250

Scottsdale Center for...

Scottsdale Center for the Performing Arts

DESIGN REVIEW BOARD

Sheet 1 content

5-D

1st:


131.

1999, 2000, 2001, 2680, 26

A-200

5-DR-2006
1st: 11/28/07

A- 2001

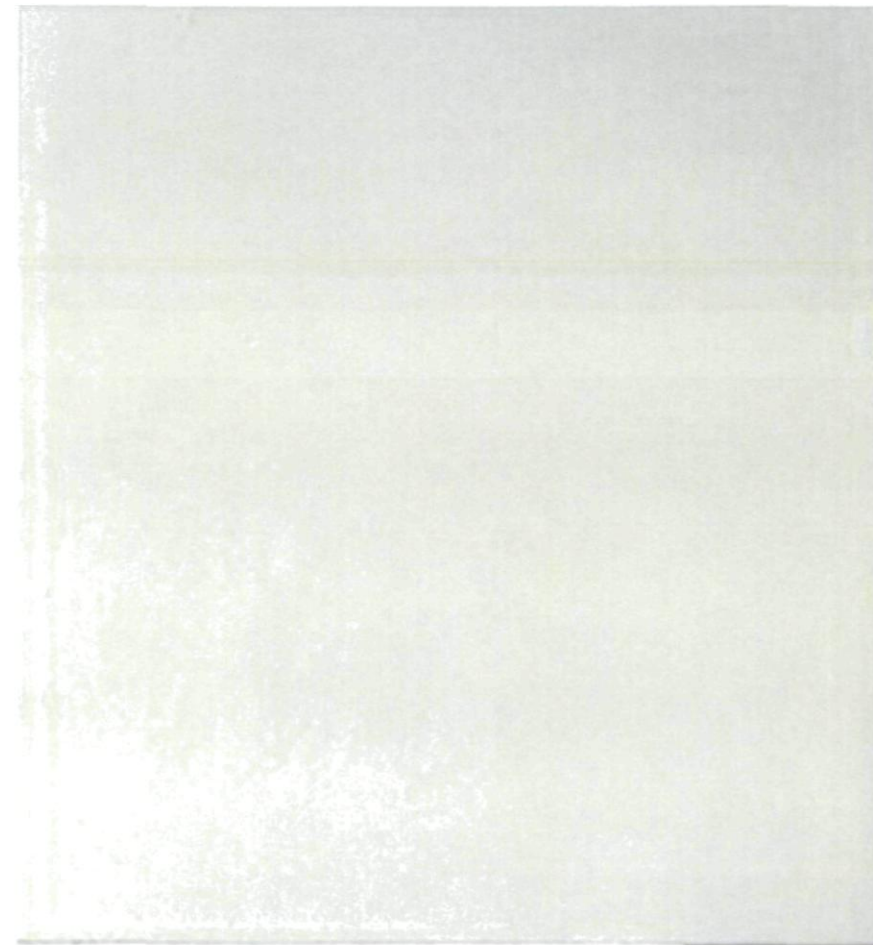

Color 'A':
Match existing wall



Glazing



Color 'B':
'Legendary Gray'
DE6369



Sun Control Louvers:
'Satin Aluminum Perforated'
ARCSOLAR



Scottsdale Center For The Arts -Remodel

5-DR-2006

ATTACHMENT #2

Scottsdale Center for the Performing Arts: Development Review - Site Location Map: 7380 E Second Street

