



**DRAINAGE NOTES**

- 59 INSTALL 24" H.D.P.E. PIPE.
- 56 H.D.P.E. PIPE END SECTION.

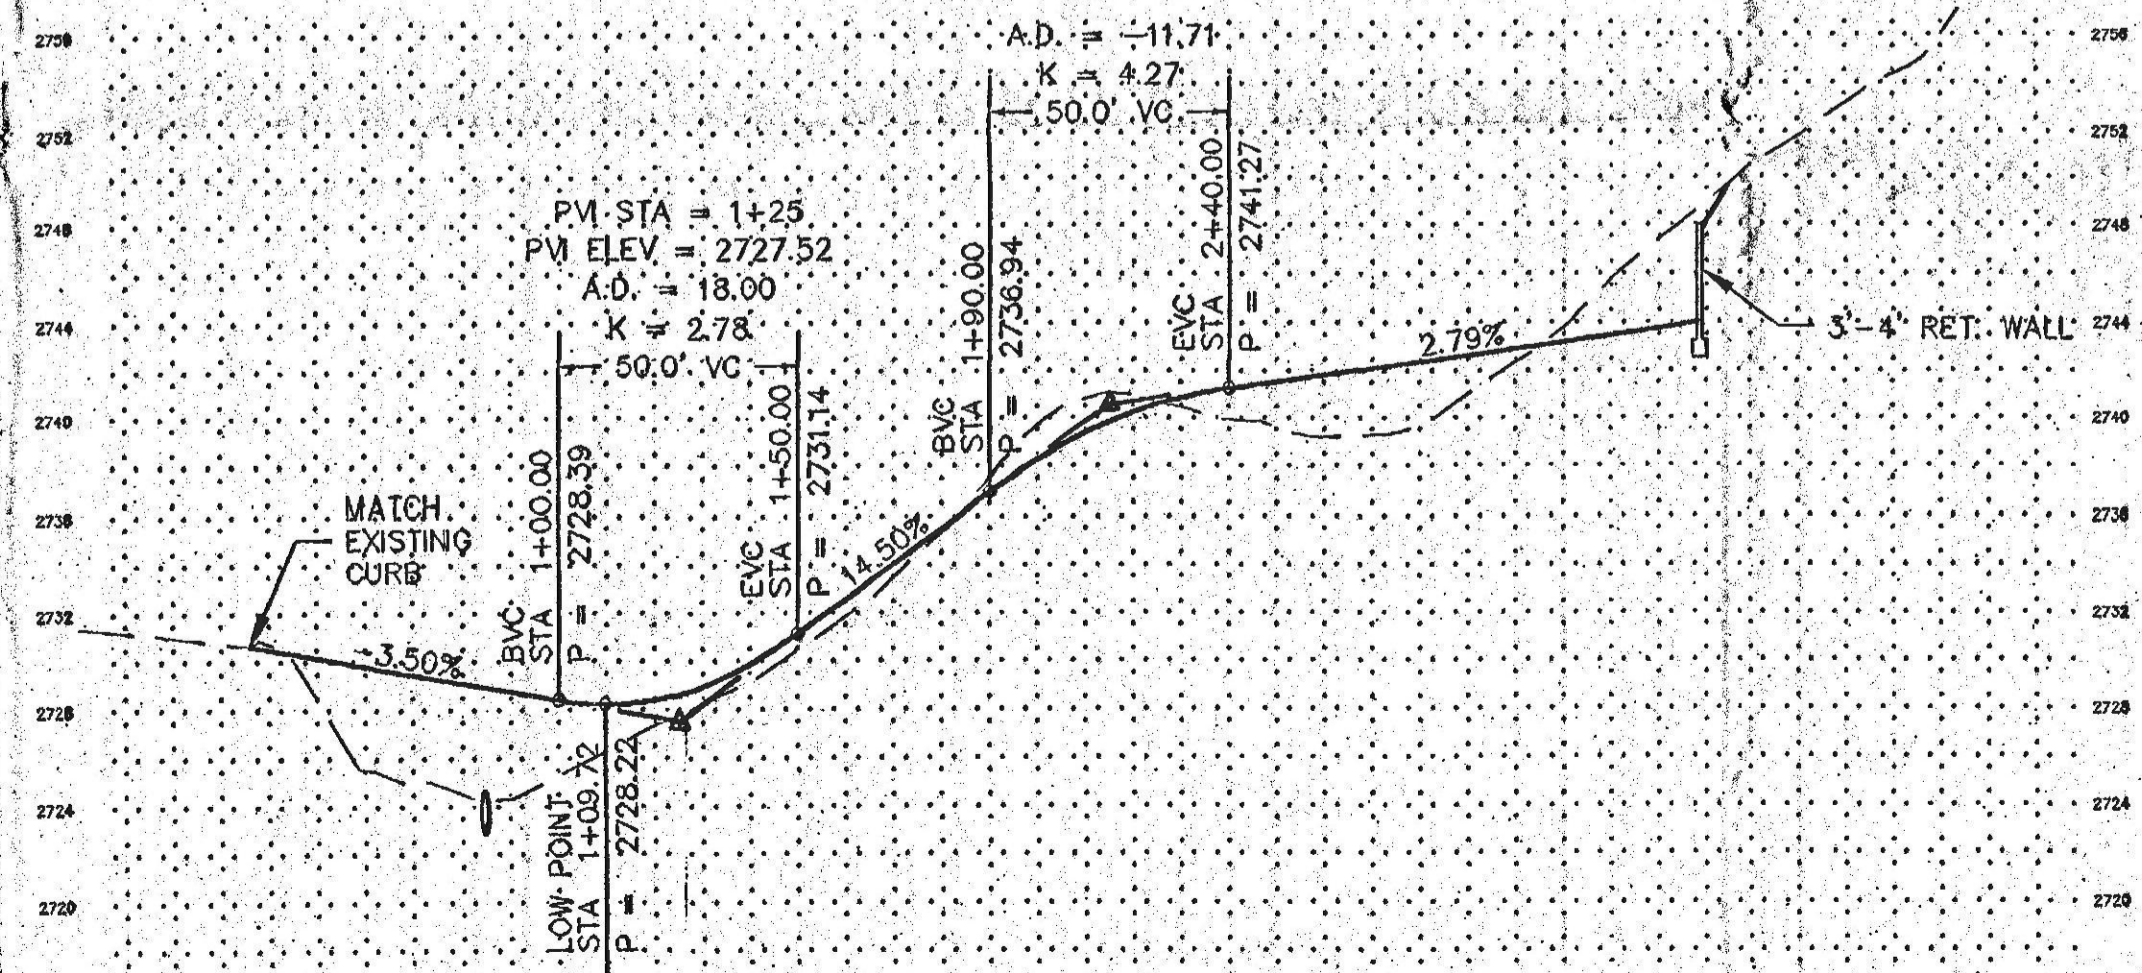


**DRIVEWAY PROFILE**

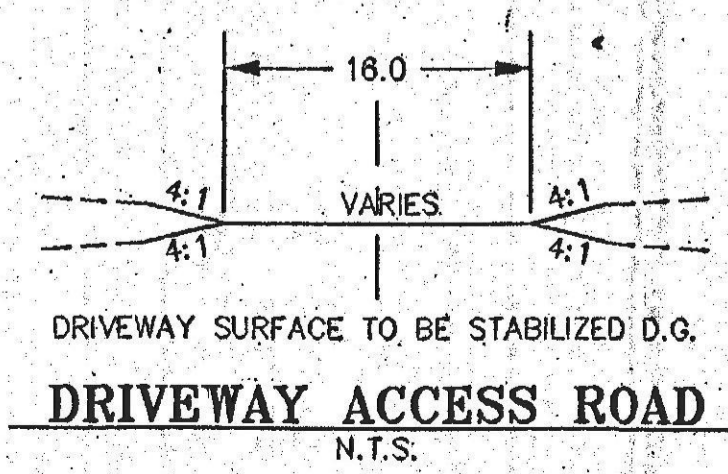

**SERENO CANYON  
SALES TRAILER  
CONCEPTUAL GRADING PLAN**

**NOT  
FOR  
CONSTRUCTION  
OR RECORDING**

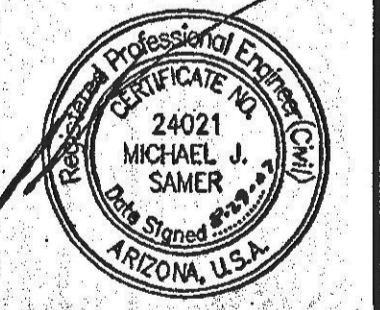

**WOOD/PATEL**  
LAND DEVELOPMENT • WATER RESOURCES  
TRANSPORTATION/TRAFFIC  
WATER/WASTEWATER • SURVEYING  
CONSTRUCTION MANAGEMENT  
2051 W. Northern Ave.  
Phoenix, AZ 85021  
(602) 335-8500  
www.woodpatel.com  
PHOENIX • MESA • TUCSON • GOODYEAR

ENGINEER **M. SAMER**  
DESIGNER **D. ZUKOWSKI**  
CAD TECHNICIAN **T. SCHWARZ**  
SCALE (HORZ) **1" = 40'**  
SCALE (VERT) **1" = 4'**  
DATE **08/29/07**  
JOB NUMBER **082654**

SHEET **1 OF 1**

CALL TWO WORKING DAYS  
BEFORE YOU DIG  
**263-1100**  
**1-800-STAKE-IT**  
(OUTSIDE MARICOPA COUNTY)