


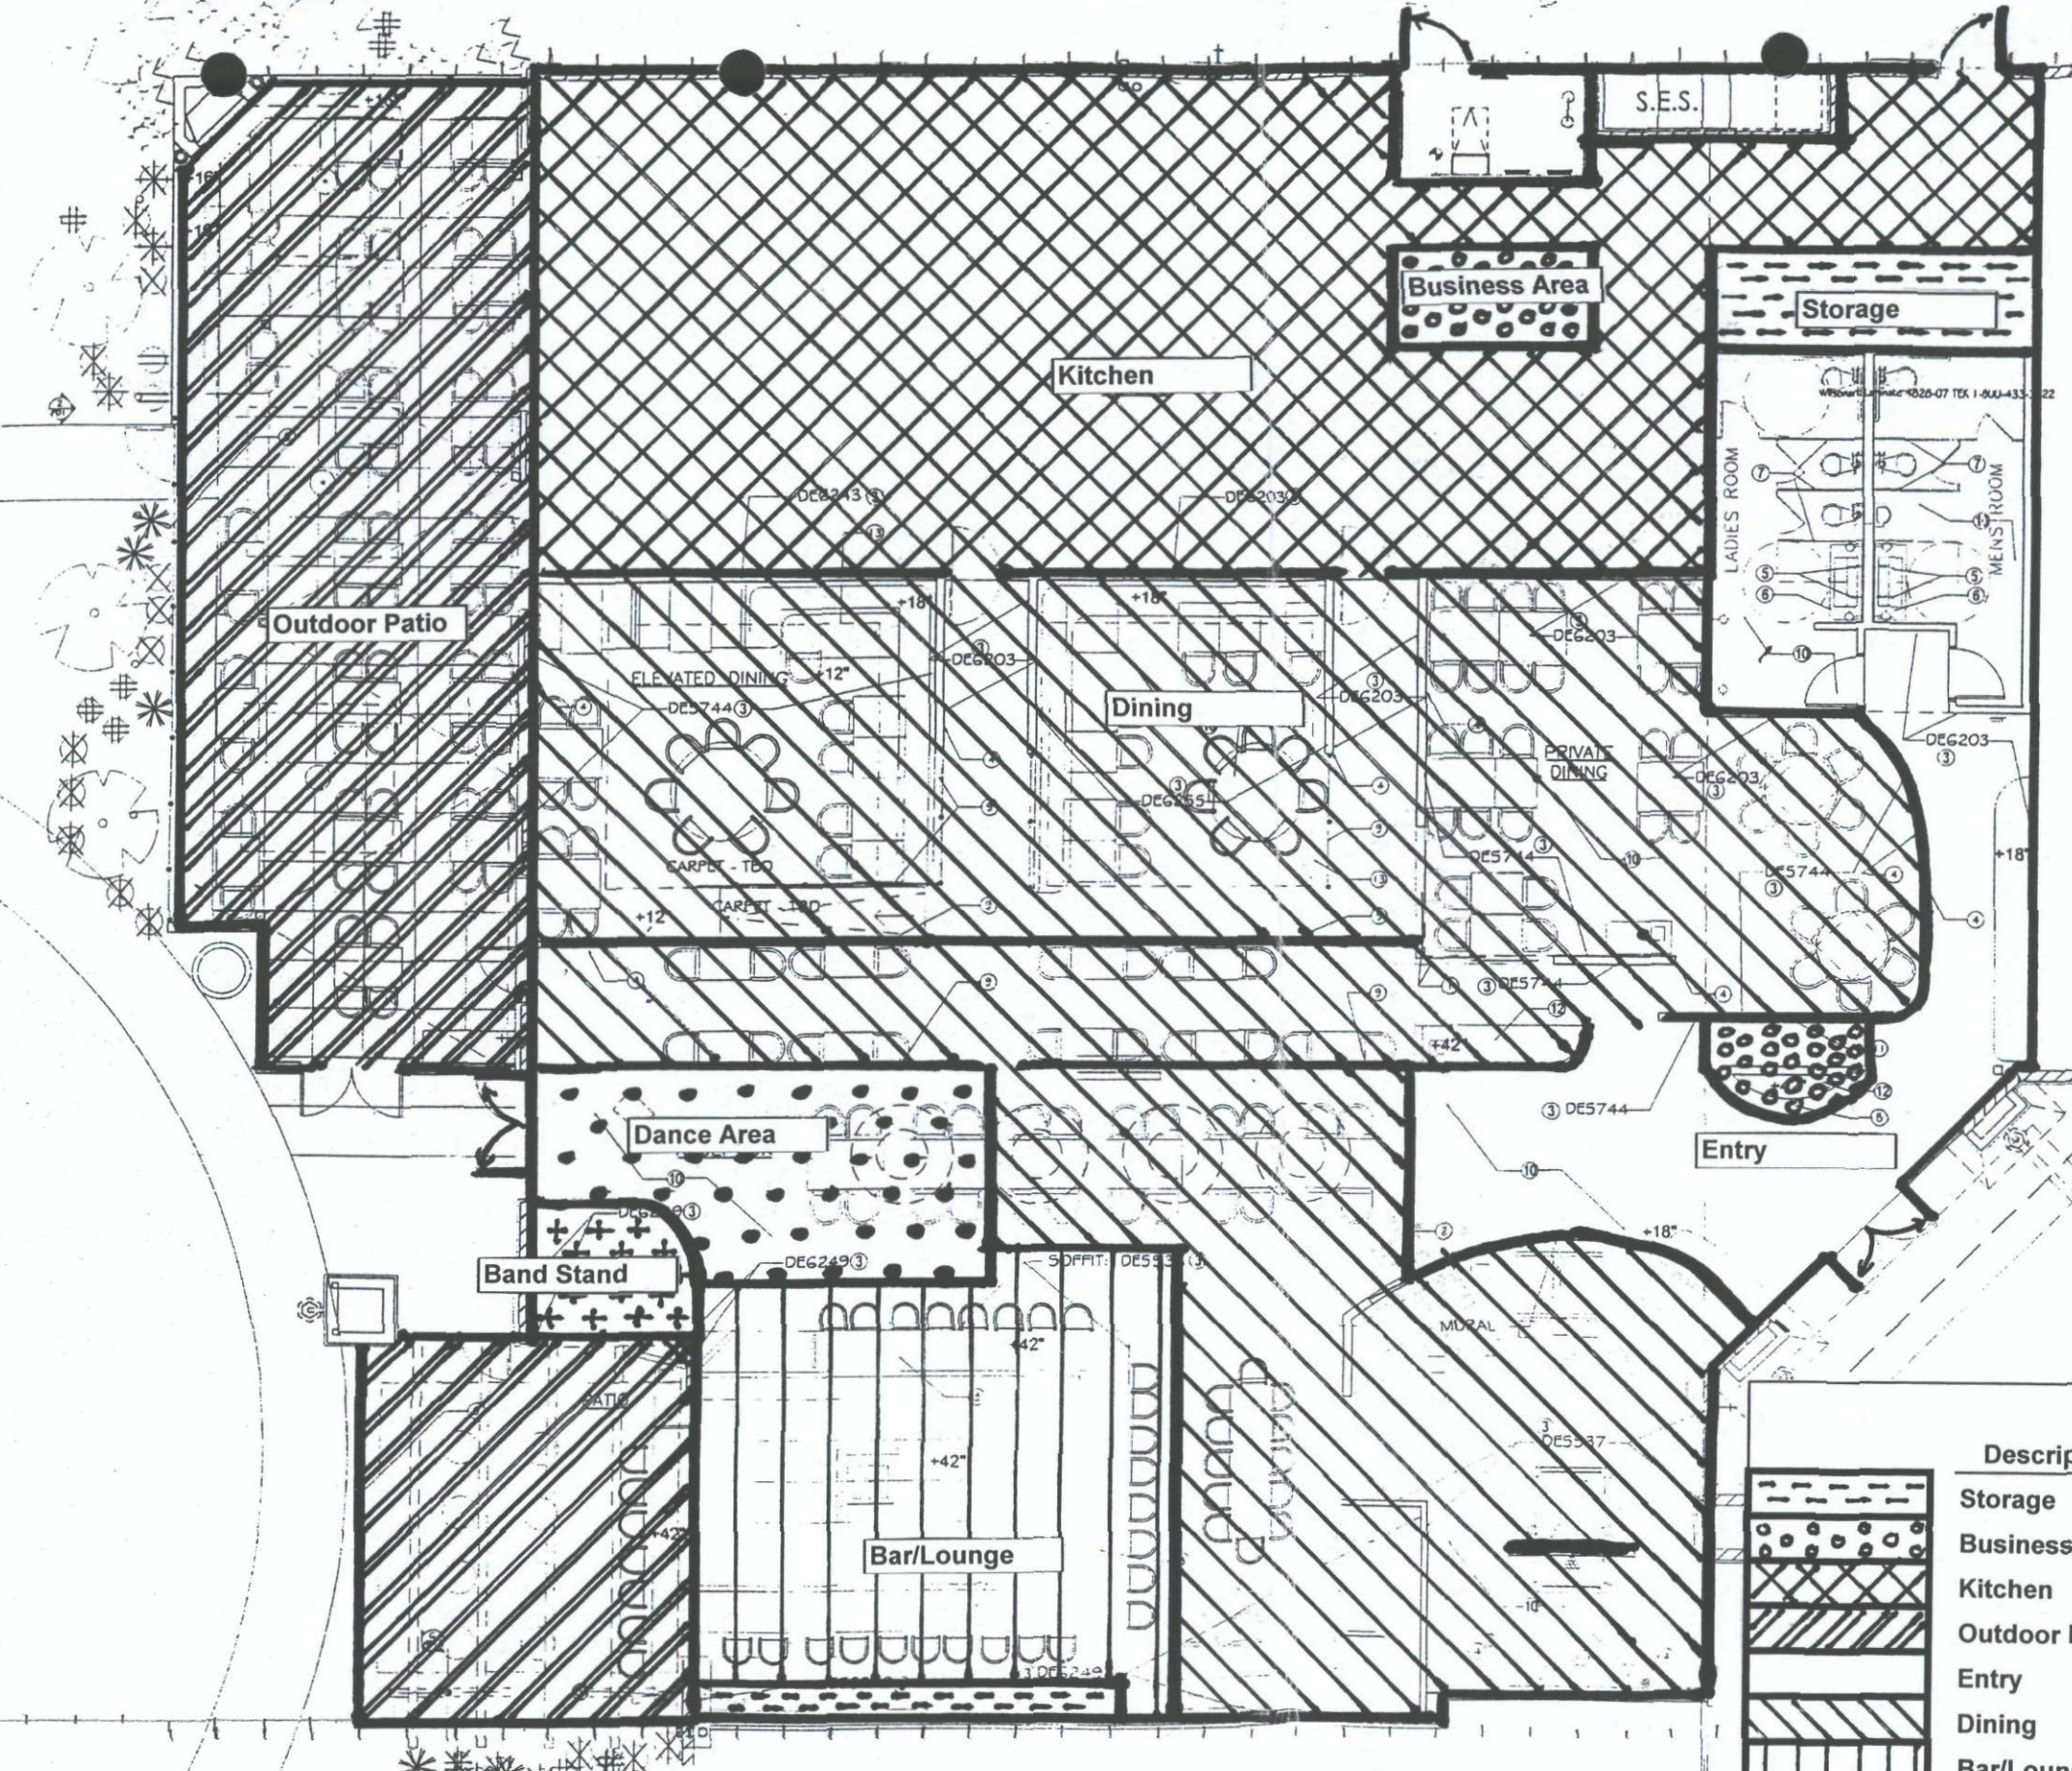

- FINISH AND FIXTURE NOTES**
- 1) SLIDING DOOR AND FIXED PANEL IN PRIVATE DINING ROOM: STORM PRODUCT: CARL DUE 177RQ, 1" GAUGE, 1/4" ALUMINUM: FRONT FINISH: SANDSTONE, BACK FINISH: SANDSTONE DISTRIBUTED BY: GLASSER ASSOCIATES, 563 EAST STACEY LANE, TEMPE, AZ 85284 480-940-5190
 - 2) PECK A BOO WALL PANEL: LAMCOR: NOTAMICALS COLLECTION: SERENGETI, 120", TEXTURE: AM 1400 MONSTER RD, SW, RENTON, WA 98057 1-822-255-4000 REP: KELLY CALCATERRA, 602-331-5019
 - 3) PAINT: DUNN-EDWARDS 2190 WEST CHANDLER BOULEVARD CHANDLER, AZ 85224 480-255-4141
 - 4) RUBBER FLOOR BASE: ROPPE - BIG O FLOOR COVERING 2002 WEST VIRGIN AVENUE, PHOENIX, AZ 85009, 602-442-2200 P124 RUBBER LAMINATE: ASUM TYPE: 1540194, 1/2" VULCANIZED SBR RUBBER, 177F194 1/8" TPE RUBBER, 170F194 1/8" VINYL, 5VSP194, 000" VINYL
 - 5) PLUMBING FIXTURE: QTY: 4, DANZA D316550 PARMA WALL M., FAUCET (P) WALL MOUNT & CENTER SET
 - 6) PLUMBING FIXTURES: QTY: 2, NEW METRO - VANITY TOP & BOWL TOP 55" CDB
 - 7) DOORICK PARTITIONS - FLOOR MOUNT SURFACE: WILSON TEK 1 LAMINATE, DOOR TO STALL TO BE WOOD WITH TUMBLING, TROSTED GLASS 1161 HARD STREET, NORTH HOLLYWOOD, CA 91605 1-818-764-1000
 - 8) GRANITE COUNTERTOP AT BAR AND HOSTESS STATION: CACTUS STONE, 5005 EAST MADISON ST., PHOENIX, AZ 85034-2018 602-914-2202
 - 9) CABLE RAIL SYSTEM: FENGY SOUTHWEST 7925 SILVERSTONE AVENUE, SUITE 506, SAN DIEGO, CA 1-858-376-6773
 - 10) FLOOR FINISH: MARBLEITE, INC. P.O. BOX 470367, LAKE MONROE, FL 32747 1-407-3302-0297 1/2" SONOCO X-LOGO TOPPING 21 PRESTAIN - PROTECTIVE & SEALER COLOR: T80 - SEE MANUFACTURER'S INSTALLATION INSTRUCTIONS
 - 11) INTERIUM - SOT 403-ASH DISTRIBUTED BY: QUALITY DESIGN PRODUCTS 4373 INDUSTRIAL ROAD LAS VEGAS, NEVADA 89118 807-617-0565
 - 12) PLASTIC LAMINATE - TO MATCH WOOD FINISH - SUBMIT SAMPLE FOR APPROVAL BY INTERIUM ARCHITECT
 - 13) SEE REFLECTED CEILING/SPECIALTY LIGHTING PLAN FOR CEILING FINISHES

APPROVED
 3/24/09
 DATE INITIALS

Description	Area (s.f.)	% of Gross	Parking Ratio	Spaces Req.
Storage	90	1.2%	300	0
Business Area	110	1.4%	250	1
Kitchen	1550	19.9%	250	6
Outdoor Patio	1505	19.3%	200	8
Entry	200	2.6%	50	4
Dining	3500	44.9%	50	70
Bar/Lounge	615	7.9%	35	18
Dance Area	245	3.1%	35	7
Band Stand	60	0.8%	35	2
TOTALS	7875			116

REVISED FLOOR PLAN/FLOOR PLAN WORKSHEET
 SCALE: 1/4"=1'-0"

design Link
 Architecture and Planning
 8701 E. Mountain View
 Suite 100
 Scottsdale, AZ 85258
 (480) 467-0094
 (480) 467-3818
 fax (480) 467-0094

SOUTH BEACH RESTAURANT
 9325 EAST SHEA BOULEVARD
 BUILDING B
 SCOTTSDALE, ARIZONA