


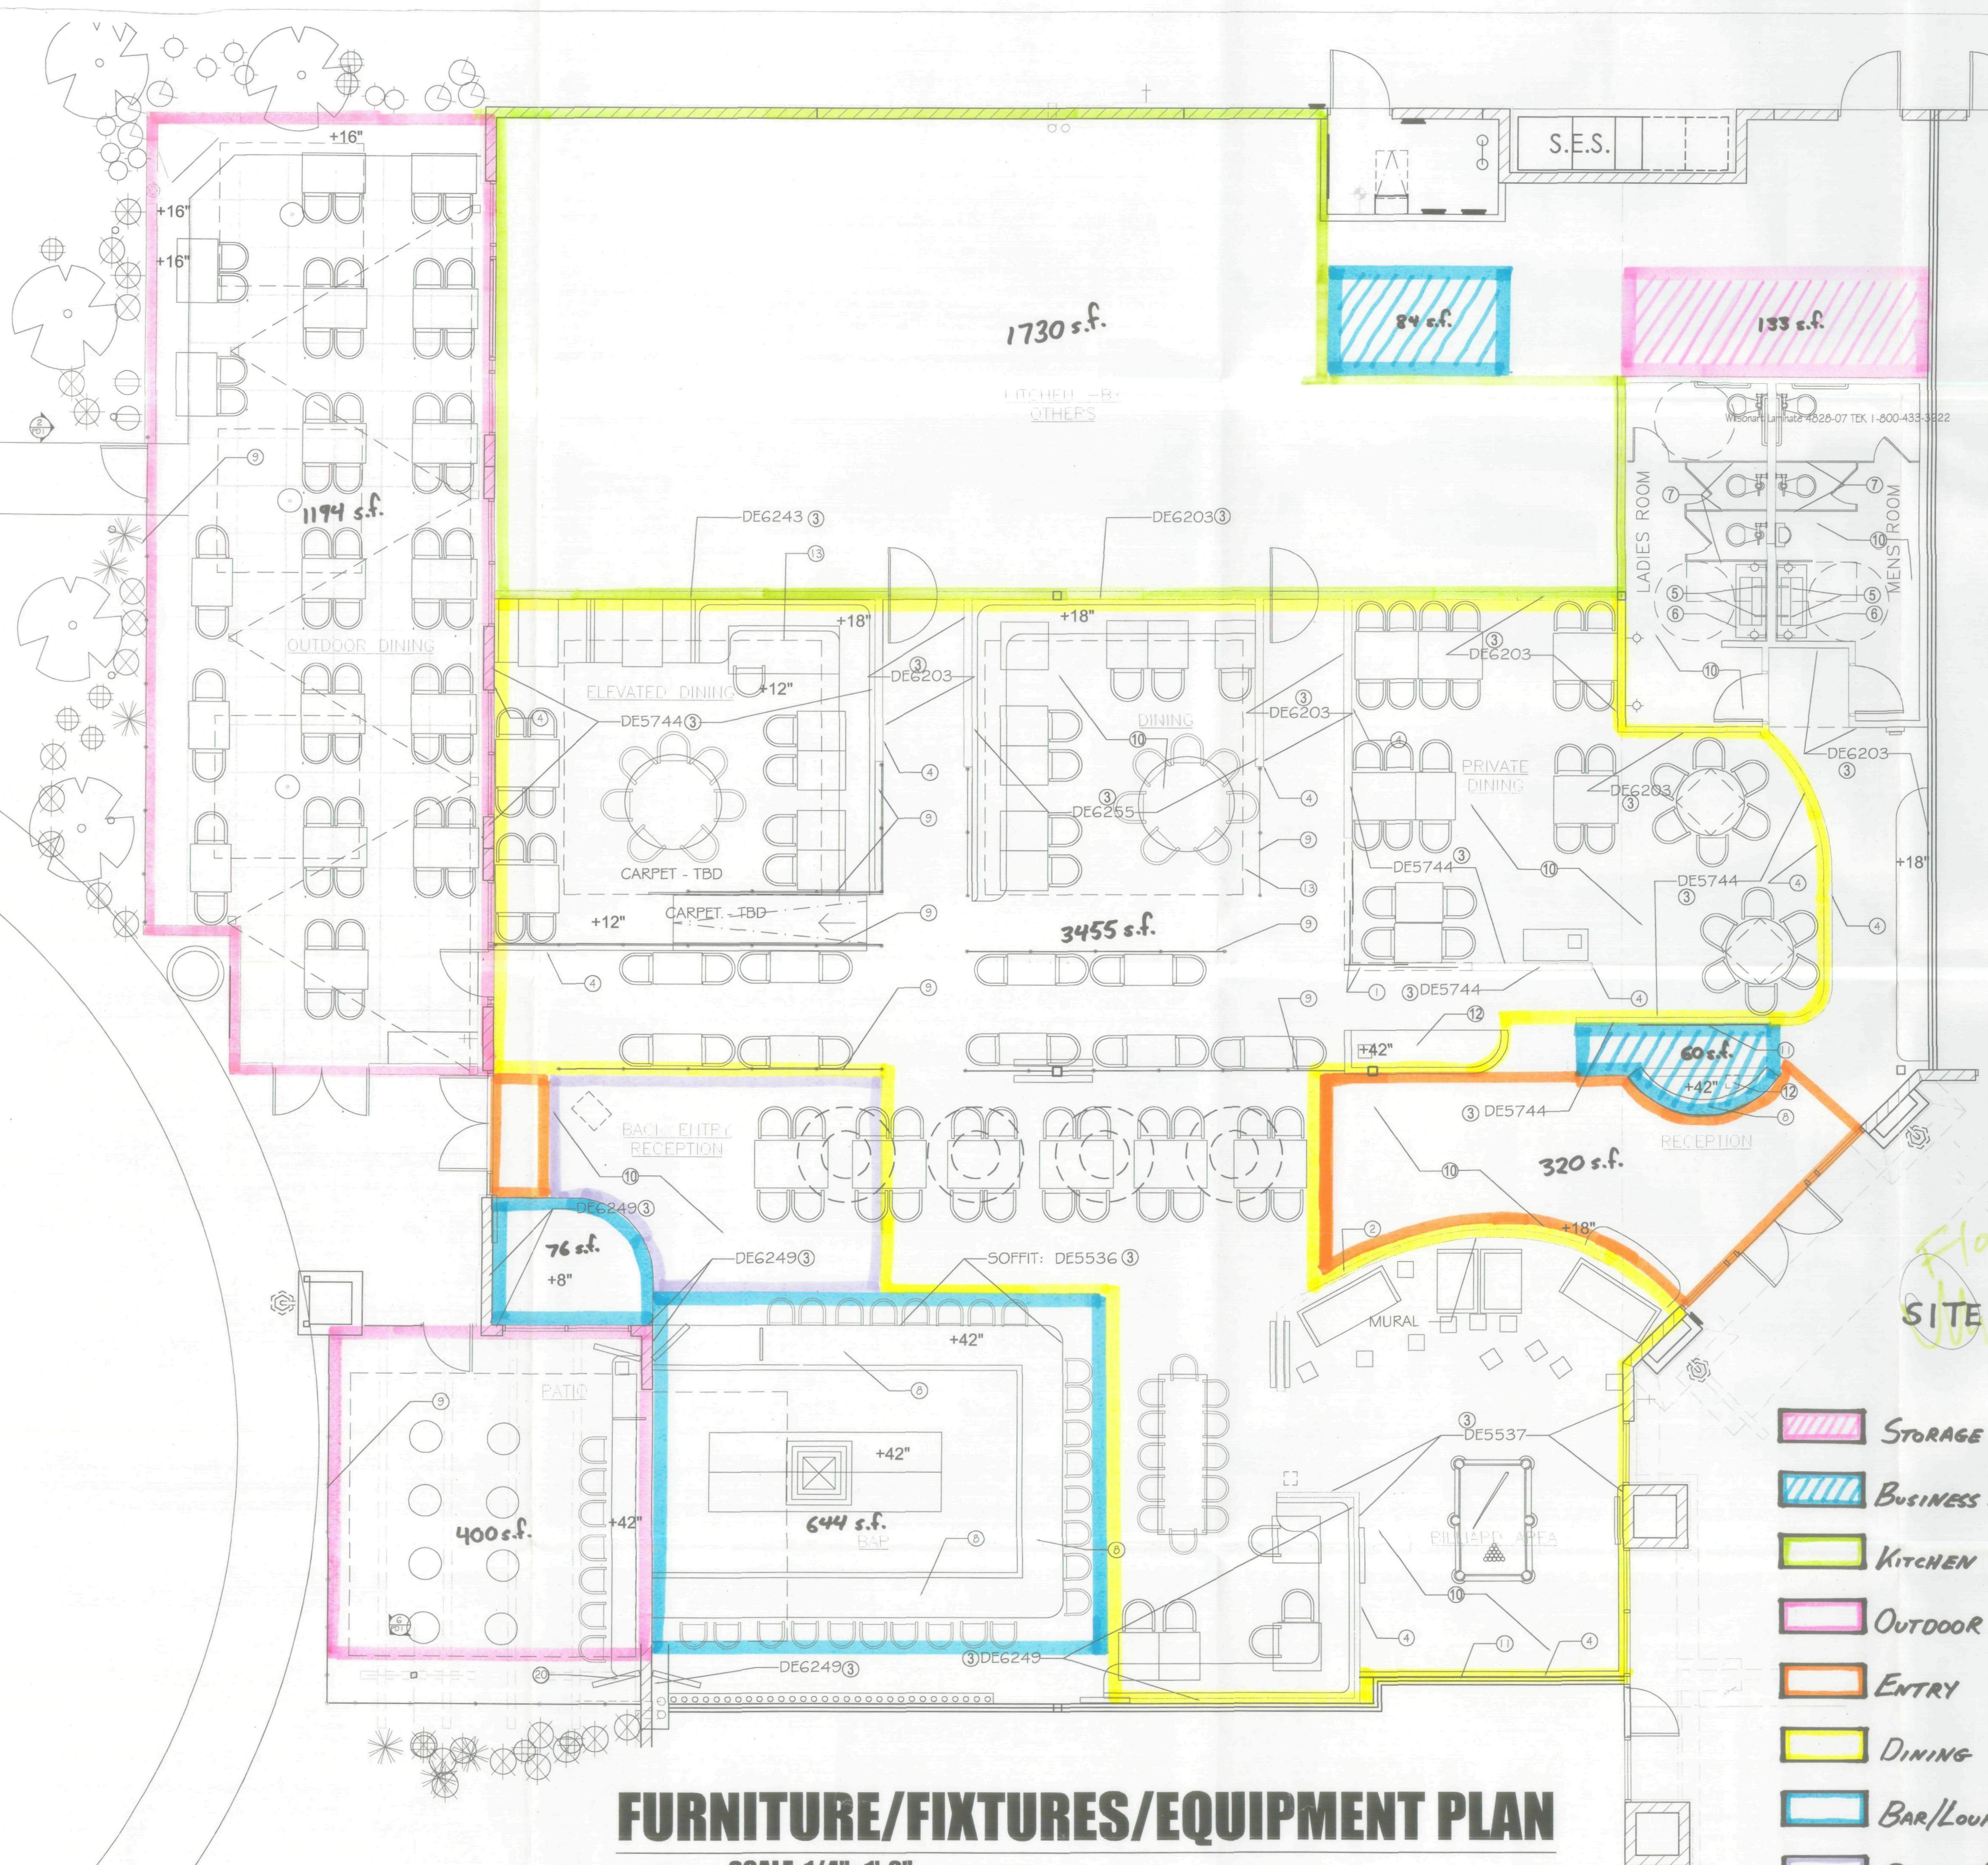

FURNITURE/FIXTURES/EQUIPMENT PLAN

SCALE: 1/4"=1'-0"

FINISH AND FIXTURE NOTES

- SLIDING DOOR AND FIXED PANEL IN PRIVATE DINING ROOM:
3" FORM. PRODUCT: CAPIZ BLUE 1/4" TUBING, 1" GAUGE, 1/4" TUBING.
FRONT FINISH: SANDSTONE, BACK FINISH: SANDSTONE.
DISTRIBUTED BY:
GLASS ASSOCIATES, 583 EAST STACEY LANE, TEMPE, AZ 85284
480-940-5139
- PEEK A BOO WALL PANEL
LUMICOR: BOTANICALS COLLECTION: SERENGETI, 120", TEXTURE: A1
1400 MONSTER RD. SW, RENTON, WA 98057
1-425-255-4000
REP: KELLY CALCATERRA, 602-331-5019
- PAINT
DUNN-EDWARDS
2190 WEST CHANDLER BOULEVARD
CHANDLER, AZ 85224
480-899-1141
- RUBBER FLOOR BASE
ROFFE - BIG D FLOOR COVERING
2802 WEST VIRGIN AVENUE, PHOENIX, AZ 85009, 602-442-2200
P124 BURNT LUMBER
ASTM TYPE: 1540194, 1/8" VULCANIZED SBR RUBBER, T77P194 1/8"
TPR RUBBER, TVSP194 1/8" VINYL, 5VSP194 .060" VINYL
- PLUMBING FAUCET
QTY: 4; DANZA D316556 PARMA WALL MT. FAUCET (PC)-WALL MOUNT
8" CENTER SET
- PLUMBING FIXTURES
QTY: 2; NEW METRO - VANITY TOP & BOWL TOP 55" EBB
- BOBROCK PARTITIONS - FLOOR MOUNT
SURFACE: WILSON TIK LAMINATE. DOOR TO STALL TO BE WOOD WITH
TEMPERED, FROSTED GLASS
1161 HART STREET, NORTH HOLLYWOOD, CA 91605
1-818-764-1000
- GRANITE COUNTERTOP AT BAR AND HOSTESS STATION
CACTUS STONE, 5005 EAST MADISON ST., PHOENIX, AZ 85034-2018
602-914-2202
STONE TYPE: GRANITE, COLOR: LEMON ICE
- CABLE RAIL SYSTEM
FEENEY SOUTHWEST
7925 SILVERCREST AVENUE, SUITE 506, SAN DIEGO, CA
1-650-576-6773
- FLOOR FINISH
MARBLELIFE - JIM; P.O. BOX 470367; LAKE MONROE, FL 32747
1-407-3302-0297
1/2" SMCX X-BOND TOPPING 2/ PRESTAIN - PROTECTIVE & SEALER
COLOR TBD - SEE MANUFACTURER'S INSTALLATION INSTRUCTIONS
- INTERLAM - SOT 403-A5H
DISTRIBUTED BY:
QUALITY DESIGN PRODUCTS
6375 INDUSTRIAL ROAD
LAS VEGAS, NEVADA 89118
807-617-0565
- PLASTIC LAMINATE - TO MATCH WOOD FINISH - SUBMIT SAMPLE FOR
APPROVAL BY INTERIORS ARCHITECT
- SEE REFLECTED CEILING/SPECIALTY LIGHTING PLAN FOR CEILING FINISHES

SITE PLAN WORKSHEET

	STORAGE	133 s.f. / 300 = 0
	BUSINESS AREA	144 s.f. / 250 = 1
	KITCHEN	1,730 s.f. / 250 = 7
	OUTDOOR PATIO	1,594 s.f. / 200 = 8
	ENTRY	320 s.f. / 50 = 6
	DINING	3,455 s.f. / 50 = 69
	BAR/LOUNGE	720 s.f. / 35 = 21
	DANCE AREA	244 s.f. / 35 = 7

FOR REFERENCE ONLY

CITY OF SCOTTSDALE
BUILDING PLANS
THESE PLANS HAVE BEEN REVIEWED
AND ARE READY FOR A PERMIT
THIS DOES NOT AUTHORIZE VIOLATIONS OF ANY
CODE OR ORDINANCE

FLOOR PLAN WORKSHEET

Date: 4/23/07
Project:
Drawn by:
Checked by:
Revisions:

18-UP-2008
1st: 6/13/2008

Sheet **FFE2**

TOTAL 119