


SPECIFICATION KEY NOTES


- ① Aluminum cabinet with routed graphics. Paint "Hazel Hurdle" #CL 2874D (Frazee) flat #2 texture finish.
- ② 1" clear acrylic push thru letters with diffuser backup and "Wrisco" brushed aluminum on the first surface. T12 fluorescent internal illumination.
- ③ Removable aluminum reverse pan tenant panel. Each tenant panel shall have a 1 1/2" return to the cabinet surface. Paint "Water Cracker" #CL 2873M (Frazee) flat #2 texture finish. The future tenant graphics shall be routed from the tenant panel face with 1" clear acrylic push thru letters, white diffuser back-up and "Wrisco" brushed aluminum on the first surface. T12 fluorescent internal illumination.

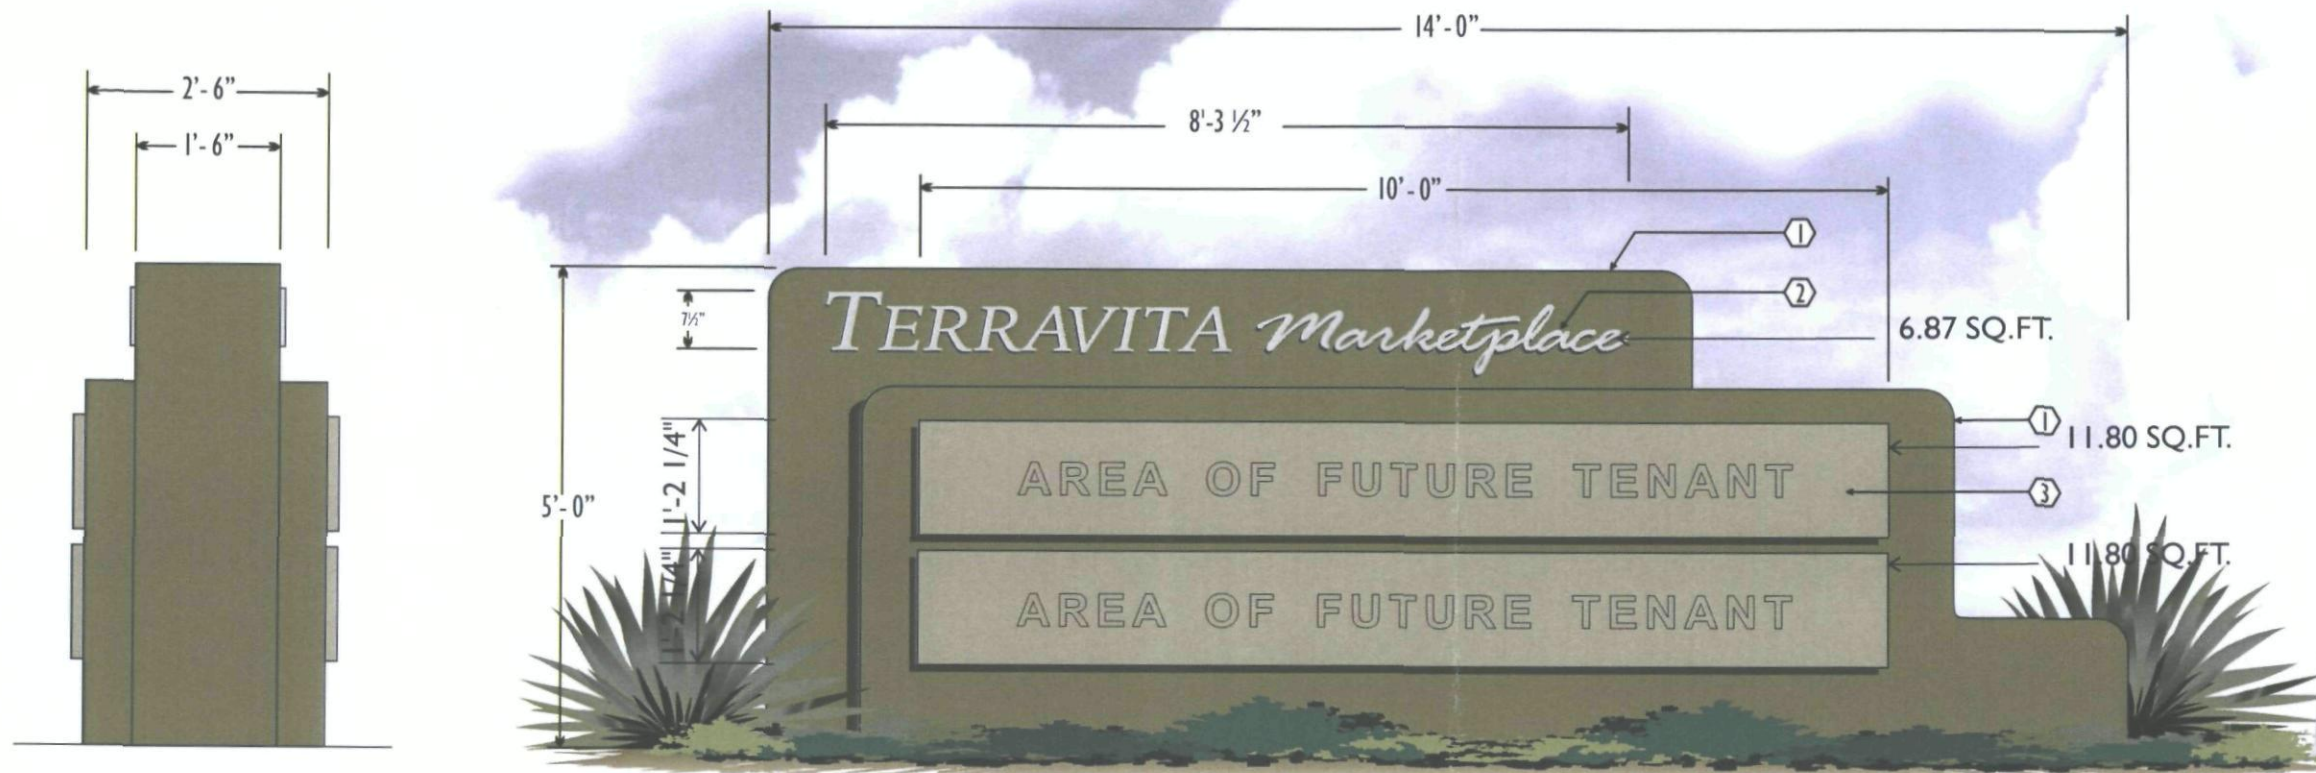

90-DR-2009
APPROVED
Griffin 7/16/09
DATE


A1 A2 ILLUMINATED DOUBLE FACE MONUMENT DISPLAY SCALE: 1/2" = 1' - 0" 30.47 SQ.FT.

SCOPE OF WORK :
 Manufacture & install (2) two internally illuminated D/F monument displays.

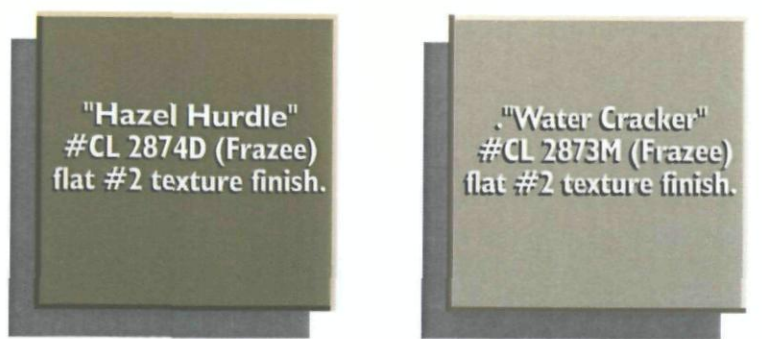

REVISION NOTES	
△ not noted.	△ Add specific color & finish notes.
△ Modify "A"	△ Change call-out for tenant panels.
△ Add side view.	△
△ Add second monument; add new site plan.	△
△ Add page 1 notes; modify site plan.	△

PHOENIX DIVISION 6725 W. Chicago Street, Chandler, Az 85226-3335 (480) 449-3726 <small>ARIZONA CONTRACTOR LICENSE NO. #073322-007, AWNINGS NO. #073322, ELECTRICAL NO. #092800</small> YESCO. YOUNG ELECTRIC SIGN COMPANY		* Illuminated displays will be wired for 120 volt power unless otherwise noted. * Cost for providing necessary electrical wiring to sign area is not included in sign proposal.		<table border="1"> <tr> <th>REV. #</th><th>DATE</th><th>BY</th><th>REV. #</th><th>DATE</th><th>BY</th></tr> <tr> <td>REV. 1</td><td>10/11/07</td><td>JW</td><td>REV. 6</td><td>11/6/08</td><td>MVS</td></tr> <tr> <td>REV. 2</td><td>01/23/08</td><td>LSD</td><td></td><td></td><td></td></tr> <tr> <td>REV. 3</td><td>02/27/08</td><td>TALL</td><td></td><td></td><td></td></tr> <tr> <td>REV. 4</td><td>10/3/08</td><td>JB</td><td></td><td></td><td></td></tr> <tr> <td>REV. 5</td><td>10/21/08</td><td>JWW</td><td></td><td></td><td></td></tr> </table>	REV. #	DATE	BY	REV. #	DATE	BY	REV. 1	10/11/07	JW	REV. 6	11/6/08	MVS	REV. 2	01/23/08	LSD				REV. 3	02/27/08	TALL				REV. 4	10/3/08	JB				REV. 5	10/21/08	JWW				FIRM NAME / PROJECT ADDRESS TERRAVITA MARKETPLACE 34402 N. SCOTTSDALE ROAD SCOTTSDALE, ARIZONA SALESPERSON BRIDGET FALCO		ORIGINAL DATE: 09/04/07 ORIG. DESIGNER: L. den Dulk SCALE: As Noted	6071188-R7 <small>FILE DESIGN NUMBER</small> 1 OF 4
REV. #	DATE	BY	REV. #	DATE	BY																																							
REV. 1	10/11/07	JW	REV. 6	11/6/08	MVS																																							
REV. 2	01/23/08	LSD																																										
REV. 3	02/27/08	TALL																																										
REV. 4	10/3/08	JB																																										
REV. 5	10/21/08	JWW																																										
SALES APPROVAL: DATE:																																												

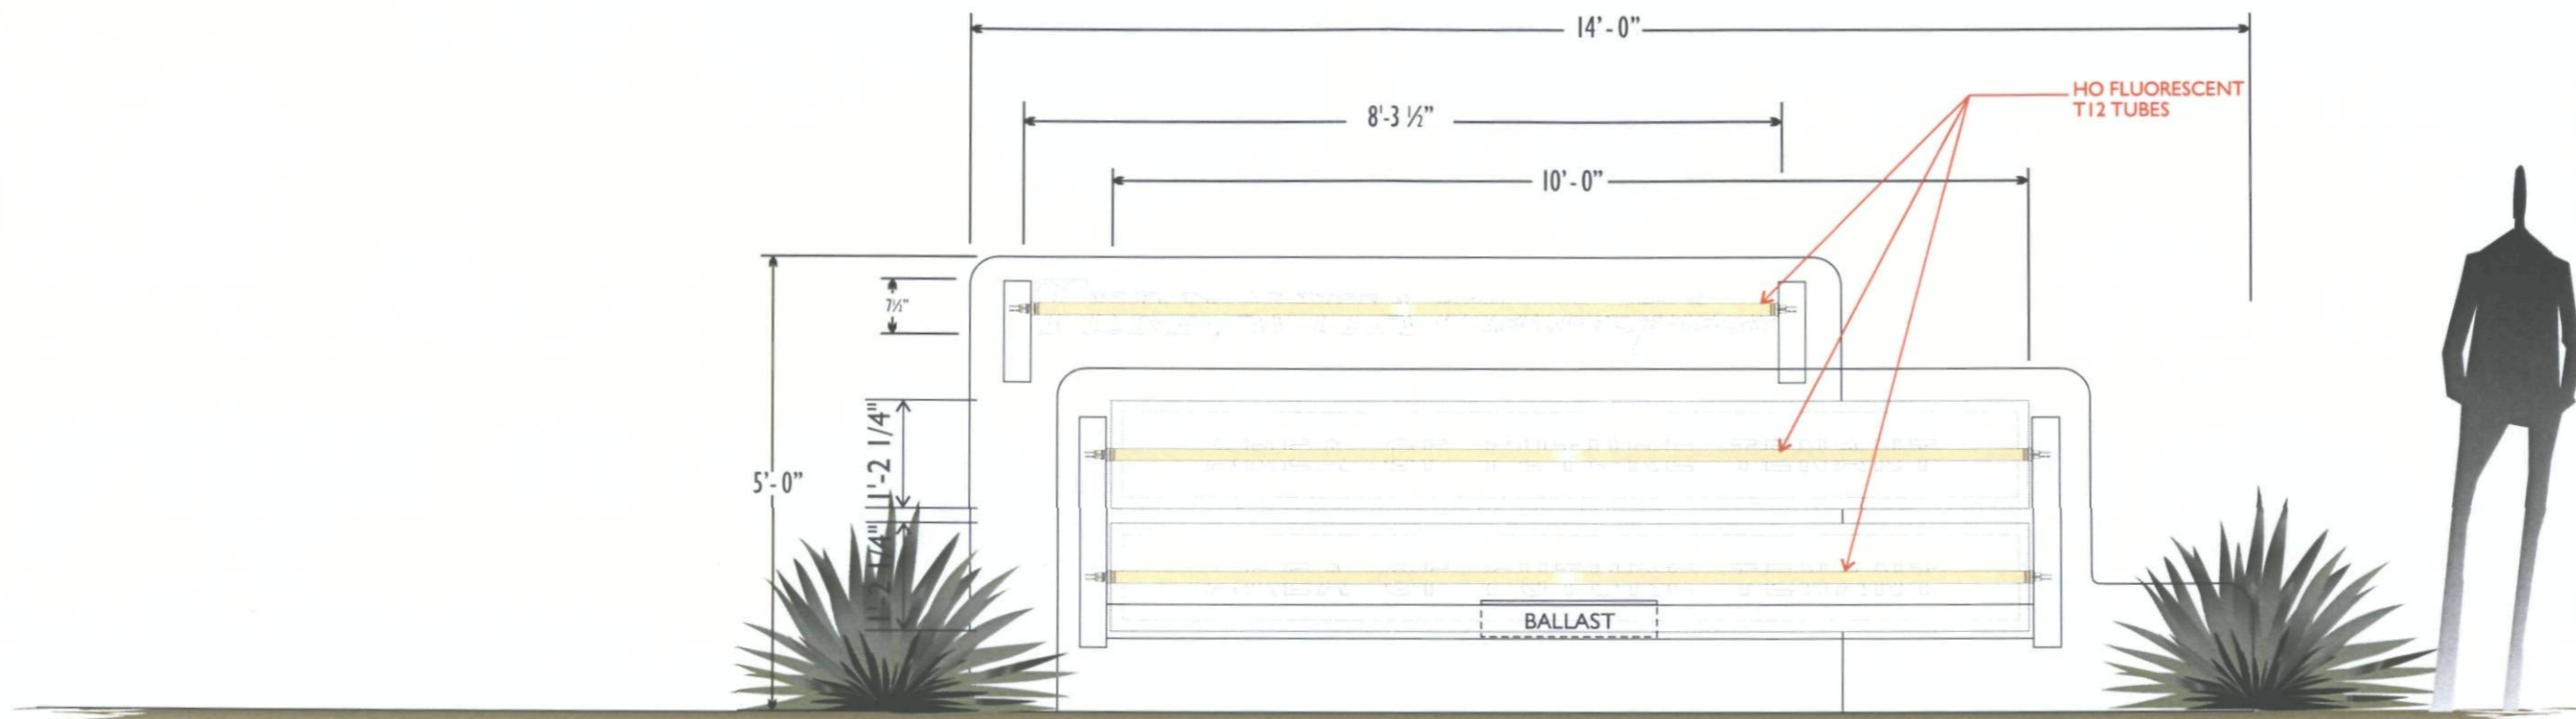


A1 A2 ILLUMINATED DOUBLE FACE: SIGN LAMP CONFIGURATION
SCALE: 1/2" = 1' - 0" 30.47 SQ.FT.

SCOPE OF WORK :

MANUFACTURE & INSTALL (2) TWO INTERNALLY ILLUMINATED D/F MONUMENT DISPLAYS. TEXTURED & PAINTED TO MATCH EXISTING. "TERRAVITA MARKETPLACE" IS 1" PUSHED THRU ACRYLIC W/ 1ST SURFACE WRISCO BRUSHED ALUMINUM. 1 1/2" RAISED TENANT PANELS, ROUTED WITH 1" PUSH -THRU ACRYLIC W/ 1ST SURFACE WRISCO BRUSHED ALUMINUM.

90-DR-2009
APPROVED
Chris McCarty 7/16/09
DATE



PHOENIX DIVISION
6725 W. Chicago Street, Chandler, Az 85226-3335 (480) 449-3726
ARIZONA CONTRACTOR LICENSE NO. #073322-007, AWNINGS NO. #073322, ELECTRICAL NO. #092800
YESCO. YOUNG ELECTRIC SIGN COMPANY

* Illuminated displays will be wired for 120 volt power unless otherwise noted.

* Cost for providing necessary electrical wiring to sign area is not included in sign proposal.

SALES APPROVAL: _____

DATE: _____

REV. #	DATE	BY	REV. #	DATE	BY
REV. 1	10/11/07	JW	REV. 6	11/6/08	MVS
REV. 2	01/23/08	LSD			
REV. 3	02/27/08	TALL			
REV. 4	10/3/08	JB			
REV. 5	10/21/08	JWW			

FIRM NAME / PROJECT ADDRESS

TERRAVITA MARKETPLACE
34402 N. SCOTTSDALE ROAD
SCOTTSDALE, ARIZONA

SALESPERSON BRIDGET FALCO

ORIGINAL DATE: 09/04/07

ORIG. DESIGNER: L. den Dulk

SCALE: As Noted

6071188-R7
FILE DESIGN NUMBER

2 OF 4

90-DR-2009
1st: 6/12/2009