



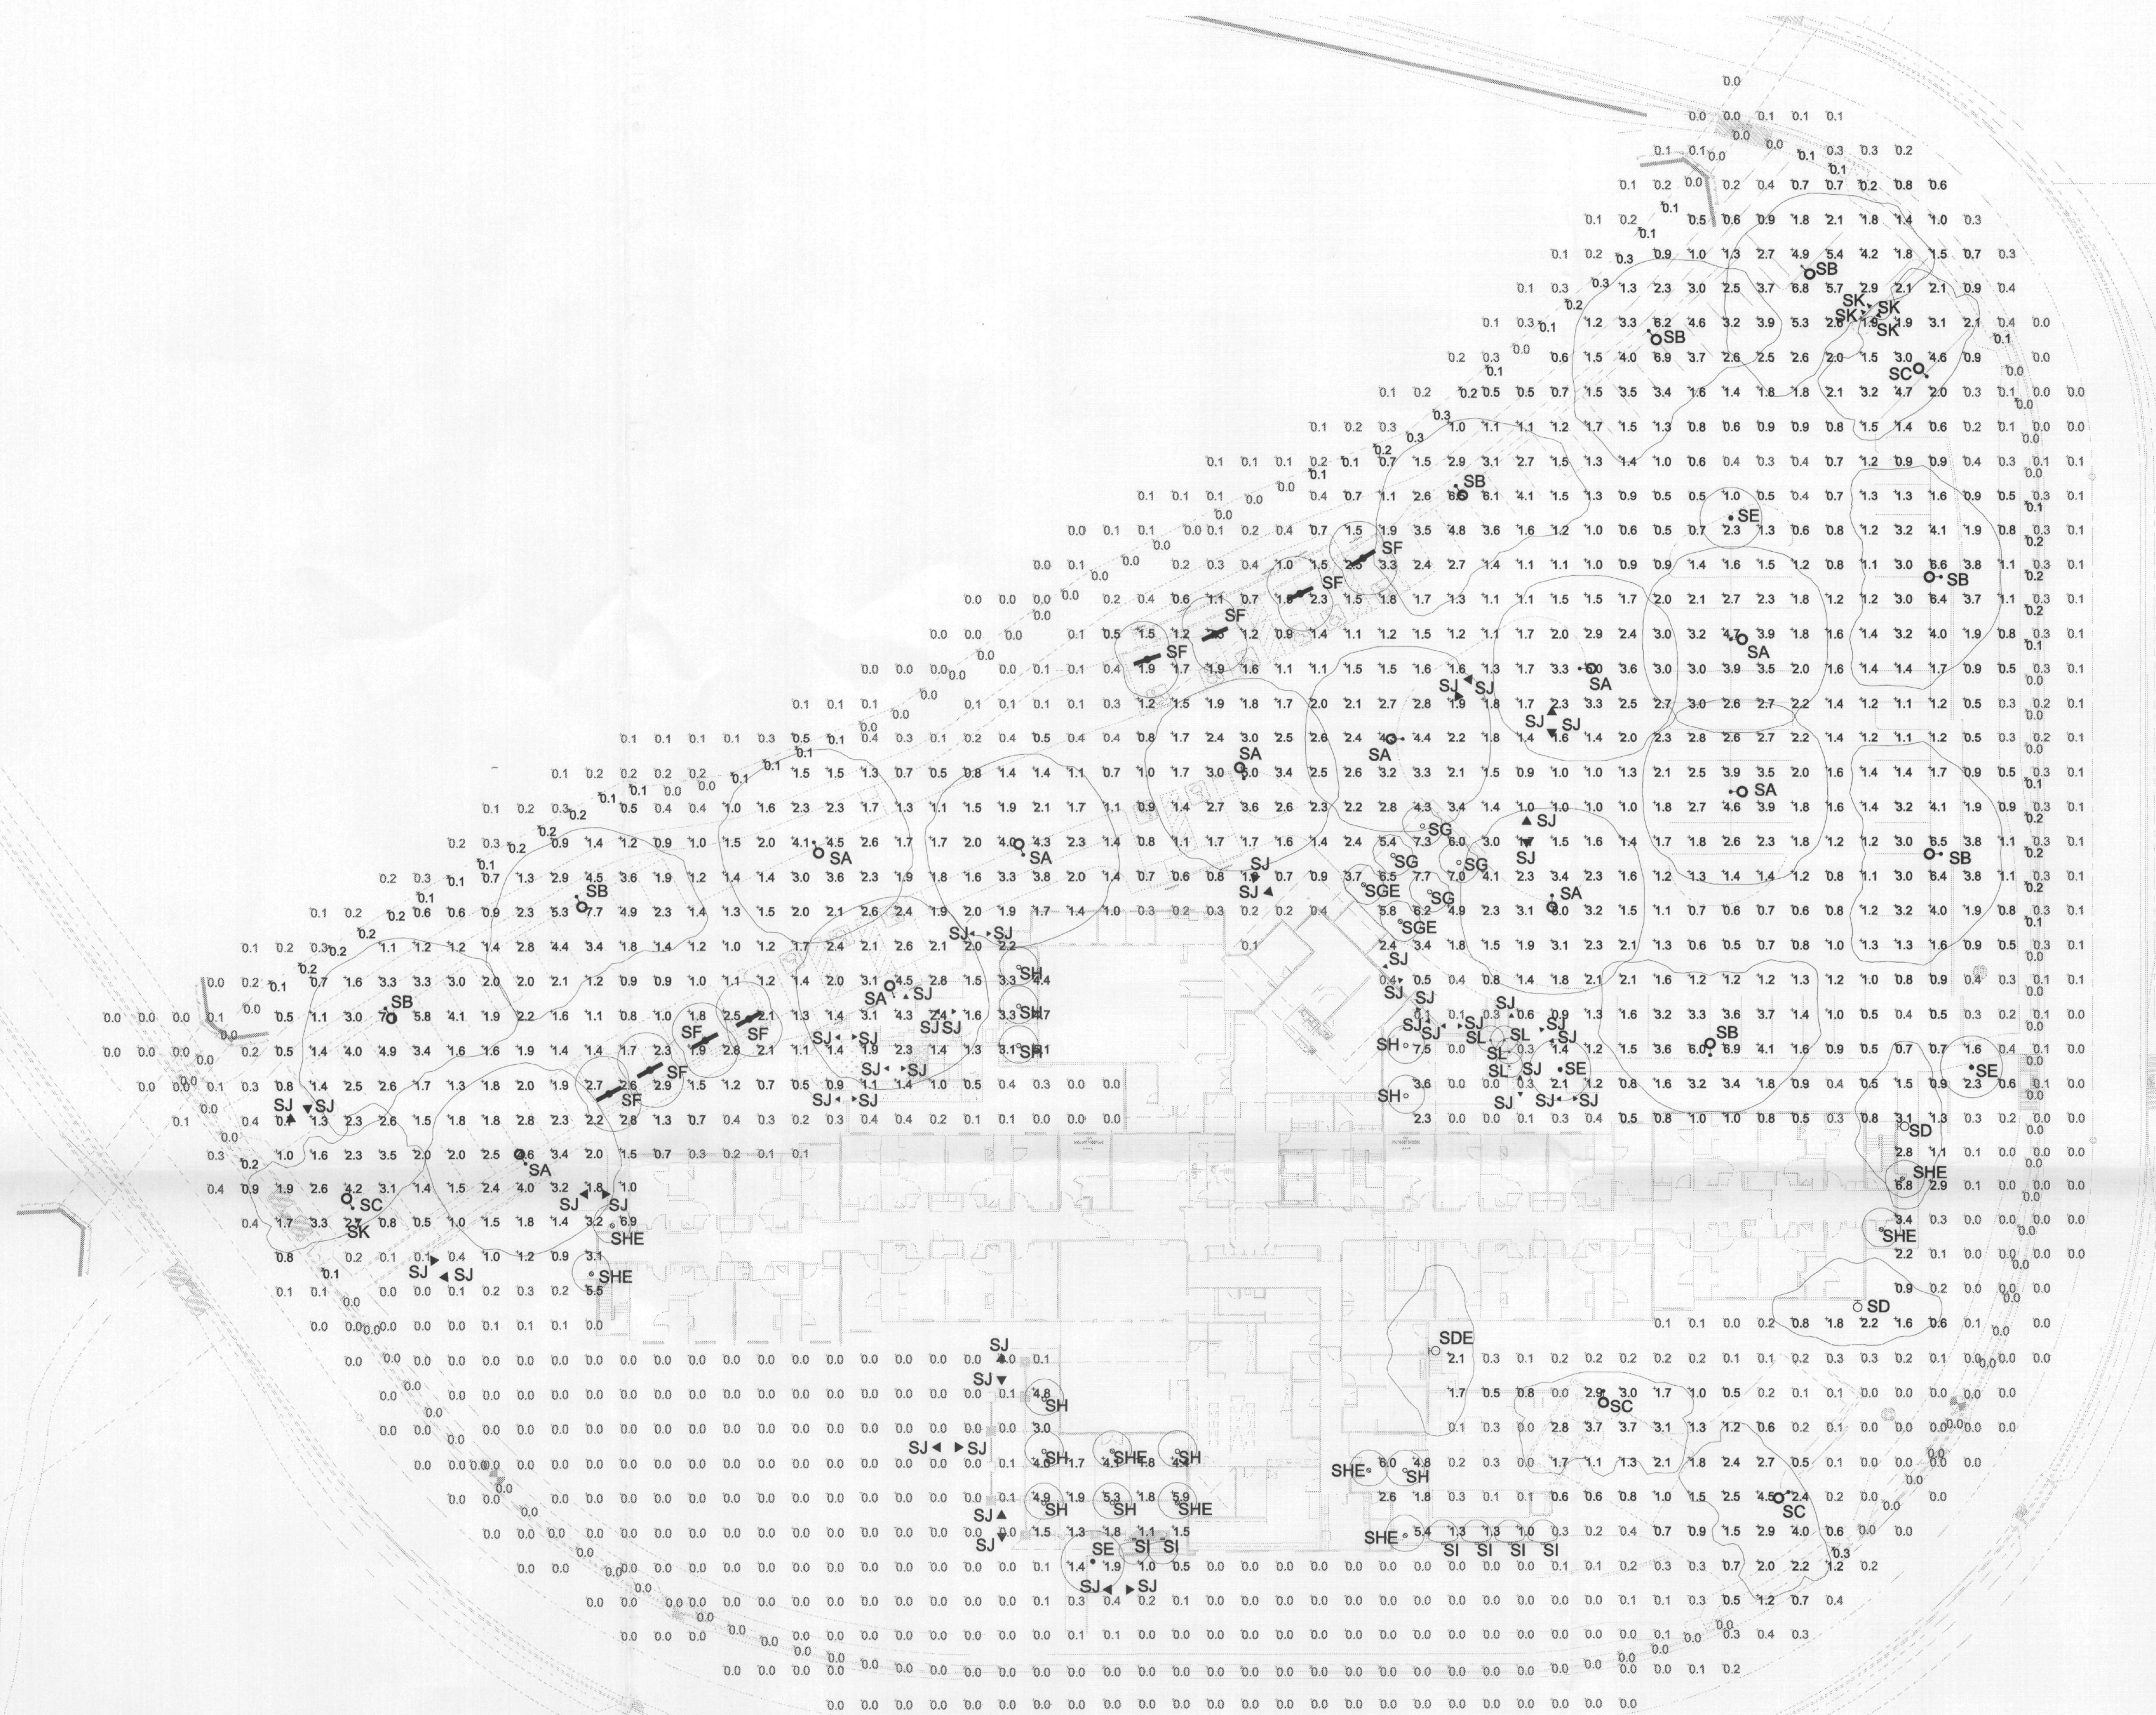

ELECTRICAL PHOTOMETRIC SITE PLAN



SCALE: 1" = 30' - 0"

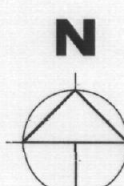

| LUMINAIRE SCHEDULE |       |     |                                                                                                                            |                                                                                                                                                                      |                                                                                 |                             |            |
|--------------------|-------|-----|----------------------------------------------------------------------------------------------------------------------------|----------------------------------------------------------------------------------------------------------------------------------------------------------------------|---------------------------------------------------------------------------------|-----------------------------|------------|
| Symbol             | Label | Qty | Catalog Number                                                                                                             | Description                                                                                                                                                          | Lamp                                                                            | File                        | Lumens LLF |
| •○                 | SA    | 10  | COOPER LIGHTING<br>-McGRAW-EDISON<br>CM AM 150 MP 240<br>S8 BZ FF. BRONZE<br>FINISH.                                       | MEDIUM ARCHITECTURAL<br>AREA LUMINAIRE - TYPE<br>V DISTRIBUTION. POLE<br>MOUNT AT +15' FROM<br>BOTTOM OF FIXTURE TO<br>FINISHED FLOOR.                               | 150 WATT PULSE-START<br>CLEAR ED-28<br>HORIZONTAL BURN                          | CIS-150-MP-XX-<br>-SF.ies   | 14000 0.72 |
| •○                 | SB    | 8   | COOPER LIGHTING<br>-McGRAW-EDISON<br>CM AM 150 MP 240<br>S8 BZ FF. BRONZE<br>FINISH.                                       | MEDIUM ARCHITECTURAL<br>AREA LUMINAIRE - TYPE<br>III DISTRIBUTION. POLE<br>MOUNT AT +15' FROM<br>BOTTOM OF FIXTURE TO<br>FINISHED FLOOR.                             | 150 WATT PULSE-START<br>CLEAR ED-17<br>HORIZONTAL BURN                          | CIS-150-MP-XX-<br>-3S.ies   | 14000 0.72 |
| •○                 | SC    | 4   | COOPER LIGHTING<br>-McGRAW-EDISON<br>CM AM 150 MP 240<br>S8 BZ FF. BRONZE<br>FINISH.                                       | MEDIUM ARCHITECTURAL<br>AREA LUMINAIRE - TYPE<br>IV DISTRIBUTION WITH<br>HOUSE SIDE SHIELD.<br>POLE MOUNT AT +15'<br>FROM BOTTOM OF<br>FIXTURE TO FINISHED<br>FLOOR. | 150 WATT PULSE-START<br>CLEAR ED-17<br>HORIZONTAL BURN                          | CIS-150-MP-<br>XX-4S-HS.ies | 14000 0.72 |
| ○                  | SD    | 2   | LITHONIA<br>LIGHTING<br>WSR 50M WT 120<br>SF QRS. WALL<br>MOUNT AT +10'<br>A.F.F. DARK<br>BRONZE<br>TEXTURED FINISH.       | ARCHITECTURAL<br>SCONCE WITH WIDE<br>THROW DISTRIBUTION<br>WITH CLEAR, FLAT<br>GLASS LENS. CLEAR<br>LAMP. Meets the<br>'NIGHTTIME FRIENDLY'<br>Criteria              | ONE 50-WATT CLEAR ED-<br>17 METAL HALIDE,<br>HORIZONTAL POSITION.               | LTL11958C.ies               | 3450 0.72  |
| ○                  | SDE   | 1   | LITHONIA<br>LIGHTING<br>WSR 50M WT 120<br>SF ZELED XXX.<br>WALL MOUNT AT<br>+10' A.F.F. DARK<br>BRONZE<br>TEXTURED FINISH. | ARCHITECTURAL<br>SCONCE WITH WIDE<br>THROW DISTRIBUTION<br>WITH CLEAR, FLAT<br>GLASS LENS. CLEAR<br>LAMP. WITH 2 LED<br>BATTERY BACKUP                               | ONE 50-WATT CLEAR ED-<br>17 METAL HALIDE,<br>HORIZONTAL POSITION.               | LTL11958C.ies               | 3450 0.72  |
| •                  | SE    | 4   | LITHONIA<br>LIGHTING<br>KBC8 50M LV<br>120 LUP. DARK<br>BRONZE FINISH.                                                     | 8 IN ROUND BOLLARD<br>W/ LOUVERS                                                                                                                                     | ONE 50-WATT CLEAR<br>METAL HALIDE,<br>VERTICAL BASE-DOWN<br>POSITION.           | 94033106.ies                | 2250 0.72  |
| ➔                  | SF    | 8   | LITHONIA<br>LIGHTING<br>VSLC 1 32 SCE DL<br>GEB10IS                                                                        | ROUGH SERVICE<br>TAMPER-PROOF<br>SURFACE MOUNT. NOM.<br>5"X4" 1 LAMP T8<br>w/PRISMATIC<br>POLYCARBONATE LENS<br>3.13" DEEP (02/28/01)<br>ELECT                       | ONE 32-WATT T8 LINEAR<br>FLUORESCENT.                                           | LI9121.ies                  | 2850 0.75  |
| ○                  | SG    | 4   | INTENSE<br>LIGHTING<br>IFH6 226 E                                                                                          | AF 6" APERTURE OPEN<br>DOWNLIGHT 2/28DTT.                                                                                                                            | TWO 26-WATT DOUBLE<br>TWIN TUBE COMPACT<br>FLUORESCENT,<br>HORIZONTAL POSITION. | LTL10779.ies                | 1825 0.75  |
| ○                  | SGE   | 2   | INTENSE<br>LIGHTING<br>IFH6 226 E<br>EM-13                                                                                 | AF 6" APERTURE OPEN<br>DOWNLIGHT 2/28DTT<br>WITH BATTERY<br>BACKUP.                                                                                                  | TWO 26-WATT DOUBLE<br>TWIN TUBE COMPACT<br>FLUORESCENT,<br>HORIZONTAL POSITION. | LTL10779.ies                | 1825 0.75  |
| ○                  | SH    | 11  | INTENSE<br>LIGHTING<br>IFS7 26 E                                                                                           | AF 6" APERTURE OPEN<br>SHALLOW HOUSING                                                                                                                               | ONE 26-WATT TRIPLE<br>TUBE COMPACT<br>FLUORESCENT,<br>HORIZONTAL POSITION.      | LI9391.ies                  | 1800 0.75  |
| ○                  | SHE   | 8   | INTENSE<br>LIGHTING<br>IFS7 26 E<br>EM-13                                                                                  | AF 6" APERTURE OPEN<br>SHALLOW HOUSING<br>WITH BATTERY<br>BACKUP.                                                                                                    | ONE 26-WATT TRIPLE<br>TUBE COMPACT<br>FLUORESCENT,<br>HORIZONTAL POSITION.      | LI9391.ies                  | 1800 0.75  |
| ■                  | SI    | 6   | COLE<br>LIGHTING<br>F 2156 J W EB B PM                                                                                     | RECESSED WALL<br>STEP LIGHT                                                                                                                                          | ONE 13W CFL.                                                                    | 69111a.ies                  | 900 0.75   |
| ▼                  | SJ    | 46  | WINONA -<br>4115 N. 31TH AVE<br>WI 48 120V LD<br>BRS FO SHO C3<br>STD WITH<br>WI PM-60                                     | GROUND MOUNT<br>BULLET LIGHT<br>WITH GLARE<br>SHIELD WITH<br>BRONZE SMOOTH<br>FINISH.                                                                                | ONE 50W MAX.<br>PAR20/FL30 LAMP                                                 | FOR LOCATION PURPOSES ONLY. |            |
| ▼                  | SK    | 5   | TROY LIGHTING<br>F435 A<br>20W/L-JCB-20 PBZ<br>(BRONZE FINISH).                                                            | FLOOD LIGHT WITH<br>GLARE SHIELD AND<br>PERMA POST<br>MOUNTING DEVICE                                                                                                | ONE 20W MAX.<br>B-P/M Q4 QUARTZ<br>HALOGEN LAMP.                                | FOR LOCATION PURPOSES ONLY. |            |
| ○                  | SL    | 4   | INTENSE<br>LIGHTING<br>IFS7 13 E                                                                                           | AF 6" APERTURE OPEN<br>SHALLOW HOUSING<br>WITH LENS. U.L.<br>LISTED FOR WET<br>LOCATION.                                                                             | ONE 13-WATT<br>COMPACT<br>FLUORESCENT,<br>HORIZONTAL POSITION.                  | 69111a.ies                  | 900 0.75   |

| STATISTICS                      |        |        |        |        |         |         |
|---------------------------------|--------|--------|--------|--------|---------|---------|
| Description                     | Symbol | Avg    | Max    | Min    | Max/Min | Avg/Min |
| SITE                            | +      | 1.3 fc | 7.7 fc | 0.0 fc | N/A     | N/A     |
| SPILL LIGHTS AT +6 FT<br>A.F.F. | ✕      | 0.1 fc | 0.3 fc | 0.0 fc | N/A     | N/A     |

Copyright © 2010 by NP ENGINEERING, INC.  
This drawing is an instrument of service. It  
is the property of NP ENGINEERING, INC. The  
contents or any accompanying specifications  
shall not be altered or reproduced without  
the written permission of NP ENGINEERING, INC.

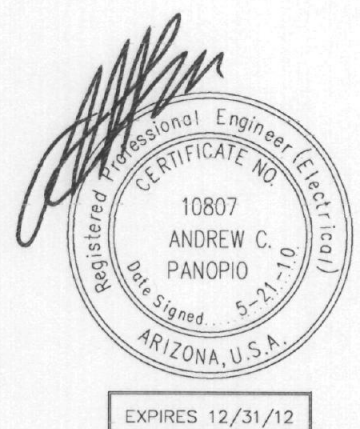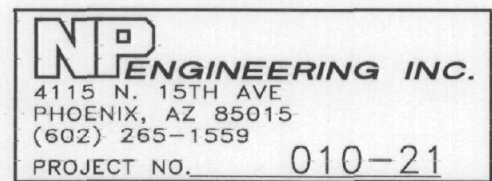

Asante of Scottsdale  
Scottsdale, Arizona  
Sante Partners, LLC



TODD & ASSOCIATES, INC.  
ARCHITECTURE 602.952.8280p PLANNING 602.952.8995f LANDSCAPE ARCHITECTURE www.toddassoc.com

Project No. 09-7017-00  
Date: 05-21-10  
DRB SUBMITTAL

PHOTOMETRIC SITE PLAN  
E1.2

48-DR-2010  
2nd: 5/21/10

Photometric