
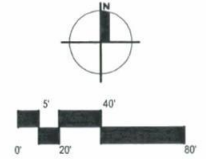


Owner:
FLW 101, LLC
PO Box 182144
Coronado, CA 92178
(619) 435 - 6000
Contact: Perry Koon

Architect:
Butler Design Group
5555 E. Van Buren, Ste 100
Phoenix, AZ 85008
(602) 957-1800
Contact: Korey Wilkes
Todd Lawrence


VICINITY MAP

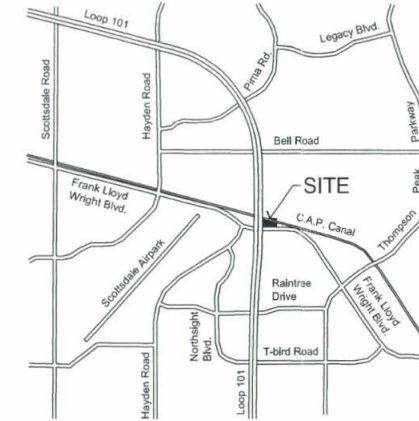

Pre App. Case Number:	476-PA-10
Site Area:	184,665 sf (4.24 ac)
Building Area:	33,370 sf
Coverage:	18.1 %
Parking Ratio:	6.0 / 1,000
Parking Required:	
33,370 / 300 =	112 Spaces
Parking Provided:	201 Spaces
Acc. Parking Required:	
201 x 4% =	9 Spaces
Acc. Parking Provided:	10 Spaces
Bike Parking Required:	
112 / 10 =	12 Spaces
Bike Parking Provided:	12 Spaces

Open Space Required:
24' building height = 10% for 12' ht.
+ 0.4 per ea. ft over = 14.8%
184,665 sf x 0.148 = 27,330 sf

37,557 sf Provided including Frontage
Open Space

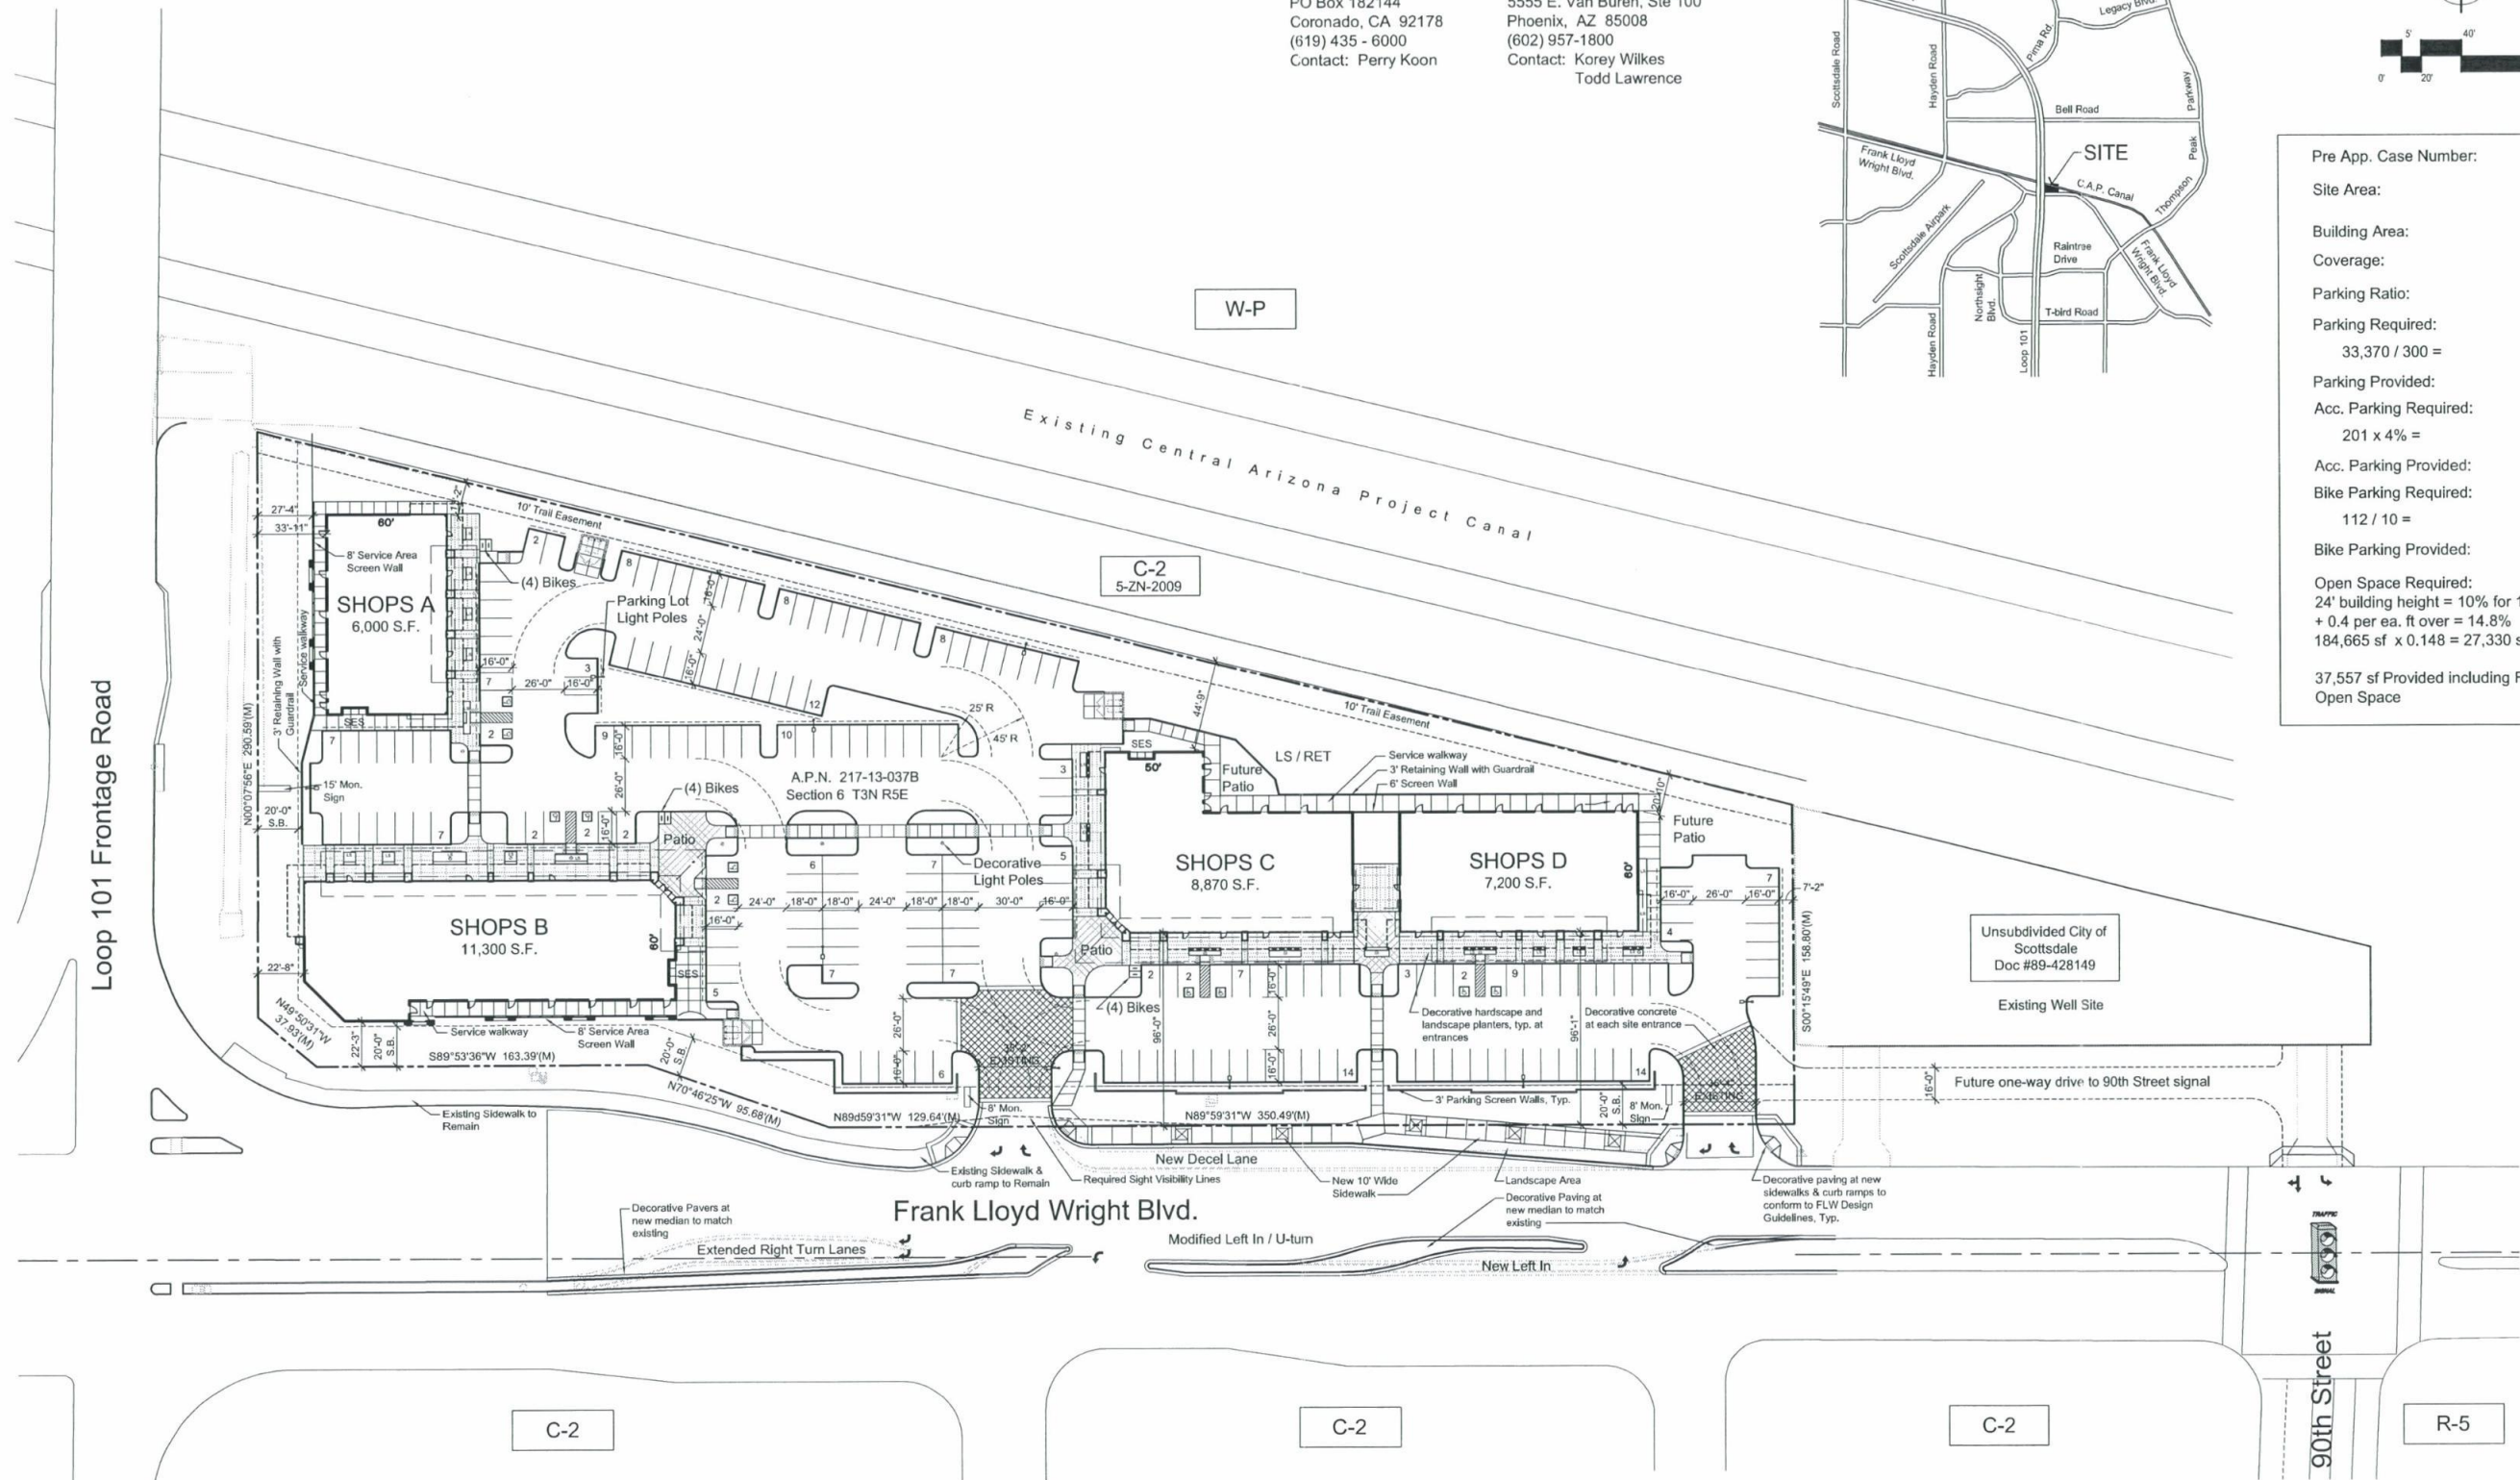

Gateway 101

FLW 101 LLC

15815 E Frank Lloyd Wright Blvd.
Scottsdale, Arizona 85260

10-07-10 10086 ST-11

Site Plan




92-DR-2010
1st: 10/07/10



East Elevation

North Elevation

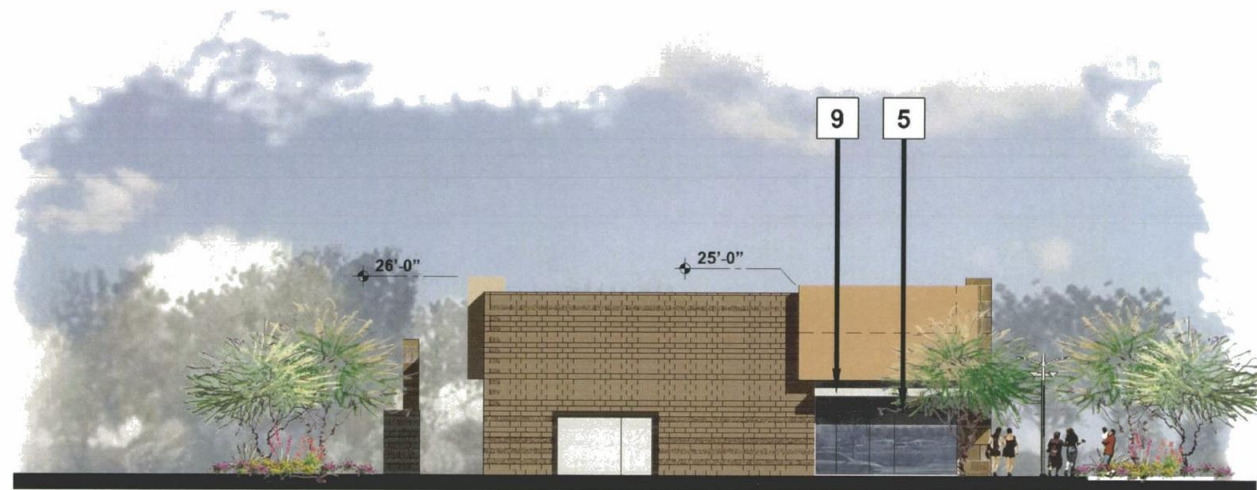

South Elevation



West Elevation

FLW 101 LLC

Gateway 101

NEC Frank Lloyd Wright Blvd. & Loop 101
Scottsdale, Arizona 85260

10.07.10

Shops A

Scale: 3/32" = 1'-0"

92-DR-2010
1st: 10/07/10



North Elevation



East Elevation



West Elevation



South Elevation

FLW 101 LLC

Gateway 101

NEC Frank Lloyd Wright Blvd. & Loop 101
Scottsdale, Arizona 85260

10.07.10

Shops B


Scale: 3/32" = 1'-0"

92-DR-2010
1st: 10/07/10





South Elevation

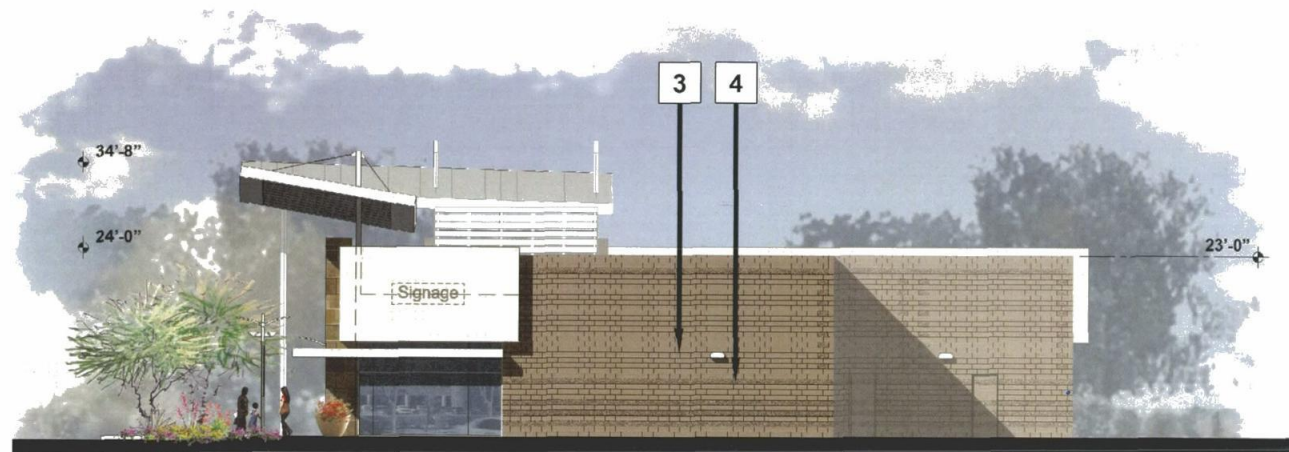

East Elevation



West Elevation



North Elevation

FLW 101 LLC

Gateway 101



NEC Frank Lloyd Wright Blvd. & Loop 101
Scottsdale, Arizona 85260

10.07.10

Shops C, D

Scale: 3/32" = 1'-0"

010086
Bd
g
Butler Design Group, Inc.
architects & planners

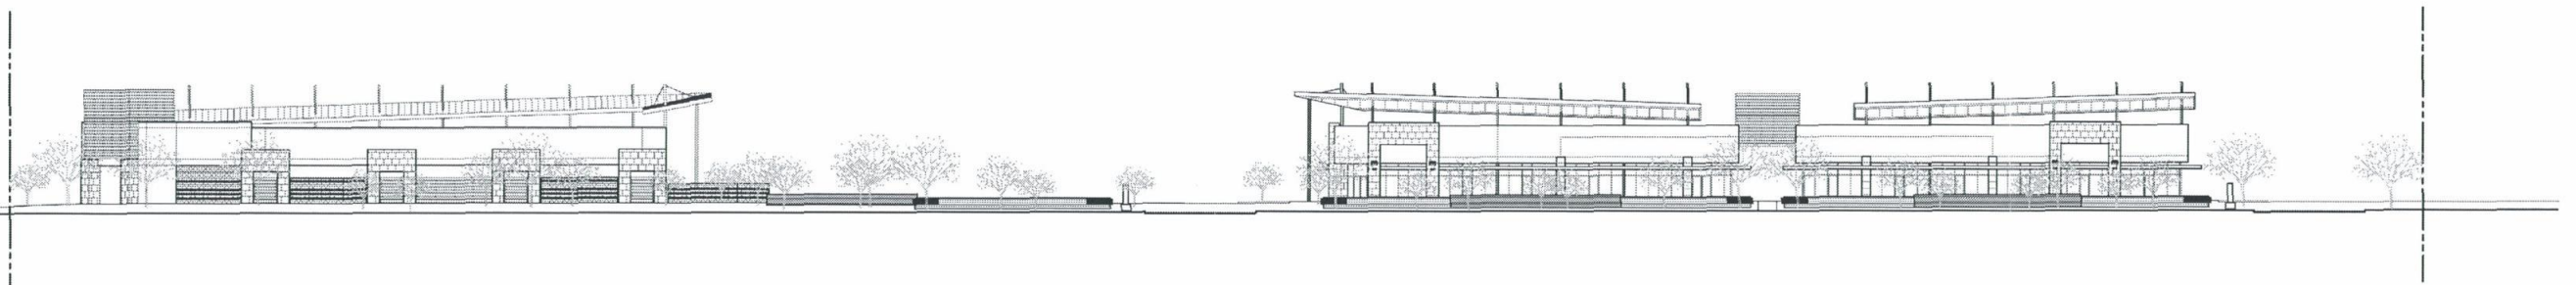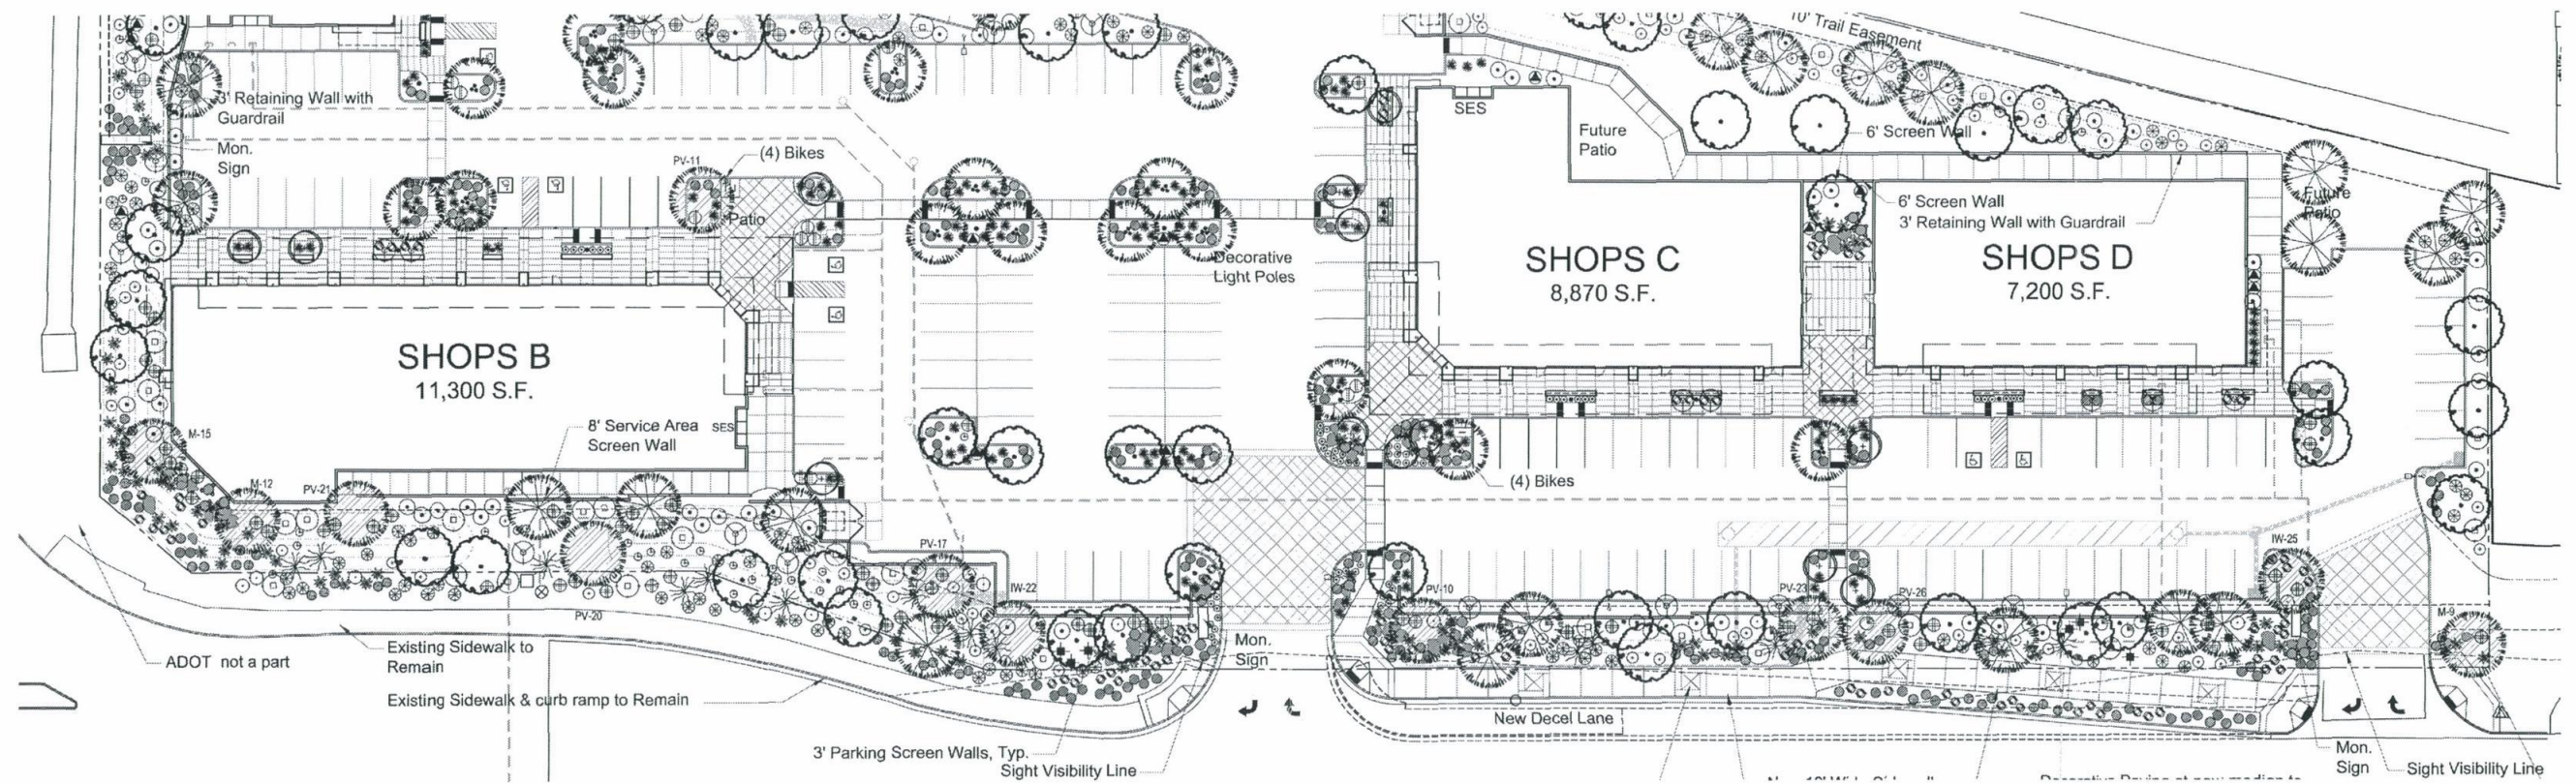

Gateway 101

FLW 101 LLC

15815 E Frank Lloyd Wright Blvd.
Scottsdale, Arizona 85260

10-07-10 10086 ST-11

Streetscape Elevation



92-DR-2010
1st: 10/07/10



Gateway 101

FLW 101 LLC


15815 E Frank Lloyd Wright Blvd.
Scottsdale, Arizona 85260

09-22-10 10086 ST-10


Combined Context Aerial
and Context Site Plan



92-DR-2010
1st: 10/07/10

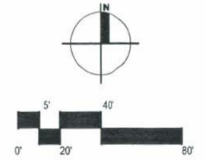

Open Space Required: 24' building height = 10% for 12' ht. + 0.4 per ea. ft over = 14.8% 184,665 sf x 0.148 = 27,330 sf 16,224 sf Provided (non-frontage open space) 37,557 sf Provided including Frontage Open Space = OK
Front Open Space Required: 27,330 sf / 2 = 13,665 sf 21,333 sf Provided = OK
Parking Area: 57,001 sf Provided
Parking Landscape Area Required: 57,001 sf x 15% = 8,550 sf 10,664 sf Provided = OK

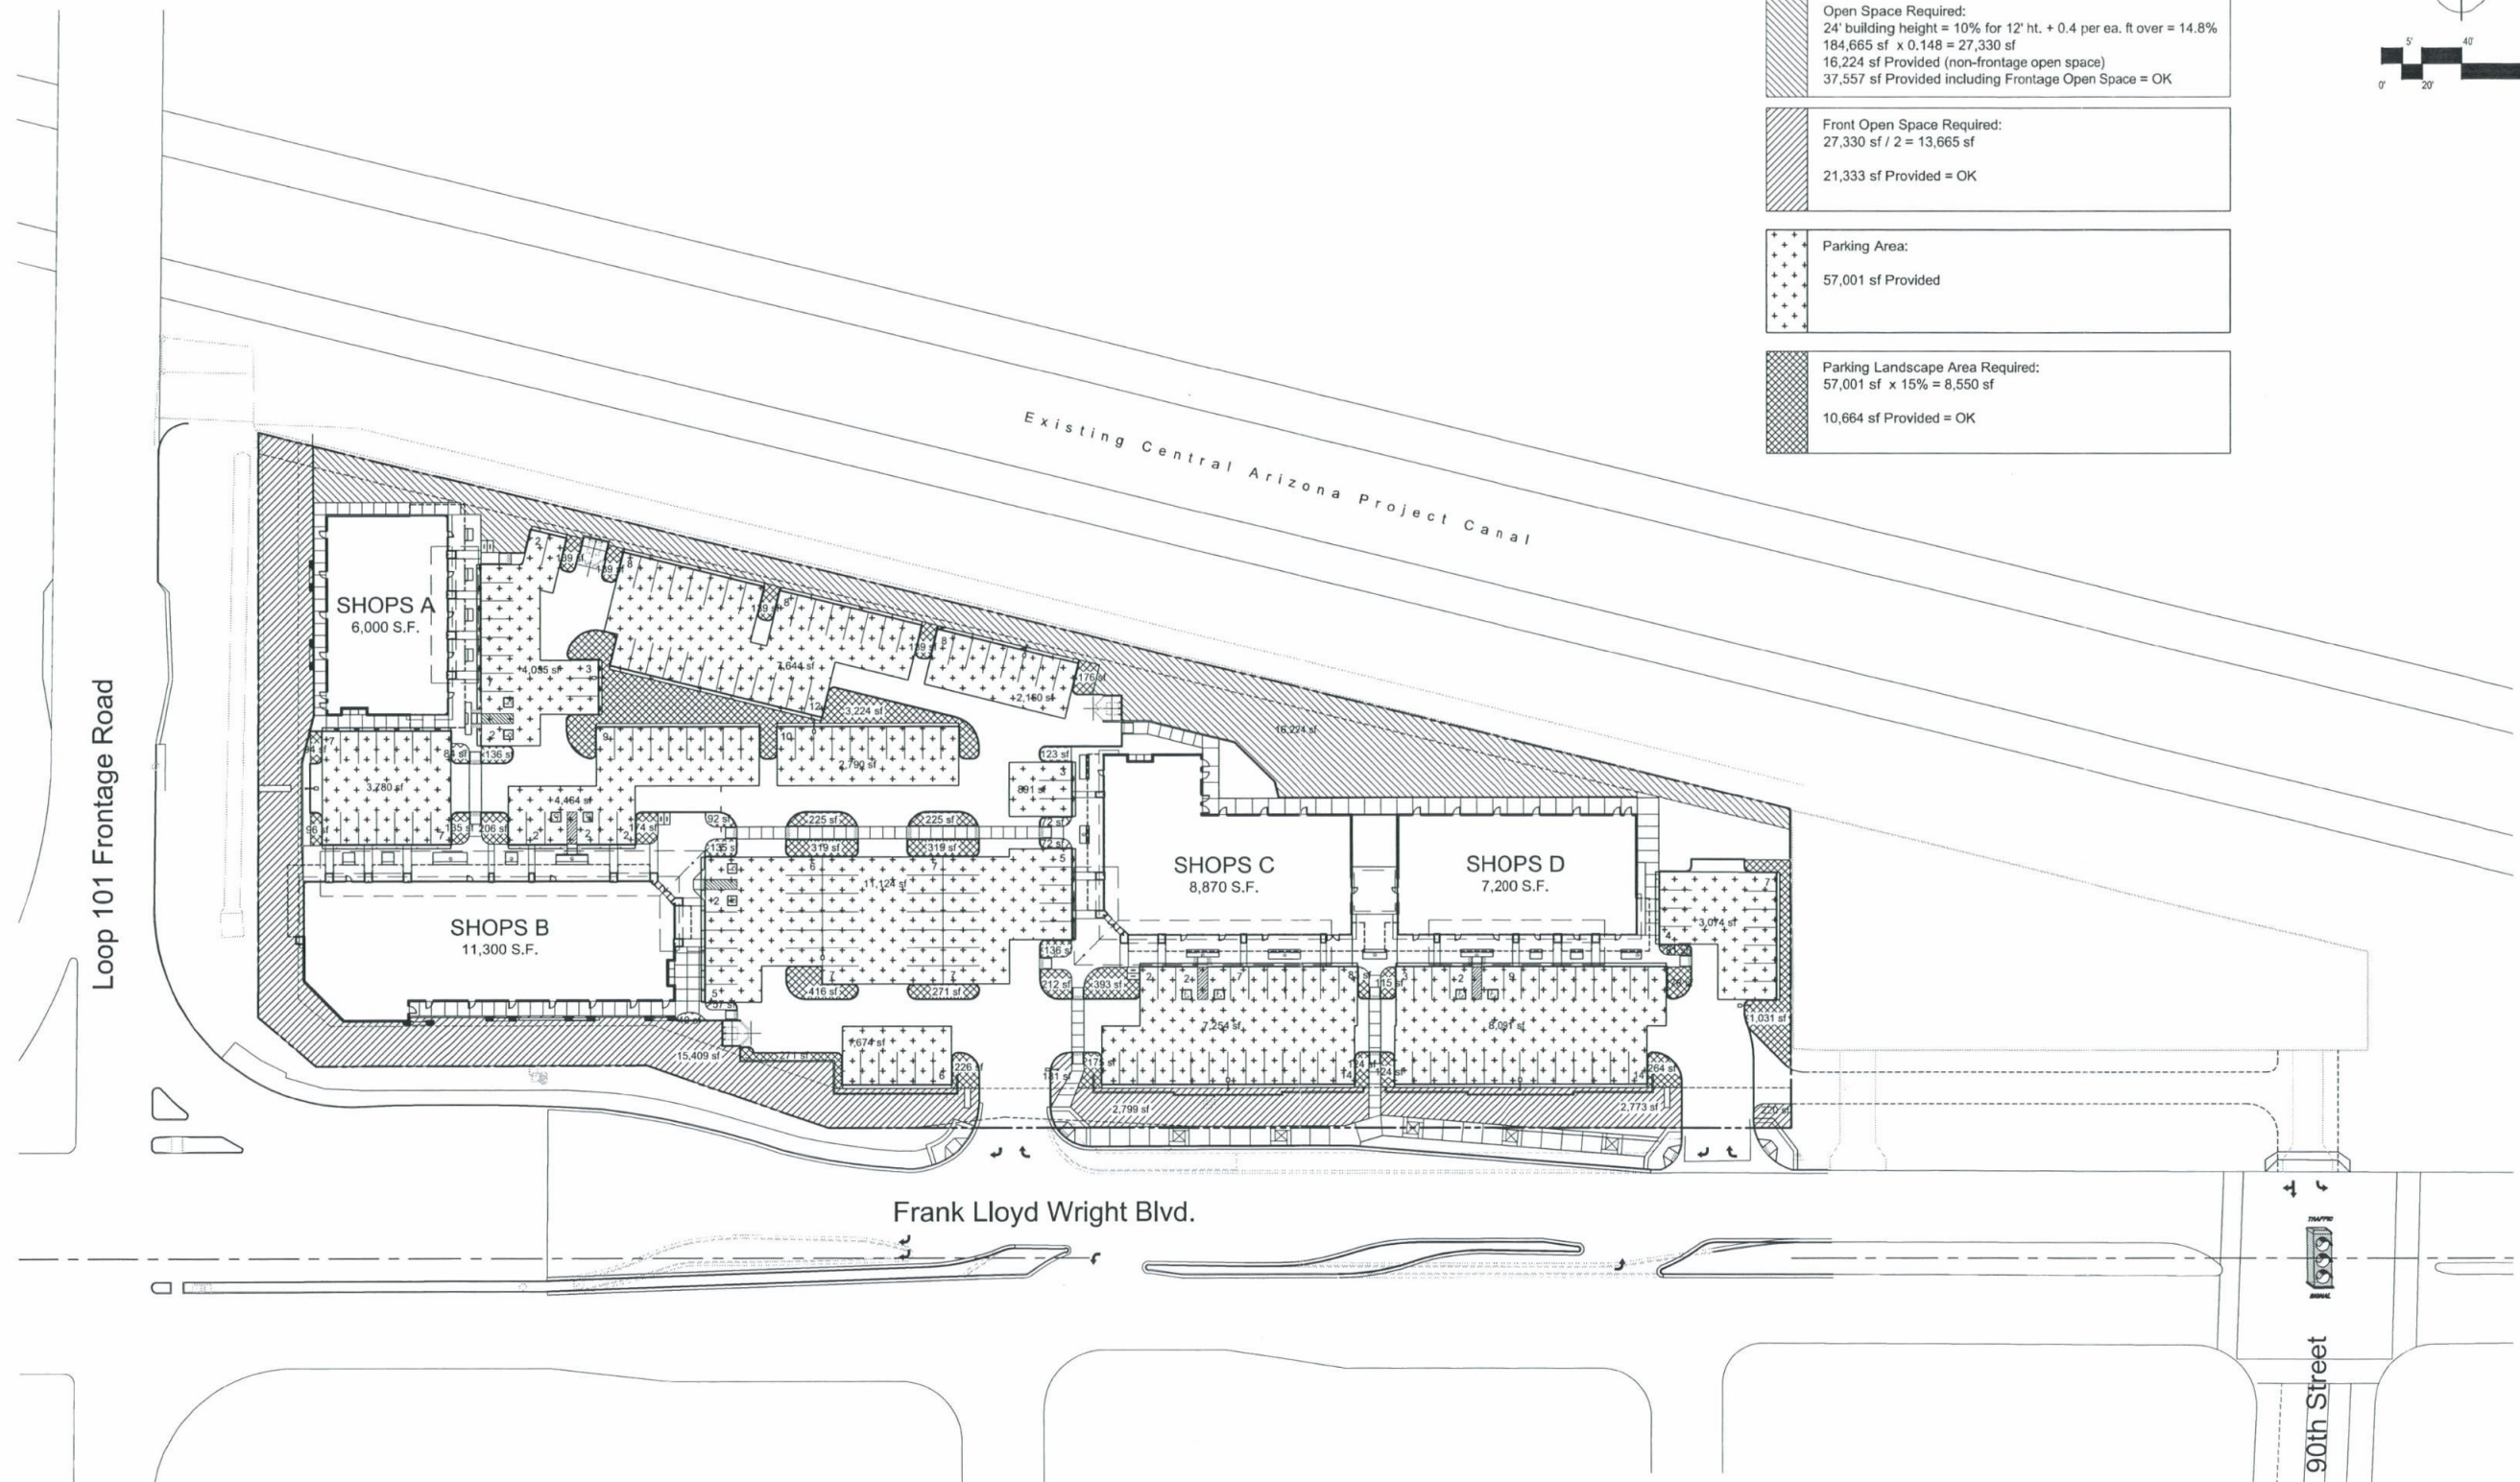

Gateway 101

FLW 101 LLC


15815 E Frank Lloyd Wright Blvd.
 Scottsdale, Arizona 85260

10-07-10 10086 ST-11

Site Plan Worksheet





92-DR-2010
 1st: 10/07/10

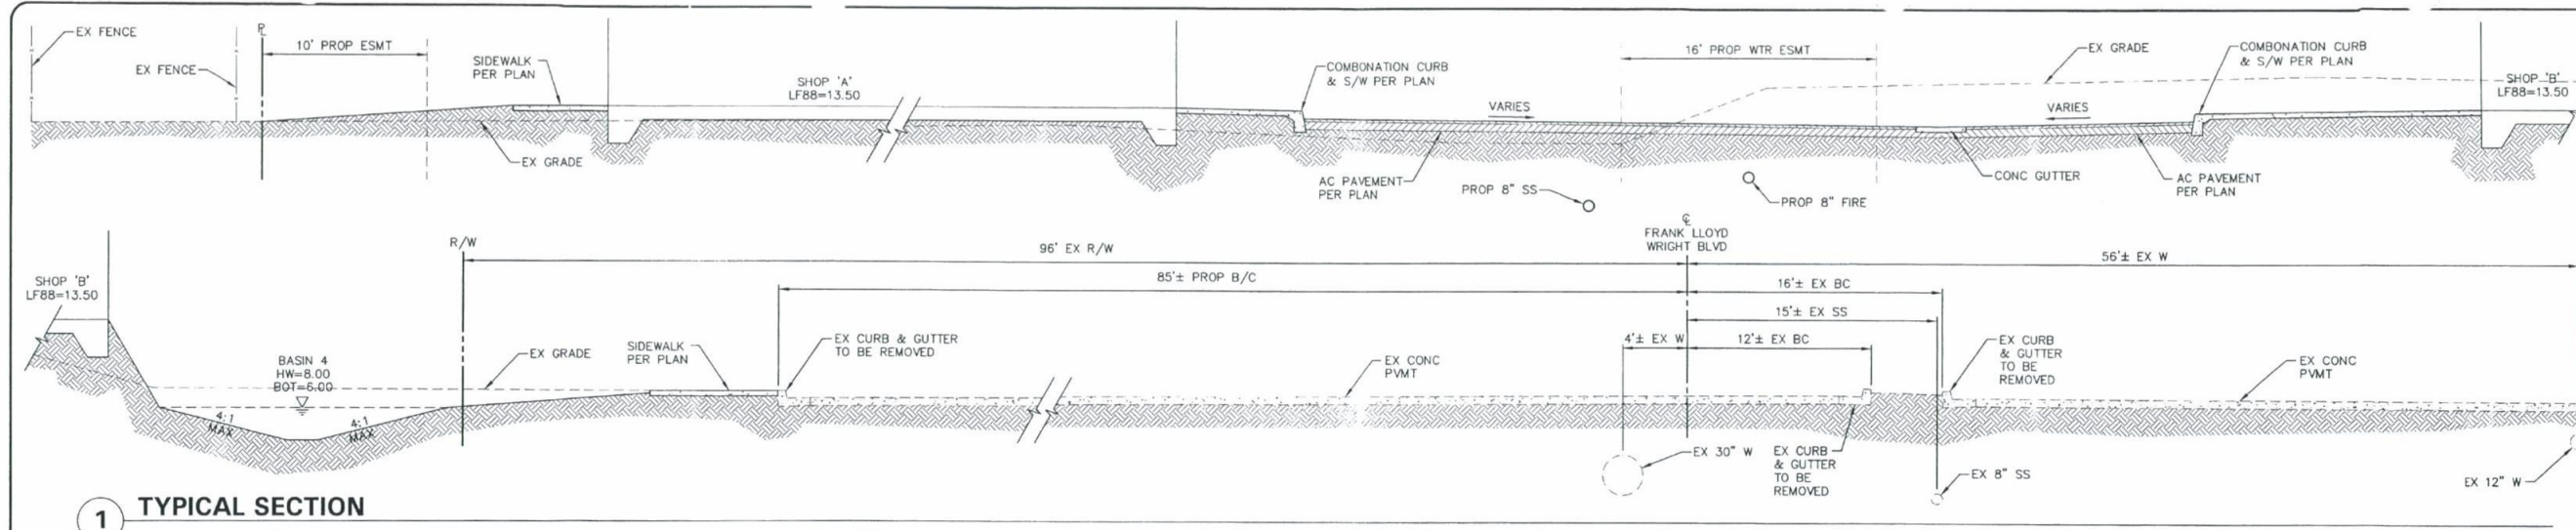

NO.	DATE	REVISION	BY

DESIGN BY: LMT
DRAWN BY: JGC
CHECKED BY: LMT

CIVIL AND SURVEY
HUNTER ENGINEERING
10450 NORTH 74TH STREET, SUITE 200
SCOTTSDALE, AZ 85258
P 480 991 3586
F 480 991 3586

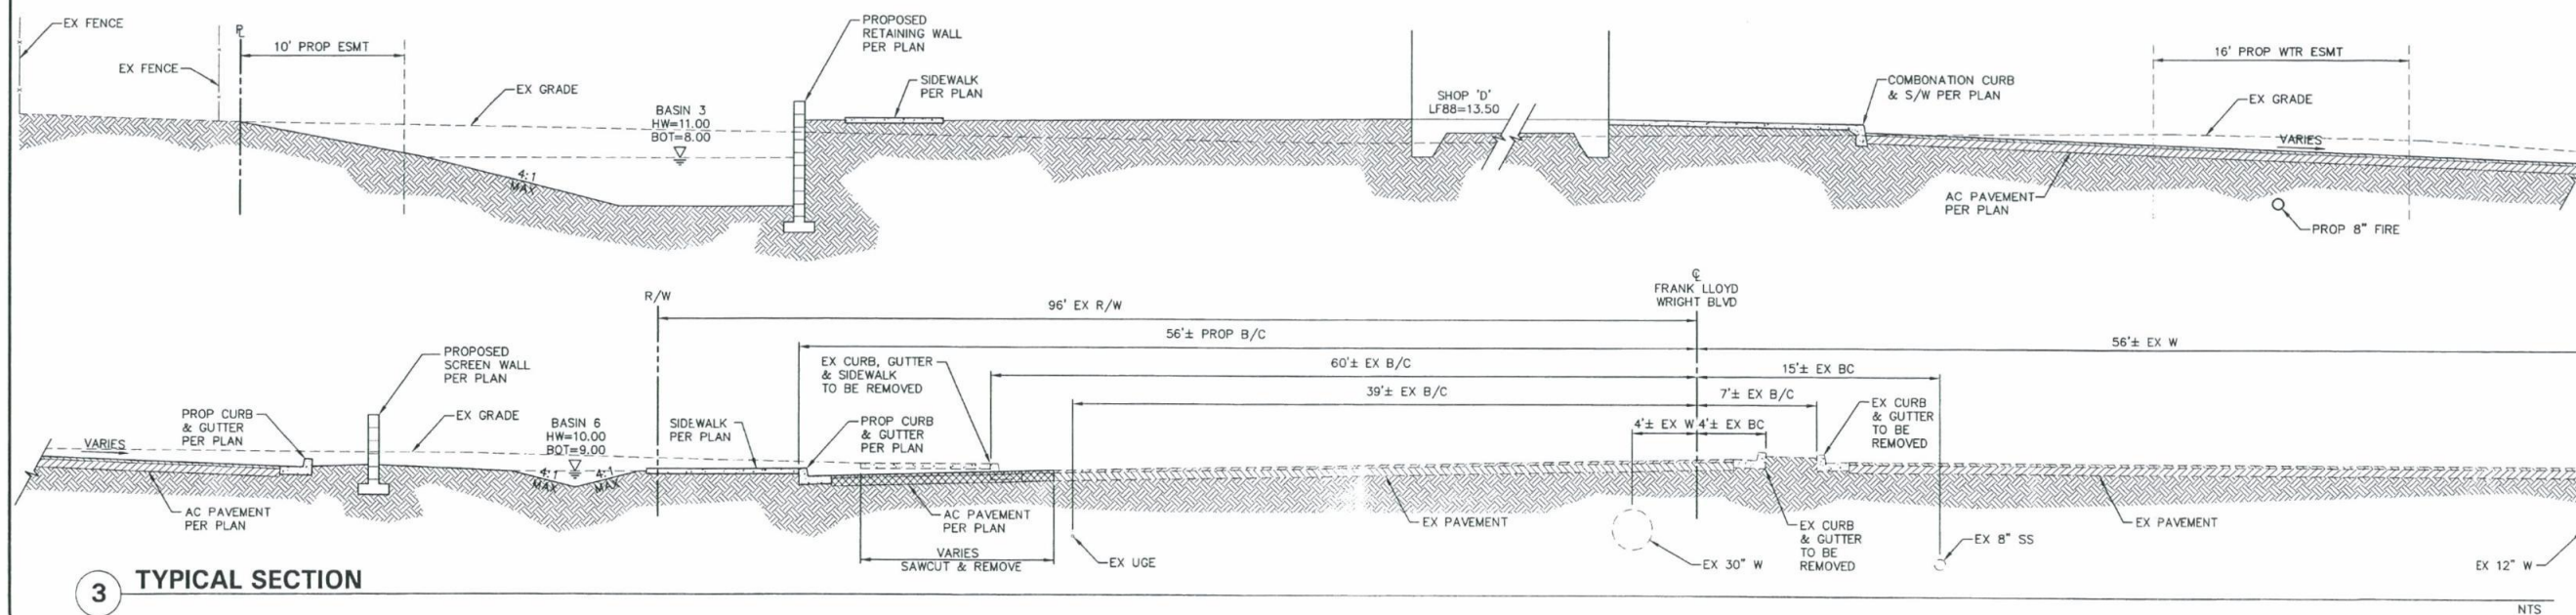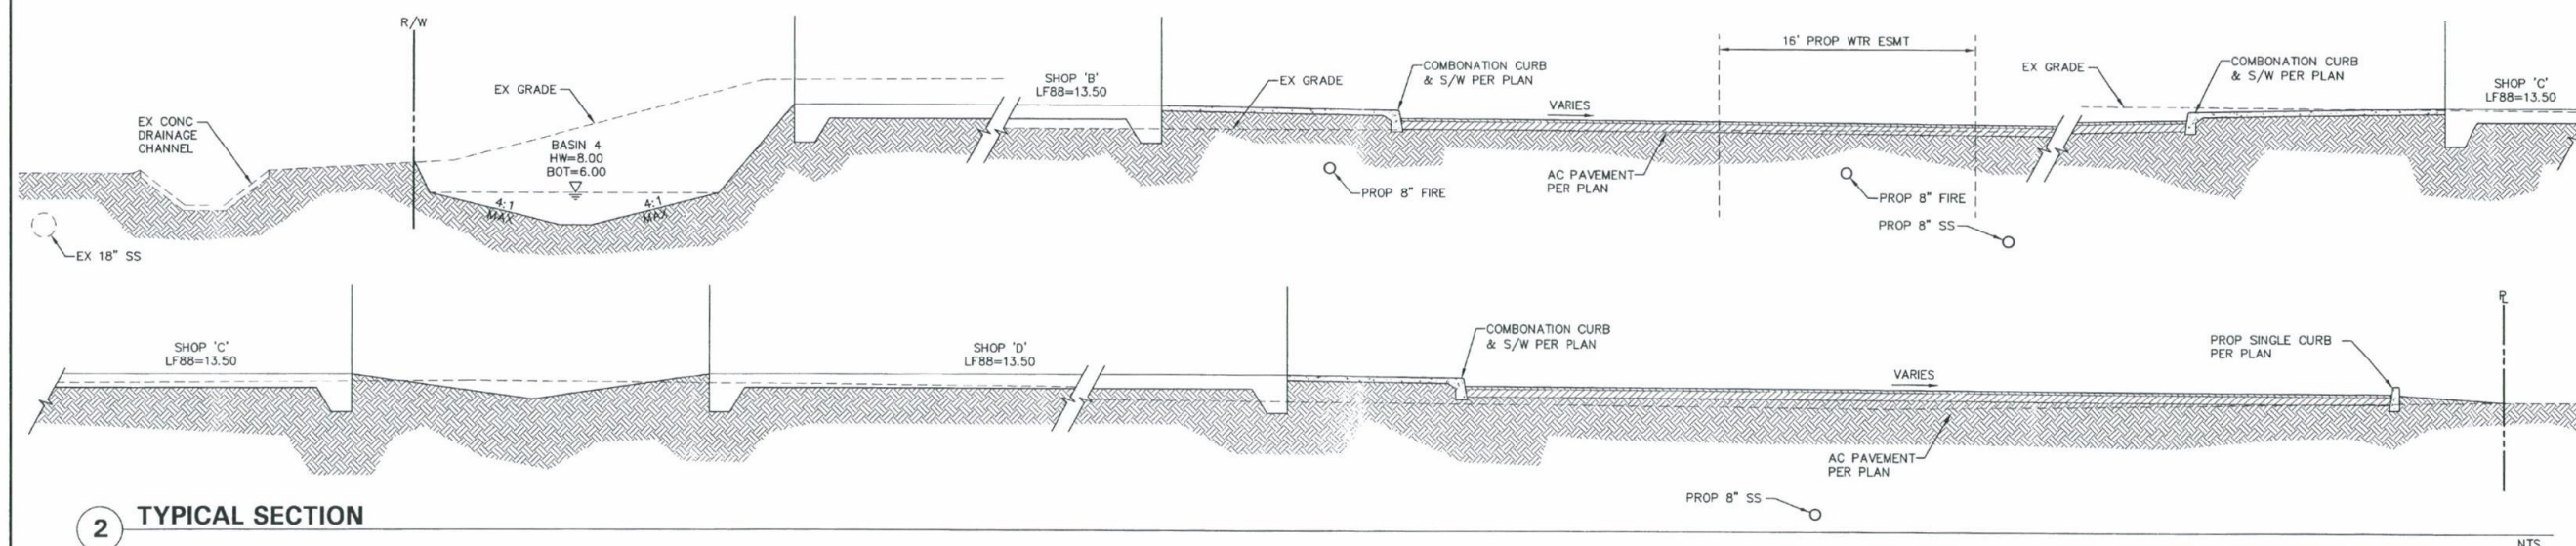

CONCEPTUAL TYPICAL SECTIONS
FOR
GATEWAY 101
NEC FRANK LLOYD WRIGHT BLVD. & LOOP 101
SCOTTSDALE, ARIZONA

THESE PLANS ARE NOT APPROVED FOR CONSTRUCTION WITHOUT AN APPROVED SIGNATURE FROM THE GOVERNING MUNICIPALITY.





HE JOB NO.:
PERR101

SCALE
1"=30'

SHEET
C2

2 OF 3

92-DR-2010
1st: 10/07/10

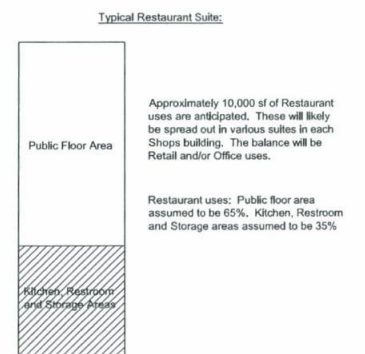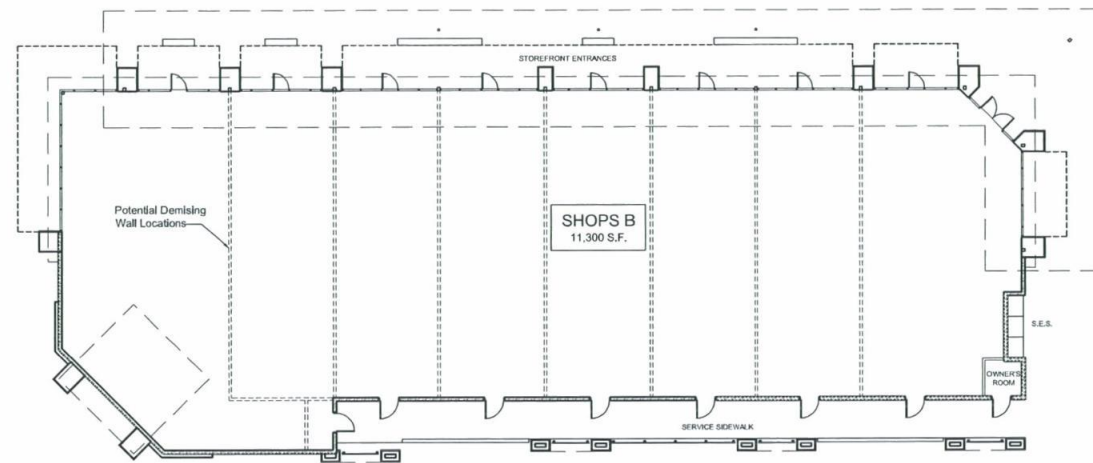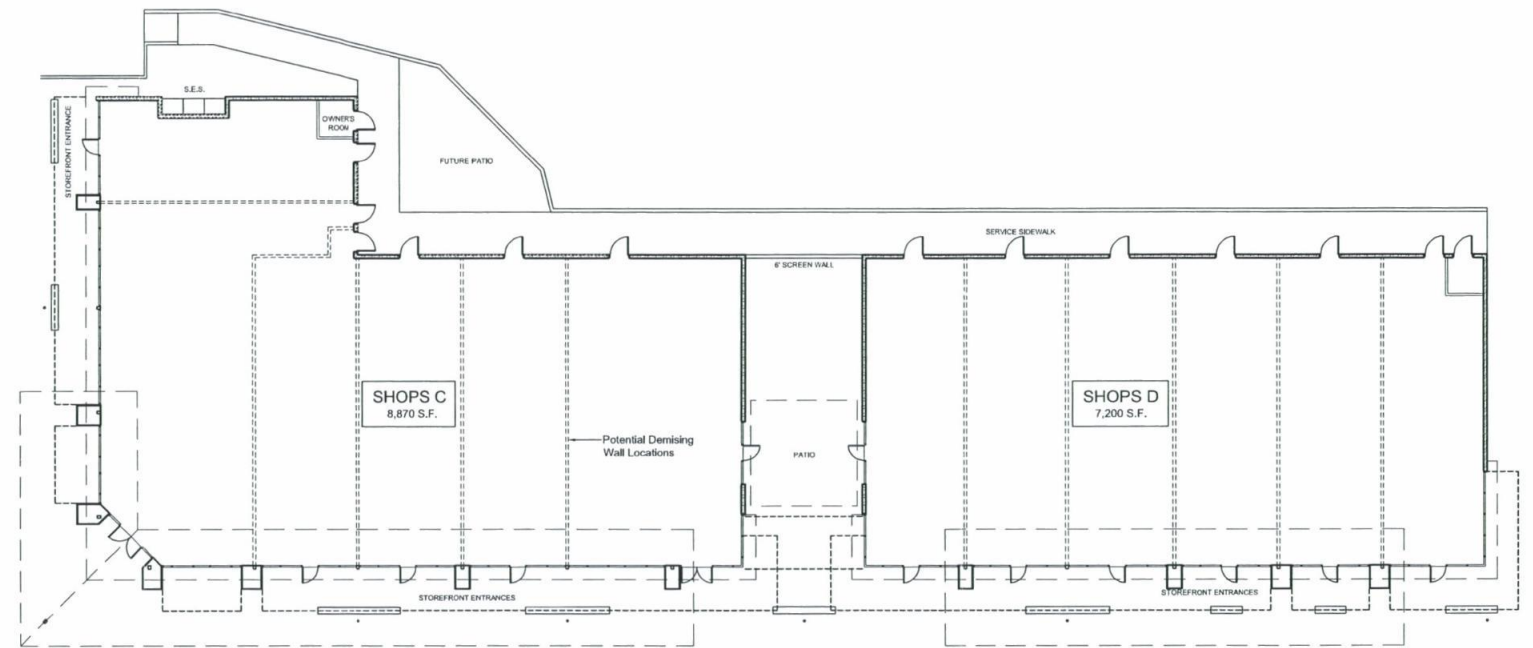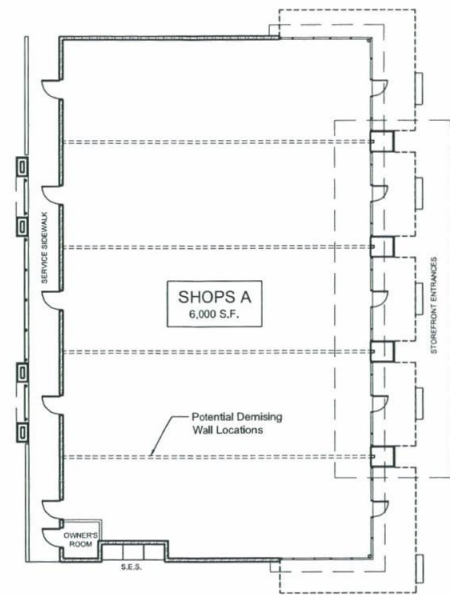

Floor Plans
SCALE: 1/16" = 1'-0"



FLW 101 LLC

Gateway 101


15815 E. Frank Lloyd Wright Blvd.
Scottsdale, Arizona 85260

10-07-10 10086 FP-02


Floor Plans and
Worksheet




92-DR-2010
1st: 10/07/10

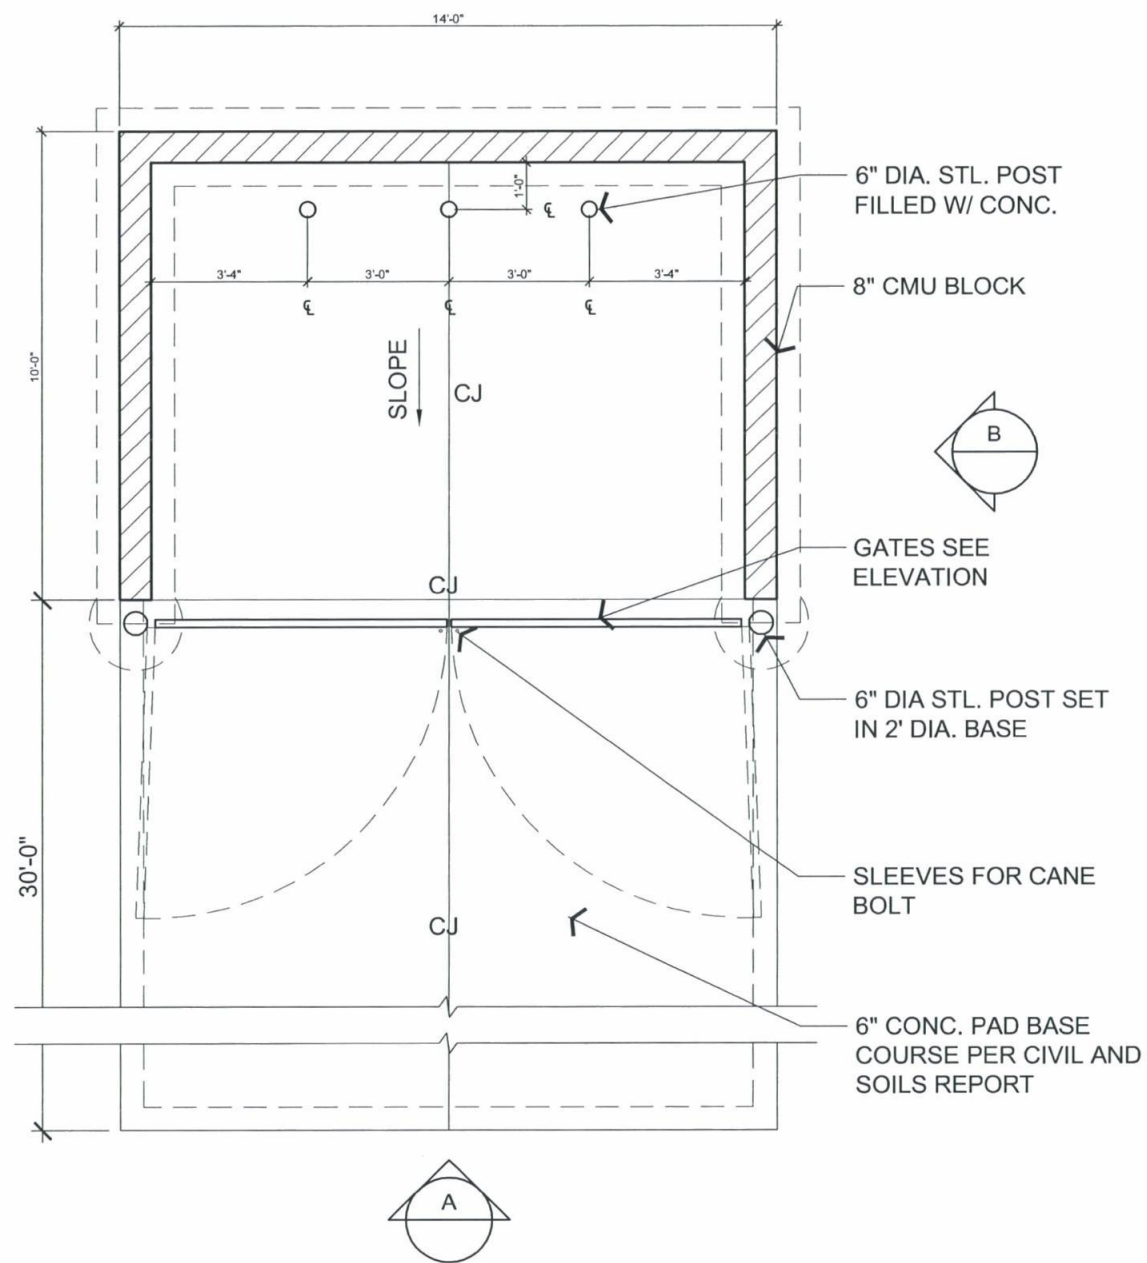


REFUSE ENCLOSURE TYPICAL PLAN
SCALE: 1/4" = 1'-0"

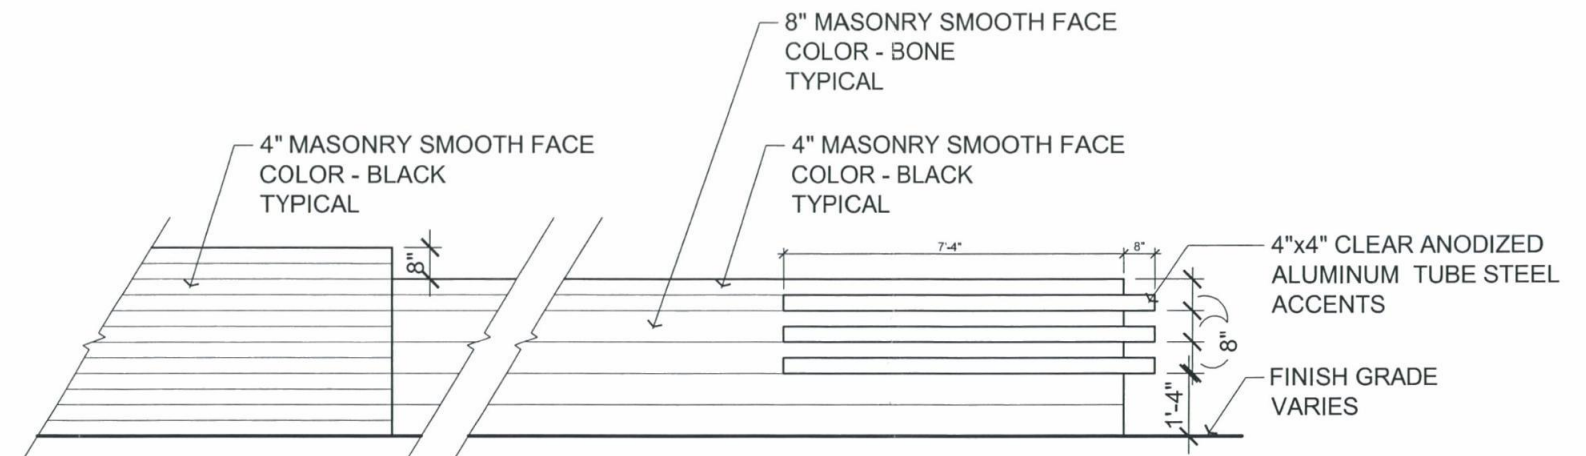

TYPICAL RETAINING WALL ELEVATION
SCALE: 1/4" = 1'-0"

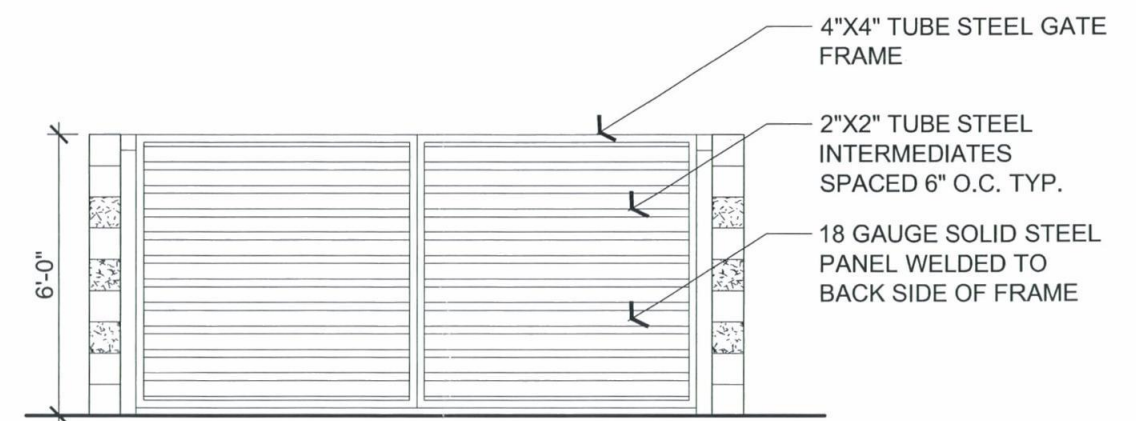

REFUSE ENCLOSURE ELEVATION A
SCALE: 1/4" = 1'-0"

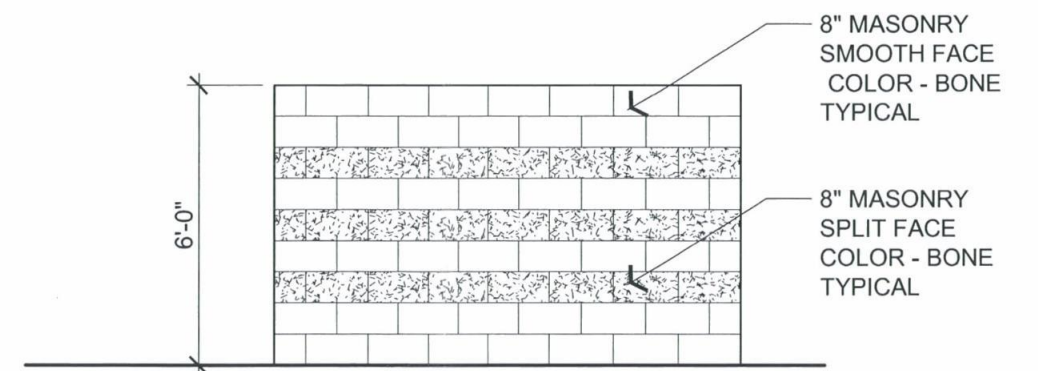

REFUSE ENCLOSURE ELEVATION B
SCALE: 1/4" = 1'-0"

Gateway 101

FLW 101 LLC




15815 E Frank Lloyd Wright Blvd.
Scottsdale, Arizona 85260

10-07-10 10086 ST-11

92-DR-2010
1st: 10/07/10

DETAILS

Bdg
Butler Design Group
Architects & Planners

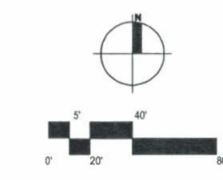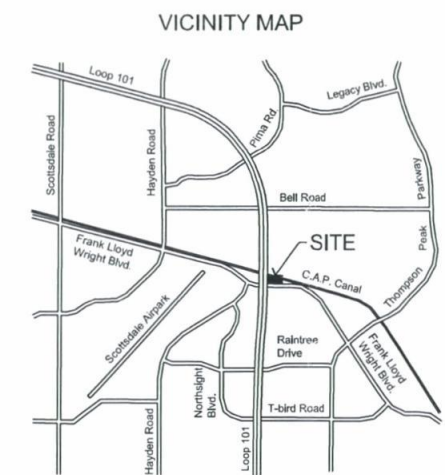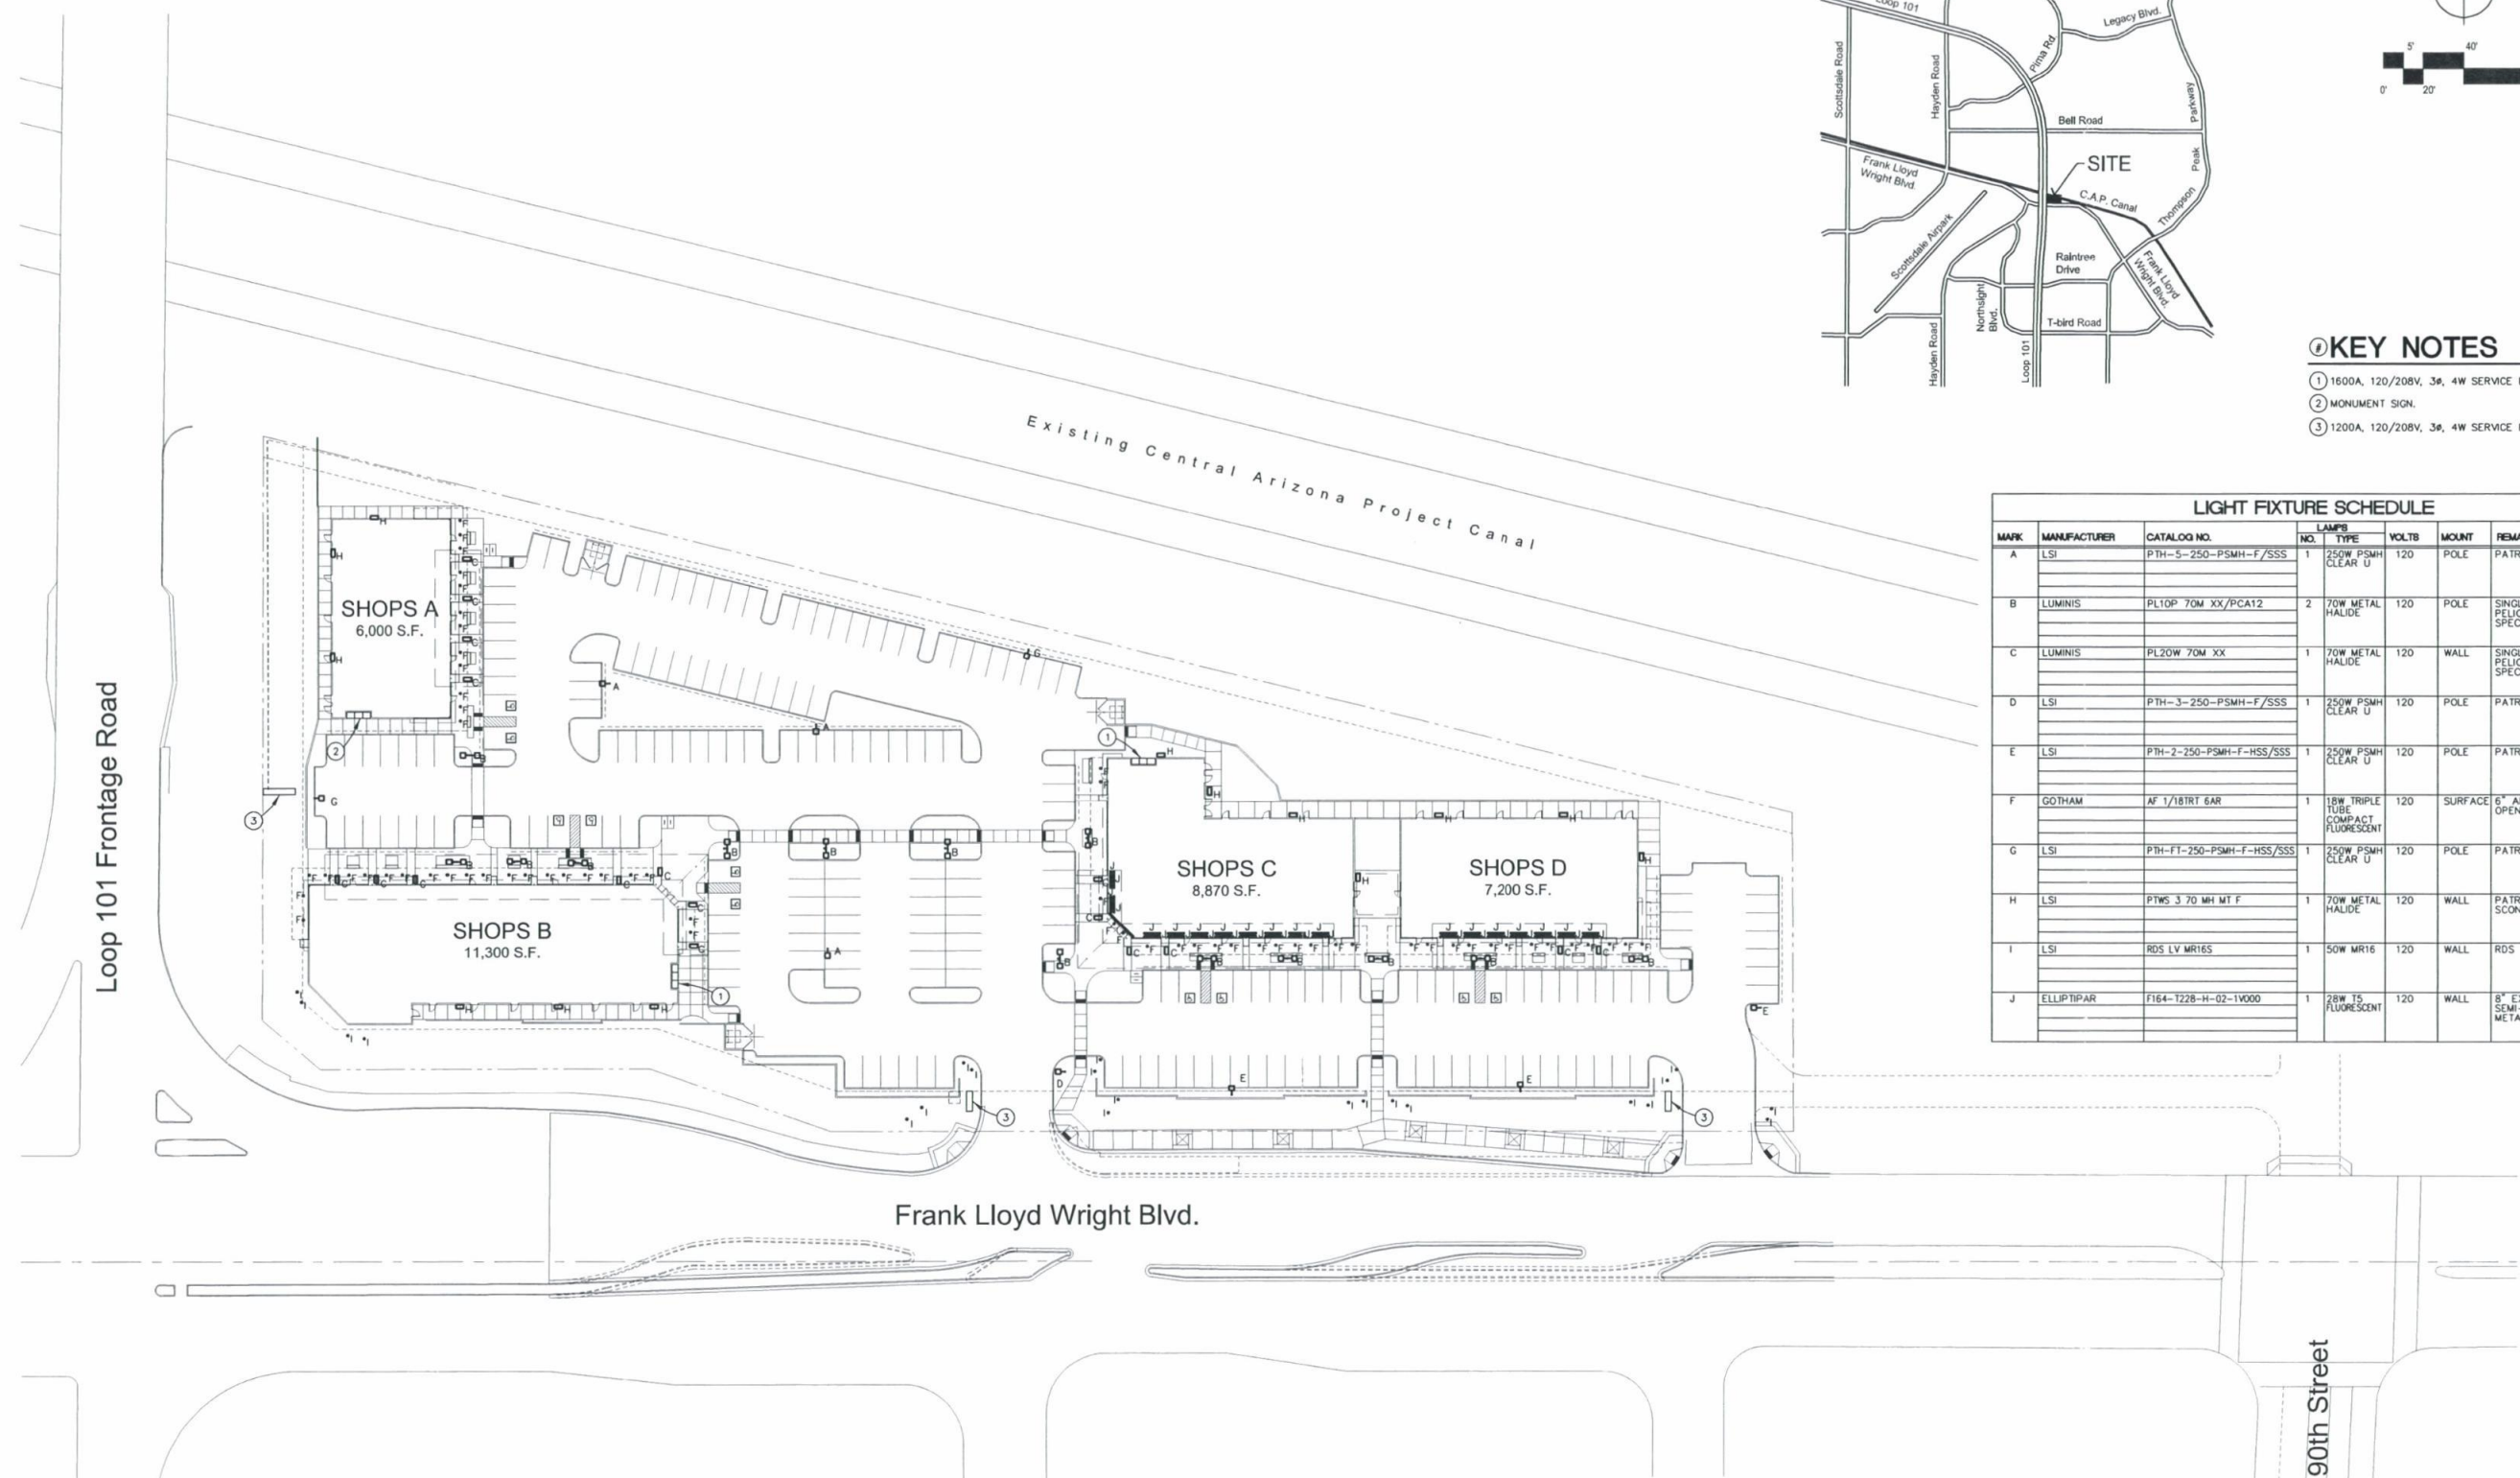

- KEY NOTES**
- 1 1600A, 120/208V, 3Ø, 4W SERVICE ENTRANCE SECTION.
 - 2 MONUMENT SIGN.
 - 3 1200A, 120/208V, 3Ø, 4W SERVICE ENTRANCE SECTION.

LIGHT FIXTURE SCHEDULE						
MARK	MANUFACTURER	CATALOG NO.	LAMP NO.	TYPE	VOLTS	MOUNT
A	LSI	PTH-S-250-PSMH-F/SSS	1	250W PSMH CLEAR U	120	POLE
B	LUMINIS	PL10P 70M XX/PCA12	2	70W METAL HALIDE	120	POLE
C	LUMINIS	PL20W 70M XX	1	70W METAL HALIDE	120	WALL
D	LSI	PTH-S-250-PSMH-F/SSS	1	250W PSMH CLEAR U	120	POLE
E	LSI	PTH-S-250-PSMH-F/SSS	1	250W PSMH CLEAR U	120	POLE
F	GOHAM	AF 1/18T12 6AR	1	18W TRIPLE TUBE COMPACT FLUORESCENT	120	SURFACE
G	LSI	PTH-F1-250-PSMH-F-HSS/SSS	1	250W PSMH CLEAR U	120	POLE
H	LSI	PTWS 3 70 MH MT F	1	70W METAL HALIDE	120	WALL
I	LSI	RDS LV MR16S	1	50W MR16	120	WALL
J	ELLIPTIPAR	F164-T22B-H-02-1V000	1	28W T5 FLUORESCENT	120	WALL
						REMARKS
						PATRIOT
						SINGLE POLE MTG. PELICAN WITH SPECULAR REFLECTOR
						SINGLE WALL MTG. PELICAN WITH SPECULAR REFLECTOR
						PATRIOT
						PATRIOT
						6" APERTURE OPEN DOWNLIGHT
						PATRIOT
						PATRIOT SMALL WALL SCONCE
						RDS
						8" EXTRUDED SEMI-SPECULAR METAL REFLECTOR

FLW 101 LLC

Gateway 101

15815 E Frank Lloyd Wright Blvd.
Scottsdale, Arizona 85260


10-07-10 10086 ST-11

McGraw Consulting Engineers, LLC
ELECTRICAL ENGINEERING
7468 N. MONTE CRISTO AVE., #2
SCOTTSDALE, ARIZONA 85250
PHONE (602) 331-9114 FAX (602) 331-9127
WEI JOB #: 10120



E1
Site
Lighting
Plan
Bd
Butler Design Group
Architects & Planners

92-DR-2010
1st: 10/07/10

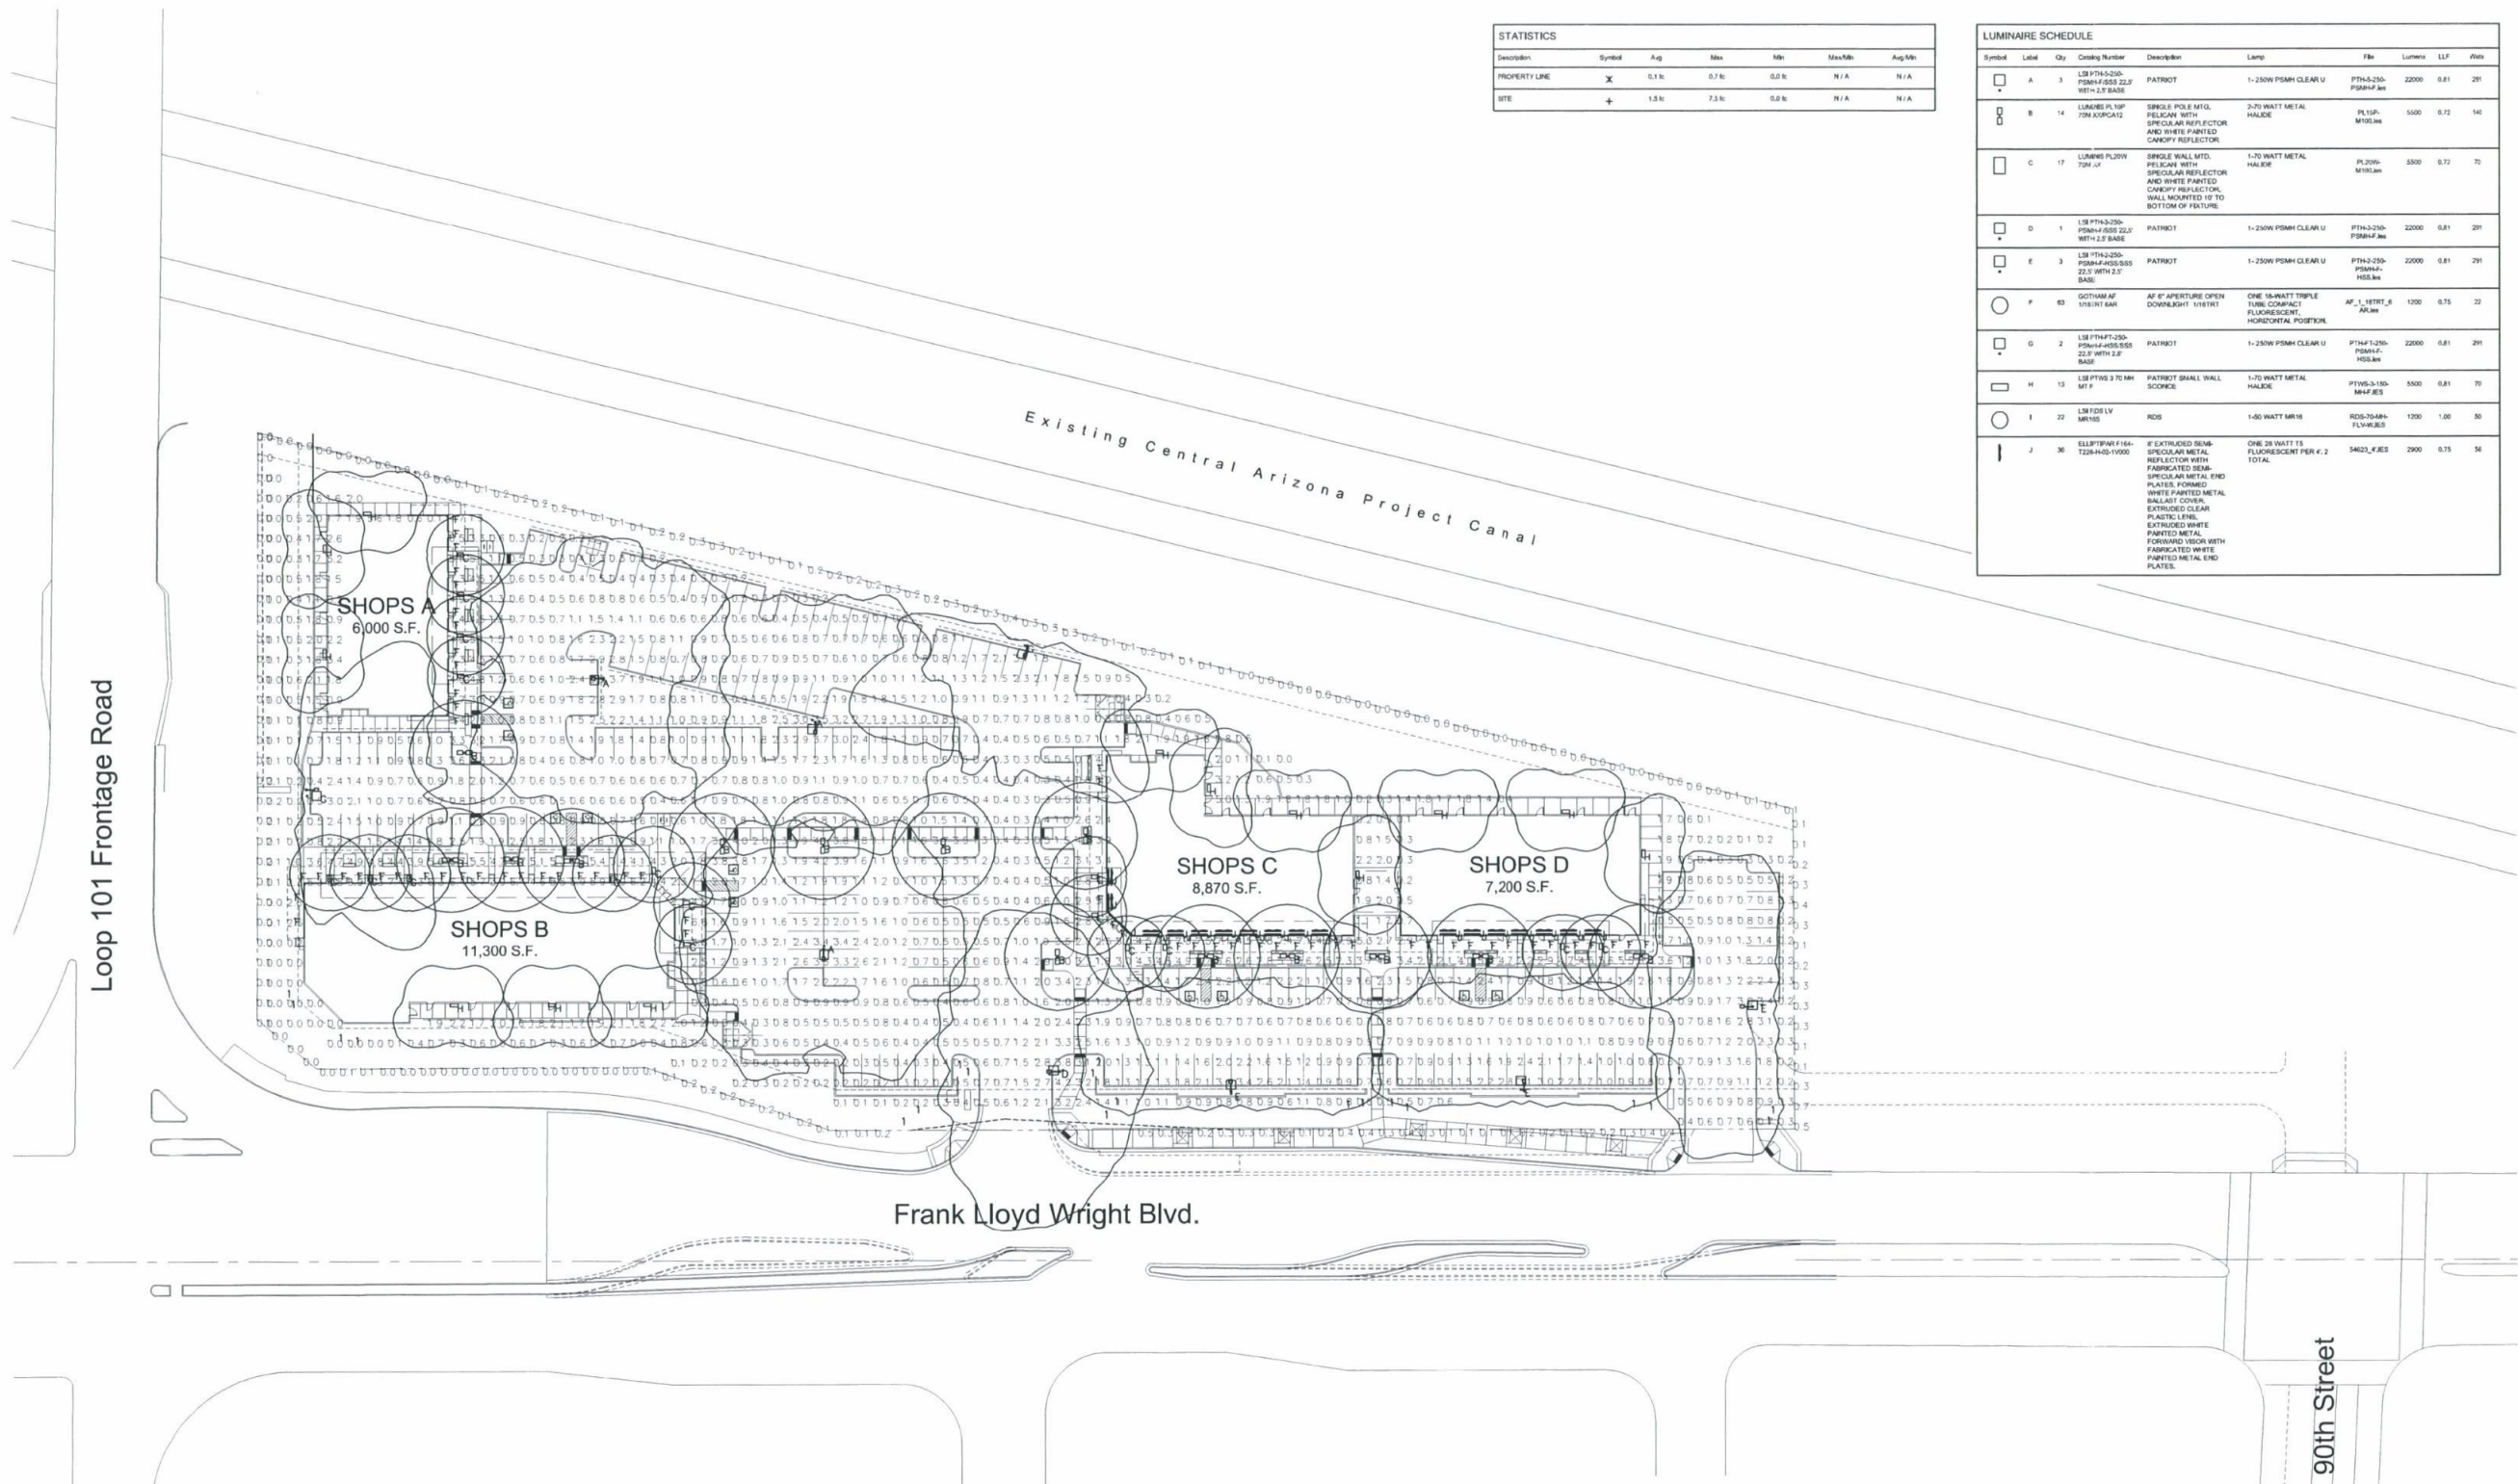

STATISTICS						
Description	Symbol	Avg	Max	Min	Max/Min	Avg/Min
PROPERTY LINE	X	5.1 fc	0.7 fc	0.0 fc	N/A	N/A
SITE	+	1.8 fc	7.5 fc	0.0 fc	N/A	N/A

LUMINAIRE SCHEDULE									
Symbol	Label	Qty	Mounting	Description	Lamp	Fits	Lumens	LLF	Foot
A	3	138	PTA3-250-PSMA-FSS-22.5' WITH 2.5' BASE	PATRIOT	1-250W PSMA CLEAR U	PTA3-250-PSMA-FSS	22000	0.81	291
B	14	LUMINEX PL10P 10M KOPCA12	SINGLE POLE MTD. PELICAN WITH SPECULAR REFLECTOR AND WHITE PAINTED CANNOPY REFLECTOR	HALOIDE	3-70 WATT METAL	PL10P-M100LM	5000	0.72	140
C	17	LUMINEX PL20W 10M J-17	SINGLE WALL MTD. PELICAN WITH SPECULAR REFLECTOR AND WHITE PAINTED CANNOPY REFLECTOR, WALL MOUNTED 10 TO BOTTOM OF FEATURE	HALOIDE	1-70 WATT METAL	PL20W-M100LM	5000	0.72	70
D	1	138	PTA3-250-PSMA-FSS-22.5' WITH 2.5' BASE	PATRIOT	1-250W PSMA CLEAR U	PTA3-250-PSMA-FSS	22000	0.81	291
E	3	138	PTA3-250-PSMA-FSS-22.5' WITH 2.5' BASE	PATRIOT	1-250W PSMA CLEAR U	PTA3-250-PSMA-FSS	22000	0.81	291
F	60	GOTHAM AF 1161KT 6AR	AF 6" APERTURE OPEN DOWNLIGHT 1161KT	ONE 18-WATT TRIPLE TUBE COMPACT FLUORESCENT, HORIZONTAL POSITION	AF-1, 1161KT, 6" AR, 18W		1200	0.75	22
G	2	138	PTA3-250-PSMA-FSS-22.5' WITH 2.5' BASE	PATRIOT	1-250W PSMA CLEAR U	PTA3-250-PSMA-FSS	22000	0.81	291
H	13	138	PTW3 3 70 NM MT F	PATRIOT SMALL WALL SCONES	1-70 WATT METAL HALOIDE	PTW3-160-M14FES	5000	0.81	70
I	22	138	PTW3 3 70 NM MT F	RDS	1-60 WATT MR16	RDS-70MM-FLWJUBS	1200	1.00	80
J	36	ELLPTRM F18-1228-HSD-1000	EXTRUDED SEMI-SPECULAR METAL REFLECTOR WITH FABRICATED SEMI-SPECULAR METAL END PLATES, FORMED WHITE PAINTED METAL BALLAST COVER, EXTRUDED CLEAR PLASTIC LENS, EXTRUDED WHITE PAINTED METAL, FORMED VISION WITH PAINTED WHITE END PLATES	ONE 28 WATT T3 FLUORESCENT PER F. 2 TOTAL	54023_FJES		2900	0.75	56

FLW 101 LLC

Gateway 101

15815 E Frank Lloyd Wright Blvd.
Scottsdale, Arizona 85260

10-07-10 10086 ST-11

90th Street



E2
Site
Photometric
Plan



92-DR-2010
1st: 10/07/10

[illegible][illegible]

3" AF Open Reflecto

Distribution curve Distribution data Output data Coefficient of illumination Illuminance Data at 30" Above Floor for a Simple Luminaire

AF 120THT BAR (1) CR2421/BA/ND35, 1200 lumens per lamp, 1.2 A/Watt, test no. L13404

Beam Angle	Beam Diameter at 30"	Beam Area at 30"	Beam Circumference at 30"	Beam Volume at 30"	Beam Length at 30"	Beam Width at 30"	Beam Height at 30"	Beam Depth at 30"	Beam Area at 30"	Beam Circumference at 30"	Beam Volume at 30"	Beam Length at 30"	Beam Width at 30"	Beam Height at 30"	Beam Depth at 30"
120°	3.0	7.07	9.42	10.8	1.73	1.73	1.73	1.73	7.07	9.42	10.8	1.73	1.73	1.73	1.73
100°	2.5	4.91	6.28	7.07	1.15	1.15	1.15	1.15	4.91	6.28	7.07	1.15	1.15	1.15	1.15
80°	2.0	3.14	3.93	4.44	0.77	0.77	0.77	0.77	3.14	3.93	4.44	0.77	0.77	0.77	0.77
60°	1.5	1.77	2.19	2.51	0.47	0.47	0.47	0.47	1.77	2.19	2.51	0.47	0.47	0.47	0.47
40°	1.0	0.79	0.98	1.11	0.26	0.26	0.26	0.26	0.79	0.98	1.11	0.26	0.26	0.26	0.26
20°	0.5	0.20	0.25	0.28	0.13	0.13	0.13	0.13	0.20	0.25	0.28	0.13	0.13	0.13	0.13

AF 120THT BAR (1) CR2421/BA/ND35, 1200 lumens per lamp, 1.2 A/Watt, test no. L13404

Beam Angle	Beam Diameter at 30"	Beam Area at 30"	Beam Circumference at 30"	Beam Volume at 30"	Beam Length at 30"	Beam Width at 30"	Beam Height at 30"	Beam Depth at 30"	Beam Area at 30"	Beam Circumference at 30"	Beam Volume at 30"	Beam Length at 30"	Beam Width at 30"	Beam Height at 30"	Beam Depth at 30"
120°	3.0	7.07	9.42	10.8	1.73	1.73	1.73	1.73	7.07	9.42	10.8	1.73	1.73	1.73	1.73
100°	2.5	4.91	6.28	7.07	1.15	1.15	1.15	1.15	4.91	6.28	7.07	1.15	1.15	1.15	1.15
80°	2.0	3.14	3.93	4.44	0.77	0.77	0.77	0.77	3.14	3.93	4.44	0.77	0.77	0.77	0.77
60°	1.5	1.77	2.19	2.51	0.47	0.47	0.47	0.47	1.77	2.19	2.51	0.47	0.47	0.47	0.47
40°	1.0	0.79	0.98	1.11	0.26	0.26	0.26	0.26	0.79	0.98	1.11	0.26	0.26	0.26	0.26
20°	0.5	0.20	0.25	0.28	0.13	0.13	0.13	0.13	0.20	0.25	0.28	0.13	0.13	0.13	0.13

AF 120THT BAR (1) CR2421/BA/ND35, 1200 lumens per lamp, 1.2 A/Watt, test no. L13404

Beam Angle	Beam Diameter at 30"	Beam Area at 30"	Beam Circumference at 30"	Beam Volume at 30"	Beam Length at 30"	Beam Width at 30"	Beam Height at 30"	Beam Depth at 30"	Beam Area at 30"	Beam Circumference at 30"	Beam Volume at 30"	Beam Length at 30"	Beam Width at 30"	Beam Height at 30"	Beam Depth at 30"
120°	3.0	7.07	9.42	10.8	1.73	1.73	1.73	1.73	7.07	9.42	10.8	1.73	1.73	1.73	1.73
100°	2.5	4.91	6.28	7.07	1.15	1.15	1.15	1.15	4.91	6.28	7.07	1.15	1.15	1.15	1.15
80°	2.0	3.14	3.93	4.44	0.77	0.77	0.77	0.77	3.14	3.93	4.44	0.77	0.77	0.77	0.77
60°	1.5	1.77	2.19	2.51	0.47	0.47	0.47	0.47	1.77	2.19	2.51	0.47	0.47	0.47	0.47
40°	1.0	0.79	0.98	1.11	0.26	0.26	0.26	0.26	0.79	0.98	1.11	0.26	0.26	0.26	0.26
20°	0.5	0.20	0.25	0.28	0.13	0.13	0.13	0.13	0.20	0.25	0.28	0.13	0.13	0.13	0.13

AF 120THT BAR (1) CR2421/BA/ND35, 1200 lumens per lamp, 1.2 A/Watt, test no. L13404

Beam Angle	Beam Diameter at
------------	------------------

[illegible]

GREENLEE RDB/RDS SERIES

Lens Types: Molded polycarbonate, high impact, shatterproof, low V0 rating, and Corning Teflon.

Mounting: Compression method, non-soldered design, mounting brackets high strength and durability. Mounting brackets are designed for the years.

Finish: Thick and standard clear coating, corrosion resistant, black. Optional aluminum accessories are available in Black or Clear powder coated finish. These accessories have a lifetime, as per finish.

Fasteners: All screws, bolts, and nuts are stainless steel, corrosion resistant, and high strength.

Lighting: Mounted to lamp holders. Medium beam or spot projector, 4000K color, with 10000 hour rated. Double ended or single ended, with 10000 hour rated. Corning Teflon, high temperature resistant.

Lighting: Mounted to lamp holders. Medium beam or spot projector, 4000K color, with 10000 hour rated. Double ended or single ended, with 10000 hour rated. Corning Teflon, high temperature resistant.

RDB Dimensions

RDB Optics

3WV C-120, 70, 150, 175, 190, 210, 230, 35770,