

Final Plans

CS4

the architectural design and data contained in these documents is an instrument of service provided by FINN architects, llc.

all discrepancies found in these documents, or conflicts between these documents and actual field conditions shall be reported to FINN architects, llc for resolution prior to commencement of work.

discrepancies between bid amounts and these documents shall be reported to the general contractor prior to commencement of work.

notice of alternate billing cycle: this contract allows the owner to require submission of billings or estimates in billing cycles other than thirty days, a written description of such other billing cycle applicable to this project is available from the owner/owner's designated agent (see cover sheet for phone/address of owner) and the owner/designated agent shall provide this written description upon request.

January 19, 2017
design development
February 01, 2017
owners meeting
February 16, 2017
75% progress set
March 02, 2017
permit submittal

LGE
DESIGN BUILD

AV3
DESIGN STUDIO
AV3@GMAIL.COM
602.282.3381

the grove at mccormick

7300 via paseo del sur
scottsdale, arizona

4-ZN-2016 & 2-CP-2016 | 8-DR-2016 | PLAN CHECK #S 296-17-1 & 296-17-2

MANUFACTURER'S
SHOP DRAWING
FOR REFERENCE
ONLY

FINN architects, llc

1810 west loermann drive, queen creek, arizona 85142

finnarchitects.com
(480-206-8229)

Wild West Lighting 1700 North Central Expressway, Suite 200 Phoenix, Arizona 85027 P: 602.282.3381 F: 602.282.3382	Description: Project Name: Notes:	CLA-1-T5-20L-7-30K-UNV-*T3R-CST THE GROVE AT MCCORMICK L6	TYPE:
---	---	---	-------

NLS LIGHTING **CLASSIC**
ARCHITECTURAL LIGHTING

The Classic LED Post Top Lantern blends traditional design with modern LED and optical technology. The Classic is able to provide illumination at (70) seventy percent energy savings compared to previous technology. The Classic LED is also virtually maintenance free with the LEDs lasting up to 60,000 hours and beyond.

The Classic is Dark Sky Friendly and features a full cutoff optical reflector system, the patent pending "Star Power" Reflector System. The Classic LED provides uniform illumination with up to four to five mounting heights. The optical system is completely concealed inside the fixture top eliminating glare. The Classic is available in 3000, 4000 and 5500 Kelvin and is available from 22-75 watts. The Classic LED Series is the perfect luminaire for traditional American neighborhoods.

The standard Classic LED comes with flat glass lens in the top of the fixture with open sides. Opal and Clear side lenses can be ordered as options.

STAR POWER™ OPTICAL SYSTEM
The Star Power™ reflector is an excellent system which provides great value and performance.

LED WATTAGE CHART

350 millamps	20W	30W
520 millamps	20W	30W
700 millamps	20W	30W
1050 millamps	20W	30W

Project Name: _____ Type: _____

CLA-1-	T5-	20L-	7-	30K-	UNV-	BRZ-	T3R-	FINIAL
Cat #	Light Dist.	No. of LEDs	Milliwatts	Kelvin	Volts	Color	Mounting	Options
Classic Mini (CLA-M)	Type 3 (T3)	20 (20L)	350 (350)	3000K (3000)	120-277 (T3R)	Bronze (BRZ)	Post Top Over 2-3/8" OD (T3R)	Marine Grade Finish (MGF)
Classic 1 (CLA-1)	Type 5 (T5)	36 (36L)	520 (520)	4000K (4000)	120-277 (T3R)	White (WHI)	Post Top Over 3" ID (T3R)	PhotoCell (PC)
						Silver (SVR)	Surge Protector (SP)	Marine Grade 120-277
						Hunter Green (HGN)	Pendant Mount (PM)	Surge Protector (SP)
						Black (BLK)	House Side Shield (HSS)	House Side Shield (HSS)
						Graphite (GPH)	Opal Side Lens (OSL)	Opal Side Lens (OSL)
						Grey (GRY)	Clear Side Lens (CSL)	Clear Side Lens (CSL)
							Frosted Side Lens	Frosted Side Lens

48

Wild West Lighting 1700 North Central Expressway, Suite 200 Phoenix, Arizona 85027 P: 602.282.3381 F: 602.282.3382	Description: Project Name: Notes:	CLA-1-T5-20L-7-30K-UNV-*PMXX THE GROVE AT MCCORMICK L6-P	TYPE:
---	---	--	-------

NLS LIGHTING **CLASSIC**
ARCHITECTURAL LIGHTING

The Classic LED Post Top Lantern blends traditional design with modern LED and optical technology. The Classic is able to provide illumination at (70) seventy percent energy savings compared to previous technology. The Classic LED is also virtually maintenance free with the LEDs lasting up to 60,000 hours and beyond.

The Classic is Dark Sky Friendly and features a full cutoff optical reflector system, the patent pending "Star Power" Reflector System. The Classic LED provides uniform illumination with up to four to five mounting heights. The optical system is completely concealed inside the fixture top eliminating glare. The Classic is available in 3000, 4000 and 5500 Kelvin and is available from 22-75 watts. The Classic LED Series is the perfect luminaire for traditional American neighborhoods.

The standard Classic LED comes with flat glass lens in the top of the fixture with open sides. Opal and Clear side lenses can be ordered as options.

STAR POWER™ OPTICAL SYSTEM
The Star Power™ reflector is an excellent system which provides great value and performance.

LED WATTAGE CHART

350 millamps	20W	30W
520 millamps <td>20W <td>30W</td> </td>	20W <td>30W</td>	30W
700 millamps <td>20W <td>30W</td> </td>	20W <td>30W</td>	30W
1050 millamps <td>20W <td>30W</td> </td>	20W <td>30W</td>	30W

Project Name: _____ Type: _____

CLA-1-	T5-	20L-	7-	30K-	UNV-	BRZ-	PMXX
Cat #	Light Dist.	No. of LEDs	Milliwatts	Kelvin	Volts	Color	Mounting
Classic Mini (CLA-M)	Type 3 (T3)	20 (20L)	350 (350)	3000K (3000)	120-277 (T3R)	Bronze (BRZ)	Post Top Over 2-3/8" OD (T3R)
Classic 1 (CLA-1)	Type 5 (T5)	36 (36L)	520 (520)	4000K (4000)	120-277 (T3R)	White (WHI)	Post Top Over 3" ID (T3R)
						Silver (SVR)	Surge Protector (SP)
						Hunter Green (HGN)	Pendant Mount (PM)
						Black (BLK)	House Side Shield (HSS)
						Graphite (GPH)	Opal Side Lens (OSL)
						Grey (GRY)	Clear Side Lens (CSL)
						Custom (CS)	Frosted Side Lens

48

Wild West Lighting 1700 North Central Expressway, Suite 200 Phoenix, Arizona 85027 P: 602.282.3381 F: 602.282.3382	Description: Project Name: Notes:	BPS-307-24-LEDWW-BK-FR-GD-170' THE GROVE AT MCCORMICK L9	TYPE:
---	---	--	-------

Tube Lighting Products **Stringer-Globes**
BPS-307 Specifications

BPS-307 are Stringer-Globes, made of shatterproof polycarbonate, injection molded for excellent clarity and a seamless appearance. Each globe is fitted with an o-ring to ensure a snug fit and weatherproof seal.

SOCKETS - Permanently fixed to each cable and sealed with silicone. Each socket is wired to the cable in parallel so individual lamp failures do not effect operation of others. Black (BK) or White (WH).

GLOBE SIZE - Large globe 3.36" x 2.26" or small globe 1.77" x 1.75". For smaller globe add SM to part number: Ex: For Clear use (CLSM)

LED LAMPS - LED lamps are 24 volts (see chart below).

LAMP SPACING - 12", 18", 24" or 36".

GLOBE COLORS - Polycarbonate Clear (CL), Frosted (FR), Red (RD), Blue (BL), Green (GN), or Amber (AM).

CABLE - Highly flexible cable contains AWG 12 stranded and plated conductor. Black (BK) or White (WH).

MOUNTING OPTIONS - Globe Up (GU) Mounting Straps and Globe Down (GD) Adaptor to hang globe (Wire rope 1/8" - 3/16" recommended and supplied by others)

LISTING - ETL listed for wet locations.

LAMP	WATTS	LUMENS	COLOR	LIFE HOURS
LEDWW	0.48	15	2800K	50,000
LEDWC	0.48	20	5500K	50,000
LEDNC	1.8	40	2300K	50,000
LEDNL	0.48	1.5	BLUE	50,000
LEDNS	0.48	4.5	GREEN	50,000
LEDOR	0.48	2.5	ORANGE	50,000
LEDPJ	0.48	3.5	PURPLE	50,000
LEDRD	0.48	2.5	RED	50,000

Note: Incandescent 12V and 24V lamps available. Please contact factory for more info.

ORDERING INFORMATION EXAMPLE

PRODUCT	SPACING	LAMP	WIRE	GLOBE	MOUNTING OPTION	LENGTH
BPS-307-	24-	LEDWW-	BK-	FR-	GD-	170'

1346 Pioneer Way
El Cerrito, CA 94530
(619) 442-0577 FAX (619) 442-0578
www.tubelightingproducts.com

REV. 06/2016

Wild West Lighting 1700 North Central Expressway, Suite 200 Phoenix, Arizona 85027 P: 602.282.3381 F: 602.282.3382	Description: Project Name: Notes:	A11-WM-STD FIN THE GROVE AT MCCORMICK L6	TYPE:
---	---	--	-------

NLS LIGHTING **ARCHITECTURAL ARM 11**
ARMS

Architectural Arm 11 is constructed of extruded aluminum tubing and available for both post top and pendant mount luminaires. Integrates with poles or tenons of 3-1/2", 4", 4-1/2", or 5" OD and is secured with 3/8" stainless steel Allen set screws.

Contact NLS for custom configuration or other mounting options. Designed, tooled, fabricated and assembled in the USA.

MODEL A B EPA SGL EPA DBL EPA WM
A11 24 in. 40 in. 1.8 2.5 1.04

Project Name: _____ Type: _____

A11-	WM-	BRZ
Cat #	Mounting	Pole or Tenon Diameter
Architectural Arm 11 (A11)	Single (SGL)	3 1/2" Round (312R)
	Double 180° (DT80)	4" Round (412R)
	Wall Mount (WM)	4 1/2" Round (412R)
		5" Round (512R)
		Color
		Bronze (BRZ)
		White (WHI)
		Silver (SVR)
		Black (BLK)
		Hunter Green (HGN)
		Graphite (GPH)
		Grey (GRY)
		Custom (CS)

1700 North Central Expressway, Suite 200, Phoenix, AZ 85027
Call Us Today (619) 442-0577

nslighting.com

163

Wild West Lighting 1700 North Central Expressway, Suite 200 Phoenix, Arizona 85027 P: 602.282.3381 F: 602.282.3382	Description: Project Name: Notes:	HRM-1-T4-16L-53-30K-UNV-WM-BRZ-EB THE GROVE AT MCCORMICK L8	TYPE:
---	---	---	-------

NLS LIGHTING **HERMOSA WALL PACK**
WALL + SURFACE LIGHTING

The Hermosa 66 Watts LED Wall Pack is California Title 24 Compliant. Each model comes with photocell. Recommended replacement wattage up to 150 watts Metal Halide. Clear lens is standard.

The Hermosa is the Best Value Solid State Outdoor Lighting Solution Today

- UL Listed for Wet Location
- Tempered Borosilicate Glass Lens
- High Quality Outdoor Powder Coat Finish
- Minimum Start Temperature -40° F
- Weather Resistant Silicon Gasket
- Independent Photometric Testing
- 5 Year Full Fixture or 50,000 Hour Life*
- Title 24 Compliant
- Die Cast Aluminum Housing
- IP 66 Rated
- Suitable for use at 40° C Ambient Temperature

STAR POWER™ OPTICAL SYSTEM
The Star Power™ reflector is an excellent system which provides great value and performance.

LED WATTAGE CHART

530 millamps	16W	30W
700 millamps <td>16W <td>30W</td> </td>	16W <td>30W</td>	30W

Project Name: _____ Type: _____

HRM-1-	T4-	16L-	53-	30K-	UNV-	WM-	BRZ-	EB
Cat #	Light Dist.	# of LEDs	Milliwatts	Kelvin	Volts	Mounting	Color	Options
Hermosa 1 (HRM-1)	Type 2 (T2)	16 (16L)	530 (530)	4000K (4000)	120-277 (UNV)	Wall Mount (WM)	Bronze (BRZ)	Surge Protector (SP)
	Type 4 (T4)	32 (32L)	700 (700)	5500K (5500)			White (WHI)	Motion Sensor (MS)
							Silver (SVR)	Polycarbonate Lens (PL)
							Hunter Green (HGN)	Photo Cell (PC)
							Black (BLK)	Marine Grade 120-277
							Graphite (GPH)	Emergency Battery Backup (EB)
							Grey (GRY)	
							Custom (CS)	

94

Wild West Lighting 1700 North Central Expressway, Suite 200 Phoenix, Arizona 85027 P: 602.282.3381 F: 602.282.3382	Description: Project Name: Notes:	CUSTOM CANOPY THE GROVE AT MCCORMICK L9	TYPE:
---	---	---	-------

APPROVED
FINAL PLANS PLANNING
DATE 10/10/17 BY [Signature]
APPROVED BY [Signature]

AS NOTED
EX SOCKET w/ LED
STEEL SHROUD TO BE POWDERCOATED TO APPROVED COLOR
EX-SH STEEL RETAINING RING
EX-G19-CL POLYCARBONATE GLOBE

TONY WOO ENGINEERING, INC.
1 W. DEER VALLEY RD.
SUITE 203
PHOENIX, AZ 85027
TEL (602) 279-8092

JOB # 617003

CONTACT: GREG HAMPTON
GREG@THE.PHX.COXMAIL.COM

CS3

the architectural design and data contained in these documents is an instrument of service provided by FINN architects, llc.

all discrepancies found in these documents, or conflicts between these documents and actual field conditions shall be reported to FINN architects, llc for resolution prior to commencement of the work.

discrepancies between bid amounts and these documents shall be reported to the general contractor prior to commencement of work.

notice of alternate billing cycle: this contract allows the owner to require submission of billings or estimates in billing cycles other than thirty days, a written description of such other billing cycle applicable to this project is available from the owner/owner's designated agent (see cover sheet for phone/address of owner) and the owner/designated agent shall provide the written description upon request.

January 19, 2017
design development
February 01, 2017
owners meeting
February 16, 2017
75% progress set
March 02, 2017
permit submittal

LGE
DESIGN BUILD

AV3
design studio
AV3@GMAIL.COM
480.338.3337

the grove at mccormick
7300 via paseo del sur
scottsdale, arizona

• 4-24-2016 & 2-GP-2016 | 8-08-2016 | PLAN CHECK #S 296-17-1 & 296-17-2

MANUFACTURER'S
SHOP DRAWING
FOR REFERENCE
ONLY

Wild West Lighting 17225 North Central Expressway, Suite 200 Northridge, CA 91329 Tel: (818) 708-7777 Fax: (818) 708-7778	Description: VUE-2-T5-96L-53-30K-UNV-DPS-BRZ Project Name: THE GROVE AT MCCORMICK Notes:	TYPE: L2B
--	--	---------------------

NLS
LIGHTING

VUE SERIES

AREA LIGHTING


The VUE Series is a collaboration of form, optics and thermal management. These combined high-quality features reduce energy costs, while the least amount of poles and fixtures are project while meeting ICC minimum foot-candle levels and extend maintenance cycles at a competitive price.

The VUE has specific optical systems designed for Parking Lots, Roadways, Auto Washes, Transit Centers, and Sports Field Lighting. The VUE's patented optical system is called "Star Power". The flexibility and power of the "Star Power" optics enables the VUE to gain additional advantage over its competitors for almost any distribution pattern. The system features 95% optical material which goes through a linear diffusion process to stretch the visible image of the globe both magnifying it and creating a large tapered square flat field horizontally and vertically. This added range increases the width of the light pattern at a greater distance compared to optical systems which rely on reflection principles using plastics. Star Power optics are also the most reliable, other plastic optics will degrade over time as well as need to have flat field white exposed being torn to the elements.

Product Features

The "Vue Series" is the Best Value Outdoor Lighting Solution

- Produces up to 120 lumens per system Watt of controlled illumination.
- Use an F107 1 life modular efficient chip upgrade solution, which takes less than a minute to perform.
- Has a Beautiful, Sleek and Sleek shape.
- Can be mounted directly on to a Wall, Pole, Mast Arm, or adjustable Mast Arm.
- 20 Degree beam max. is available.
- Light distributions are types 2, 3, 4, 5, and Tennis Optic.
- Is the Perfect Long Life Solution for any Municipality, School, or Infrastructure.
- The VUE conforms to the strictest Made in the USA standards.
- Designed, Tooled, Fabricated and Assembled in California.

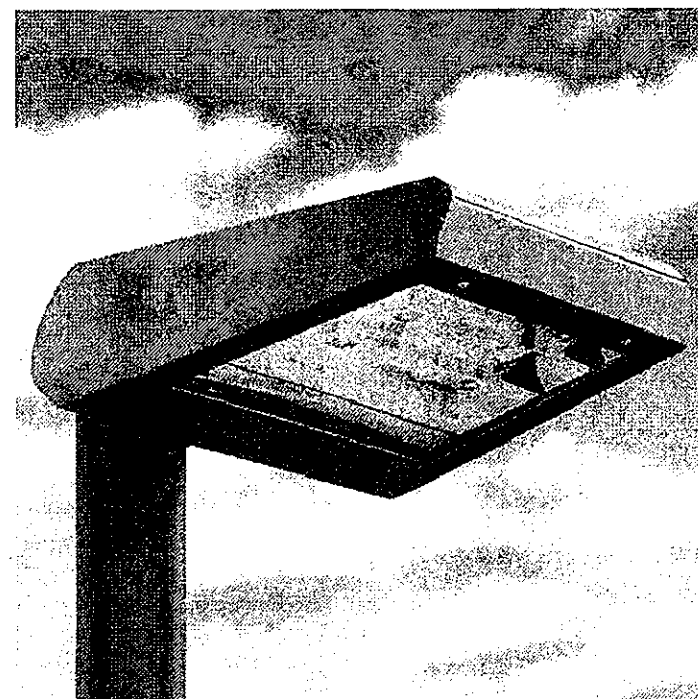

STAR POWER™ OPTICAL SYSTEM
The Star Power™ reflector is an excellent system which provides great value and performance.

LED WATTAGE CHART
16L 22L 44L 66L 88L 112L 128L 144L 160L 176L 192L
500 milliwatts 350 500 650 800 950 1100 1250 1400 1550 1700 1850
750 milliwatts 525 750 1050 1400 1750 2100 2450 2800 3150 3500 3850
1050 milliwatts 787 1125 1575 2100 2625 3150 3675 4200 4725 5250 5775

Project Name:						Type:			
VUE-2-	T5-	96L-	53-	30K-	UNV-	DPS	BRZ		
Cat #	Light Dist.	No. of LEDs	Milliwatts	Kelvin	Volts	Mounting	Color	Shields	Options
VUE-1 (20'x20'x20' (006-1))	Type 2 (T2)	16 (16L)	500 (500)	3000K (30K)	120-277 (UNV)	Hook Top Square (007)	Black (BRZ)	House Side Shield (005)	Red Jacket (005)
VUE-2 (20'x20'x20' (006-2))	Type 3 (T3)	32 (32L)	1000 (1000)	3000K (30K)	120-277 (UNV)	Hook Top Square (007)	White (WHT)	House Side Shield (005)	Marine Grade Finish (005)
VUE-3 (20'x20'x20' (006-3))	Type 4 (T4)	64 (64L)	2000 (2000)	3000K (30K)	120-277 (UNV)	Hook Top Square (007)	White (WHT)	House Side Shield (005)	Marine Grade Finish (005)
VUE-4 (20'x20'x20' (006-4))	Type 5 (T5)	96 (96L)	3000 (3000)	3000K (30K)	120-277 (UNV)	Hook Top Square (007)	White (WHT)	House Side Shield (005)	Marine Grade Finish (005)
VUE-5 (20'x20'x20' (006-5))	Type 6 (T6)	128 (128L)	4000 (4000)	3000K (30K)	120-277 (UNV)	Hook Top Square (007)	White (WHT)	House Side Shield (005)	Marine Grade Finish (005)
VUE-6 (20'x20'x20' (006-6))	Type 7 (T7)	160 (160L)	5000 (5000)	3000K (30K)	120-277 (UNV)	Hook Top Square (007)	White (WHT)	House Side Shield (005)	Marine Grade Finish (005)
VUE-7 (20'x20'x20' (006-7))	Type 8 (T8)	192 (192L)	6000 (6000)	3000K (30K)	120-277 (UNV)	Hook Top Square (007)	White (WHT)	House Side Shield (005)	Marine Grade Finish (005)

Wild West Lighting 17225 North Central Expressway, Suite 200 Northridge, CA 91329 Tel: (818) 708-7777 Fax: (818) 708-7778	Description: CLA-1-T5-20L-7-30K-UNV-T3R-CST Project Name: THE GROVE AT MCCORMICK Notes:	TYPE: L4
--	---	--------------------

NLS
LIGHTING

CLASSIC

ARCHITECTURAL LIGHTING

The Classic LED Post Top Lantern blends traditional design with modern LED and optical technology. The Classic is able to provide illumination at (70) seventy percent energy savings compared to previous technology. The Classic LED is also virtually maintenance free with the LEDs lasting up to 60,000 hours and beyond.

The Classic is Dark Sky Friendly and features a full cutoff optical reflector system, the patent pending "Star Power" Reflector System. The Classic LED provides uniform illumination with up to four to five mounting heights. The optical system is completely concealed inside the fixture top eliminating glare. The Classic is available in 3000, 4000 and 5500 Kelvin and is available from 22.75 watts. The Classic LED Series is the perfect luminaire for traditional American neighborhoods.

The standard Classic LED comes with flat glass lens in the top of the fixture with open sides. Opal and Clear side lenses can be ordered as options.



STAR POWER™ OPTICAL SYSTEM
The Star Power™ reflector is an excellent system which provides great value and performance.

LED WATTAGE CHART
20L 30L 40L 13390L 1340

january 19, 2017
design development
february 01, 2017
owners meeting
february 16, 2017
75% progress set
march 02, 2017
permit submittal



• 4-ZN-2016 & 2-GP-2016 | 8-DR-2016 | PLAN CHECK #'S 296-17-1 & 296-17-2

**MANUFACTURER'S
SHOP DRAWING
FOR REFERENCE
ONLY**

1810 west loemann drive, queen creek, arizona 85142
(480-206-8229)

[illegible]

Wild West Lighting 1724 Harrison Street, Suite 100 Portland, Oregon 97201-3100 Phone (503) 222-1111 Fax (503) 222-1112	Description : Project Name: Type:	SSSP-15-4S-11G-9BC-5GL-BRZ-3430 THE GROVE AT MCCORMICK	TYPE L2
---	--	--	-----------------------------------

NLS
LIGHTING

SQUARE STRAIGHT STEEL POLE

POLES + BASES

POLE

Shall be Straight Steel Grade B Extrusion with yield of 46,000 PSI. Conforms to ASTM A500 Standards. Poles have ground bolt welded inside hand hole opposite side of the pole extrusion. Pole Extrusion is joined to Anchor Base by welding internal to pole shaft and external to pole shaft. Hand Hole reinforcement is Constructed of 3"x5" rectangular steel tubing which is welded to pole shaft for added strength.

ANCHOR BASE

Manufactured from A36 Steel rated at 36,000 PSI, conforms the ASTM -A36 standards. Base Plate vary in size from 1" thick for poles 21 feet and over, 3/4" thick for poles 10 to 20 feet.

COATING

All poles have minimum 3mm powder coat finish. All poles are sandblasted prior to powder coat application.

ANCHORAGE

All anchor bolts are fully hot dipped galvanized and come with two galvanized nuts and washers per bolt.

BASE COVER, HAND HOLE COVER AND POLE CAP

All poles come with removable polymer pole cap installed. All poles caps are black finish. All base covers are made of aluminum and powder coated to match the pole. The hand hole covers are provided with internal bridge support and also powder coated to match pole finish.

Project Name:

Type:

SSSP-	15-	4S-	11G-	9BC-	SGL-	BRZ-	3430	
Cat #	Height	Pole Dim.	Size	Base Pattern	Orient	Color	Bolts	Enhancements
Square Straight Steel pole (SSSP)	10' (10) 12' (12) 15' (15) 18' (18) 20' (20) 22' (22) 24' (24) 26' (26) 28' (28) 30' (30)	4" Square (4S) 5" Square (5S)	120 x 120 (11G) 150 x 150 (11G)	(10' 20') 20" x 10" (9BC) (12' 24') 24" x 12" (9BC) (15' 18') 18" x 15" (9BC)	Single (SGL) Double (D-180) Triple (T-360) Quad (Q)	White (WHT) Silver (GRN) Green (GRN) Black (BLK) Blue (BLU) Orange (OPR) Grey (GRY)	3/4" x 20" (3430) 1 1/2" x 20" (175) 2" x 20" (175) 2 1/2" x 20" (175) 3" x 20" (175) 3 1/2" x 20" (175) 4" x 20" (175) 4 1/2" x 20" (175) 5" x 20" (175) 5 1/2" x 20" (175) 6" x 20" (175) 6 1/2" x 20" (175) 7" x 20" (175) 7 1/2" x 20" (175) 8" x 20" (175) 8 1/2" x 20" (175) 9" x 20" (175) 9 1/2" x 20" (175) 10" x 20" (175) 10 1/2" x 20" (175) 11" x 20" (175) 11 1/2" x 20" (175) 12" x 20" (175) 12 1/2" x 20" (175) 13" x 20" (175) 13 1/2" x 20" (175) 14" x 20" (175) 14 1/2" x 20" (175) 15" x 20" (175) 15 1/2" x 20" (175) 16" x 20" (175) 16 1/2" x 20" (175) 17" x 20" (175) 17 1/2" x 20" (175) 18" x 20" (175) 18 1/2" x 20" (175) 19" x 20" (175) 19 1/2" x 20" (175) 20" x 20" (175) 20 1/2" x 20" (175) 21" x 20" (175) 21 1/2" x 20" (175) 22" x 20" (175) 22 1/2" x 20" (175) 23" x 20" (175) 23 1/2" x 20" (175) 24" x 20" (175) 24 1/2" x 20" (175) 25" x 20" (175) 25 1/2" x 20" (175) 26" x 20" (175) 26 1/2" x 20" (175) 27" x 20" (175) 27 1/2" x 20" (175) 28" x 20" (175) 28 1/2" x 20" (175) 29" x 20" (175) 29 1/2" x 20" (175) 30" x 20" (175)	Galvanneal (GRN) Powder Coat Only (PCO) Customized (CUST) Anodized Aluminum (ALU) Teak Stainless Steel (SS) Aluminum (ALU) Carbon Fiber (CF) Fiberglass (FRG) Kevlar (KEV) Titanium (TIT) Inconel (INC) Copper (CU) Brass (BRA) Nickel (NIC) Silver (SIL) Gold (GOL) Platinum (PLT) Iridium (IRI) Rhodium (RHO) Palladium (PAL) Neodymium (NDY) Lanthanum (LAN) Cerium (CEM) Europium (EUR) Gadolinium (GAD) Terbium (TER) Dysprosium (DYS) Holmium (HOL) Erbium (ERB) Thulium (THU) Ytterbium (YTB) Lutetium (LUT) Hafnium (HAF) Tantalum (TAN) Niobium (NIO) Molybdenum (MOB) Technetium (TEC) Ruthenium (RUT) Rhodium (RHO) Palladium (PAL) Silver (SIL) Gold (GOL) Platinum (PLT) Iridium (IRI) Osmium (OSM) Iridium (IRI) Rhenium (REN) Cadmium (CAD) Mercury (MER) Lead (LEA) Tin (TIN) Antimony (ANT) Arsenic (ARS) Selenium (SEL) Tellurium (TEL) Polonium (POL) Astatine (AST) Radon (RAD) Francium (FRC) Actinium (ACT) Thorium (THO) Protactinium (PRO) Uranium (URA) Neptunium (NEP) Plutonium (PLU) Americium (AMR) Curium (CUR) Berkelium (BER) Californium (CAL) Einsteinium (EIN) Fermium (FER) Mendelevium (MEN) Nobelium (NOB) Lawrencium (LAW) Rutherfordium (RUF) Dubnium (DUB) Seaborgium (SEB) Bohrium (BOH) Hassium (HAS) Meitnerium (MEI) Darmstadtium (DAR) Roentgenium (ROE) Copernicium (COP) Livermorium (LIV) Tennessine (TEN) Oganesson (OGA)

128

Wild West Lighting
1000 North Main Street • Suite 200
Bismarck, ND 58101 • Phone: 701-223-1111
Fax: 701-223-1112 • Email: info@wildwestlighting.com

Specification:

DPB-400-5R-*
THE GROVE AT MCCORMICK

Project Name:

THE GROVE AT MCCORMICK

Notes:

TYPE:

L1-2

NLS
LIGHTING

DECORATIVE POLE BASES 300 + 400

POLES + BASES

DPB-300

DPB Category: Highway, Residential or Commercial projects

Base Material: Heavy-duty die-cast aluminum base. Interior grade copper free aluminum. Base plate 9" ON measures 37.5" tall x 10.19" wide.

Finish: 5 Mil aluminum rich textured powder coat finish. Custom color match available upon request. Including Traffic White and Weathered Brown.

Compatible Pole: Round Street Light Steel (RSSP) or Round Straight Aluminum (RSAP) poles in 4", or 5" OD in 7 or 11 gauge. Consult factory for fluted options.

Project Name:		Type:
Cat #	Pole Dim.	Color
Decorative Pole Base 300 (DPB-300)	4" Fluted (4R) 5" Fluted (5R)	Bronze (BRZ) White (WHI) Silver (SILV) Black (BLK) Hinter Green (HGRN) Toughpole (TPW) Grey (GRY) Custom (CS)

DPB-400

DPB Category: Highway or Residential projects

Base Material: Two piece die-cast aluminum base. Interior grade copper free aluminum. Base plate 9" SQ. Measures 19.5" tall x 10.19" OD wide.

Finish: 5 Mil aluminum rich textured powder coat finish. Custom color match, including Traffic White and Weathered Brown.

Compatible Pole: Round Street Light Steel (RSSP) or Round Straight Aluminum (RSAP) poles in 4", or 5" OD in 7 or 11 gauge. Consult factory for fluted options.

Project Name:		Type:
DPB-400	(SQ)	BSL
Cat #	Pole Dim.	Color
Decorative Pole Base 400 (DPB-400)	4" Fluted (4R) 5" Fluted (5R)	Bronze (BRZ) White (WHI) Silver (SILV) Black (BLK) Hinter Green (HGRN) Toughpole (TPW) Grey (GRY) Custom (CS)

NLS
LIGHTING

101 Ridgely Place, Carson, IA 51304-66
Call Us Today 701-223-1111

nslighting.com

427

LGE
DESIGN BUILD

AV3
design studio
AVDESIGNSTUDIO.COM
603.356.3302

• 4-ZN-2016 & 2-GP-2016 | 8-DR-2016 | PLAN CHECK #'S 296-17-1 & 296-17-2

WWL Calculation Summary						
Label	CalcType	Units	Avg	Max	Min	Avg/Min
Grade	Illuminance	Fc	1.92	7.6	0.0	N.A.
Vertical spill at 6 ft afg	Illuminance	Fc	0.15	0.8	0.0	N.A.

WWL Luminaire Schedule						
Symbol	Qty	Label	Arrangement	Total Lamp Lumens	LLF	Description
□	6	B	SINGLE	768	0.980	SL630-N324P/12-IN
□	6	L1	SINGLE	N.A.	0.970	CLA-1-T5-20L-3-30K-UNV-FINISH-T3R-CST
□	4	L1-2	SINGLE	N.A.	0.970	CLA-1-T5-20L-3-30K-UNV-FINISH-T3R-CST
□	4	L12	SINGLE	N.A.	0.980	SN908-G17/LVX01-FL-9W-27K/GN10K-G1713
□	2	L2B	SINGLE	N.A.	0.970	VUE-2-T5-98L-53-30K-UNV-DPS-FINISH
□	1	L4	SINGLE	N.A.	0.970	CLA-1-T5-20L-7-30K-UNV-FINISH-T3R-CST
□	10	L5	SINGLE	N.A.	0.840	520-G17/LVX01-FL-13W-27K/GN23A-G17
□	4	L5P	SINGLE	N.A.	0.840	520-G17/LVX01-FL-13W-27K/ 643BK-G17
□	13	L6	SINGLE	N.A.	0.970	CLA-1-T5-20L-3-30K-UNV-FINISH-T3R-CST
□	12	L6-P	SINGLE	N.A.	0.970	CLA-1-T5-20L-3-30K-UNV-FINISH-T3R-CST
□	6	L8	SINGLE	N.A.	0.970	HRM-1-T4-16L-53-30K-UNV-WM-BRZ
□	64	L9	SINGLE	150	0.980	HYA-STL/USHIO 1004161 LAMP Qty shown is number of lamps
□	9	L2A	SINGLE	N.A.	0.970	VUE-2-T3-80L-53-30K-UNV-DPS-BRZ-HSS
□	2	L11	SINGLE	N.A.		DWHWL-24V-W31-DSH-PF24-T-1022-24-1
□	5	EM	SINGLE	N.A.		MAE BB 10 B W
□	9	AE	SINGLE	N.A.	0.970	SS4G3DR1308-EM7

the architectural design and data contained in these documents is an instrument of service provided by FINN architects, llc.

all discrepancies found in these documents, or conflicts between these documents and actual field conditions shall be reported to FINN architects, llc for resolution prior to commencement of the work.

discrepancies between bid amounts and these documents shall be reported to the general contractor prior to commencement of work.

notice of alternate billing cycle: this contract allows the owner to require submission of billings or estimates in billing cycles other than thirty days. a written description of such other billing cycle applicable to this project is available from the owner/owner's designated agent (see cover sheet for phone/address of owner) and the owner/designated agent shall provide this written description upon request.


January 19, 2017
design development
February 01, 2017
owners meeting
February 16, 2017
75% progress set
March 02, 2017
permit submittal

AUGUST 30, 2017
PLANNING COMMENTS

LGE
DESIGN BUILD

AV3
design studio
AV3@GMAIL.COM
602.281.0007

APPROVED
FINAL PLANS
10/10/2017
DATE APPROVAL

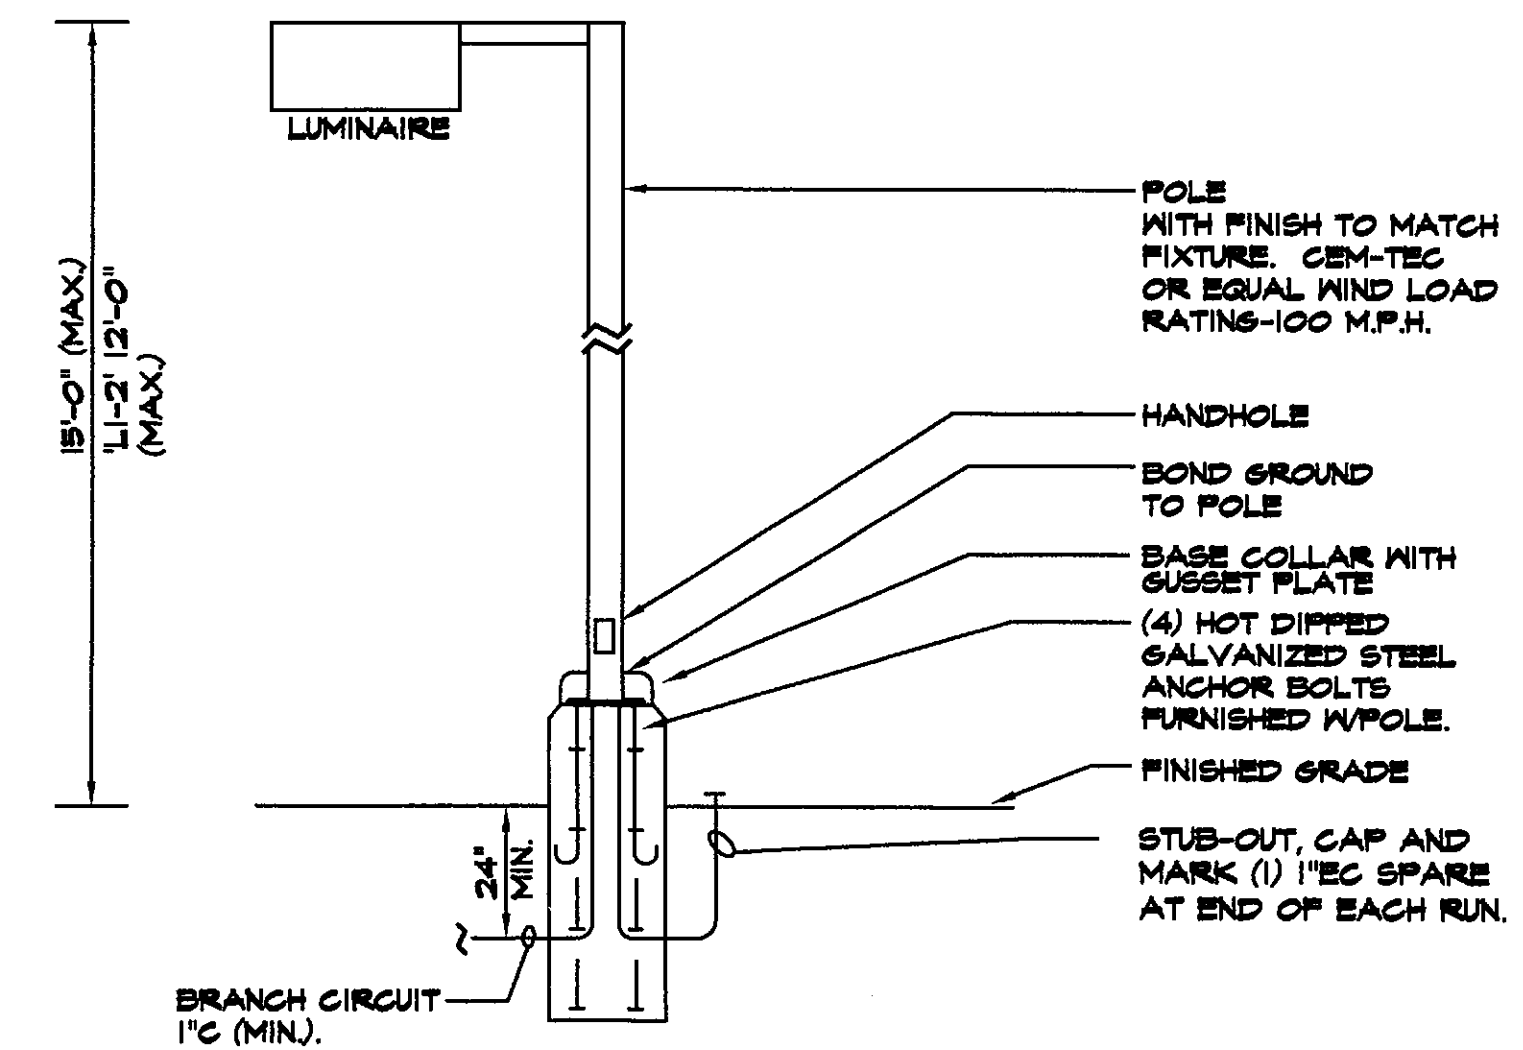

LIGHT FIXTURE 'L2', 'L2A' & 'L2B' DETAIL

NO SCALE

('L1' AND 'L1-2' SIMILAR EXCEPT AS NOTED AND DECORATIVE FLUTED POLE W/POSTOP FIXTURE WITH CLAM SHELL BASE.)

TONY WOO ENGINEERING, INC.
1 W. DEER VALLEY RD.
SUITE 203
PHOENIX, AZ 85027
TEL (602) 279-8092

JOB # 617003
CONTACT: GREG HAMPTON
GREG@THEPHXCOXMAIL.COM

PHOTOMETRIC SITE PLAN


SCALE: 1" = 20'-0"

FINN architects, llc
1810 west loermann drive, queen creek, arizona 85142
(480-206-8229)

the grove at mccormick
7300 via paseo del sur
scottsdale, arizona
4-ZN-2016 & 2-CP-2016 | 8-DR-2016 | PLAN CHECK #S 296-17-1 & 296-17-2

**MANUFACTURER'S
SHOP DRAWING
FOR REFERENCE
ONLY**

NOTE:
THE PRE-CURFEN LIGHTING DESIGN HOURS SHALL BE DEFINED AS DUSK TO 10:00 PM, AND THE POST-CURFEN LIGHTING DESIGN HOURS SHALL BE DEFINED AS 10:00 PM TO DAWN. ALL EXTERIOR LIGHTS SHALL BE TURNED OFF DURING POST-CURFEN WITH THE EXCEPTION OF LIGHTS FOR SECURITY PURPOSES.
A PROGRAMMABLE TIMER AND PHOTOCELLS SHALL CONTROL THE PRE- AND POST-CURFEN LIGHTS. PHOTOCELLS SHALL BE MOUNTED ON THE NORTH SIDE OF BLDG. THE PROGRAMMABLE TIMER MAY CONTAIN A MAXIMUM OF 1-HOUR OVER RIDE WITH AN AUTOMATIC TURN OFF FOR AFTER HOURS, AND SPECIAL EVENTS USE ONLY.
COORDINATE POLE LIGHT LOCATIONS WITH TREES IN FIELD WITH LANDSCAPE CONTRACTOR.
SEE SHEET E6 FOR PHOTOCELL "ON" TIMELOCK "OFF" REQUIREMENTS.

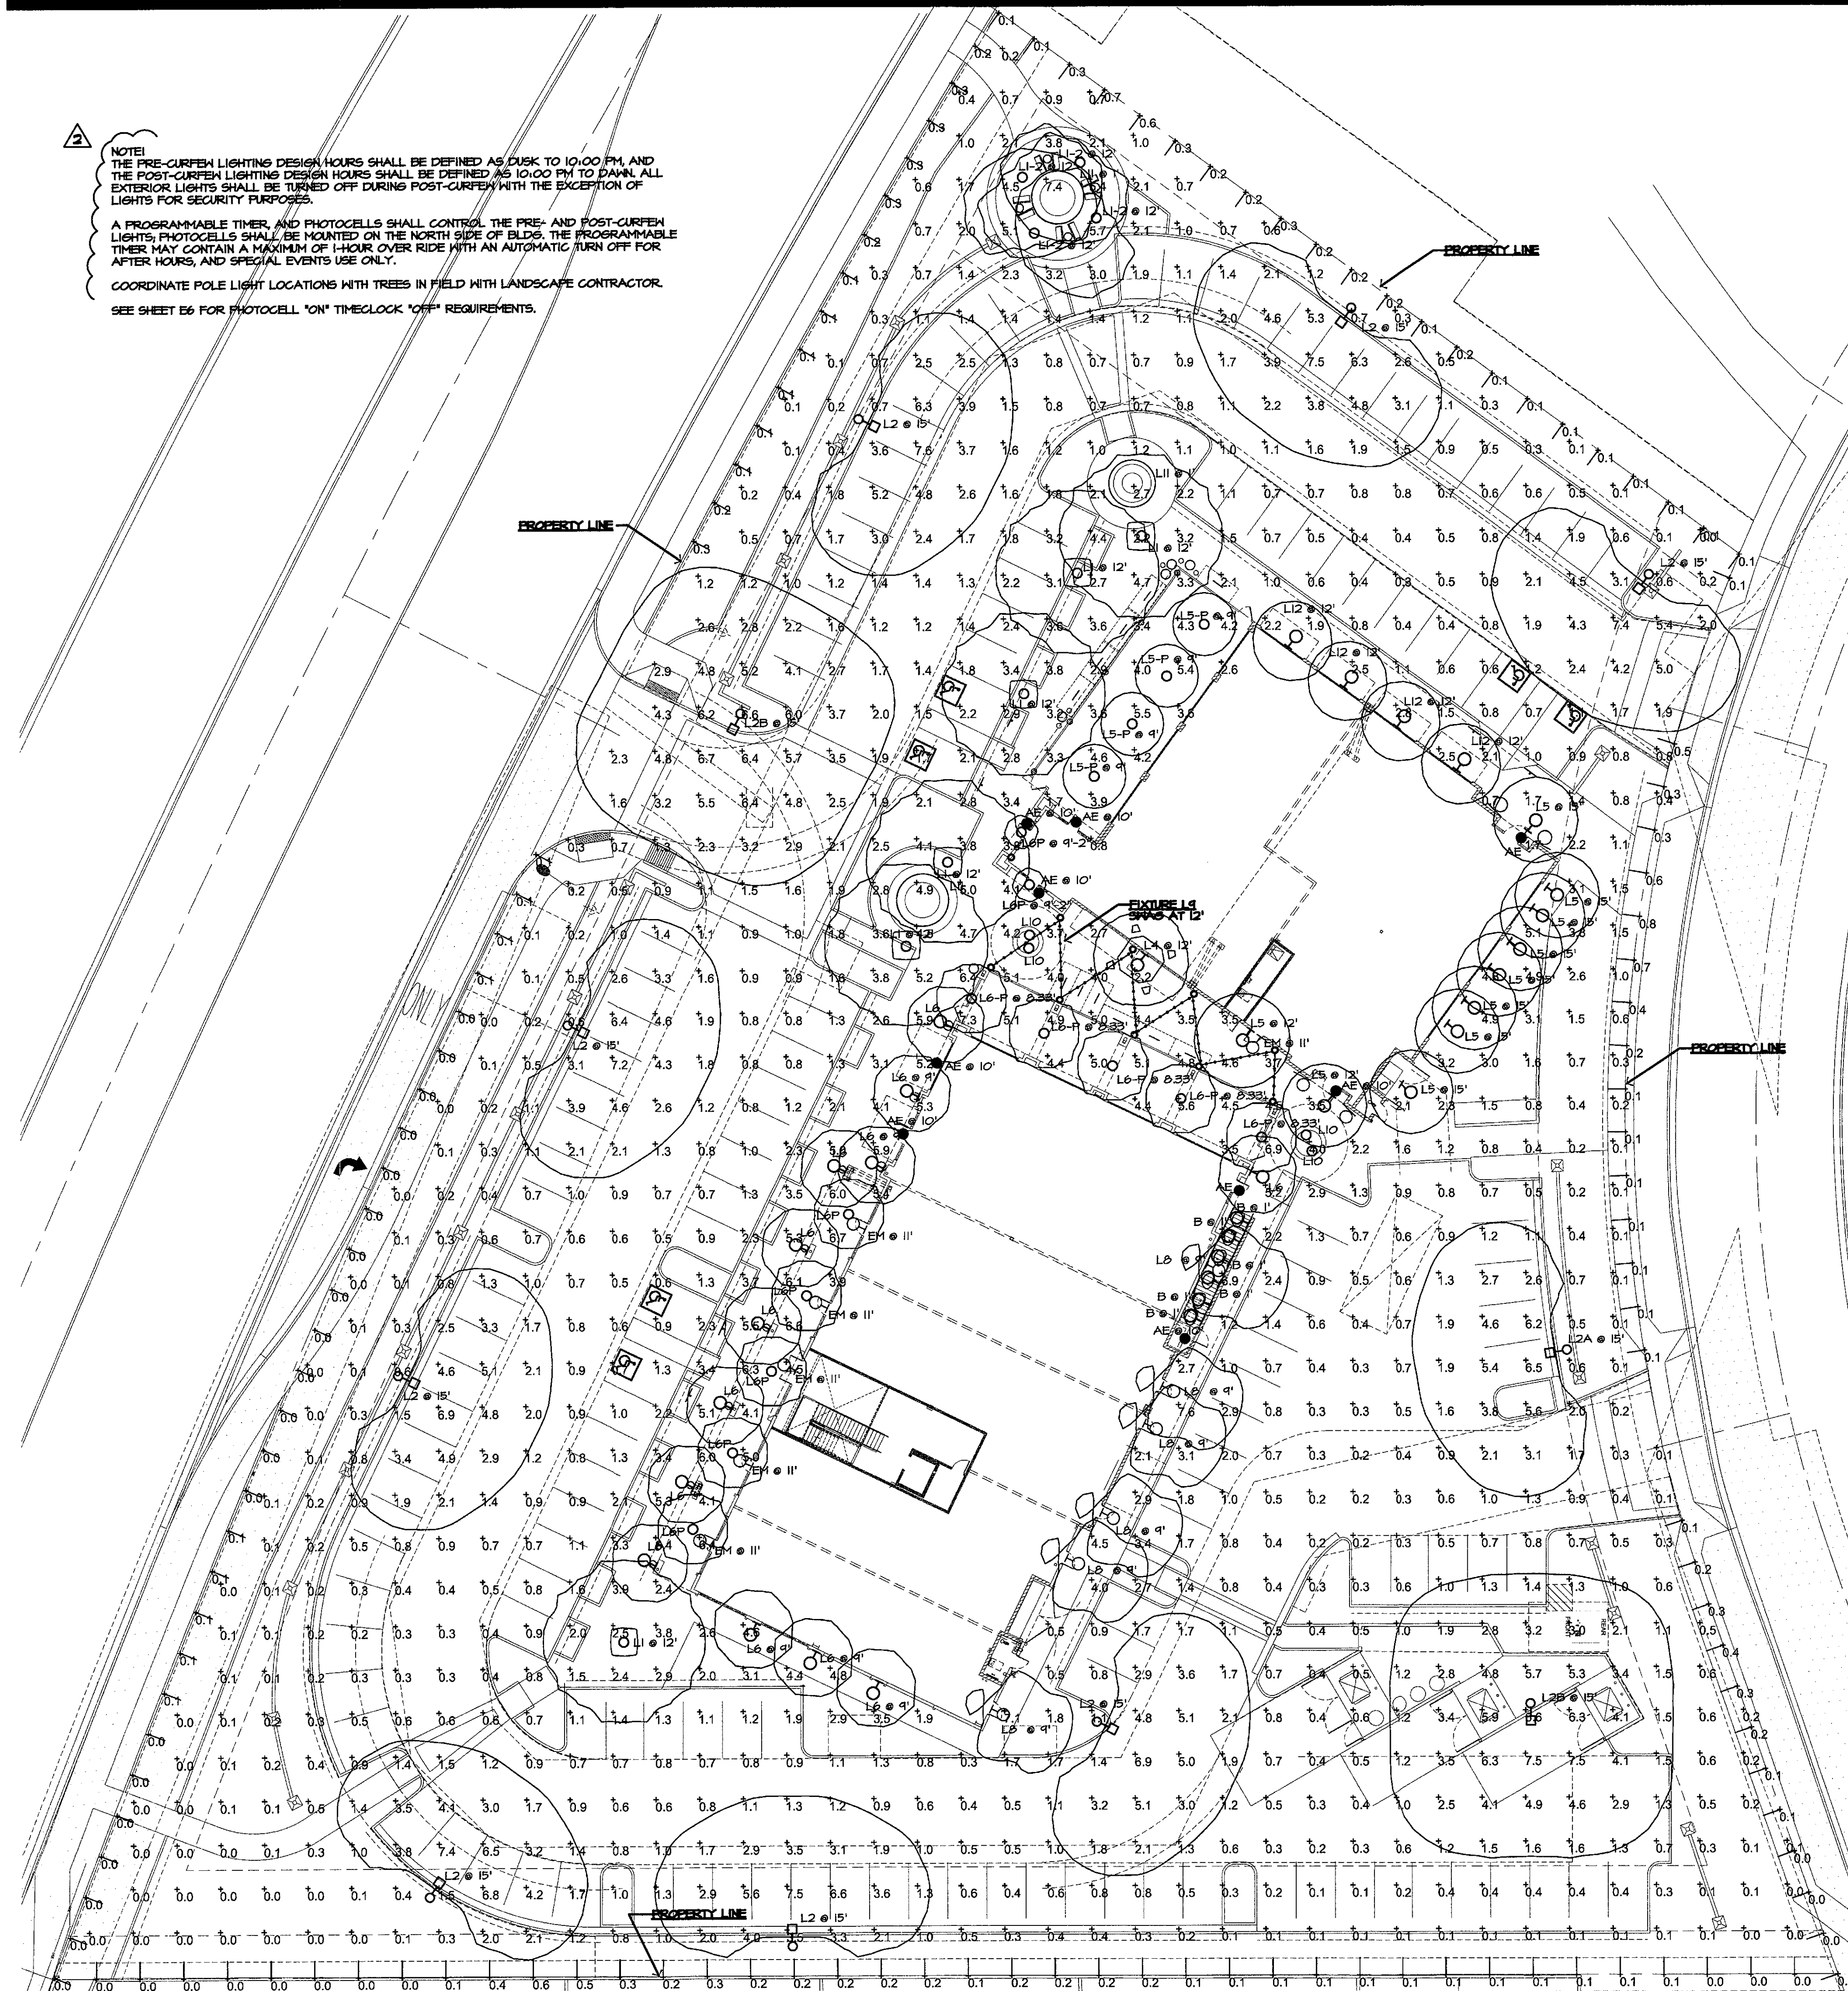

the architectural design and data contained in these documents is an instrument of service provided by FINN architects, llc.

all discrepancies found in these documents, or conflicts between these documents and actual field conditions shall be reported to FINN architects, llc for resolution prior to commencement of the work.

discrepancies between bid amounts and these documents shall be reported to the general contractor prior to commencement of work.

notice of alternate billing cycle: this contract allows the owner to require submission of billings or estimates in billing cycles other than thirty days, a written description of such other billing cycle applicable to this project is available from the owner/owner's designated agent (see cover sheet for phone/address of owner) and the owner/designated agent shall provide this written description upon request.

january 19, 2017
design development
february 01, 2017
owners meeting
february 16, 2017
75% progress set
march 02, 2017
permit submittal
may 19, 2017
CITY COMMENTS/COORD.
AUGUST 30, 2017
PLANNING COMMENTS



GENERAL NOTES:

ALL WORK TO BE PERFORMED IN ACCORDANCE WITH 2014 (OR LATEST ADOPTED) NATIONAL ELECTRICAL CODES ALL APPLICABLE LOCAL CODES, ORDINANCES AND AMENDMENTS TO NEC.

ELECTRICAL CONTRACTOR SHALL COORDINATE W/ GENERAL CONTRACTOR AND CONTACT POWER COMPANY REGARDING EXACT LOCATION OF ALL PRIMARY SERVICE EQUIPMENT, TRENCH LOCATION, TRANSFORMER LOCATION, METER LOCATION, ACCOUNT SETUP, ETC.

ELECTRICAL CONTRACTOR SHALL PROVIDE ALL NECESSARY POWER TRENCHING, BACKFILL, SERVICE EQUIPMENT, TRANSFORMER PADS, AND CONDUIT STUDS IN TRENCH AS REQUIRED BY POWER COMPANY AND TO THEIR SPECIFICATIONS. CONTRACTOR SHALL PROVIDE IN ADDITION TO HIS BID UNIT PRICING FOR PRIMARY 3", 4"EC, 5"EC AND SECONDARY 4" EC, TRENCHING AND BACKFILL.

ELECTRICAL CONTRACTOR SHALL COORDINATE W/ GENERAL CONTRACTOR AND CONTACT TELEPHONE AND CATV COMPANY REGARDING EXACT LOCATION OF ALL PRIMARY SERVICE EQUIPMENT, TRENCH LOCATION, ETC.

ELECTRICAL CONTRACTOR SHALL PROVIDE ALL NECESSARY TELEPHONE AND CATV TRENCHING, BACKFILL, CATV, TTC AND CONDUIT STUDS INTO TRENCH AS REQUIRED BY TELEPHONE AND CATV COMPANY AND TO THEIR SPECIFICATIONS. CONTRACTOR SHALL PROVIDE IN ADDITION TO HIS BID UNIT PRICING FOR 4" EC, 2 1/2"EC AND 1 1/2"EC TRENCHING AND BACKFILL.

ALL PENETRATIONS OF FIRE RESISTIVE FLOORS OR SHAFT WALLS SHALL BE PROTECTED BY MATERIALS AND INSTALLATION DETAILS THAT CONFORM TO UNDERWRITERS LABORATORY'S LISTINGS FOR THROUGH PENETRATION FIRESTOP SYSTEMS. THE CONTRACTOR SHALL SUBMIT SHOP DRAWING DETAILS WHICH SHOW COMPLETE CONFORMANCE TO THE LISTINGS TO THE INSPECTORS. THE DRAWINGS SHALL BE SPECIFIC FOR EACH PENETRATION WITH ALL VARIABLES DEFINED.

ALL WIRING SHALL BE COPPER UNLESS OTHERWISE NOTED. INSULATION SHALL BE TYPE THHN/THAN-2. NON-METALLIC-SHEATHED CABLE WILL NOT BE PERMITTED. MC CABLE (WHERE PERMITTED BY CODE) SHALL BE USED IN NON EXPOSED AREAS ONLY. PANEL FEEDERS, A/C UNIT AND AIR HANDLER BRANCH CIRCUITS SHALL BE THHN/THAN-2 OR XHHW-2. ALL WIRE TERMINATIONS SHALL BE RATED FOR 75 DEGREE MINIMUM. ALL HOMERUNS TO PANELS SHALL BE IN CONDUIT.

ALL WIRING DEVICES AND ELECTRICAL EQUIPMENT SHALL BE COMMERCIAL GRADE. RESIDENTIAL GRADE EQUIPMENT WILL NOT BE PERMITTED. DEVICE COVERPLATES SHALL BE STAINLESS STEEL. DEVICE COLOR SELECTED BY INTERIORS/ARCHITECT.

ALL J-BOXES COVERS AND THE BACK SIDE OF ALL WIRING DEVICE COVERPLATES ON THIS PROJECT SHALL BE MARKED WITH PANEL DESIGNATION AND CIRCUIT NUMBERS PER AS-BUILT CONDITIONS VIA PERMANENT BLACK MARKER.

ALL WIRING FOR OUTSIDE LIGHTING SHALL BE A MINIMUM OF #10 COPPER WITH TYPE THHN INSULATION.

VERIFY EXACT LOCATION, MOUNTING HEIGHT AND ELECTRICAL REQUIREMENTS OF ALL EQUIPMENT PROVIDED BY OTHERS PRIOR TO ROUGH-IN. PROVIDE DISCONNECT SWITCH, TRANSFORMER AS REQUIRED, AND FINAL CONNECTIONS TO EQUIPMENT PER OWNER.

IN ADDITION TO EFCI RECEIPTS SHOWN ALL RECEPTACLES WITHIN 6' OF A SINK OR BASIN, ENTIRE KITCHEN, BREAK ROOM COUNTERS, ENTIRE BATHROOMS, TOILETS, VENDING MACHINES OR EXTERIOR SHALL BE GFCI. PROTECTED AND BE READILY ACCESSIBLE PER NEC 210.8(B).

PROVIDE GROUND WIRE IN ALL RACEWAYS SIZED PER NEC. ART. #250-122. INSTALL 250 LB PULL CORD IN ALL EMPTY CONDUITS.

PROVIDE AND INSTALL ADDITIONAL EXIT SIGNS, EMERGENCY LIGHTS AND NIGHT LIGHTS AS REQUIRED BY GOVERNING INSPECTOR DURING WALK THRU.

ELECTRICAL CONTRACTOR SHALL IDENTIFY ALL PANELS AND DISCONNECT SWITCHES WITH METAL NAMEPLATES AND TYPE PANEL SCHEDULE(S) PER NEC. 110-22 AS REQUIRED BY THIS PROJECT. COORDINATE DESCRIPTION WITH OWNER IN FIELD.


COORDINATE EXACT LOCATION AND MOUNTING HEIGHTS OF ALL OUTLETS WITH ARCH. ELEVATIONS, OWNER AND OR TENANT IN FIELD PRIOR TO ANY ROUGH-IN.

ALL LIGHTING AND ELECTRICAL EQUIPMENT SHALL BE INSTALLED IN ACCORDANCE WITH LOCAL AND NATIONAL ELECTRICAL CODES AND MFR'S RECOMMENDATIONS. ALL FIXTURES, DEVICES AND EQUIPMENT SHALL BE INSTALLED LEVEL/PLUMB AND BEAR THE UL LABEL.

THE ELECTRICAL CONTRACTOR SHALL COORDINATE WITH MECHANICAL CONTRACTOR FOR EXACT LOCATION AND REQUIREMENTS OF ALL MECHANICAL EQUIPMENT BEING PROVIDED PRIOR TO ROUGH-IN. COORDINATE ALL LIGHT FIXTURE LOCATIONS WITH MECH. GRILLE LOCATIONS IN FIELD WITH MECH. CONTRACTOR PRIOR TO ROUGH-IN.

CONTRACTOR SHALL COORDINATE LIGHT SWITCH AND NIGHT LIGHT (NOT EMERGENCY LIGHTS) LOCATIONS WITH OWNER AND/OR TENANT IN FIELD PRIOR TO ROUGH-IN. SEE SYMBOL LIST FOR ADDITIONAL INFO. AND REQUIREMENTS.

APPROVED
FINAL PLANS
10/12/2017
DATE
APPROVED BY

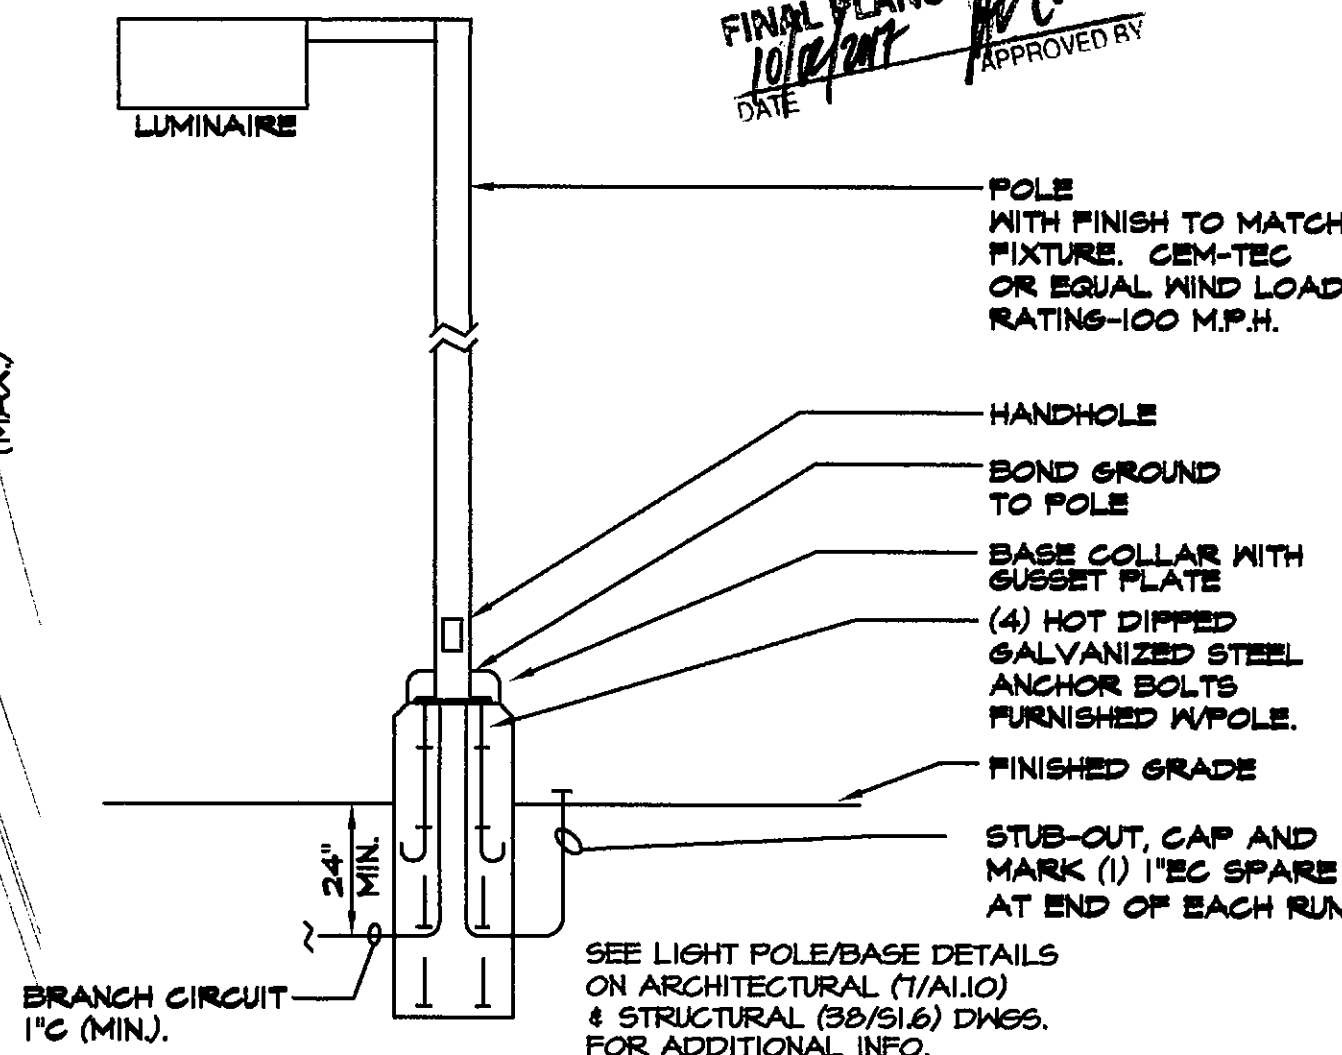

LIGHT FIXTURE 'L2', 'L2A' & 'L2B' DETAIL

(L1' AND 'L1-2' SIMILAR EXCEPT AS NOTED AND DECORATIVE FLUTED POLE W/POSTOP FIXTURE WITH CLAM SHELL BASE.)

NO SCALE

ELECTRICAL SITE PLAN

SCALE: 1" = 20'-0"

TONY WOO ENGINEERING, INC.
1 W. DEER VALLEY RD.
SUITE 203
PHOENIX, AZ 85027
TEL. (602) 279-8092


JOB # 617003

CONTACT: GREG HAMPTON
GREG@TNE.PHXCOXMAIL.COM.

the grove at mccormick

7300 via paseo del sur
scottsdale, arizona

4-ZN-2016 & 2-CP-2016 | 8-DR-2016 | 5-296-17-1 & 296-17-2

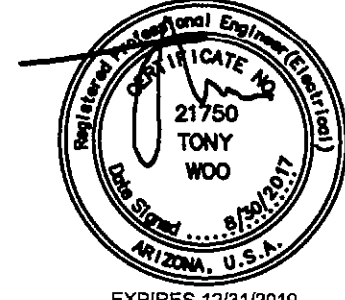

A7.2

(building 'b')

MATERIAL LEGEND

- (STO) STUCCO - SYNTHETIC SYSTEM WITH SAND FINISH. SEE A8.3 LRV81
- (PRE) PRECAST CONCRETE - CONCRETE DESIGNS INC. ACCENT WAINSCOTING - COLOR 'OATMEAL' - ACID ETCH FINISH
- (COR) PRECAST COLUMN - CONCRETE DESIGNS INC. TUSCAN 14"x8"-0" U.N.O. - COLOR 'OATMEAL' - ACID ETCH FINISH
- (BLK) SMOOTH BLOCK - WESTERN BLOCK - 8x4x16 AND 4x16 SMOOTH FACE SHELLS/VENEER - COLOR 'JAVELINA BROWN' WITH LIGHT OVERGROUT FINISH
- (ACT) ACCENT TILE - TABARKA STUDIO - ASAMA 8"x8" PATTERN - COLOR 'NATURAL TERRACOTTA' - FINISH 'CARAMEL'
- (AC2) ACCENT TILE - ARIZONA TILE - MARRAKESH - COLOR 'PORC GREY' MATTE MIX - FINISH 'MATTE'
- (AWN) CANVAS AWNING - SUNBRELLA - AWNING FABRIC - COLOR 'TERRACOTTA' - EXTERIOR GRADE
- (MTL) METAL PAINT - KYNAR 500 (O.E.) STEEL PAINT, COLOR 'DARK BRONZE' - MATTE FINISH
- (WBM) WOOD BEAMS - ELMWOOD RECLAIMED TIMBER, PRODUCT 'ANTIQUE OAK' - COLOR #2 - FINISH 'RESAWN TIMBER'
- (CLA) CLAY ROOF TILE - SEE ROOF PLAN FOR SPEC. BORAL 2 PIECE CLAY TILE -60% NEWPORT 40% CARMEL BLEND WITH 100% TUSCANY FANS
- (FAS) STAIN GRADE EXTERIOR FASCIA AND RAFTER TAILS AND WINDOW TRIM (see plans/color legend for finish)

the architectural design and data contained in these documents is an instrument of service provided by FINN architects, llc.

all discrepancies found in these documents, or conflicts between these documents and actual field conditions shall be reported to FINN architects, llc for resolution prior to commencement of the work.

discrepancies between bid amounts and these documents shall be reported to the general contractor prior to commencement of work.

notice of alternate billing cycle: this contract allows the owner to require submission of billings or estimates in billing cycles other than thirty days. a written description of such other billing cycle applicable to this project is available from the owner/owner's designated agent (see cover sheet for phone/address of owner) and the owner/designated agent shall provide this written description upon request.

January 19, 2017	design development
February 01, 2017	owners meeting
February 16, 2017	75% progress set
March 02, 2017	permit submittal
March 18, 2017	admin dtd submittal
August 09, 2017	admin dtd resubmittal
September 06, 2017	permit submittal

COLOR LEGEND

- ① DUNN EDWARDS - 'ANTIQUE PAPER' DE6218 LRV81
- ② MINWAX - 'CHESTNUT' GEL STAIN
- ③ MINWAX - 'GOLDEN OAK' MATTE FINISH, WATER BASED STAIN

March 12, 2017 city comments/coord.
August 30, 2017 3rd permit submittal
August 30, 2017 city comments



AV3
DESIGN BUILD
1001 N. 1ST AVE
SCOTTSDALE, AZ 85261

SEALANTS TO MATCH ADJACENT MATERIAL COLORS, WHITE OR OFF WHITE SEALANTS ARE NOT ALLOWED

PAINTER SHALL PROVIDE (2) COATS OF SEALER TO ALL NATURAL BLOCK, PRECAST CONCRETE ITEMS, CONCRETE AND NON-PAINTED SURFACES AND MATERIALS FOR A WEATHER SEALED PROJECT

PAINTER SHALL PROVIDE CMU, BLOCK, CONCRETE AND OTHER MATERIALS WITH FINISH, PAINT COLOR FOR REVIEW AND APPROVAL PRIOR TO APPLICATION - ANY PAINT FINISHES TO BE APPLIED TO THE ACTUAL BUILDING SHALL BE APPROVED PRIOR BY CONTRACTOR/ARCHITECT FOR LOCATION AND SIZE PRIOR TO APPLICATION

STOREFRONT | GLAZING SPECIFICATION

ALUMINUM STOREFRONT SYSTEM:

ARCADIA AFG451 2" X 4 1/2", CENTER GLAZED NON-THERMAL STOREFRONT

- DARK BRONZE FINISH
- 1" OVERALL GLAZING - SEE GLAZING BELOW

1" INSULATED GLAZING (GROUND FLOOR)

- OUTBOARD: 1/4" PPG SOLARBAN R100 ON CLEAR #2
- AIR SPACE: 1/2" SPACER, AIR FILLED
- INBOARD: 1/4" CLEAR
- U-FACTOR - 0.29, SHGC = 0.23

1" INSULATED GLAZING (SECOND FLOOR)

- OUTBOARD: 1/4" PPG SOLARCOOL #2 ON SOLARBONORE
- AIR SPACE: 1/2" SPACER, AIR FILLED
- INBOARD: 1/4" SOLARBAN 60 #3 ON CLEAR
- U-FACTOR - 0.29, SHGC = 0.16

the grove at mccormick

7300 n. via paseo del sur
scottsdale, arizona

4-IN-2016 & 2-GP-2016 | 8-DR-2016 | 12-PP-2016 | PLAN CHECK #S 296-17-1 & 296-17-2


building B
exterior elevations
scale: 1/8"=1'-0"

FINN architects, llc


1810 west loermann drive, queen creek, arizona 85142 (480-206-8229)



EXPIRES 09/30/2020

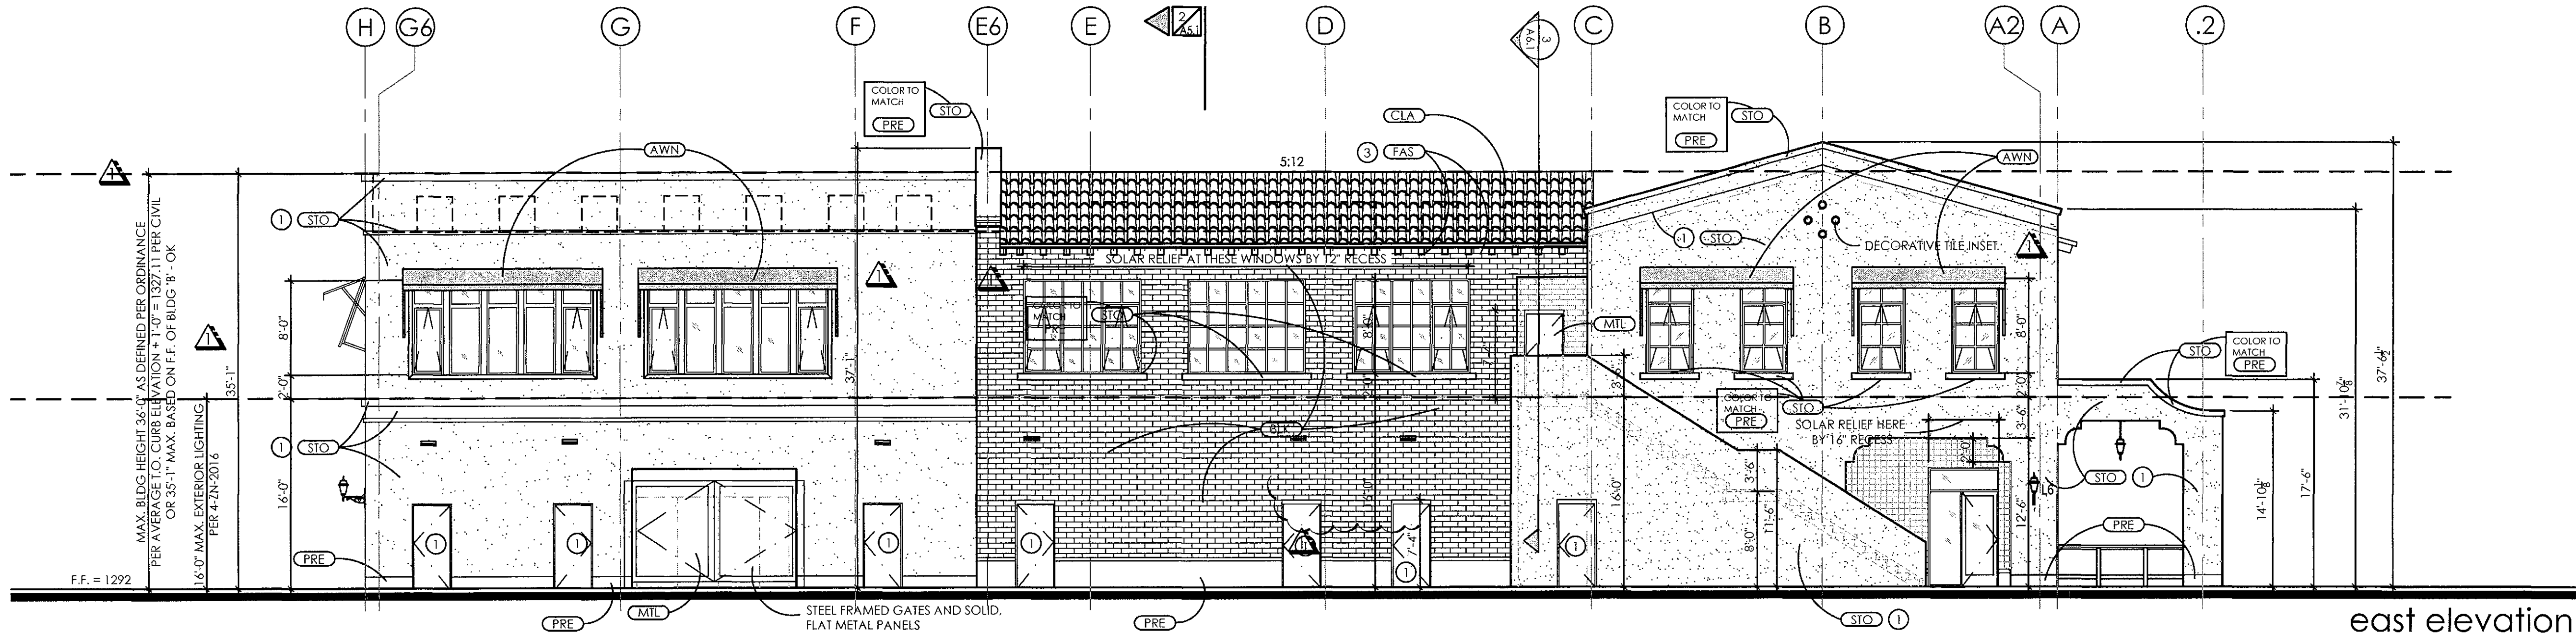

east elevation

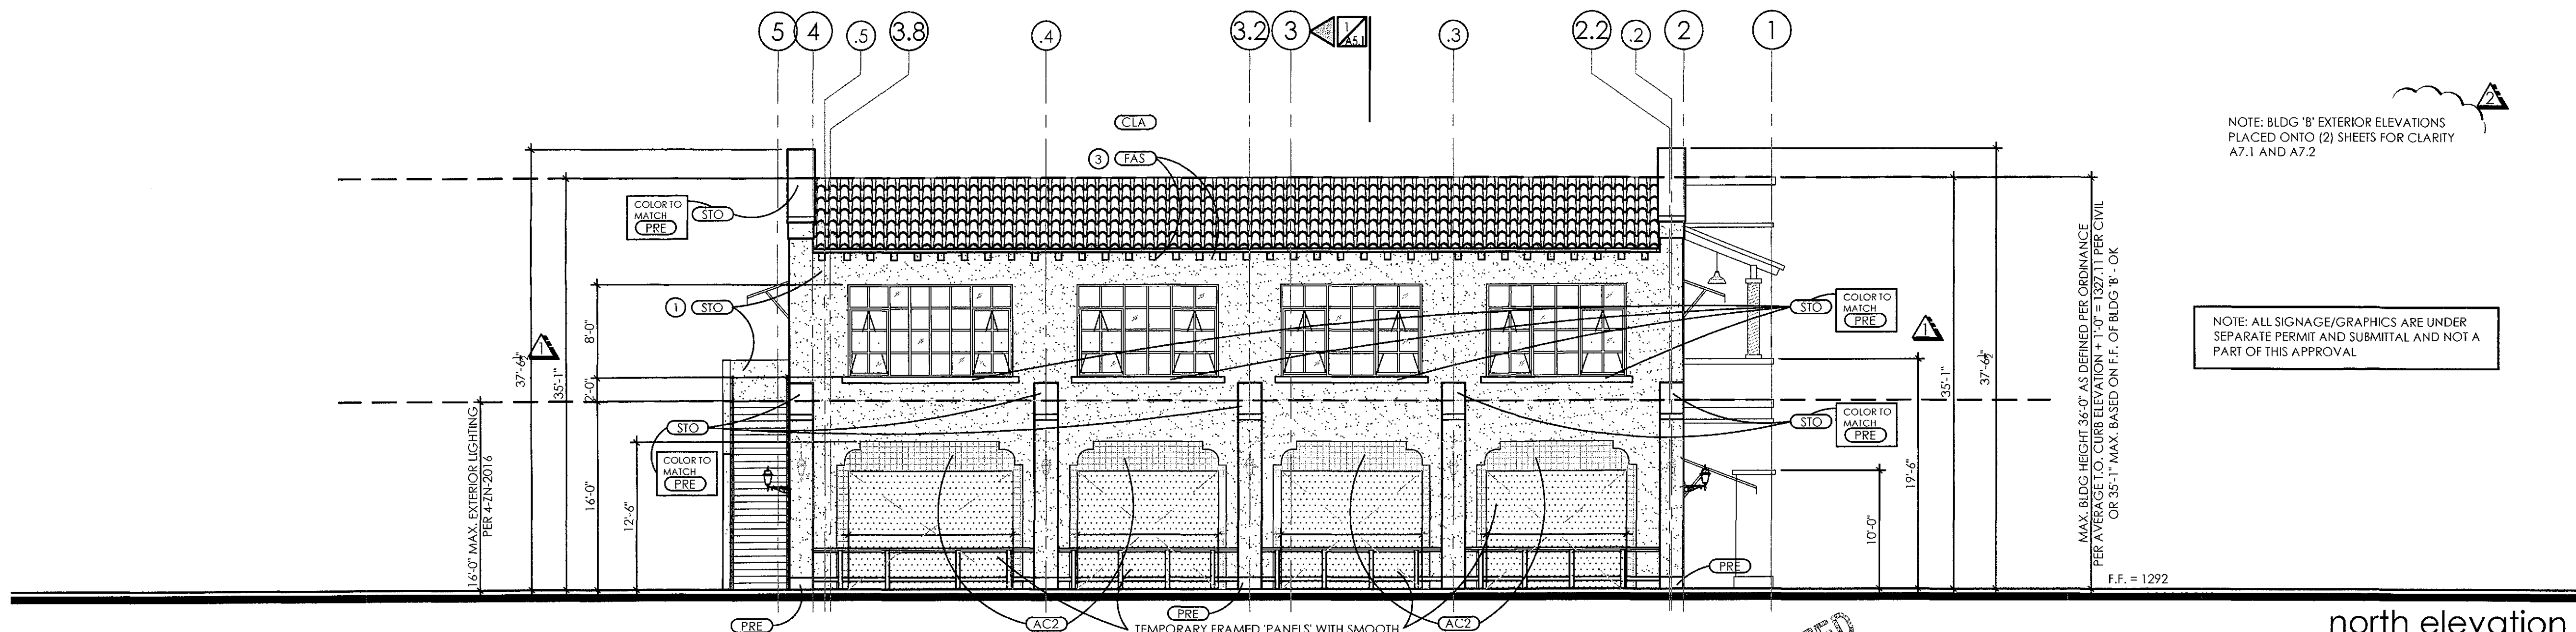

north elevation

PLAN NOTES

SEE STRUCTURAL PLANS FOR LINTELS/INFORMATION

SEE STRUCTURAL DRAWINGS FOR CONTROL JOINT LOCATIONS - WHERE CONTROL JOINTS OCCUR BENEATH WALL FINISH SYSTEMS, THE CONTROL JOINT AND WALL FINISH SHALL BE CARRIED THRU - PROVIDE MANUFACTURE APPROVED CONTROL JOINT TRIM, JOINTS AS APPLICABLE PER WALL FINISH


SEE FLOOR PLAN AND SCHEDULES FOR DOOR HEIGHTS. IN CMU WALLS CONFIRM FRAMES 'COURSE' WITH MODULAR CMU HEIGHTS

ALL CMU LINTELS ARE TO BE LINTEL BLOCKS, NO 2 CORE OR HOLLOW CMU ALLOWED

ALL ROOF DRAIN LEADERS ARE TO BE BRASS 'LAMBS' TONGUE, COMPLETE WITH TRIM RING - NO PVC ALLOWED

PRIOR TO PROCURING MATERIALS, CONTRACTOR SHALL PROVIDE SAMPLES OF ALL MATERIALS, COLORS FOR REVIEW AND APPROVAL BY ARCHITECT AND OWNER

ALL SAMPLES SHALL BE SUBMITTED FOR REVIEW AS A COMPLETE SUBMITTAL, AT ONE TIME, MATERIAL SAMPLES SHALL BE LARGE ENOUGH TO DEPICT THE FINISH, TEXTURE OF 12" SQUARE OR AS APPROPRIATE

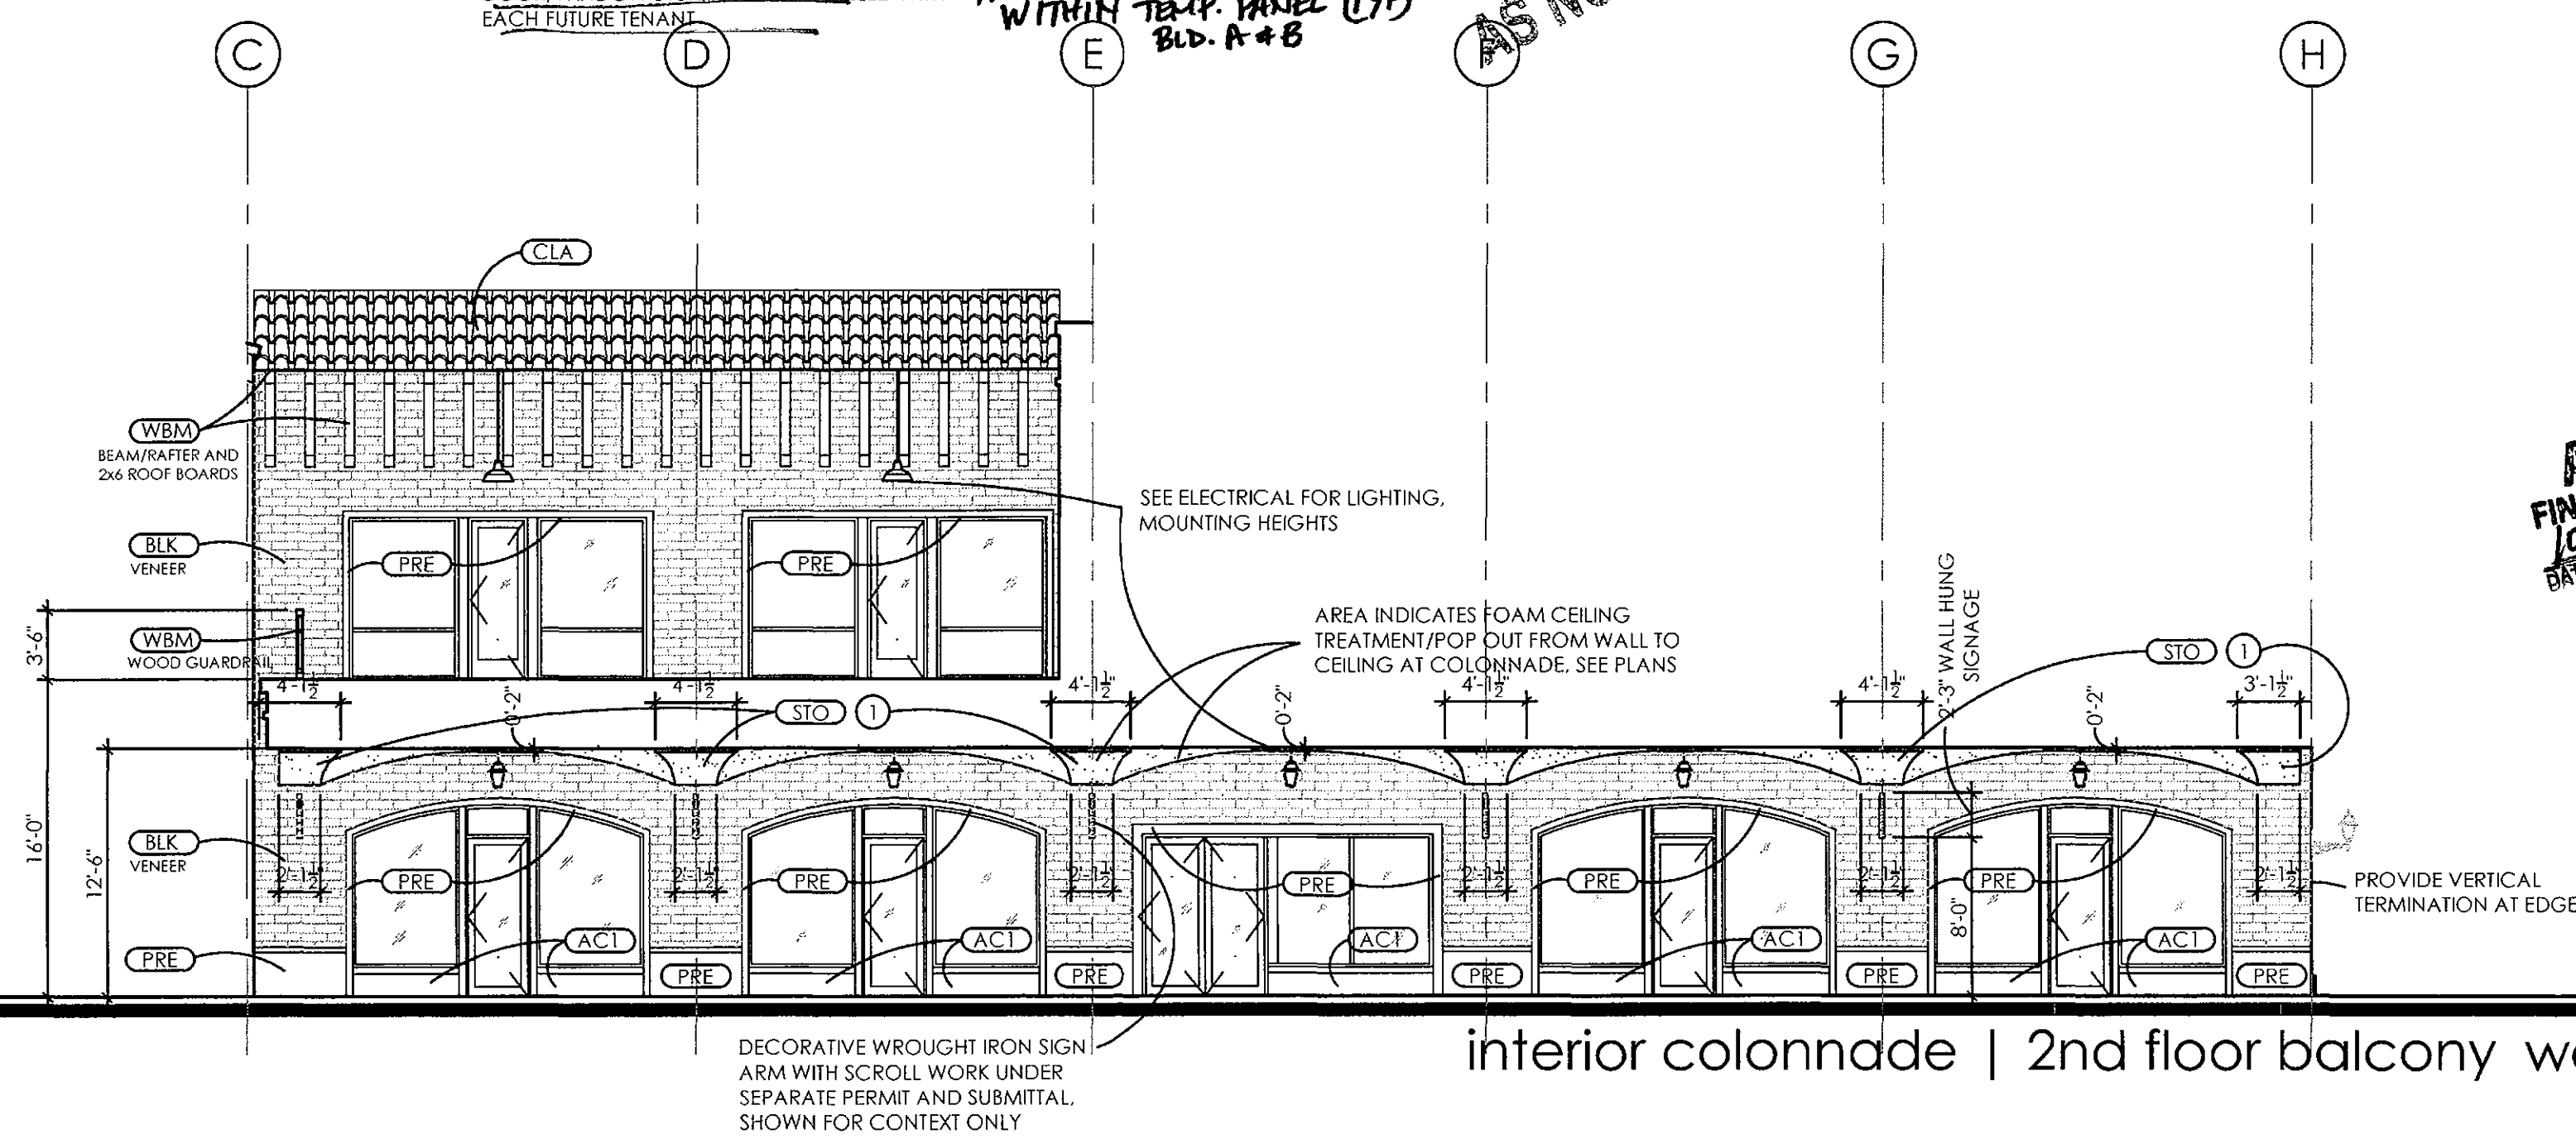

interior colonnade | 2nd floor balcony west elevation

APPROVED
FINAL PLANS
10/02/2017
DATE
AS NOTED

A7.1

(building 'b')

MATERIAL LEGEND

- (STO) STUCCO - SYNTHETIC SYSTEM WITH SAND FINISH. SEE A8.3 LRV81
- (PRE) PRECAST CONCRETE - CONCRETE DESIGNS INC. ACCENT WAINSCOTING - COLOR 'OATMEAL' - ACID ETCH FINISH
- (COL) PRECAST COLUMN - CONCRETE DESIGNS INC. TUSCAN 1'4"x8'-0" U.N.O. - COLOR 'OATMEAL' - ACID ETCH FINISH
- (BLK) SMOOTH BLOCK - WESTERN BLOCK - 8x4x16 AND 4x16 SMOOTH FACE SHELLS/VENEER - COLOR 'JAVELINA BROWN' WITH LIGHT OVERGROUT FINISH
- (ACT) ACCENT TILE - TABARCA STUDIO - ASAMA 8"x8" PATTERN - COLOR 'NATURAL TERRACOTTA' - FINISH 'CARAMEL'
- (AC2) ACCENT TILE - ARIZONA TILE - MARRAKESH - COLOR 'PORC GREY MATTE MIX' - FINISH 'MATTE'
- (AWN) CANVAS AWNING - SUNBRELLA - AWNING FABRIC - COLOR 'TERRACOTTA' - EXTERIOR GRADE
- (MIL) METAL PAINT - KYNAR 500 (O.E.) STEEL PAINT, COLOR 'DARK BRONZE' - MATTE FINISH
- (WBN) WOOD BEAMS - ELMWOOD RECLAIMED TIMBER, PRODUCT 'ANTIQUE OAK' - COLOR #2 - FINISH 'RESAWN TIMBER'
- (CLA) CLAY ROOF TILE - SEE ROOF PLAN FOR SPEC, BORAL 2 PIECE CLAY TILE - 60% NEWPORT 40% CARMEL BLEND WITH 100% TUSCANY PANS
- (FAS) STAIN GRADE EXTERIOR FASCIA AND RAFTER TAILS AND WINDOW TRIM (see plans/color legend for finish)

COLOR LEGEND

- ① DUNN EDWARDS - 'ANTIQUE PAPER' DE6218 LRV81
- ② MINWAX - 'CHESTNUT' GEL STAIN
- ③ MINWAX - 'GOLDEN OAK' MATTE FINISH, WATER BASED STAIN

SEALANTS TO MATCH ADJACENT MATERIAL COLORS, WHITE OR OFF WHITE SEALANTS ARE NOT ALLOWED

PAINTER SHALL PROVIDE (2) COATS OF SEALER TO ALL NATURAL BLOCK, PRECAST CONCRETE ITEMS, CONCRETE AND NON-PAINTED SURFACES AND MATERIALS FOR A WEATHER SEALED PROJECT

PAINTER SHALL PROVIDE CMU, BLOCK, CONCRETE AND OTHER MATERIALS WITH FINISH, PAINT COLOR FOR REVIEW AND APPROVAL PRIOR TO APPLICATION - ANY PAINT FINISHES TO BE APPLIED TO THE ACTUAL BUILDING SHALL BE APPROVED PRIOR BY CONTRACTOR/ARCHITECT FOR LOCATION AND SIZE PRIOR TO APPLICATION

STOREFRONT | GLAZING SPECIFICATION

ALUMINUM STOREFRONT SYSTEM:

ARCADIA AFG451 2" X 4 1/2", CENTER GLAZED NON-THERMAL STOREFRONT

- DARK BRONZE FINISH
- 1" OVERALL GLAZING, SEE GLAZING BELOW

1" INSULATED GLAZING (GROUND FLOOR)

- OUTBOARD: 1/4" PPG SOLARBAN R100 ON CLEAR #2
- AIR SPACE: 1/2" SPACER, AIR FILLED
- INBOARD: 1/4" CLEAR
- U-FACTOR - 0.29, SHGC = 0.23

1" INSULATED GLAZING (SECOND FLOOR)

- OUTBOARD: 1/4" PPG SOLARCOOL #2 ON SOLARBRONZE
- AIR SPACE: 1/2" SPACER, AIR FILLED
- INBOARD: 1/4" SOLARBAN 60 #3 ON CLEAR
- U-FACTOR - 0.29, SHGC = 0.18

ALL ROOF DRAINS ARE INTERNALIZED. SEE 5/A8.2

APPROVED
FINAL PLANS PLANNING
10/10/2017
DATE: 10/10/2017
BY: [Signature]

building & b
exterior elevations

scale: 1/8"=1'-0"

FINN architects, llc

1810 west loemann drive, queen creek, arizona 85142

(480-206-8229)

January 19, 2017
design development
February 01, 2017
owners meeting
February 16, 2017
75% progress set
March 02, 2017
permit submittal
March 18, 2017
admin drb submittal
August 09, 2017
admin drb resubmittal
September 06, 2017
permit submittal

LGE
DESIGN BUILD

AV3
DESIGN STUDIO
4025 S. 19TH AVENUE
SUITE 200
DENVER, CO 80202


the grove at mccormick

7300 n. via paseo del sur
scottsdale, arizona


4-IN-2016 & 2-CP-2016 | 8-DR-2016 | 12-PP-2016 | PLAN CHECK #5 296-17-1 & 296-17-2

REGISTERED ARCHITECT
STEVEN J. NEVALA
52718
ARIZONA, U.S.A.

EXPIRES 09/30/2020

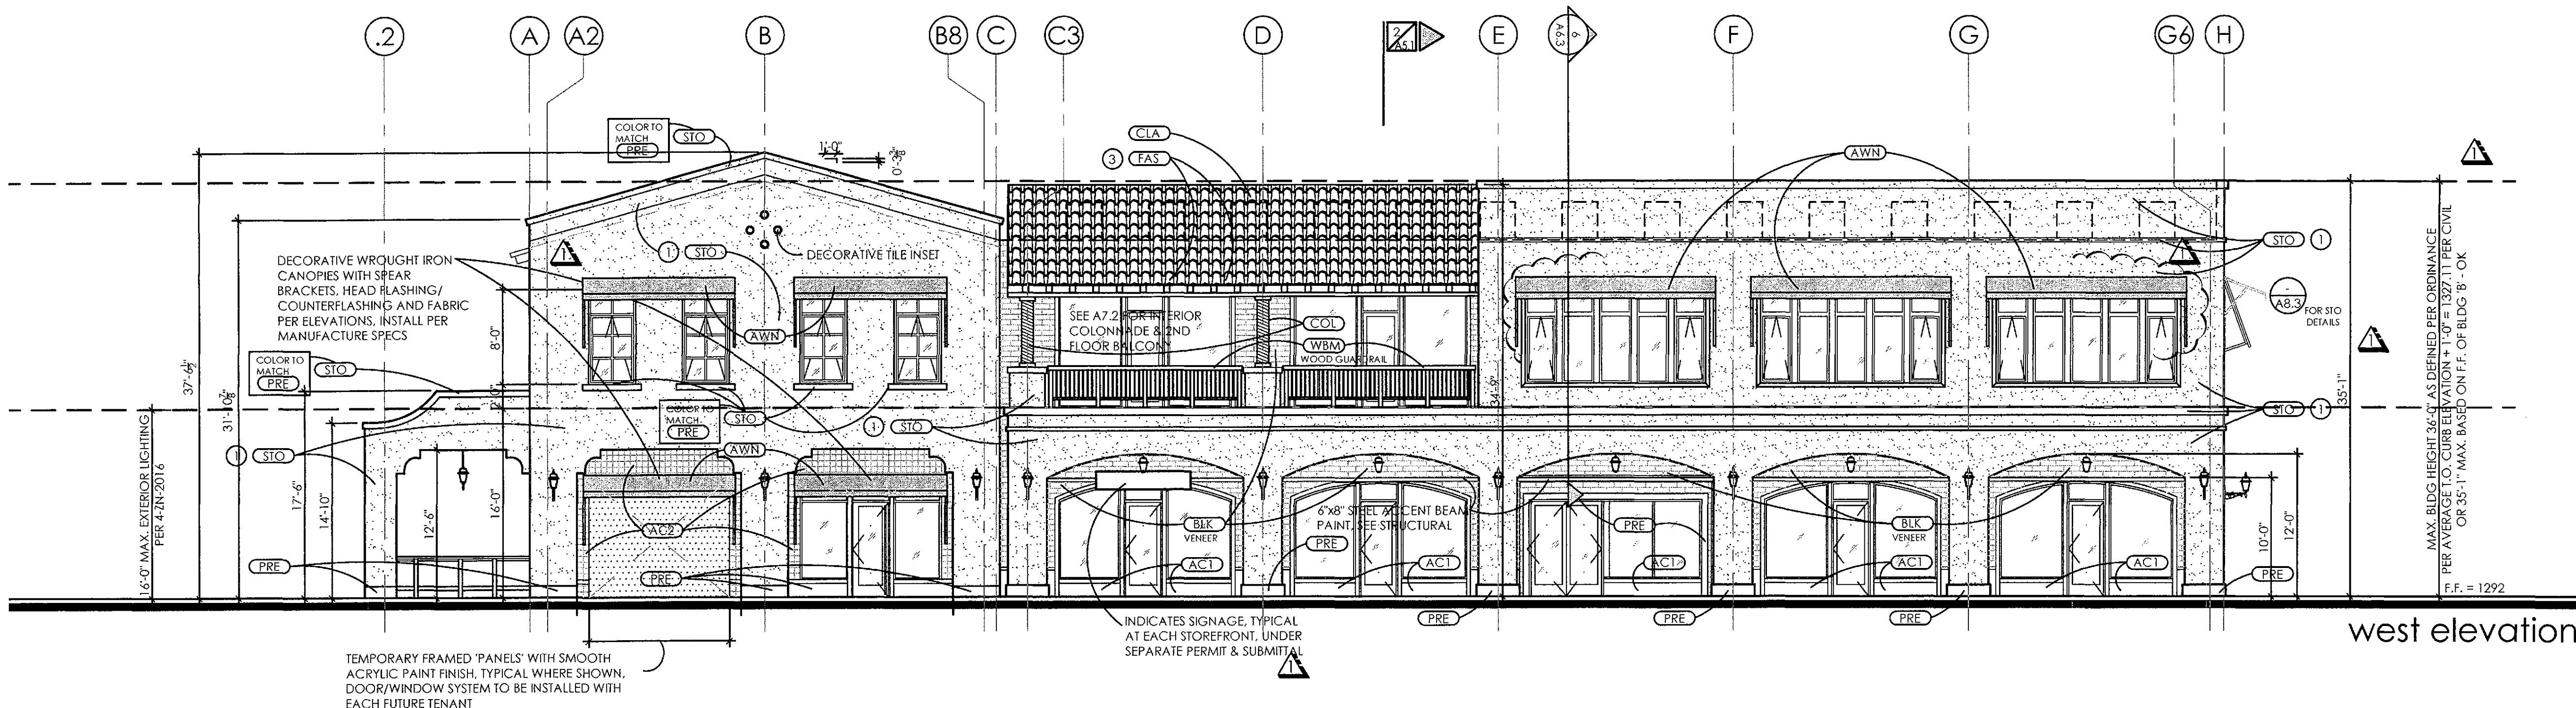


west elevation

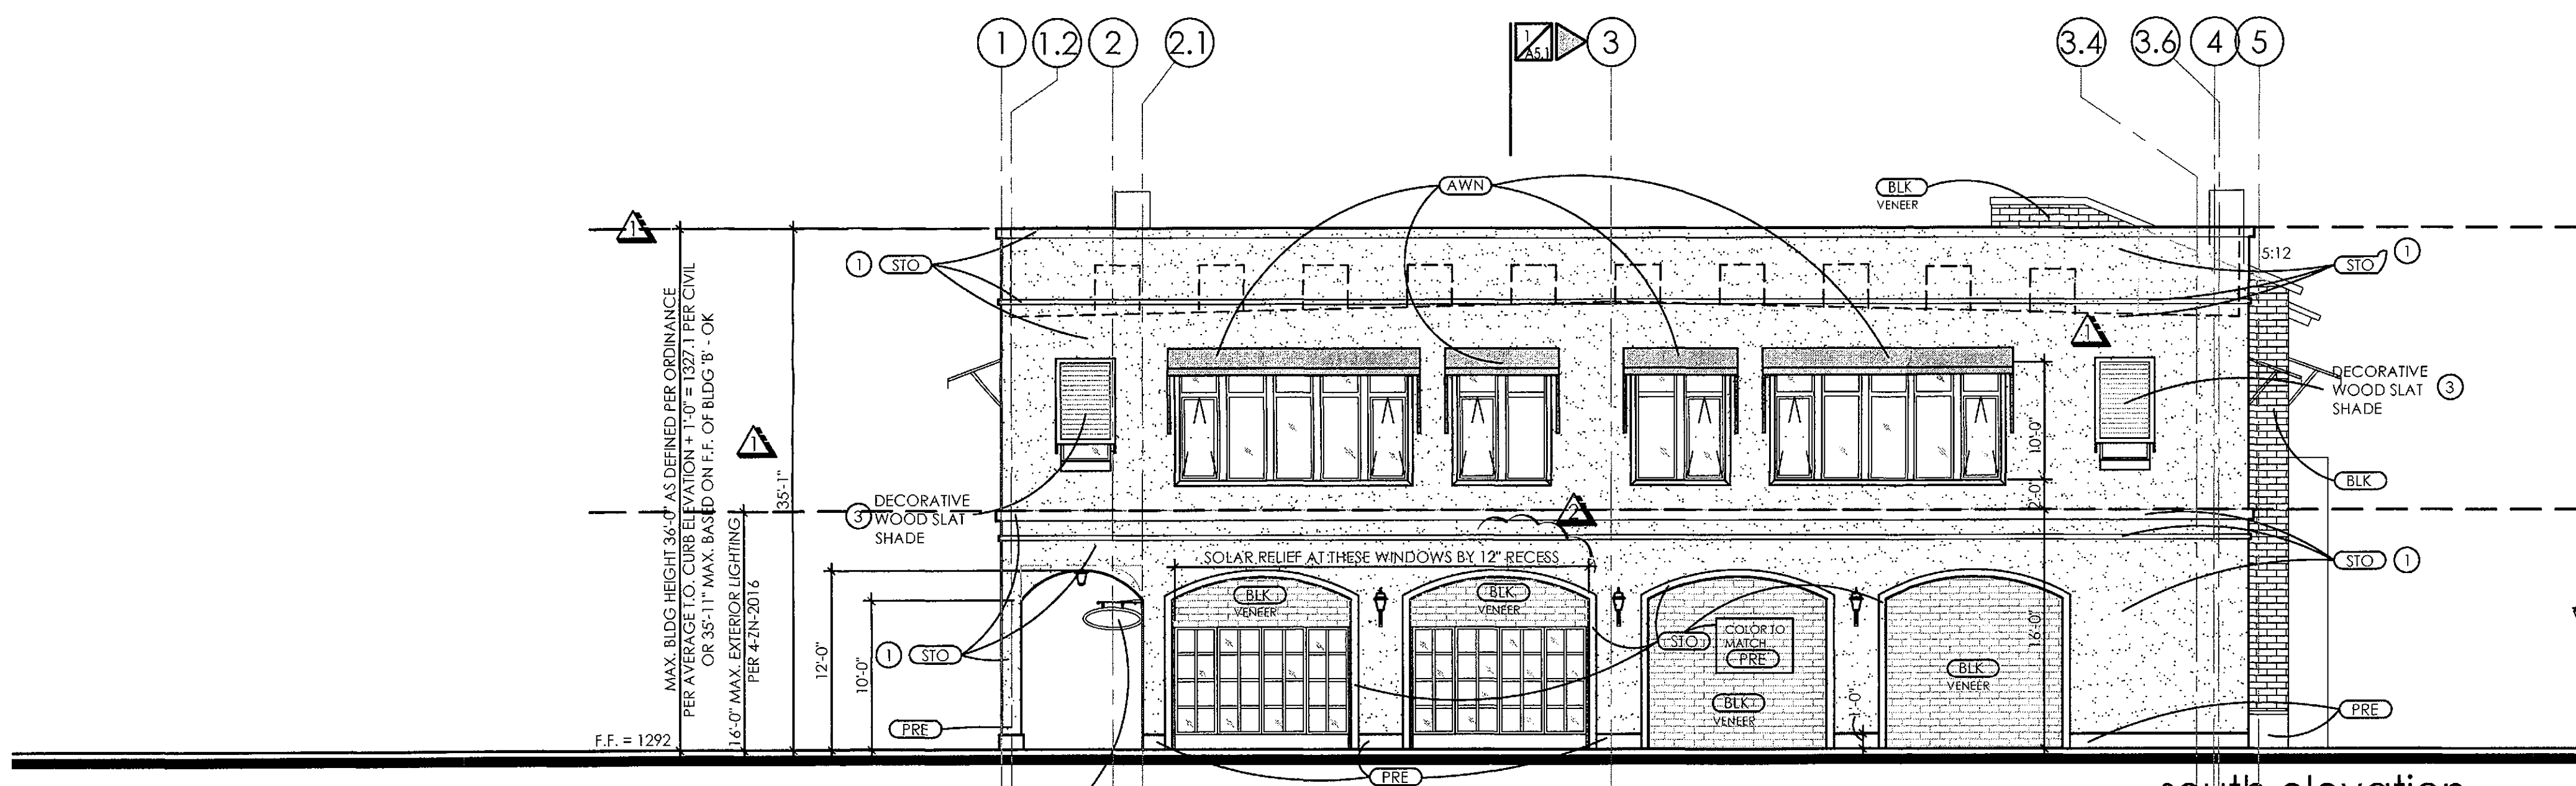

south elevation

NOTE: ALL SIGNAGE IS UNDER SEPARATE PERMIT AND SUBMITTAL

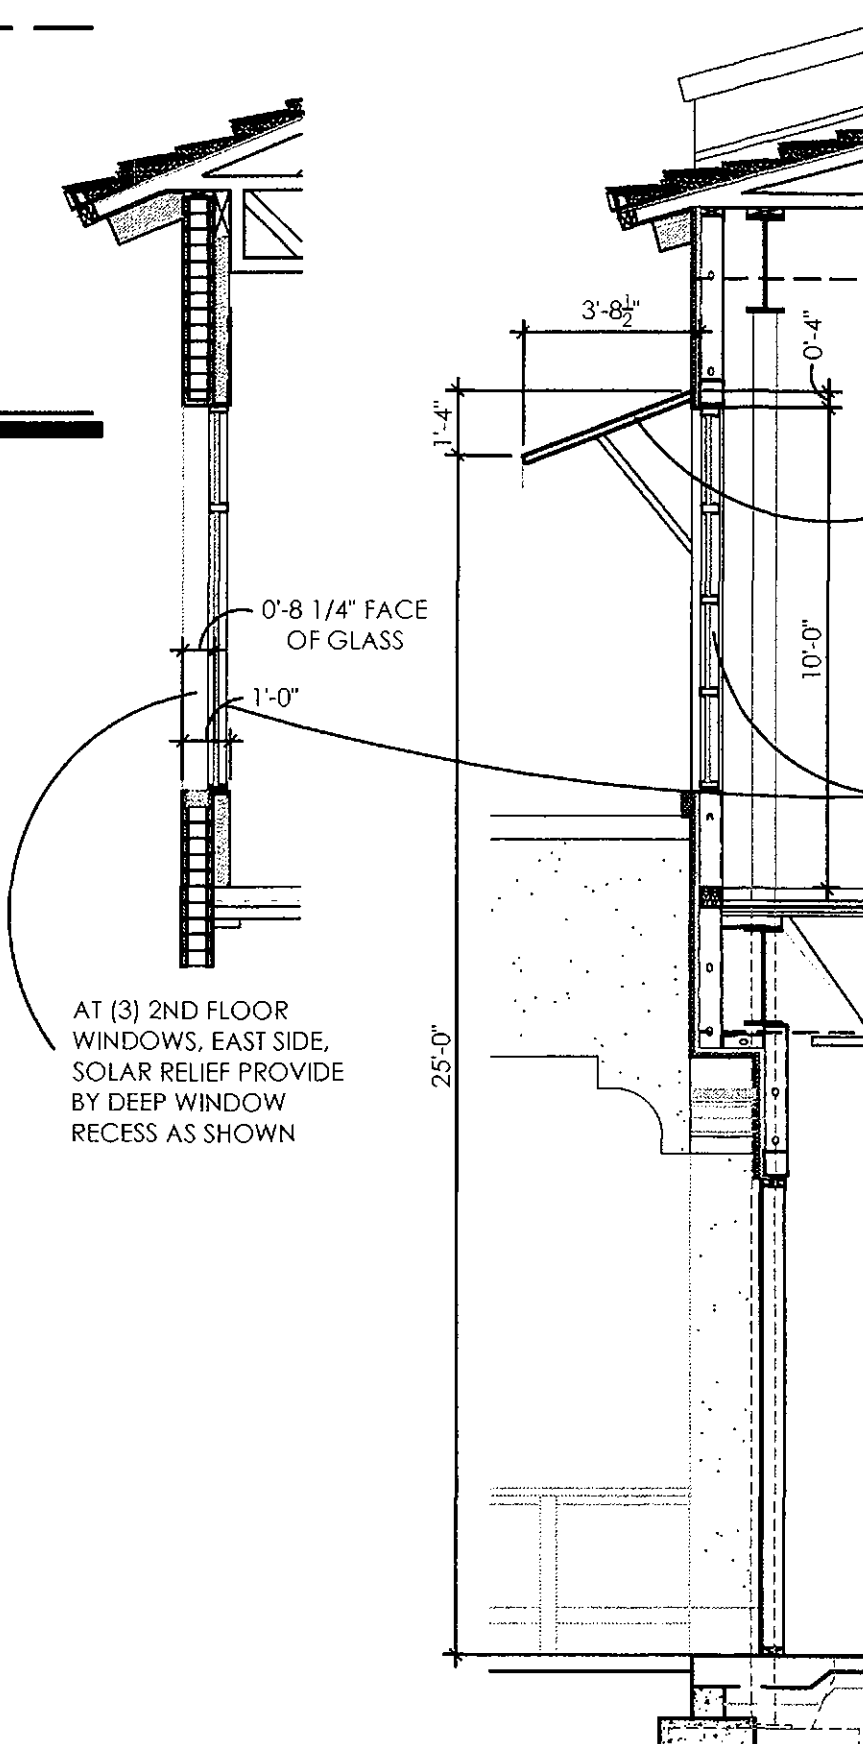

AT (3) 2ND FLOOR WINDOWS, EAST SIDE, SOLAR RELIEF PROVIDE BY DEEP WINDOW RECESS AS SHOWN

NOTE: BLDG 'B' EXTERIOR ELEVATIONS PLACED ONTO (2) SHEETS FOR CLARITY A7.1 AND A7.2

PLAN NOTES

SEE STRUCTURAL PLANS FOR LINTELS/INFORMATION

SEE STRUCTURAL DRAWINGS FOR CONTROL JOINT LOCATIONS - WHERE CONTROL JOINTS OCCUR BENEATH WALL FINISH SYSTEMS, THE CONTROL JOINT AND WALL FINISH SHALL BE CARRIED THRU - PROVIDE MANUFACTURE APPROVED CONTROL JOINT TRIM, JOINTS AS APPLICABLE PER WALL FINISH

SEE FLOOR PLAN AND SCHEDULES FOR DOOR HEIGHTS. IN CMU WALLS CONFIRM 'FRAMES' COURSE' WITH MODULAR CMU HEIGHTS

ALL CMU LINTELS ARE TO BE LINTEL BLOCKS, NO 2 CORE OR HOLLOW CMU ALLOWED

ALL ROOF DRAIN LEADERS ARE TO BE BRASS 'LAMBS' TONGUE, COMPLETE WITH TRIM RING - NO PVC ALLOWED

PRIOR TO PROCURING MATERIALS, CONTRACTOR SHALL PROVIDE SAMPLES OF ALL MATERIALS, COLORS FOR REVIEW AND APPROVAL BY ARCHITECT AND OWNER

ALL SAMPLES SHALL BE SUBMITTED FOR REVIEW AS A COMPLETE SUBMITTAL, AT ONE TIME, MATERIAL SAMPLES SHALL BE LARGE ENOUGH TO DEPICT THE FINISH, TEXTURE OF 12" SQUARE OR AS APPROPRIATE

DECORATIVE WROUGHT IRON SIGN ARM WITH SCROLL WORK UNDER SEPARATE PERMIT AND SUBMITTAL, SHOWN FOR CONTEXT ONLY

TEMPORARY FRAMED 'PANELS' WITH SMOOTH ACRYLIC PAINT FINISH, TYPICAL WHERE SHOWN, DOOR/WINDOW SYSTEM TO BE INSTALLED WITH EACH FUTURE TENANT

INDICATES SIGNAGE, TYPICAL AT EACH STOREFRONT, UNDER SEPARATE PERMIT & SUBMITTAL

MAX. BLDG HEIGHT 36'-0" AS DEFINED PER ORDINANCE PER AVERAGE TO CURB ELEVATION + 1'-0" = 1327.11 PER CIVIL OR 35'-11" MAX. BASED ON F.F. OF BLDG 'B' - OK

MAX. BLDG HEIGHT 36'-0" AS DEFINED PER ORDINANCE PER AVERAGE TO CURB ELEVATION + 1'-0" = 1327.11 PER CIVIL OR 35'-11" MAX. BASED ON F.F. OF BLDG 'B' - OK

MAX. BLDG HEIGHT 36'-0" AS DEFINED PER ORDINANCE PER AVERAGE TO CURB ELEVATION + 1'-0" = 1327.11 PER CIVIL OR 35'-11" MAX. BASED ON F.F. OF BLDG 'B' - OK

F.F. = 1292

A7.1

(building 'a')

MATERIAL LEGEND

- (STO) STUCCO - SYNTHETIC SYSTEM WITH SAND FINISH - SEE A8.3 LRV81
- (PRE) PRECAST CONCRETE - CONCRETE DESIGNS INC. ACCENT WAINSCOTING - COLOR 'OATMEAL' - ACID ETCH FINISH
- (COL) PRECAST COLUMN - CONCRETE DESIGNS INC. TUSCAN 14"x8'-0" U.N.O. - COLOR 'OATMEAL' - ACID ETCH FINISH
- (SVR) STONE VENEER - APACHE STONE (O.E.) ACCENT BASE WAINSCOT - COLOR 'NAKANTAN' WITH HEAVY OVERGROUT MORTAR WASH
- (ACC) ACCENT TILE - TABARKA STUDIO - ADAMA 6-HEXAGON - (2) COLOR PATTERN - 'DARK' 'AFOR LIGHT' 'AGUR' - SEALED
- (AWN) CANVAS AWNING - SUNBRELLA - AWNING FABRIC - COLOR 'BEAFORE CLASSIC' - EXTERIOR GRADE
- (MTL) METAL PAINT - KYNAR 500 (O.E.) STEEL PAINT, COLOR 'DARK BRONZE' - MATTE FINISH
- (WBM) WOOD BEAMS - ELMWOOD RECLAIMED TIMBER, PRODUCT 'ANTIQUE OAK' - COLOR #2 - FINISH 'RESAWN TIMBER'
- (CLA) CLAY ROOF TILE - SEE ROOF PLAN FOR SPEC. BORAL 2 PIECE CLAY TILE - 60% NEWPORT 40% CARMEL BLEND WITH 100% TUSCANY PANS
- (FAS) STAIN GRADE EXTERIOR FASCIA AND RAFTER TAILS (see plans/color legend for finish)

COLOR LEGEND

- ① DUNN EDWARDS - 'ANTIQUE PAPER' DE6218 LRV81
- ② MINWAX - 'CHESTNUT' GEL STAIN
- ③ MINWAX - 'GOLDEN OAK' MATTE FINISH, WATER BASED STAIN

SEALANTS TO MATCH ADJACENT MATERIAL COLORS, WHITE OR OFF WHITE SEALANTS ARE NOT ALLOWED

PAINTER SHALL PROVIDE (2) COATS OF SEALER TO ALL NATURAL BLOCK, PRECAST CONCRETE ITEMS, CONCRETE AND NON-PAINTED SURFACES AND MATERIALS FOR A WEATHER SEALED PROJECT

PAINTER SHALL PROVIDE CMU, BLOCK, CONCRETE AND OTHER MATERIALS WITH FINISH, PAINT COLOR FOR REVIEW AND APPROVAL PRIOR TO APPLICATION - ANY PAINT FINISHES TO BE APPLIED TO THE ACTUAL BUILDING SHALL BE APPROVED PRIOR BY CONTRACTOR/ARCHITECT FOR LOCATION AND SIZE PRIOR TO APPLICATION

STOREFRONT | GLAZING SPECIFICATION

ALUMINUM STOREFRONT SYSTEM:

ARCADIA, AFG451 2" X 4 1/2", CENTER GLAZED NON-THERMAL STOREFRONT

- DARK BRONZE FINISH
- 1" OVERALL GLAZING, SEE GLAZING BELOW

1" INSULATED GLAZING

- OUTBOARD: 1/4" PPG SOLARBAN R100 ON CLEAR #2
- AIR SPACE: 1/2" SPACER, AIR FILLED
- INBOARD: 1/4" CLEAR
- U-FACTOR - 0.029, SHGC = 0.23

PLAN NOTES

SEE STRUCTURAL PLANS FOR LINTELS/INFORMATION

SEE STRUCTURAL DRAWINGS FOR CONTROL JOINT LOCATIONS - WHERE CONTROL JOINTS OCCUR BENEATH WALL FINISH SYSTEMS, THE CONTROL JOINT AND WALL FINISH SHALL BE CARRIED THRU - PROVIDE MANUFACTURE APPROVED CONTROL JOINT TRIM, JOINTS AS APPLICABLE PER WALL FINISH

SEE FLOOR PLAN AND SCHEDULES FOR DOOR HEIGHTS, IN CMU WALLS CONFIRM FRAMES 'COURSE' WITH MODULAR CMU HEIGHTS

ALL CMU LINTELS ARE TO BE LINTEL BLOCKS, NO 2 CORE OR HOLLOW CMU ALLOWED

ALL ROOF DRAIN LEADERS ARE TO BE BRASS 'LAMBS' TONGUE, COMPLETE WITH TRIM RING - NO PVC ALLOWED

PRIOR TO PROCURING MATERIALS, CONTRACTOR SHALL PROVIDE SAMPLES OF ALL MATERIALS, COLORS FOR REVIEW AND APPROVAL BY ARCHITECT AND OWNER

ALL SAMPLES SHALL BE SUBMITTED FOR REVIEW AS A COMPLETE SUBMITTAL, AT ONE TIME. MATERIAL SAMPLES SHALL BE LARGE ENOUGH TO DEPICT THE FINISH, TEXTURE OF 12" SQUARE OR AS APPROPRIATE

building a
exterior elevations

scale: 1/8"=1'-0"

FINN architects, llc


1810 west loemann drive, queen creek, arizona 85142

(480-206-8229)



the grove at mccormick

7300 n. via paseo del sur
scottsdale, arizona

4-2N-2016 & 2-GF-2016 | 8-DR-2016 | 2-PP-2016 | 132-SA-2017 | PLAN CHECK #5 296-17-1 & 296-17-2

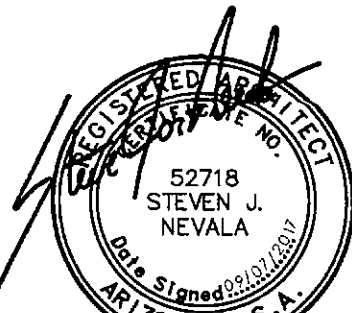

EXPIRES 09/30/2020

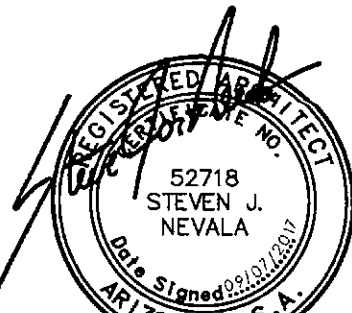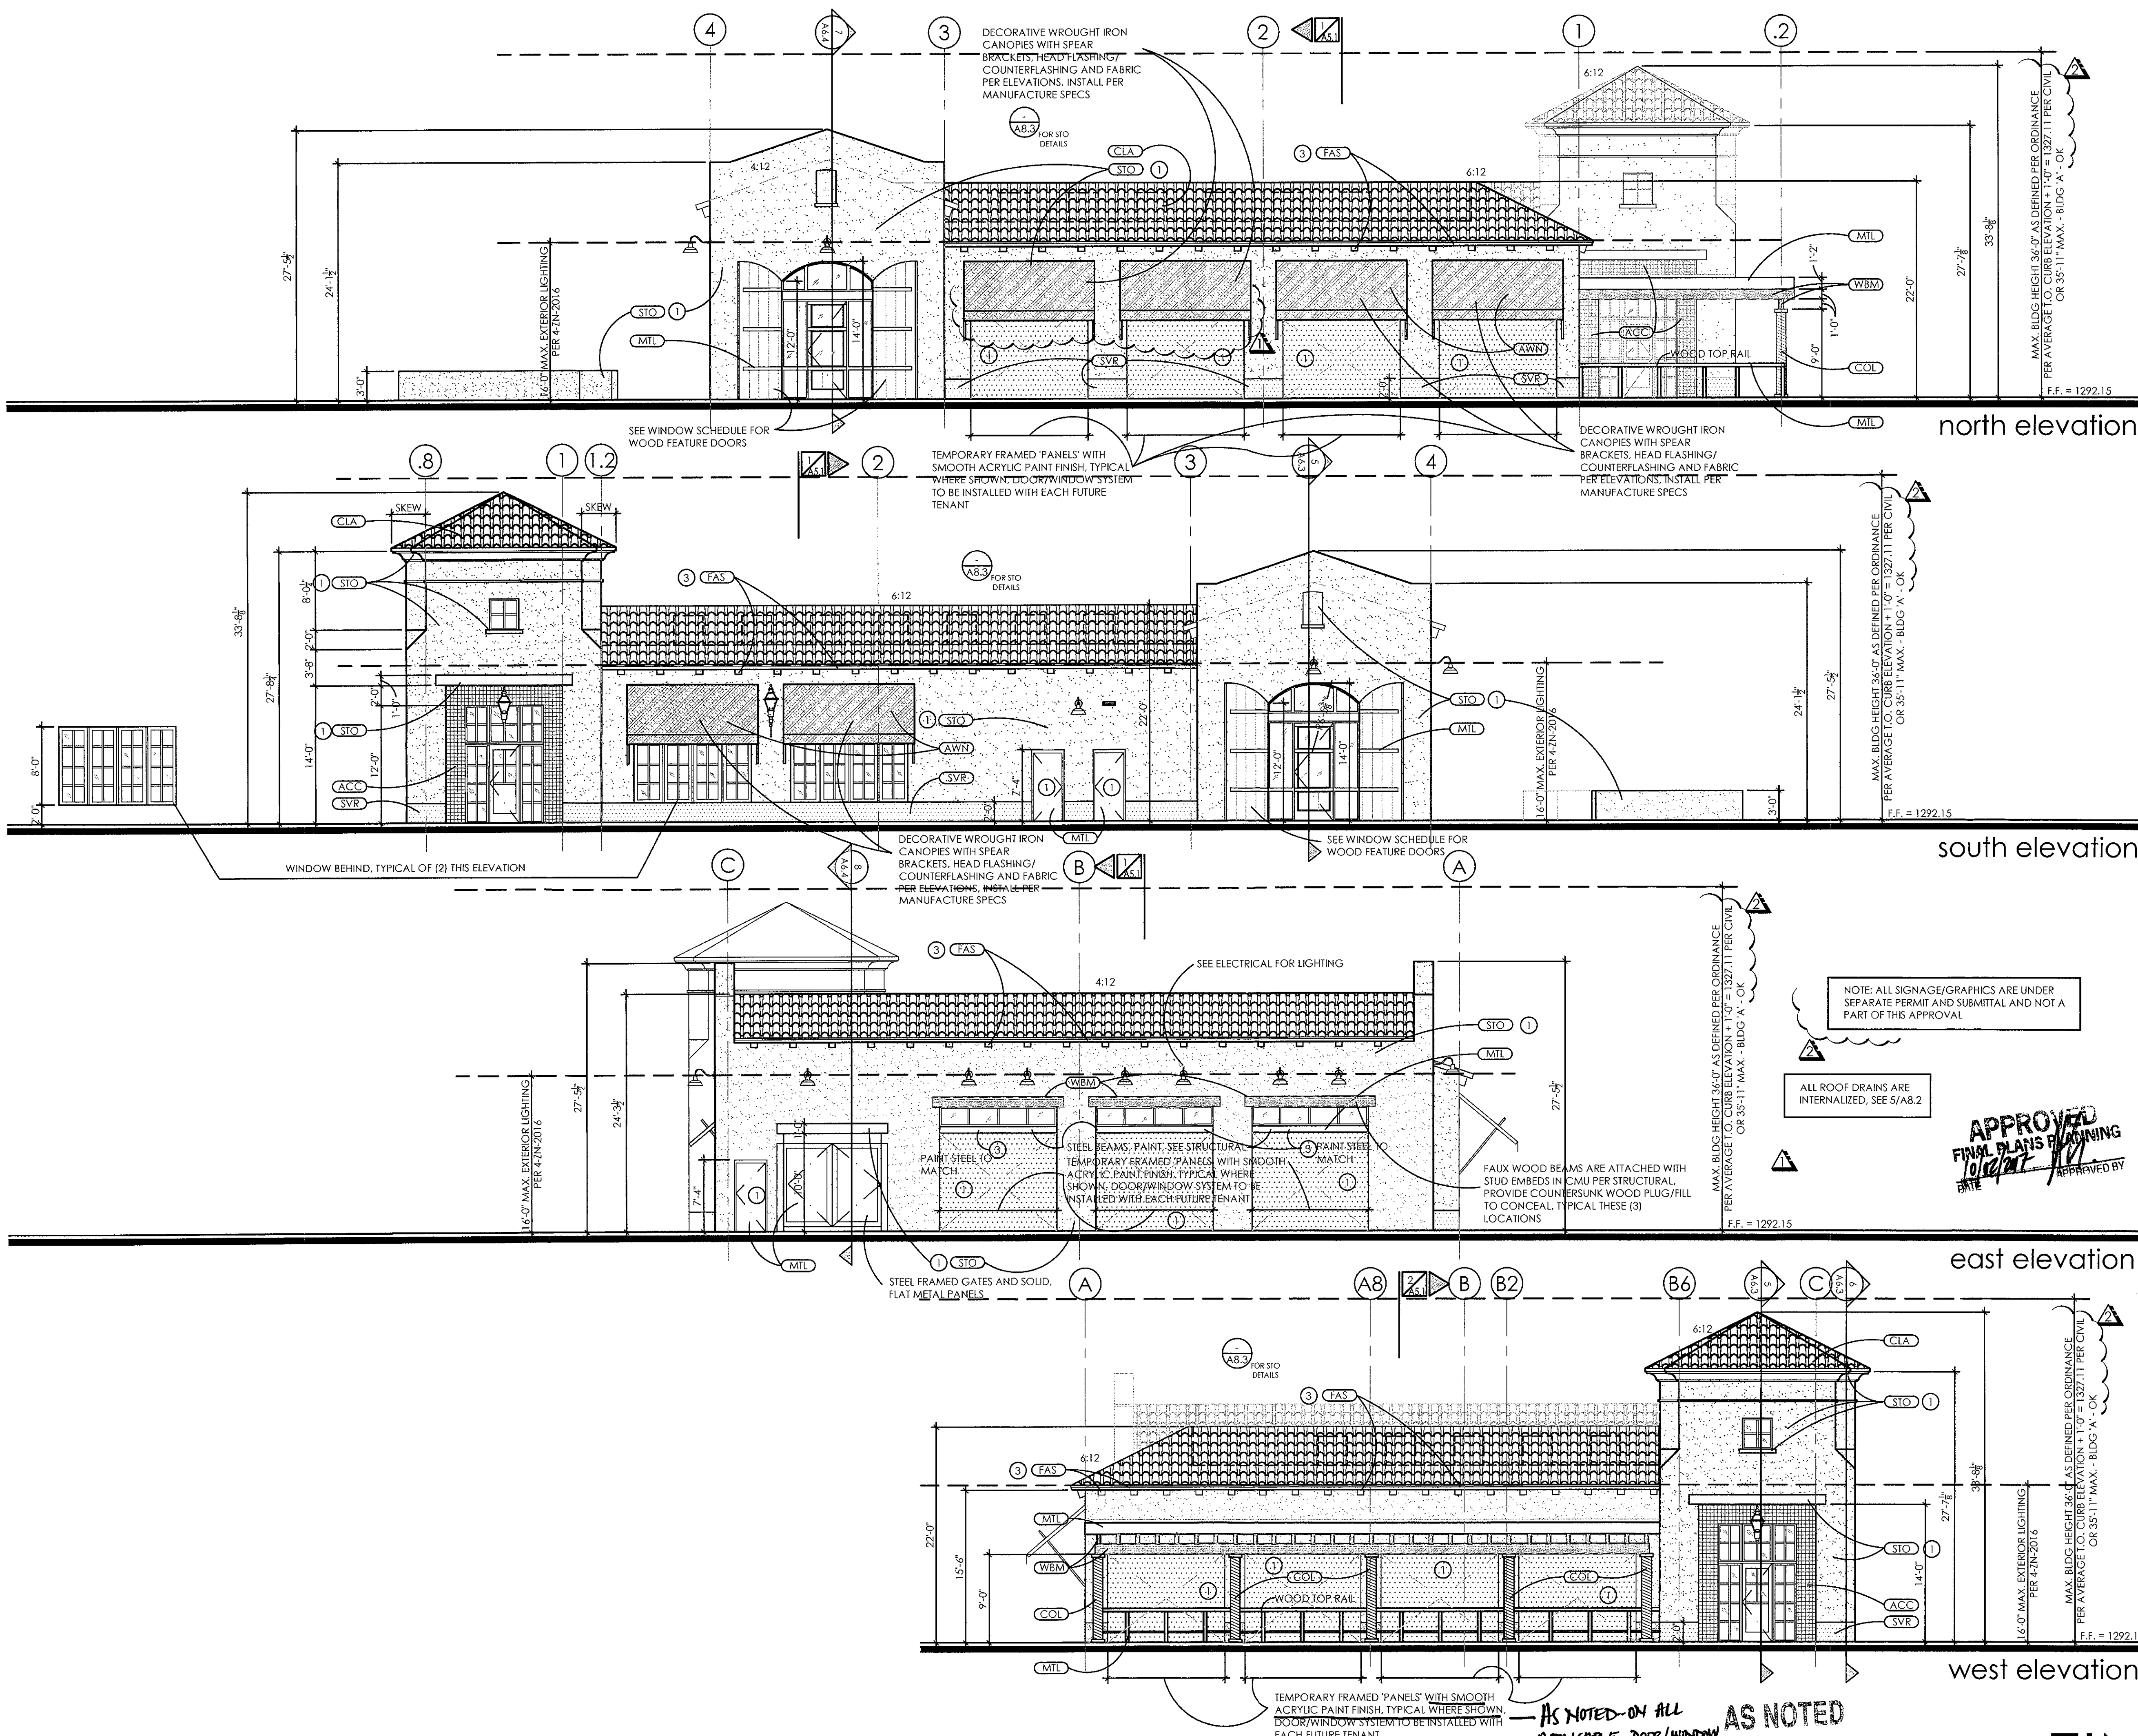

EXPIRES 09/30/2020

PROJECT DATA

ADDRESS: 7300 N. VIA PASEO DEL SUR, SCOTTSDALE, AZ
APN: 177-03-216
ZONING: C-1, PCD
LAND USE: NEIGHBORHOOD COMMERCIAL
SITE AREA: +/-115,254 S.F. (+/-2.64 AC.)





OPEN SPACE CALCULATIONS

OPEN SPACE REQUIRED (5,1304)		
BUILDING HEIGHT 36'-0"		
FIRST 12'-0" (10%)	115,254	11,525 S.F.
NEXT 24'-0" HEIGHT: 24 x (0.4%)	115,254	11,064 S.F.
OPEN SPACE REQUIRED:		22,589 S.F.

PROVIDED OPEN SPACE		21,300 S.F.
FRONT OPEN SPACE		21,300 S.F.
(REQUIRED FRONT SPACE	= 22,589 x .5 =	11,295 S.F.)
COMMON OPEN SPACE		15,203 S.F.
TOTAL PROVIDED:		36,503 S.F.


PARKING LOT LANDSCAPE		52,343 S.F.
PARKING LOT AREA		52,343 S.F.
PARKING LANDSCAPE REQUIRED: 15%(52,343S.F.)		7,851 S.F.
INTERIOR ISLAND REQUIRED: 7,851 x .3 =		2,321 S.F.
TOTAL REQUIRED:		10,442 S.F.
TOTAL PROVIDED:		13,456 S.F.

LEGEND

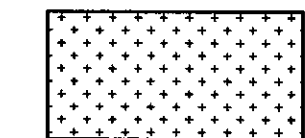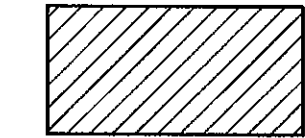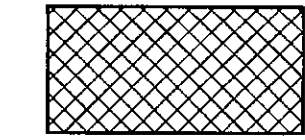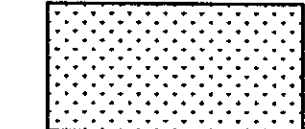-  DENOTES FRONT OPEN SPACE: 21,300 S.F.
-  DENOTES COMMON OPEN SPACE: 15,203 S.F.
-  DENOTES PARKING LOT LANDSCAPE AREA: 9,804 S.F.
-  PARKING LOT LANDSCAPE ISLANDS: 3,652 S.F.

APPROVED
FINAL PLANS PLANNING
DATE 10/24/17 APPROVED BY [Signature]

VICINITY MAP

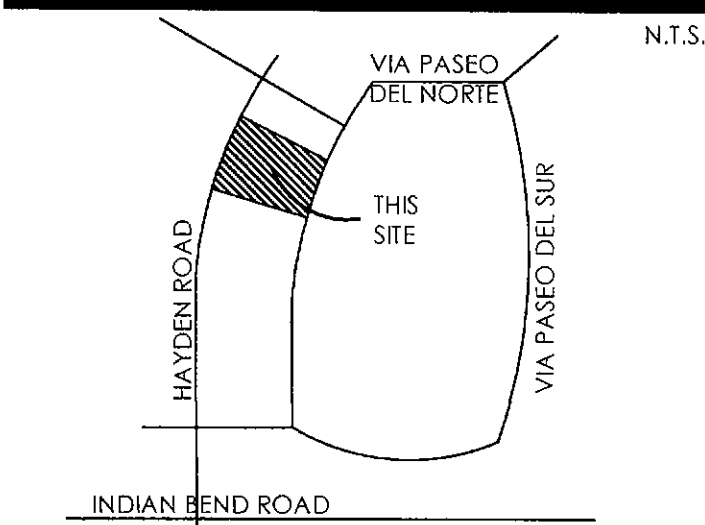

open space plan
scale: 1"=30'-0"

the architectural design and data contained in these documents is an instrument of service provided by FINN architects, llc.

all discrepancies found in these documents, or conflicts between these documents and actual field conditions shall be reported to FINN architects, llc for resolution prior to commencement of the work.

discrepancies between bid amounts and these documents shall be reported to the general contractor prior to commencement of work.

notice of alternate billing cycle: this contract allows the owner to require submission of billing or estimates in billing cycles other than thirty days, a written description of such other billing cycle applicable to this project is available from the owner/owner's designated agent (see cover sheet for phone/address of owner) and the owner/designated agent shall provide this written description upon request.


- January 19, 2017 design development
- February 01, 2017 owners meeting
- February 16, 2017 75% progress set
- March 02, 2017 permit submittal
- March 18, 2017 admin dtd submittal
- August 09, 2017 admin dtd resubmittal
- September 06, 2017 permit submittal

- March 12, 2017 city comments/coord.
- August 30, 2017 3rd permit submittal
- August 30, 2017 city comments

LGE
DESIGN BUILD

AV3
DESIGN STUDIO
ARCHITECTS, PLLC
EST. 2007

the grove at mccormick
7300 n. via paseo del sur
scottsdale, arizona
• 4-IN-2016 & 2-GP-2016 | 8-DR-2016 | 12-PP-2016 | 132-SA-2017 | PLAN CHECK #S 296-17-1 & 296-17-2

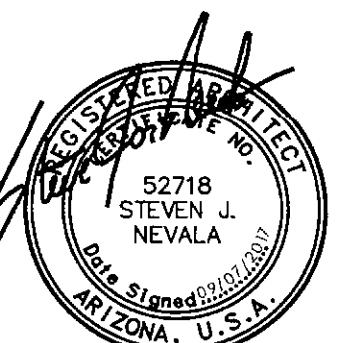

↑
N.T.S.

 march 12, 2017
city comments/coord.



1/4" - 1'-0"

WALL TYPE **A** PARKING SCREEN WALL

PER PLAN , 2'-8" , PER PLAN

4'-0"

3'-0"

4'-0"

DRAIN OPENINGS W/ RIP RAP APRON THRU WALL AS OCCUR, SEE CIVIL STRUCTURAL

2'-6"

CONCRETE

PER A7.1

PER PLAN

2'-8"

PER PLAN

SYNTHETIC 3-COAT STUCCO SYSTEM OVER 8x8x16 CMU WITH GROUT CAP AND CMU PIERS AS OCCUR WITH PRECAST CONCRETE CAP, CONCRETE DESIGNS, INC. COLOR - OATMEAL ACID ETCH

WALL TYPE **C** TRASH ENCLOSURE SCREEN WALL

SYNTHETIC 3-COAT
STUCCO SYSTEM
(EXTERIOR ONLY) OVER
8x8x16 CMU WITH
GROUT CAP

INTERIOR OF TRASH
ENCLOSURE TO BE
SEALED AND PAINTED

6'-0"

TRASH ENCLOSURE

1 PER A7.1

WALL TYPE **E** PATIO SCREEN WALL - BUILDING 'A' PATIO 102

The drawing consists of two views: a plan view (top) and an elevation view (bottom). The plan view shows a horizontal section with a total length of 14'-0" V.I.F. (Vertical Interval Factor). It features two circular gate locations, each with a diameter of 3'-6". The elevation view shows the vertical layout of the rail system, including the gate structure and the rail layout. The gate structure is shown with a height of 3'-6" and a width of 2'-6". The rail layout is shown with a height of 4'-0" and a width of 2'-6". The drawing is labeled "SEE PLANS FOR EXIT GATE LOCATIONS AND COMPLETE RAIL LAYOUT" at the bottom.

- COLUMN BEYOND, ROUT CLEAN & NEAT AT TRANSITION THRU PRE CAST COLUMN. SEAL
- 4" SQUARE RECLAIMED WOOD TOP RAIL, SEALED & STAINED
- 4"x2" VERTICAL POST AS SHOWN. PAINT
- 2" SQUARE STEEL BOTTOM RAIL, PAINT
- SET BASE BELOW PATIO SLAB

WALL TYPE **B** PATIO WALL

WALL TYPE **D** RESIDENTIAL SCREEN WALL - V.I.F. HEIGHTS/FINISHES WITH EXISTING

0'-8"

4'-8" V.I.F.

MATCH EXISTING

REPAIR

SYNTHETIC 3-COAT STUCCO SYSTEM (EXTERIOR ONLY) OVER 8x8x16 CMU WITH GROUT CAP

CONTINUE EXISTING REVEAL ALIGN WITH EXISTING

PAINT COLOR(S) TO BE FIELD MATCHED TO EXISTING WALL

WALL TYPE **F** PATIO SCREEN WALL - BUILDING 'B' PATIO 105

15'-4" V.I.F.

3'-6"

0'-2"

SEE PLANS FOR EXIT GATE LOCATIONS AND COMPLETE RAIL LAYOUT

WALL TYPE ☒ G RAISED PLANTER / SEAT AREA

1 1/2" THICK INTEGRALLY COLORED CONCRETE SEAT.
SEAL COLOR - OATMEAL. SEE A7.1 PRECAST CONCRETE

2'-0" 8'-0" 2'-0"

0'-3 3/4" 0'-4" 1'-8"

RADIUSED CMU BASE WITH TILE VENEER. (ACC) ON A7.1 SET WITH BOTTOM J MOLDING

INTERIOR OF CMU TO BE PAINTED () PER A7.1

LED TAPE LIGHT, FULL PERIMETER, SET IN CHANNEL TO DIRECT LIGHT ONTO TILE. MECHANICALLY FASTEN TO CONCRETE. SEE 1/A1.1A

LANDSCAPE AND LIGHTING. SEE PLANS

the grove at mccormick

scottsdale, arizona

REGISTERED ARCHITECT
 52718
 STEVEN J. NEVALA
 Date Signed 09/07/2012

RES 09/30/2020

FINN architects, llc
finnarchitects.com

1810 west loemann drive, queen creek, arizona 85142

finnarchitects.com (480-206-8229)

A1.1A

the architectural design and data contained in these documents is an instrument of service provided by FINN architects, llc.

all discrepancies found in these documents, or conflicts between these documents and actual field conditions shall be reported to FINN architects, llc for resolution prior to commencement of the work.

discrepancies between bid amounts and these documents shall be reported to the general contractor prior to commencement of work.


notice of alternate billing cycle: this contract allows the owner to require submission of billings or estimates in billing cycles other than thirty days, a written description of such other billing cycle applicable to this project is available from the owner/owner's designated agent (see cover sheet for phone/address of owner) and the owner/designated agent shall provide this written description upon request.

january 19, 2017
design development
february 01, 2017
owners meeting
february 16, 2017
75% progress set
march 02, 2017
permit submittal
march 18, 2017
admin drb submittal
august 09, 2017
admin drb resubmittal
september 06, 2017
permit submittal


▲	march 12, 2017
	city comments/coord.
	august 30, 2017
	3rd permit submittal
▲	august 30, 2017
	city comments




the grove at mccormick
7300 n. via paseo del sur
scottsdale, arizona

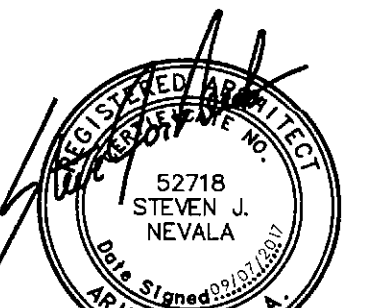

EXPIRES 09/30/2020

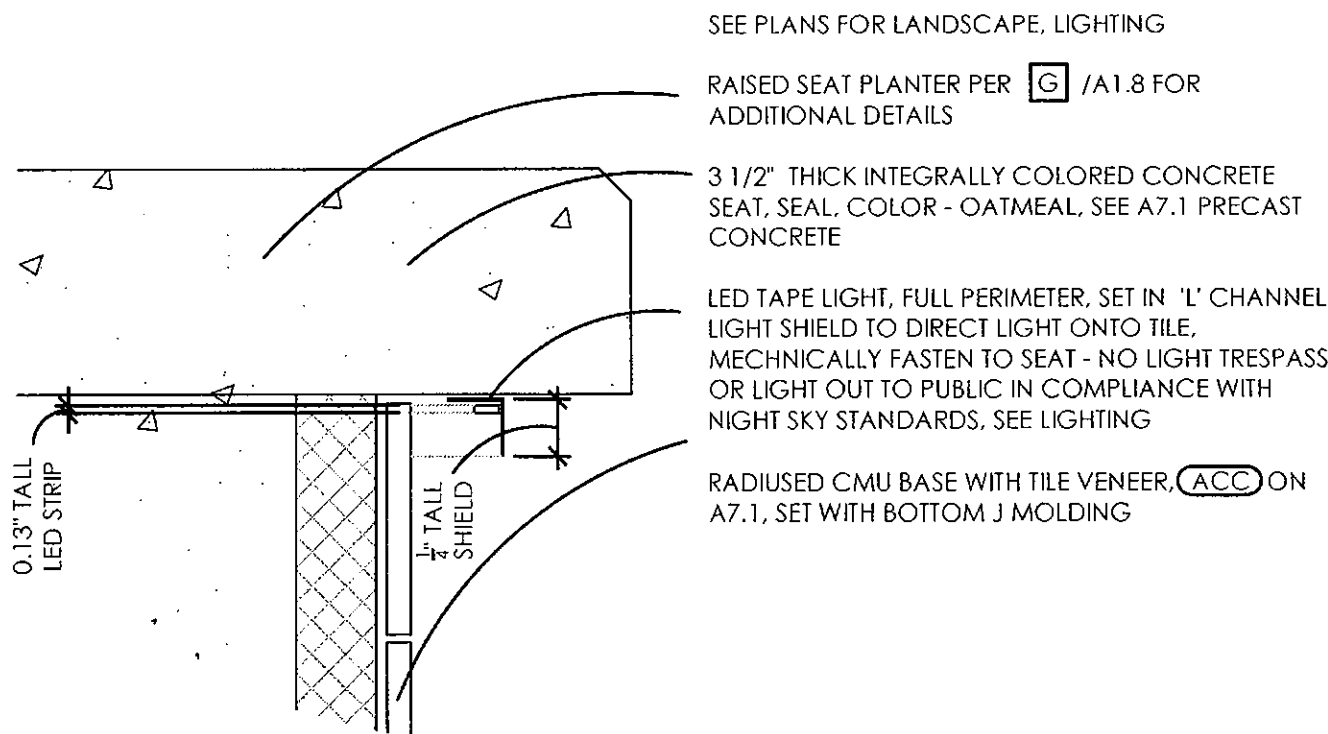

1 i.e.d. tape accent light at raised planters
scale: full

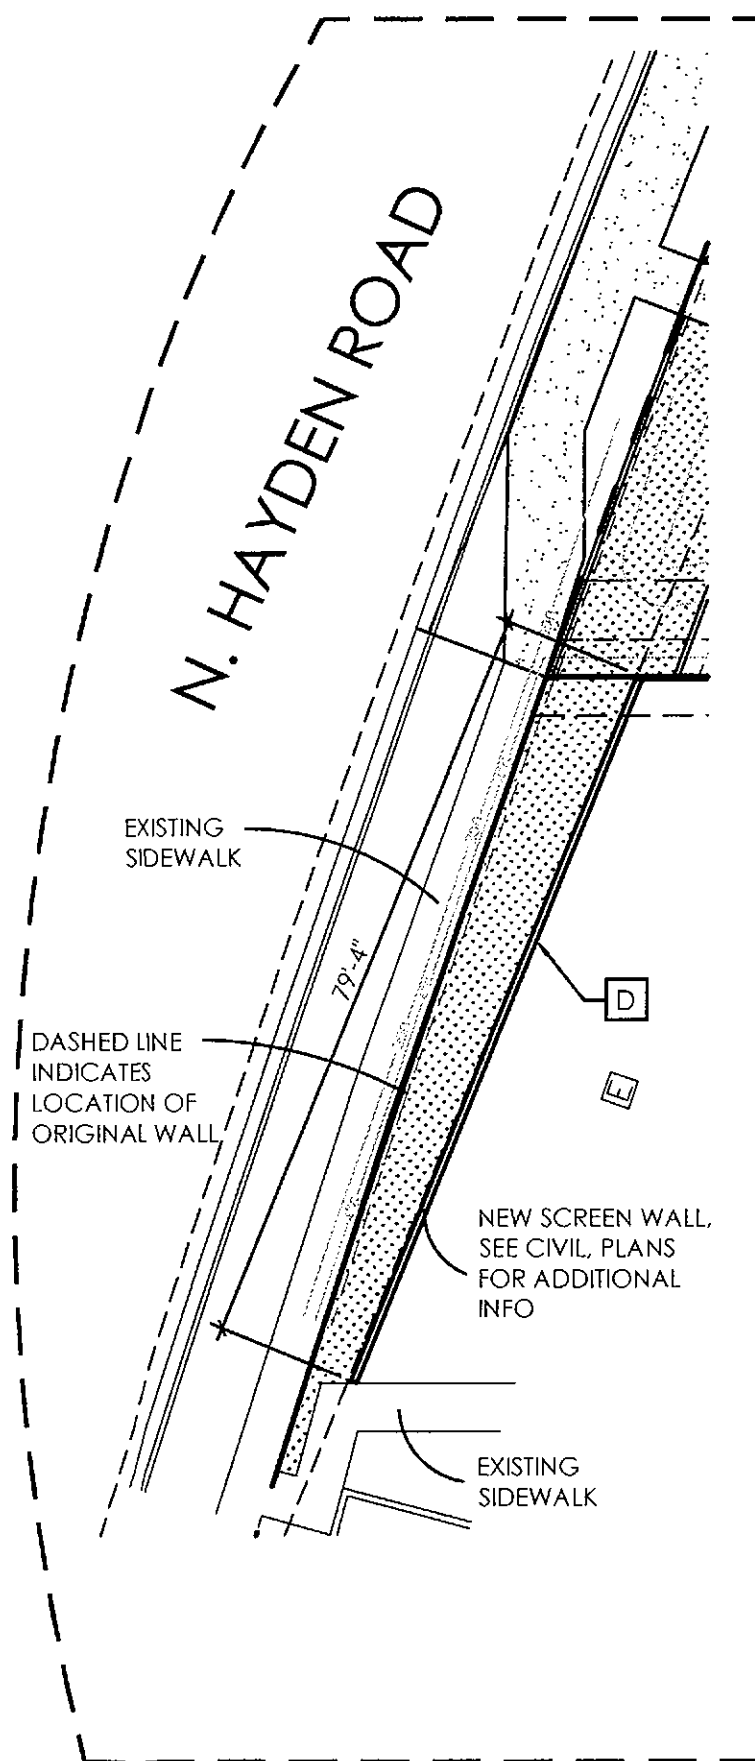

2 partial site plan
scale: 1"=20'-0"

NOTE: SEE CIVIL PLANS FOR ALL TOP OF WALL/TOP OF FOOTING ELEVATIONS FOR ALL SCREEN/SITE WALLS, TYPICAL

the architectural design and data contained in these documents is an instrument of service provided by FINN architects, llc.

all discrepancies found in these documents and actual field conditions shall be reported to FINN architects, llc for resolution prior to commencement of the work.

discrepancies between bid amounts and these documents shall be reported to the general contractor prior to commencement of work.

notice of alternate billing cycle: this contract allows the owner to require submission of billings or estimates in billing cycles other than thirty days. a written description of such other billing cycle applicable to this project is available from the owner/owner's designated agent (see cover sheet for phone/address of owner) and the owner/designated agent shall provide this written description upon request.

January 19, 2017	design development
February 01, 2017	owners meeting
February 16, 2017	75% progress set
March 02, 2017	permit submittal
March 18, 2017	admin drb submittal
August 09, 2017	admin drb resubmittal
September 06, 2017	permit submittal
March 12, 2017	city comments/coord.
March 12, 2017	city comments
August 30, 2017	3rd permit submittal
August 30, 2017	city comments



LEGEND

—	CENTERLINE
—	PROPERTY LINE
- - -	SETBACK LINE
- - -	EASEMENT LINE
—	CURB
—	EXISTING CURB
PAINT STRIPING	BIKE RACK
CONCRETE SIDEWALK / DECORATIVE PAVING AS OCCURS	FIRE HYDRANT
RAMP, VARIES SEE PLAN	EXISTING FIRE HYDRANT
SITE WALL	FDC
EXISTING SITE WALL	FIRE RISER
RIP RAP, NATIVE STONE	LIGHT POLE
	EXISTING LIGHT POLE
	RELOCATED LIGHT POLE

SCREEN WALL, WALL TAG, SEE A1.8 PLANS, STRUCTURAL	THRU C SEE A1.8
10'x20' VISIBILITY TRIANGLE	
UTILITY TRANSFORMER	
SOLID DOT INDICATES BUILDING LAYOUT DIMENSION POINTS	
LANDSCAPE POTS/PLANTERS - SEE LANDSCAPE	

PROJECT DATA

ADDRESS: 7300 VIA PASEO DEL SUR, SCOTTSDALE, AZ
APN: 177-03-216
LEGAL: LOT 1 PASEO VILLAGE AMENDED - BOOK 154 OF MAPS, PAGE 13, RECORDS OF MARICOPA COUNTY
ZONING: C-1, PCD
LAND USE: NEIGHBORHOOD COMMERCIAL
NET SITE AREA: +/-115,254 S.F. (+/-2.64 AC.)

GROSS BUILDING AREA:	
BUILDING A (SINGLE STORY)	6,956 S.F.
(COVERED PATIO)	1,264 S.F.
BUILDING B (2-STORY)	GROUND - 10,784 S.F.
(COVERED BALCONY)	SECOND - 11,516 S.F.
380 S.F.	
TOTAL GROSS BUILDING AREA:	30,900 S.F.


BUILDING AREA:	
BUILDING A (SINGLE STORY)	6,956 S.F.
RETAIL/RESTAURANT	
BUILDING B (2-STORY)	22,300 S.F.
RETAIL/RESTAURANT/OFFICE	
(2ND FLOOR BALCONY 380 S.F.)	
TOTAL:	29,256 S.F.

PATIO AREA:	
BUILDING A	
PATIO DINING, EAST (UNCOVERED)	896 S.F.
PATIO DINING, WEST (COVERED)	1,264 S.F.
BUILDING B	
PATIO DINING (UNCOVERED)	1,140 S.F.
TOTAL:	3,300 S.F.
TOTAL BUILDING/PATIO AREA:	32,556 S.F.

LOT COVERAGE:	
ALLOWED:	0.80
PROVIDED:	0.164 (19,004 S.F. / 115,254 S.F.)
FAR:	26.8 (30,900 S.F. / 115,254 S.F.)

BUILDING HEIGHT:	
ALLOWED:	36'-0"
PROVIDED:	36'-0"
CONSTRUCTION TYPE:	V-B
OCCUPANCY:	A/B/M (NON-SEPARATED)
ALLOWABLE AREA:	UNLIMITED, 60' YARDS
PARAPET SCREENING:	5' (PARAPET)

VICINITY MAP

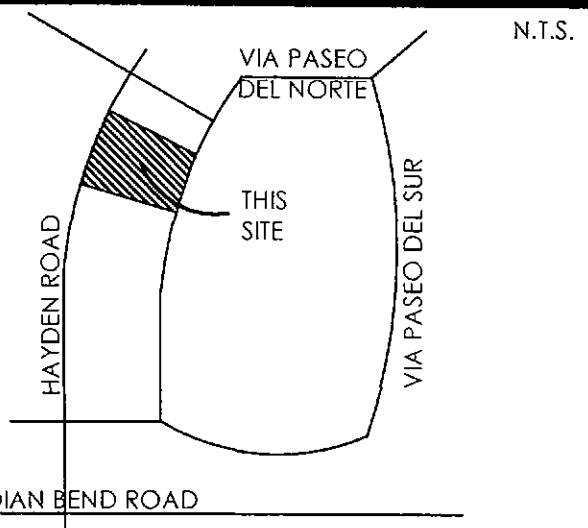


PARKING DATA

USE	S.F.	RATIO	REQUIRED
COMMERCIAL			
MIXED USE	32,556 S.F.	1/300	109 (108.52)
TOTAL REQUIRED:			109
TOTAL PROVIDED:			102
5,141/1,000 S.F.		(6 ACCESSIBLE/134 STANDARD)	140
(ADA CALC - 143 x .04 = 5.72 (6 REQ'D/PROV'D))			
BIKE PARKING:			
(1 BIKE SPACE PER 10 REQUIRED VEHICLE SPACES)			
TOTAL REQUIRED:			11
TOTAL PROVIDED:			18



site revisions
admin drb app.

the grove at mccormick
7300 n. via paseo del sur
scottsdale, arizona

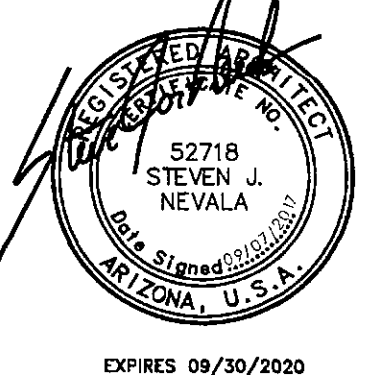

CITY OF SCOTTSDALE SITE PLAN NOTES

SIGHT DISTANCE TRIANGLES SHALL BE SHOWN ON FINAL PLANS FOR DRIVEWAYS FROM COMMERCIAL SITES AND ANY INTERSECTIONS. AREA WITHIN THE SAFETY TRIANGLE IS TO BE CLEAR OF LANDSCAPING, SIGNS, OR OTHER VISIBILITY OBSTRUCTIONS WITH A HEIGHT GREATER THAN 1.5 FEET. TREES WITHIN THE SAFETY TRIANGLE SHALL BE SINGLE TRUNK AND HAVE A CANOPY THAT BEGINS AT 8 FEET IN HEIGHT UPON INSTALLATION. ALL HEIGHTS ARE MEASURED FROM NEAREST STREET LINE ELEVATION.

TEMPORARY/SECURITY FENCING THAT IS REQUIRED OR IS OPTIONALLY PROVIDED SHALL BE IN ACCORDANCE WITH THE ZONING ORDINANCE AND THE DESIGN STANDARDS AND POLICIES MANUAL.

THE TEMPORARY/SECURITY FENCE LOCATION SHALL NOT BE MODIFIED OR THE TEMPORARY/SECURITY FENCE SHALL NOT BE REMOVED WITHOUT THE APPROVAL OF THE PLANNING AND DEVELOPMENT SERVICES' INSPECTION SERVICES DIVISION.

ALL RIGHTS-OF-WAY ADJACENT TO THIS PROPERTY SHALL BE LANDSCAPED AND MAINTAINED BY THE PROPERTY OWNER.

ALL SIGNS REQUIRE SEPARATE PERMITS AND APPROVALS.

A MASTER SIGN PROGRAM SHALL BE SUBJECT TO THE APPROVED OF THE DEVELOPMENT REVIEW BOARD PRIOR TO THE ISSUANCE OF A SIGN PERMIT FOR MULTI-TENANT BUILDINGS.

NO EXTERIOR VENDING OR DISPLAY SHALL BE ALLOWED.

FLAGPOLES, IF PROVIDED, SHALL BE ONE PIECE CONICAL TAPERED.

NO EXTERIOR PUBLIC ADDRESS OR SPEAKER SYSTEM SHALL BE ALLOWED.

PATIO UMBRELLAS, IF PROVIDED, SHALL BE SOLID COLORS AND SHALL NOT HAVE ANY ADVERTISING IN THE FORM OF SIGNAGE OR LOGOS.

ALL EXTERIOR MECHANICAL, UTILITY, AND COMMUNICATION EQUIPMENT SHALL BE SCREENED TO THE HEIGHT OF THE TALLEST UNIT BY PARAPET OR SCREEN WALL THAT MATCHES THE ARCHITECTURAL COLOR AND ARCHITECTURAL FINISH OF THE BUILDING. GROUND MOUNTED MECHANICAL, UTILITY, AND COMMUNICATION EQUIPMENT SHALL BE SCREENED BY A SCREEN WALL THAT MATCHES THE ARCHITECTURAL COLOR AND ARCHITECTURAL FINISH OF THE BUILDING, WHICH IS A MINIMUM OF 1'-0" HIGHER THAN THE HIGHEST POINT OF TALLEST UNIT. (DETAILS ARE STILL REQUIRED.)

ALL EQUIPMENT, UTILITIES, OR OTHER APPURTENANCES ATTACHED TO THE BUILDING SHALL BE AN INTEGRAL PART OF THE BUILDING DESIGN IN TERMS OF FORM, COLOR AND TEXTURE.

NO EXTERIOR VISIBLE LADDERS SHALL BE ALLOWED.

ALL POLE-MOUNTED LIGHTING SHALL BE A MAXIMUM OF 20 FEET IN HEIGHT.

NO CHAIN LINK FENCING SHALL BE ALLOWED.

NO TURF AREAS SHALL BE PROVIDED IN R.O.W.

