


Full Size or Largest Size
(site plan, landscape, elevations)

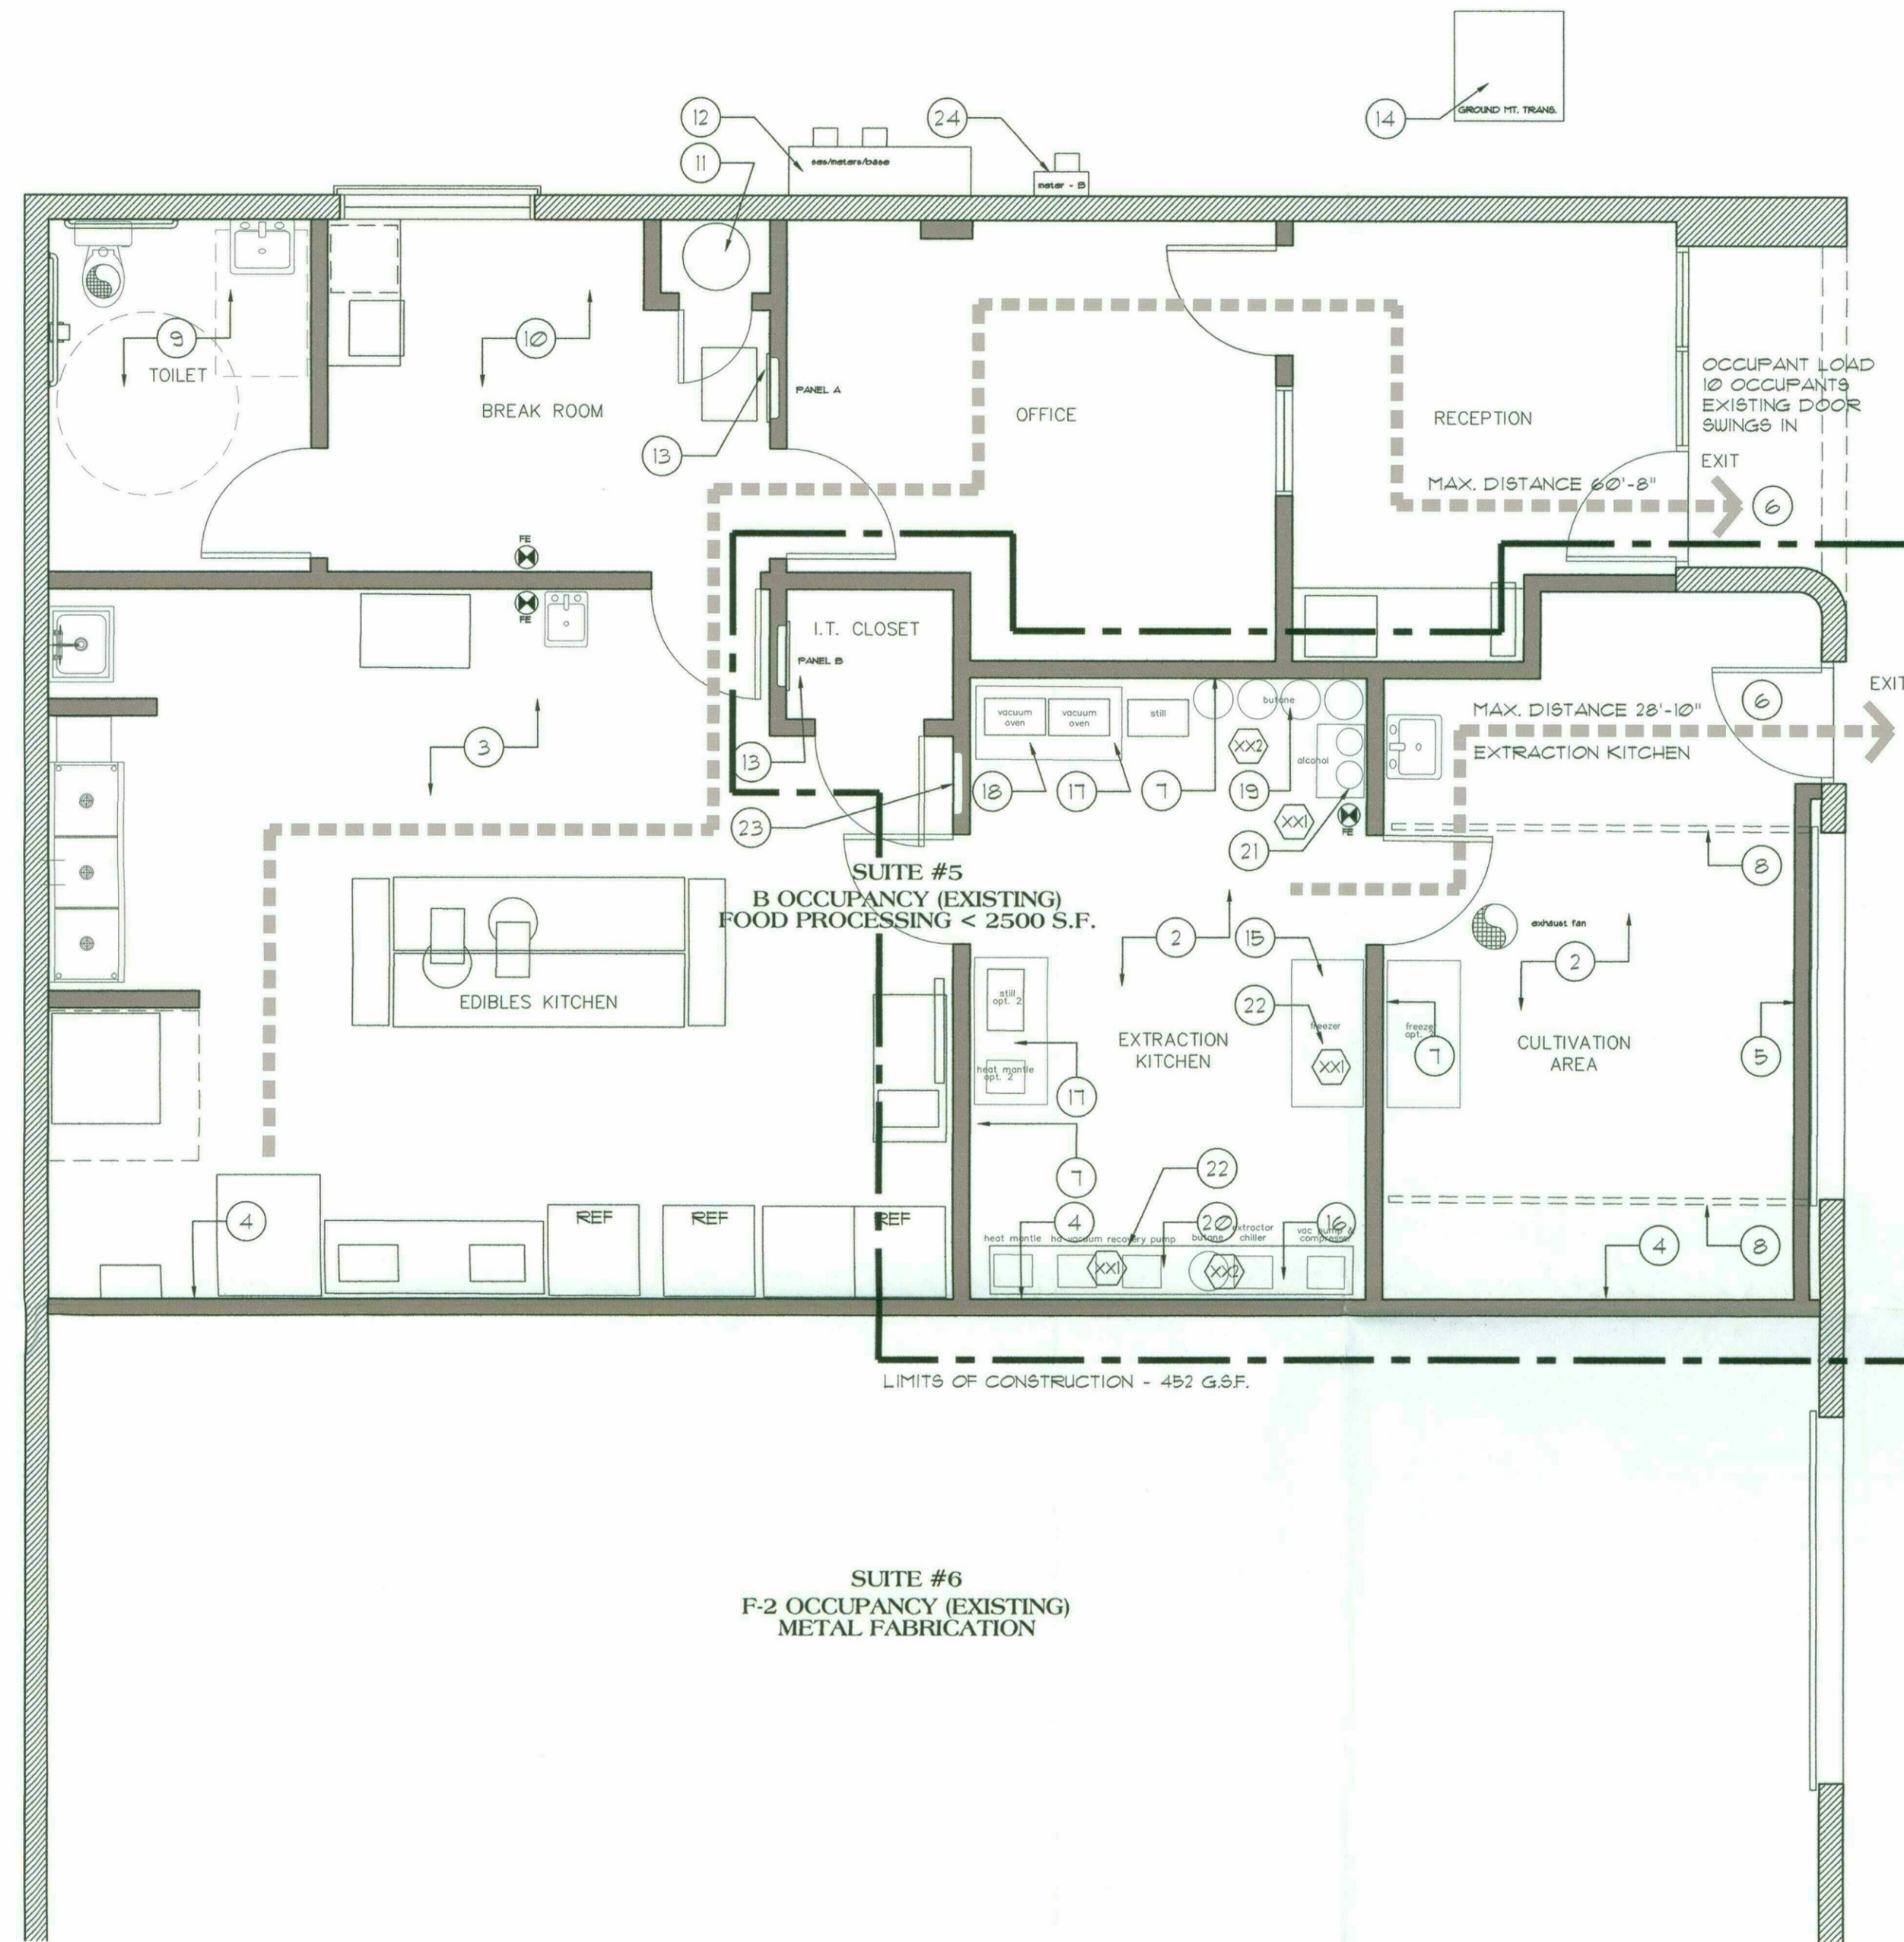

Floor Plan
Scale: 1/4" = 1'-0"

KEYNOTES


- EXISTING ADJACENT SUITE - NO WORK.
- EXISTING KITCHEN - THIS PERMIT AREA.
- EXISTING KITCHEN.
- EXISTING DIVISING WALL.
- EXISTING PARTITION COVERING O.H. DOOR THIS LOCATION TO REMAIN.
- EXISTING EXIT DOOR AND HARDWARE. NO CHANGE.
- EXISTING FRAMED PARTITION WALL WITH G.W.B. FINISH TO REMAIN.
- EXISTING OVERHEAD DOOR RAILS. NO CHANGE.
- EXISTING RESTROOM. NO CHANGE.
- EXISTING STAFF BREAK ROOM. NO CHANGE.
- EXISTING WATER HEATER. NO CHANGE.
- EXISTING SES / METER AND BASE, THIS LOCATION.
- EXISTING ELECTRICAL SUB-PANEL. SEE ELECTRICAL PLANS.
- EXISTING GROUND MOUNTED ELECTRICAL TRANSFORMER. PROVIDE NEW UNDERGROUND CONDUIT TO PANELS. SEE ELECTRICAL PLANS, THIS LOCATION.
- NEW FREEZER UNIT BY OWNER.
- EXTRACTION EQUIPMENT. SEE ELECTRICAL PLANS.
- TABLE BY OWNER.
- OVEN BY OWNER.
- BUTANE TANK STORAGE. SEE COVER SHEET/HAZARDOUS MATERIAL STORAGE/CALCULATIONS. MATERIAL DESIGNATION XX2.
- BUTANE TANK/EXTRACTION PROCESS. SEE COVER SHEET/HAZARDOUS MATERIAL USE/CALCULATIONS. MATERIAL DESIGNATION XX2.
- ETHYL ALCOHOL STORAGE. SEE COVER SHEET/HAZARDOUS MATERIAL STORAGE/CALCULATIONS. MATERIAL DESIGNATION XXI.
- ETHYL ALCOHOL EXTRACTION PROCESS. SEE COVER SHEET/HAZARDOUS MATERIAL USE/CALCULATIONS. MATERIAL DESIGNATION XXI.
- NEW ELECTRICAL PANEL. SEE ELECTRICAL PLANS.
- EXISTING METER /METER BOARD TO BE REPLACED. SEE ELECTRICAL PLANS, THIS LOCATION.

NOSTDAHL LIPTACK

ARCHITECTS
3033 NORTH CENTRAL AVENUE
SUITE #420
PHOENIX, ARIZONA 85012
TEL: (602) 200-0787
FAX: (602) 200-0787

PARC Commercial Kitchen

Kitchen Improvements
7655 East Evans Road
Scottsdale, Arizona

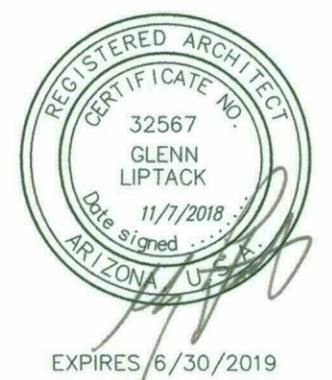

EXPIRES 6/30/2019

Floor Plan

Scale: 1/4"=1'-0"
SHEET NO.

A2.0

10-UP-2013#3
01/30/2019

DRAWN BY:	DN/SL
CHECKED BY:	DN/SL
PROJECT NO.:	2018.16
FILE NAME:	10-UP-2013#3
DATE:	11/7/2018
DESIGN DEVELOPMENT	<input checked="" type="checkbox"/>
SCHEMATIC DESIGN	<input checked="" type="checkbox"/>
CONSTRUCTION DOCUMENTS	<input checked="" type="checkbox"/>
REVISIONS	

CONTRACTOR MUST VERIFY ALL DIMENSIONS PRIOR TO PROCEEDING WITH THIS WORK. THESE DRAWINGS AND SPECIFICATIONS SHALL REMAIN THE PROPERTY OF THE ARCHITECT. IF THE PROJECT FOR WHICH THESE DRAWINGS AND SPECIFICATIONS NOT, THESE DRAWINGS AND SPECIFICATIONS SHALL NOT BE USED BY ANYONE ON ANY PROJECT, OR FOR COMPLETION OF THIS PROJECT, OR FOR COMPLETION OF THIS PROJECT BY OTHERS EXCEPT BY THE ARCHITECT. DO NOT REPRODUCE THESE DRAWINGS OR SPECIFICATIONS WITHOUT THE WRITTEN PERMISSION OF THE ARCHITECT.

©NOSTDAHL LIPTACK ARCHITECTS, P.C. 2018