


Luminaire Schedule						
Symbol	Qty	Label	Arrangement	LLF	Description	Lum. Lumens
	2	G1	SINGLE	0.900	E250LED-1RND35T5-MDL03-FL - 3000K	2504
	10	XT2	SINGLE	0.900	OWL-ISOLITE-AC 3000K	1530

PREPARED BY:
CITY LIGHTING PRODUCTS
4307 WEST PAPIN STREET
ST. LOUIS, MO 63110
(314)534-1090

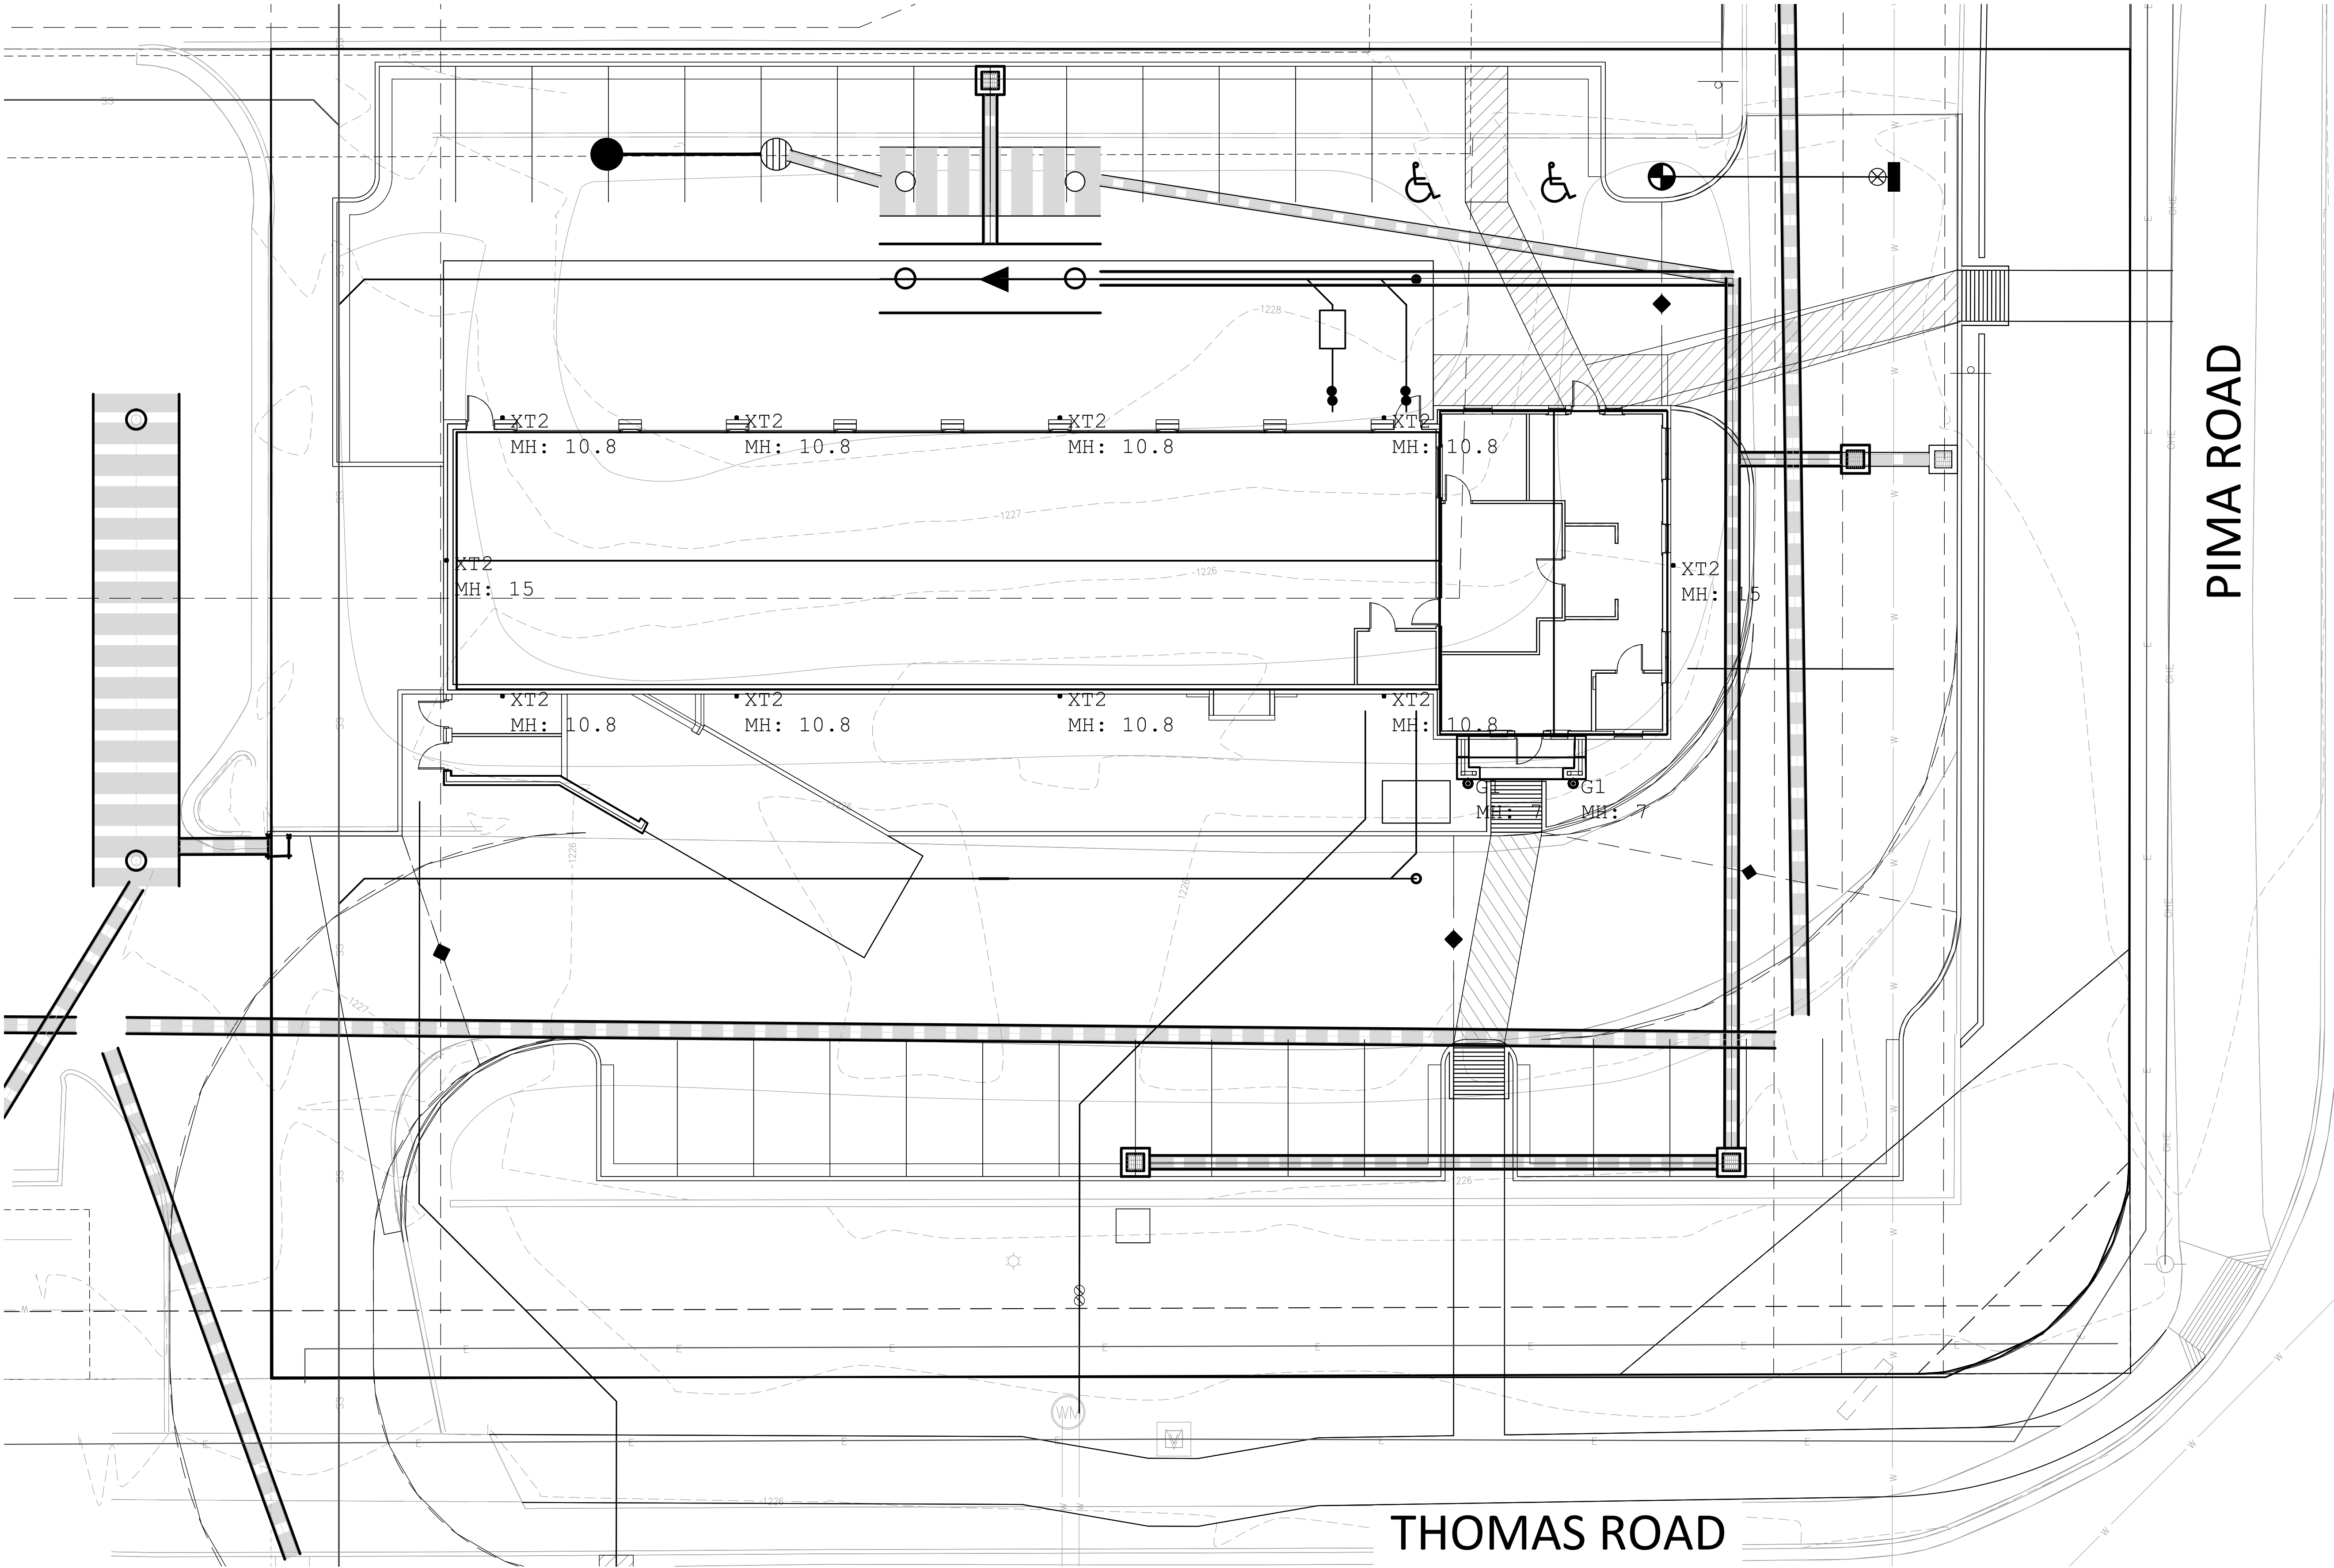

Bowman

Bowman Consulting Group Ltd
1600 N. Desert Drive Ste 210
Tempe, Arizona 85281
Phone: (480) 629-8830
www.bowmanconsulting.com
© 2021 Bowman Consulting Group Ltd

ELECTRICAL SITE PLAN
CHRISTIAN BROTHERS AUTOMOTIVE
8700 E THOMAS ROAD
SCOTTSDALE, ARIZONA
MARICOPA COUNTY

PROJECT NUMBER

PLAN STATUS

DATE	DESCRIPTION		
DMN	JCB	JSR	
DESIGN	DRAWN	CHKD	
SCALE	H: 1"=10'	V: NONE	
JOB No. 050840-01-001			
DATE : 01/20/22			

EL01
SHEET 01 OF 01