
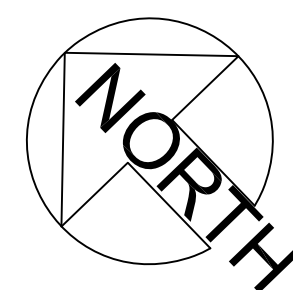


LIGHTING LEGEND

A WALL PACK

B CAN LIGHT

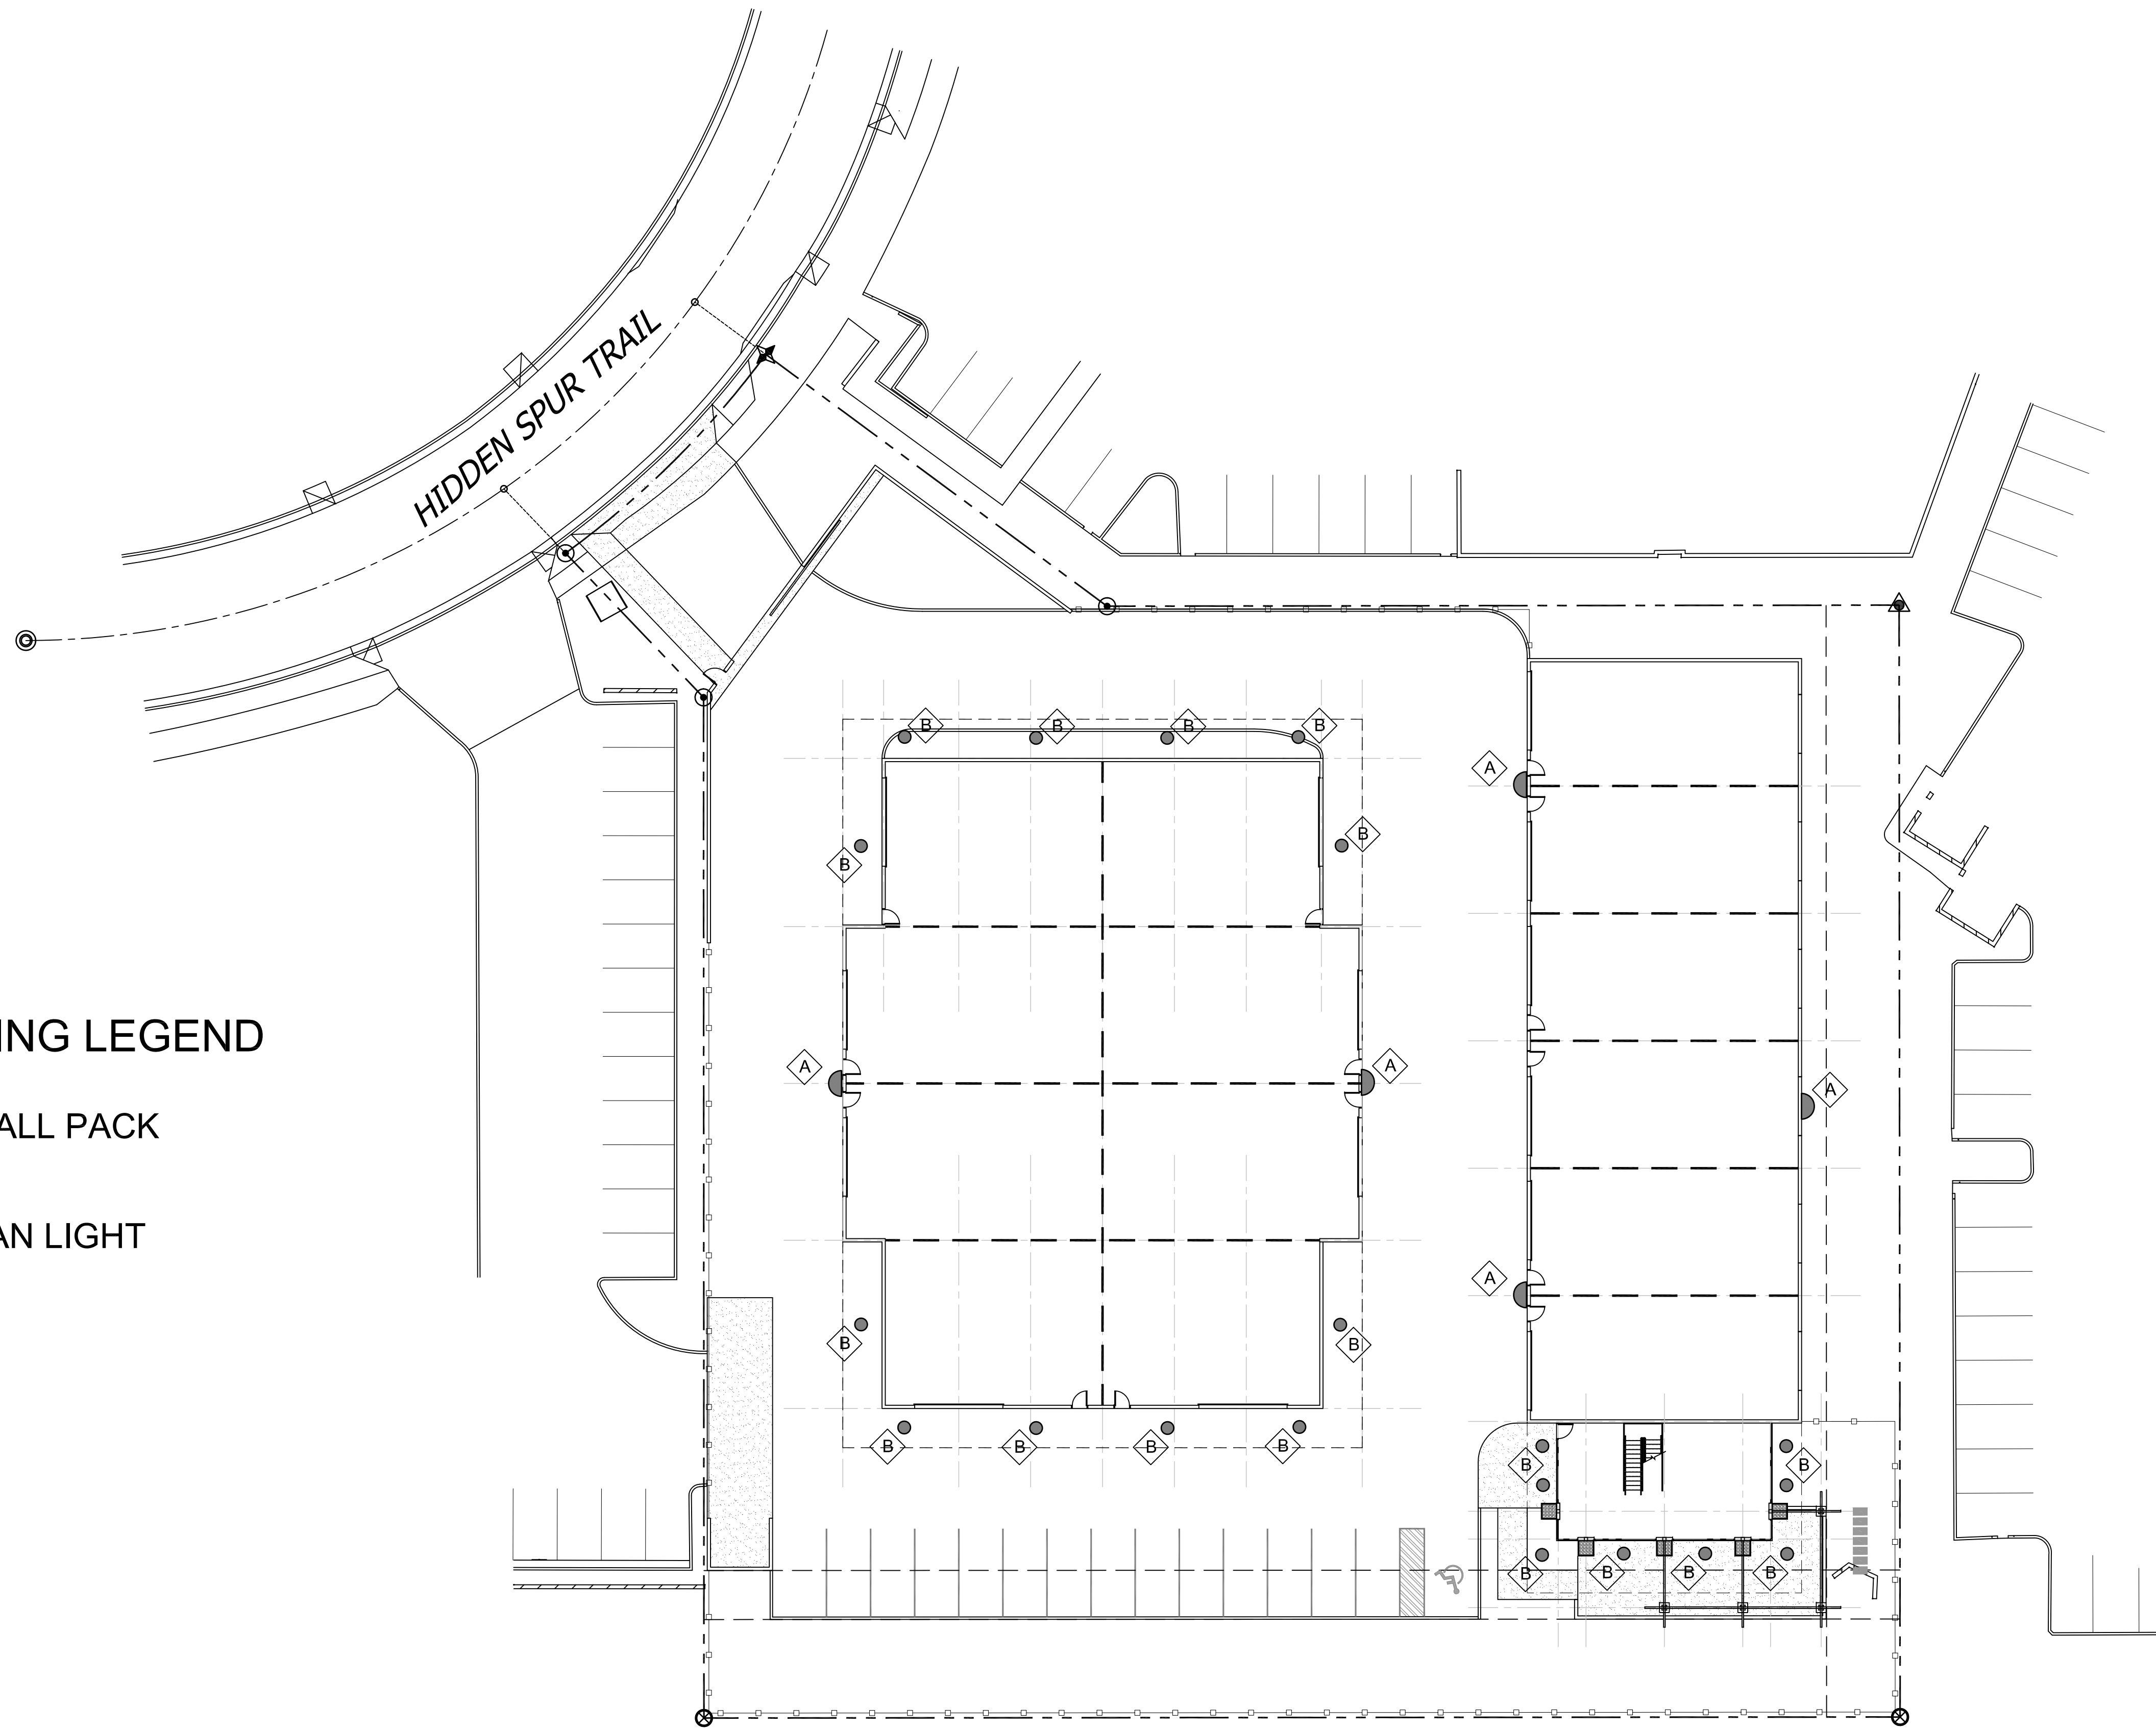

SITE LIGHTING PLAN

SCALE: 1" = 20'

DATE: 6.1.21
REVISED:

C.O.S. 7.29.21
COMMENTS

james
elson
architect

16420 north 92nd street
suite two hundred nineteen
scottsdale, arizona
85260

85260
602.903.5311.m

j4747e@aol.com

jameselsonarchitect@gmail.com

SL1
SITE
LIGHTING
PLAN

SILVERLEAF AUTO STORAGE
9271 E. HIDDEN SPUR TRAIL
DC RANCH CORPORATE CENTER - LOT 8