

EDC ELECTRICAL
CONSULTING, LLC

Designer: Edward Camacho
Job #: 21052

PROJECT DESCRIPTION

SCOTTSDALE & MOUNTAIN VIEW
9880 N. SCOTTSDALE RD.
SCOTTSDALE, ARIZONA 85253

[illegible]

THESE DRAWINGS ARE THE INSTRUMENTS OF SERVICE AND ARE THE PROPERTY OF VERTICAL DESIGN STUDIO. VERTICAL DESIGN STUDIO EXPRESSLY RESERVES ITS COMMON LAW COPYRIGHT AND OTHER PROPERTY RIGHTS TO THESE PLANS. THESE PLANS ARE NOT TO BE REPRODUCED, CHANGED OR COPIED IN ANY FORM OR MANNER WHATSOEVER, NOR ARE THEY TO BE ASSIGNED TO ANY THIRD PARTY. WITHOUT FIRST OBTAINING THE EXPRESSED WRITTEN PERMISSION AND CONSENT OF VERTICAL DESIGN STUDIO, ANY WRITTEN COMMENTS ON THESE DRAWINGS SHALL HAVE NO EFFECT.


©COPYRIGHT 2021, VERTICAL DESIGN STUDIOS

SHEET TITLE

HORIZONTAL PHOTOMETRIC SITE PLAN
PROJECT NUMBER
21003

E-002

Calculation Summary							
Label	CalcType	Units	Avg	Max	Min	Avg/Min	Max/Min
Site	Illuminance	Fc	3.72	17.5	0.0	N.A.	N.A.

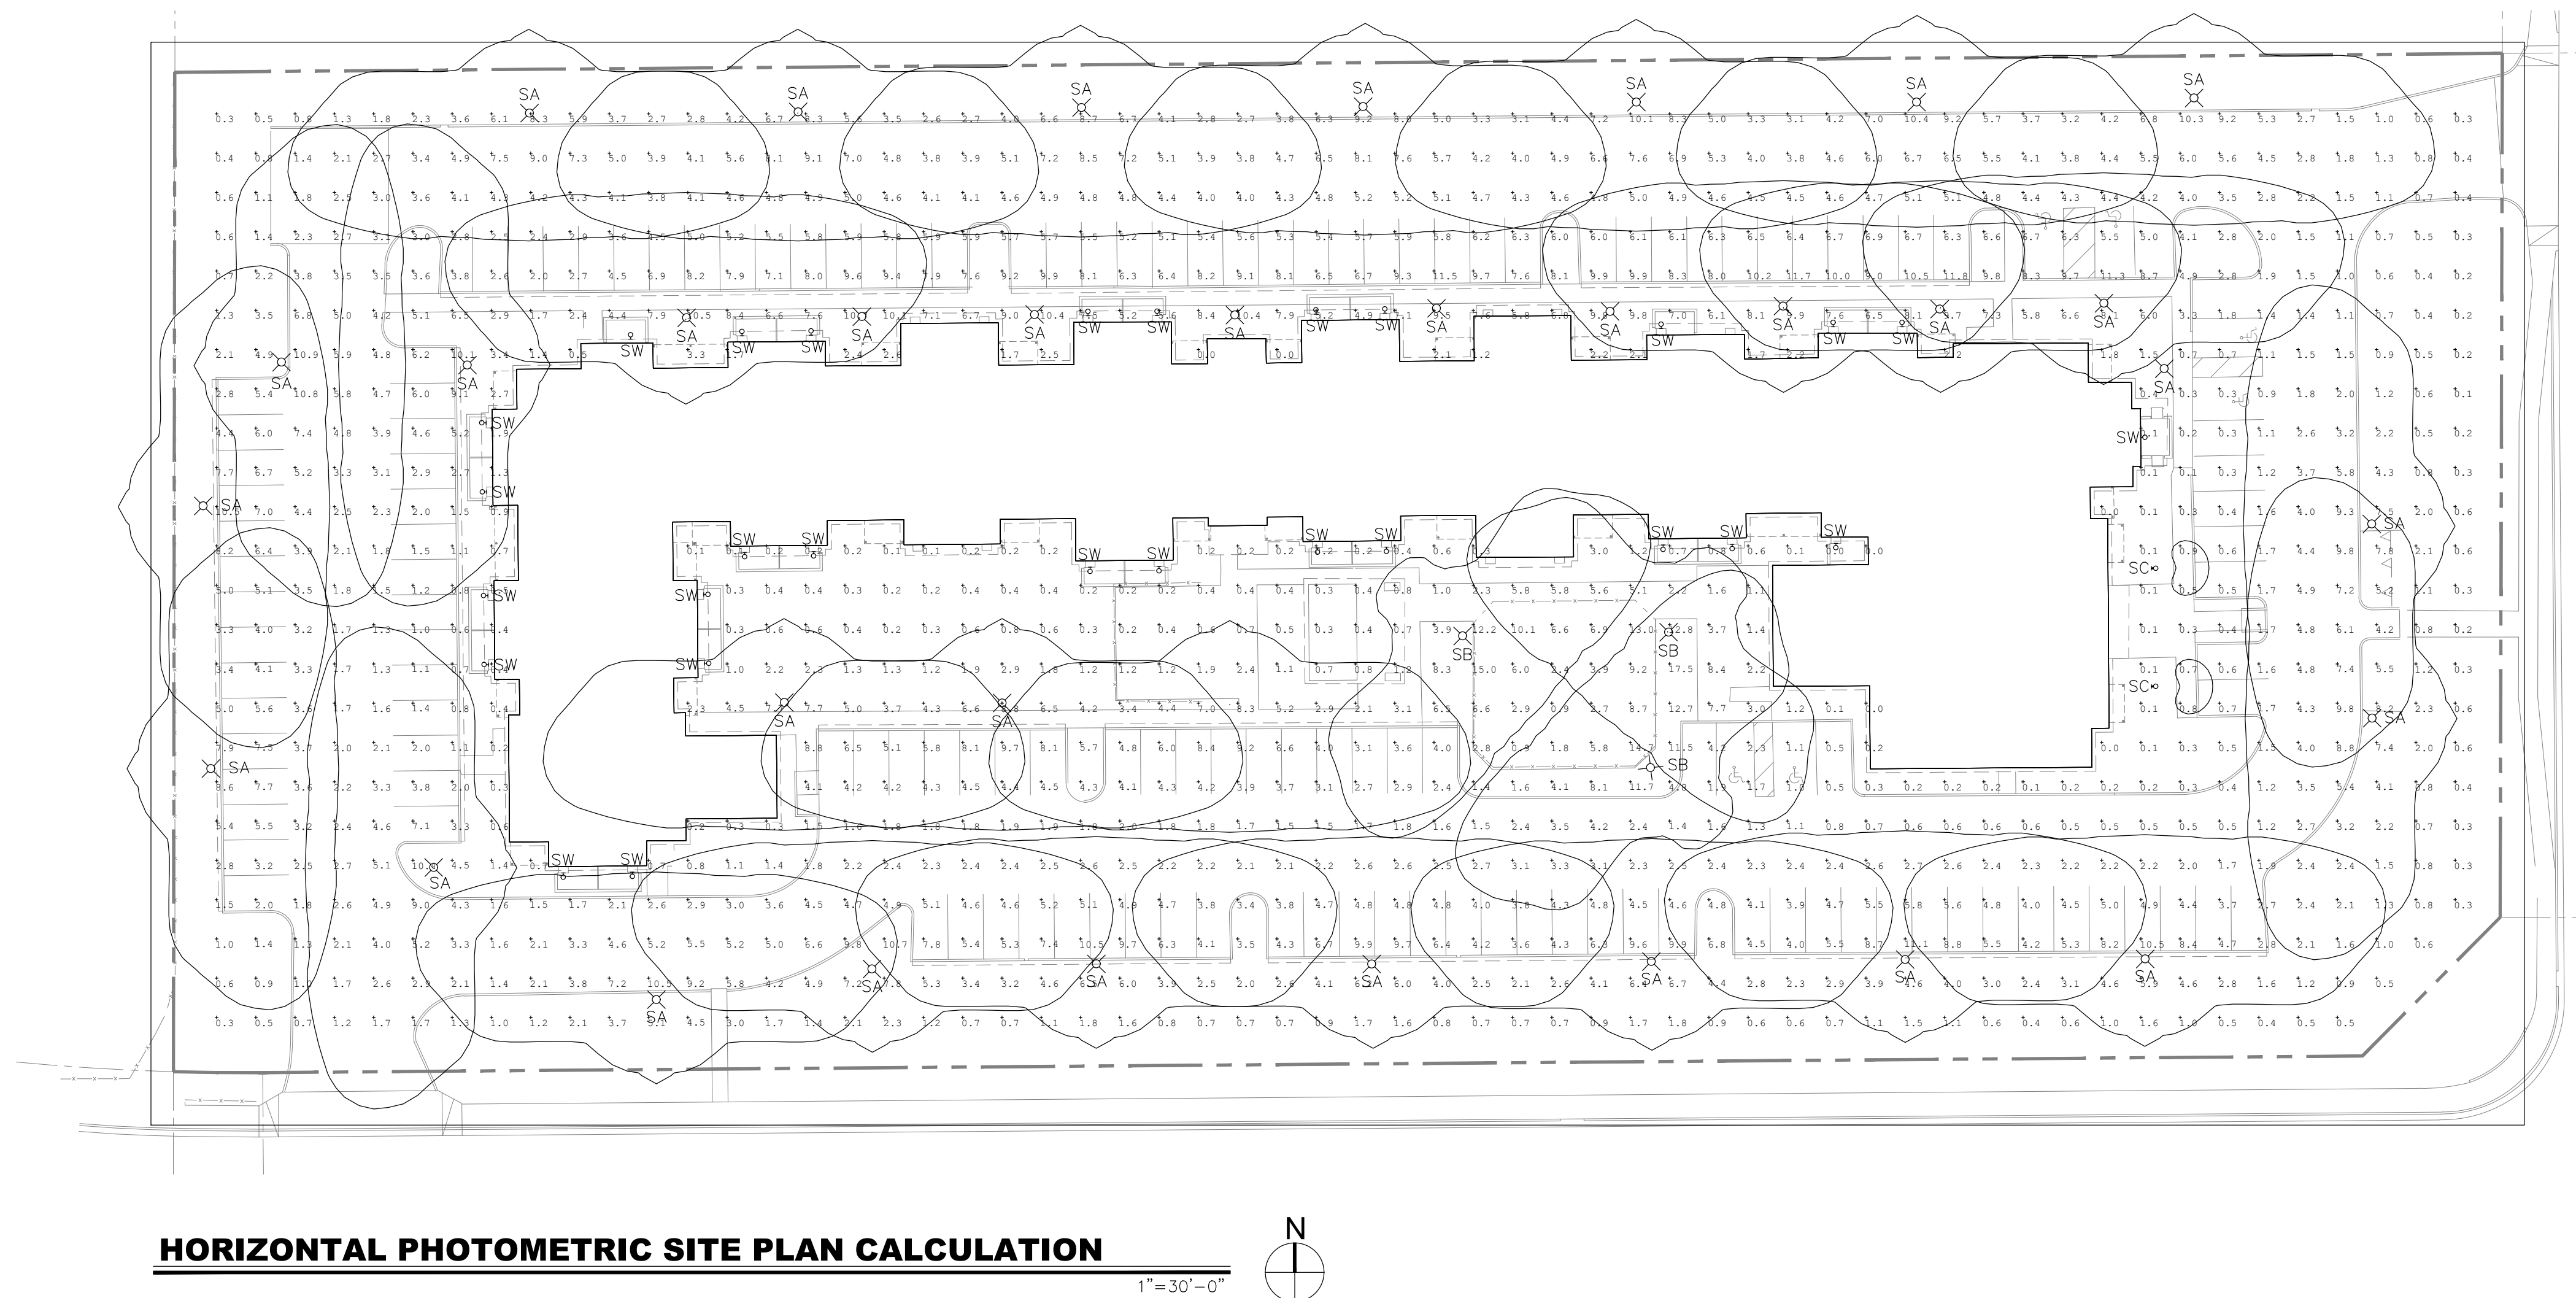

PLAN REVIEWER THIS PHOTOMETRIC CALCULATION INCLUDES THE EXISTING SITE LIGHTING POLES AND THE (2) NEW WALL SCONCE FIXTURES AT THE FRONT ENTRY TYPE 'SC' IT DOES NOT INCLUDE THE PATIO WALL SCONCE LIGHT FIXTURES 'SW'.

