



PLOT DATE: Wednesday, September 9, 2020 2:56:46 PM

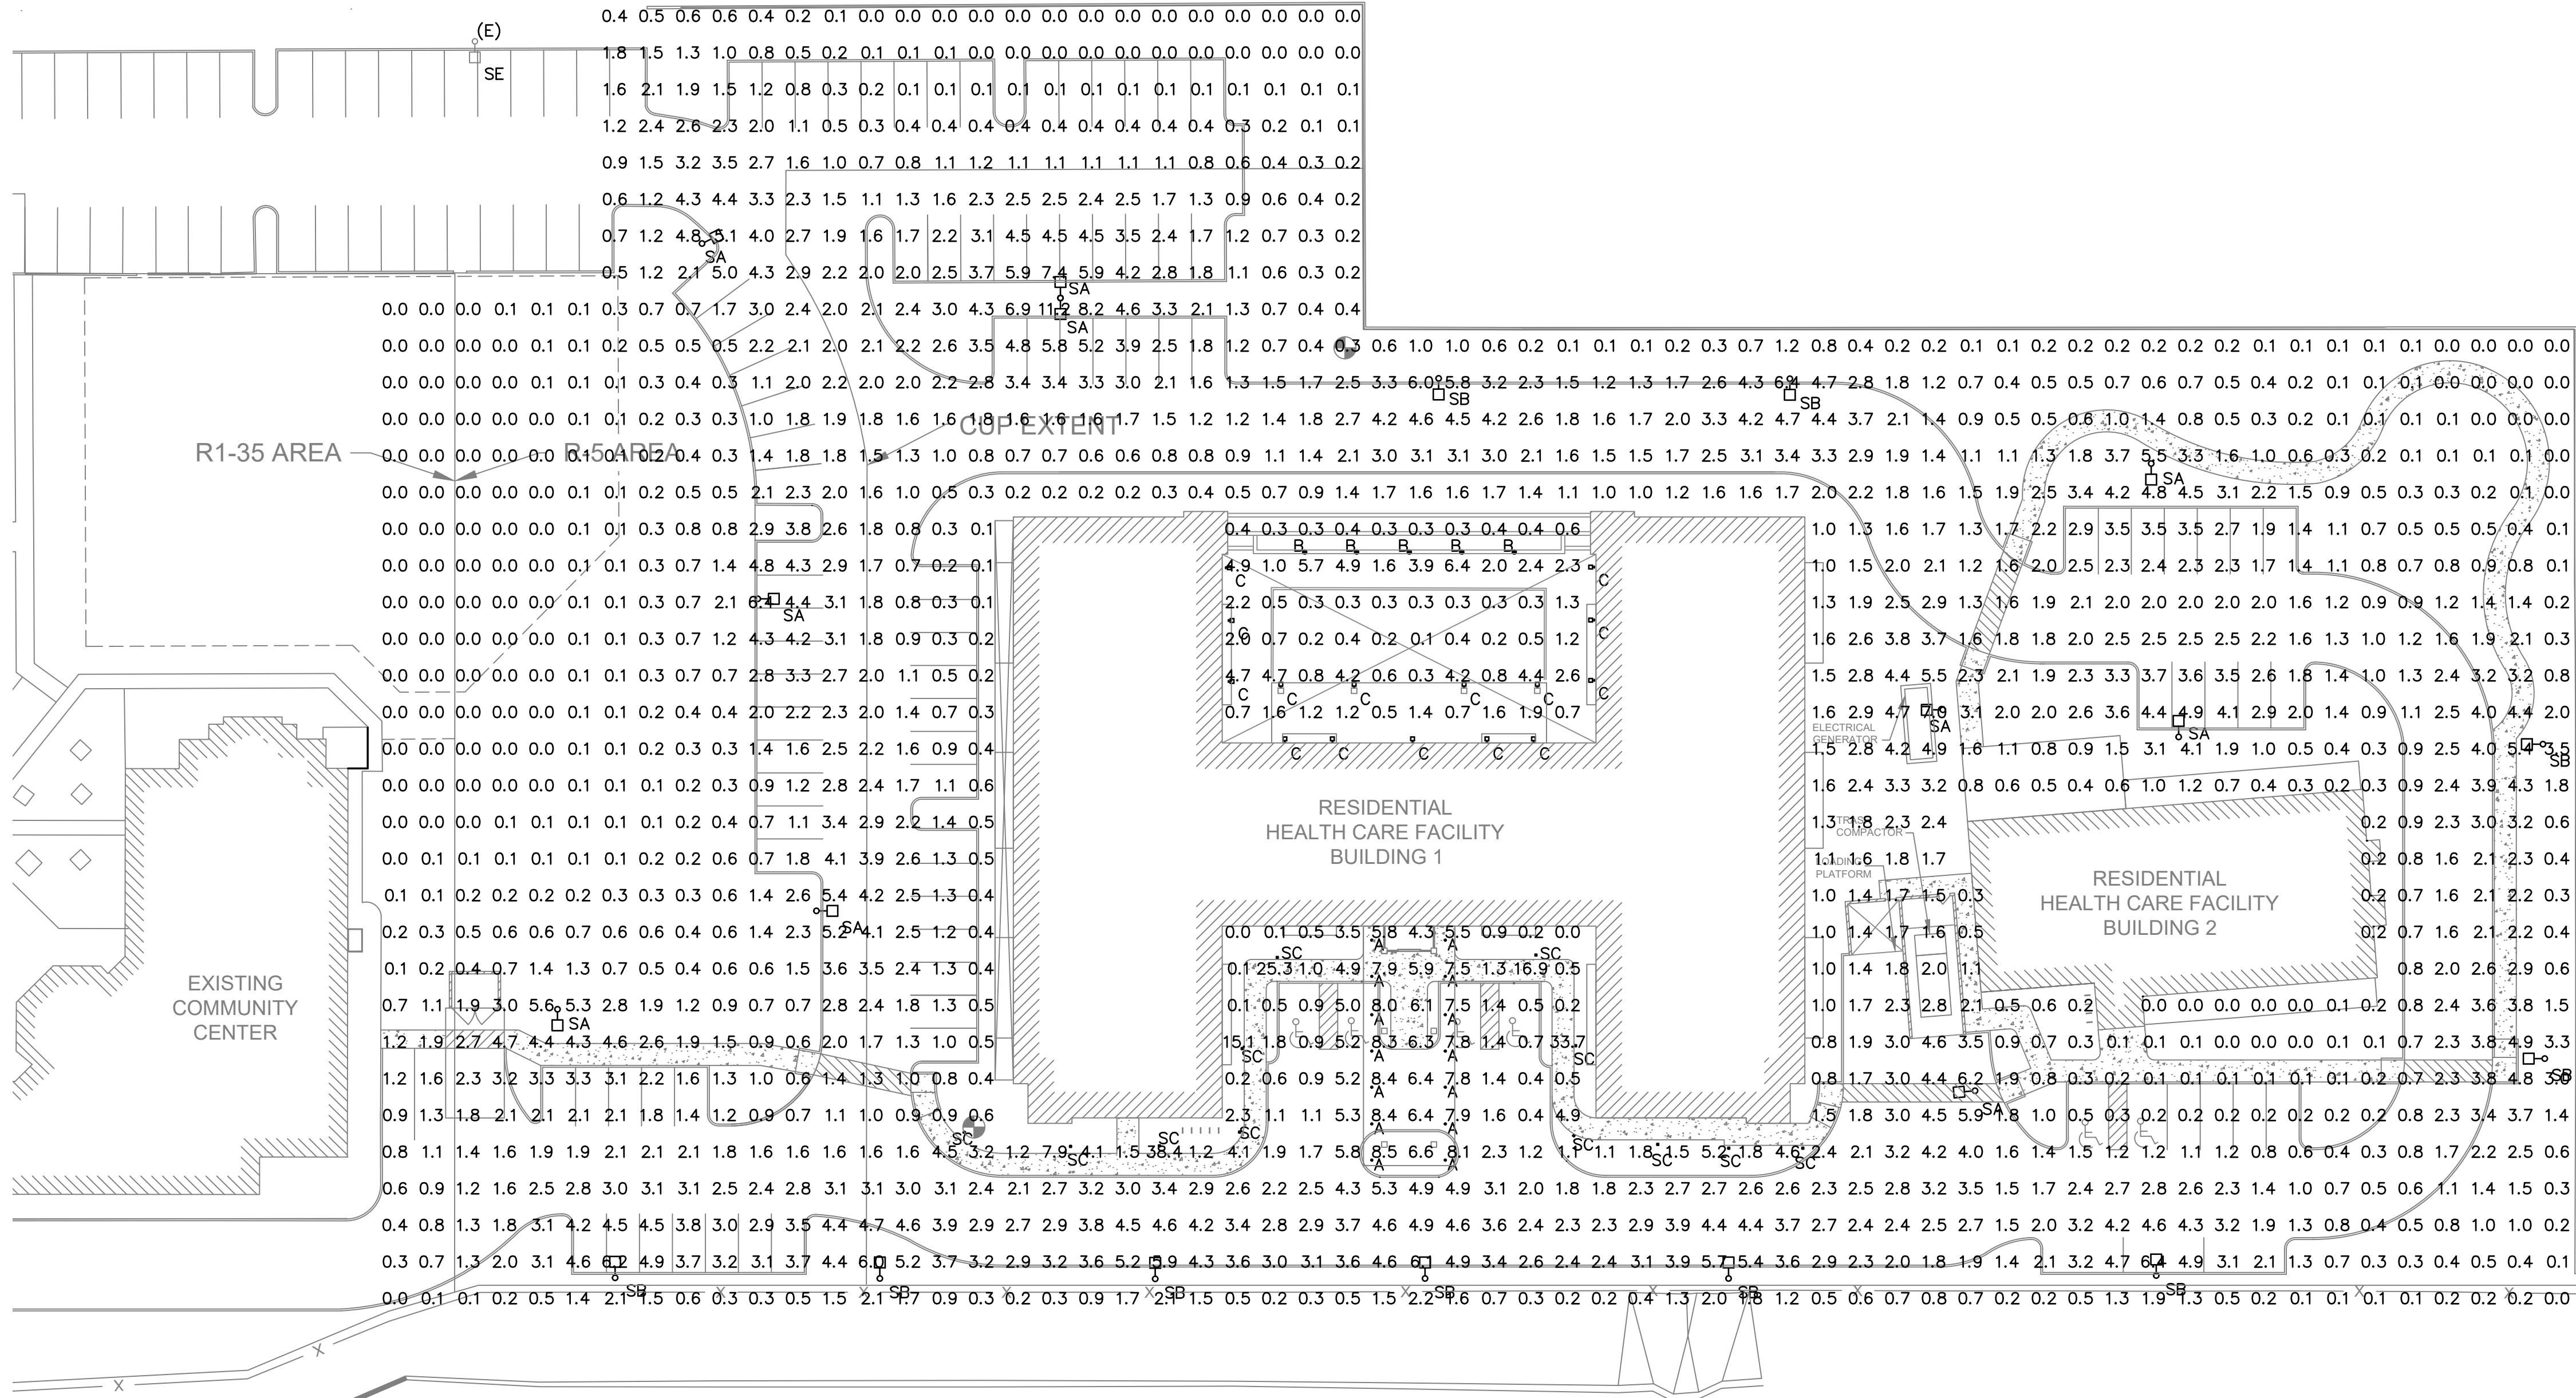

LUMINAIRE SCHEDULE									
CALLOUT	SYMBOL	LAMP	DESCRIPTION	MOUNTING	MODEL	VOLTS	NOTE 1	QUANTITY	INPUT W
A	.	(1) LED	6" LED DOWN LIGHT	RECESSED	GOTHAM EVO 35 15 6AR MWD LSS	120V 1P 2W		14	18.8
B	.	(1) LED (INCL)	LED STEP LIGHT	RECESSED	Winona Lighting, STEP13 INT 12LONG L LST2A WHT30K MVOLT LBPS	120V 1P 2W	DARK SKIES	5	11
C	.	(1) 16W LED(INCL)	OUTDOOR WALL SCONCE	WALL 80" TO TOP	Urban Indoor/Outdoor LED Wall Sconce BY MODERN FORMS, BRONZE, MEDIUM	120V 1P 2W	960 LUMEN, DARK SKIES	15	16
SA	◐◑	(1) LED	LED POLE FIXTURE	POLE	Lithonia Lighting, KAD LED 60C 530 40K R3 MVOLT	120V 1P 2W	BRONZE, DARK SKY	10	103
SB	◐◑	(1) LED	LED POLE FIXTURE	POLE	Lithonia Lighting, KAD LED 60C 530 40K R3 MVOLT	120V 1P 2W	BRONZE, HOUSE SIDE SHIELD, DARK SKY	10	103
SC	.	(1) LED	42" BOLLARD	POLE	RAB LIGHTING INC. BLED13N	120V 1P 2W	DARK SKY	12	15

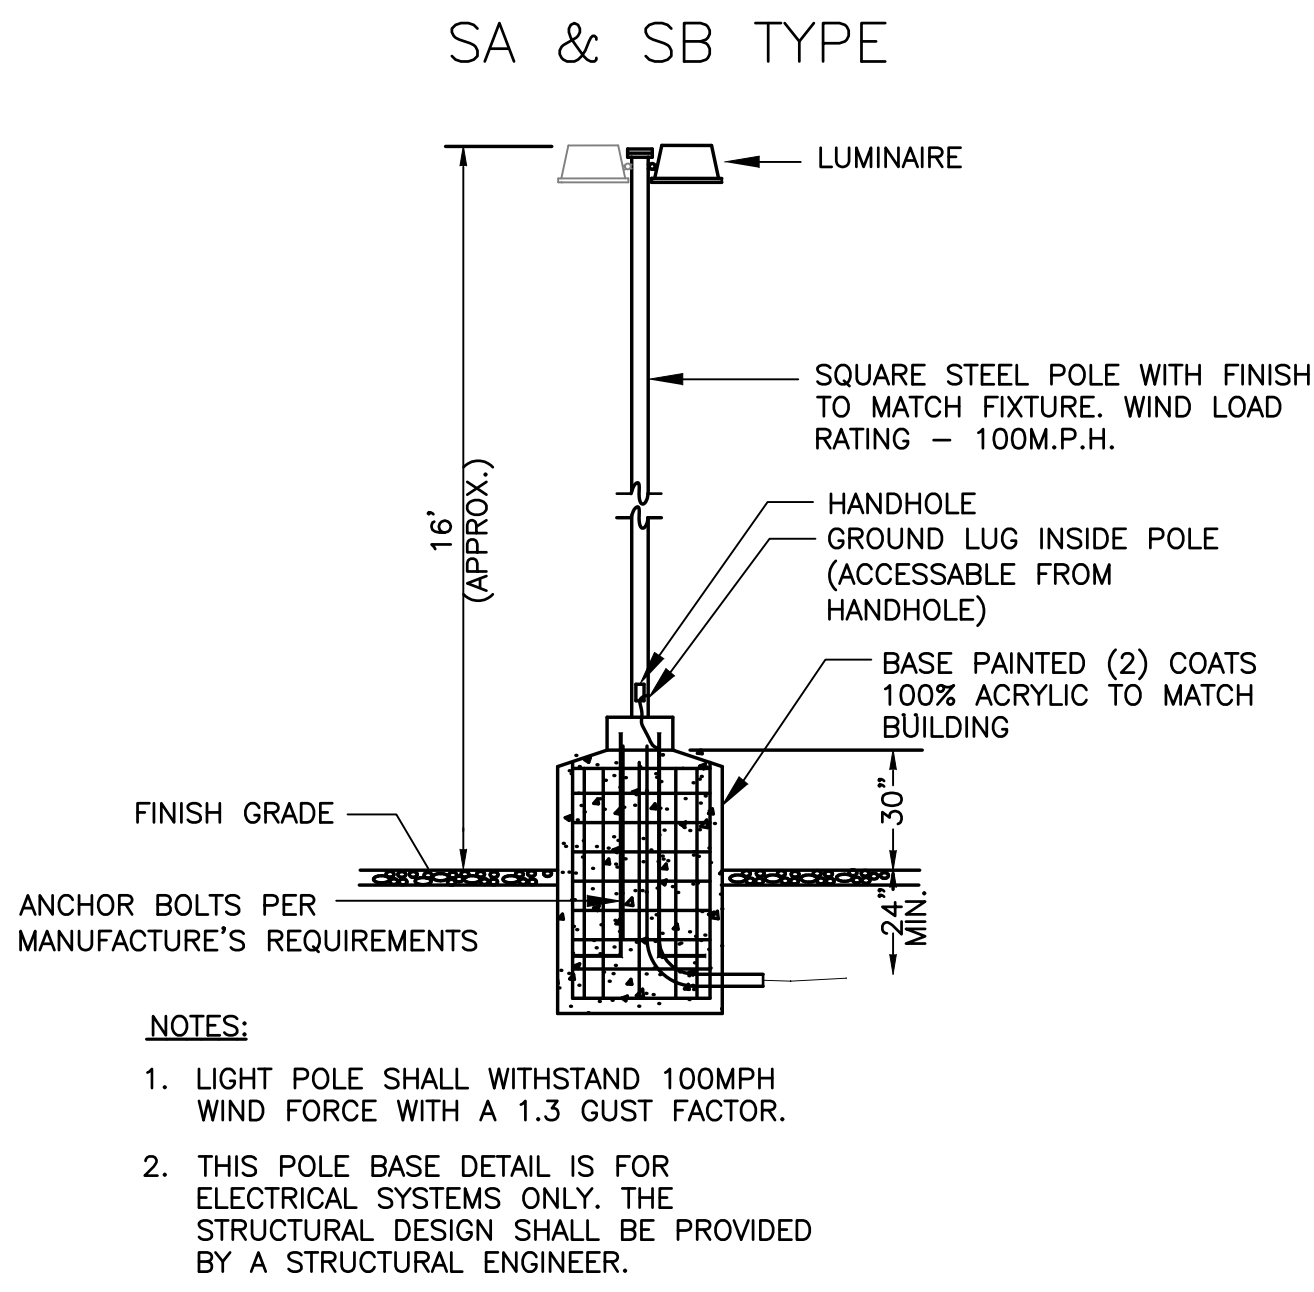

- NOTES:
1. LIGHT POLE SHALL WITHSTAND 100MPH WIND FORCE WITH A 1.3 GUST FACTOR.
 2. THIS POLE BASE DETAIL IS FOR ELECTRICAL SYSTEMS ONLY. THE STRUCTURAL DESIGN SHALL BE PROVIDED BY A STRUCTURAL ENGINEER.

LIGHT POLE DETAIL

N.T.S.

1 SITE LIGHTING PLAN
scale: 1"= 30'

MEGERDICHIAN
SENIOR CENTER
8849 E. CHOLLA ST.
SCOTTSDALE, AZ 85260

PRE-CONSTRUCTION PHASE	
NO.	ISSUED FOR: DATE
1	REZONING & C.U.P. 12-13-2018
2	REZONING & C.U.P. 08-03-2020
3	2nd Review

CONSTRUCTION PHASE	
REV.	BULLETIN # DATE
1	
2	
3	

SHEET TITLE

SCALE: 08/03/2020

DATE: 1727-00

JOB NUMBER:

E1.0