
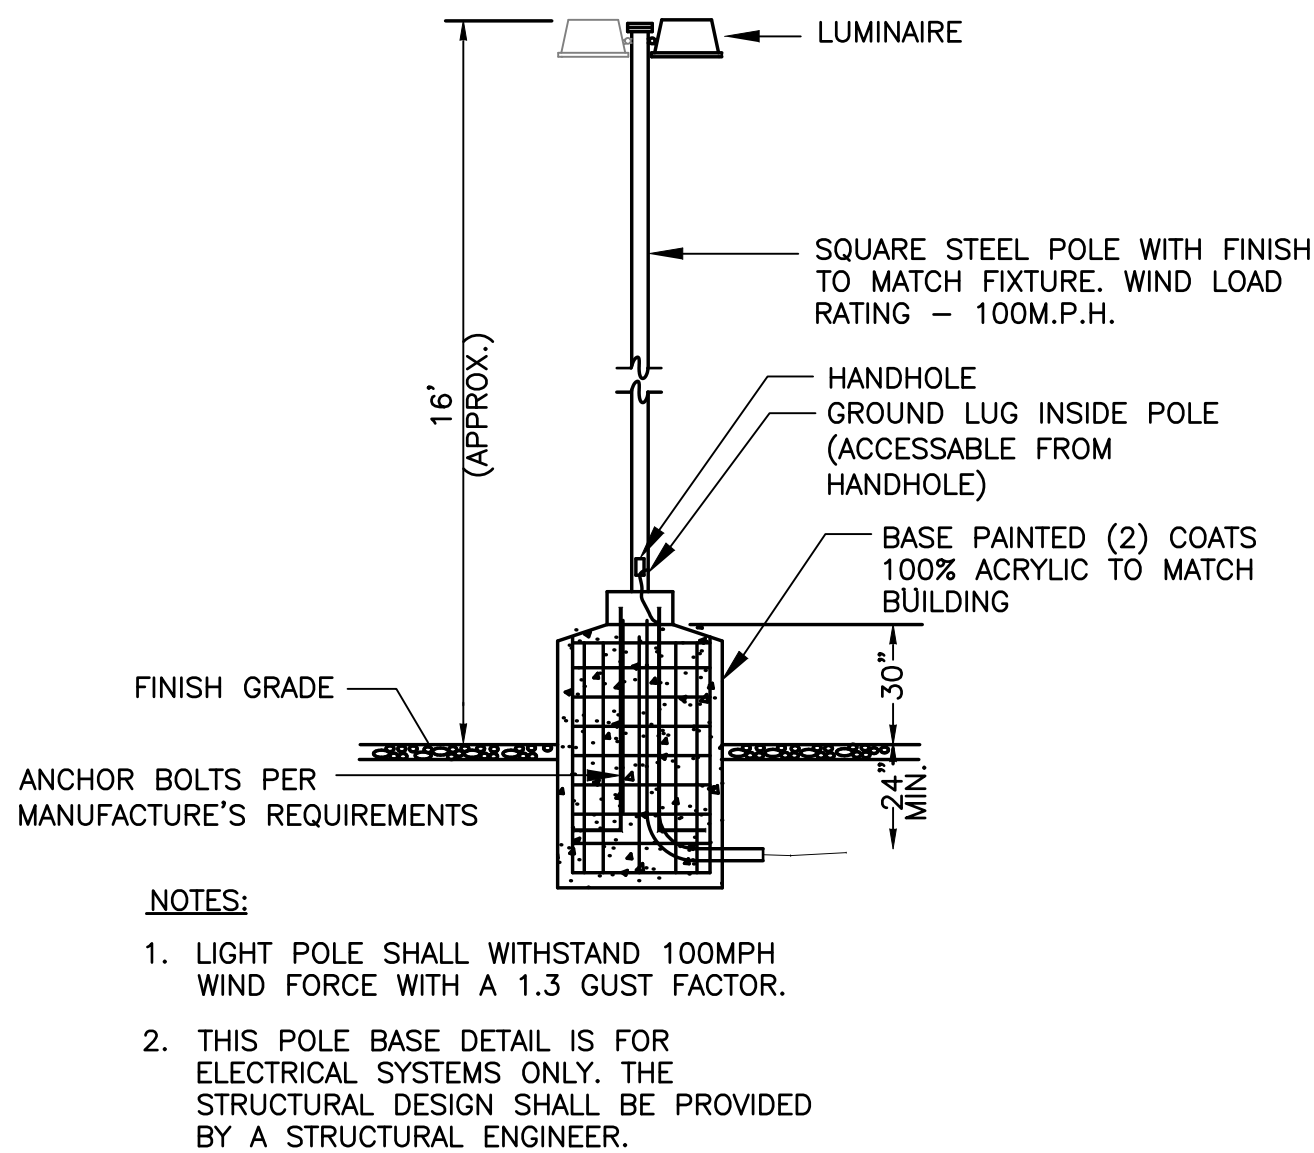


PLOT DATE: Wednesday, September 9, 2020 2:55:49 PM

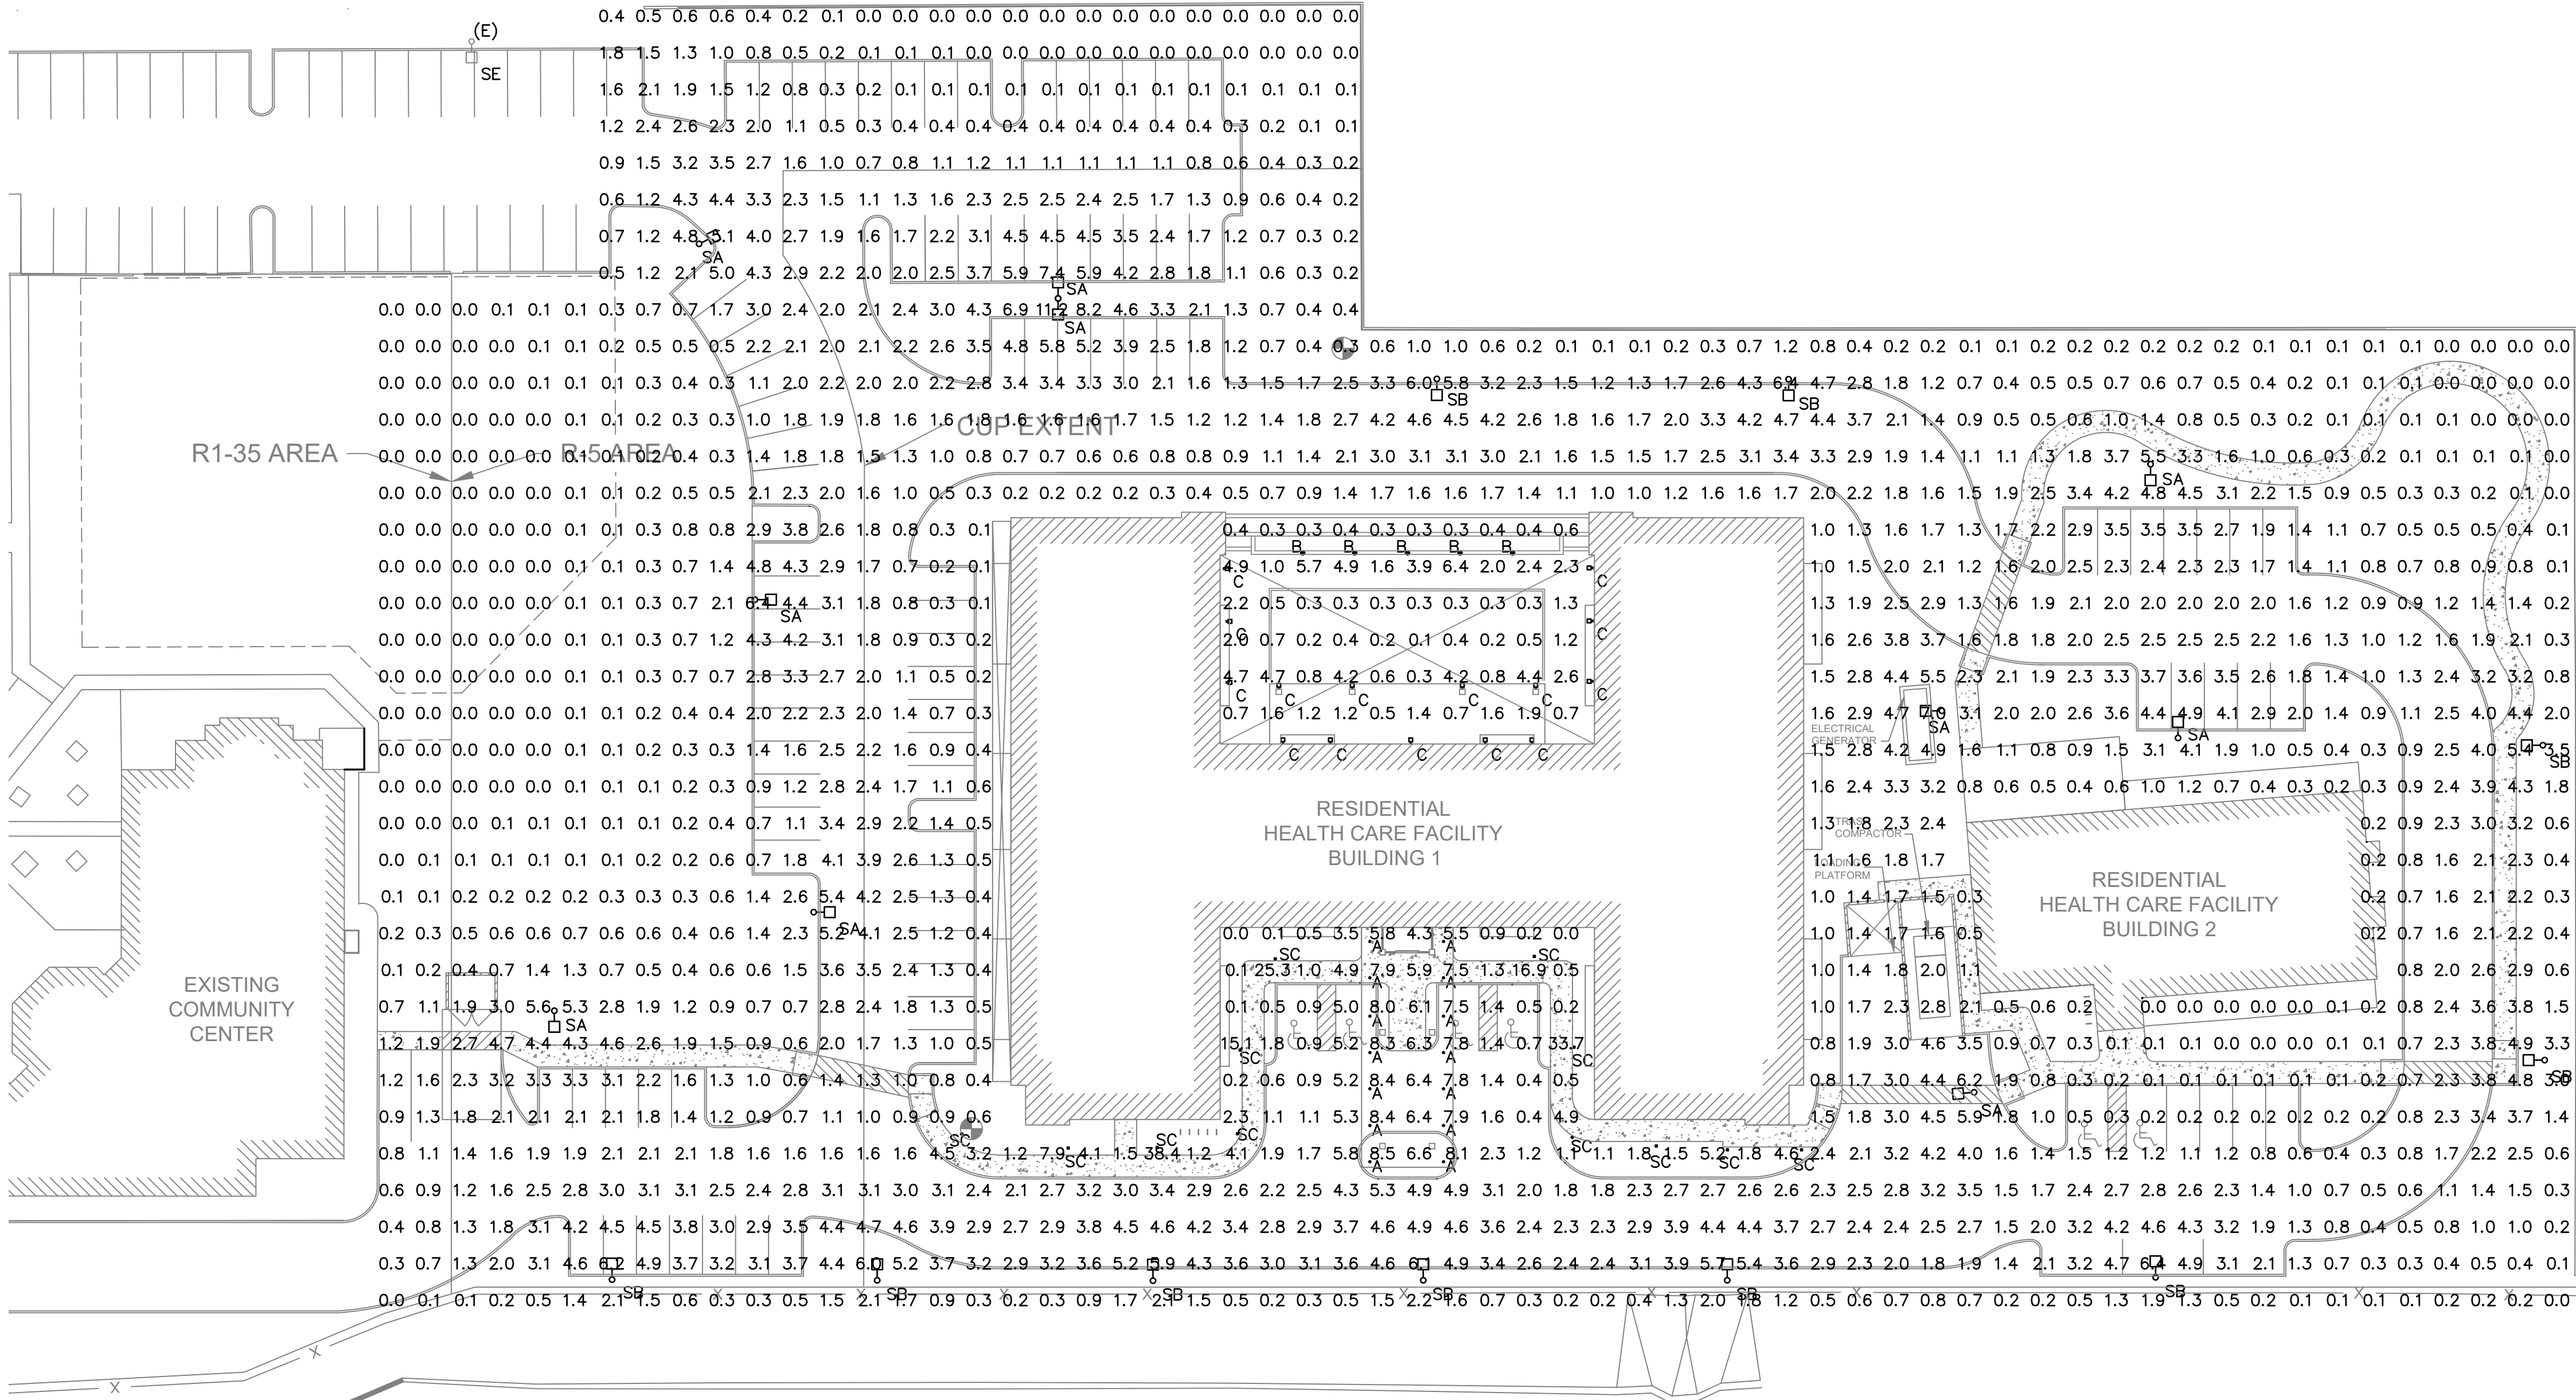

- NOTES:**
1. LIGHT POLE SHALL WITHSTAND 100MPH WIND FORCE WITH A 1.3 GUST FACTOR.
 2. THIS POLE BASE DETAIL IS FOR ELECTRICAL SYSTEMS ONLY. THE STRUCTURAL DESIGN SHALL BE PROVIDED BY A STRUCTURAL ENGINEER.

LIGHT POLE DETAIL

N.T.S.

LUMINAIRE SCHEDULE


CALLOUT	SYMBOL	LAMP	DESCRIPTION	MOUNTING	MODEL	VOLTS	NOTE 1	QUANTITY	INPUT W
A	.	(1) LED	6" LED DOWN LIGHT	RECESSED	GOTHAM EVO 35 15 6AR MWD LSS	120V 1P 2W		14	18.8
B	.	(1) LED (INCL)	LED STEP LIGHT	RECESSED	Winona Lighting, STEP13 INT 12LONG L LST2A WHIT30K MVOLT LBPS	120V 1P 2W	DARK SKIES	5	11
C	.	(1) 16W LED(INCL)	OUTDOOR WALL SCONCE	WALL	Urban Indoor/Outdoor LED Wall Sconce BY MODERN FORMS, BRONZE, MEDIUM	120V 1P 2W	960 LUMEN, DARK SKIES	15	16
SA	◻	(1) LED	LED POLE FIXTURE	POLE	Lithonia Lighting, KAD LED 60C 530 40K R3 MVOLT	120V 1P 2W	BRONZE, DARK SKY	10	103
SB	◻	(1) LED	LED POLE FIXTURE	POLE	Lithonia Lighting, KAD LED 60C 530 40K R3 MVOLT	120V 1P 2W	BRONZE, HOUSE SIDE SHIELD, DARK SKY	10	103
SC	.	(1) LED	42" BOLLARD	POLE	RAB LIGHTING INC. BLED13N	120V 1P 2W	DARK SKY	12	15

General Photometric Schedule

AVERAGE FOOT-CANDLES	1.75
MAXIMUM FOOT-CANDLES	38.4
MINIMUM FOOT-CANDLES	0.0
MINIMUM TO MAXIMUM FC RATIO	0.00
MAXIMUM TO MINIMUM FC RATIO	3582.98
AVERAGE TO MINIMUM FC RATIO	163.60

SITE PHOTOMETRIC PLAN


scale: 1"= 30'

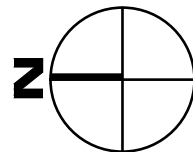

DON WITT ENGINEERING ASSOCIATES
2323 E. MINTON MESA, AZ 85213
(480)656-0810
PROJECT# 6779 FAX: (480)656-0812

MEGERDICHIAN SENIOR CENTER 8849 E. CHOLLA ST. SCOTTSDALE, AZ 85260

PRE-CONSTRUCTION PHASE		
NO.	ISSUED FOR:	DATE
1	REZONING & C.U.P.	12-13-2018
2	REZONING & C.U.P. 2nd Review	08-03-2020
3		
4		
5		
CONSTRUCTION PHASE		
REV.	BULLETIN #	DATE
1		
2		
3		
4		
5		

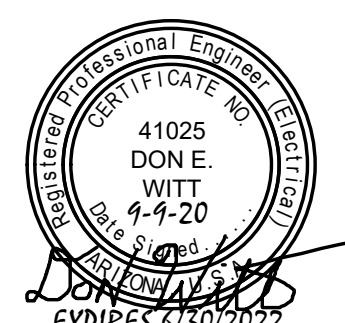

SHEET TITLE

SCALE: 1"= 30'
DATE: 08/03/2020
JOB NUMBER: 1727-00

PH1.0