


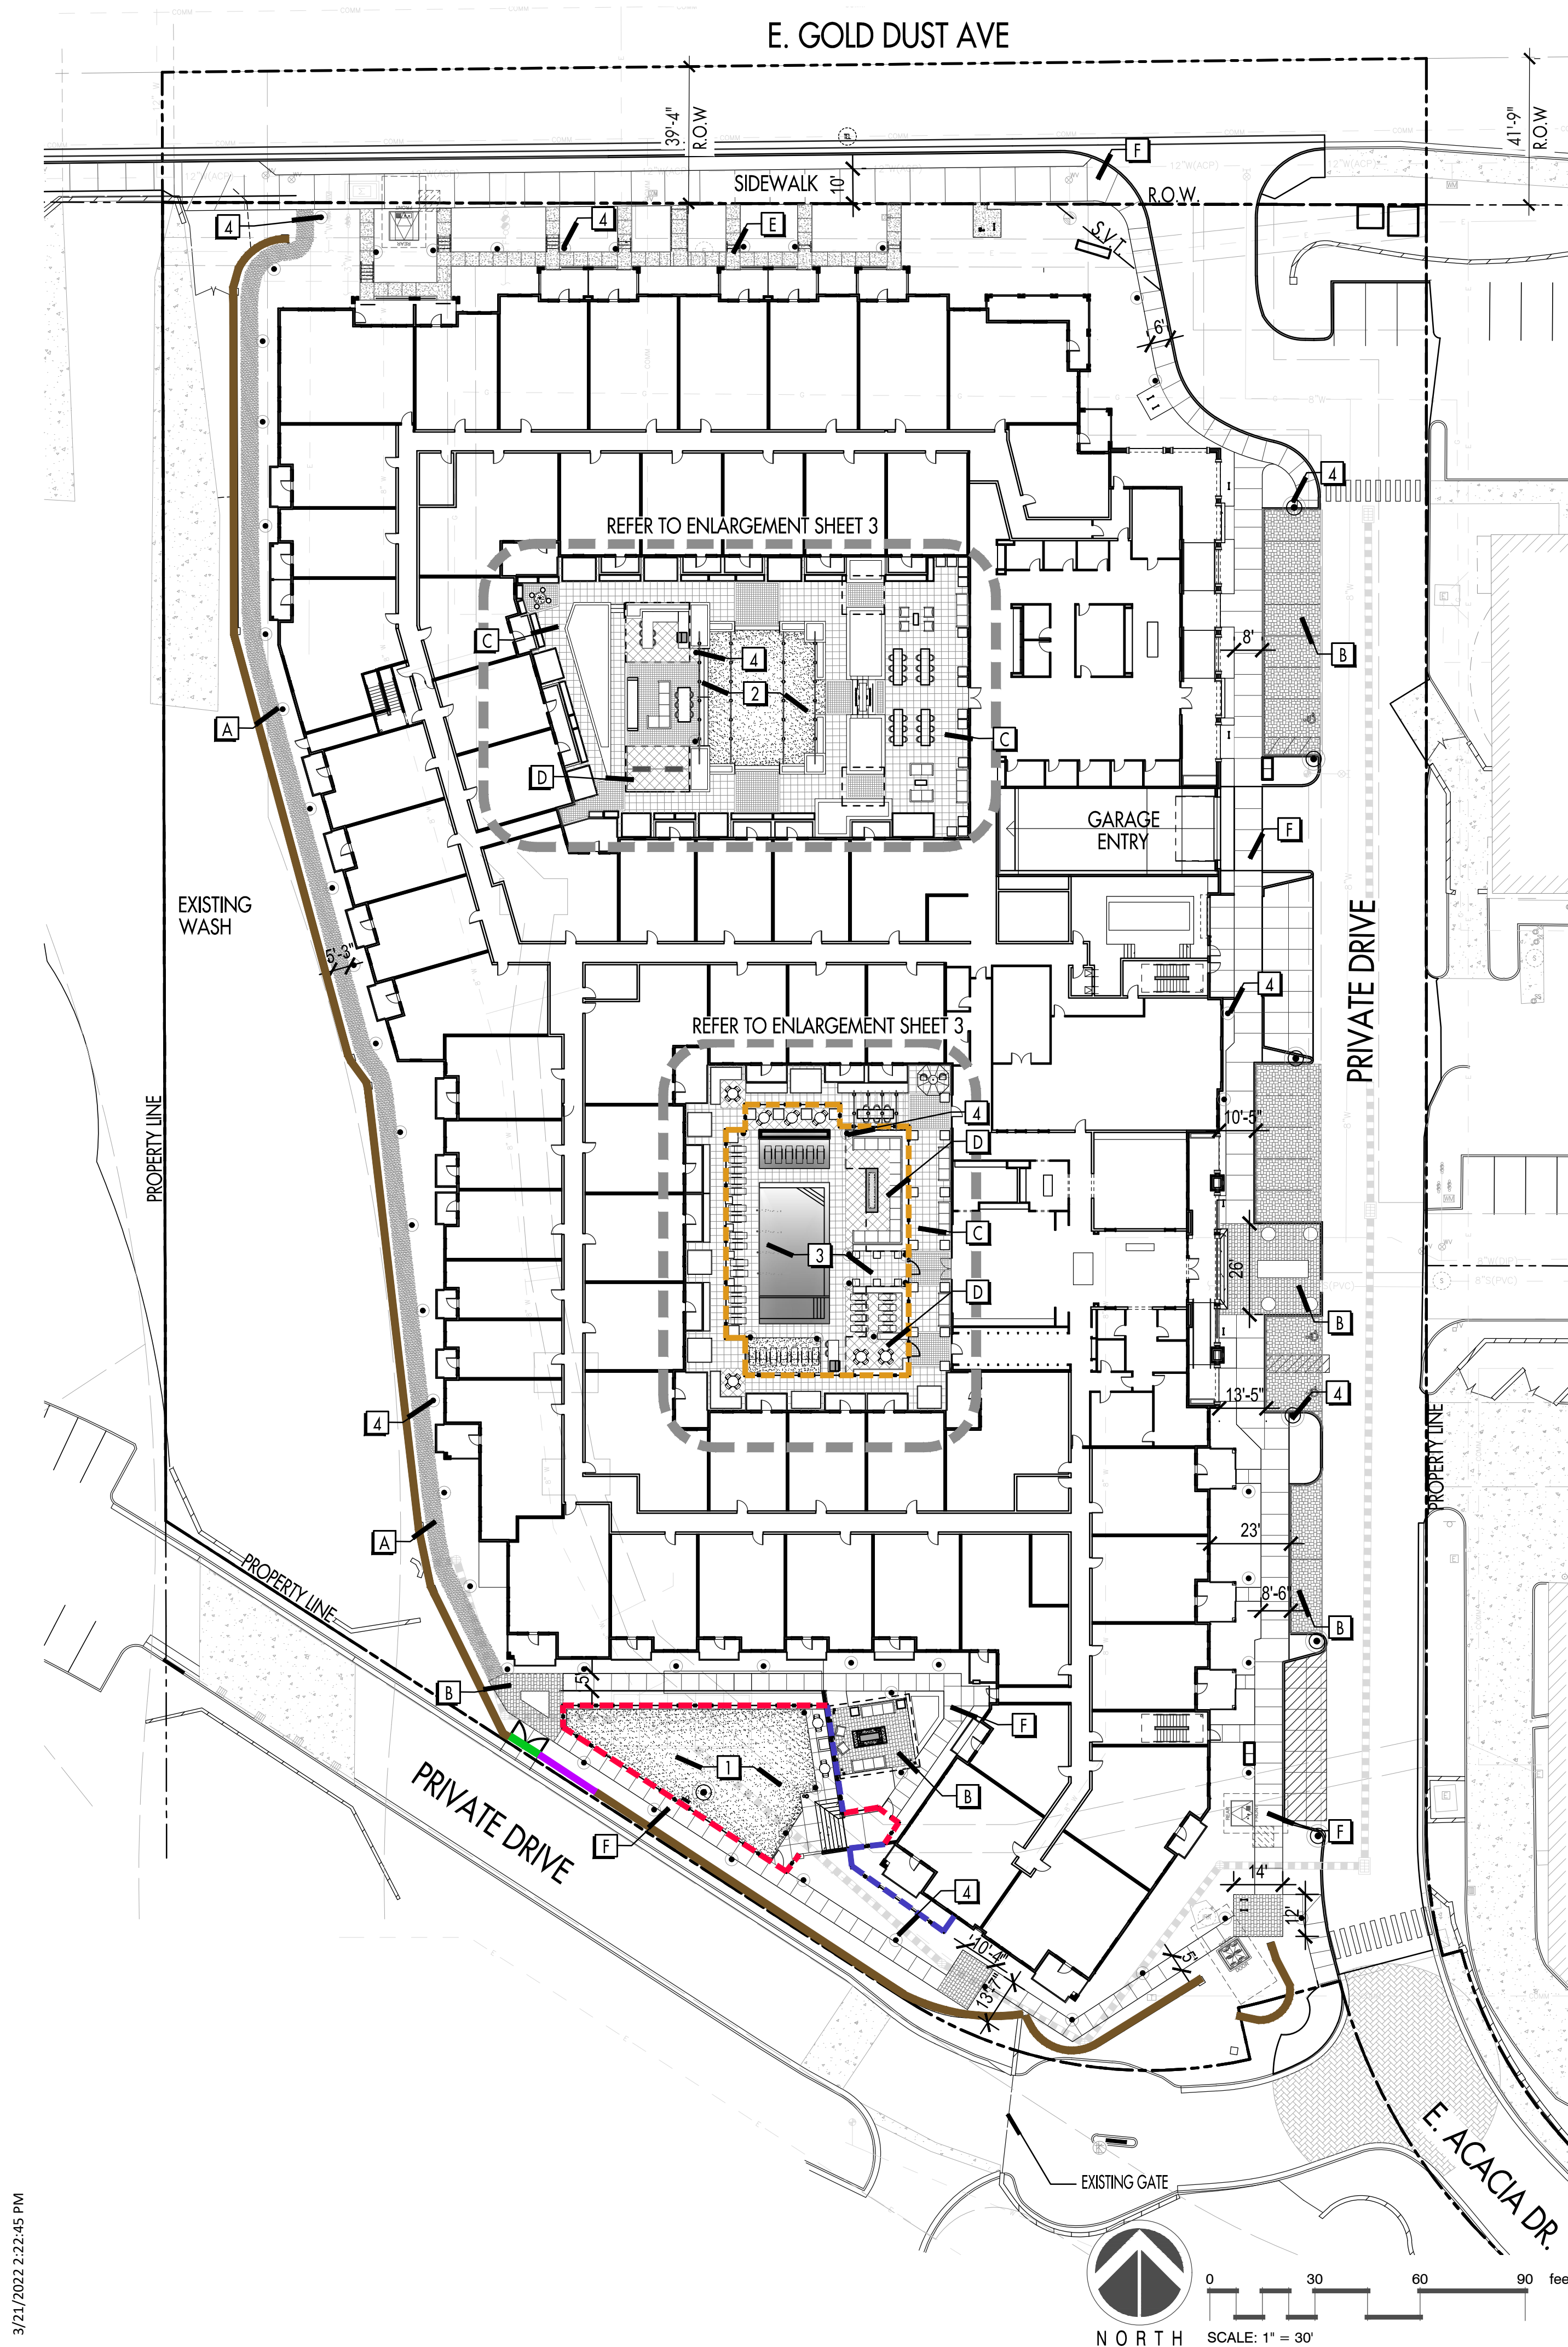

WALL LEGEND


- POOL FENCE
- DOG AREA FENCE
- RETAINING WALL WITH GUARDRAIL
- FIRE ACCESS GATE
- EXISTING WALL & FENCE TO REMAIN
- NEW WALL & FENCE TO MATCH EXISTING

HARDSCAPE KEYNOTES


- AMENITY AREA WITH DOG RUN, DOG FOUNTAIN, & FIREPLACE.
- CO-WORKING COURTYARD WITH ADJACENT WITH OUTDOOR BBQ, WATER FEATURE, SWINGS, FIREPLACE, AND INFORMAL PLAY LAWN.
- POOL AMENITY AREA WITH LARGE GROUP SEATING, FIRE PIT, BBQ, POOL/SPA, DETACHED BAJA SHELF WITH WATER FEATURE, & SYNTHETIC TURF.
- SITE LIGHTING, TYP. REFER TO ELECTRICAL PLAN.

HARDSCAPE FINISHES


- A STABILIZED DG TRAIL
REFER TO SHEET L7 FOR COLOR & FINISH
- B VEHICULAR & PEDESTRIAN PAVERS
REFER TO SHEET L7 FOR COLOR & FINISH
- C ENHANCED PAVERS
REFER TO SHEET L7 FOR COLOR & FINISH
- D ENHANCED PAVERS
REFER TO SHEET L7 FOR COLOR & FINISH
- E NATURAL GRAY CONCRETE
REFER TO SHEET L7 FOR COLOR & FINISH
- F NATURAL GRAY CONCRETE WITH MEDIUM ACID ETCH
REFER TO SHEET L7 FOR COLOR & FINISH
- G ACCENT PAVERS IN COURTYARD

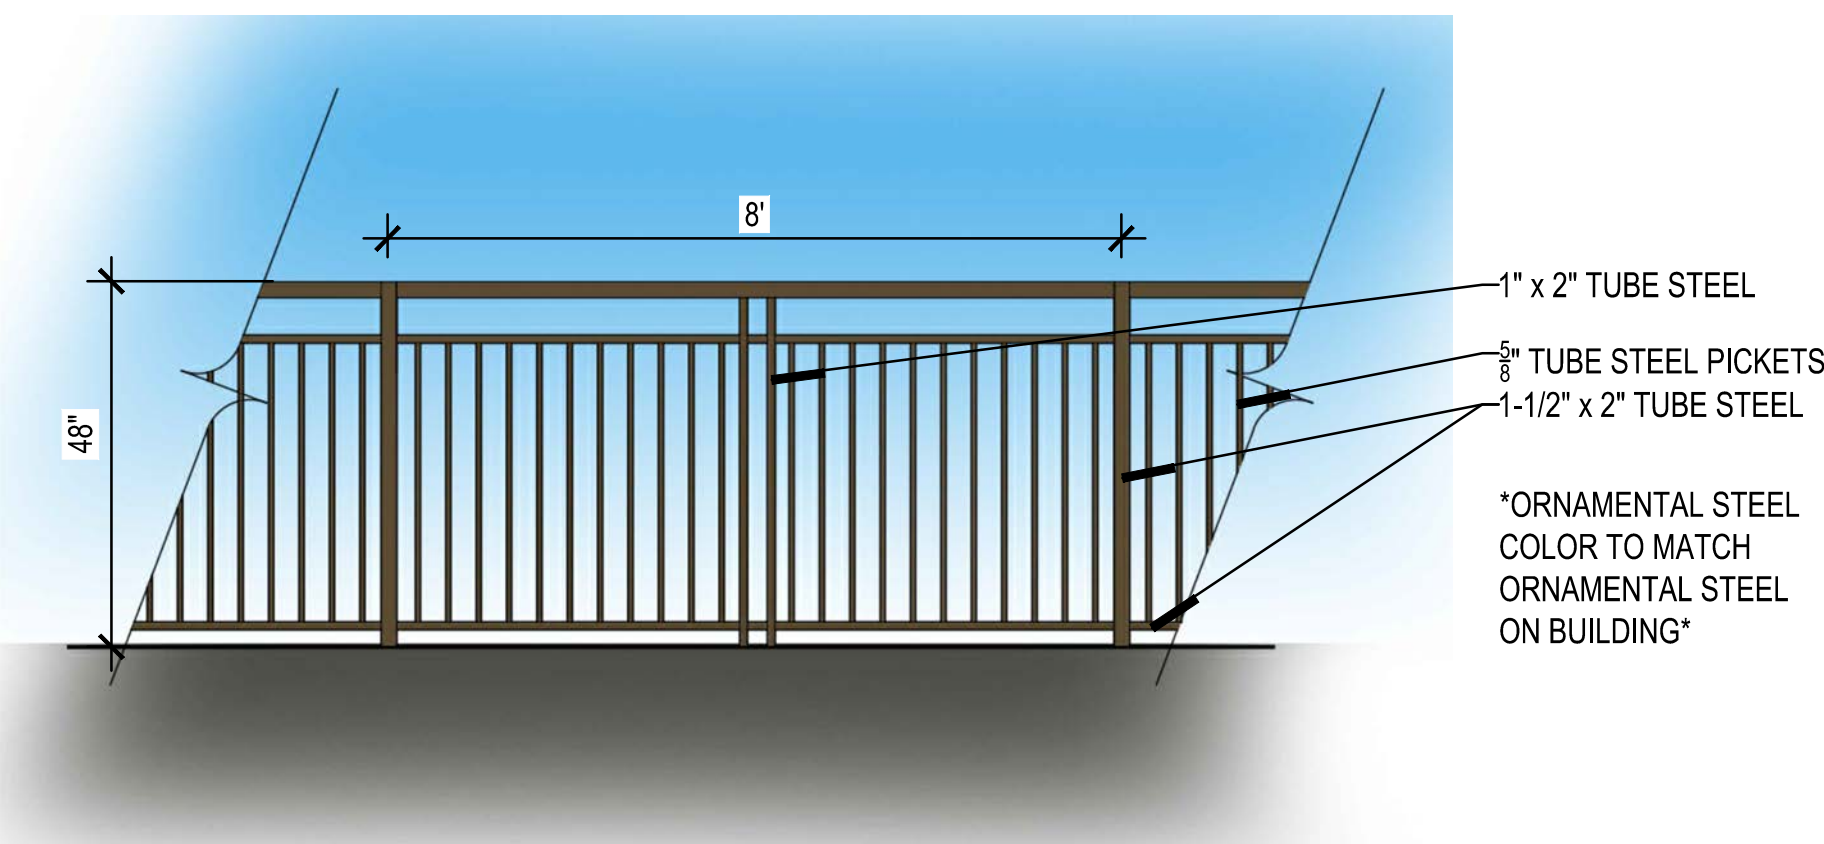


DOG AREA FENCE

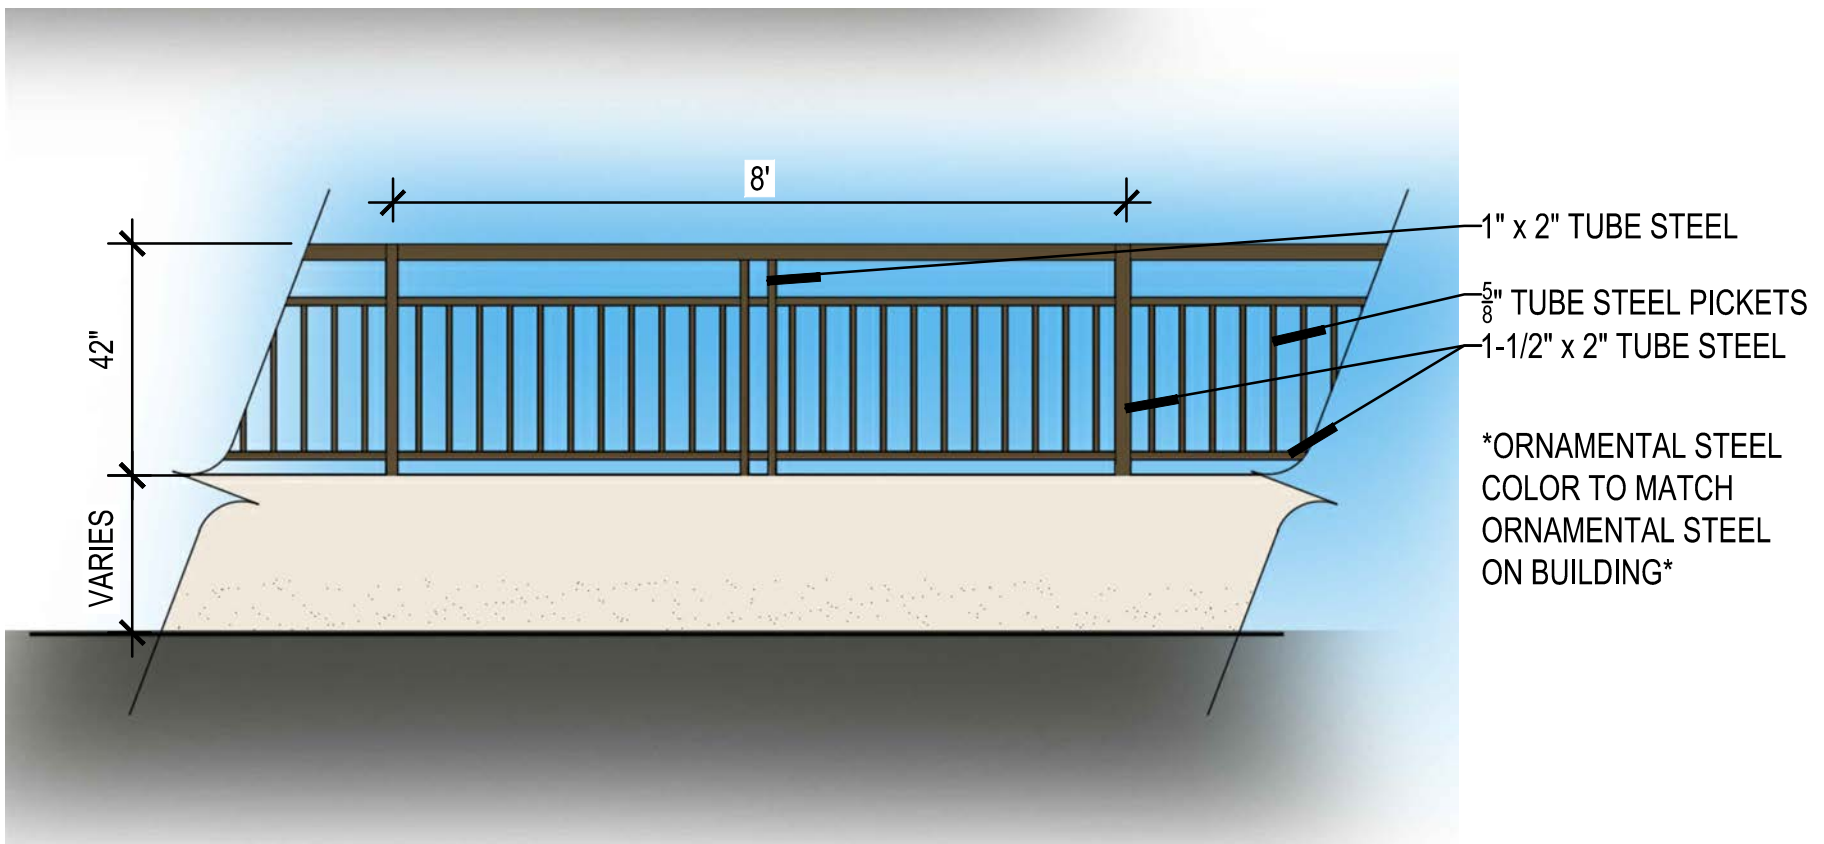

RETAINING WALL WITH GUARDRAIL

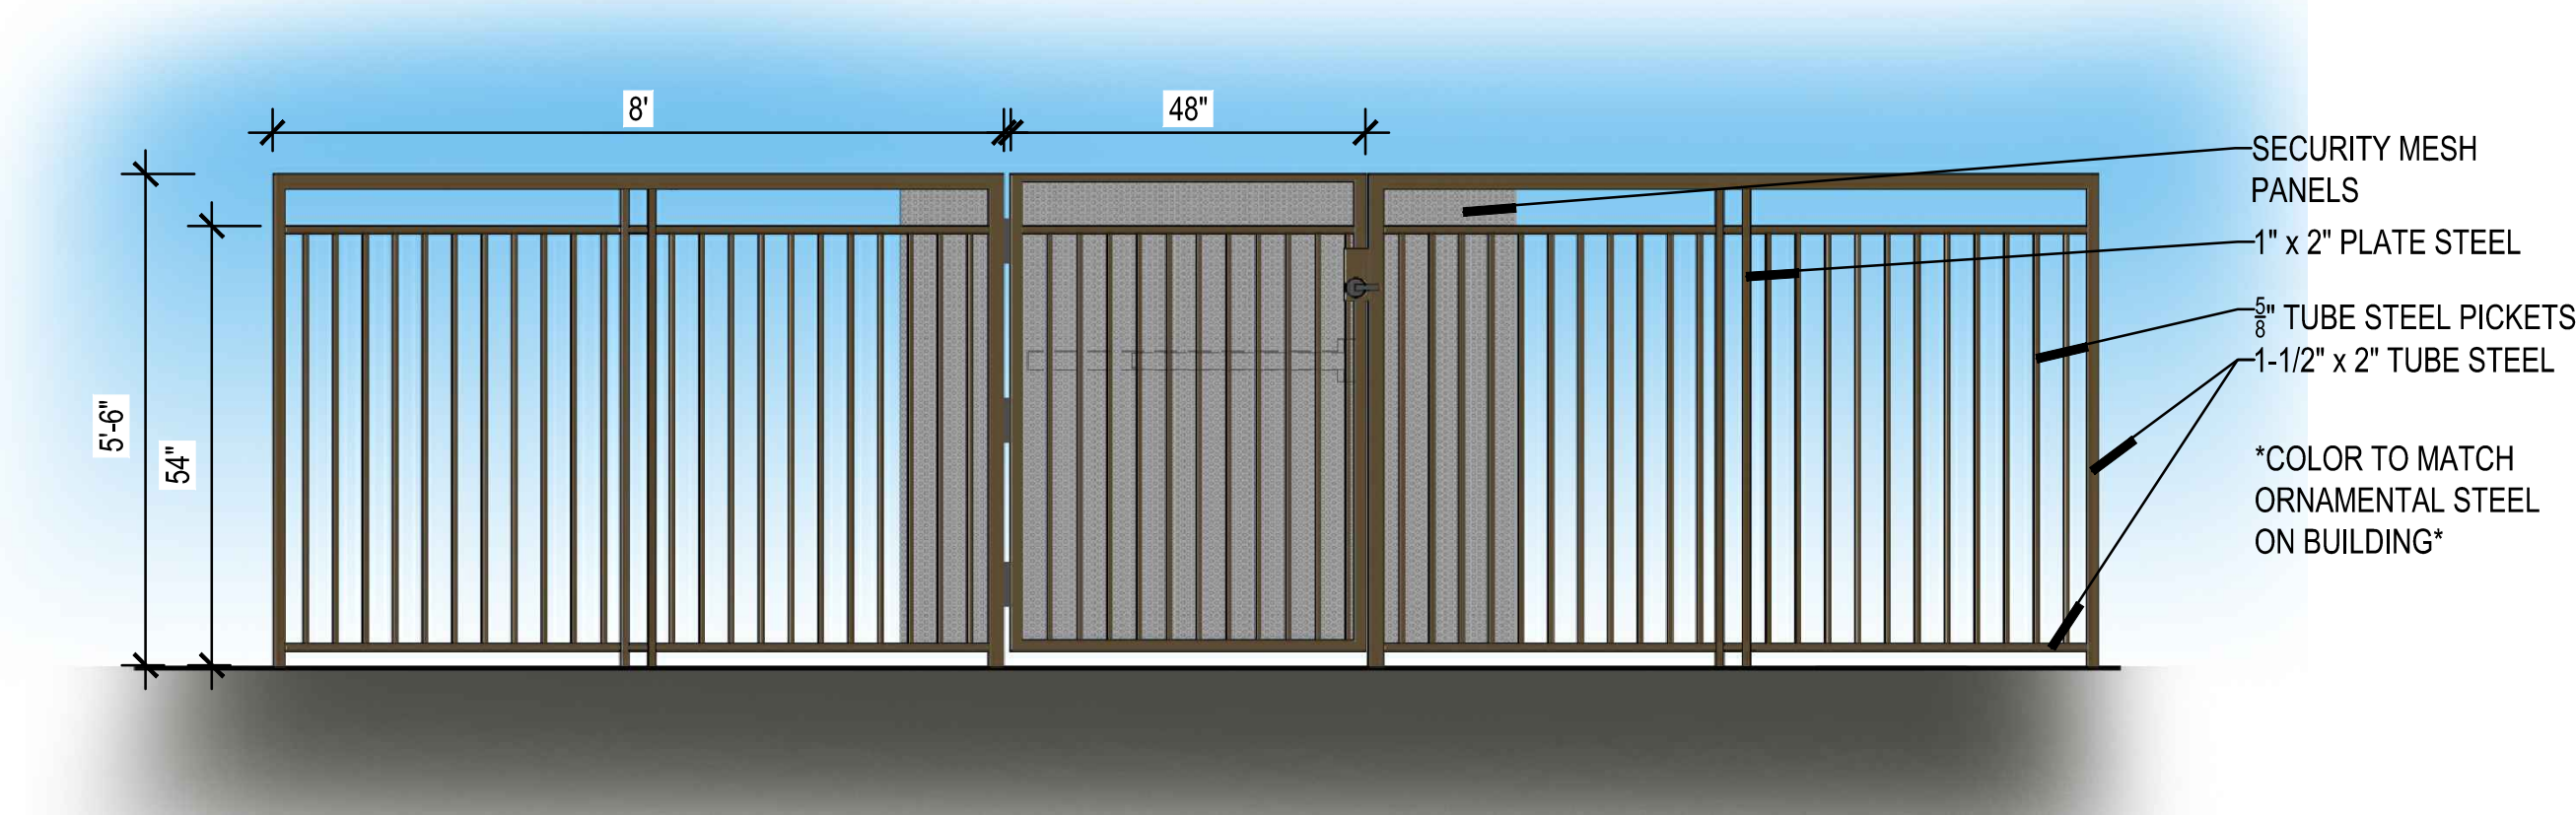

POOL FENCE

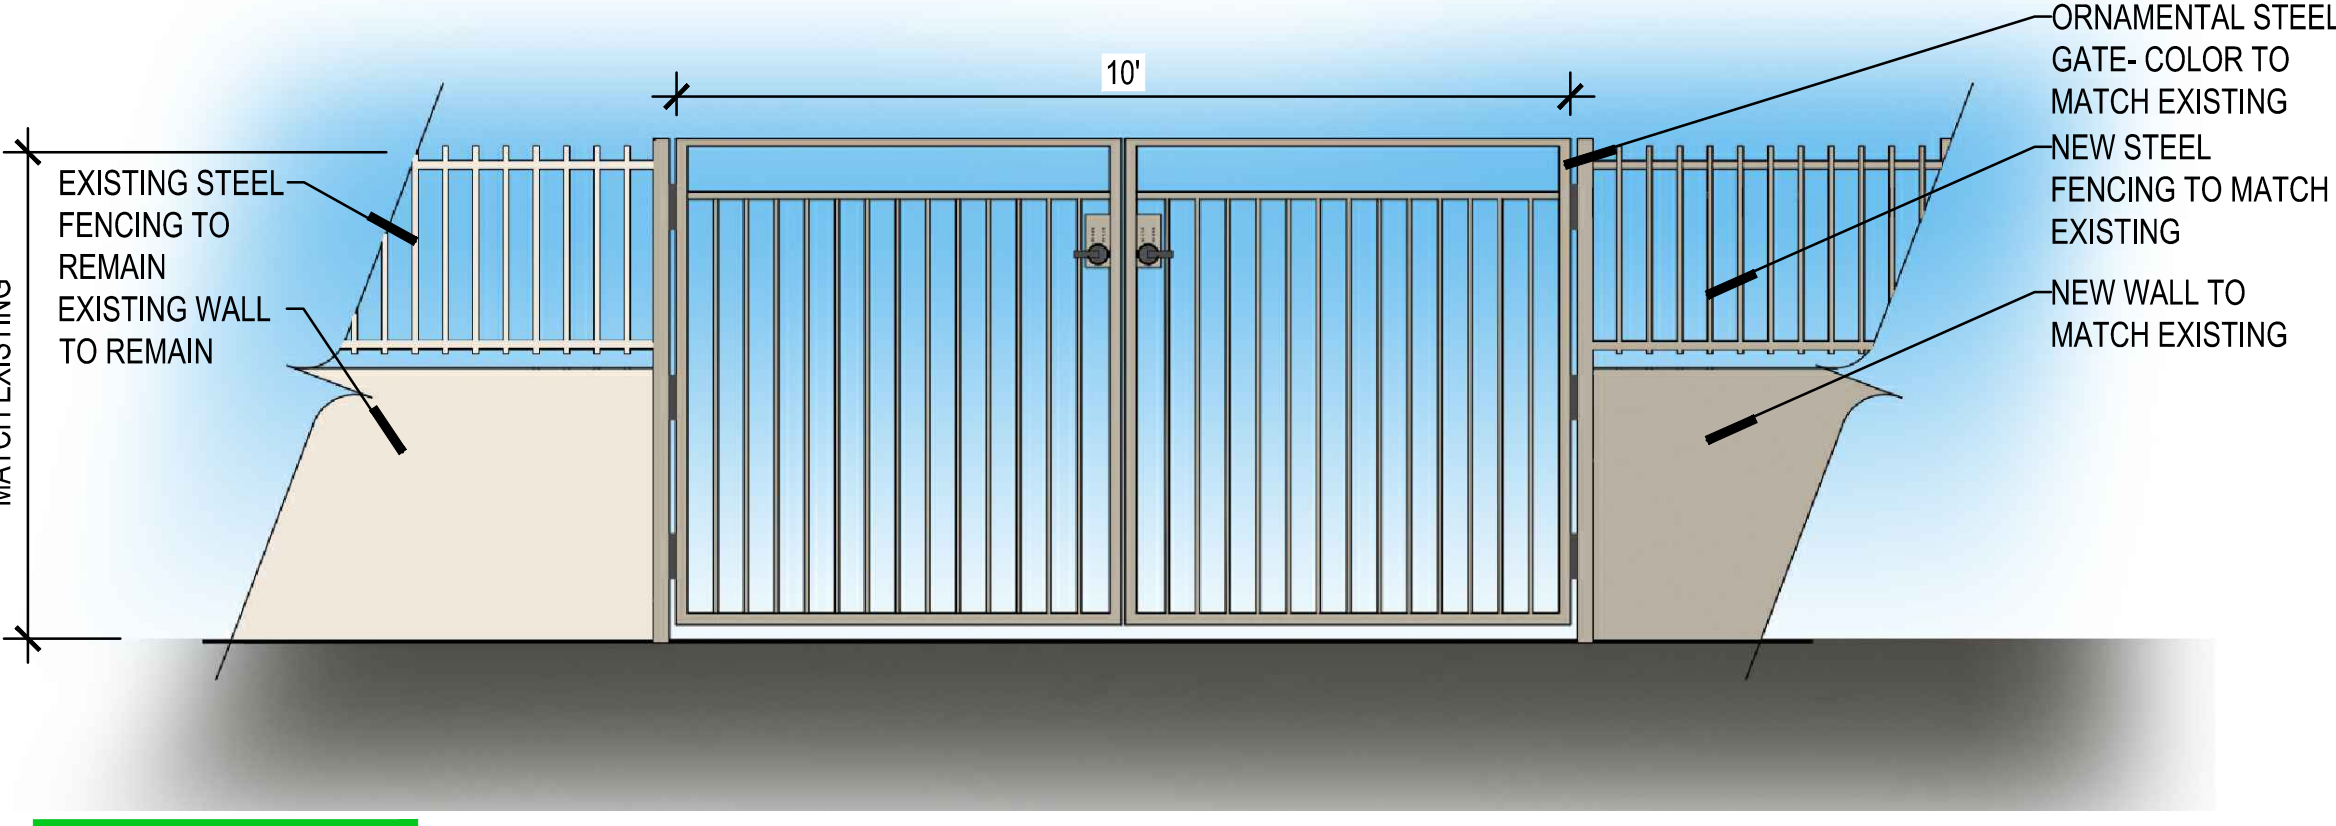

FIRE ACCESS GATE

Gold Dust Ave &
Scottsdale Rd

Scottsdale, AZ



esc
ARCHITECTURE & DESIGN


500 Washington Avenue South, Suite 1080
Minneapolis, MN 55415
p 612.339.5508 | f 612.339.5382
www.esgarch.com

I hereby certify that this plan, specification, or
report was prepared by me or under my direct
supervision and that I am a duly licensed architect
under the laws of the State of Arizona

Signature

Typed or Printed Name

License # Date

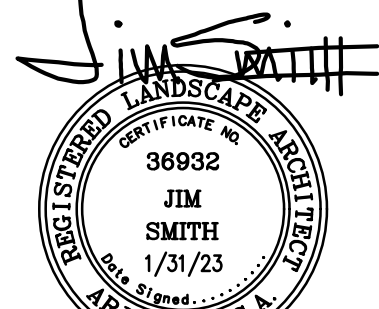

EXPIRES 12.31.25

DRB
SUBMITTAL
1/31/2023

ORIGINAL ISSUE:

REVISIONS	No.	Description	Date
-----------	-----	-------------	------

221564

PROJECT NUMBER

DRAWN BY CHECKED BY

KEY PLAN

Gold Dust Ave &
Scottsdale Rd

HARDSCAPE, WALL PLAN &
ELEVATIONS

L.2

collectiV
landscape architects