


**GARAGE - LUMINAIRE SCHEDULE**

1. PROVIDE 90 MINUTE EMERGENCY BATTERY BACK-UP FOR ALL EMERGENCY FIXTURES. SEE SCHEDULE BELOW FOR SPECIFICATIONS AND LUMEN REQUIREMENTS.
2. MODULAR WIRING SYSTEM FOR LIGHT FIXTURES IS AN ACCEPTABLE ALTERNATE.
3. BASE BID FOR LUMINAIRES SHALL BE BASED ON MANUFACTURERS LISTED IN CONTRACT DOCUMENTS. UPON AWARD OF PROJECT, ALTERNATES PROPOSED BY CONTRACTOR SHALL BE SUBMITTED WITH WRITTEN OWNER APPROVAL & AN ITEMIZED DEDUCT TO BASE BID.
4. ALTERNATE FIXTURE SELECTIONS MAY REQUIRE ADDITIONAL TIME FOR SUBMITTAL REVIEW & POSSIBLE ENGINEERING DESIGN CHANGES, TO BE BILLED TO THE CONTRACTOR.
5. PROVIDE MINIMUM 10 MINUTE TIME DELAY ON EMERGENCY FIXTURES WHEN HID AREA LIGHTING IS USED.

MARK	MANUFACTURER MODEL NUMBER	VOLTS	LAMPS CR/ CCT INPUT WATTS	REMARKS/MOUNTING
SAE	LITHONIA VCPG LED P1 40K T5M MVOLT UPL1 E10WH	MVOLT	LED 33.0 WATTS	GARAGE LIGHT FIXTURE PROVIDE 90 MINUTE BATTERY BACK-UP WHERE NOTED "EM". 0-10V DIMMING, OCCUPANCY SENSOR.

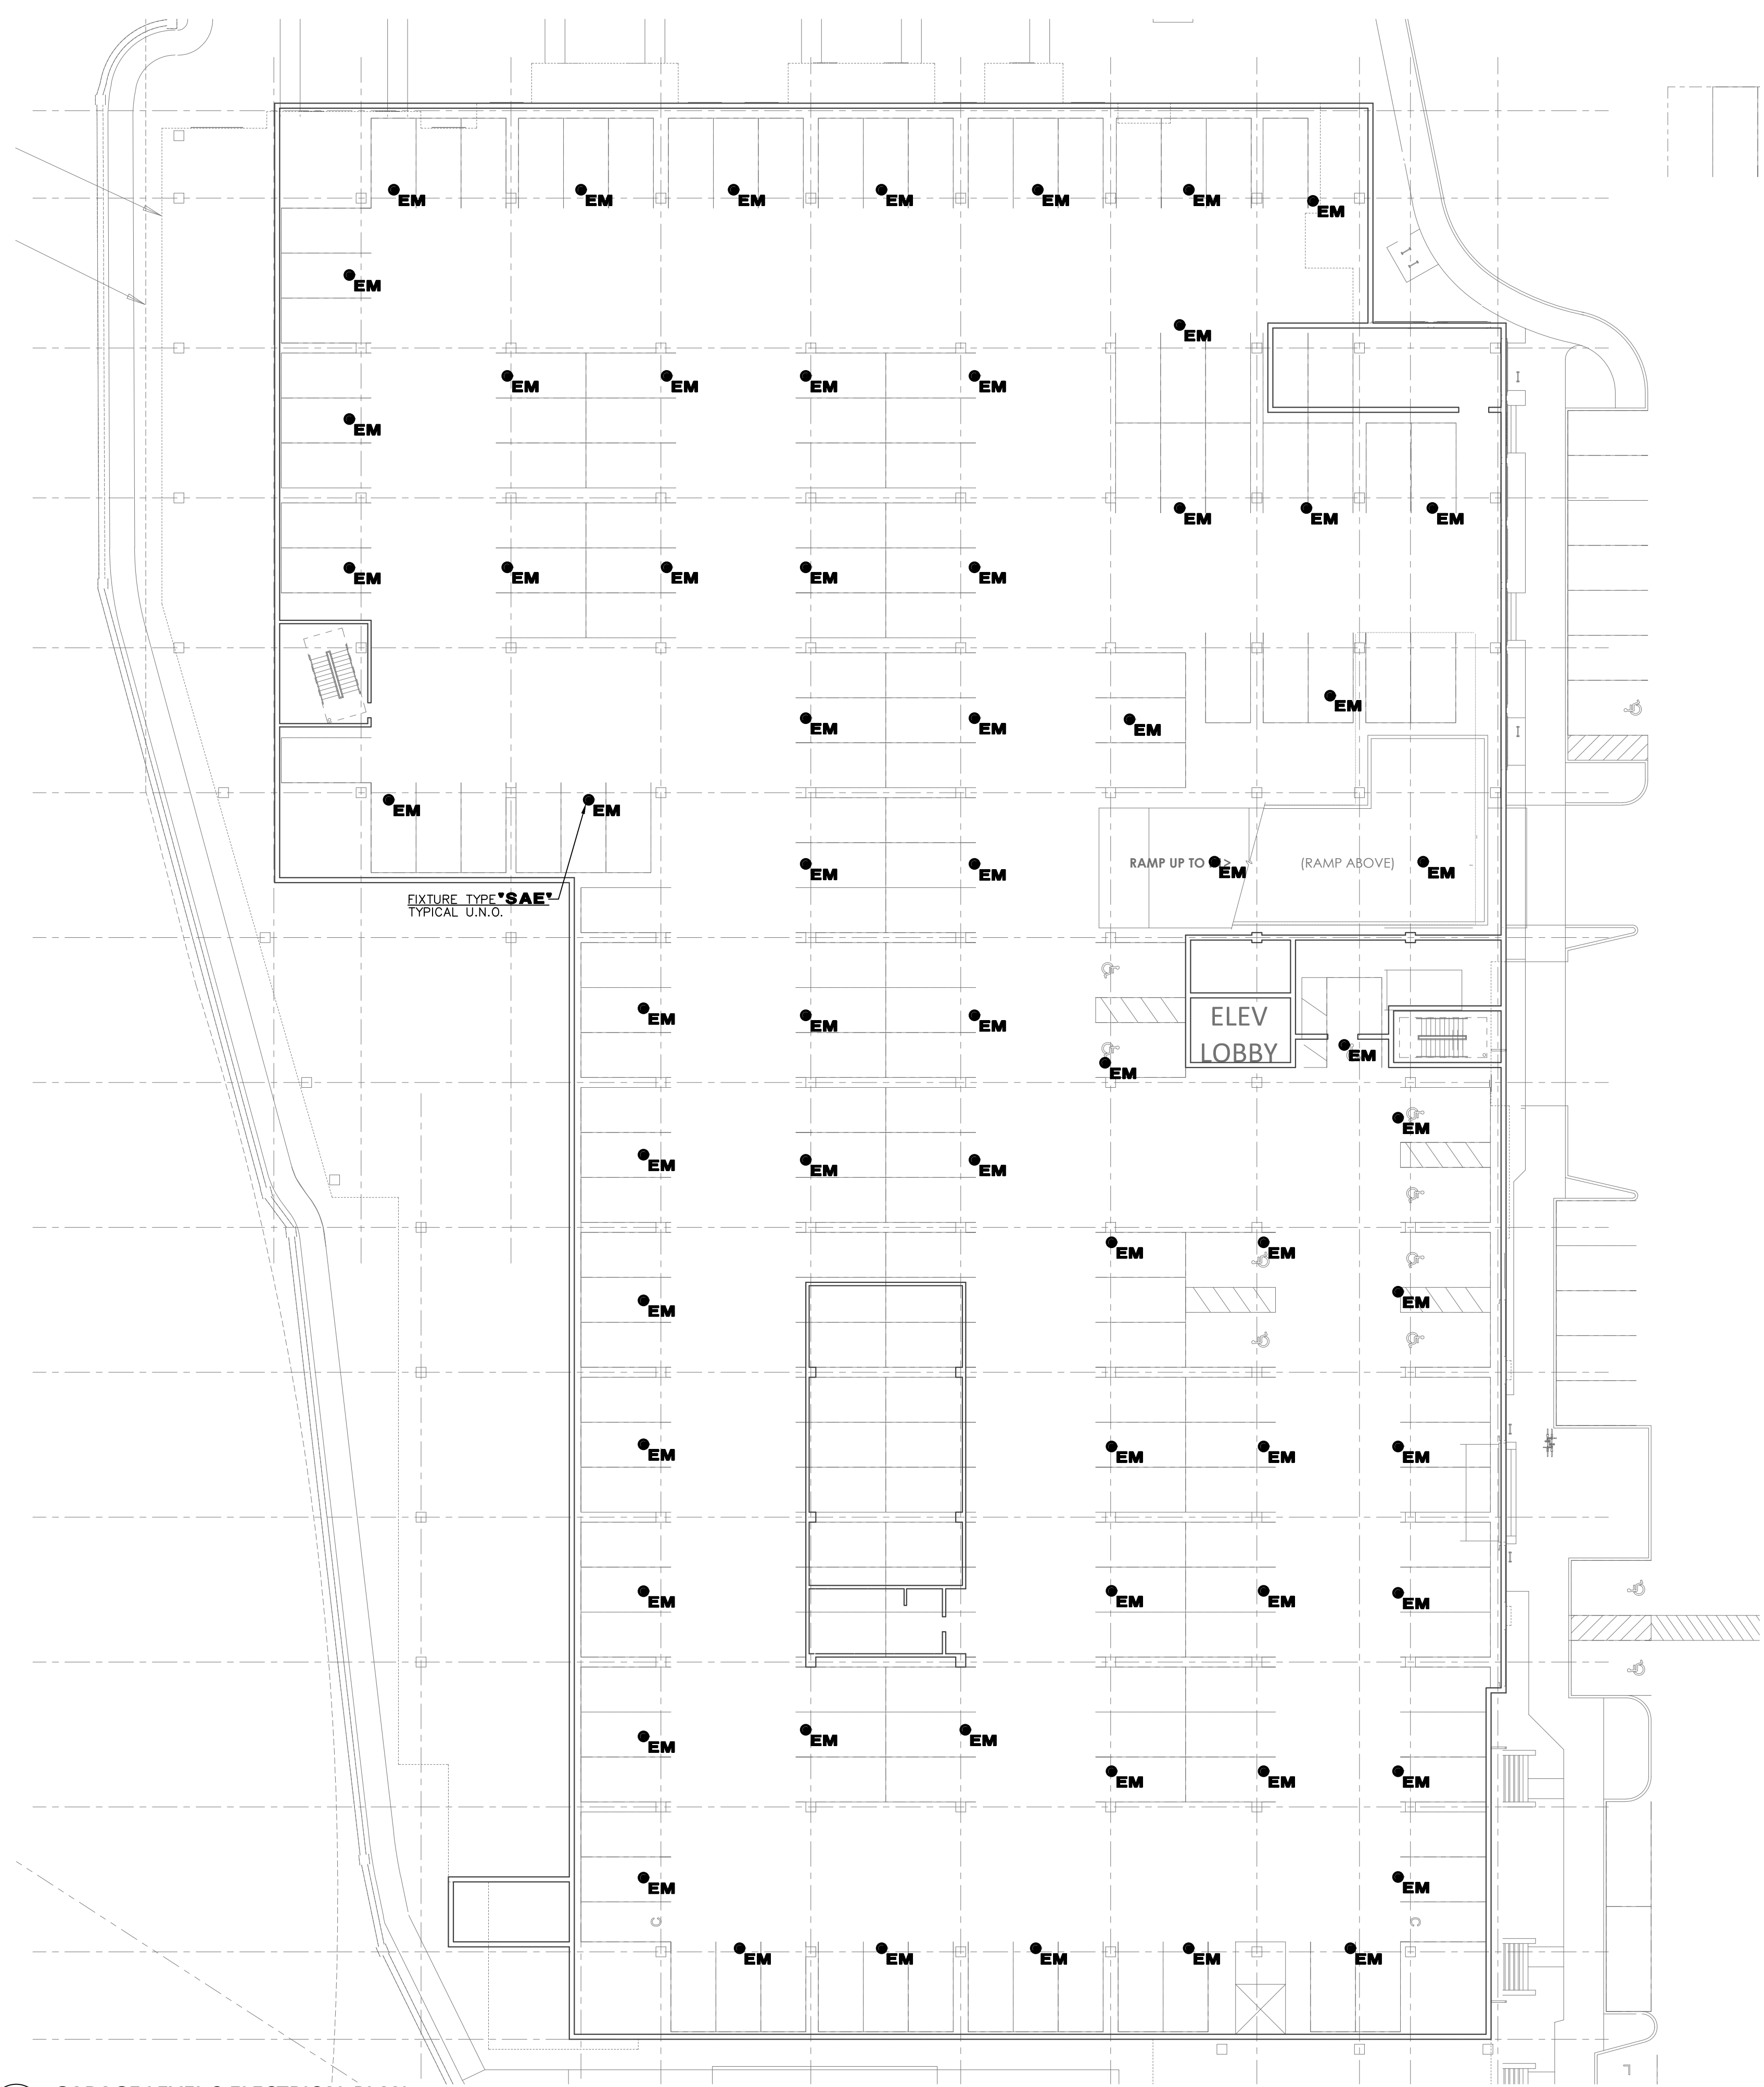

1 GARAGE LEVEL 2 ELECTRICAL PLAN  
DR1.2 1" = 20' - 0"

I hereby certify that this plan, specification, or report was prepared by me or under my direct supervision and that I am a duly licensed architect under the laws of the State of Arizona

Signature \_\_\_\_\_  
 Typed or Printed Name \_\_\_\_\_  
 License # \_\_\_\_\_ Date \_\_\_\_\_



**DRB SUBMITTAL**  
01/31/2023

REVISIONS No.	Description	Date

221564  
PROJECT NUMBER  
Author \_\_\_\_\_ Checker \_\_\_\_\_  
DRAWN BY \_\_\_\_\_ CHECKED BY \_\_\_\_\_

KEY PLAN

Gold Dust Ave &  
Scottsdale Rd  
GARAGE LEVEL 2  
ELECTRICAL PLAN

**DR1.2**

**DESIGN CODES**  
IECC, 2021 NEC, 2020

**ELECTRICAL CONTRACTOR SHALL NOTIFY DESIGNER/ENGINEER PRIOR TO ANY DEVIATION FROM THIS SET OF ELECTRICAL DESIGN PLANS. ANY CHANGES TO THE DESIGN, IF APPROVED BY ENGINEER, WILL REQUIRE REVISIONS TO PLANS AND POSSIBLE ADDITIONAL SERVICE FEE.**

**PRELIMINARY**  
**NOT FOR CONSTRUCTION**

Project Contact/Designer: **RANDY GROTHAUS**  
Project #: 23018  
**HAWKINS DESIGN GROUP INC.**  
ELECTRICAL CONSULTING ENGINEERS  
140 WEST HARVELL ROAD  
CULBERT, ARIZONA 85233  
Ph: 480.813.9000 Fax: 480.813.9001  
EMAIL: email@hawkinsdg.com

All concepts, designs and data indicated on these drawings are the sole property of the Hawkins Design Group Inc., and shall not be used for any other purpose other than originally intended without written permission of the engineer.

IF DRAWING IS NOT PLOTTED AT 24 X 36 THEY ARE NOT FULL SIZE