


PRELIMINARY  
NOT ISSUED FOR  
CONSTRUCTION

CITY OF SCOTTSDALE  
**ROUNDHOUSE, SPLASH PAD &  
SITE IMPROVEMENTS**  
7301 E. Indian Bend Road  
Scottsdale AZ 85250



| REVISIONS |             |      |
|-----------|-------------|------|
| No.       | Description | Date |


DESIGN  
DEVELOPMENT  
COPYRIGHT 2023  
DWL ARCHITECTS + PLANNERS, INC.

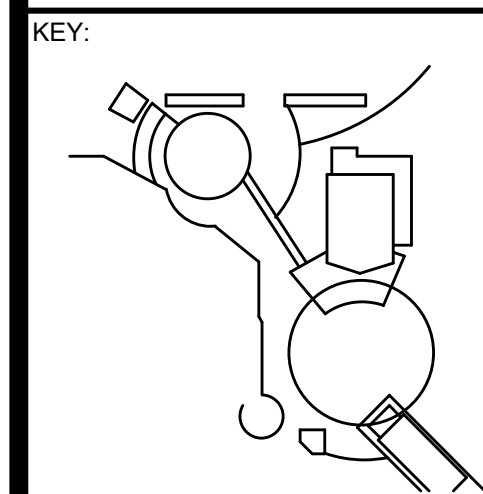

SHEET TITLE:  
**SITE LIGHTING  
PLAN**

SHEET NUMBER:  
**50.0**

|                    |                            |
|--------------------|----------------------------|
| DRAWN BY:<br>MLL   | REVIEWED BY:<br>JPS        |
| DATE:<br>4/28/2023 | PROJECT NUMBER:<br>1939.00 |

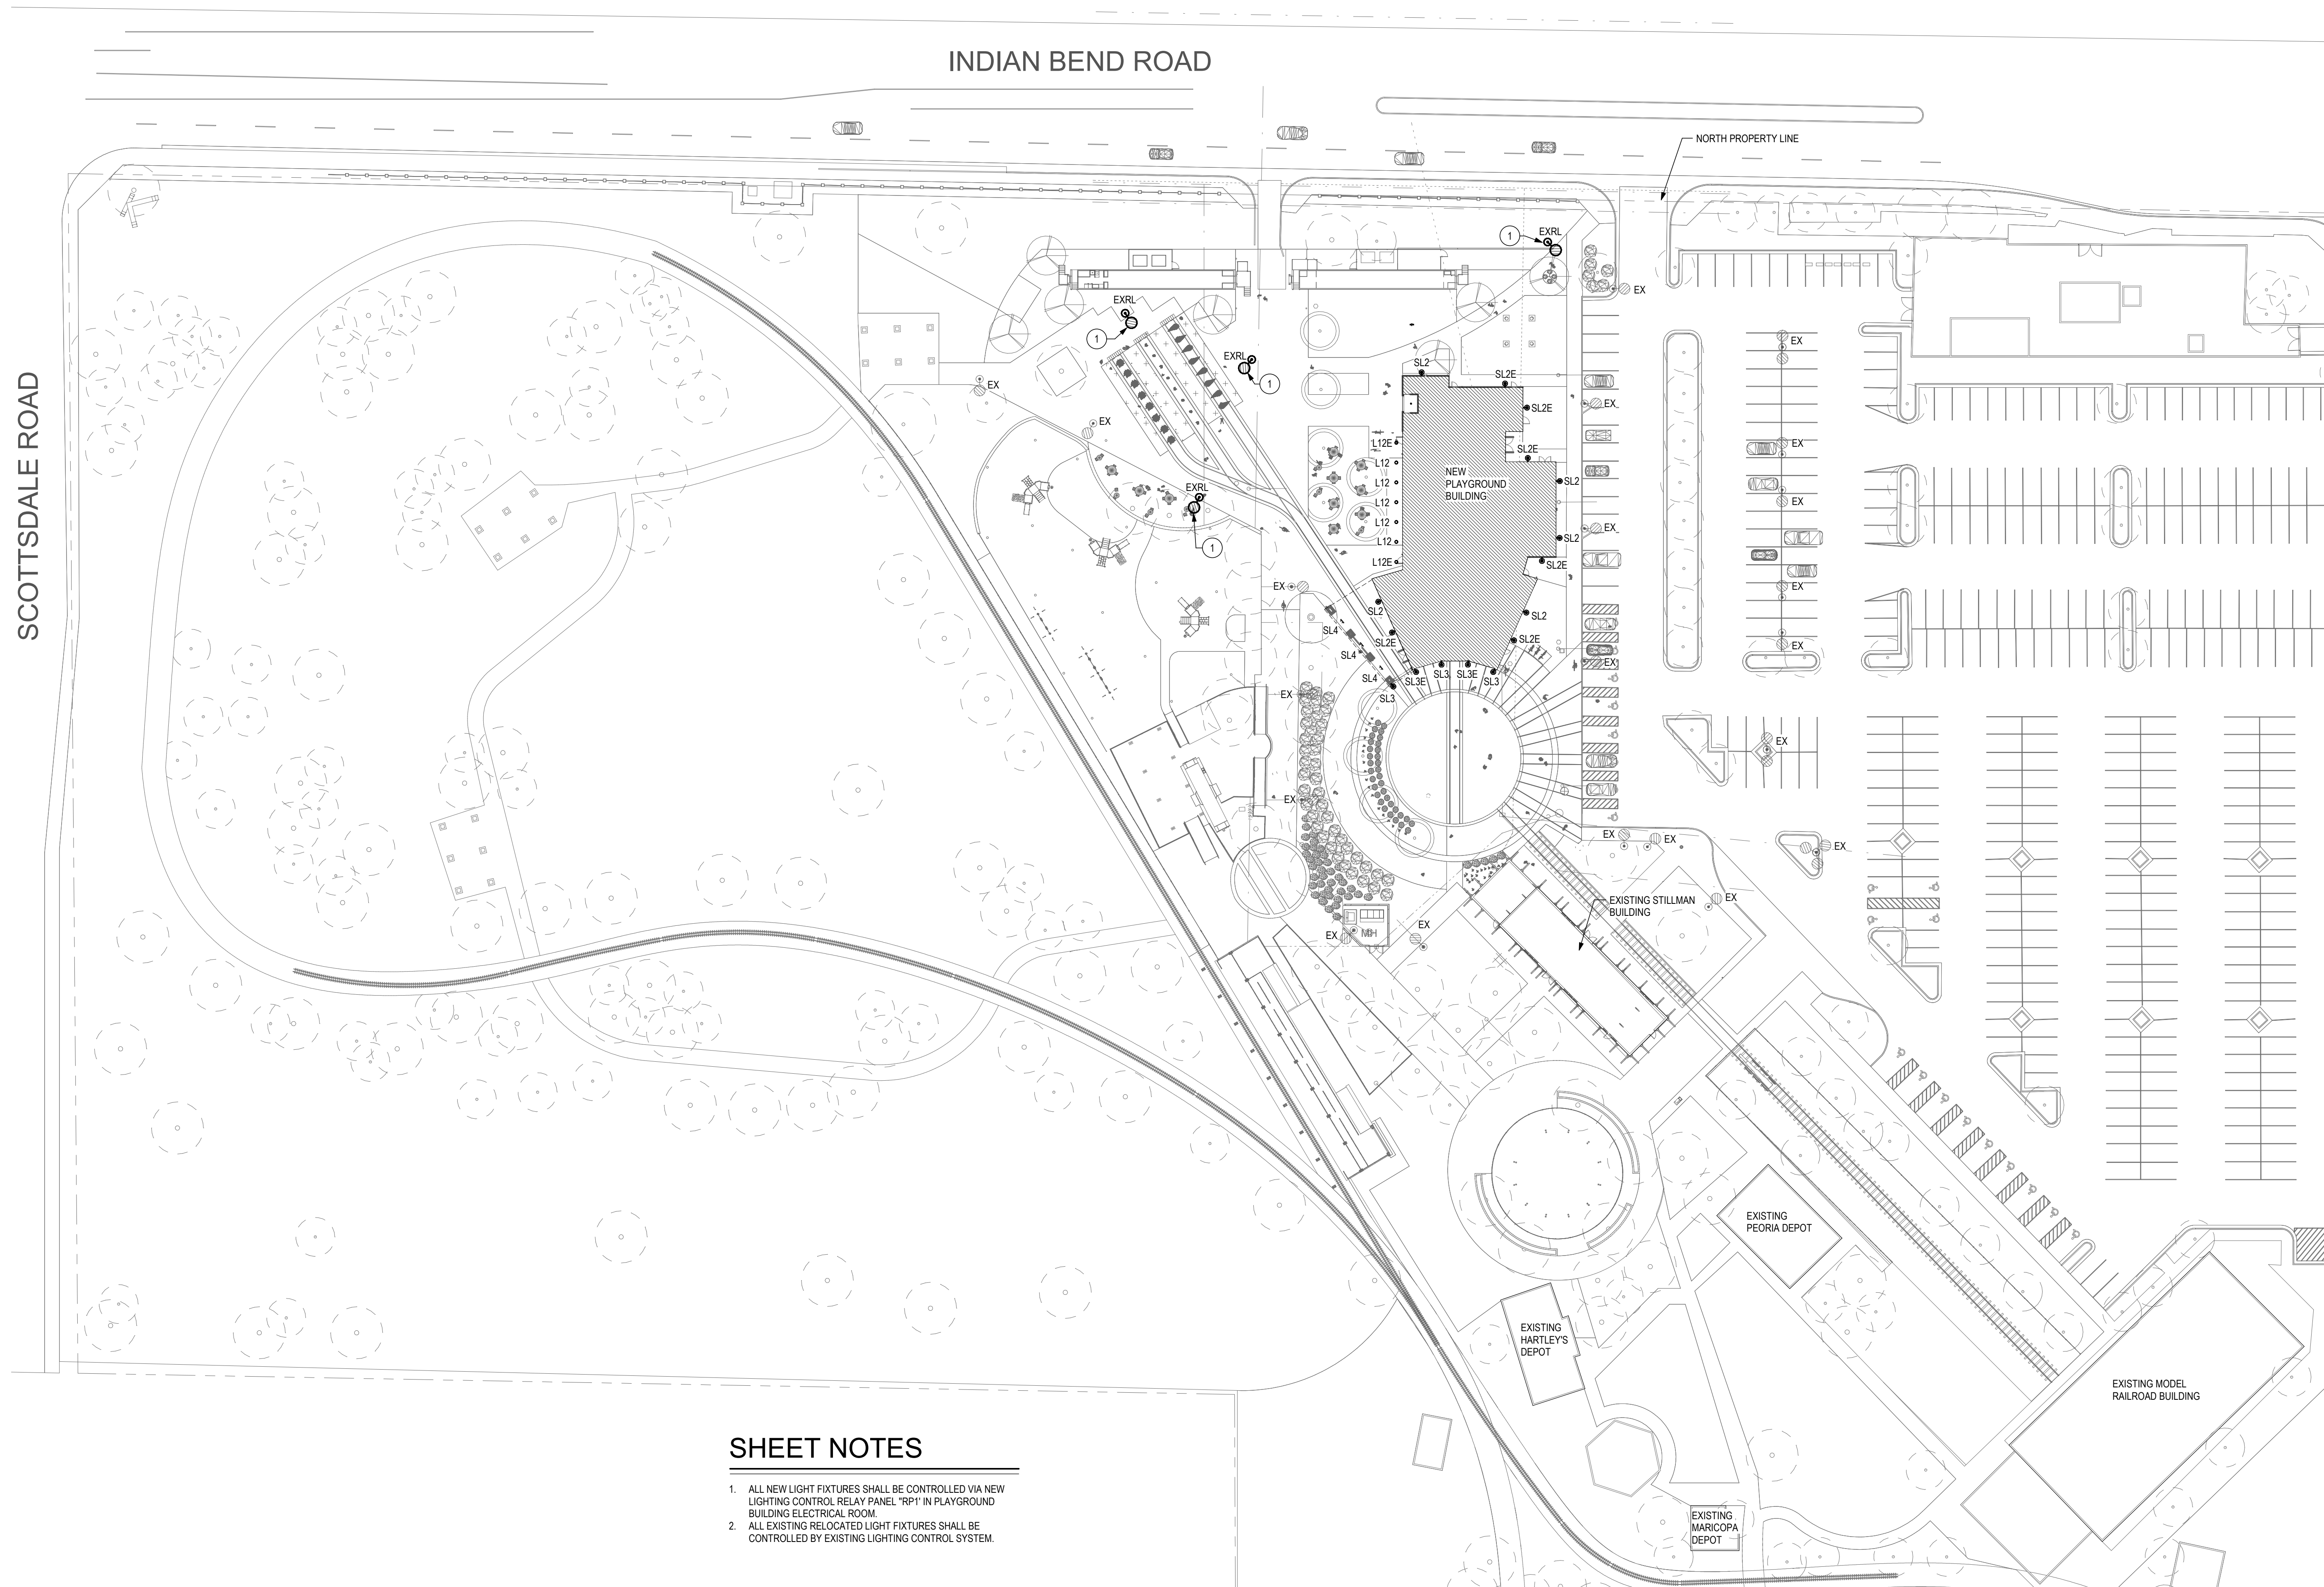

**SHEET NOTES**

1. ALL NEW LIGHT FIXTURES SHALL BE CONTROLLED VIA NEW LIGHTING CONTROL RELAY PANEL "RP1" IN PLAYGROUND BUILDING ELECTRICAL ROOM.
2. ALL EXISTING RELOCATED LIGHT FIXTURES SHALL BE CONTROLLED BY EXISTING LIGHTING CONTROL SYSTEM.

**1 ELECTRICAL SITE LIGHTING PLAN**  
1" = 40'-0"

