



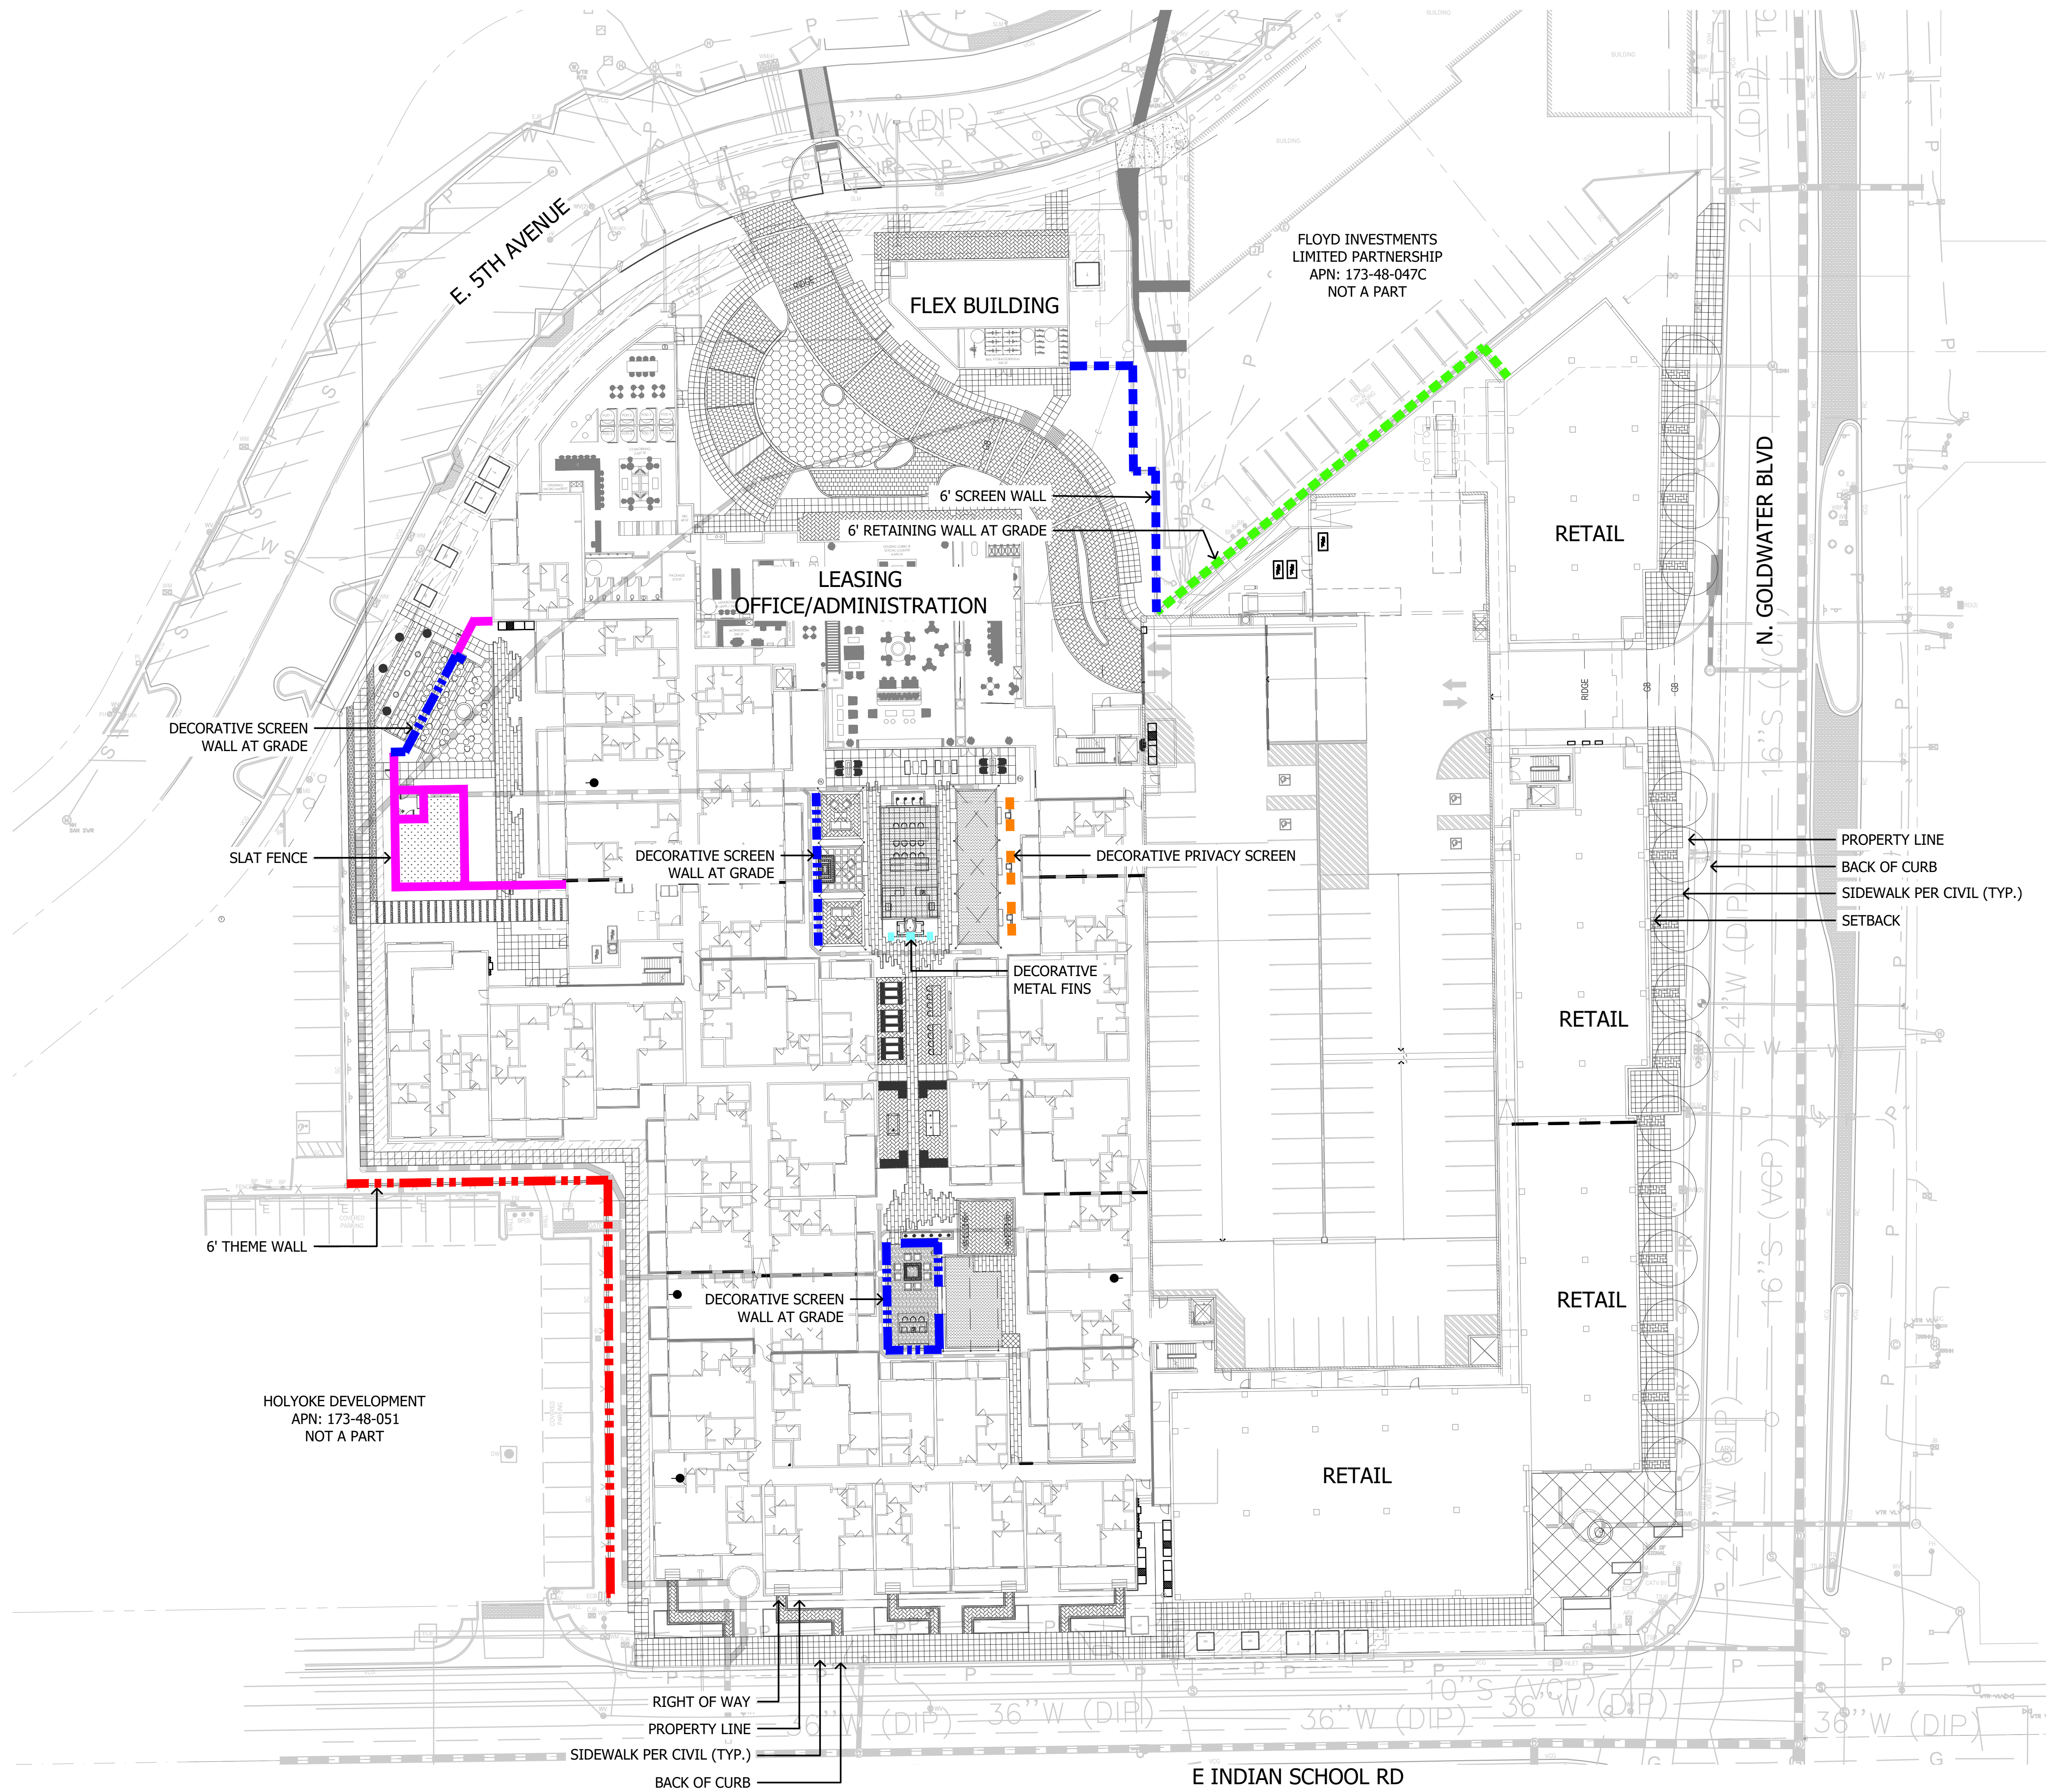

LEVEL 1 WALL LEGEND		
SYMBOL	DESCRIPTION	QTY.
[Pink dashed line]	SLAT FENCE	210 LF
[Orange dashed line]	DECORATIVE PRIVACY SCREEN	36 LF
[Blue dashed line]	DECORATIVE SCREEN WALL AT GRADE	198 LF
[Red dashed line]	6' THEME WALL	245 LF
[Cyan dashed line]	DECORATIVE METAL FINIS	16 LF
[Green dashed line]	6' RETAINING WALL AT GRADE	166 LF
[Dark blue dashed line]	6' SCREEN WALL	119 LF



- GENERAL WALL NOTES
1. QUANTITIES SHOWN ARE FOR BIDDING AND PERMITTING PURPOSES ONLY, CONTRACTOR TO VERIFY.
 2. QUANTITIES SHOWN FOR TOTAL LENGTHS OF ALL WALL PLAN SHEETS
 3. ALL WALLS, RETURNS, COLUMNS AND MONUMENTS ARE SHOWN GRAPHICALLY AND DO NOT REPRESENT ACTUAL SIZE.

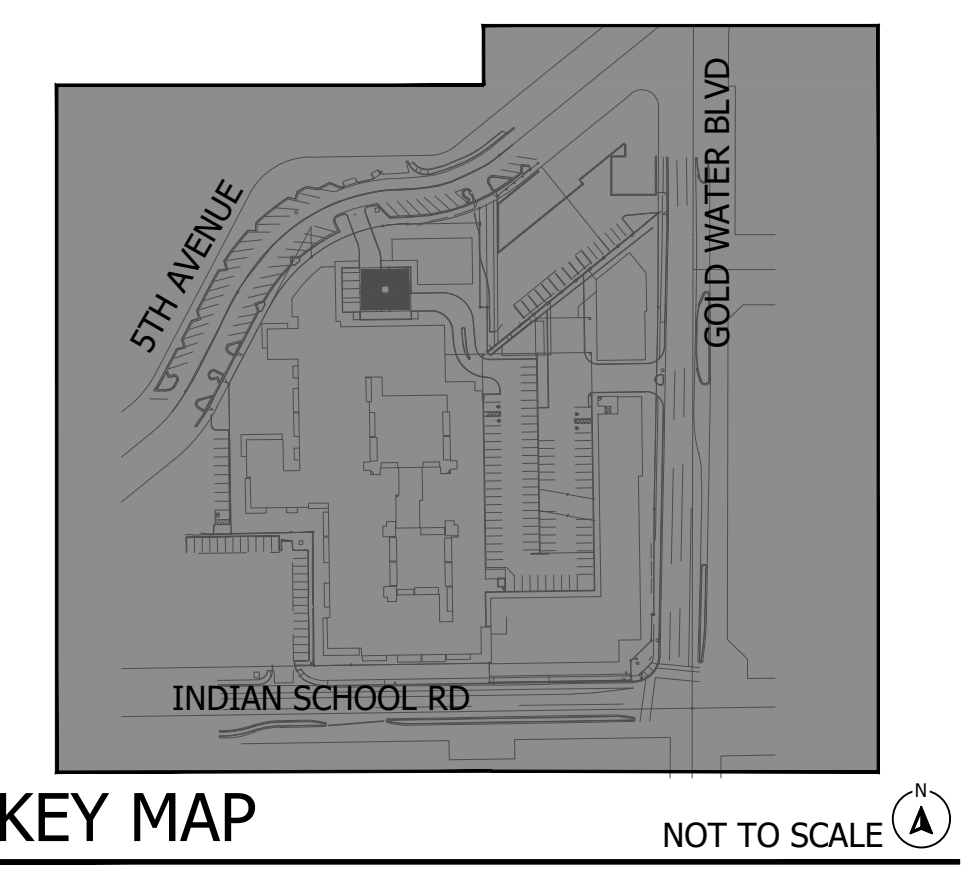


LEVEL 5 WALL LEGEND		
SYMBOL	DESCRIPTION	QTY.
	GLASS POOL BARRIER ON RETAINING WALL AT PODIUM	195 LF
	GLASS POOL BARRIER AT PODIUM DECK	70 LF
	LOW RETAINING WALL AT PODIUM	94 LF
	DECORATIVE SCREEN WALL AT PODIUM	39 LF
	TV WALL AT PODIUM DECK	13 LF

GENERAL WALL NOTES


- QUANTITIES SHOWN ARE FOR BIDDING AND PERMITTING PURPOSES ONLY, CONTRACTOR TO VERIFY.
- QUANTITIES SHOWN FOR TOTAL LENGTHS OF ALL WALL PLAN SHEETS
- ALL WALLS, RETURNS, COLUMNS AND MONUMENTS ARE SHOWN GRAPHICALLY AND DO NOT REPRESENT ACTUAL SIZE.

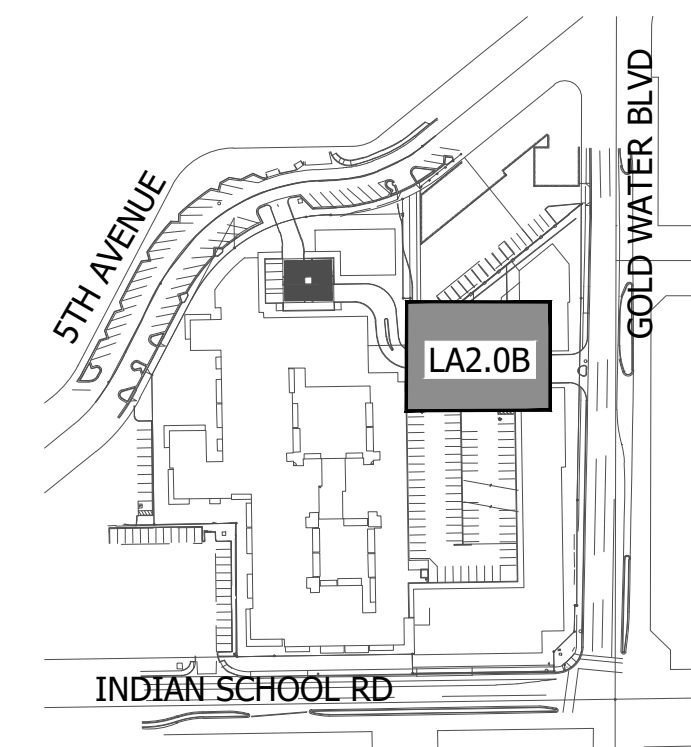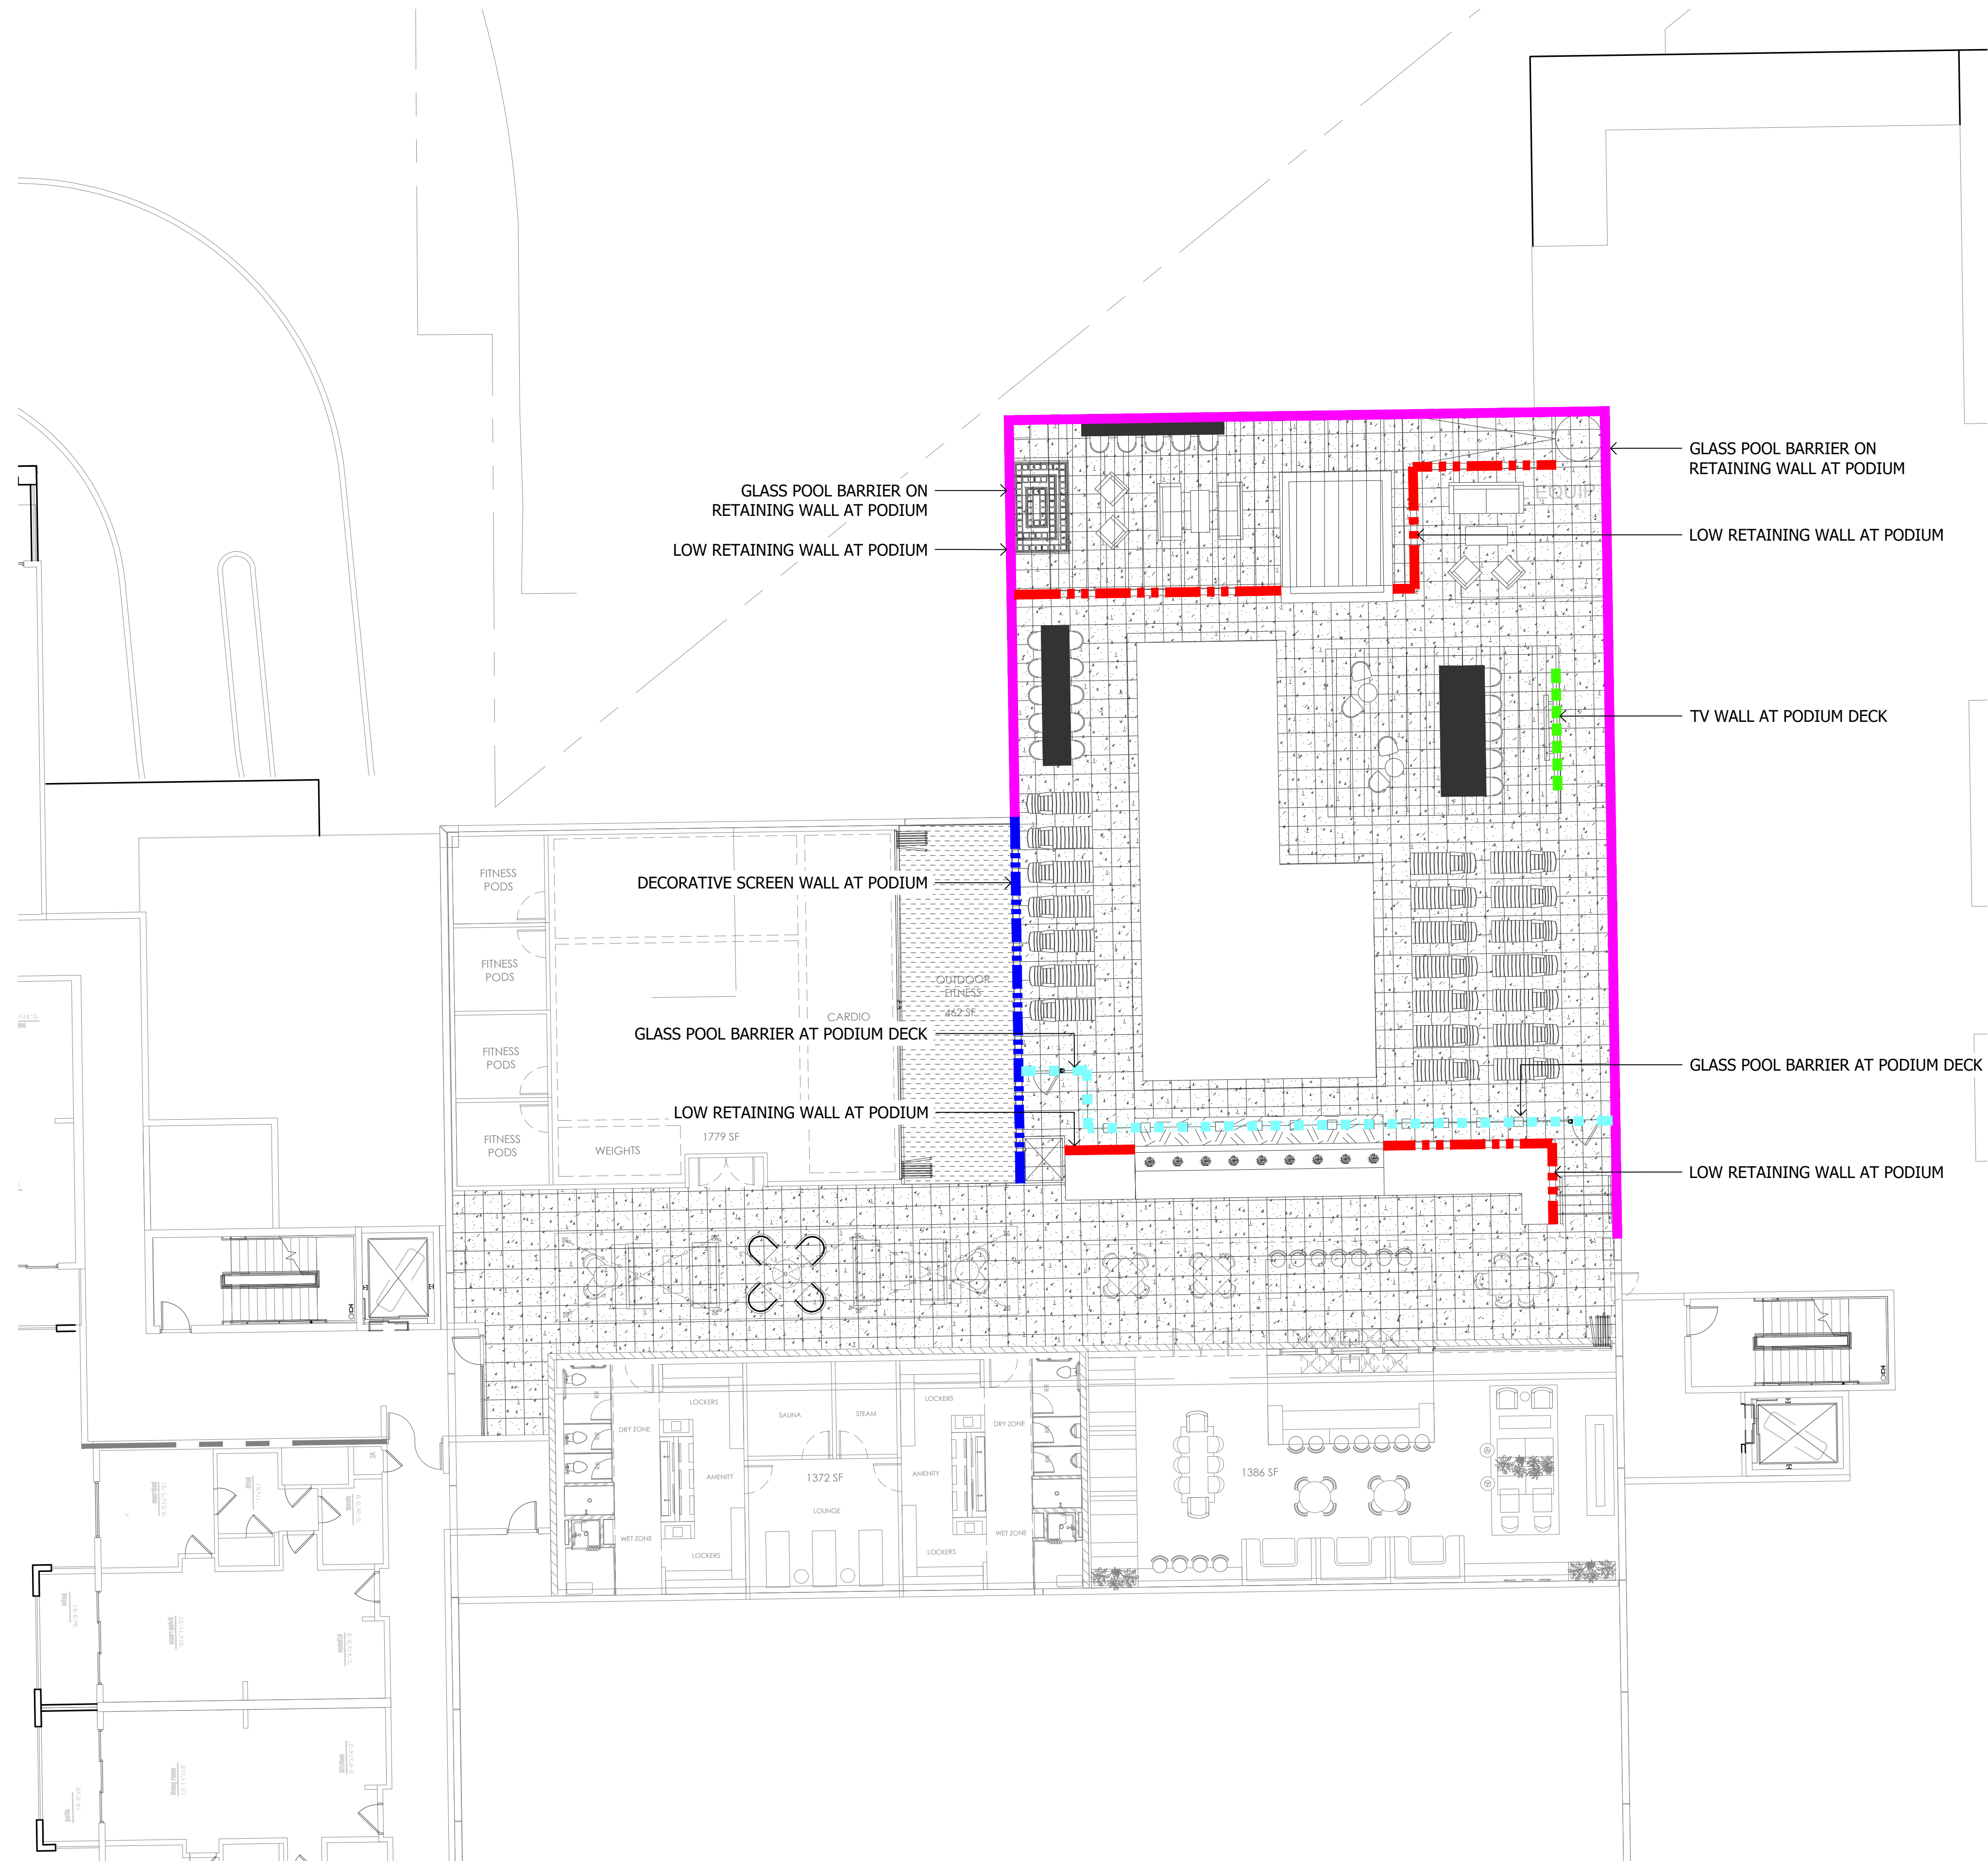

KEY MAP NOT TO SCALE

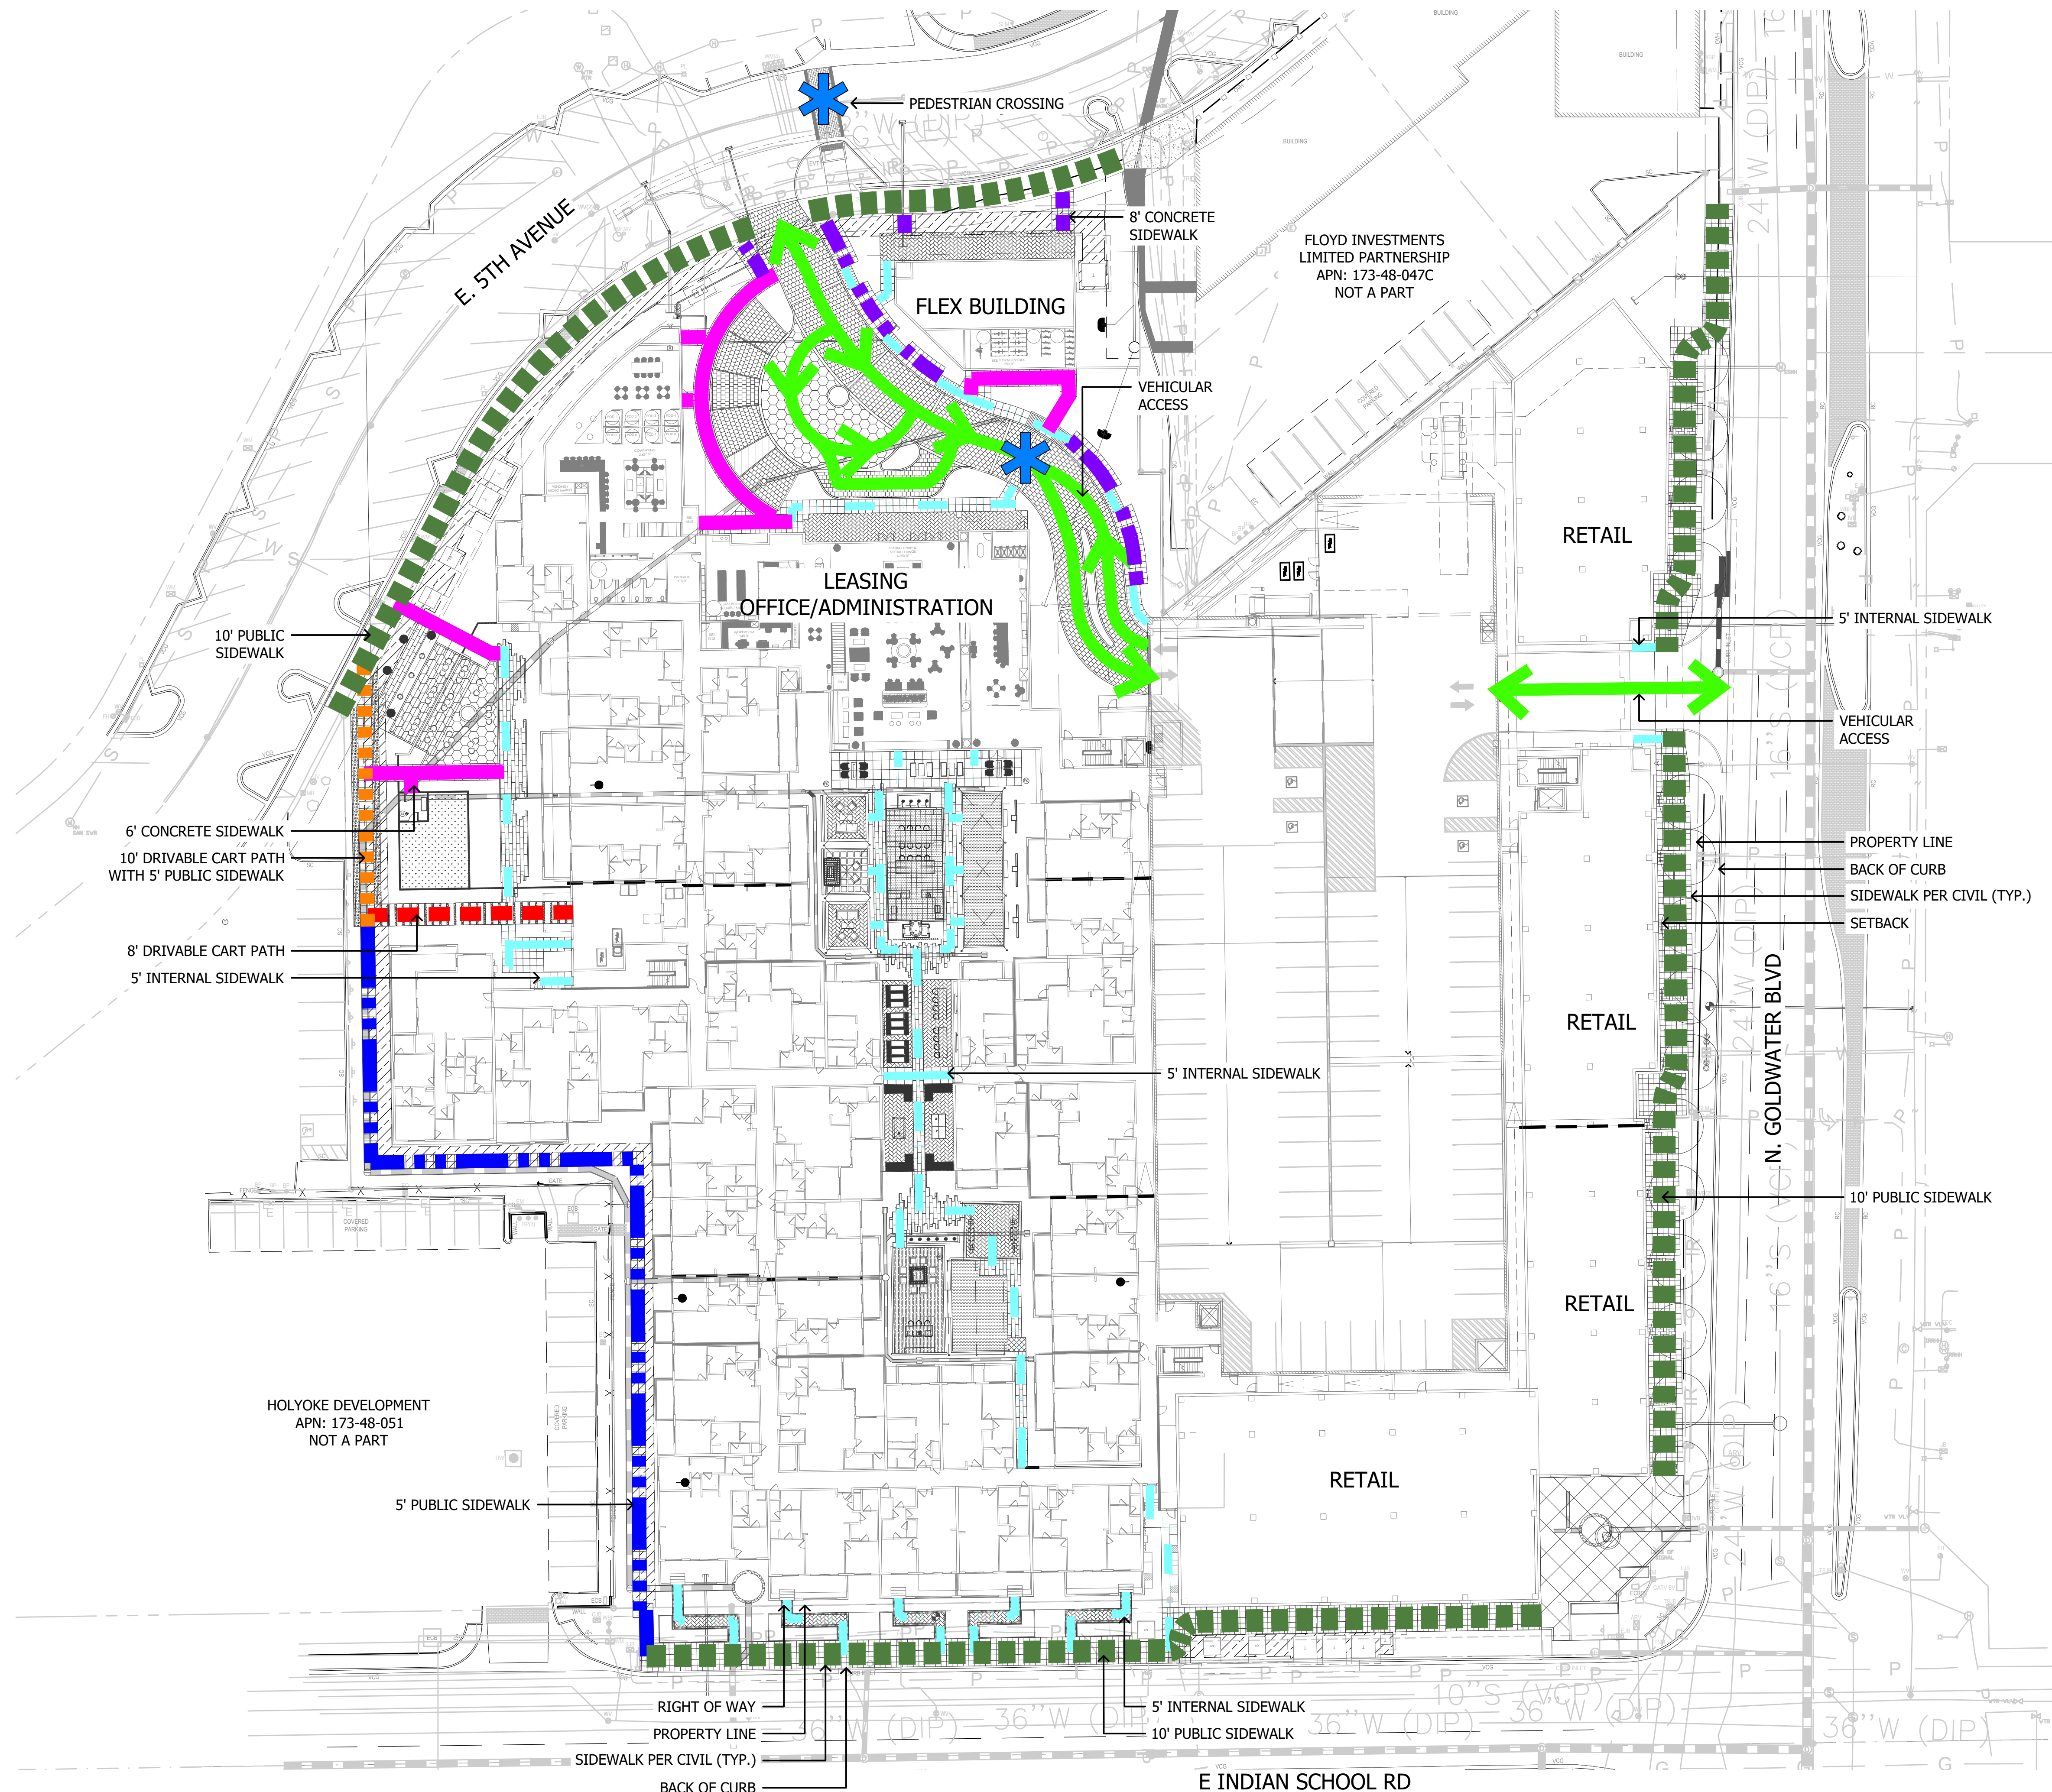



SYMBOL	DESCRIPTION
	10' PUBLIC SIDEWALK
	5' PUBLIC SIDEWALK
	6' CONCRETE SIDEWALK
	8' CONCRETE SIDEWALK
	8' DRIVABLE CART PATH
	5' INTERNAL SIDEWALK
	PEDESTRIAN CROSSING
	VEHICULAR ACCESS
	10' DRIVABLE CART PATH WITH 5' PUBLIC SIDEWALK

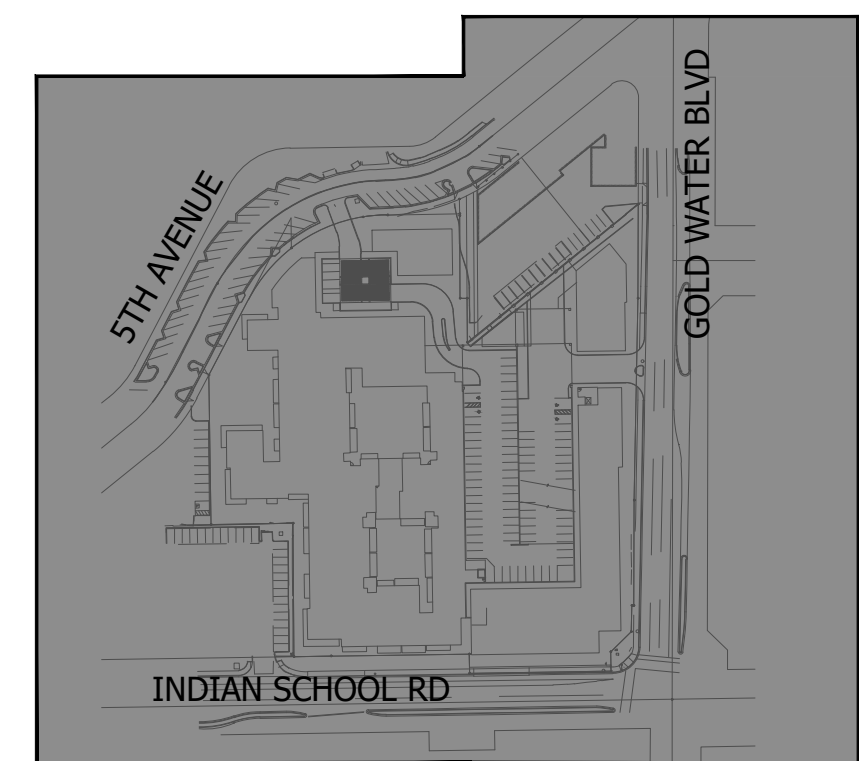

KEY MAP NOT TO SCALE

 

SITE AREA	
NET	4.82 ac (209,959 S.F.)
REQUIRED OPEN SPACE	
D/OC-2 PBD DO ZONING	
NO MINIMUM OPEN SPACE REQUIREMENT	
TOTAL REQUIRED OPEN SPACE	0 S.F.
PROVIDED OPEN SPACE:	70,676 S.F. (±34%)
REQUIRED FRONTAGE OPEN SPACE	
D/OC-2 PBD DO ZONING	
NO MINIMUM OPEN SPACE REQUIREMENT	
TOTAL REQUIRED FRONTAGE SPACE	0 S.F.
PROVIDED FRONTAGE OPEN SPACE:	±20,629 S.F.
LEGEND	
	COMMON OPEN SPACE
	FRONTAGE OPEN SPACE

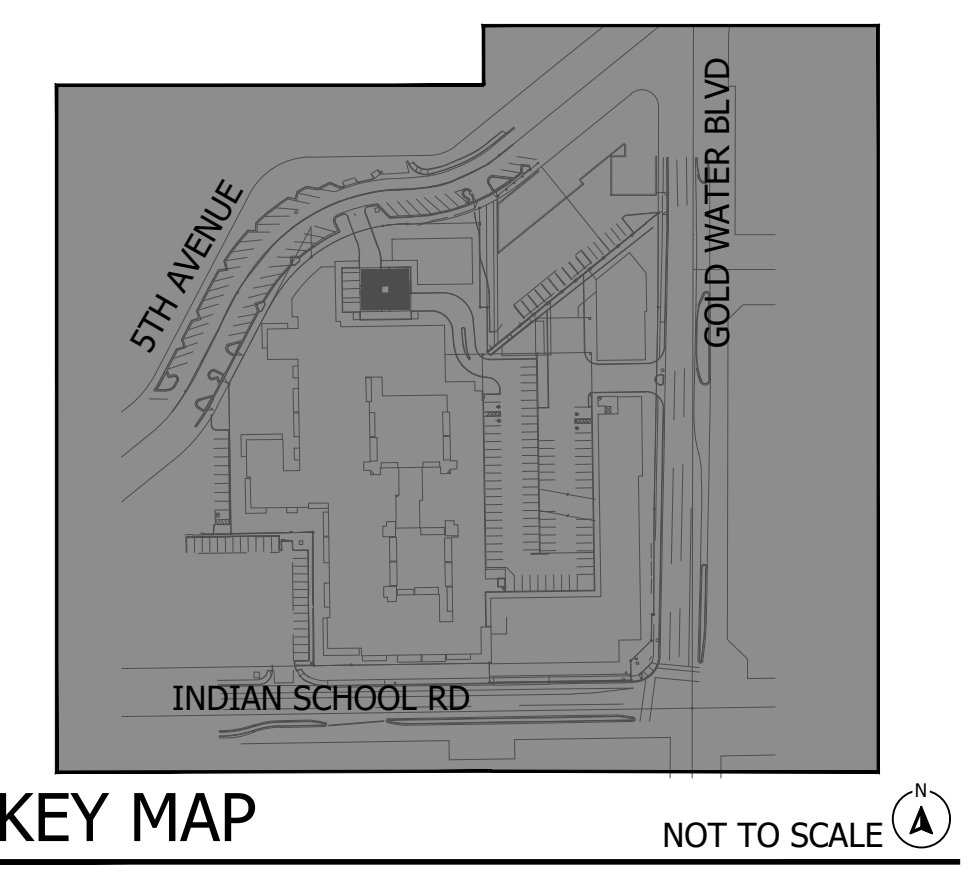

KEYNOTES

- 1 LANDSCAPE AREA WITH DECOMPOSED GRANITE

2 CONCRETE SIDEWALK

3 CONCRETE HEADER

4 CONCRETE PAD

5 LINEAR PAVERS

6 HERRINGBONE PAVERS

7 SOLDIER COURSE PAVER BORDER

8 2'X2' SCORED CONCRETE

9 2'X2' CONCRETE PAVERS

10 2' OCTAGON PAVERS

11 PAVERS AT RETAIL PATIO

12 DRIVABLE GRAVEL PAVE

13 PAVING AT TRASH ENTRY DRIVE

14 TURF

15 WOOD DECK

16 PODIUM DECK PAVERS

17 ARTIFICIAL TURF AT GRADE

18 ARTIFICIAL TURF AT PODIUM

19 ADA RAMP

20 DECORATIVE PAVING AT PLAZA

21 CONCRETE STAIRS AT GRADE

22 CONCRETE STAIRS AT PODIUM

23 SLAT FENCE

24 SLAT FENCE GATE

25 DECORATIVE PRIVACY SCREEN

26 DECORATIVE SCREEN WALL AT GRADE

27 DECORATIVE SCREEN WALL AT PODIUM

28 LOW RETAINING WALL AT GRADE

29 LOW RETAINING WALL AT PODIUM

30 GLASS POOL BARRIER AT PODIUM DECK

31 GLASS POOL BARRIER ON RETAINING WALL AT PODIUM DECK

32 DECORATIVE METAL FINS

33 20'X40' SHADE STRUCTURE AT OUTDOOR KITCHEN

34 20'X20' SHADE STRUCTURE AT PORCH SWING NODE

35 PORCH SWING

36 11'X13' CANTILEVER SHADE STRUCTURE AT WOOD DECK

37 18'X36' SHADE STRUCTURE AT PUBLIC PLAZA

38 18'X36' SHADE STRUCTURE AT PODIUM DECK

39 18'X25' SHADE STRUCTURE AT PODIUM DECK

40 OUTDOOR FIREPLACE AT GRADE

41 OUTDOOR FIREPLACE AT PODIUM DECK

42 COMMUNITY FIRE PIT AT WOOD DECK

43 CREDENZA

44 CONCRETE TABLE AT OUTDOOR KITCHEN

45 SEATING ISLAND AT OUTDOOR KITCHEN

46 SEATING ISLAND AT CANTILEVER SHADE STRUCTURE

47 SEATING ISLAND AT PODIUM DECK

48 BBQ AT OUTDOOR KITCHEN

49 WATER FEATURE AT COURTYARD A

50 WATER FEATURE AT COURTYARD B

51 FESTOON LIGHTS

52 BBQ AT OUTDOOR KITCHEN

53 PIZZA OVEN AT OUTDOOR KITCHEN

54 PORCH SWING AT COURTYARD B
- 55 RECTANGULAR CONCRETE BENCH

56 ROUND CONCRETE BENCH AT PUBLIC PLAZA

57 METAL BENCH

58 STEEL HEADER PLANTER

59 RAISED PLANTER AT OUTDOOR CORRIDOR

60 ROUND RAISED PLANTER AT PLAZA

61 PORTRAIT ART AT OUTDOOR COORIDOR

62 POOL TABLE AT OUTDOOR CORRIDOTR

63 PING PONG TABLE AT OUTDOOR COORIDOR

64 BAR TOP AT OUTDOOR CORRIDOR

65 TV WALL AT OUTDOOR CORRIDOR

66 TV WALL AT PODIUM DECK

67 FIREPIT

68 RIM FLOW POOL

69 RAISED SPA

70 NEGATIVE EDGE WATER FEATURE AT PODIUM DECK

71 DECORATIVE GLASS PLANTER AT PODIUM

72 WHEELCHAIR LIFT AT PODIUM

73 HIGHTOP AT PODIUM DECK

74 PUBLIC ART

75 FURNITURE BY OTHERS

76 ENTRY DRIVE AT 5TH AVE

77 CONCRETE TABLE AT PODIUM DECK

78 PORTRAIT ART AT OUTDOOR CORRIDOR



79 RUG AT OUTDOOR CORRIDOR

80 FIRE PIT & SPA CONTROLS

81 6'-0" RETAINING WALL AT GRADE

82 6'-0" SCREEN WALL

83 6'-0" THEME WALL

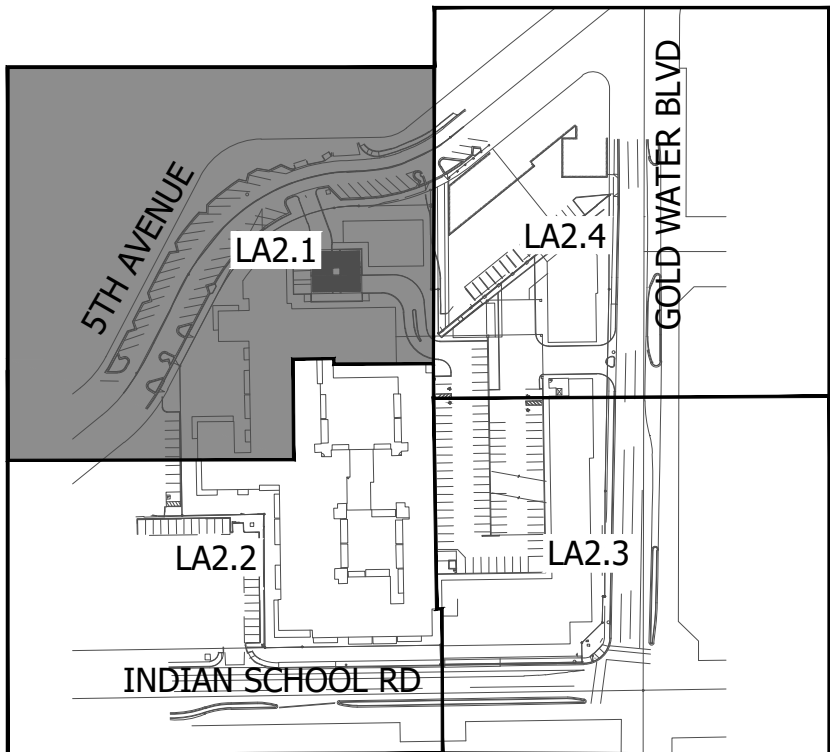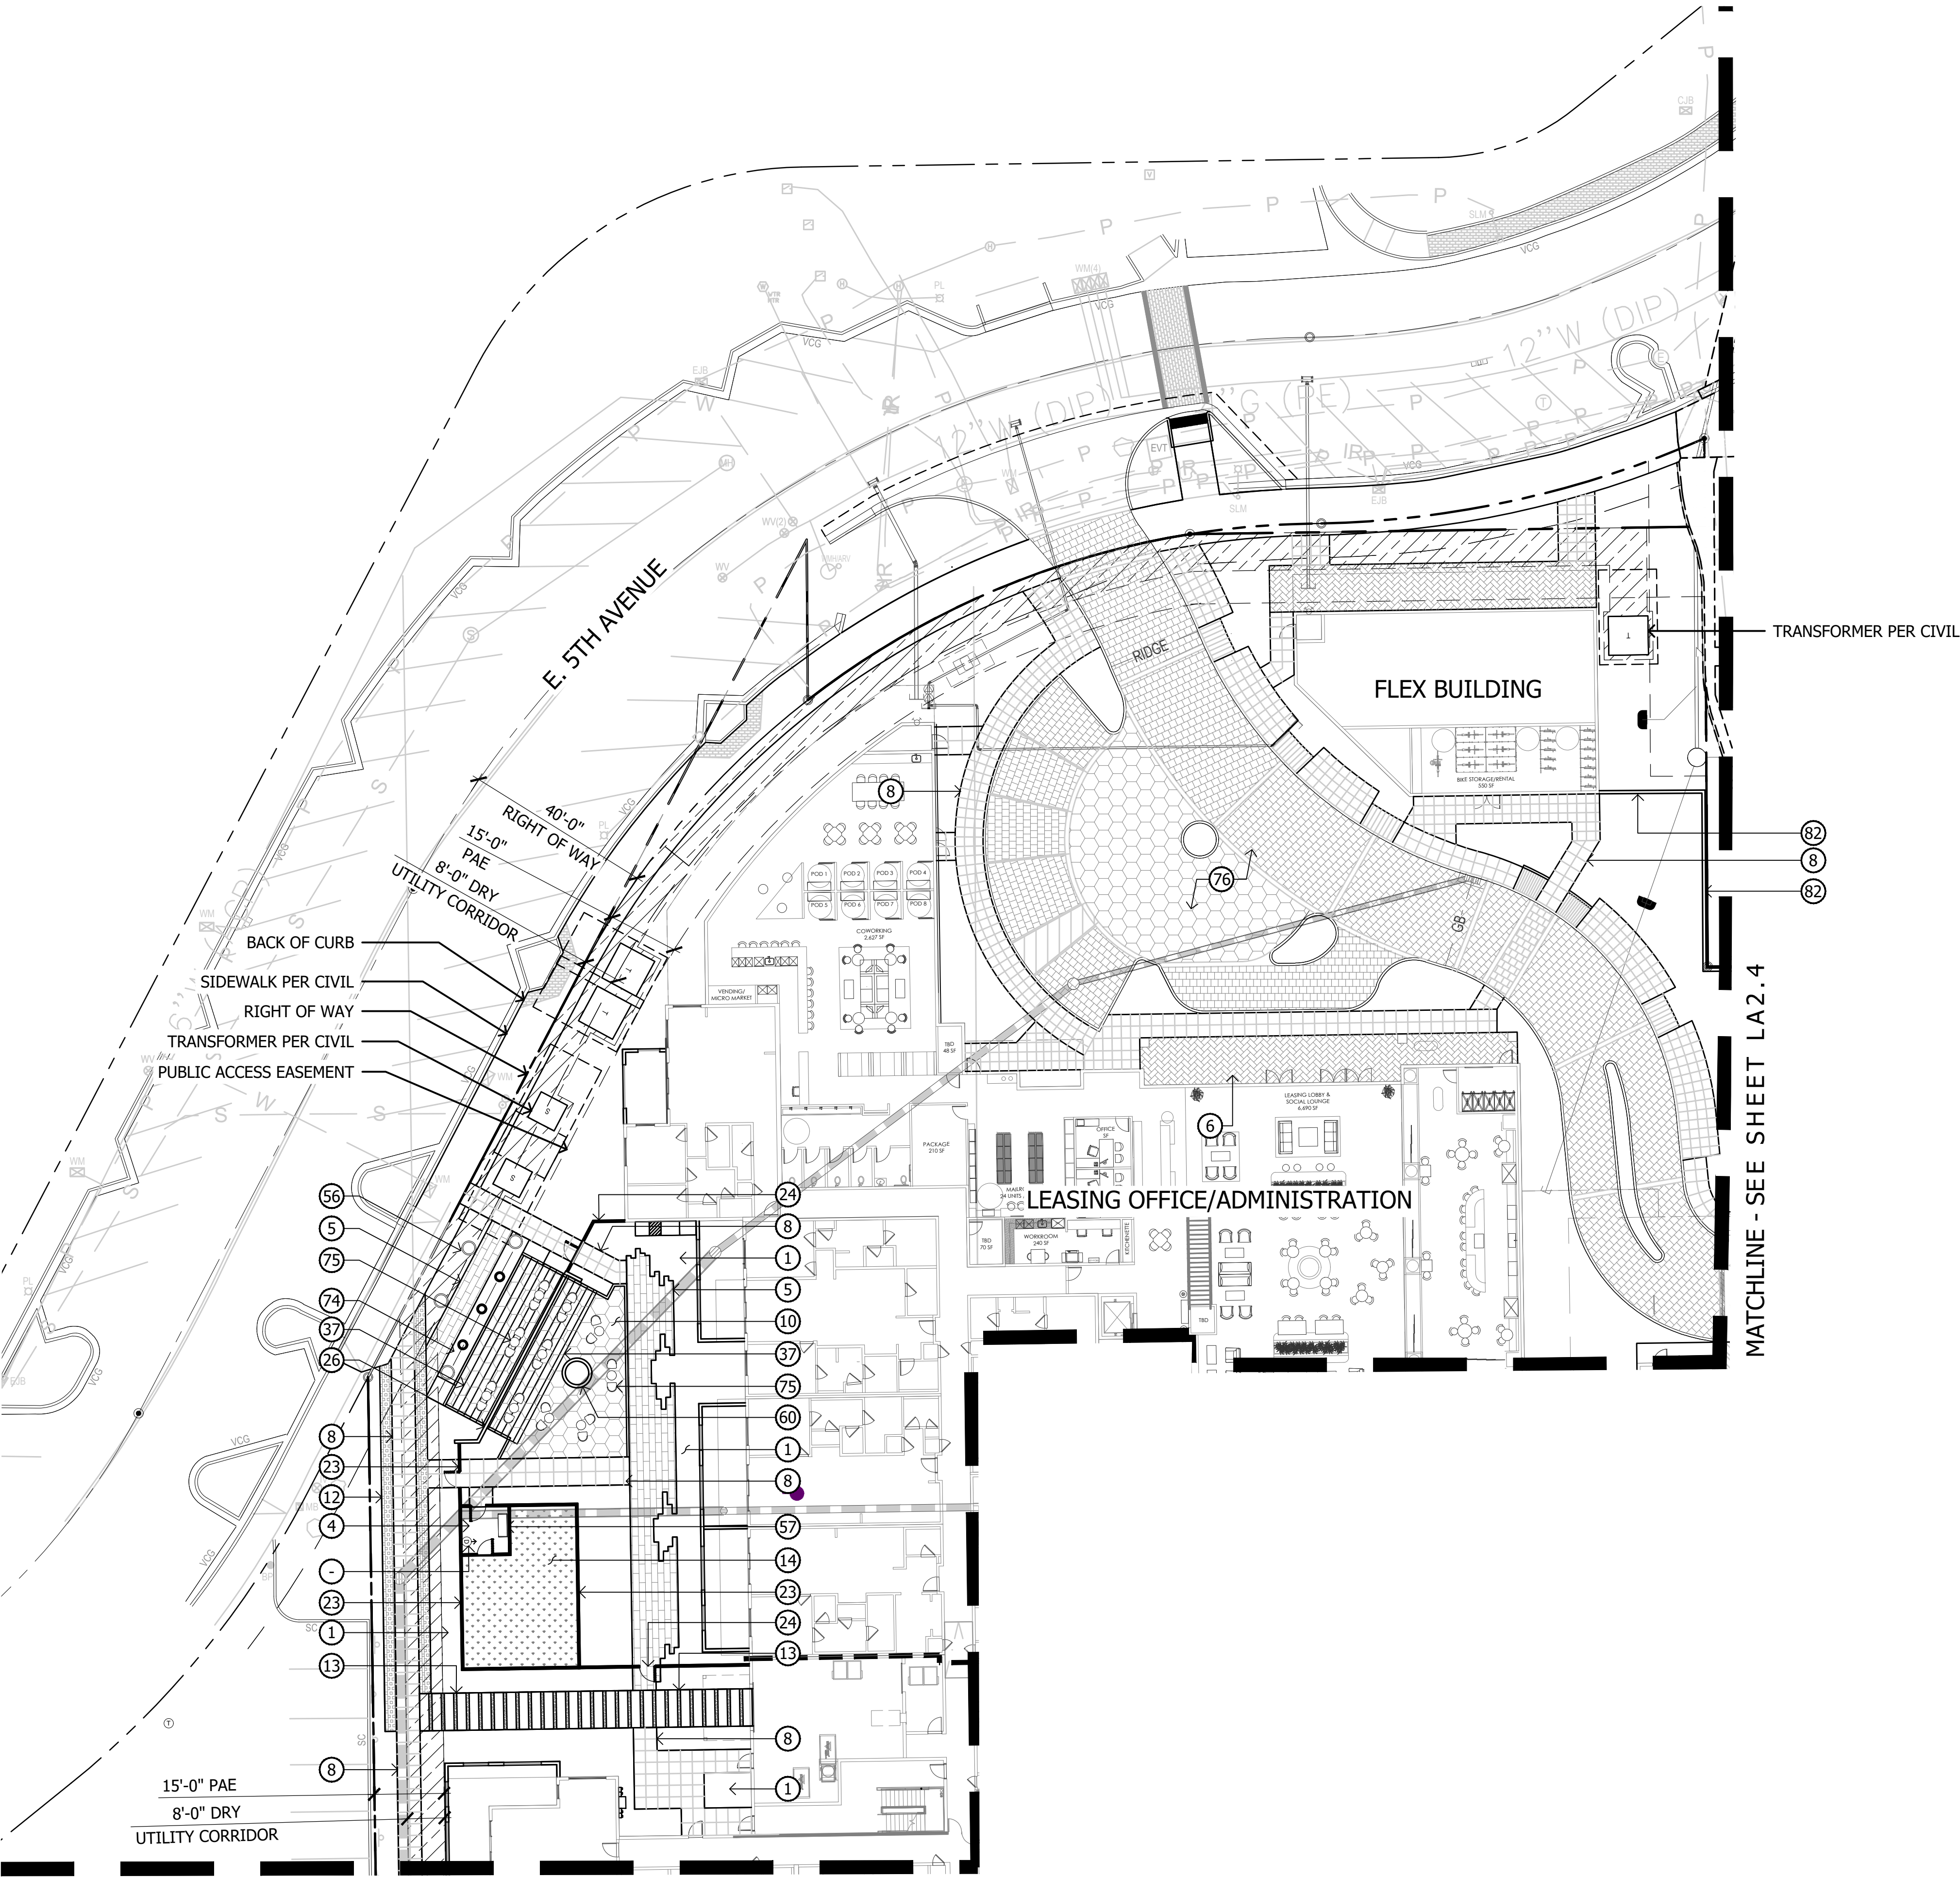

KEY MAP

NOT TO SCALE



5TH & GOLDWATER
LA2.1 - Hardscape Plan




ABLASTUDIO.COM




5TH AVENUE PARTNERS LLC/
EQUITABLE HOME MORTGAGE INC
APN: 173-48-050B
NOT A PART

HOLYOKE DEVELOPMENT
APN: 173-48-051
NOT A PART

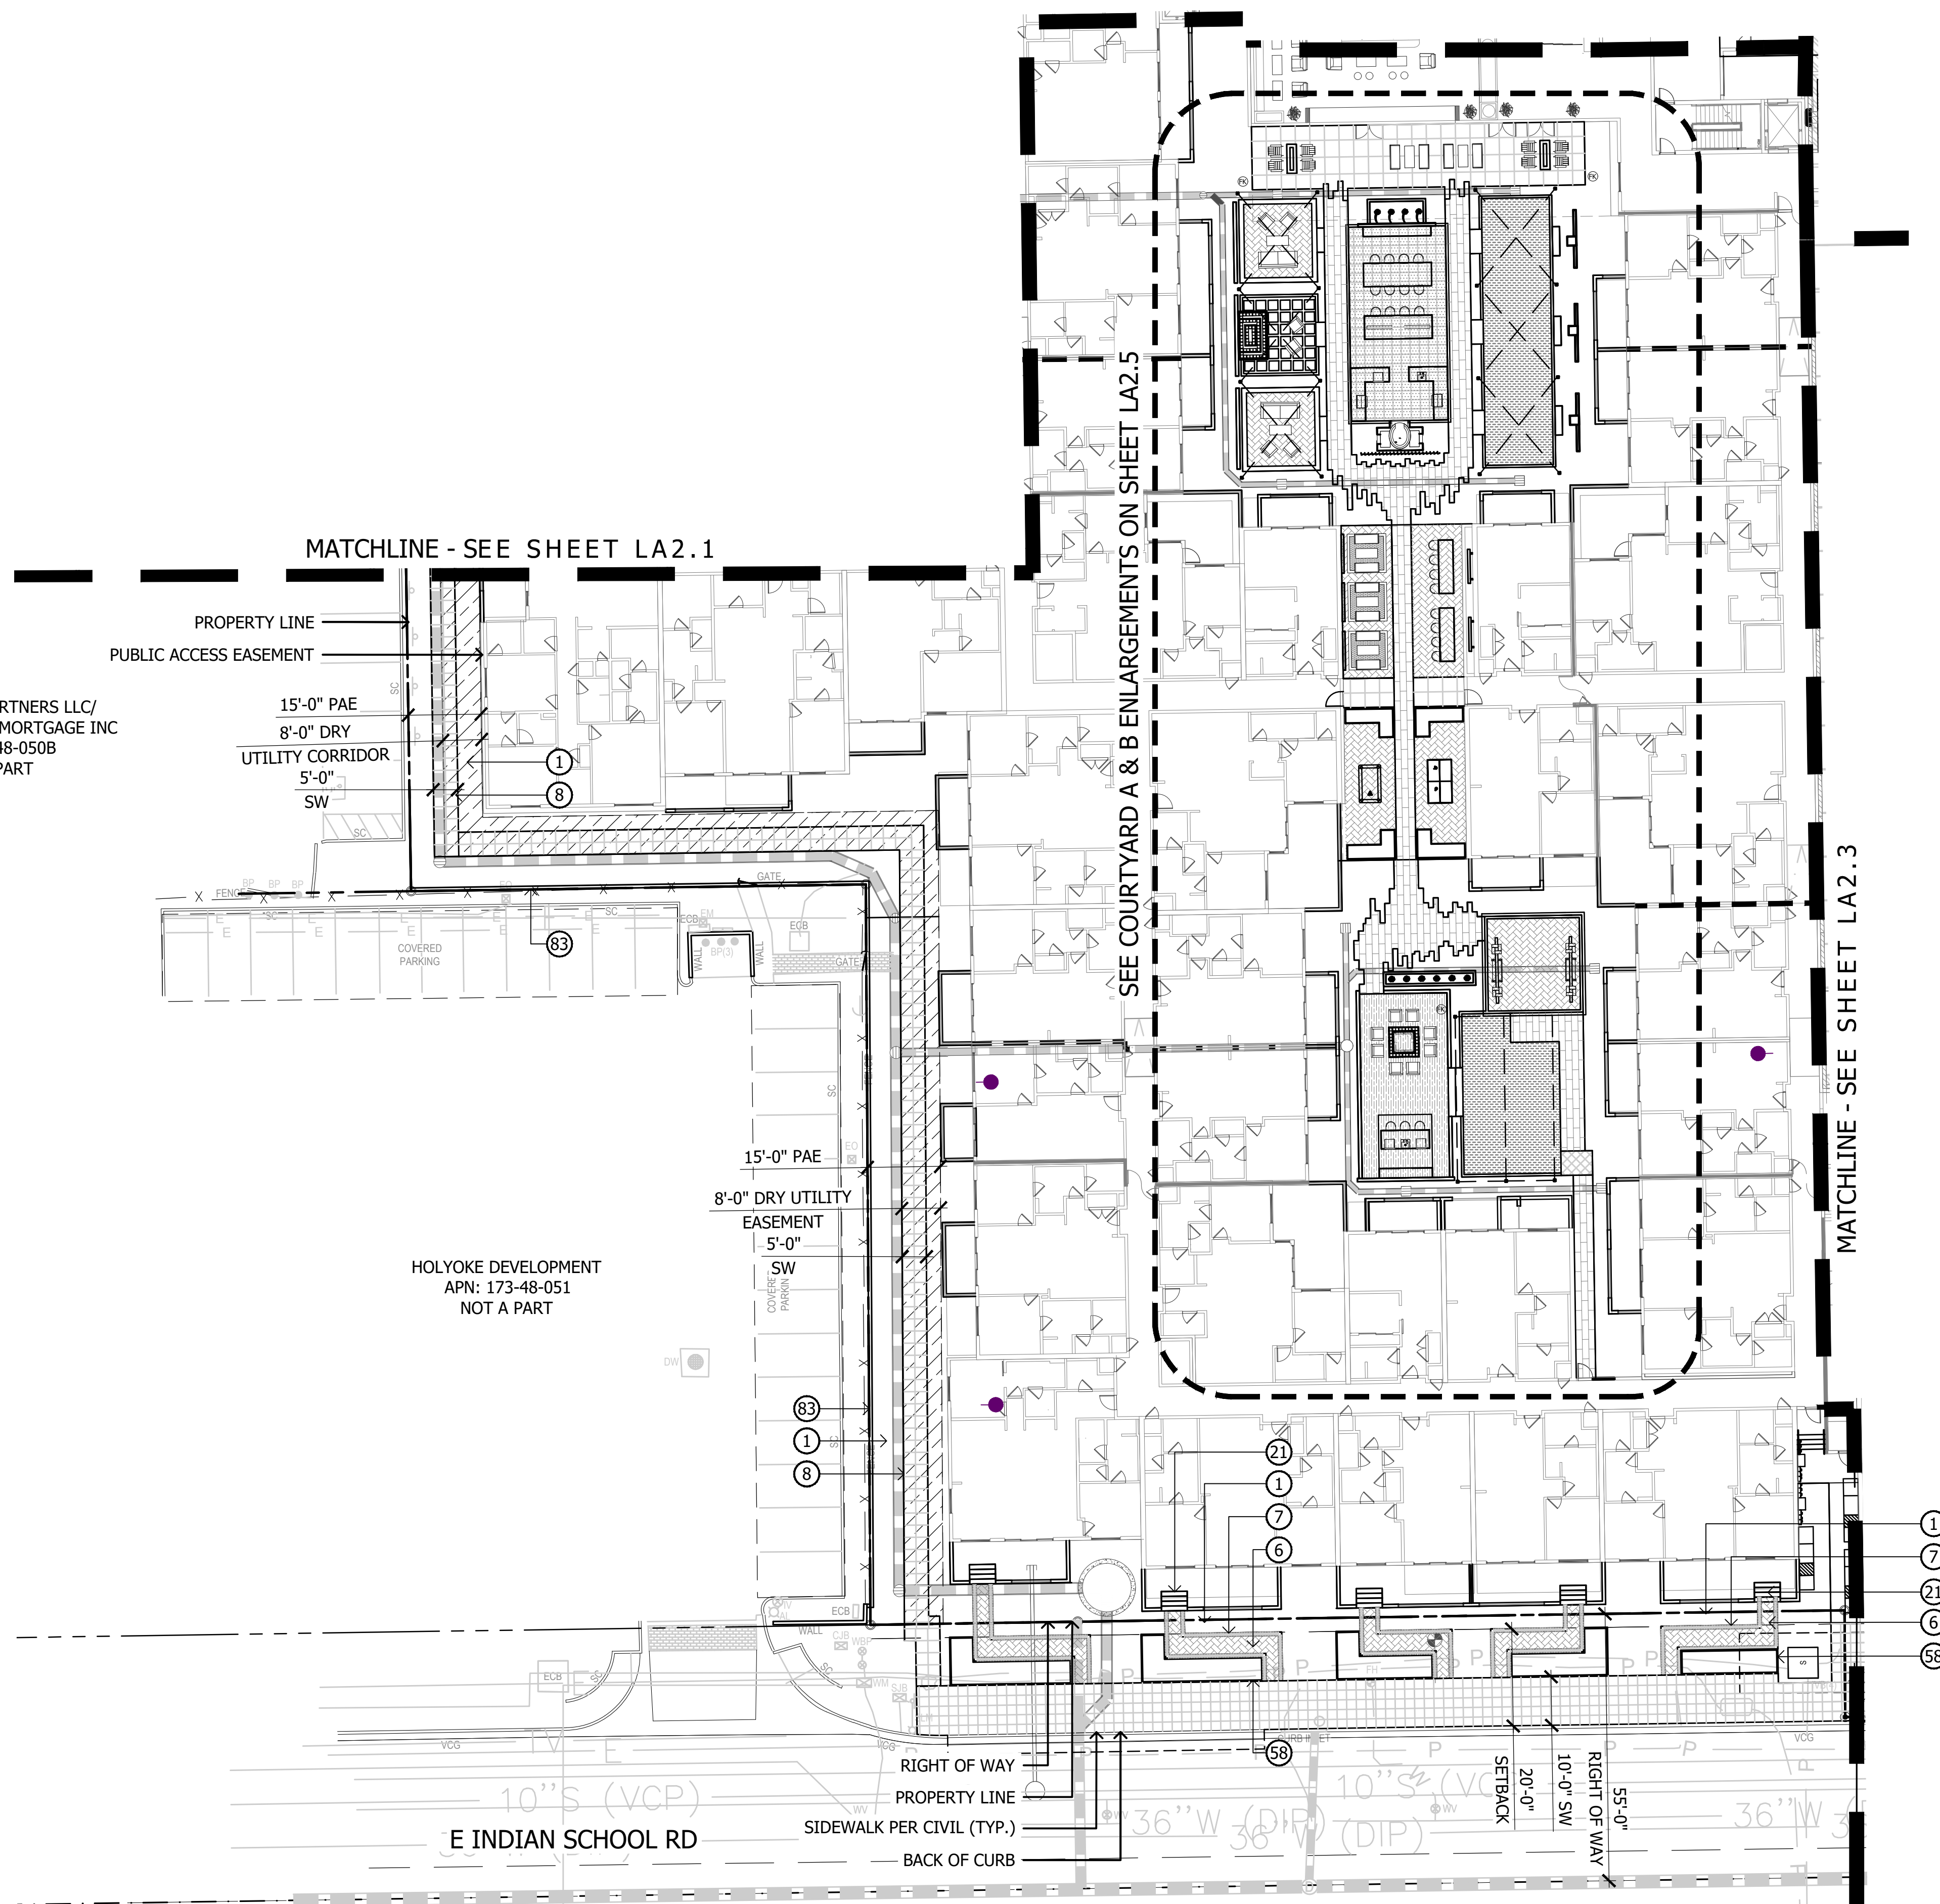


KEYNOTES

- | | |
|--|---|
| 1 LANDSCAPE AREA WITH DECOMPOSED GRANITE | 55 RECTANGULAR CONCRETE BENCH |
| 2 CONCRETE SIDEWALK | 56 ROUND CONCRETE BENCH AT PUBLIC PLAZA |
| 3 CONCRETE HEADER | 57 METAL BENCH |
| 4 CONCRETE PAD | 58 STEEL HEADER PLANTER |
| 5 LINEAR PAVERS | 59 RAISED PLANTER AT OUTDOOR CORRIDOR |
| 6 HERRINGBONE PAVERS | 60 ROUND RAISED PLANTER AT PLAZA |
| 7 SOLDIER COURSE PAVER BORDER | 61 PORTRAIT ART AT OUTDOOR COORIDOR |
| 8 2'X2' SCORED CONCRETE | 62 POOL TABLE AT OUTDOOR CORRIDOTR |
| 9 2'X2' CONCRETE PAVERS | 63 PING PONG TABLE AT OUTDOOR COORIDOR |
| 10 2' OCTAGON PAVERS | 64 BAR TOP AT OUTDOOR CORRIDOR |
| 11 PAVERS AT RETAIL PATIO | 65 TV WALL AT OUTDOOR CORRIDOR |
| 12 DRIVABLE GRAVEL PAVE | 66 TV WALL AT PODIUM DECK |
| 13 PAVING AT TRASH ENTRY DRIVE | 67 FIREPIT |
| 14 TURF | 68 RIM FLOW POOL |
| 15 WOOD DECK | 69 RAISED SPA |
| 16 PODIUM DECK PAVERS | 70 NEGATIVE EDGE WATER FEATURE AT PODIUM DECK |
| 17 ARTIFICIAL TURF AT GRADE | 71 DECORATIVE GLASS PLANTER AT PODIUM |
| 18 ARTIFICIAL TURF AT PODIUM | 72 WHEELCHAIR LIFT AT PODIUM |
| 19 ADA RAMP | 73 HIGHTOP AT PODIUM DECK |
| 20 DECORATIVE PAVING AT PLAZA | 74 PUBLIC ART |
| 21 CONCRETE STAIRS AT GRADE | 75 FURNITURE BY OTHERS |
| 22 CONCRETE STAIRS AT PODIUM | 76 ENTRY DRIVE AT 5TH AVE |
| 23 SLAT FENCE | 77 CONCRETE TABLE AT PODIUM DECK |
| 24 SLAT FENCE GATE | 78 PORTRAIT ART AT OUTDOOR CORRIDOR |
| 25 DECORATIVE PRIVACY SCREEN | 79 RUG AT OUTDOOR CORRIDOR |
| 26 DECORATIVE SCREEN WALL AT GRADE | 80 FIRE PIT & SPA CONTROLS |
| 27 DECORATIVE SCREEN WALL AT PODIUM | 81 6'-0" RETAINING WALL AT GRADE |
| 28 LOW RETAINING WALL AT GRADE | 82 6'-0" SCREEN WALL |
| 29 LOW RETAINING WALL AT PODIUM | 83 6'-0" THEME WALL |
| 30 GLASS POOL BARRIER AT PODIUM DECK | |
| 31 GLASS POOL BARRIER ON RETAINING WALL AT PODIUM DECK | |
| 32 DECORATIVE METAL FINS | |
| 33 20'X40' SHADE STRUCTURE AT OUTDOOR KITCHEN | |
| 34 20'X20' SHADE STRUCTURE AT PORCH SWING NODE | |
| 35 PORCH SWING | |
| 36 11'X13' CANTILEVER SHADE STRUCTURE AT WOOD DECK | |
| 37 18'X36' SHADE STRUCTURE AT PUBLIC PLAZA | |
| 38 18'X36' SHADE STRUCTURE AT PODIUM DECK | |
| 39 18'X25' SHADE STRUCTURE AT PODIUM DECK | |
| 40 OUTDOOR FIREPLACE AT GRADE | |
| 41 OUTDOOR FIREPLACE AT PODIUM DECK | |
| 42 COMMUNITY FIRE PIT AT WOOD DECK | |
| 43 CREDENZA | |
| 44 CONCRETE TABLE AT OUTDOOR KITCHEN | |
| 45 SEATING ISLAND AT OUTDOOR KITCHEN | |
| 46 SEATING ISLAND AT CANTILEVER SHADE STRUCTURE | |
| 47 SEATING ISLAND AT PODIUM DECK | |
| 48 BBQ AT OUTDOOR KITCHEN | |
| 49 WATER FEATURE AT COURTYARD A | |
| 50 WATER FEATURE AT COURTYARD B | |
| 51 FESTOON LIGHTS | |
| 52 BBQ AT OUTDOOR KITCHEN | |
| 53 PIZZA OVEN AT OUTDOOR KITCHEN | |
| 54 PORCH SWING AT COURTYARD B | |

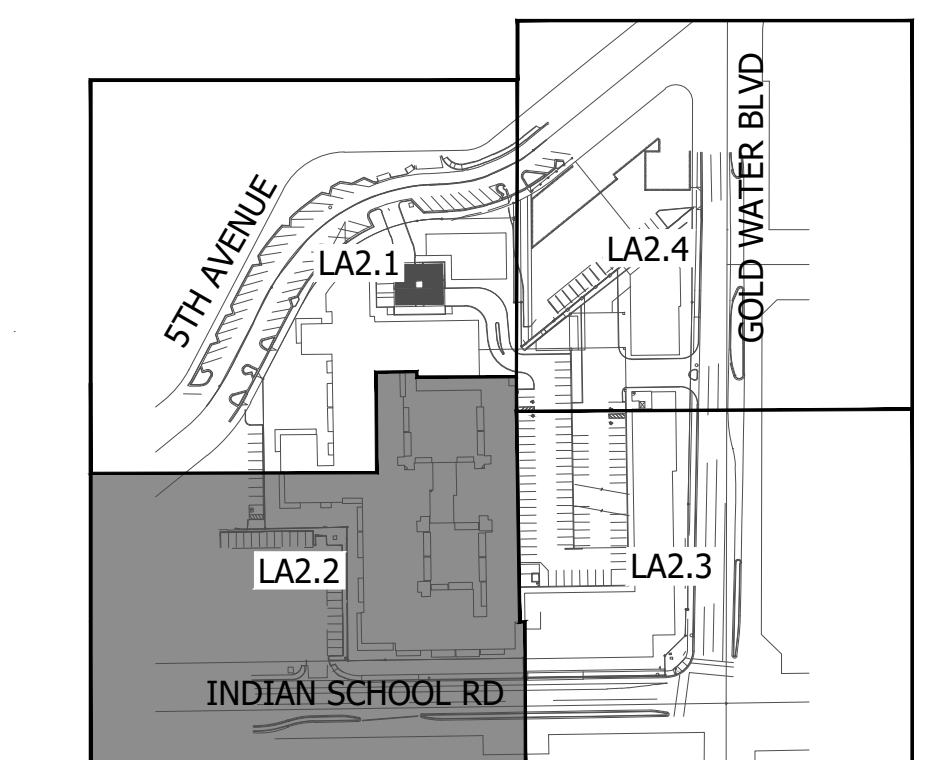




KEY MAP

NOT TO SCALE

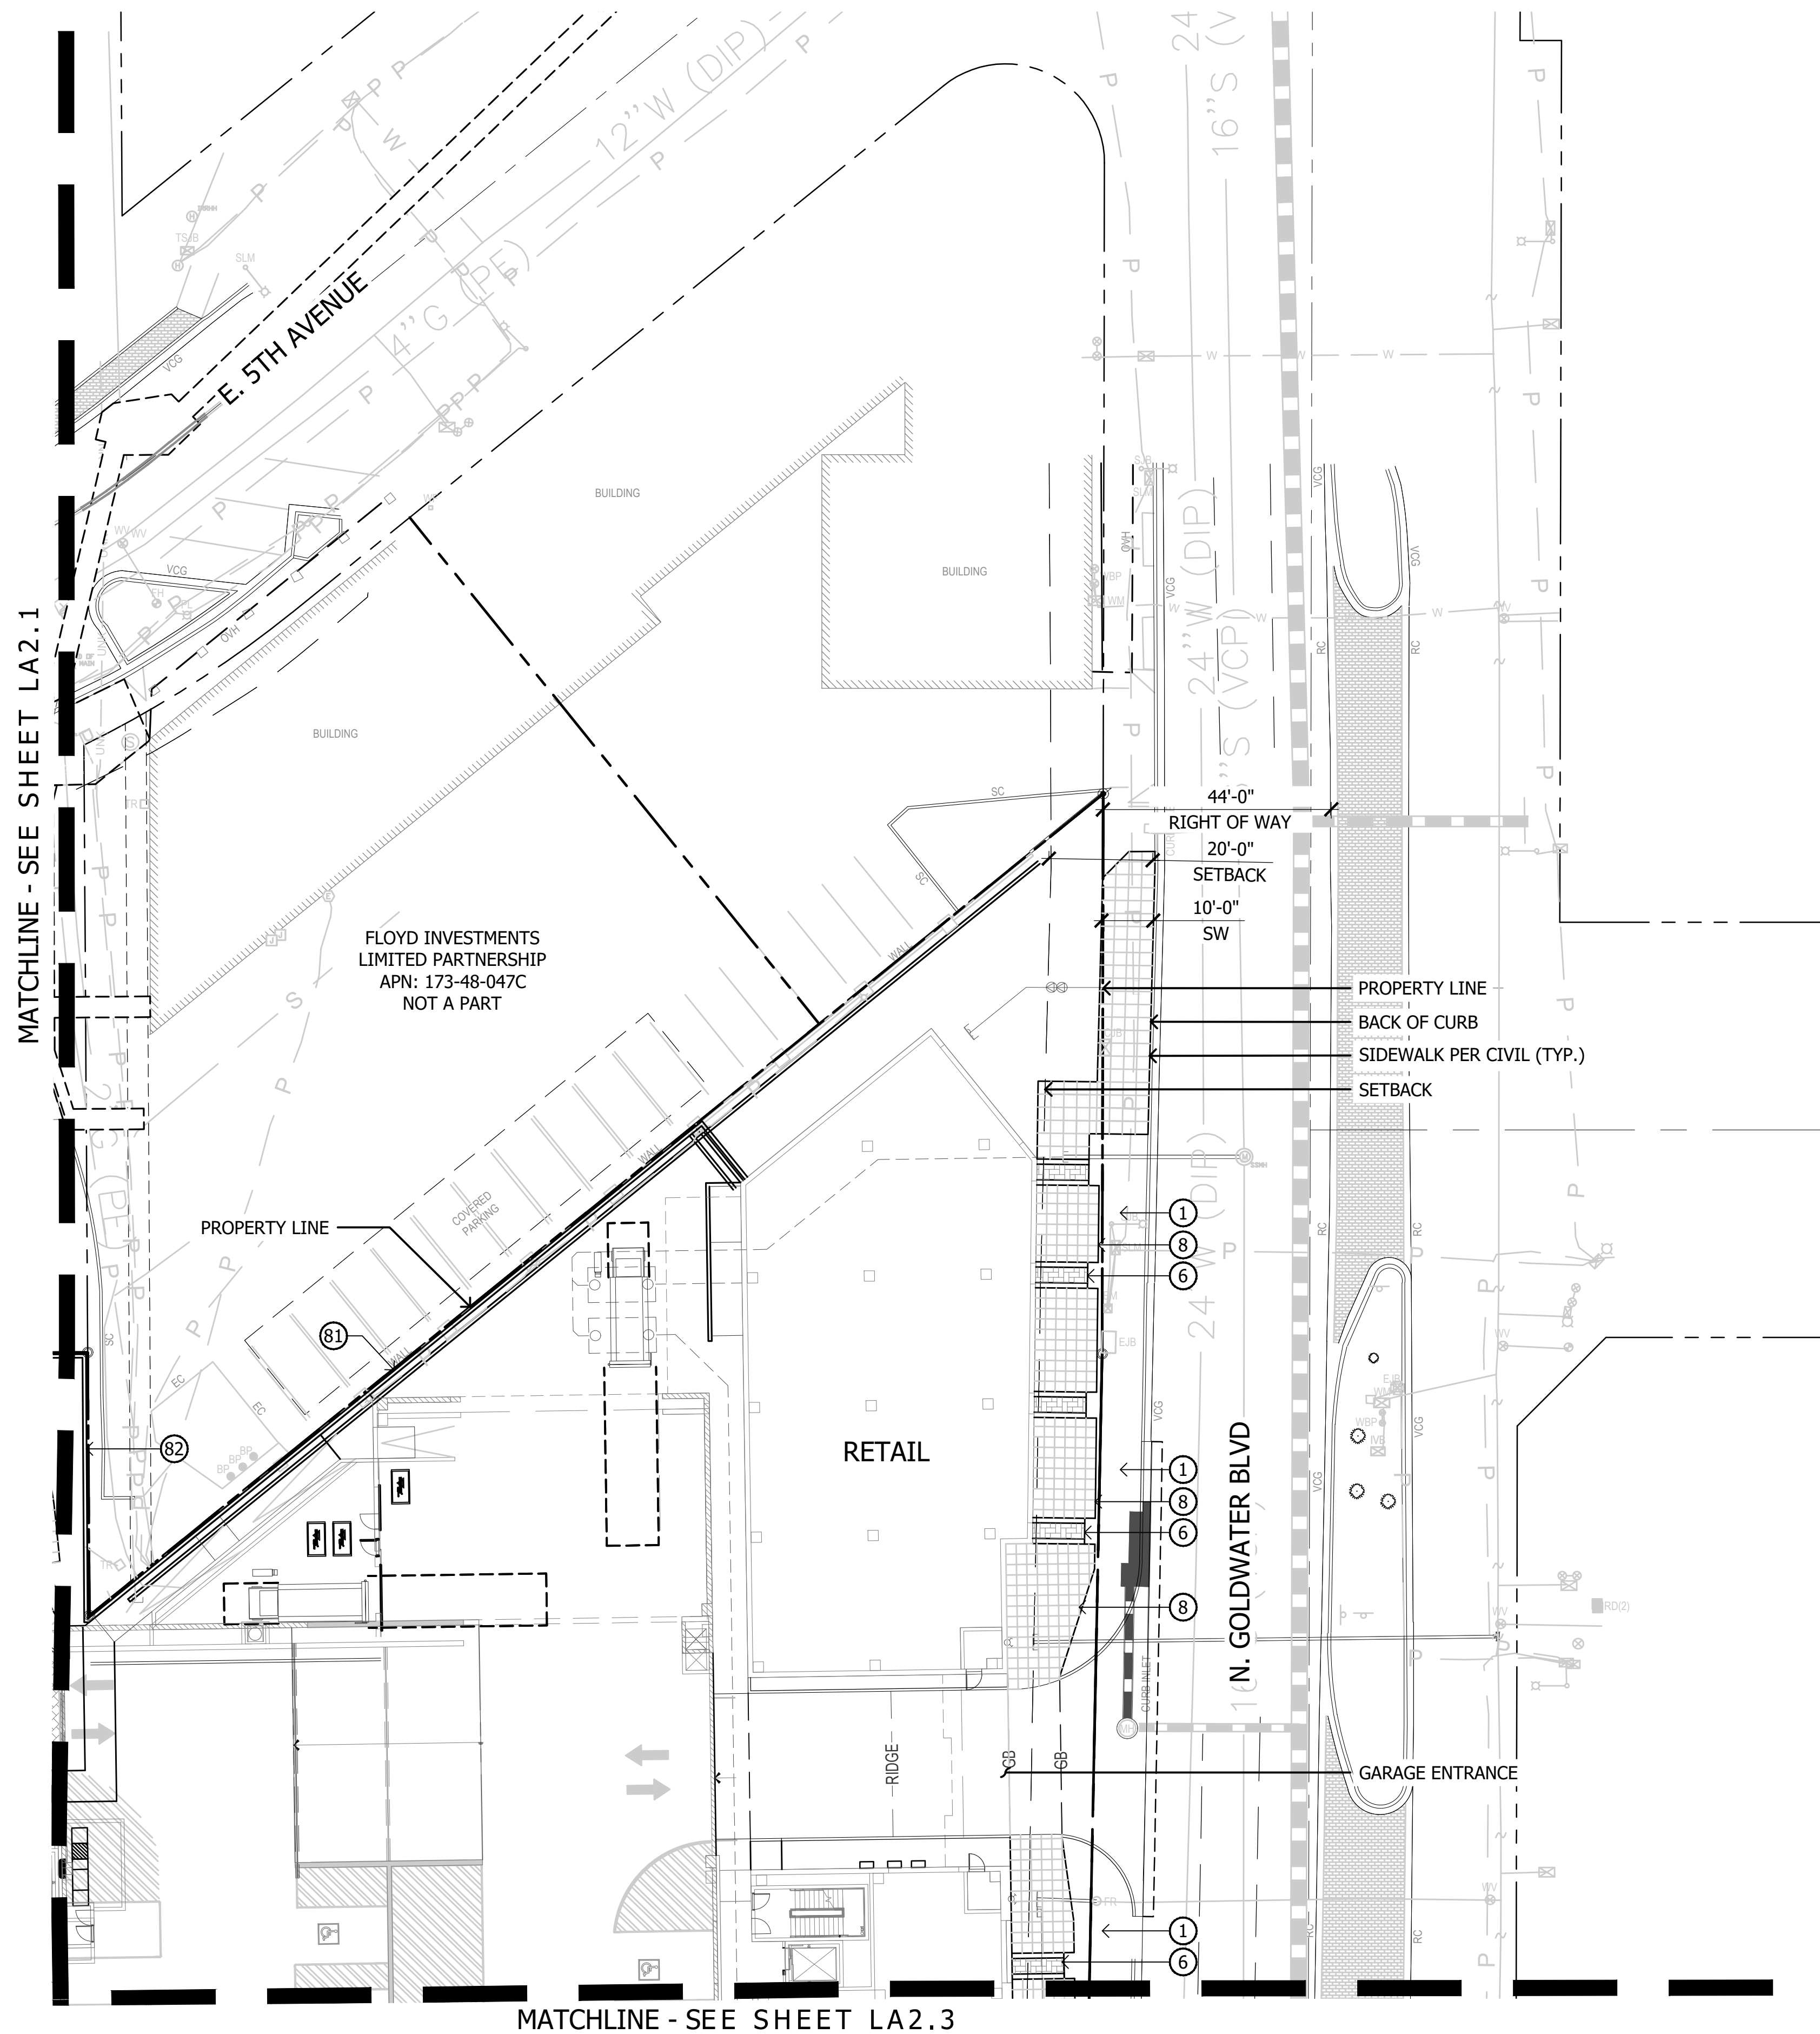


KEYNOTES	
1 LANDSCAPE AREA WITH DECOMPOSED GRANITE	55 RECTANGULAR CONCRETE BENCH
2 CONCRETE SIDEWALK	56 ROUND CONCRETE BENCH AT PUBLIC PLAZA
3 CONCRETE HEADER	57 METAL BENCH
4 CONCRETE PAD	58 STEEL HEADER PLANTER
5 LINEAR PAVERS	59 RAISED PLANTER AT OUTDOOR CORRIDOR
6 HERRINGBONE PAVERS	60 ROUND RAISED PLANTER AT PLAZA
7 SOLDIER COURSE PAVER BORDER	61 PORTRAIT ART AT OUTDOOR COORIDOR
8 2'X2' SCORED CONCRETE	62 POOL TABLE AT OUTDOOR CORRIDOTR
9 2'X2' CONCRETE PAVERS	63 PING PONG TABLE AT OUTDOOR COORIDOR
10 2' OCTAGON PAVERS	64 BAR TOP AT OUTDOOR CORRIDOR
11 PAVERS AT RETAIL PATIO	65 TV WALL AT OUTDOOR CORRIDOR
12 DRIVABLE GRAVEL PAVE	66 TV WALL AT PODIUM DECK
13 PAVING AT TRASH ENTRY DRIVE	67 FIREPIT
14 TURF	68 RIM FLOW POOL
15 WOOD DECK	69 RAISED SPA
16 PODIUM DECK PAVERS	70 NEGATIVE EDGE WATER FEATURE AT PODIUM DECK
17 ARTIFICIAL TURF AT GRADE	71 DECORATIVE GLASS PLANTER AT PODIUM
18 ARTIFICIAL TURF AT PODIUM	72 WHEELCHAIR LIFT AT PODIUM
19 ADA RAMP	73 HIGHTOP AT PODIUM DECK
20 DECORATIVE PAVING AT PLAZA	74 PUBLIC ART
21 CONCRETE STAIRS AT GRADE	75 FURNITURE BY OTHERS
22 CONCRETE STAIRS AT PODIUM	76 ENTRY DRIVE AT 5TH AVE
23 SLAT FENCE	77 CONCRETE TABLE AT PODIUM DECK
24 SLAT FENCE GATE	78 PORTRAIT ART AT OUTDOOR CORRIDOR
25 DECORATIVE PRIVACY SCREEN	79 RUG AT OUTDOOR CORRIDOR
26 DECORATIVE SCREEN WALL AT GRADE	80 FIRE PIT & SPA CONTROLS
27 DECORATIVE SCREEN WALL AT PODIUM	81 6'-0" RETAINING WALL AT GRADE
28 LOW RETAINING WALL AT GRADE	82 6'-0" SCREEN WALL
29 LOW RETAINING WALL AT PODIUM	83 6'-0" THEME WALL
30 GLASS POOL BARRIER AT PODIUM DECK	
31 GLASS POOL BARRIER ON RETAINING WALL AT PODIUM DECK	
32 DECORATIVE METAL FINS	
33 20'X40' SHADE STRUCTURE AT OUTDOOR KITCHEN	
34 20'X20' SHADE STRUCTURE AT PORCH SWING NODE	
35 PORCH SWING	
36 11'X13' CANTILEVER SHADE STRUCTURE AT WOOD DECK	
37 18'X36' SHADE STRUCTURE AT PUBLIC PLAZA	
38 18'X36' SHADE STRUCTURE AT PODIUM DECK	
39 18'X25' SHADE STRUCTURE AT PODIUM DECK	
40 OUTDOOR FIREPLACE AT GRADE	
41 OUTDOOR FIREPLACE AT PODIUM DECK	
42 COMMUNITY FIRE PIT AT WOOD DECK	
43 CREDENZA	
44 CONCRETE TABLE AT OUTDOOR KITCHEN	
45 SEATING ISLAND AT OUTDOOR KITCHEN	
46 SEATING ISLAND AT CANTILEVER SHADE STRUCTURE	
47 SEATING ISLAND AT PODIUM DECK	
48 BBQ AT OUTDOOR KITCHEN	
49 WATER FEATURE AT COURTYARD A	
50 WATER FEATURE AT COURTYARD B	
51 FESTOON LIGHTS	
52 BBQ AT OUTDOOR KITCHEN	
53 PIZZA OVEN AT OUTDOOR KITCHEN	
54 PORCH SWING AT COURTYARD B	

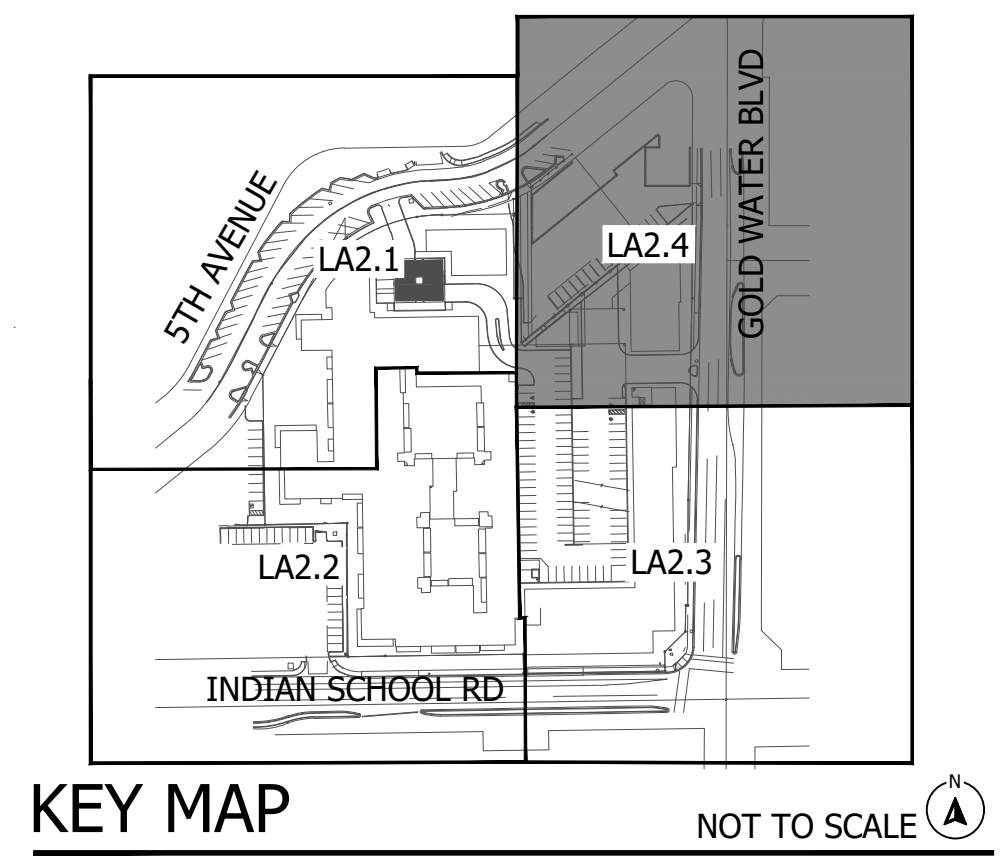

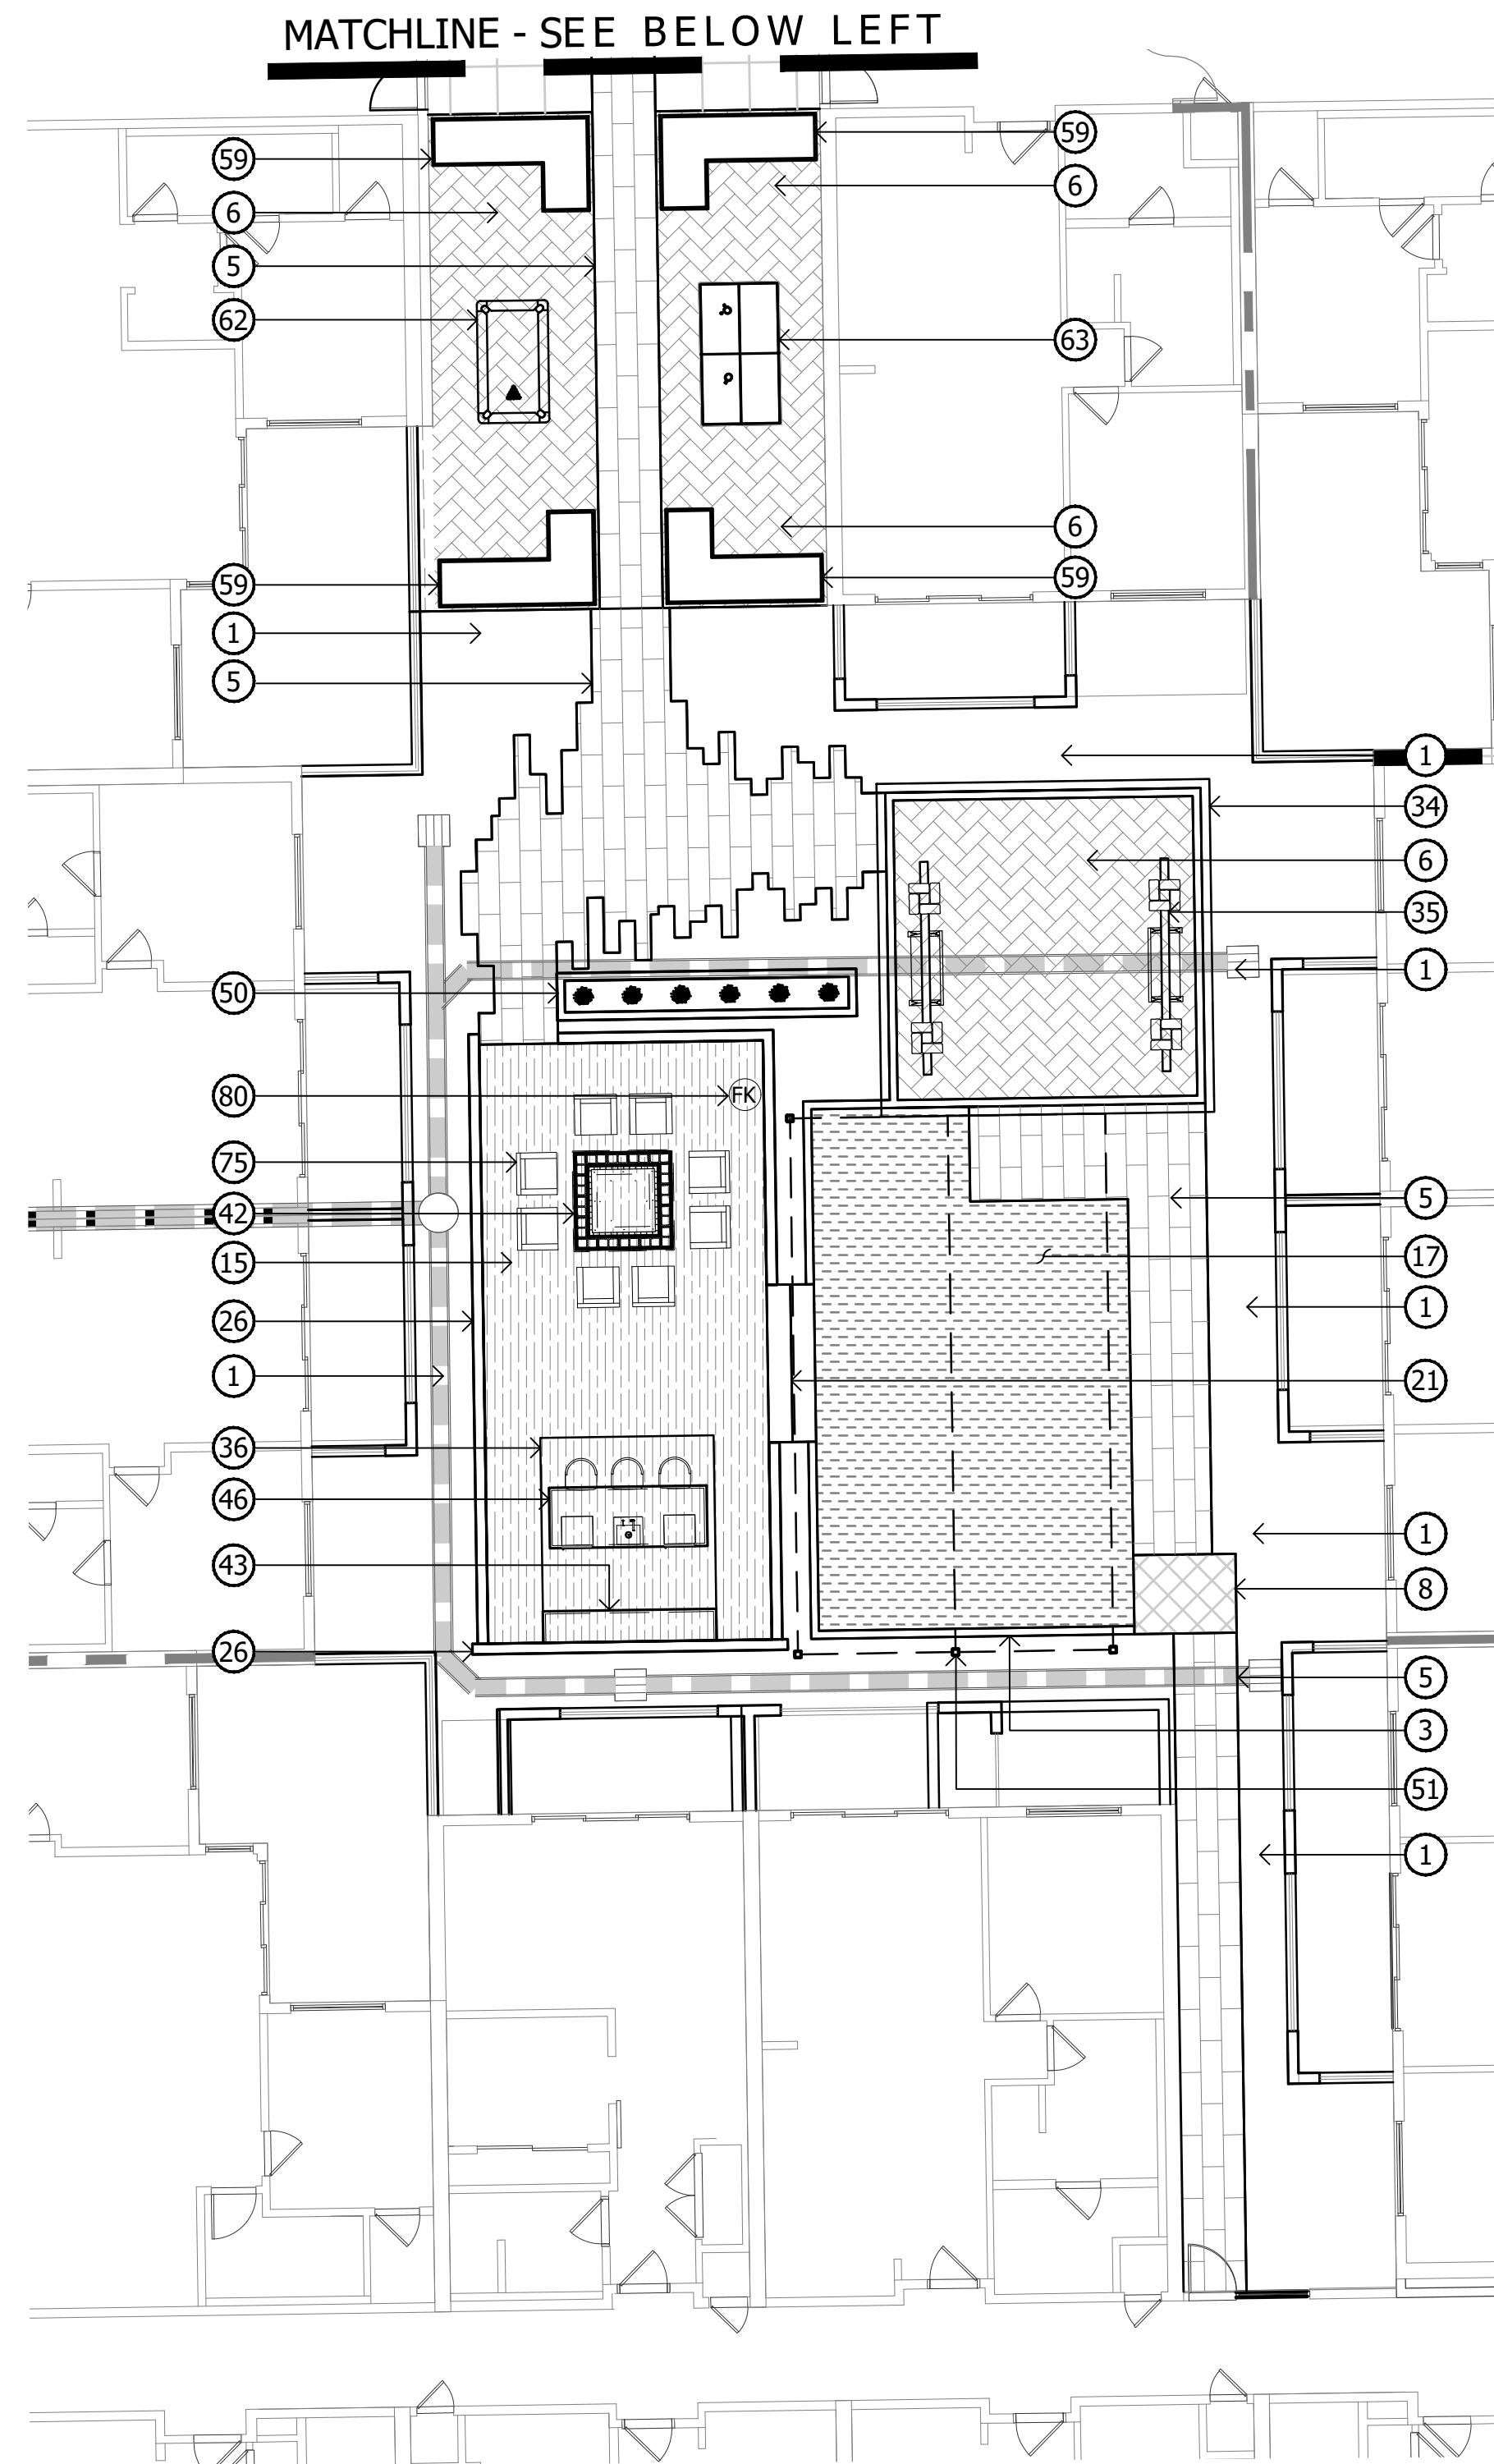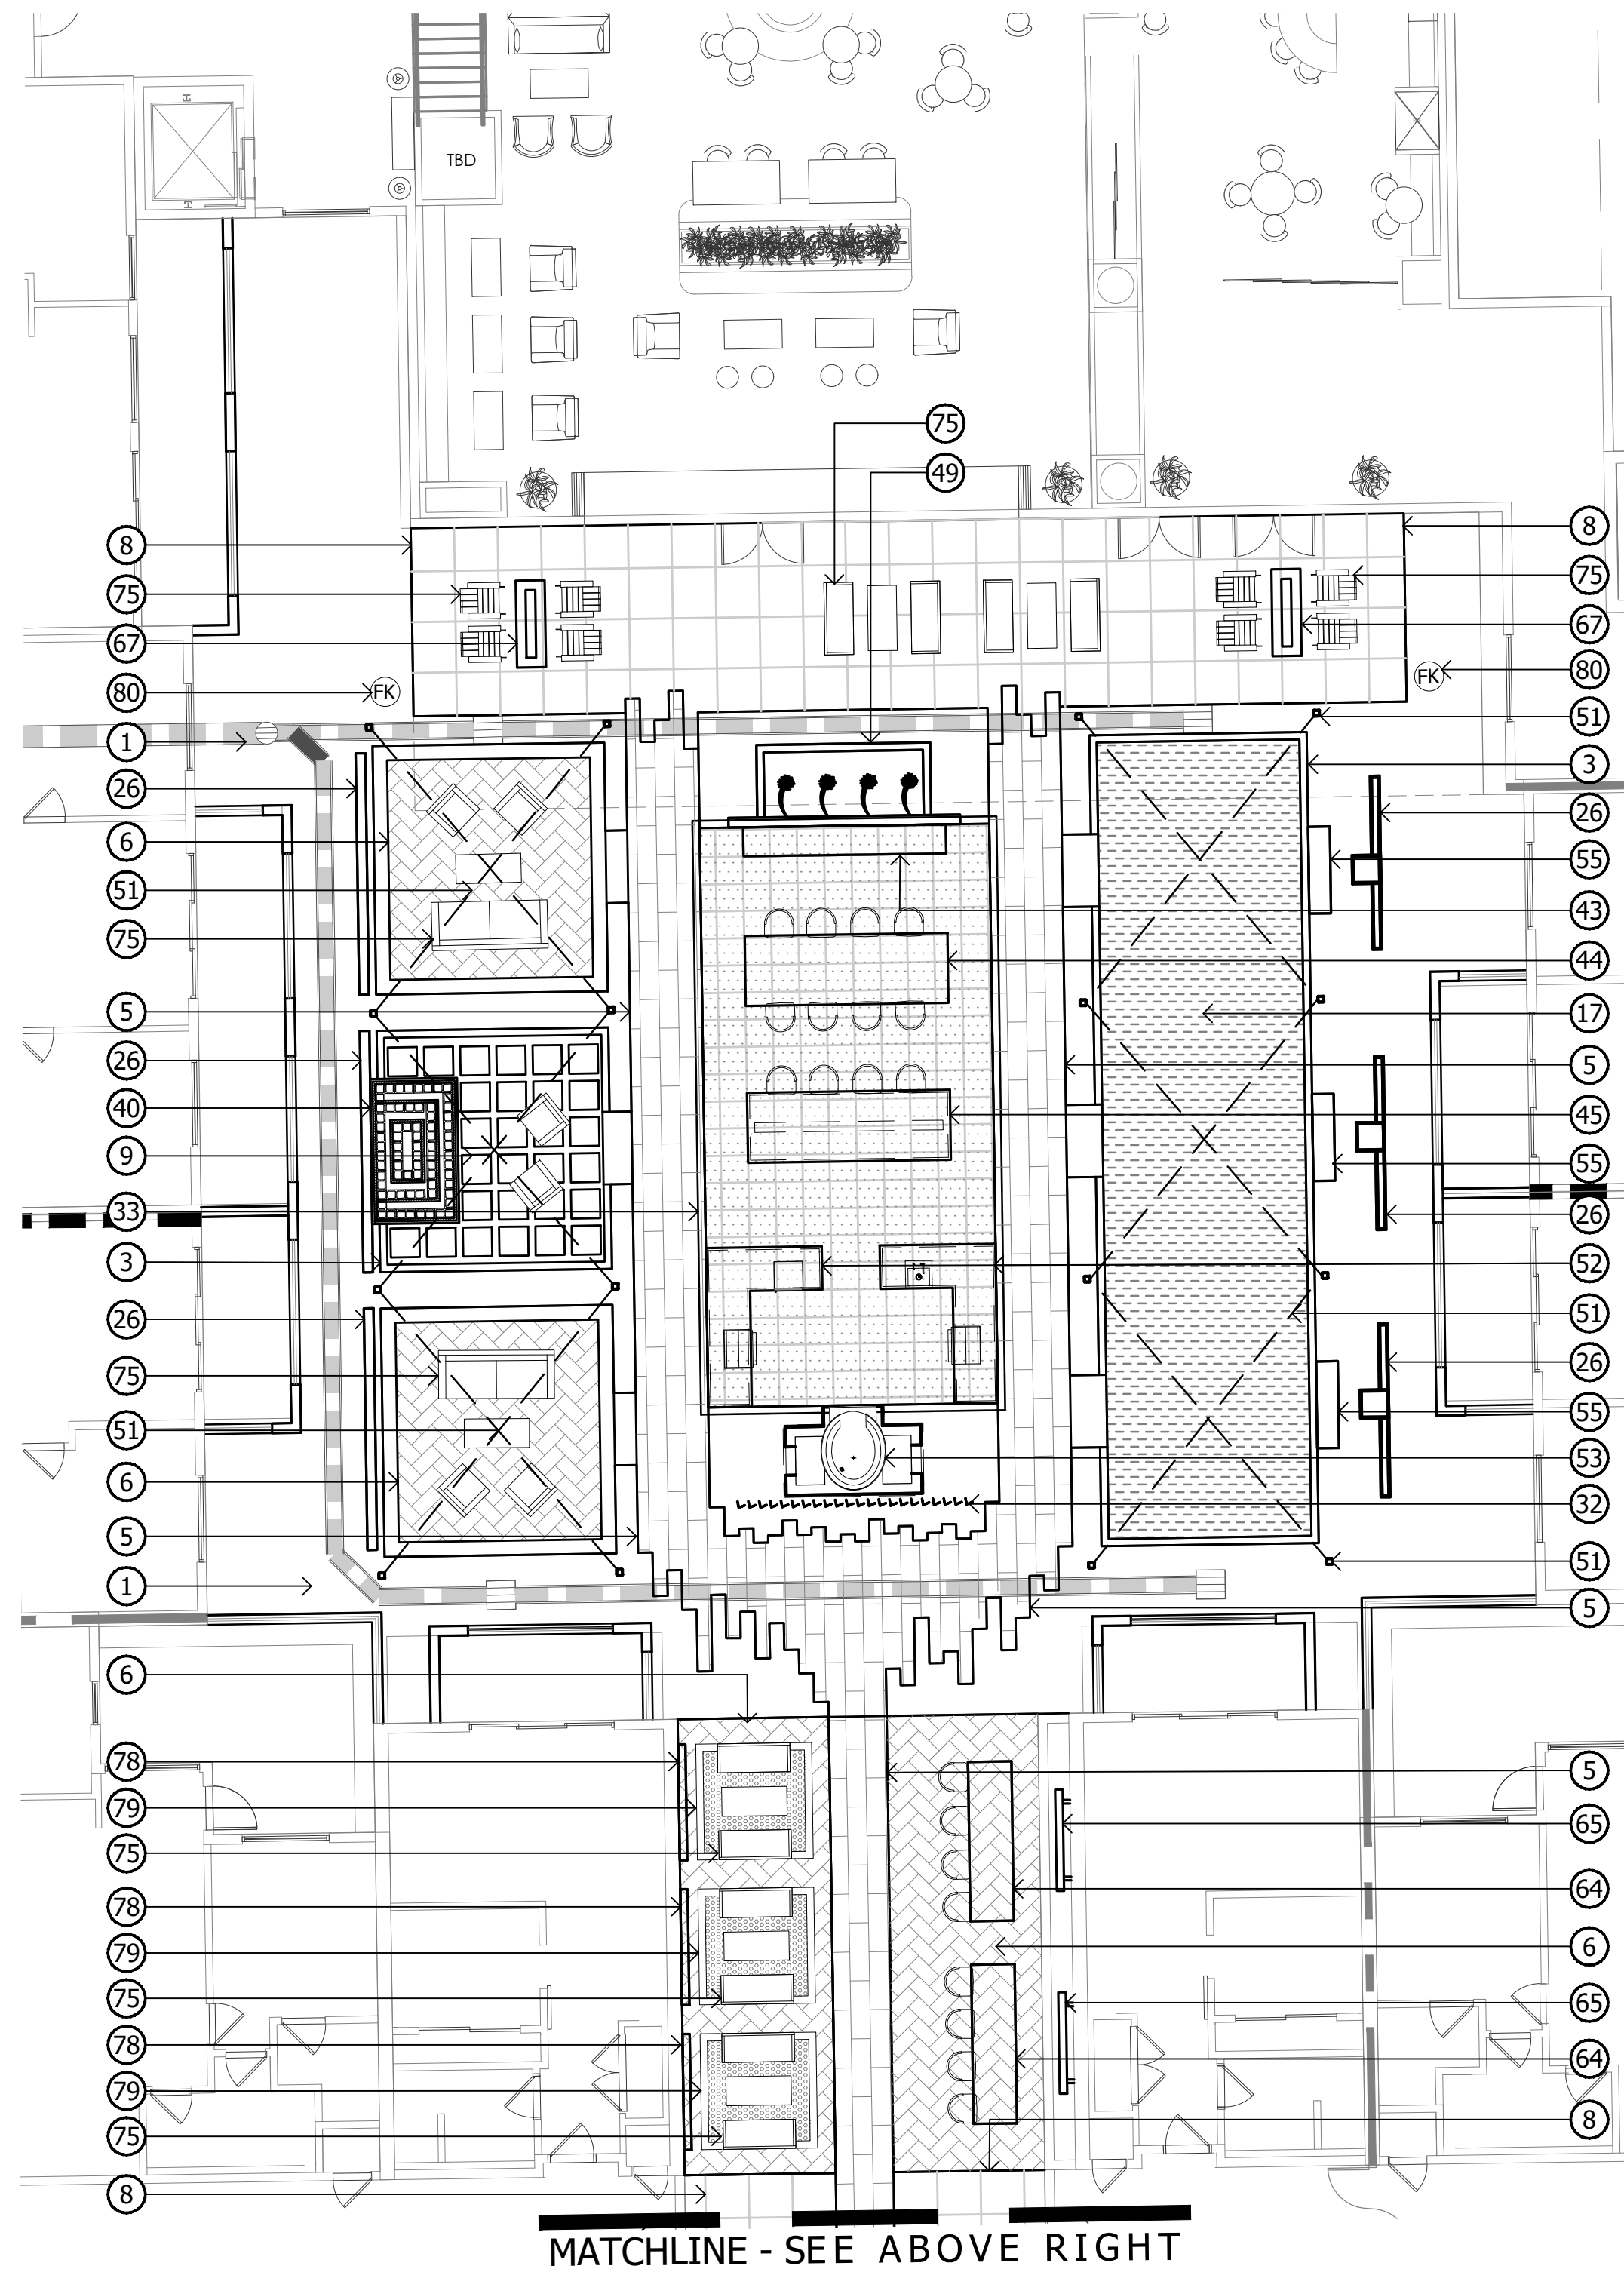


KEYNOTES

- | | |
|--|---|
| 1 LANDSCAPE AREA WITH DECOMPOSED GRANITE | 55 RECTANGULAR CONCRETE BENCH |
| 2 CONCRETE SIDEWALK | 56 ROUND CONCRETE BENCH AT PUBLIC PLAZA |
| 3 CONCRETE HEADER | 57 METAL BENCH |
| 4 CONCRETE PAD | 58 STEEL HEADER PLANTER |
| 5 LINEAR PAVERS | 59 RAISED PLANTER AT OUTDOOR CORRIDOR |
| 6 HERRINGBONE PAVERS | 60 ROUND RAISED PLANTER AT PLAZA |
| 7 SOLDIER COURSE PAVER BORDER | 61 PORTRAIT ART AT OUTDOOR COORIDOR |
| 8 2'X2' SCORED CONCRETE | 62 POOL TABLE AT OUTDOOR CORRIDOTR |
| 9 2'X2' CONCRETE PAVERS | 63 PING PONG TABLE AT OUTDOOR COORIDOR |
| 10 2' OCTAGON PAVERS | 64 BAR TOP AT OUTDOOR CORRIDOR |
| 11 PAVERS AT RETAIL PATIO | 65 TV WALL AT OUTDOOR CORRIDOR |
| 12 DRIVABLE GRAVEL PAVE | 66 TV WALL AT PODIUM DECK |
| 13 PAVING AT TRASH ENTRY DRIVE | 67 FIREPIT |
| 14 TURF | 68 RIM FLOW POOL |
| 15 WOOD DECK | 69 RAISED SPA |
| 16 PODIUM DECK PAVERS | 70 NEGATIVE EDGE WATER FEATURE AT PODIUM DECK |
| 17 ARTIFICIAL TURF AT GRADE | 71 DECORATIVE GLASS PLANTER AT PODIUM |
| 18 ARTIFICIAL TURF AT PODIUM | 72 WHEELCHAIR LIFT AT PODIUM |
| 19 ADA RAMP | 73 HIGHTOP AT PODIUM DECK |
| 20 DECORATIVE PAVING AT PLAZA | 74 PUBLIC ART |
| 21 CONCRETE STAIRS AT GRADE | 75 FURNITURE BY OTHERS |
| 22 CONCRETE STAIRS AT PODIUM | 76 ENTRY DRIVE AT 5TH AVE |
| 23 SLAT FENCE | 77 CONCRETE TABLE AT PODIUM DECK |
| 24 SLAT FENCE GATE | 78 PORTRAIT ART AT OUTDOOR CORRIDOR |
| 25 DECORATIVE PRIVACY SCREEN | 79 RUG AT OUTDOOR CORRIDOR |
| 26 DECORATIVE SCREEN WALL AT GRADE | 80 FIRE PIT & SPA CONTROLS |
| 27 DECORATIVE SCREEN WALL AT PODIUM | 81 6'-0" RETAINING WALL AT GRADE |
| 28 LOW RETAINING WALL AT GRADE | 82 6'-0" SCREEN WALL |
| 29 LOW RETAINING WALL AT PODIUM | 83 6'-0" THEME WALL |
| 30 GLASS POOL BARRIER AT PODIUM DECK | |
| 31 GLASS POOL BARRIER ON RETAINING WALL AT PODIUM DECK | |
| 32 DECORATIVE METAL FINS | |
| 33 20'X40' SHADE STRUCTURE AT OUTDOOR KITCHEN | |
| 34 20'X20' SHADE STRUCTURE AT PORCH SWING NODE | |
| 35 PORCH SWING | |
| 36 11'X13' CANTILEVER SHADE STRUCTURE AT WOOD DECK | |
| 37 18'X36' SHADE STRUCTURE AT PUBLIC PLAZA | |
| 38 18'X36' SHADE STRUCTURE AT PODIUM DECK | |
| 39 18'X25' SHADE STRUCTURE AT PODIUM DECK | |
| 40 OUTDOOR FIREPLACE AT GRADE | |
| 41 OUTDOOR FIREPLACE AT PODIUM DECK | |
| 42 COMMUNITY FIRE PIT AT WOOD DECK | |
| 43 CREDENZA | |
| 44 CONCRETE TABLE AT OUTDOOR KITCHEN | |
| 45 SEATING ISLAND AT OUTDOOR KITCHEN | |
| 46 SEATING ISLAND AT CANTILEVER SHADE STRUCTURE | |
| 47 SEATING ISLAND AT PODIUM DECK | |
| 48 BBQ AT OUTDOOR KITCHEN | |
| 49 WATER FEATURE AT COURTYARD A | |
| 50 WATER FEATURE AT COURTYARD B | |
| 51 FESTOON LIGHTS | |
| 52 BBQ AT OUTDOOR KITCHEN | |
| 53 PIZZA OVEN AT OUTDOOR KITCHEN | |
| 54 PORCH SWING AT COURTYARD B | |

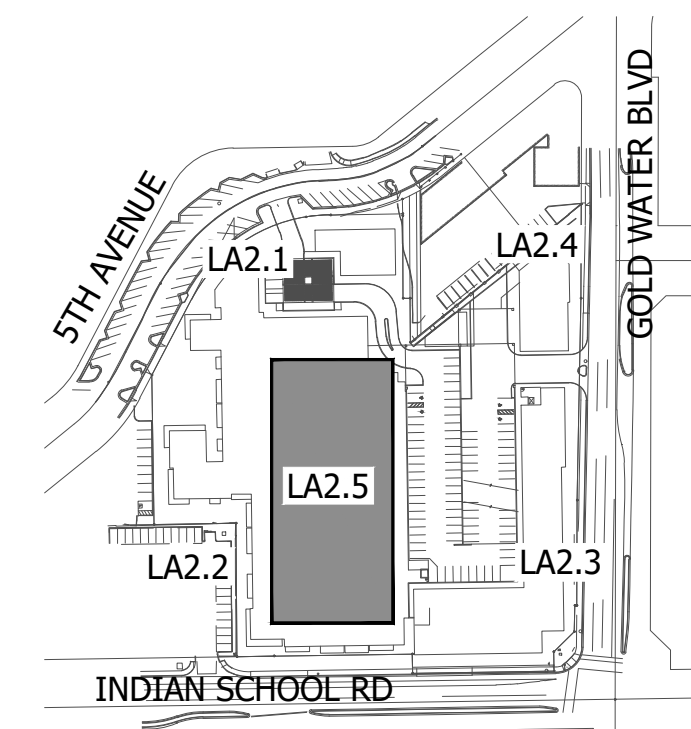


KEY MAP

NOT TO SCALE

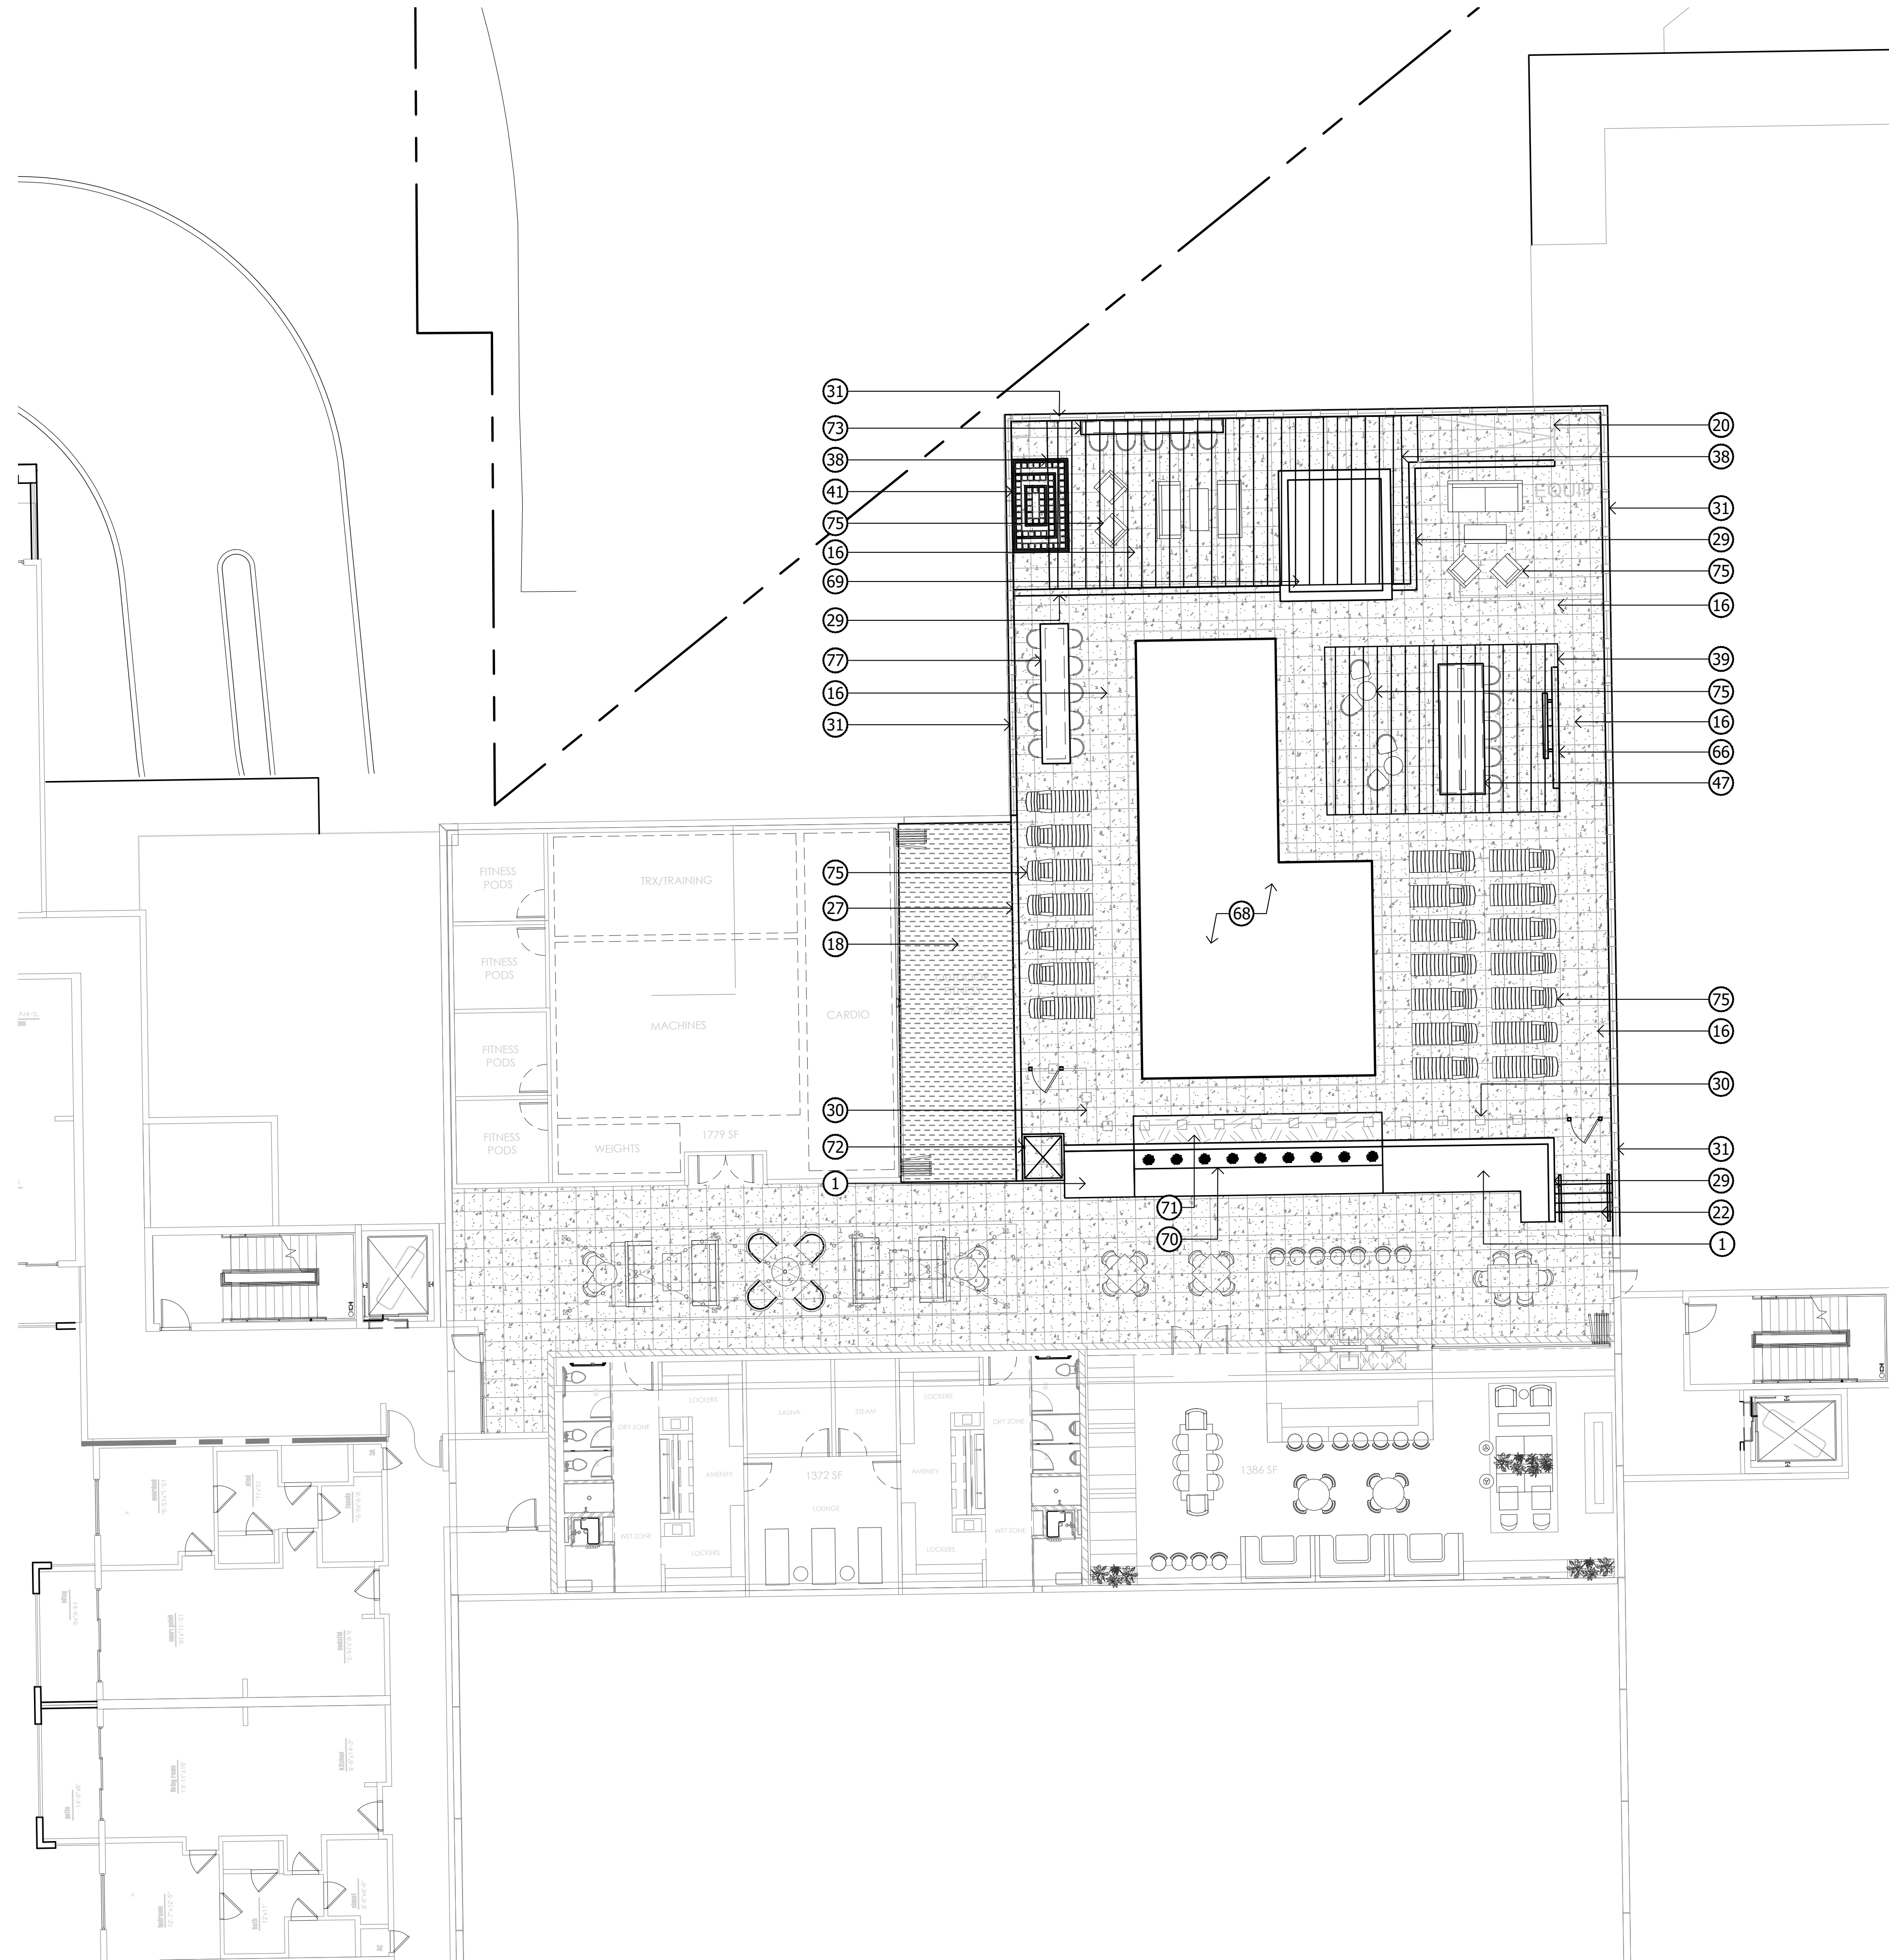

KEYNOTES

- | | |
|--|---|
| 1 LANDSCAPE AREA WITH DECOMPOSED GRANITE | 55 RECTANGULAR CONCRETE BENCH |
| 2 CONCRETE SIDEWALK | 56 ROUND CONCRETE BENCH AT PUBLIC PLAZA |
| 3 CONCRETE HEADER | 57 METAL BENCH |
| 4 CONCRETE PAD | 58 STEEL HEADER PLANTER |
| 5 LINEAR PAVERS | 59 RAISED PLANTER AT OUTDOOR CORRIDOR |
| 6 HERRINGBONE PAVERS | 60 ROUND RAISED PLANTER AT PLAZA |
| 7 SOLDIER COURSE PAVER BORDER | 61 PORTRAIT ART AT OUTDOOR COORIDOR |
| 8 2'X2' SCORED CONCRETE | 62 POOL TABLE AT OUTDOOR CORRIDOTR |
| 9 2'X2' CONCRETE PAVERS | 63 PING PONG TABLE AT OUTDOOR COORIDOR |
| 10 2' OCTAGON PAVERS | 64 BAR TOP AT OUTDOOR CORRIDOR |
| 11 PAVERS AT RETAIL PATIO | 65 TV WALL AT OUTDOOR CORRIDOR |
| 12 DRIVABLE GRAVEL PAVE | 66 TV WALL AT PODIUM DECK |
| 13 PAVING AT TRASH ENTRY DRIVE | 67 FIREPIT |
| 14 TURF | 68 RIM FLOW POOL |
| 15 WOOD DECK | 69 RAISED SPA |
| 16 PODIUM DECK PAVERS | 70 NEGATIVE EDGE WATER FEATURE AT PODIUM DECK |
| 17 ARTIFICIAL TURF AT GRADE | 71 DECORATIVE GLASS PLANTER AT PODIUM |
| 18 ARTIFICIAL TURF AT PODIUM | 72 WHEELCHAIR LIFT AT PODIUM |
| 19 ADA RAMP | 73 HIGHTOP AT PODIUM DECK |
| 20 DECORATIVE PAVING AT PLAZA | 74 PUBLIC ART |
| 21 CONCRETE STAIRS AT GRADE | 75 FURNITURE BY OTHERS |
| 22 CONCRETE STAIRS AT PODIUM | 76 ENTRY DRIVE AT 5TH AVE |
| 23 SLAT FENCE | 77 CONCRETE TABLE AT PODIUM DECK |
| 24 SLAT FENCE GATE | 78 PORTRAIT ART AT OUTDOOR CORRIDOR |
| 25 DECORATIVE PRIVACY SCREEN | 79 RUG AT OUTDOOR CORRIDOR |
| 26 DECORATIVE SCREEN WALL AT GRADE | 80 FIRE PIT & SPA CONTROLS |
| 27 DECORATIVE SCREEN WALL AT PODIUM | 81 6'-0" RETAINING WALL AT GRADE |
| 28 LOW RETAINING WALL AT GRADE | 82 6'-0" SCREEN WALL |
| 29 LOW RETAINING WALL AT PODIUM | 83 6'-0" THEME WALL |
| 30 GLASS POOL BARRIER AT PODIUM DECK | |
| 31 GLASS POOL BARRIER ON RETAINING WALL AT PODIUM DECK | |
| 32 DECORATIVE METAL FINS | |
| 33 20'X40' SHADE STRUCTURE AT OUTDOOR KITCHEN | |
| 34 20'X20' SHADE STRUCTURE AT PORCH SWING NODE | |
| 35 PORCH SWING | |
| 36 11'X13' CANTILEVER SHADE STRUCTURE AT WOOD DECK | |
| 37 18'X36' SHADE STRUCTURE AT PUBLIC PLAZA | |
| 38 18'X36' SHADE STRUCTURE AT PODIUM DECK | |
| 39 18'X25' SHADE STRUCTURE AT PODIUM DECK | |
| 40 OUTDOOR FIREPLACE AT GRADE | |
| 41 OUTDOOR FIREPLACE AT PODIUM DECK | |
| 42 COMMUNITY FIRE PIT AT WOOD DECK | |
| 43 CREDENZA | |
| 44 CONCRETE TABLE AT OUTDOOR KITCHEN | |
| 45 SEATING ISLAND AT OUTDOOR KITCHEN | |
| 46 SEATING ISLAND AT CANTILEVER SHADE STRUCTURE | |
| 47 SEATING ISLAND AT PODIUM DECK | |
| 48 BBQ AT OUTDOOR KITCHEN | |
| 49 WATER FEATURE AT COURTYARD A | |
| 50 WATER FEATURE AT COURTYARD B | |
| 51 FESTOON LIGHTS | |
| 52 BBQ AT OUTDOOR KITCHEN | |
| 53 PIZZA OVEN AT OUTDOOR KITCHEN | |
| 54 PORCH SWING AT COURTYARD B | |

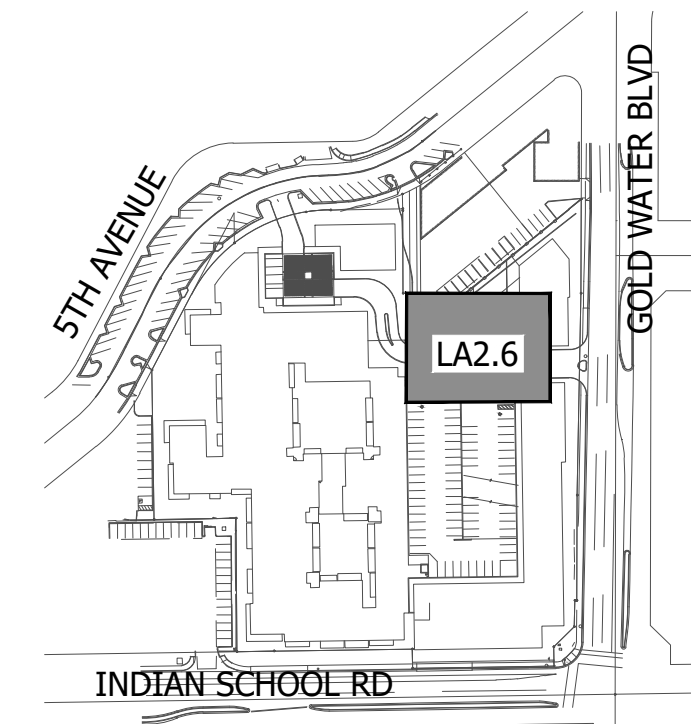

KEY MAP

NOT TO SCALE

PLANT MATERIALS LEGEND

Tree	Cal (in.)	Height (Ft.)	Width (Ft.)	Box (in.)	Qty
Acacia aneura	.75"	6'	2'	24"	
Mulga Acacia					
Acacia smallii	1"	5'	3'	24"	
Sweet Acacia					
Acacia stenophylla	1"	8'	3'	24"	
Shoestring Acacia					
Acacia willardiana	1"	5'	2.5'	24"	
Cascalote					
Chilopsis linearis	1"	5'	3'	24"	
Desert Willow					
Eucalyptus papuana	1.25"	7'	3'	24"	
Ghost Gum					
Jacaranda mimosifolia	1"	7'	3'	24"	
Jacaranda					
Lysiloma microphylla	.75"	5'	3'	24"	
Desert Fern					
Olea europaea 'Wilsonii'	N/A	6'	3'	24"	
Wilsonii Olive					
Olneya tesota	N/A	4'	2.5'	24"	
Desert Ironwood					
Parkinsonia hybrid 'Desert Museum' 1"	5'	3'	24"		
Desert Museum Palo Verde					
Parkinsonia praecox	1"	5'	3'	24"	
Palo Brea					
Phoenix dactylifera	N/A	18'	TO PINEAPPLE		
Date Palm					
Pistacia chinensis	1"	7'	2.5'	24"	
Chinese Pistache					
Pistacia lentiscus	1"	7'	2.5'	24"	
Mastic Tree					
Prosopis alba	1"	6'	3'	24"	
Argentine Mesquite					
Prosopis chilensis	1.25"	5'	6'	24"	
Chilean Mesquite					
Prosopis glandulosa	1"	5'	3'	24"	
Thornless Honey Mesquite					
Prosopis hybrid	1.25"	5'	6'	24"	
Thornless Mesquite					
Quercus virginiana 'Joan Lionetti'	1"	7'	3'	24"	
'Joan Lionetti' Live Oak					
Sophora secundiflora	0.75"	3'	2'	24"	
Texas Mountain Laurel					
Ulmus parvifolia 'Allee'	1"	7'	3'	24"	
Allee Elm					
Ulmus parvifolia 'Bosque'	1"	7'	3'	24"	
Bosque Elm					
Vitex agnus-castus	N/A	5'	3'	24"	
Chaste Tree					
Washingtonia filifera	N/A	18'	TO PINEAPPLE		
California Fan Palm					
Washingtonia robusta	N/A	18'	TO PINEAPPLE		
Mexican Fan Palm					



Extra Large Shrubs	Size	Qty	Large Shrubs	Size	Qty
Bk- Bougainvillea 'Barbara Karst'			AK- Aquilegia chrysantha		
Barbara Karst Bougainvillea	5 gal.		Golden Columbine	5 gal.	
Bougainvillea 'California Gold'			CV- Calliandra californica		
California Gold Bougainvillea	5 gal.		Red Fairy Duster	5 gal.	
Bougainvillea 'Rosenka'			CS- Cassia artemisioides 'Silver'		
Rosenka Bougainvillea	5 gal.		Silver Cassia	5 gal.	
Caesalpinia mexicana			JB- Justicia californica		
Mexican Bird of Paradise	5 gal.		Yellow Chuparosa	5 gal.	
Caesalpinia pulcherrima			LY- Leucophyllum langmaniae 'Lynn's Legacy'		
Red Bird of Paradise	5 gal.		Lynn's Legacy Sage	5 gal.	
Chamaerops humilis			RB- Leucophyllum langmaniae 'Rio Bravo'		
Mediterranean Fan Palm	3 head		Rio Bravo Sage	5 gal.	
Cordia parvifolia			LJ- Ligustrum japonicum		
Little Leaf Cordia	5 gal.		Japanese Privet	5 gal.	
Dodonaea viscosa			CL- Salvia clevelandii		
Green Hopseed Bush	5 gal.		Chaparral Sage	5 gal.	
Psoralea schottii			SC- Simmondsia chinensis		
Indigo Bush	5 gal.		Jojoba	15 gal.	
Tecoma alata 'Orange Jubilee'					
Orange Jubilee	15 gal.				
Tecoma 'Sparky'					
Sparky Bells	5 gal.				
Tecoma Stans					
Yellow Bells	15 gal.				
Vauquelinia californica					
Arizona Rosewood	15 gal.				

Medium Shrubs	Size	Qty	Cacti/ Accents	Size	Qty
B- Bougainvillea 'Torch Glow'			AG- Agave americana 'Marginata'		
Torch Glow Bougainvillea	5 gal.		Century Plant	5 gal.	
Eremophila glabra spp. carnea			AB- Aloe barbadensis		
Winter Blaze	5 gal.		Medicinal Aloe	5 gal.	
Eremophila hygrophana Blue Bells			AF- Aloe ferox		
Blue Bells	5 gal.		Tree Aloe	5 gal.	
J- Justicia candicans			Aloe hyb. 'Blue Elf'		
Red Justicia	5 gal.		Blue Elf Aloe	5 gal.	
L- Lantana camara			Aloe striata		
Bush Lantana	1 gal.		Coral Aloe	5 gal.	
Leucophyllum frutescens 'Compacta'			Bouteloua gracilis		
Compact Texas Sage	5 gal.		Blonde Ambition	1 gal.	
N- Nerium oleander 'Little Red'			C- Calamagrostis acutiflora		
Little Red Oleander	5 gal.		Karl Foerster Grass	3 gal.	
Nerium oleander 'Petite Pink'			D- Dasylium acrotrichum		
Petite Pink Oleander	5 gal.		Green Desert Spoon	5 gal.	
P- Punica granatum			D- Dasylium wheeleri		
Dwarf Pomegranate	5 gal.		Desert Spoon	5 gal.	
R- Rosmarinus officinalis 'Tuscan Blue'			E- Echinocactus grusonii		
Tuscan Blue Rosemary	5 gal.		Golden Barrel Cactus	5 gal.	
Ruella brittoniana			E- Euphorbia antisyphilitica		
Purple Ruella	5 gal.		Candelilla	1 gal.	
Ruella peninsularis			E- Euphorbia rigida		
Desert Ruella	5 gal.		Gopher Plant	5 gal.	
T- Teucrium fruticans			E- Euphorbia royleana		
Bush Germander	5 gal.		Churee	5 gal.	
Small Shrubs	Size	Qty	H- Hesperaloe parviflora 'Stoplights'		
B- Bougainvillea 'Alexandra'			Stoplights Red Yucca	3 gal.	
Alexandra Bougainvillea	5 gal.		M- Muhlenbergia capillaris		
C- Callistemon viminalis 'Little John'			'Regal Mist'	5 gal.	
Little John Bottle Brush	5 gal.		M- Muhlenbergia lindheimeri		
G- Gaura lindheimeri			'Autumn Glow'	5 gal.	
Siskiyou Pink Gaura	1 gal.		M- Muhlenbergia rigens		
Myrtus communis 'compacta'			Deer Grass	1 gal.	
Dwarf Myrtle	5 gal.		O- Opuntia basilaris		
Olea europaea 'Little Ollie'			Beavertail Prickly Pear	5 gal.	
Coral Olive	5 gal.		O- Opuntia santa rita		
Russelia equisetiformis			Purple Prickly Pear	5 gal.	
Coral Fountain	5 gal.		O- Opuntia sp. Kelly's Choice		
Salvia leucantha			Kelly's Choice Prickly Pear	5 gal.	
Mexican Bush Sage	1 gal.		P- Pachycereus marginatus		
T- Teucrium chamaedrys			Mexican Fence Post Cactus	5 gal.	
Germander	1 gal.		P- Pedilanthus macrocarpus		
Groundcovers	Size	Qty	S- Penstemon eatonii		
Baileya multiradiata			Firecracker Penstemon	1 gal.	
Desert Marigold	1 gal.		P- Portulacaria afra minima		
Dalea capitata 'Sierra Gold'			Dwarf Elephant Food	5 gal.	
Sierra Gold Dalea	1 gal.		Y- Yucca baccata		
E- Eremophila prostrata			Banana Yucca	5 gal.	
Outback Sunrise Eremophila	1 gal.		Y- Yucca pallida		
Gazania rigens 'Sun Gold'			Pale Leaf Yucca	5 gal.	
Trailing Yellow Gazania	1 gal.		Y- Yucca recurvifolia		
L- Lantana montevidensis			Soft Leaf Yucca	15 gal.	
Purple Trailing Lantana	1 gal.				
Y- Lantana sp.					
'New Gold' Lantana	1 gal.				
L- Lantana sp.					
'New Red' Lantana	1 gal.				
R- Rosmarinus officinalis 'Prostratus'					
Trailing Rosemary	1 gal.				
R- Ruella 'Katie'					
Dwarf Ruella 'Katie'	1 gal.				
T- Teucrium chamaedrys 'prostratum'					
Prostrate Germander	1 gal.				
W- Wedelia trilobata					
Wedelia	1 gal.				

NOTES:
1. QUANTITIES SHOWN FOR SUBMITTAL PURPOSES ONLY.
2. ALL QUANTITIES SHOWN ARE FOR THE LANDSCAPE ARCHITECT'S ESTIMATING PURPOSES ONLY AND THEREFORE ARE NOT GUARANTEED. THE CONTRACTOR SHALL CALCULATE QUANTITIES BASED ON THIS DRAWING SET.
3. ALL TREES SHALL COMPLY WITH THE LATEST AMENDED EDITION OF THE "ARIZONA NURSERY ASSOCIATION - RECOMMENDED TREE SPECIFICATIONS."



PLANT MATERIALS LEGEND

Tree	Cal (in.)	Height (Ft.)	Width (Ft.)	Box (in.)	Qty
Acacia aneura	.75"	6'	2'	24"	
Mulga Acacia					
Acacia smallii	1"	5'	3'	24"	
Sweet Acacia					
Acacia stenophylla	1"	8'	3'	24"	
Shoestring Acacia					
Acacia willardiana	1"	5'	2.5'	24"	
Palo Blanco					
Bauhinia x blakeana	1.25"	7'	2.5'	24"	
Hong Kong Orchid					
Caesalpinia cacalaco	1"	5'	3'	24"	
Cascalote					
Chilopsis linearis	1"	5'	3'	24"	
Desert Willow					
Eucalyptus papuana	1.25"	7'	3'	24"	
Ghost Gum					
Jacaranda mimosifolia	1"	7'	3'	24"	
Jacaranda					
Lysiloma microphylla	.75"	5'	3'	24"	
Desert Fern					
Olea europaea 'Wilsonii'	N/A	6'	3'	24"	
Wilsonii Olive					
Olneya tesota	N/A	4'	2.5'	24"	
Desert Ironwood					
Parkinsonia hybrid 'Desert Museum'	1"	5'	3'	24"	
Desert Museum Palo Verde					
Parkinsonia praecox	1"	5'	3'	24"	
Palo Brea					
Phoenix dactylifera	N/A	18' TO PINEAPPLE			
Date Palm					
Pistacia chinensis	1"	7'	2.5'	24"	
Chinese Pistache					
Pistacia lentiscus	1"	7'	2.5'	24"	
Mastic Tree					
Prosopis alba	1"	6'	3'	24"	
Argentine Mesquite					
Prosopis chilensis	1.25"	5'	6'	24"	
Chilean Mesquite					
Prosopis glandulosa	1"	5'	3'	24"	
Thornless Honey Mesquite					
Prosopis hybrid	1.25"	5'	6'	24"	
Thornless Mesquite					
Quercus virginiana 'Joan Lionetti'	1"	7'	3'	24"	
'Joan Lionetti' Live Oak					
Sophora secundiflora	0.75"	3'	2'	24"	
Texas Mountain Laurel					
Ulmus parvifolia 'Allee'	1"	7'	3'	24"	
Allee Elm					
Ulmus parvifolia 'Bosque'	1"	7'	3'	24"	
Bosque Elm					
Vitex agnus-castus	N/A	5'	3'	24"	
Chaste Tree					
Washingtonia filifera	N/A	18' TO PINEAPPLE			
California Fan Palm					
Washingtonia robusta	N/A	18' TO PINEAPPLE			
Mexican Fan Palm					

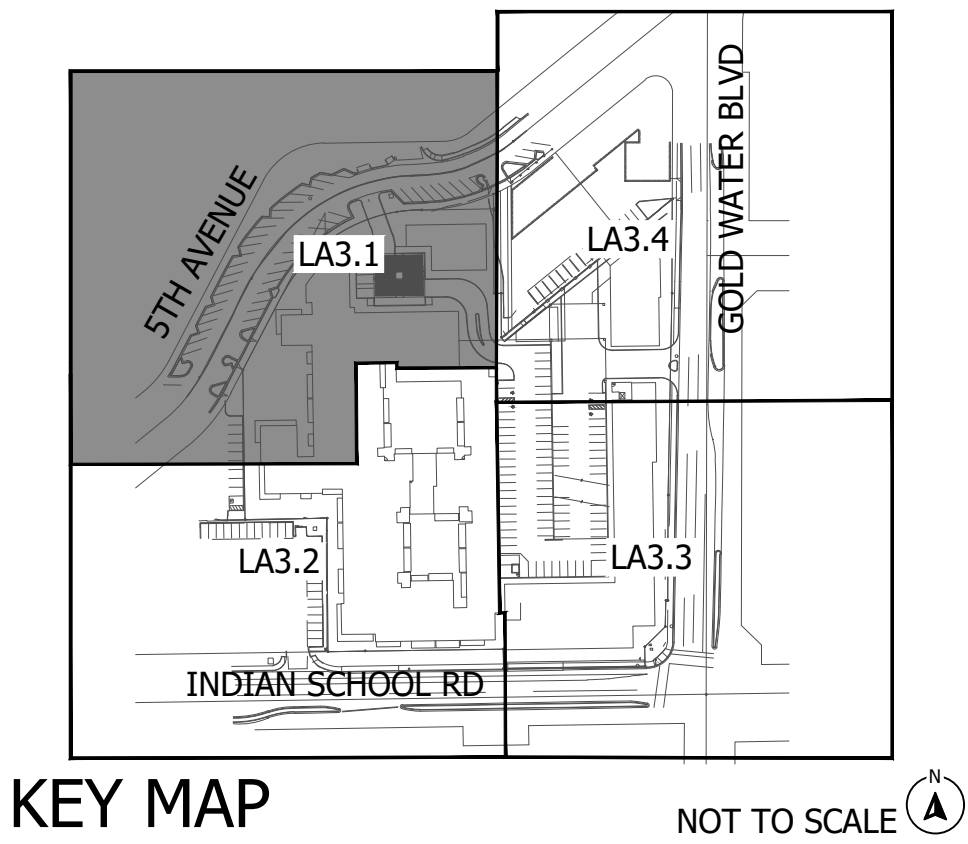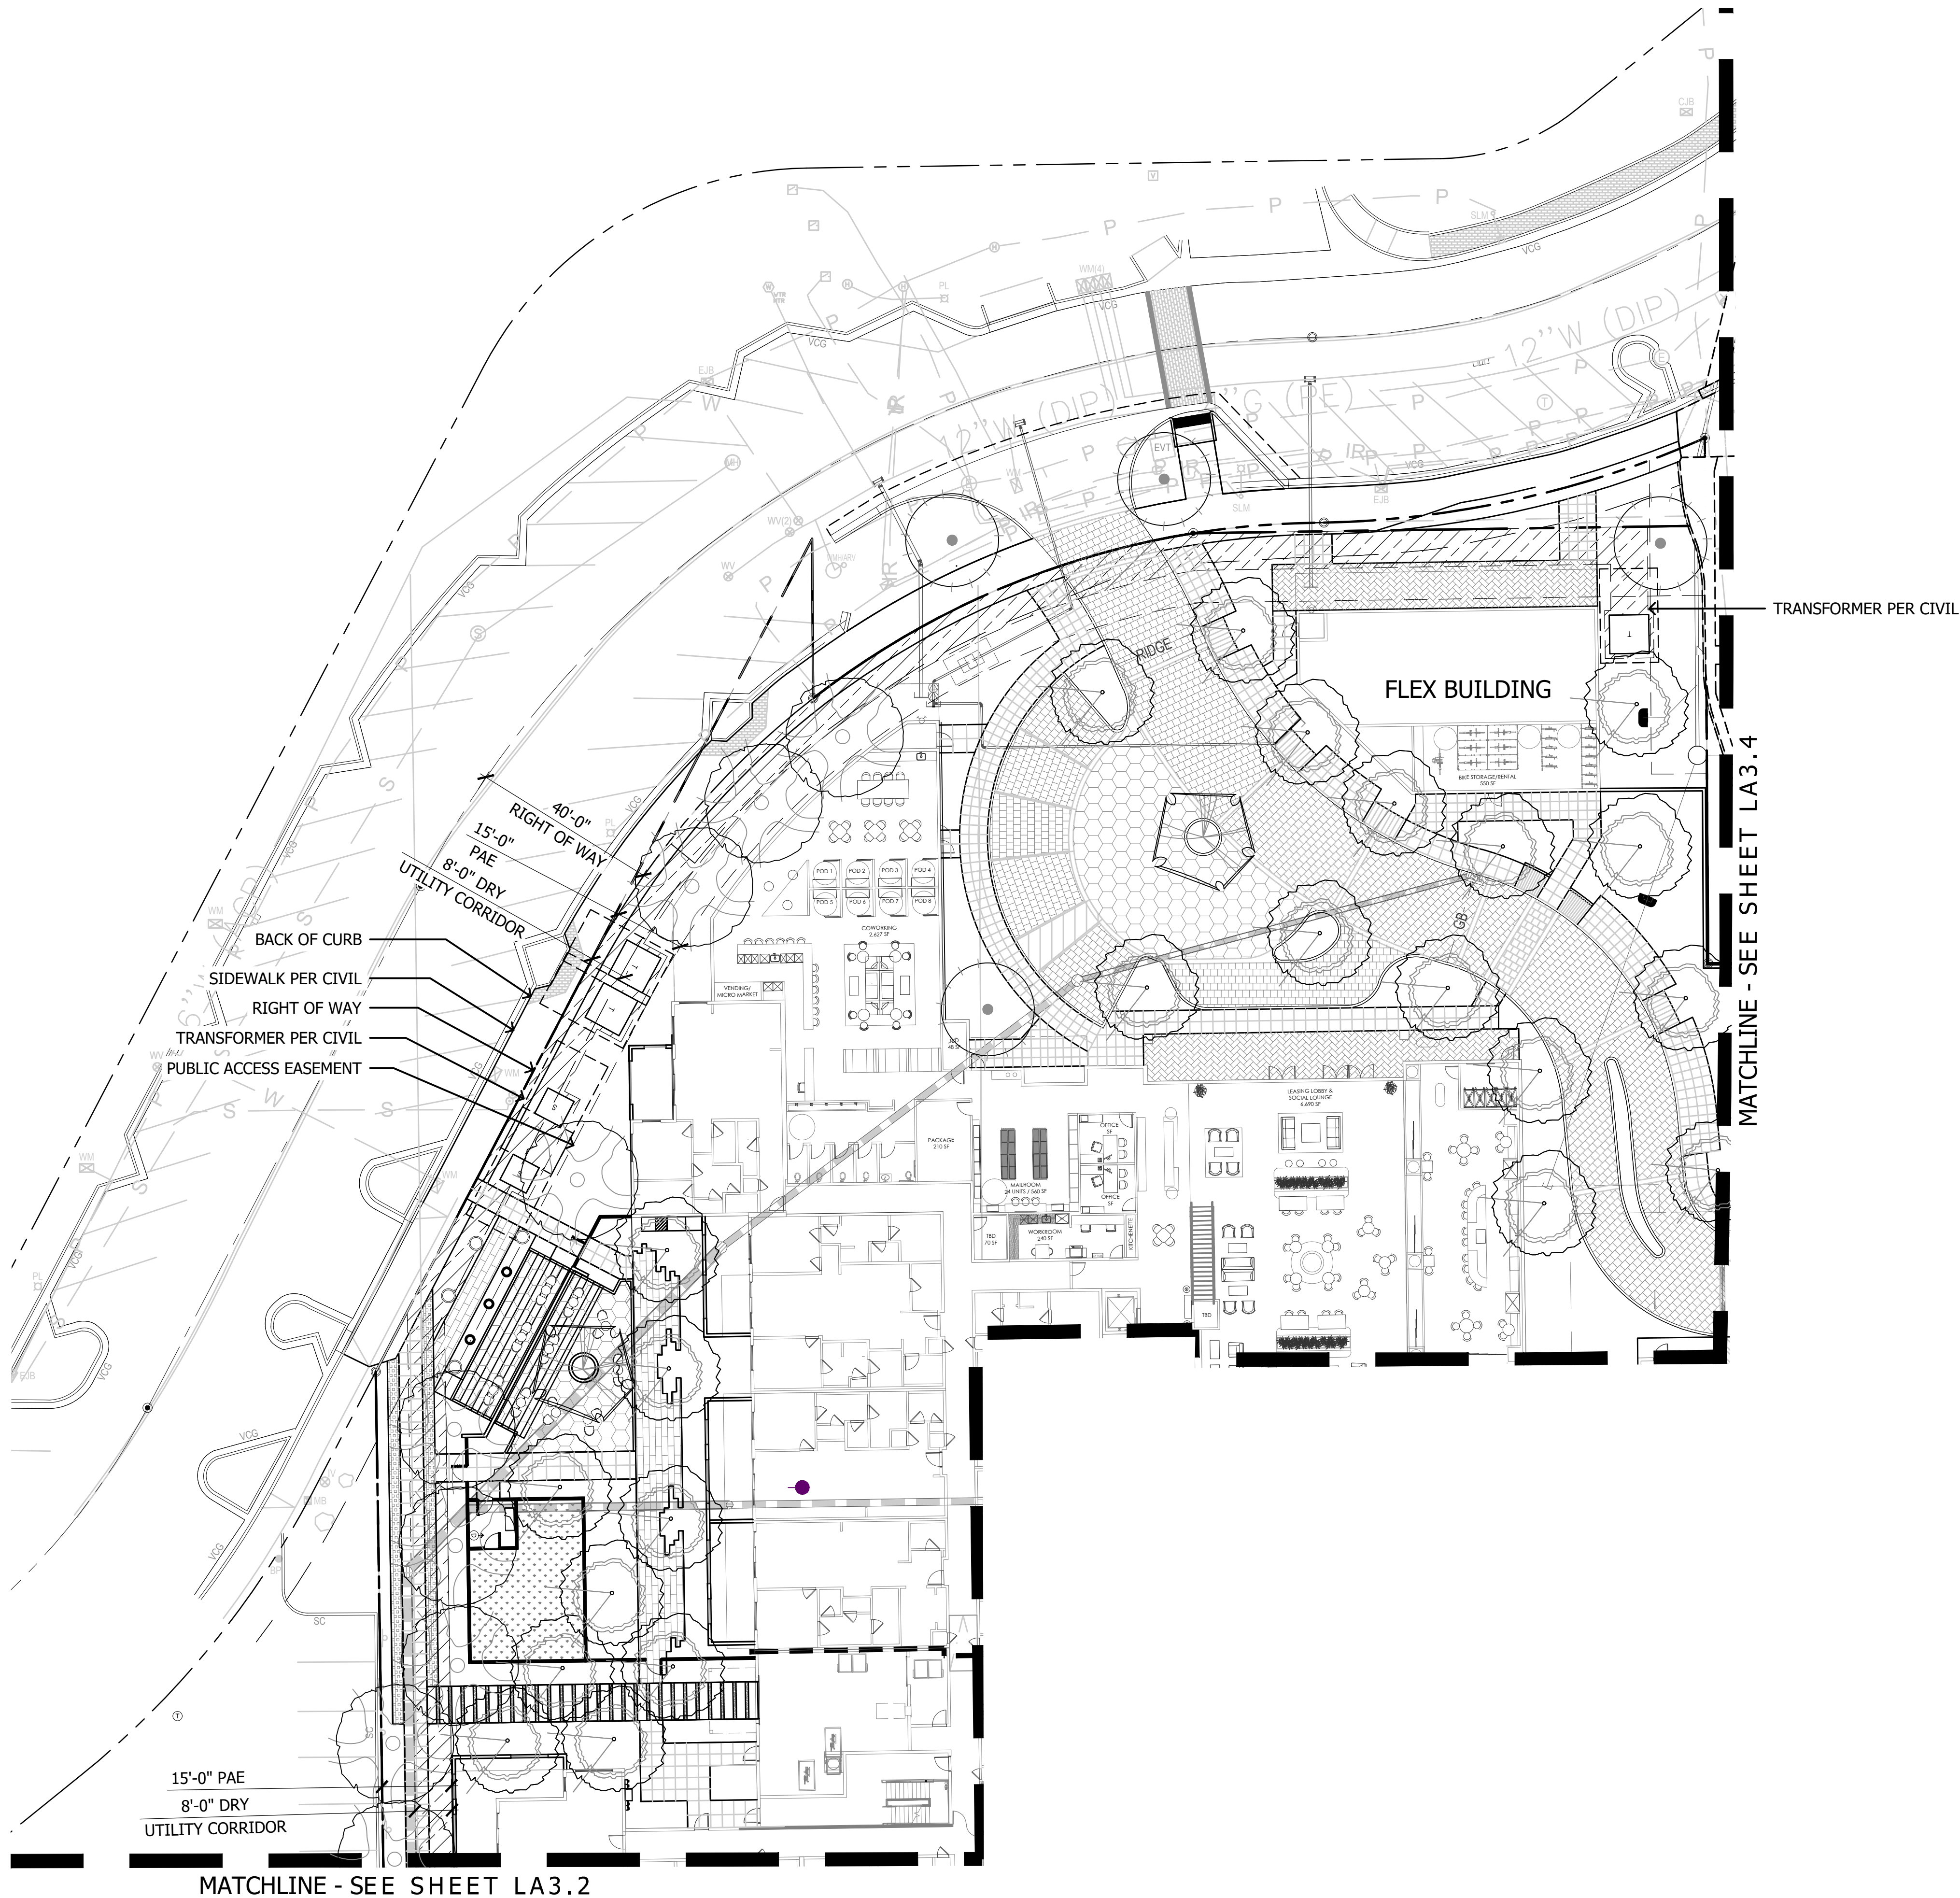

PLANT MATERIALS LEGEND

Tree	Cal (in.)	Height (Ft.)	Width (Ft.)	Box Qty (in.)
Acacia aneura	.75"	6'	2'	24"
Mulga Acacia				
Acacia smallii	1"	5'	3'	24"
Sweet Acacia				
Acacia stenophylla	1"	8'	3'	24"
Shoestring Acacia				
Acacia willardiana	1"	5'	2.5'	24"
Palo Blanco				
Bauhinia x blakeana	1.25"	7'	2.5'	24"
Hong Kong Orchid				
Caesalpinia cacalaco	1"	5'	3'	24"
Cascalote				
Chilopsis linearis	1"	5'	3'	24"
Desert Willow				
Eucalyptus papuana	1.25"	7'	3'	24"
Ghost Gum				
Jacaranda mimosifolia	1"	7'	3'	24"
Jacaranda				
Lysiloma microphylla	.75"	5'	3'	24"
Desert Fern				
Olea europaea 'Wilsonii'	N/A	6'	3'	24"
Wilsonii Olive				
Olneya tesota	N/A	4'	2.5'	24"
Desert Ironwood				
Parkinsonia hybrid 'Desert Museum'	1"	5'	3'	24"
Desert Museum Palo Verde				
Parkinsonia praecox	1"	5'	3'	24"
Palo Brea				
Phoenix dactylifera	N/A	18' TO PINEAPPLE		
Date Palm				
Pistacia chinensis	1"	7'	2.5'	24"
Chinese Pistache				
Pistacia lentiscus	1"	7'	2.5'	24"
Mastic Tree				
Prosopis alba	1"	6'	3'	24"
Argentine Mesquite				
Prosopis chilensis	1.25"	5'	6'	24"
Chilean Mesquite				
Prosopis glandulosa	1"	5'	3'	24"
Thornless Honey Mesquite				
Prosopis hybrid	1.25"	5'	6'	24"
Thornless Mesquite				
Quercus virginiana 'Joan Lionetti'	1"	7'	3'	24"
'Joan Lionetti' Live Oak				
Sophora secundiflora	0.75"	3'	2'	24"
Texas Mountain Laurel				
Ulmus parvifolia 'Allee'	1"	7'	3'	24"
Allee Elm				
Ulmus parvifolia 'Bosque'	1"	7'	3'	24"
Bosque Elm				
Vitex agnus-castus	N/A	5'	3'	24"
Chaste Tree				
Washingtonia filifera	N/A	18' TO PINEAPPLE		
California Fan Palm				
Washingtonia robusta	N/A	18' TO PINEAPPLE		
Mexican Fan Palm				

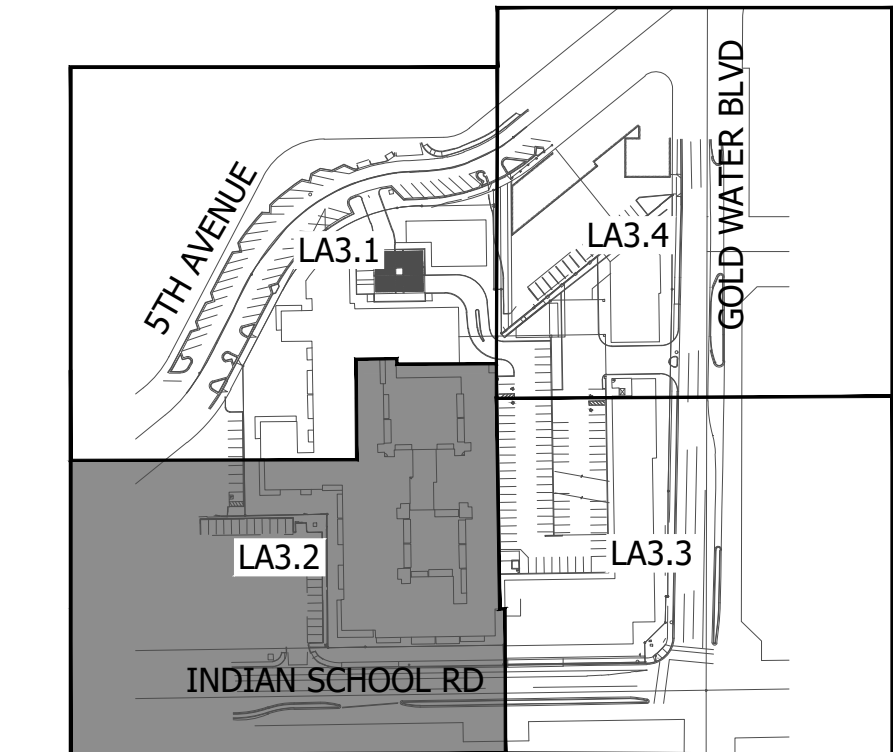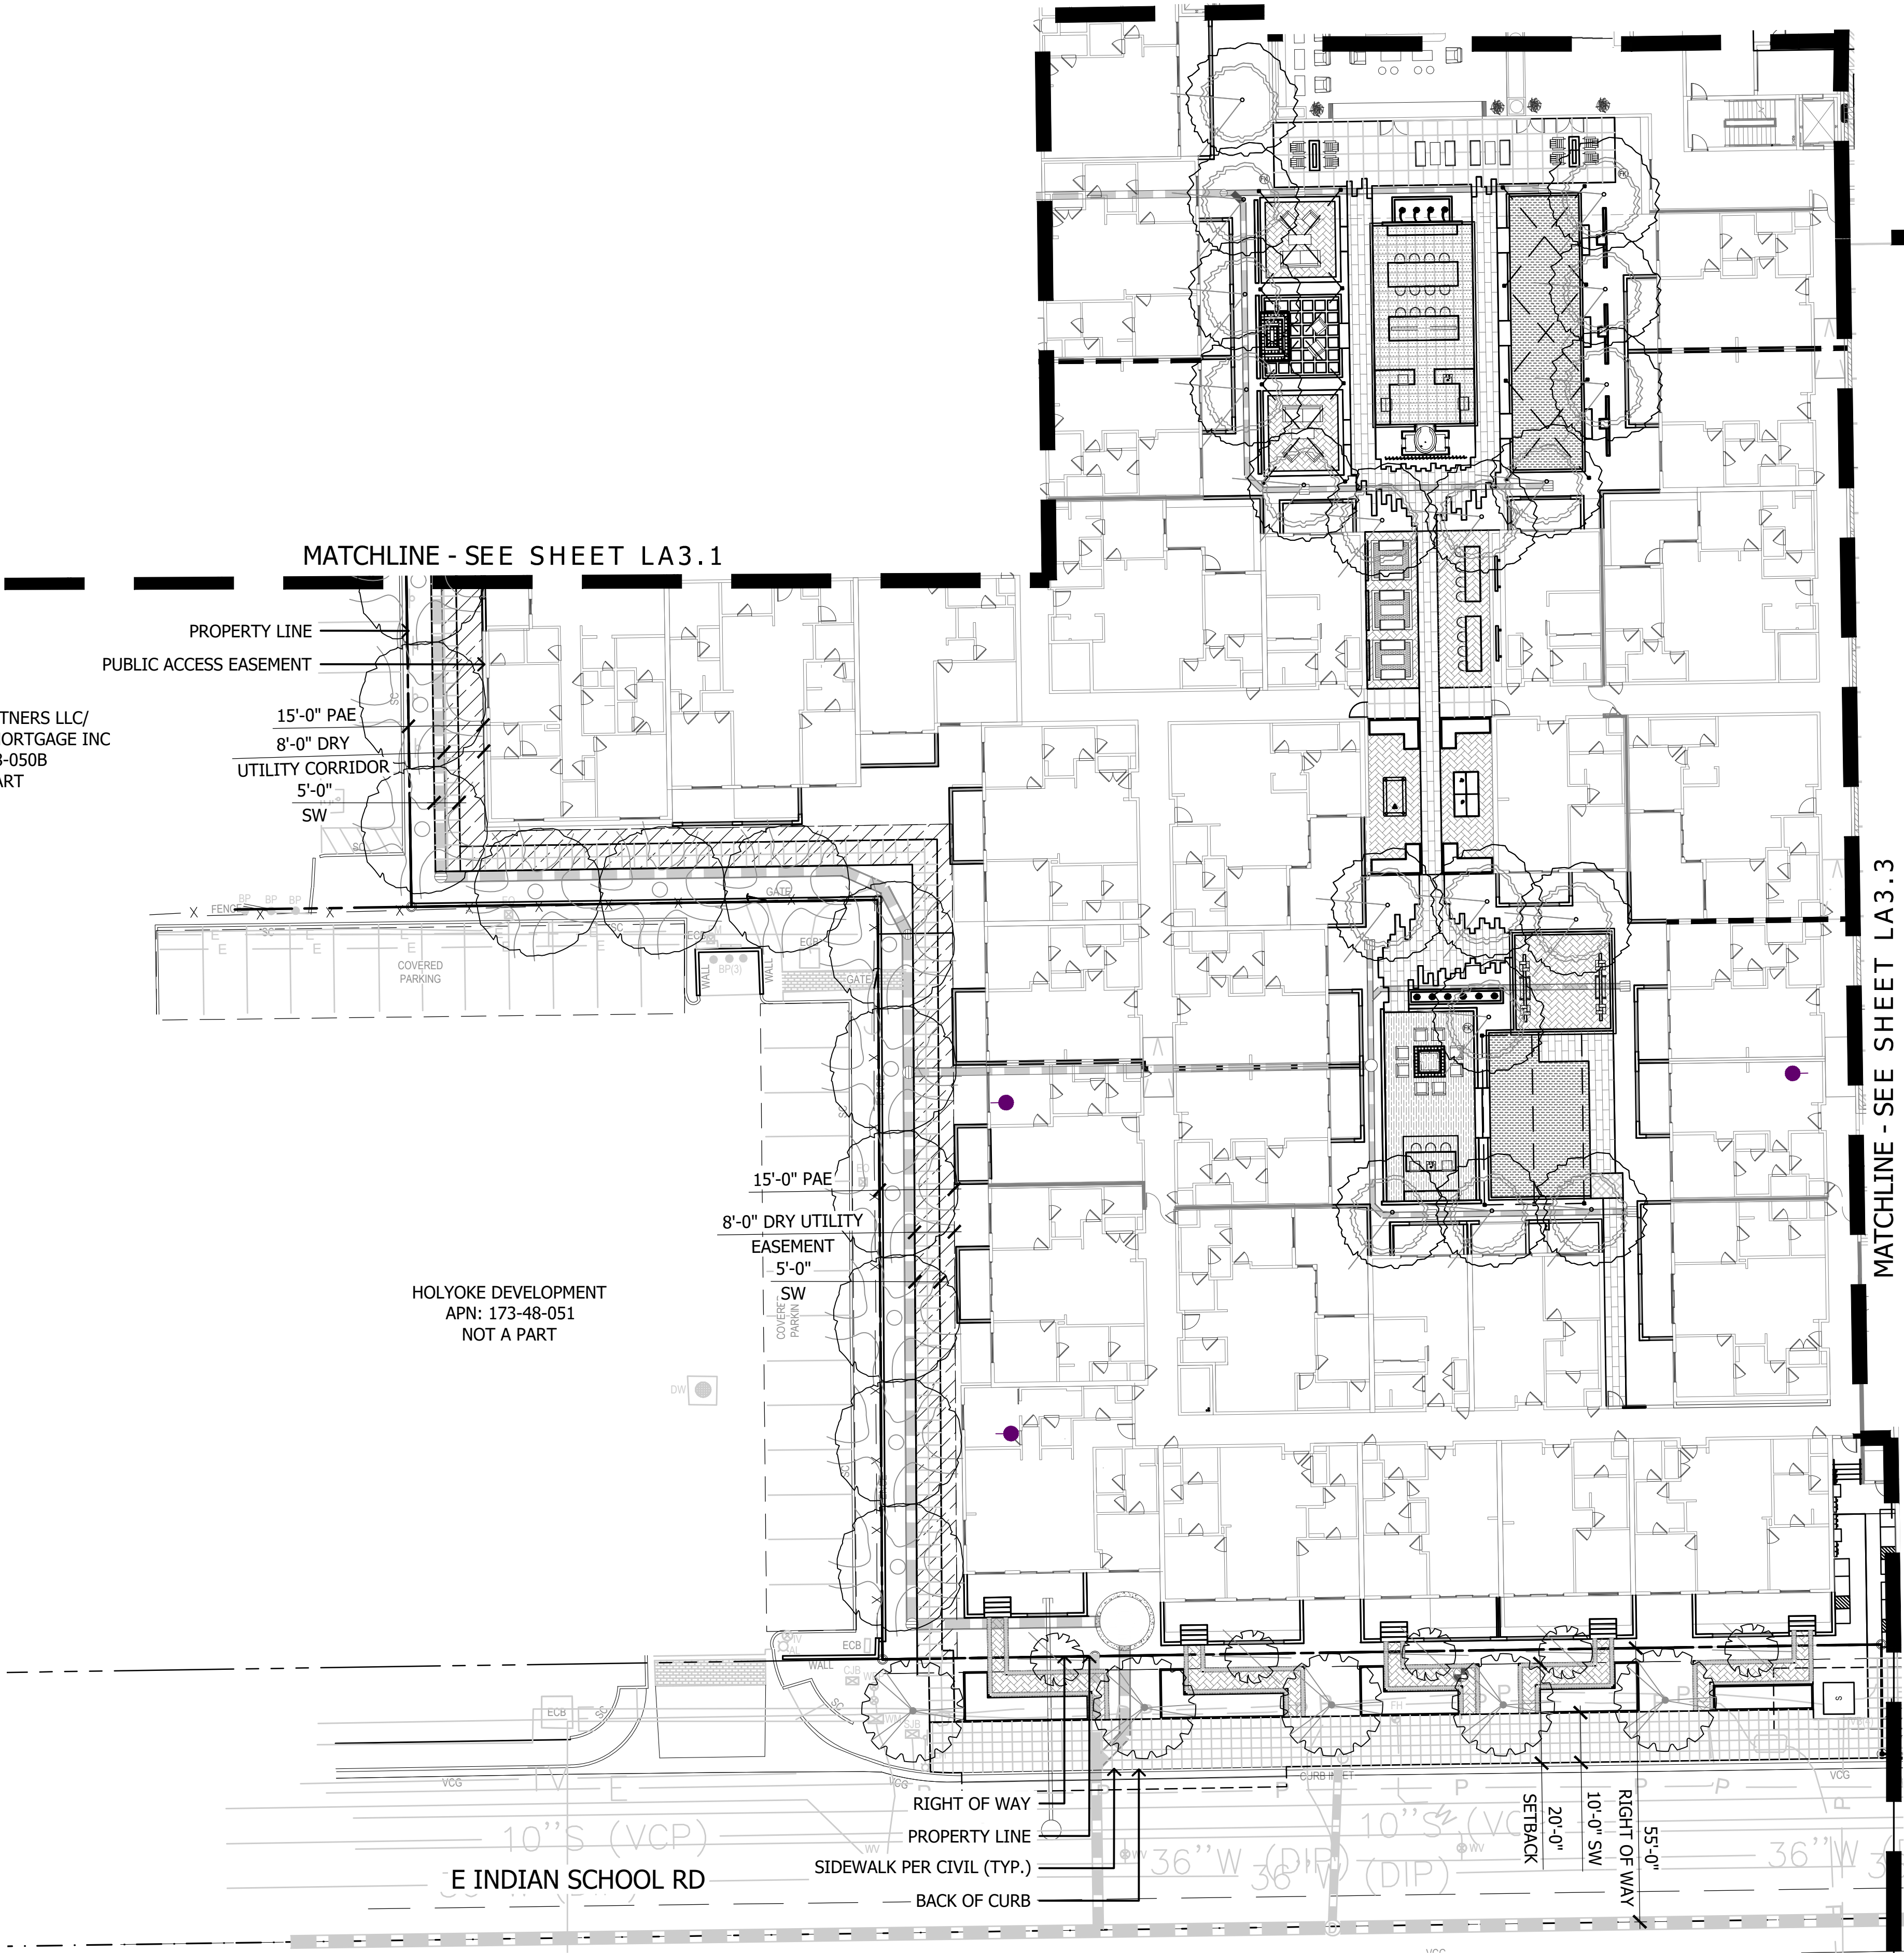


5TH & GOLDWATER
LA3.2 - Landscape Plan




ABLASTUDIO.COM



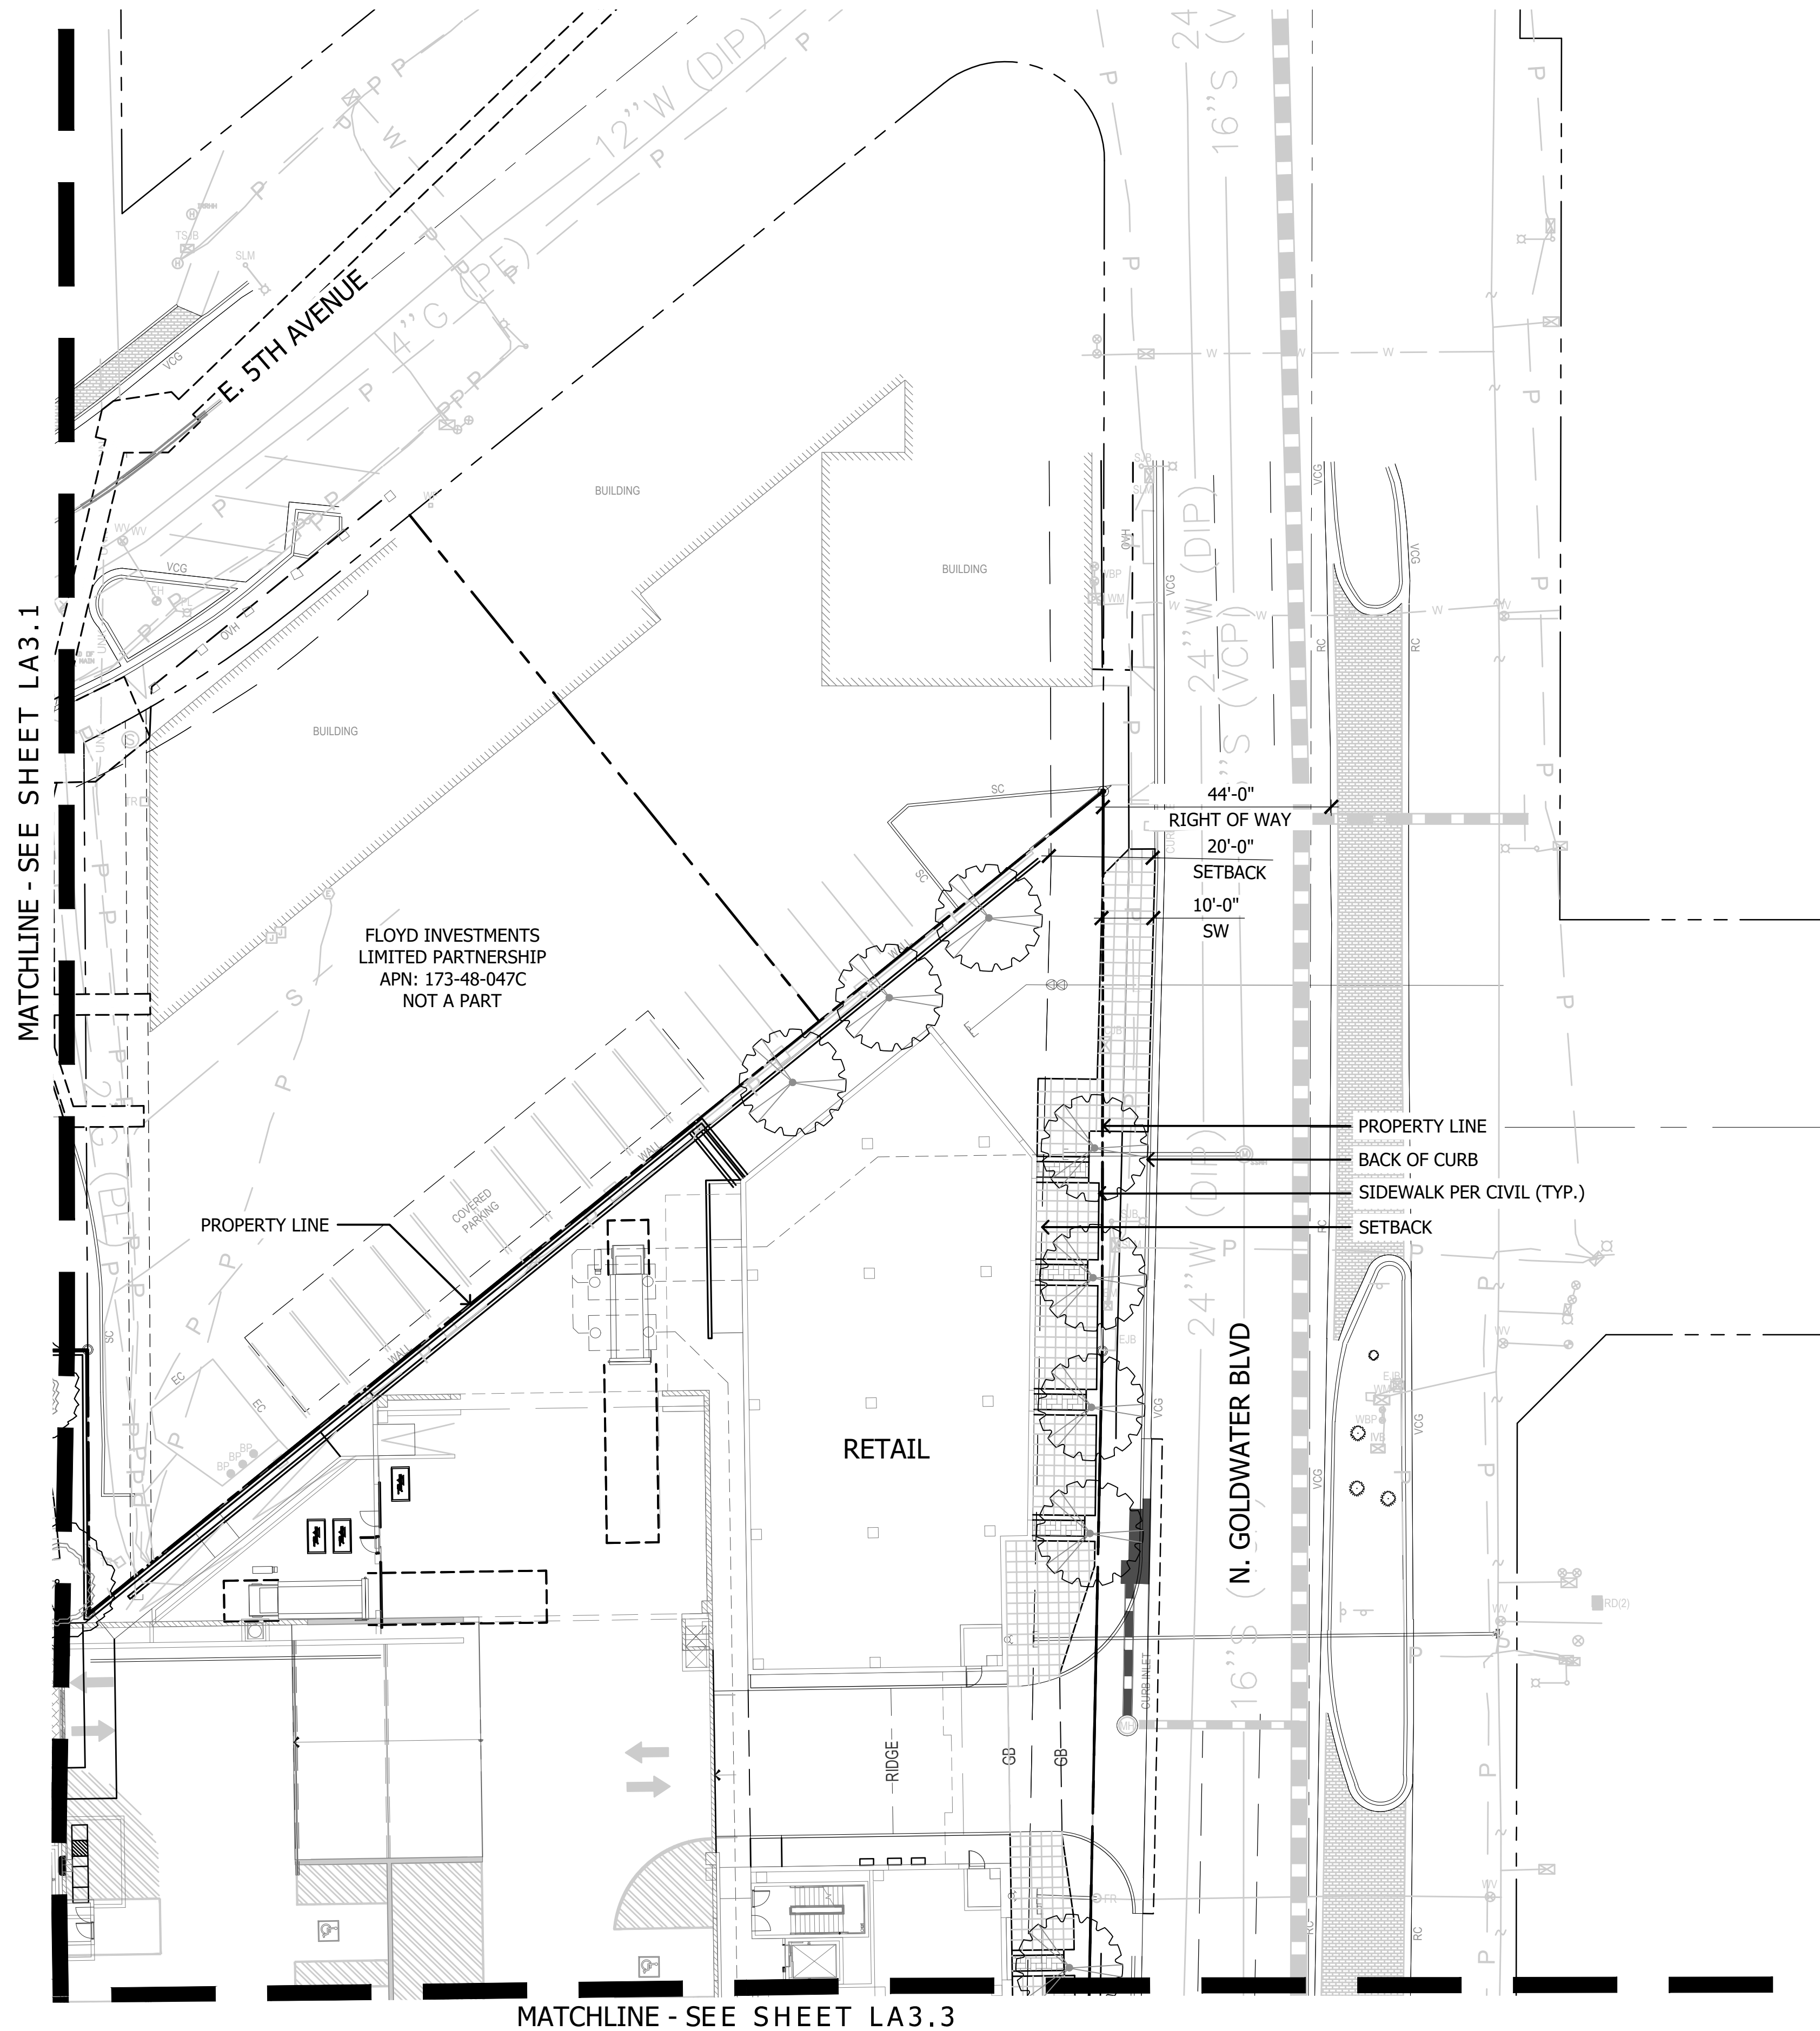

PLANT MATERIALS LEGEND


Tree	Cal (in.)	Height (Ft.)	Width (Ft.)	Box (in.)	Qty
Acacia aneura	.75"	6'	2'	24"	
Mulga Acacia					
Acacia smallii	1"	5'	3'	24"	
Sweet Acacia					
Acacia stenophylla	1"	8'	3'	24"	
Shoestring Acacia					
Acacia willardiana	1"	5'	2.5'	24"	
Palo Blanco					
Bauhinia x blakeana	1.25"	7'	2.5'	24"	
Hong Kong Orchid					
Caesalpinia cacalaco	1"	5'	3'	24"	
Cascalote					
Chilopsis linearis	1"	5'	3'	24"	
Desert Willow					
Eucalyptus papuana	1.25"	7'	3'	24"	
Ghost Gum					
Jacaranda mimosifolia	1"	7'	3'	24"	
Jacaranda					
Lysiloma microphylla	.75"	5'	3'	24"	
Desert Fern					
Olea europaea 'Wilsonii'	N/A	6'	3'	24"	
Wilsonii Olive					
Olneya tesota	N/A	4'	2.5'	24"	
Desert Ironwood					
Parkinsonia hybrid 'Desert Museum'	1"	5'	3'	24"	
Desert Museum Palo Verde					
Parkinsonia praecox	1"	5'	3'	24"	
Palo Brea					
Phoenix dactylifera	N/A	18' TO PINEAPPLE			
Date Palm					
Pistacia chinensis	1"	7'	2.5'	24"	
Chinese Pistache					
Pistacia lentiscus	1"	7'	2.5'	24"	
Mastic Tree					
Prosopis alba	1"	6'	3'	24"	
Argentine Mesquite					
Prosopis chilensis	1.25"	5'	6'	24"	
Chilean Mesquite					
Prosopis glandulosa	1"	5'	3'	24"	
Thornless Honey Mesquite					
Prosopis hybrid	1.25"	5'	6'	24"	
Thornless Mesquite					
Quercus virginiana 'Joan Lionetti'	1"	7'	3'	24"	
'Joan Lionetti' Live Oak					
Sophora secundiflora	0.75"	3'	2'	24"	
Texas Mountain Laurel					
Ulmus parvifolia 'Allee'	1"	7'	3'	24"	
Allee Elm					
Ulmus parvifolia 'Bosque'	1"	7'	3'	24"	
Bosque Elm					
Vitex agnus-castus	N/A	5'	3'	24"	
Chaste Tree					
Washingtonia filifera	N/A	18' TO PINEAPPLE			
California Fan Palm					
Washingtonia robusta	N/A	18' TO PINEAPPLE			
Mexican Fan Palm					

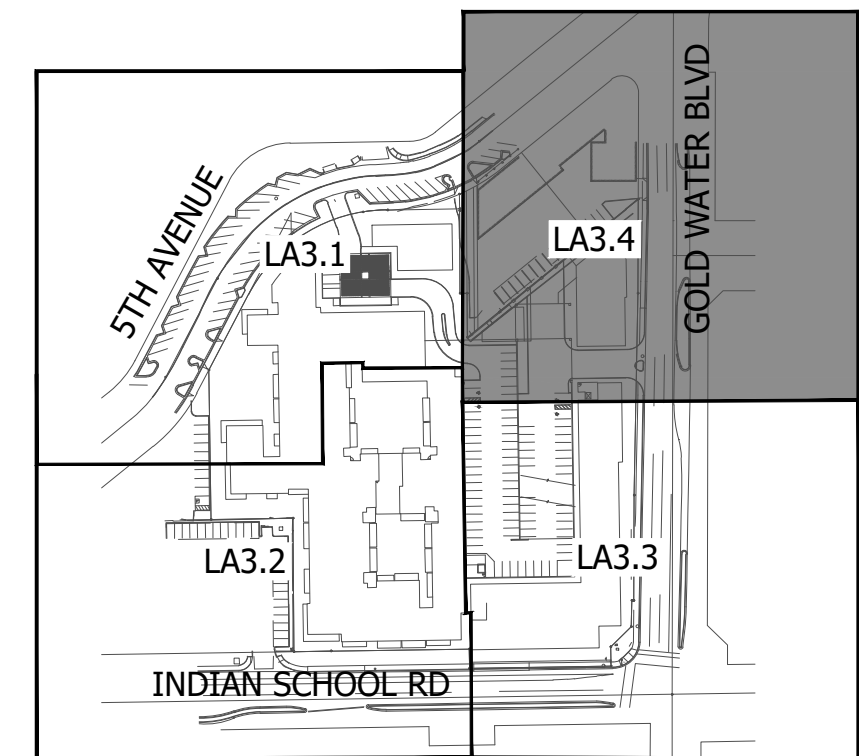


KEY MAP NOT TO SCALE

PLANT MATERIALS LEGEND


Tree	Cal (in.)	Height (Ft.)	Width (Ft.)	Box (in.)	Qty
Acacia aneura	.75"	6'	2'	24"	
Mulga Acacia					
Acacia smallii	1"	5'	3'	24"	
Sweet Acacia					
Acacia stenophylla	1"	8'	3'	24"	
Shoestring Acacia					
Acacia willardiana	1"	5'	2.5'	24"	
Palo Blanco					
Bauhinia x blakeana	1.25"	7'	2.5'	24"	
Hong Kong Orchid					
Caesalpinia cacalaco	1"	5'	3'	24"	
Cascalote					
Chilopsis linearis	1"	5'	3'	24"	
Desert Willow					
Eucalyptus papuana	1.25"	7'	3'	24"	
Ghost Gum					
Jacaranda mimosifolia	1"	7'	3'	24"	
Jacaranda					
Lysiloma microphylla	.75"	5'	3'	24"	
Desert Fern					
Olea europaea 'Wilsonii'	N/A	6'	3'	24"	
Wilsonii Olive					
Olneya tesota	N/A	4'	2.5'	24"	
Desert Ironwood					
Parkinsonia hybrid 'Desert Museum'	1"	5'	3'	24"	
Desert Museum Palo Verde					
Parkinsonia praecox	1"	5'	3'	24"	
Palo Brea					
Phoenix dactylifera	N/A	18' TO PINEAPPLE			
Date Palm					
Pistacia chinensis	1"	7'	2.5'	24"	
Chinese Pistache					
Pistacia lentiscus	1"	7'	2.5'	24"	
Mastic Tree					
Prosopis alba	1"	6'	3'	24"	
Argentine Mesquite					
Prosopis chilensis	1.25"	5'	6'	24"	
Chilean Mesquite					
Prosopis glandulosa	1"	5'	3'	24"	
Thornless Honey Mesquite					
Prosopis hybrid	1.25"	5'	6'	24"	
Thornless Mesquite					
Quercus virginiana 'Joan Lionetti'	1"	7'	3'	24"	
'Joan Lionetti' Live Oak					
Sophora secundiflora	0.75"	3'	2'	24"	
Texas Mountain Laurel					
Ulmus parvifolia 'Allee'	1"	7'	3'	24"	
Allee Elm					
Ulmus parvifolia 'Bosque'	1"	7'	3'	24"	
Bosque Elm					
Vitex agnus-castus	N/A	5'	3'	24"	
Chaste Tree					
Washingtonia filifera	N/A	18' TO PINEAPPLE			
California Fan Palm					
Washingtonia robusta	N/A	18' TO PINEAPPLE			
Mexican Fan Palm					

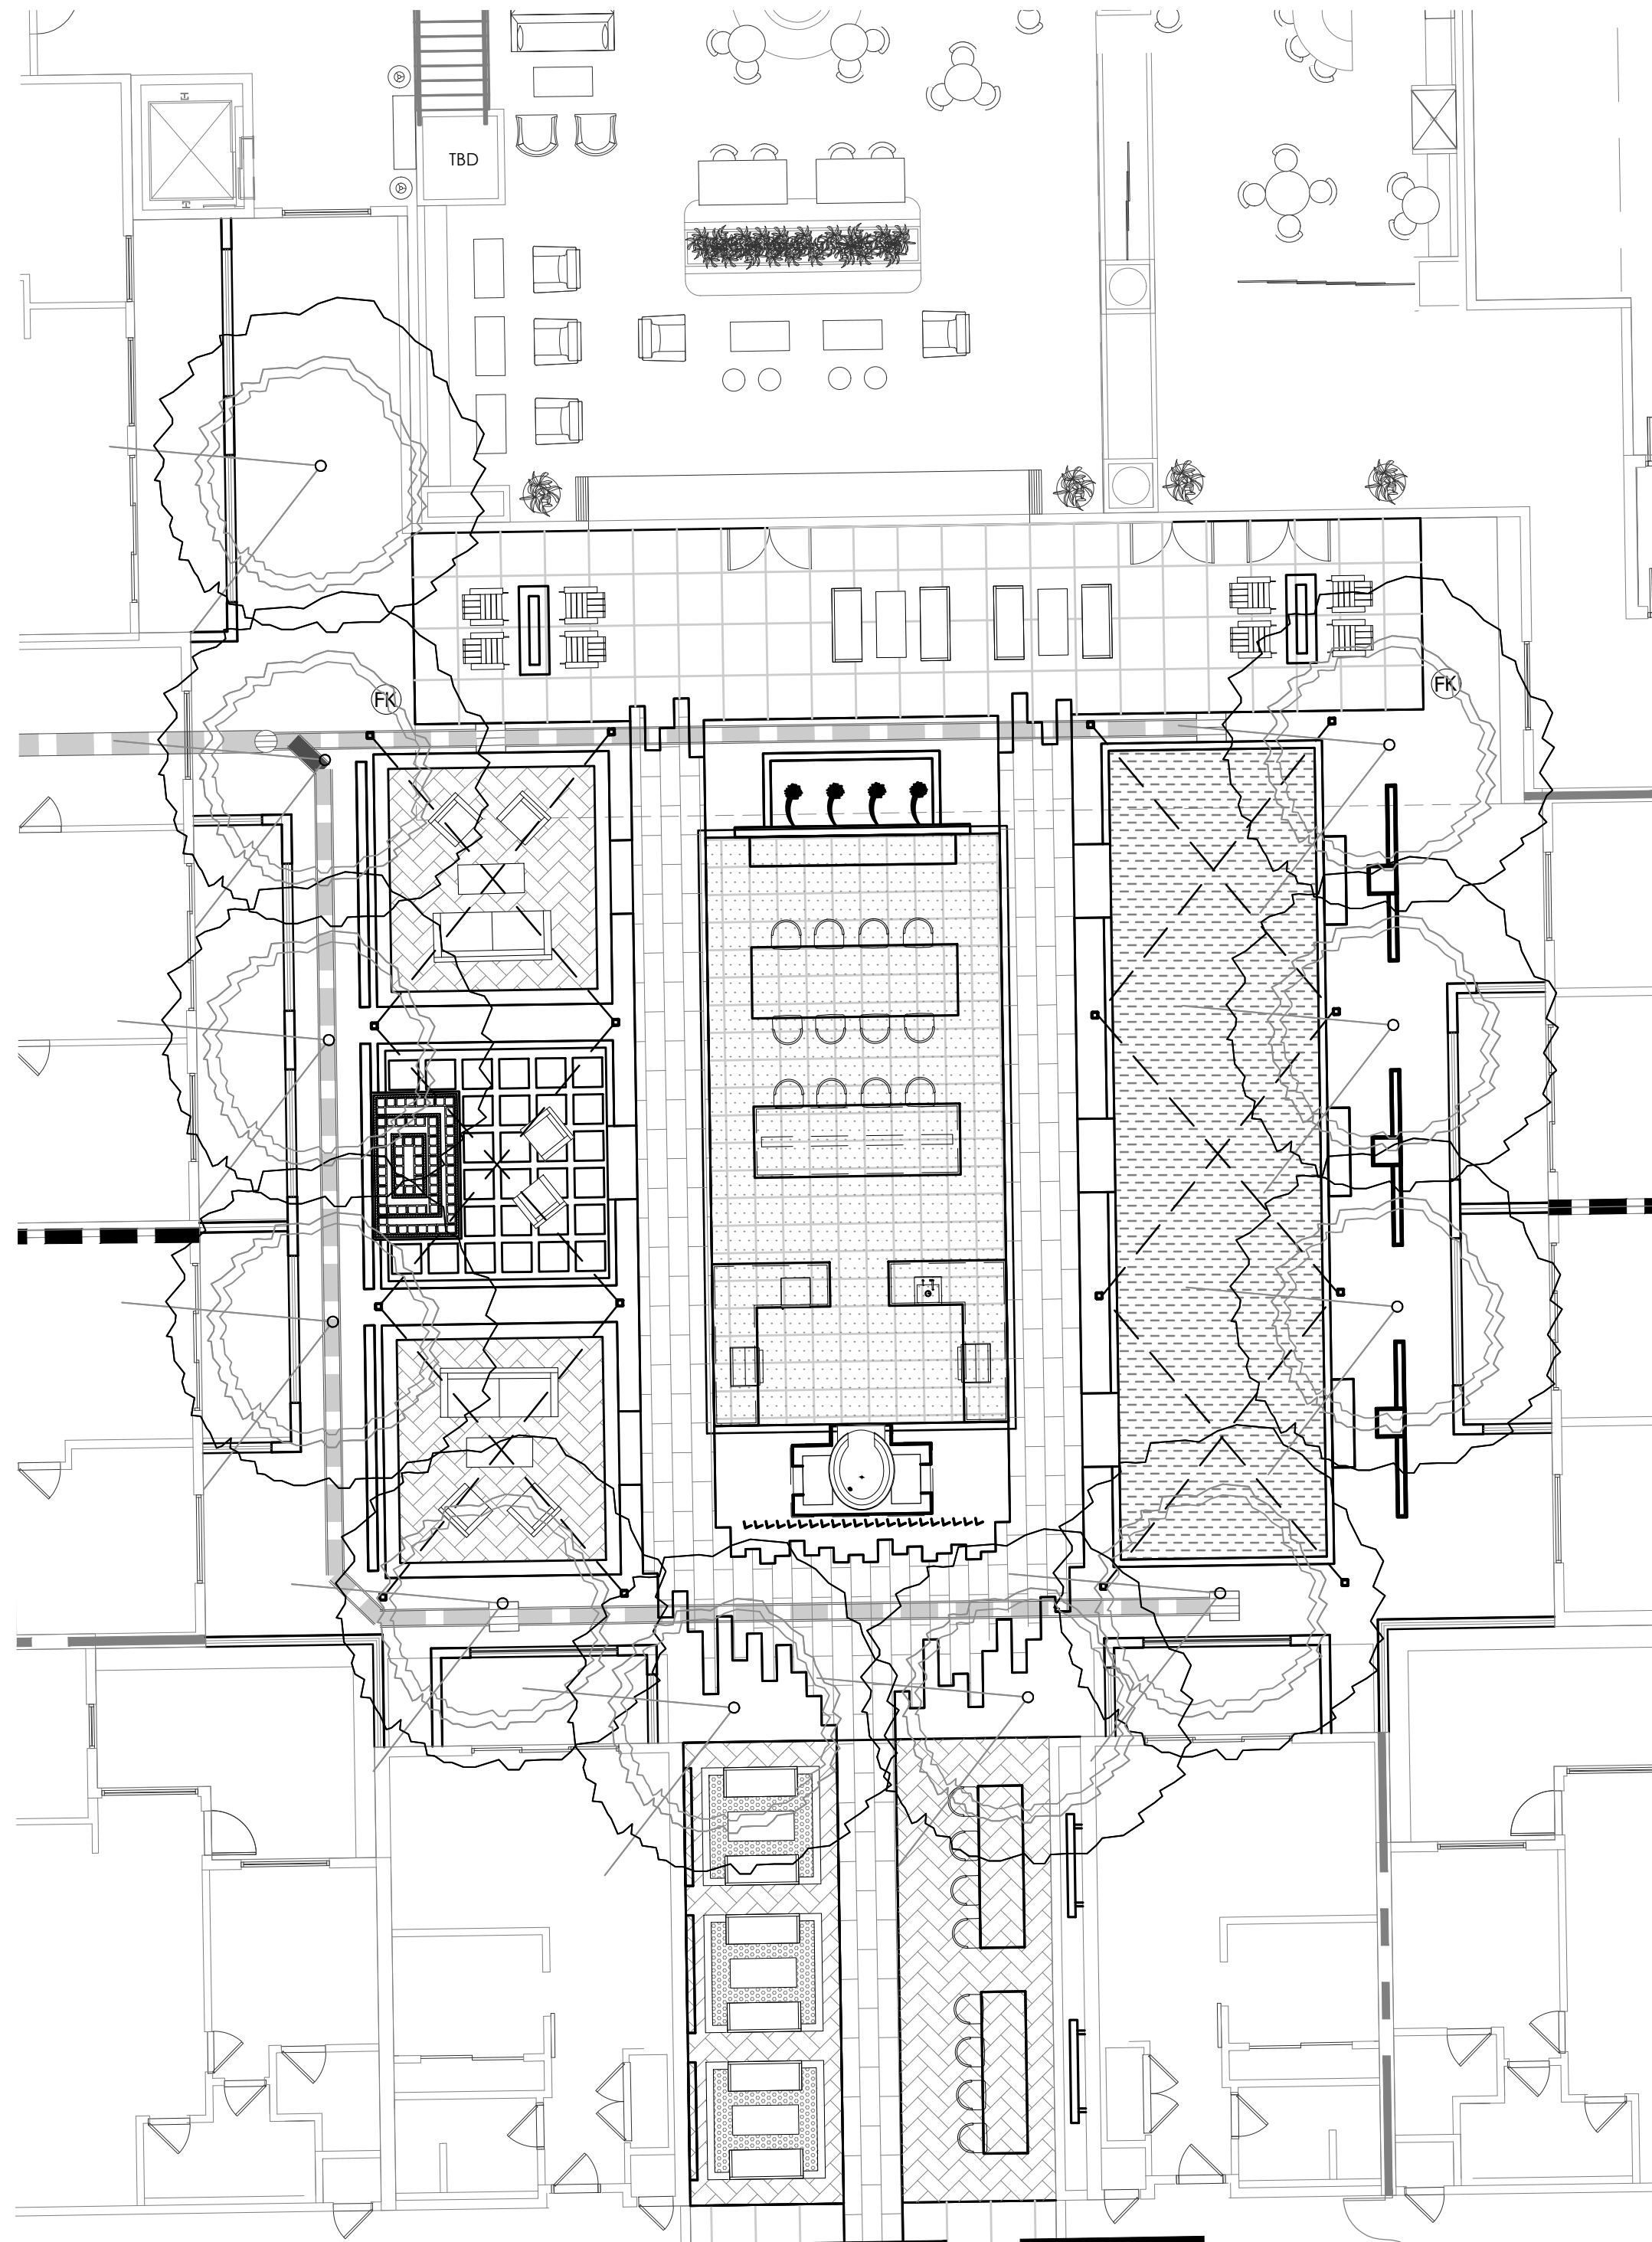

MATCHLINE - SEE ABOVE RIGHT

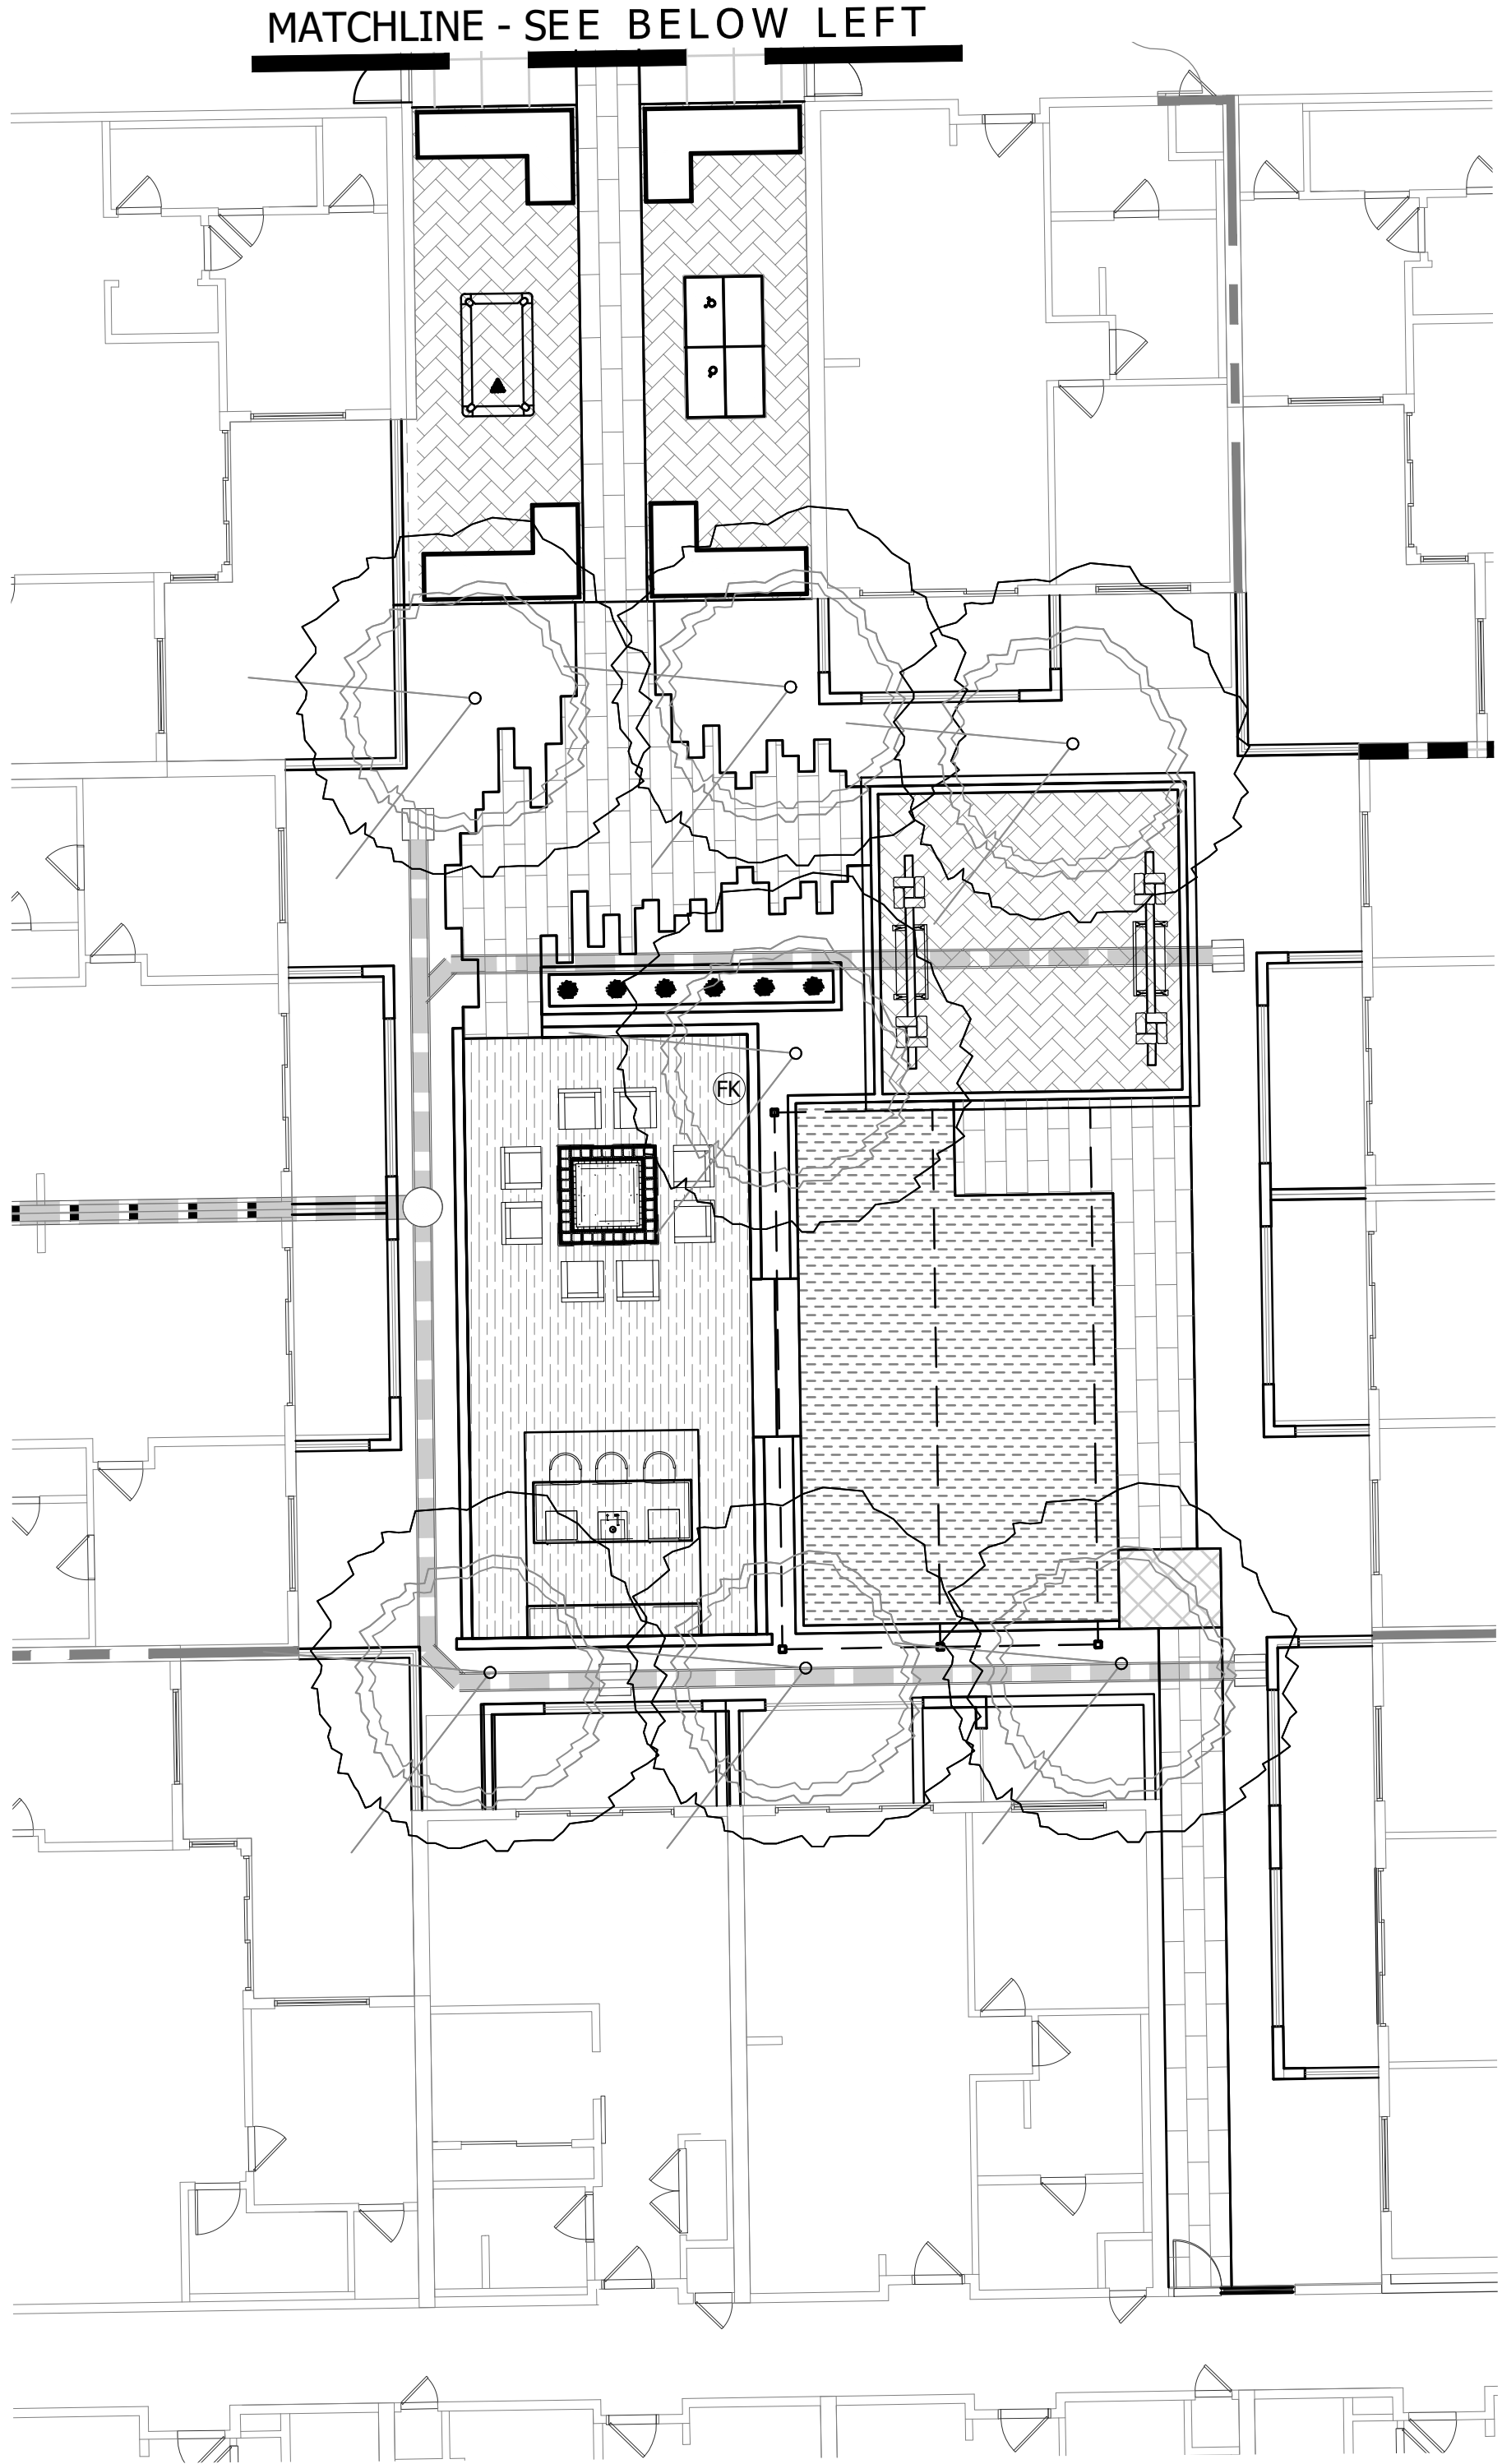


MATCHLINE - SEE BELOW LEFT

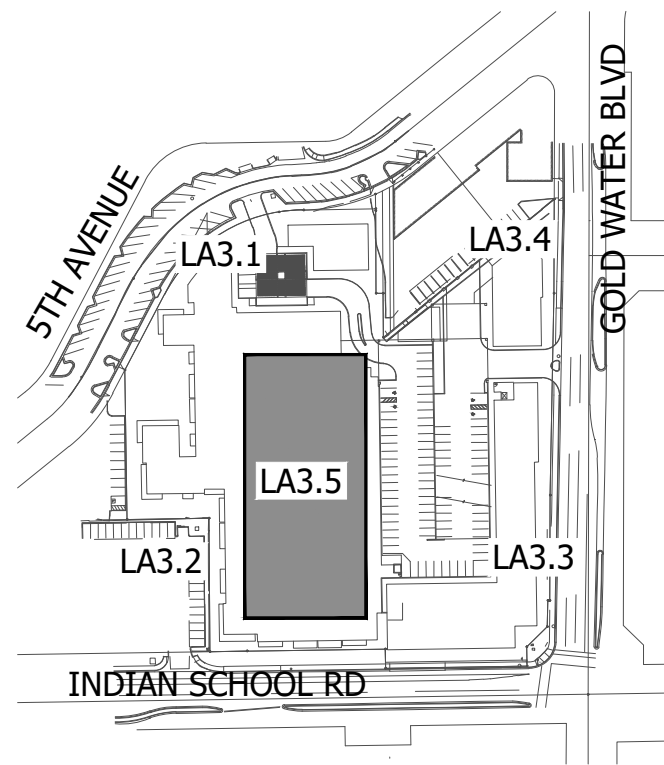


KEY MAP

NOT TO SCALE

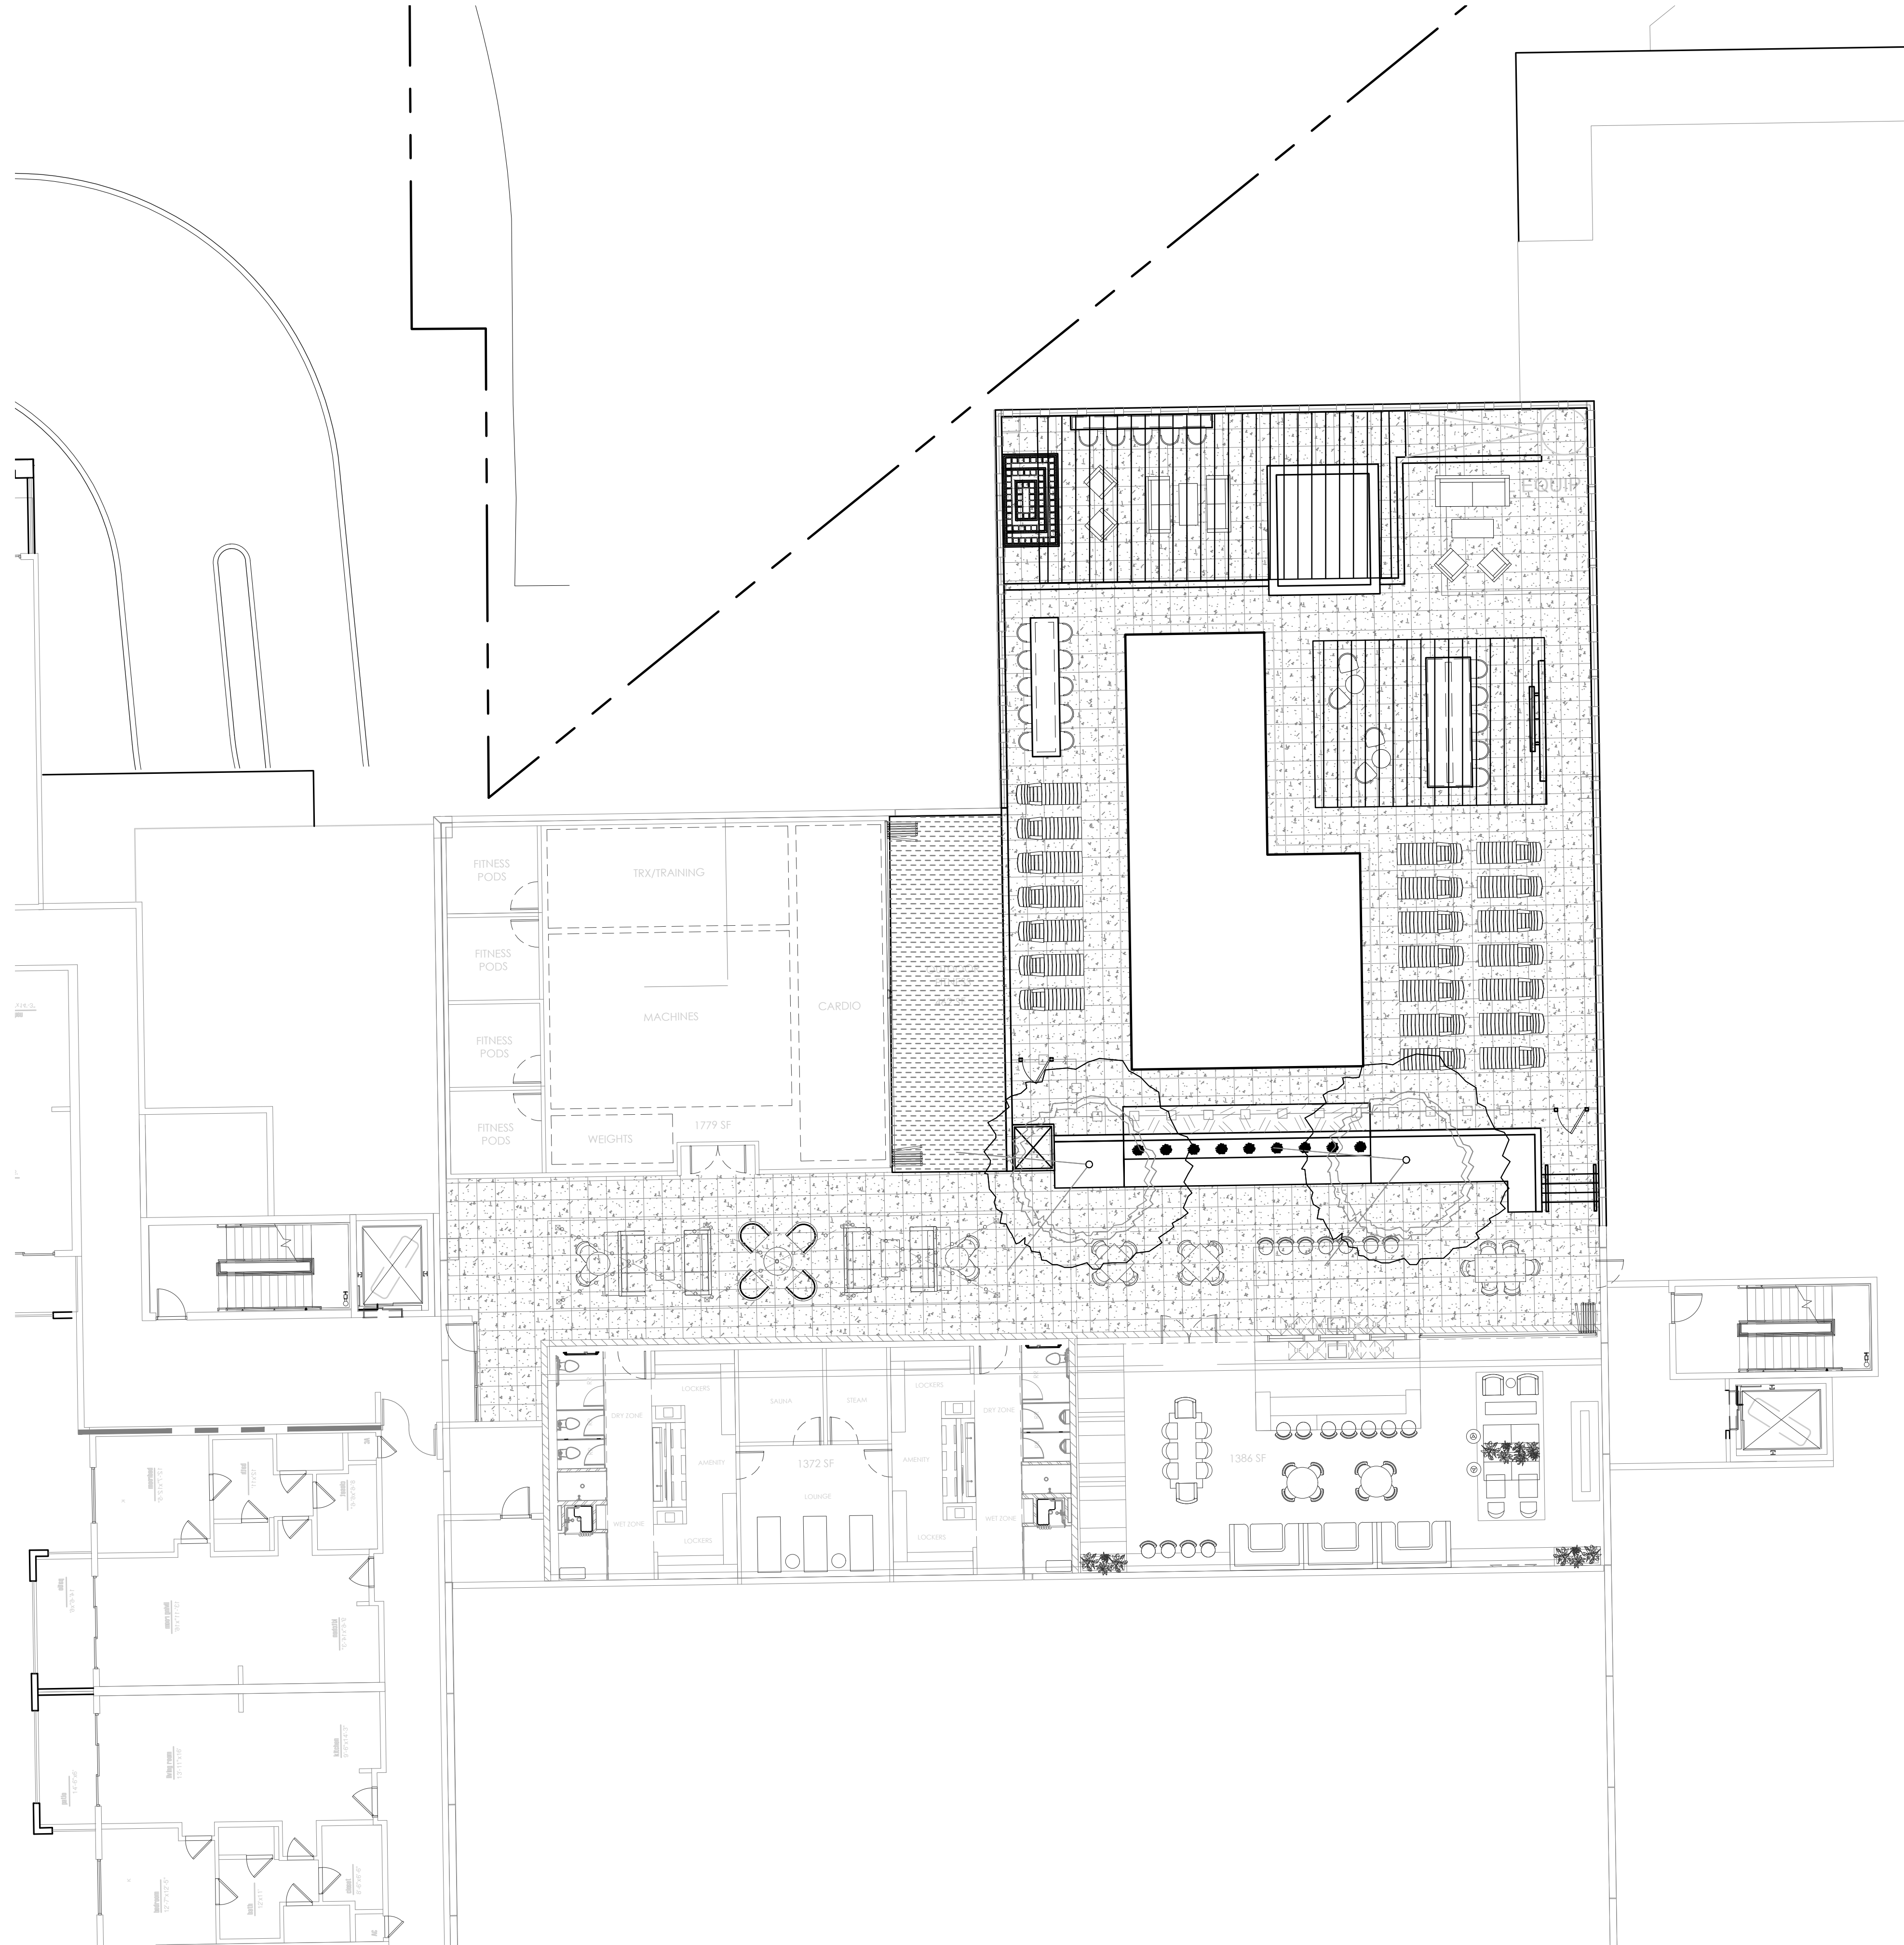

PLANT MATERIALS LEGEND

Tree	Cal (in.)	Height (Ft.)	Width (Ft.)	Box (in.)	Qty
Acacia aneura	.75"	6'	2'	24"	
Mulga Acacia					
Acacia smallii	1"	5'	3'	24"	
Sweet Acacia					
Acacia stenophylla	1"	8'	3'	24"	
Shoestring Acacia					
Acacia willardiana	1"	5'	2.5'	24"	
Palo Blanco					
Bauhinia x blakeana	1.25"	7'	2.5'	24"	
Hong Kong Orchid					
Caesalpinia cacalaco	1"	5'	3'	24"	
Cascalote					
Chilopsis linearis	1"	5'	3'	24"	
Desert Willow					
Eucalyptus papuana	1.25"	7'	3'	24"	
Ghost Gum					
Jacaranda mimosifolia	1"	7'	3'	24"	
Jacaranda					
Lysiloma microphylla	.75"	5'	3'	24"	
Desert Fern					
Olea europaea 'Wilsonii'	N/A	6'	3'	24"	
Wilsonii Olive					
Olneya tesota	N/A	4'	2.5'	24"	
Desert Ironwood					
Parkinsonia hybrid 'Desert Museum'	1"	5'	3'	24"	
Desert Museum Palo Verde					
Parkinsonia praecox	1"	5'	3'	24"	
Palo Brea					
Phoenix dactylifera	N/A	18' TO PINEAPPLE			
Date Palm					
Pistacia chinensis	1"	7'	2.5'	24"	
Chinese Pistache					
Pistacia lentiscus	1"	7'	2.5'	24"	
Mastic Tree					
Prosopis alba	1"	6'	3'	24"	
Argentine Mesquite					
Prosopis chilensis	1.25"	5'	6'	24"	
Chilean Mesquite					
Prosopis glandulosa	1"	5'	3'	24"	
Thornless Honey Mesquite					
Prosopis hybrid	1.25"	5'	6'	24"	
Thornless Mesquite					
Quercus virginiana 'Joan Lionetti'	1"	7'	3'	24"	
'Joan Lionetti' Live Oak					
Sophora secundiflora	0.75"	3'	2'	24"	
Texas Mountain Laurel					
Ulmus parvifolia 'Allee'	1"	7'	3'	24"	
Allee Elm					
Ulmus parvifolia 'Bosque'	1"	7'	3'	24"	
Bosque Elm					
Vitex agnus-castus	N/A	5'	3'	24"	
Chaste Tree					
Washingtonia filifera	N/A	18' TO PINEAPPLE			
California Fan Palm					
Washingtonia robusta	N/A	18' TO PINEAPPLE			
Mexican Fan Palm					

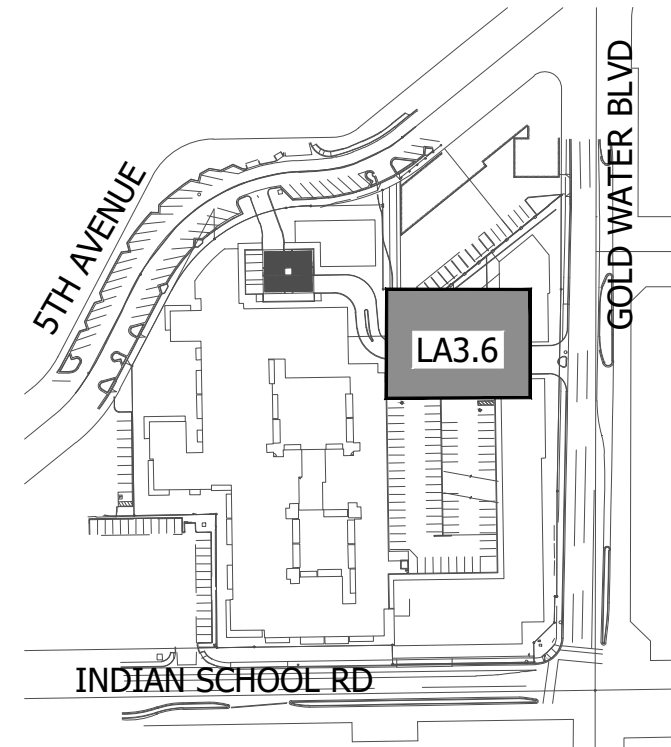


KEY MAP

NOT TO SCALE



5TH & GOLDWATER
LA3.6 - Landscape Plan


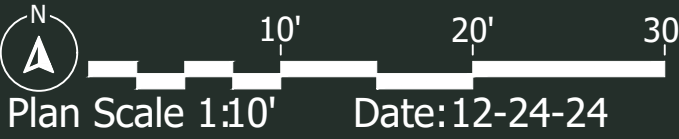


ABLASTUDIO.COM



Light Fixtures Legend

Symbol	Model	Type	Manufacturer	Finsh	Qty	Detail
●	M-PZ-ZD-3LED	Path Light	FX Luminare	FB	33	
■	FC-6LED-GW-090	Well Light	FX Luminare	BZ	79	
▲	FB-ZD-3LED	Uplight	FX Luminare	BZ	17	
		Festoon Lights		FB		
T-1	LUXOR 300 WATT	Light Controller	FX Luminare	SS	2	

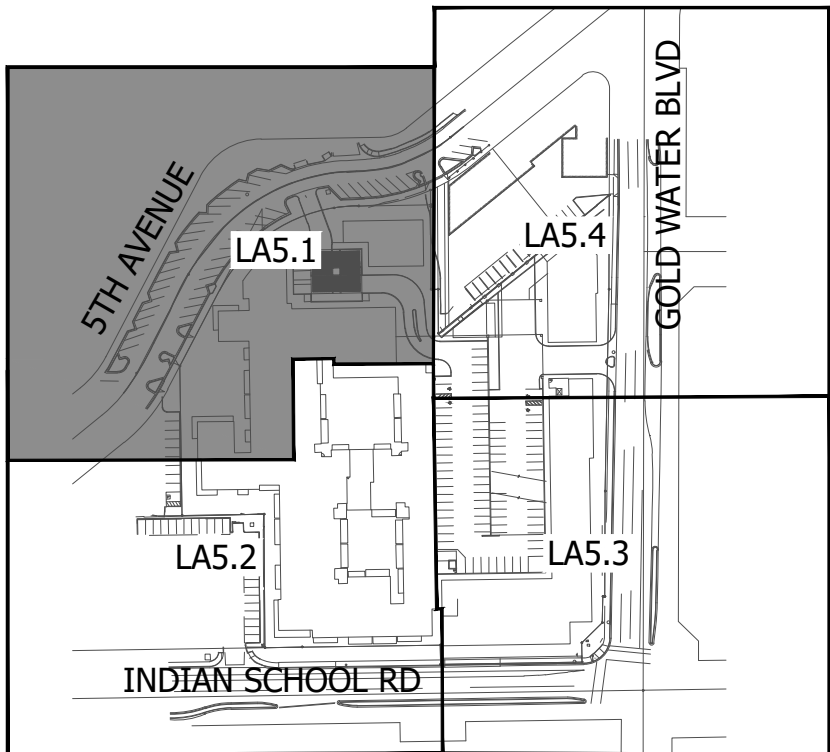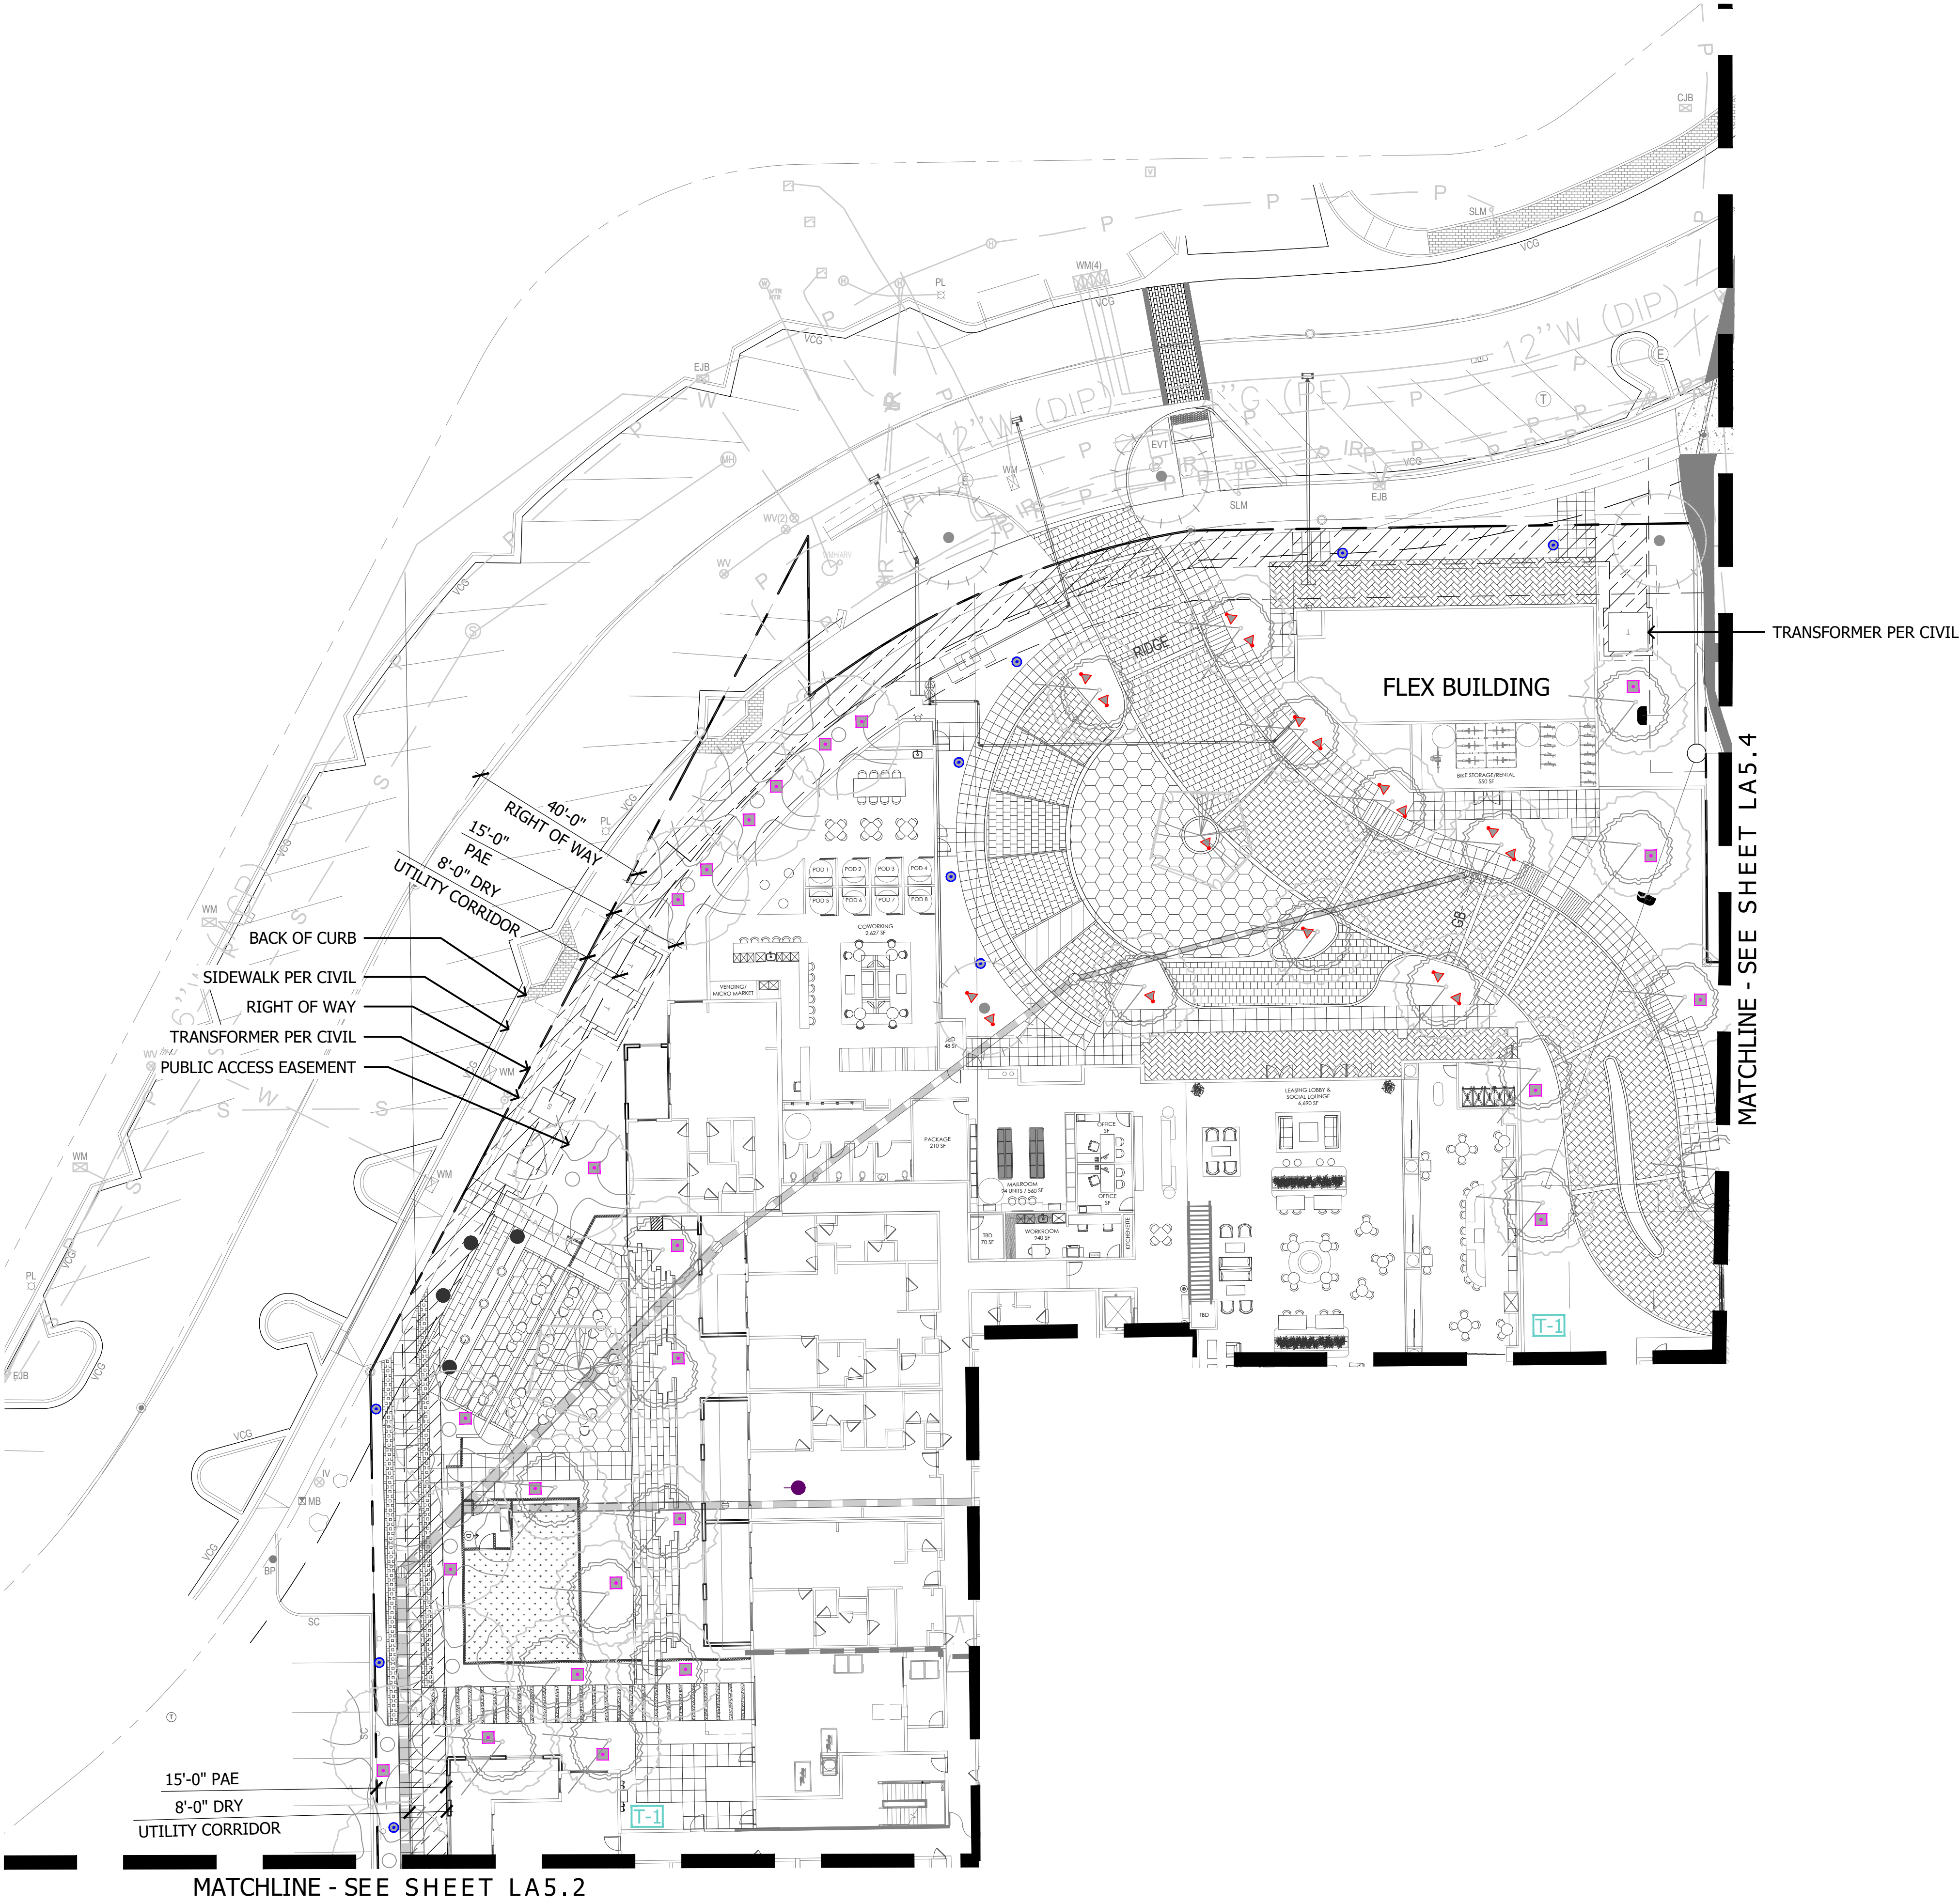


KEY MAP

NOT TO SCALE



5TH & GOLDWATER
LA5.1 - Lighting Plan


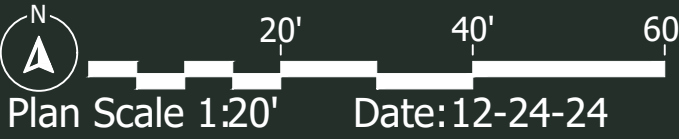


ABLASTUDIO.COM



Light Fixtures Legend

Symbol	Model	Type	Manufacturer	Finsh	Qty	Detail
●	M-PZ-ZD-3LED	Path Light	FX Luminaire	FB	33	
■	FC-6LED-GW-090	Well Light	FX Luminaire	BZ	79	
▲	FB-ZD-3LED	Uplight	FX Luminaire	BZ	17	
		Festoon Lights		FB		
T-1	LUXOR 300 WATT	Light Controller	FX Luminaire	SS	2	

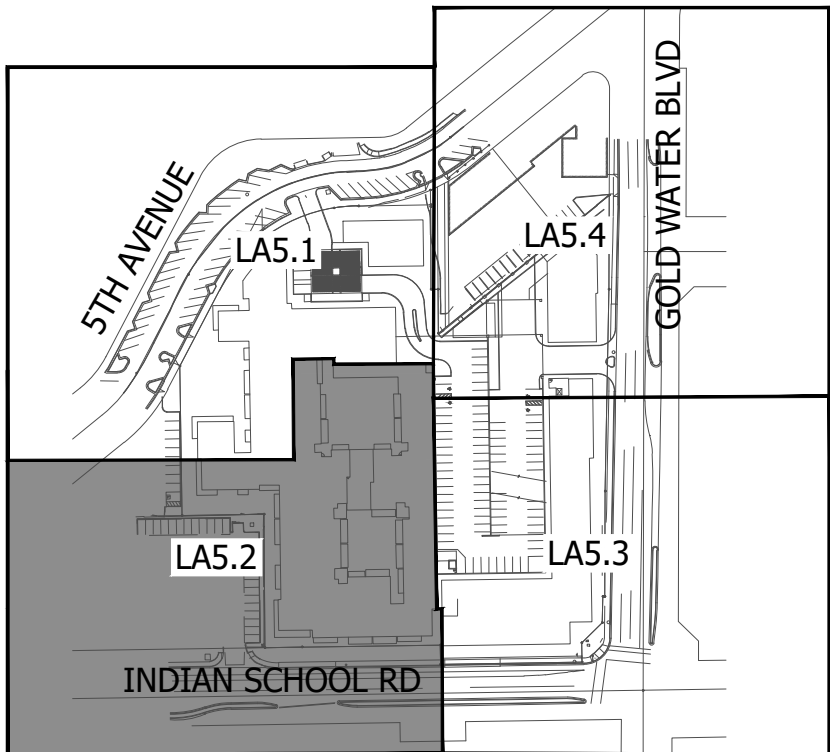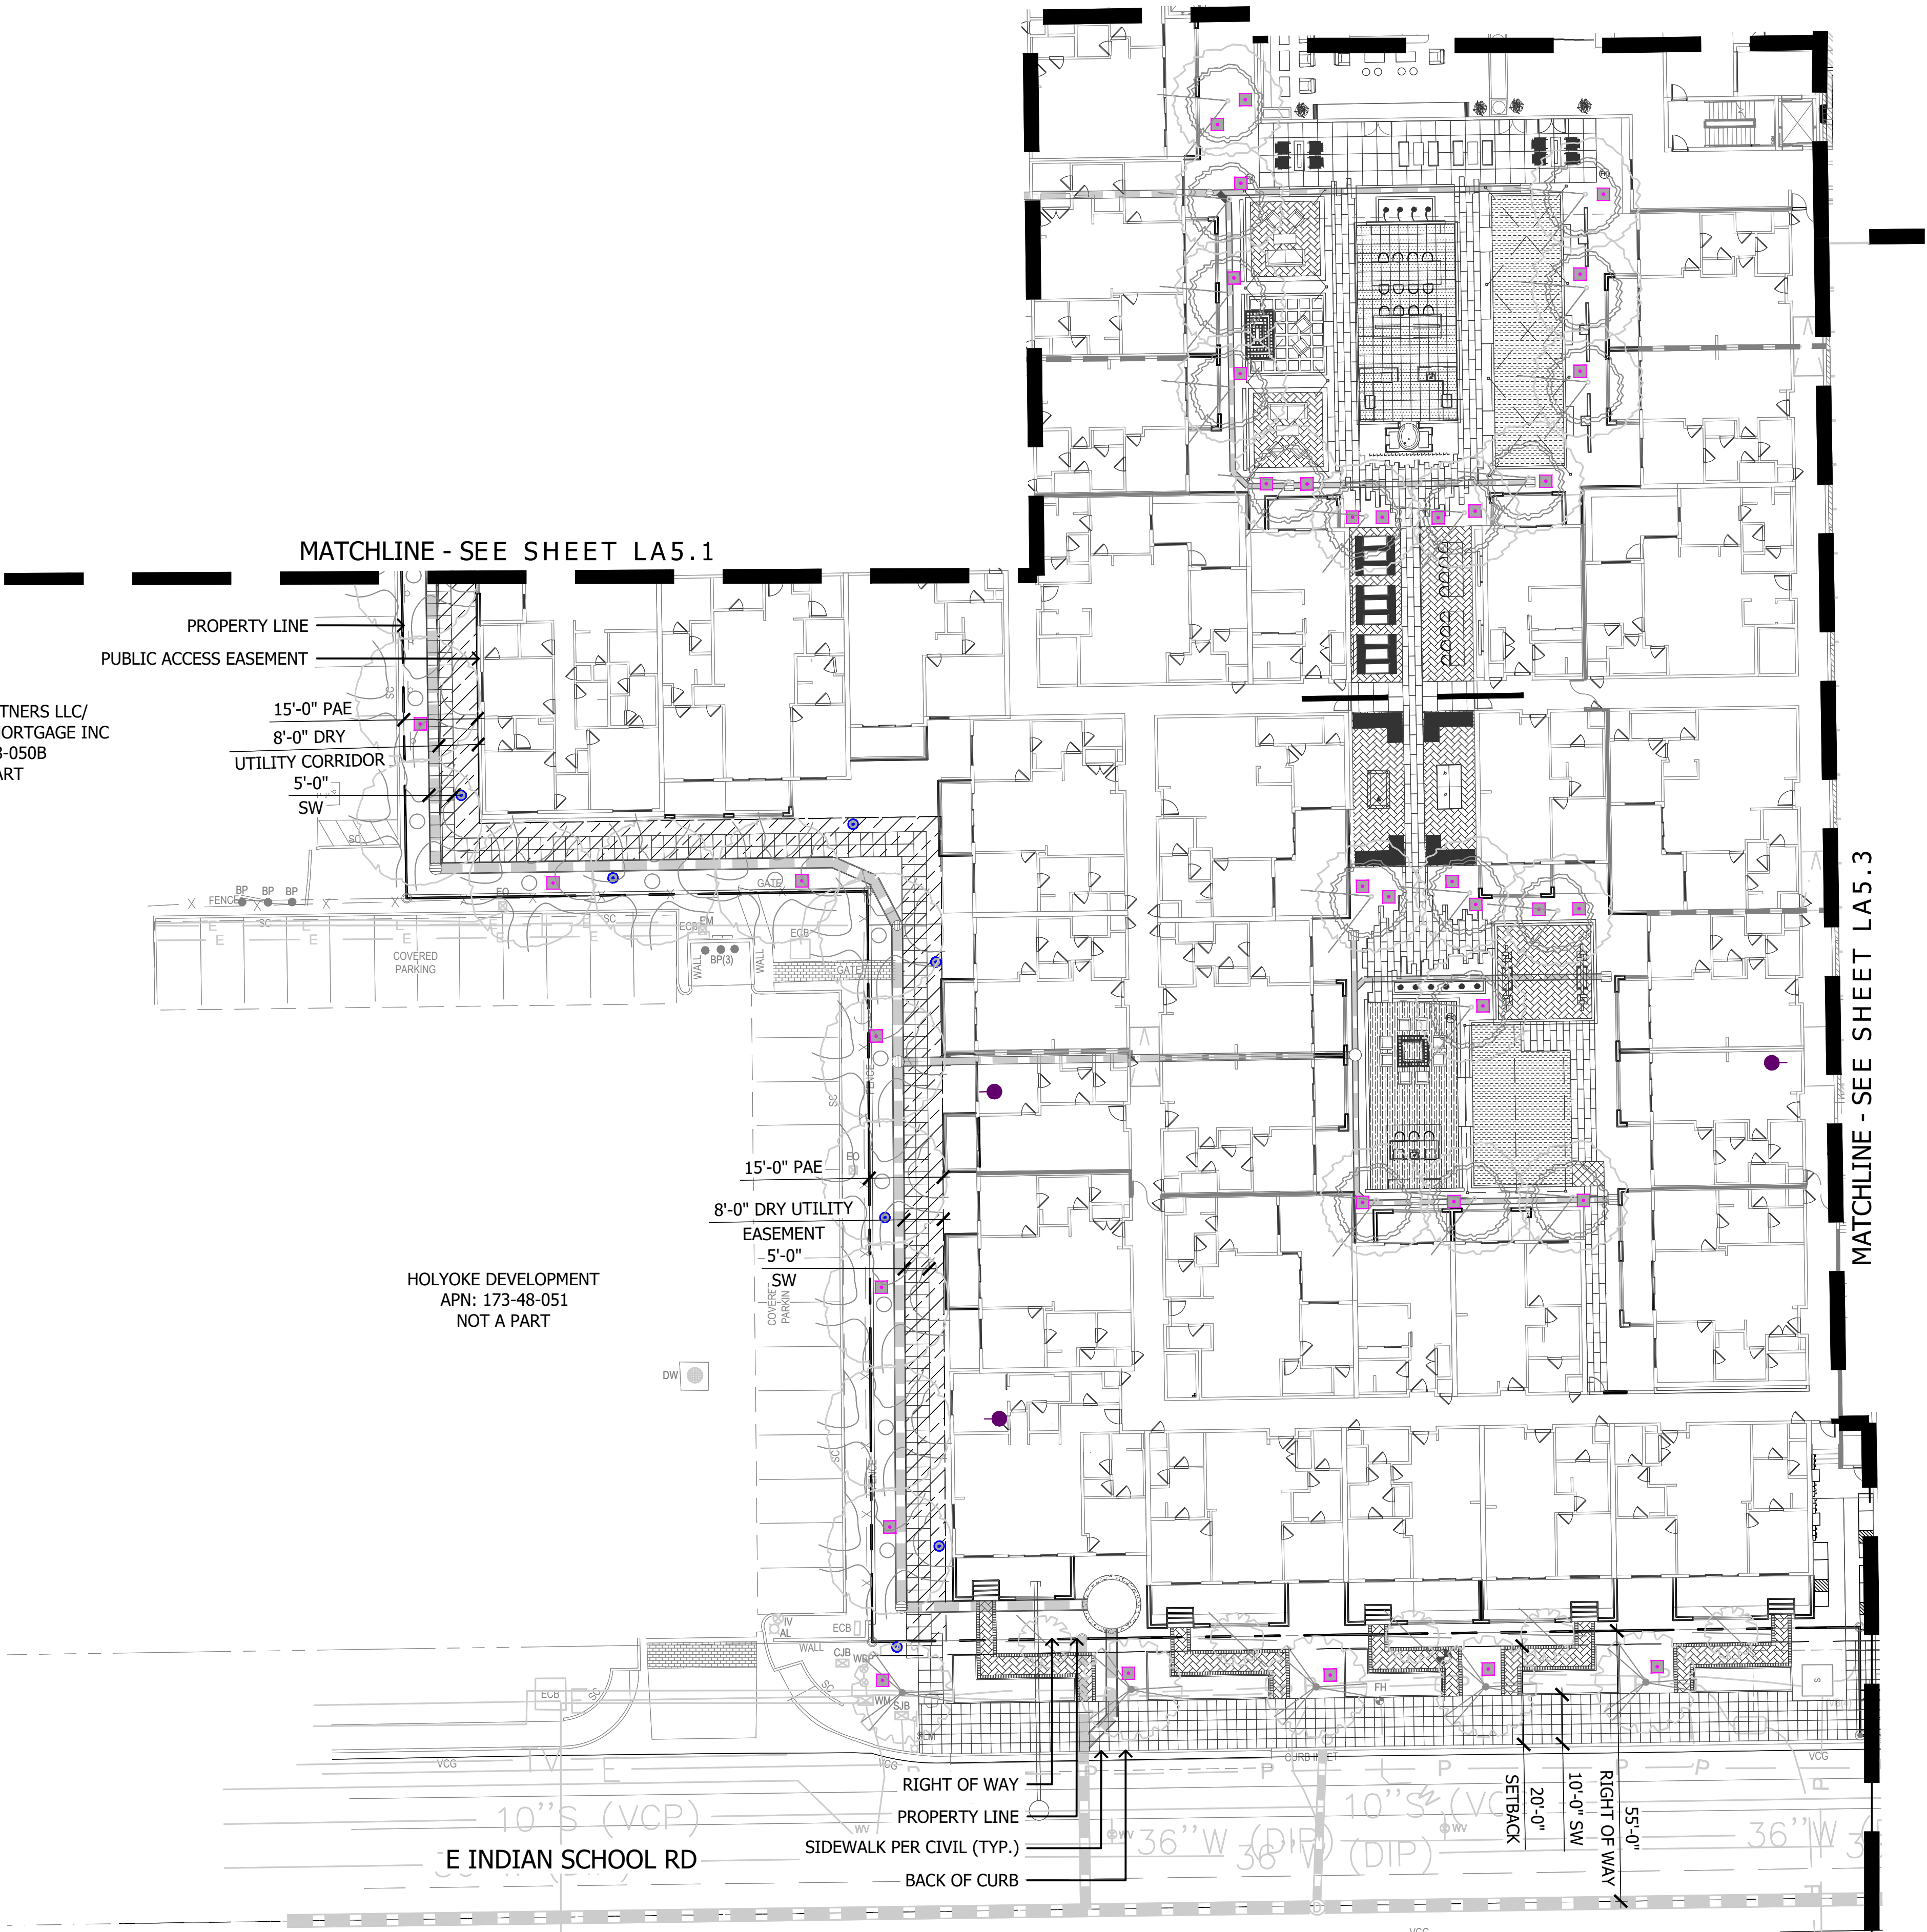

KEY MAP

NOT TO SCALE



5TH & GOLDWATER

LA5.2 - Lighting Plan





ABLASTUDIO.COM



Light Fixtures Legend


Symbol	Model	Type	Manufacturer	Finsh	Qty	Detail
●	M-PZ-ZD-3LED	Path Light	FX Luminare	FB	33	
■	FC-6LED-GW-090	Well Light	FX Luminare	BZ	79	
▲	FB-ZD-3LED	Uplight	FX Luminare	BZ	17	
		Festoon Lights		FB		
T-1	LUXOR 300 WATT	Light Controller	FX Luminare	SS	2	

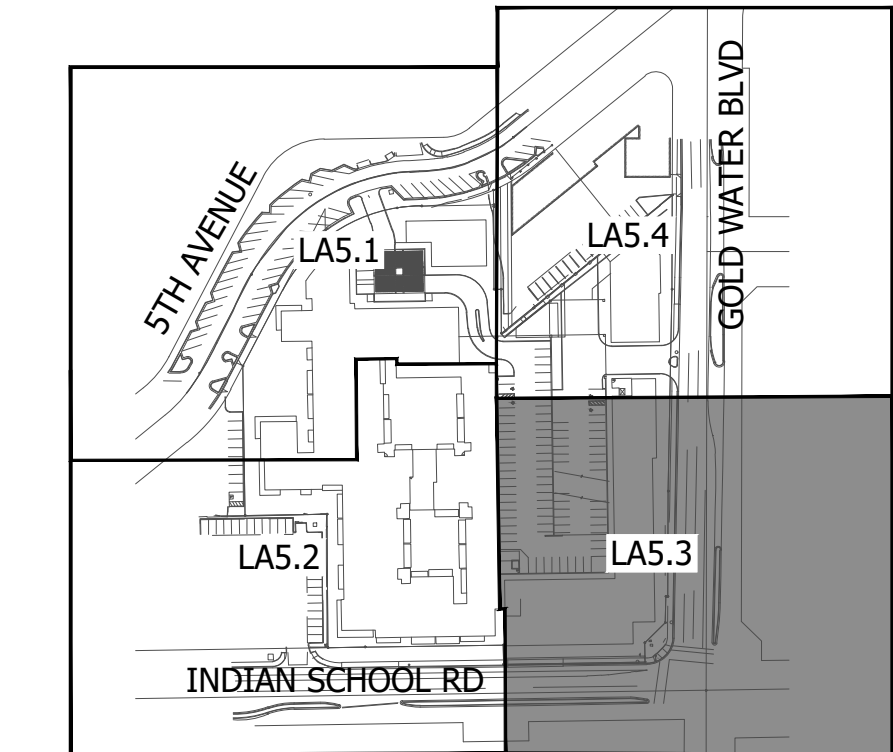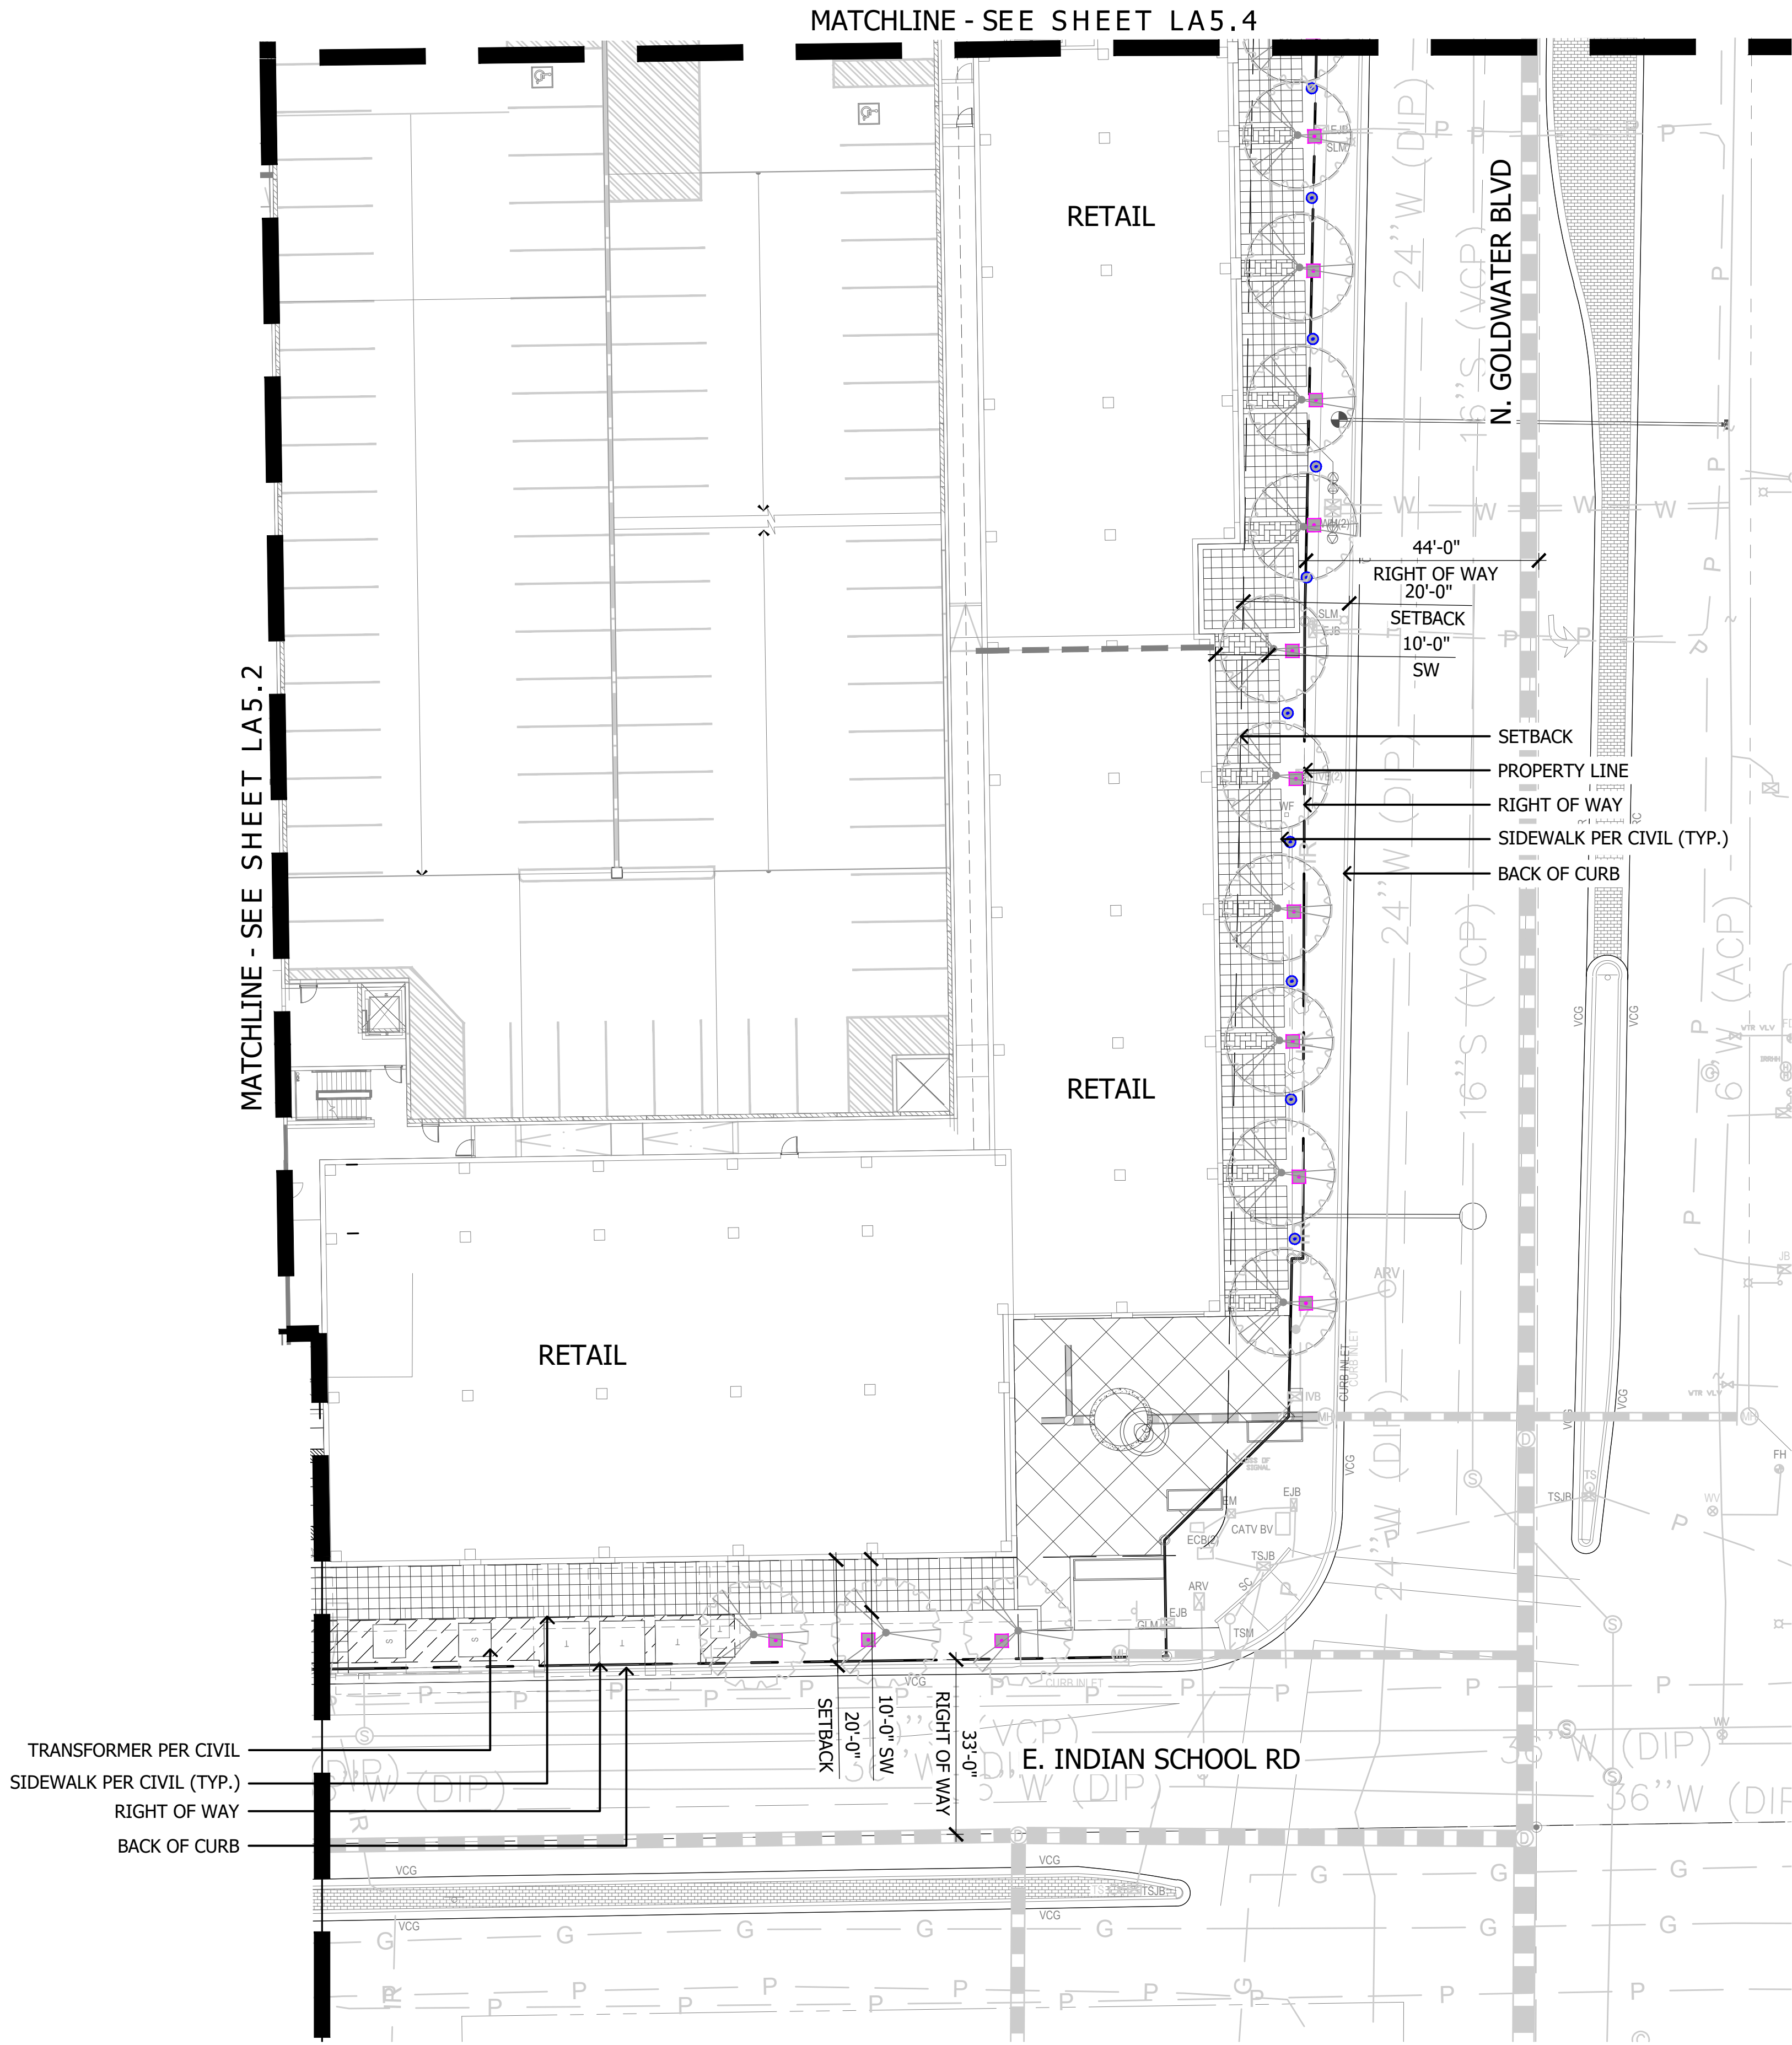


KEY MAP

NOT TO SCALE


Symbol	Model	Type	Manufacturer	Finsh	Qty	Detail
Symbol	Model	Type	Manufacturer	Finsh	Qty	
	M-PZ-ZD-3LED	Path Light	FX Luminare	FB	33	
	FC-6LED-GW-090	Well Light	FX Luminare	BZ	79	
	FB-ZD-3LED	Uplight	FX Luminare	BZ	17	
		Festoon Lights		FB		
	LUXOR 300 WATT	Light Controller	FX Luminare	SS	2	

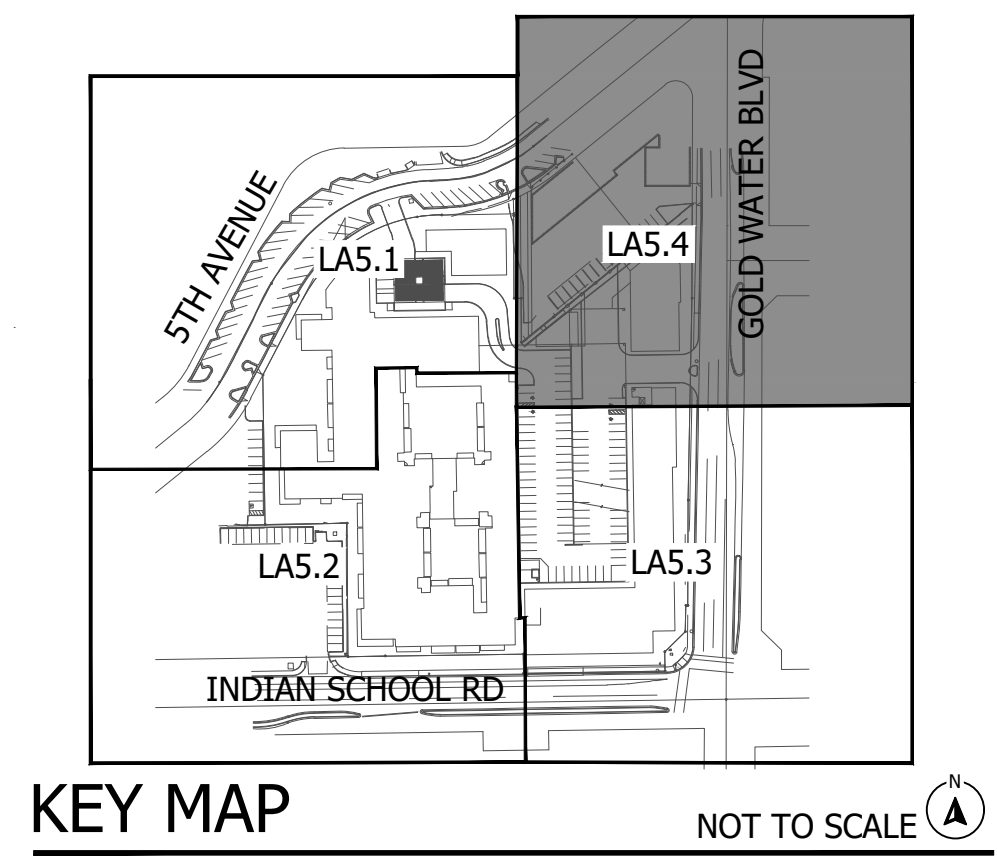

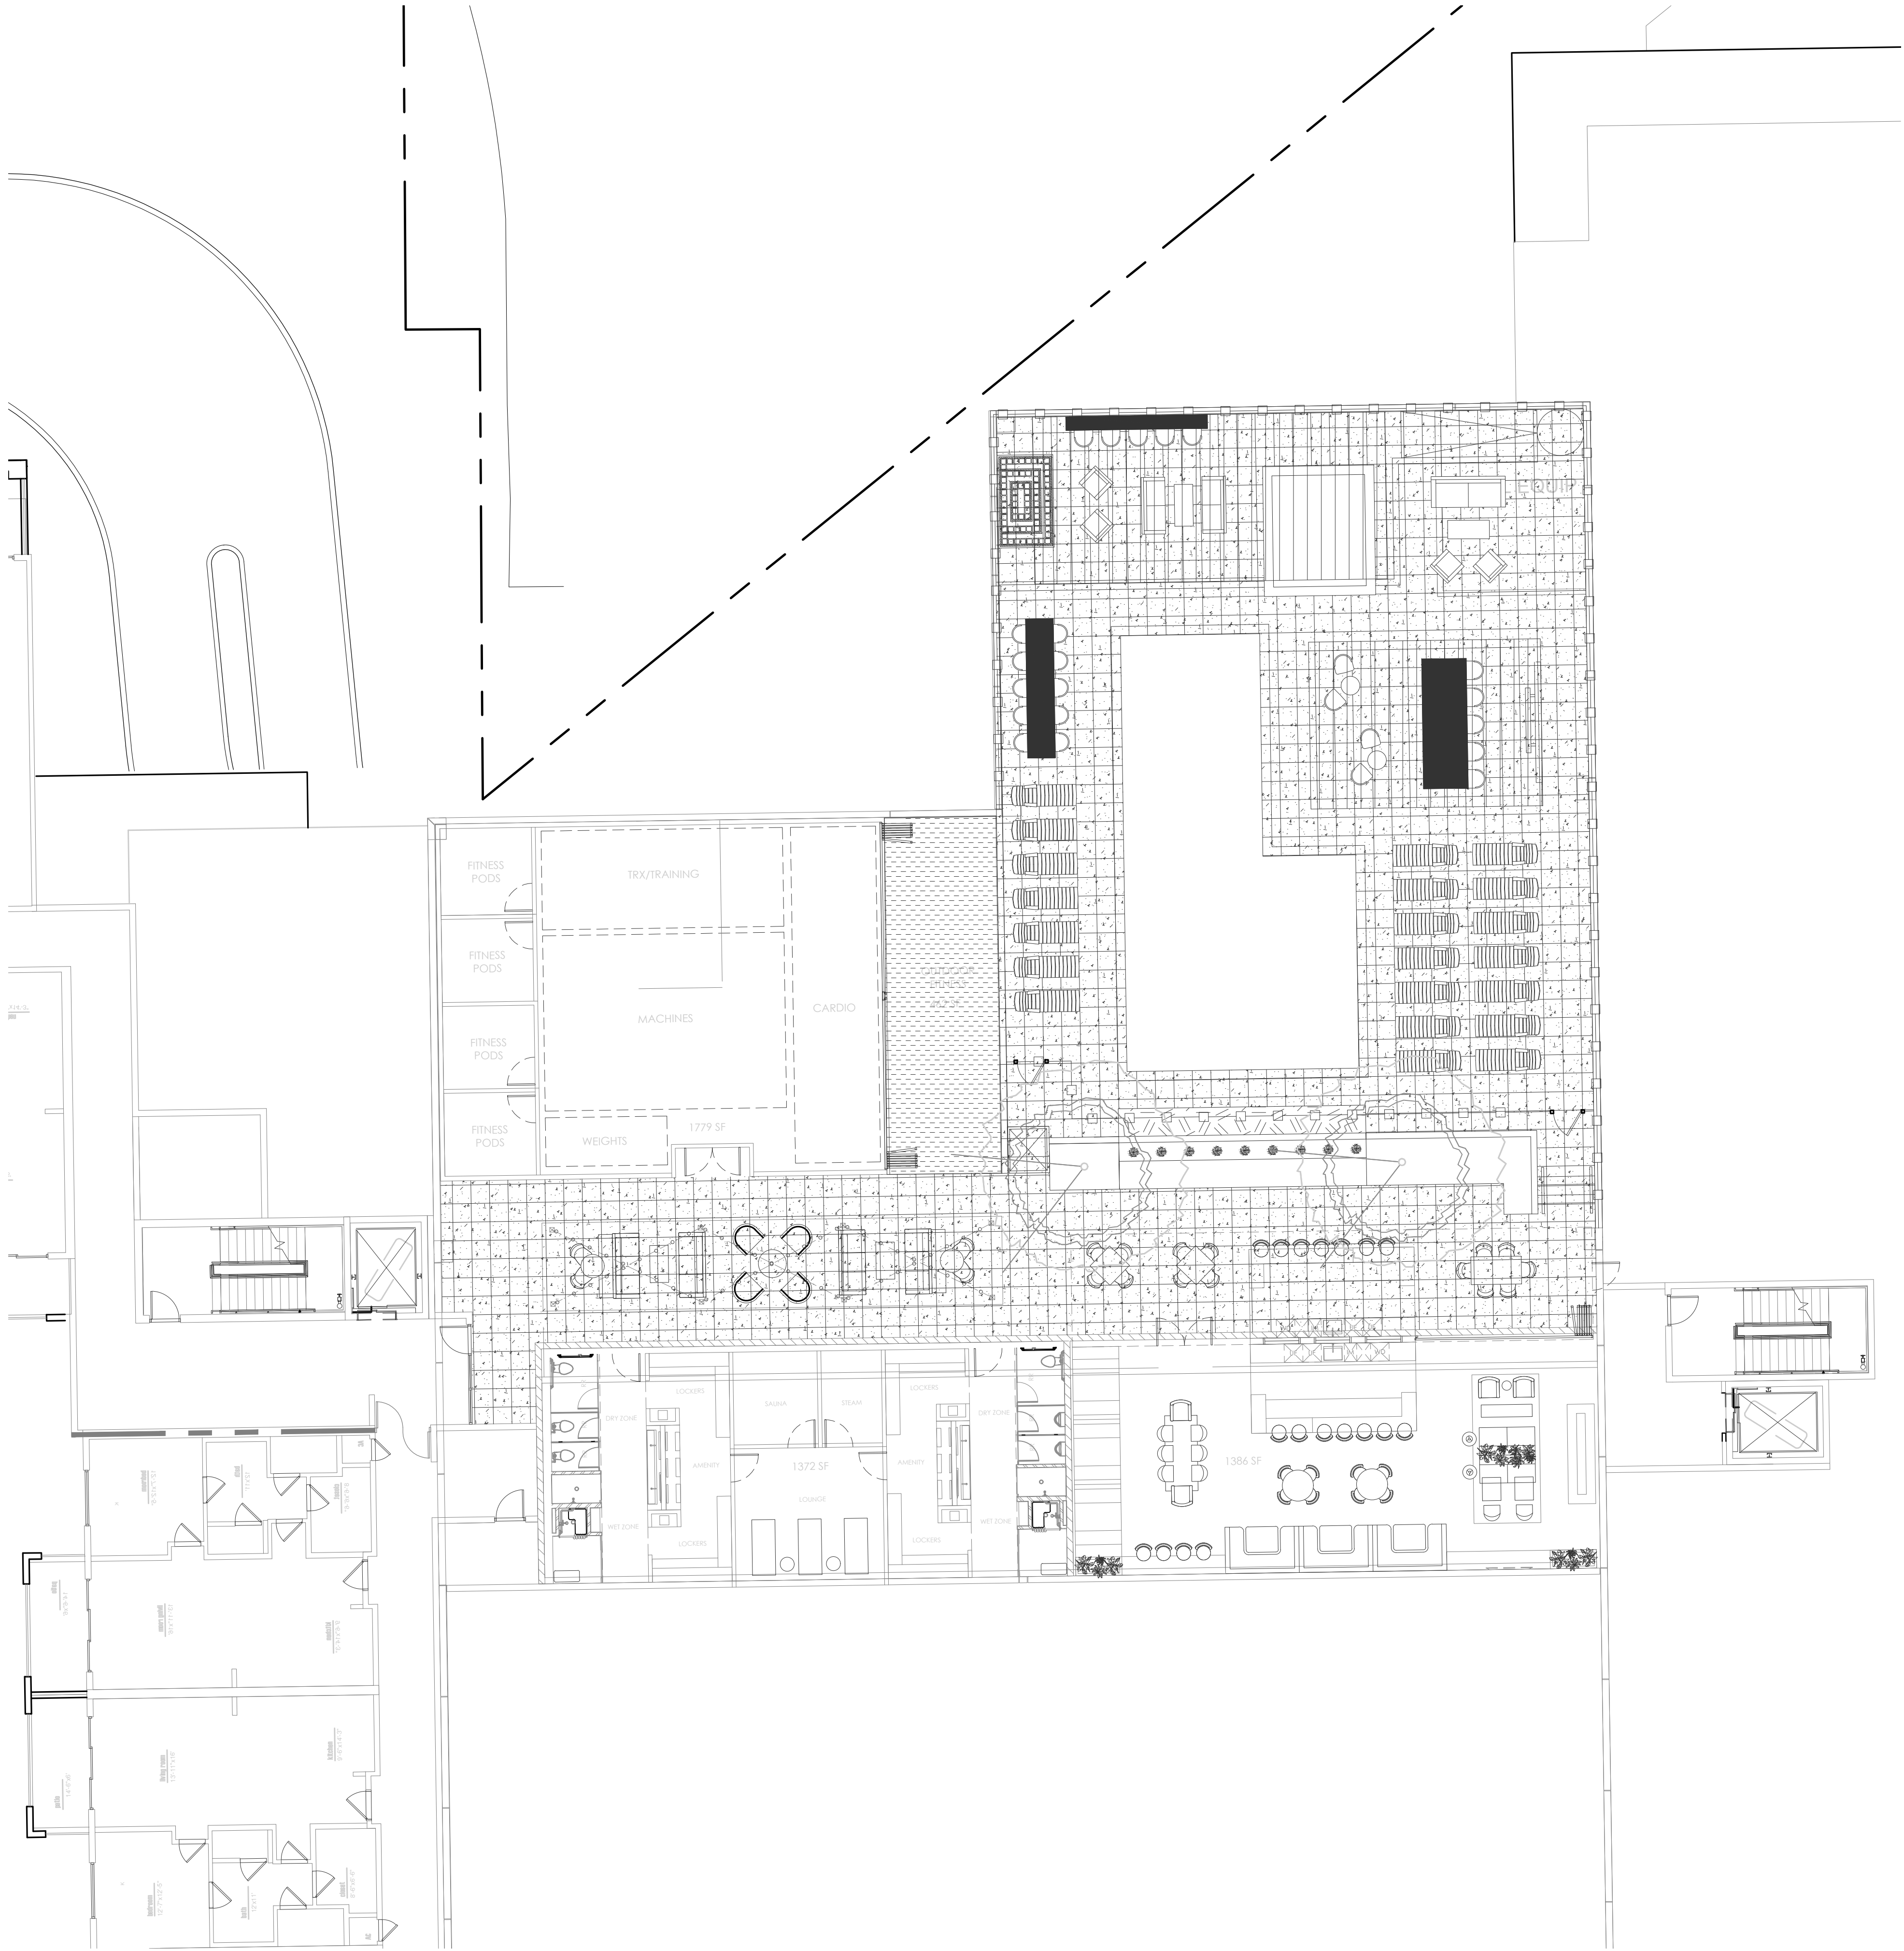

Light Fixtures Legend

Symbol	Model	Type	Manufacturer	Finsh	Qty	Detail
●	M-PZ-ZD-3LED	Path Light	FX Luminare	FB	33	
■	FC-6LED-GW-090	Well Light	FX Luminare	BZ	79	
▲	FB-ZD-3LED	Uplight	FX Luminare	BZ	17	
		Festoon Lights		FB		
T-1	LUXOR 300 WATT	Light Controller	FX Luminare	SS	2	

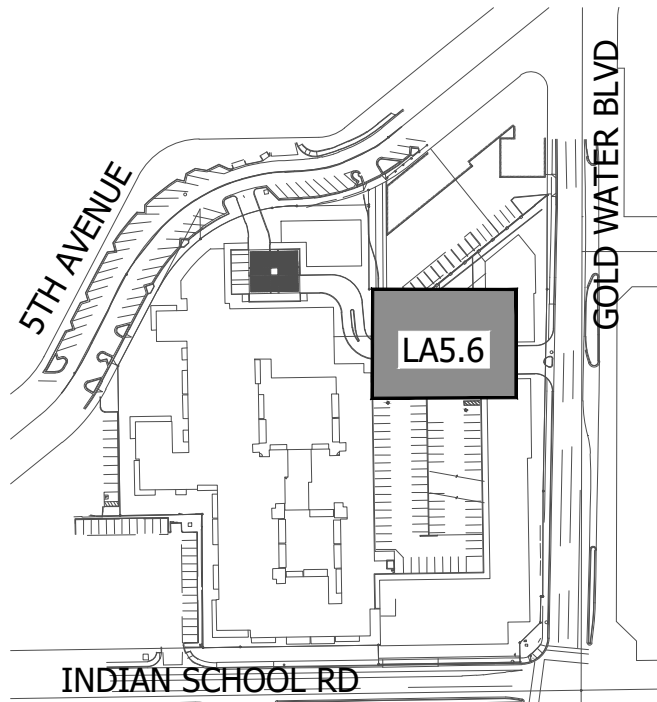


KEY MAP

NOT TO SCALE



5TH & GOLDWATER
LA5.5 - Lighting Plan

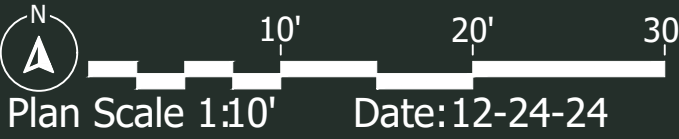

ABLASTUDIO.COM






The BQ 1 LED stainless steel light illuminates grilling areas. It is designed to work with the Luxor® system, or it can be operated independently with an optional plug-in transformer.

BQ: Barbeque Light

NUMBER OF LEDs:	1
HALOGEN LUMEN OUTPUT EQUIVALENT:	10 Watt
USEFUL LED LIFE (L70):	50,000 hrs avg
INPUT VOLTAGE:	10 to 15V
VA TOTAL: (Use to size the lighting controller)	2.4
WATTS USED:	2.0
LUMENS PER WATT (EFFICACY)	42
MAX LUMENS:	81.5
CRI (Ra)	82

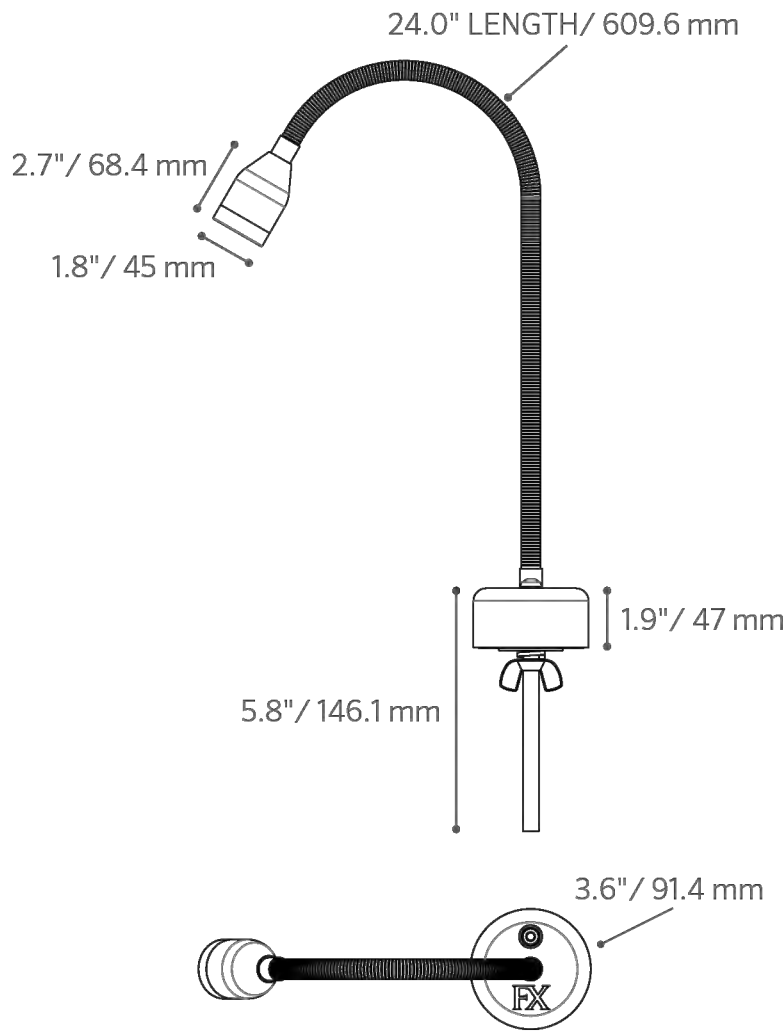

Learn more about FX Luminaire specialty lights. Visit: fxl.com/products



BQ: Barbeque Light

FACTORY INSTALLED OPTIONS: Order 1 + 2 (optional) + 3 + 4

Step	Description	Code
1	FIXTURE	BQ
2	OPTIONAL ZD	ZD (Refer to the Luxor page in the Lighting Control section)
3	LAMP	1LED (50,000 avg. life hours)
4	FINISH	SS

EXAMPLE: BQ-ZD-1LED-SS = BQ - ZD Option - 1LED Board - Stainless Steel


METALS

SS = Stainless Steel

FIELD INSTALLED OPTIONS:

PART NUMBER	DESCRIPTION
MT12W	MINI TRANSFORMER, 12W

PHOTOMETRICS:

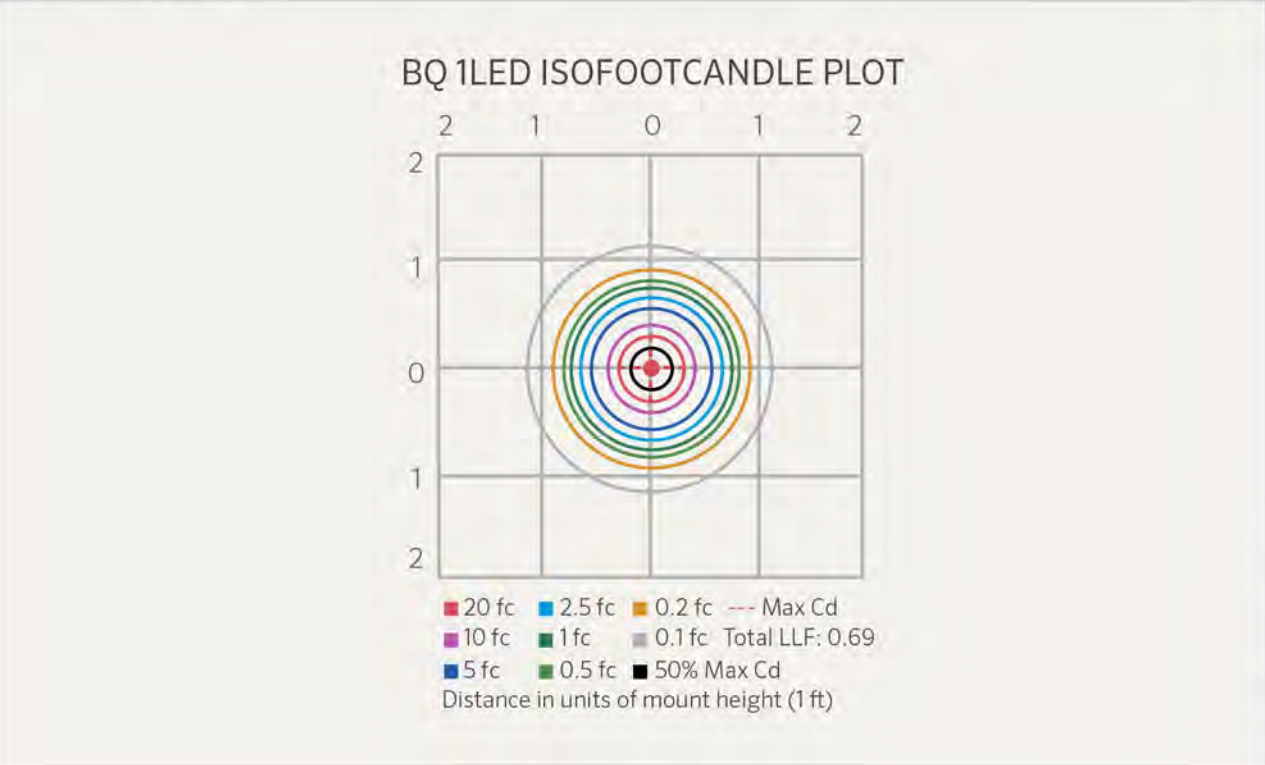

The BQ includes a 1 LED board, mounting hardware for countertop, and a 2 ft lead.

Beam angle is defined as two times the vertical angle at which the intensity is 50% of the maximum. It is calculated using LM-79 method for SSL Luminaires.

Low Voltage Light Fixture - "A"
BQ-ZD-1LED-WM-SS



Angled Orientation

PROJECT

CATALOG #

TYPE


NOTES

KG Well Light DESIGNER PREMIUM

Reversible angled or flat-top well light in 3, 6, or 9 LED.
RGBW capable with **Luxor**® systems.

Quick Facts

- Die-cast brass or aluminum construction
 - Powder-coat, natural, or antiqued brass finishes
 - Cree® integrated LEDs
 - Reversible design for flat or angled installation
- Tamper-resistant features
 - Compatible with Luxor technology
 - Phase and PWM dimmable
 - Input voltage: 10-15V

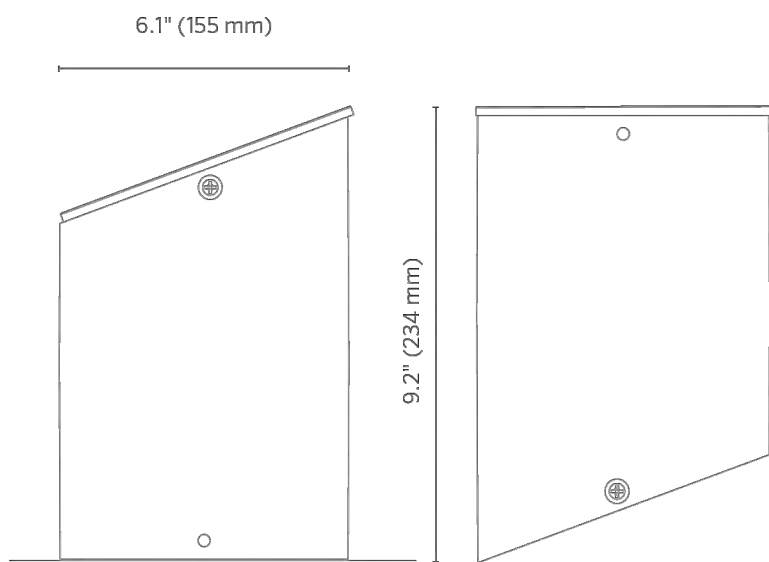

LANDSCAPE & ARCHITECTURAL LIGHTING

KG Well Light ORDERING INFORMATION

Fixture	Luxor Option	Compliance	Output	Finish		
KG*	[default] Zone	[default] UL Listed	3LED 128 Lumens	BS Natural Brass	WG White Gloss	
	ZD Zone/Dim	e CE Certified	6LED 265 Lumens	BZ Bronze Metallic	FW Natural Brass	
			9LED 321 Lumens	DG Desert Granite	AL Almond	
	ZDC Zone/Dim/Color		[default] 123 Lumens	WI Weathered Iron	AB Antique Bronze	
				SB Sedona Brown	AT Antique Tumbled	
				FB Black	NP Nickel Plate	
				CB** Camo Bronze		

**Composite grid faceplate

EXAMPLE FIXTURE CONFIGURATION: KG-ZD-6LED-BS

KG

-

-

-

-

*Includes 6" (152 mm) Reversible (Flat/Angled) Conduit Sleeve (Z500T1630000)

Accessory: Specify Separately

Item	Code
CLEAR PROTECTIVE INSERT 2.5" (64 mm) x 12" (305 mm)	KG-CPI

LANDSCAPE & ARCHITECTURAL LIGHTING

KG Well Light PHOTOMETRICS

KG 3LED Illuminance at a Distance

Feet (Meters)	Center Beam	Beam Width	
		Vertical 23.9°	Horizontal 23.8°
4.2' (1.3 m)	22.8 fc (245 lx)	1.8' (0.6 m)	1.8' (0.6 m)
8.3' (2.5 m)	5.7 fc (61 lx)	3.5' (1.1 m)	3.5' (1.1 m)
12.5' (3.8 m)	2.5 fc (27 lx)	5.3' (1.6 m)	5.3' (1.6 m)
16.7' (5.1 m)	1.5 fc (16 lx)	7.0' (2.1 m)	7.0' (2.1 m)
20.8' (6.3 m)	0.9 fc (10 lx)	8.8' (2.7 m)	8.8' (2.7 m)
25.0' (7.6 m)	0.6 fc (7 lx)	10.6' (3.2 m)	10.5' (3.2 m)

KG 9LED Illuminance at a Distance

Feet (Meters)	Center Beam	Beam Width	
		Vertical 27.9°	Horizontal 27.0°
4.2' (1.3 m)	51.7 fc (557 lx)	2.1' (0.6 m)	2.0' (0.6 lx)
8.3' (2.5 m)	13.0 fc (140 lx)	4.1' (1.3 m)	4.0' (1.2 m)
12.5' (3.8 m)	5.8 fc (62 lx)	6.2' (1.9 m)	6.0' (1.8 m)
16.7' (5.1 m)	3.2 fc (35 lx)	8.3' (2.5 m)	8.0' (2.4 m)
20.8' (6.3 m)	2.1 fc (23 lx)	10.4' (3.2 m)	10.0' (3.1 m)
25.0' (7.6 m)	1.4 fc (15 lx)	12.4' (3.8 m)	12.0' (3.7 m)

KG 6LED Illuminance at a Distance

Feet (Meters)	Center Beam	Beam Width	
		Vertical 27.8°	Horizontal 27.9°
4.2' (1.3 m)	42.7 fc (460 lx)	2.1' (0.6 m)	2.1' (0.6 m)
8.3' (2.5 m)	10.7 fc (115 lx)	4.1' (1.3 m)	4.1' (1.3 m)
12.5' (3.8 m)	4.8 fc (52 lx)	6.2' (1.9 m)	6.2' (1.9 m)
16.7' (5.1 m)	2.7 fc (29 lx)	8.3' (2.5 m)	8.3' (2.5 m)
20.8' (6.3 m)	1.7 fc (18 lx)	10.3' (3.1 m)	10.3' (3.1 m)
25.0' (7.6 m)	1.2 fc (13 lx)	12.4' (3.8 m)	12.4' (3.8 m)

KG ZDC Illuminance at a Distance

Feet (Meters)	Center Beam	Beam Width	
		Vertical 54.4°	Horizontal 38.9°
4.2' (1.3 m)	4.4 fc (47 lx)	4.4' (1.3 m)	3.0' (0.9 m)
8.3' (2.5 m)	1.1 fc (12 lx)	9.0' (2.7 m)	6.1' (1.9 m)
12.5' (3.8 m)	0.5 fc (5 lx)	13.4' (4.1 m)	9.2' (2.8 m)
16.7' (5.1 m)	0.3 fc (3 lx)	17.8' (5.4 m)	12.2' (3.7 m)
20.8' (6.3 m)	0.2 fc (2 lx)	22.3' (6.8 m)	15.3' (4.7 m)
25.0' (7.6 m)	0.1 fc (1 lx)	26.7' (8.1 m)	18.3' (5.6 m)

Cree is a registered trademark of Cree Inc. MoistureBlock is a trademark of DSM&T Co. Inc.

© 2020 Hunter Industries Inc. Hunter, FX Luminaire, all related logos, and all other trademarks are property of Hunter Industries, registered in the U.S. and other countries.

| Learn more. Visit fxl.com | +1 760.744.5240

FXLIT-015-SS-SPECIALTY-DSN-KG 4/20


Low Voltage Light Fixture - "B"
KG-ZD-3LED-FB



Our largest wall-wash up light, the LC, projects a broad spectrum of light on large walls and spaces. It is available in 1, 3, 6 and 9LED, and is available in an array of finishes to suit the needs of any design that calls for a large-span wall washing up light.

LC: Up Light

NUMBER OF LEDs:	1	3	6	9
HALOGEN LUMEN OUTPUT EQUIVALENT:	10 Watt	20 Watt	35 Watt	50 Watt
USEFUL LED LIFE (L70):	50,000 hrs avg	50,000 hrs avg	50,000 hrs avg	50,000 hrs avg
INPUT VOLTAGE:	10 to 15V	10 to 15V	10 to 15V	10 to 15V
VA TOTAL: (Use to size the lighting controller)	2.4	4.5	13.5	13.5
WATTS USED:	2.0	4.2	10.1	11.2
LUMENS PER WATT (EFFICACY)	30.9	36.5	36.1	36.8
MAX LUMENS:	63	154	331	436
CRI (Ra)	82.8	80.2	82.2	79.2

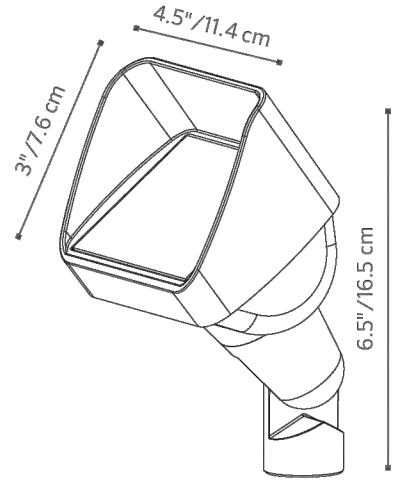

Learn more about FX Luminaire up lights. Visit: fxl.com

760.744.5240



LC: Up Light

FACORY INSTALLED OPTIONS: Order 1 + 2 (optional) + 3 + 4

Step	Description	Code
1	FIXTURE	LC
2	OPTIONAL ZD	ZD (Refer to the Luxor page in the Lighting Control section)
3	LAMP	1LED, 3LED, 6LED, 9LED (50,000 avg. life hours)
4	FINISH	AB*, AT*, NP*, BS, WG, FW, AL, BZ, DG, WI, VF, SB, FB


EXAMPLE: LC-ZD-3LED-BZ = LC - ZD Option - 3LED Board - Bronze Metallic Finish

FIELD INSTALLED OPTIONS: Order Individually

Mounting Options	
Long Slot Spike (250015840000) 2.5" x 10" Included	
Super Slot Spike (753900) 2" x 10"	
Super J-Box (SJ-XX**) 2.5" x 12"	
Post Mount (PM-XX**) 2.5" x 13"	

EXAMPLE: 753900 = Super Slot Spike

PHOTOMETRICS:

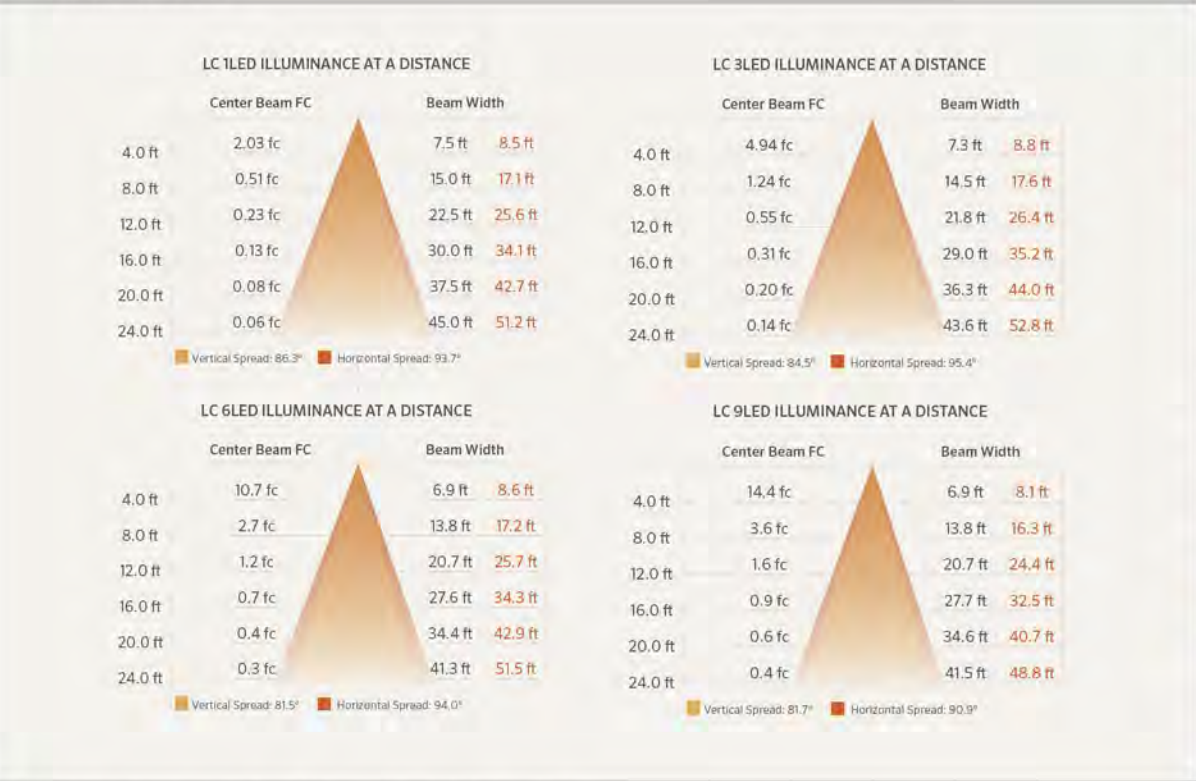

Beam angle is calculated using LM-79 method for SSL luminaires.
*Beam angle is defined as two times the vertical angle at which the intensity is 50% of the maximum.

METALS

AB	Antique Bronze* (On Brass)
AT	Antique Tumbled* (On Brass)
NP	Nickel Plate*
BS	Natural Brass

POWDER COAT

WG	White Gloss
FW	Flat White
AL	Almond
BZ	Bronze Metallic
DG	Desert Granite
WI	Weathered Iron
VF	Verde Speckle
SB	Sedona Brown
FB	Flat Black

The LC includes your choice LED boards, choice of finish, 4 ft. lead wire and a Long Slot Spike.

All LC up lights come standard with amber, green, blue and frosted filters

* May require longer lead time

** Denotes finish code



FXLuminaire.

Low Voltage Light Fixture - "C"


LC-ZD-3LED-FB



The LF is our LED under-the-cap hardscape wall light. It can easily be fitted between a block wall and capstone for a neat, clean installation. Due to its modular bracket design, the LF can even be installed under railings and existing construction.

LF: Wall Light

NUMBER OF LEDs:	1
HALOGEN LUMEN OUTPUT EQUIVALENT:	10 Watt
USEFUL LED LIFE (L70):	50,000 hrs avg
INPUT VOLTAGE:	10 to 15V
VA TOTAL: (Use this number to size the transformer)	2.4
WATTS USED:	2.0
LUMENS PER WATT (EFFICACY)	37
MAX LUMENS:	77
CCT (Ra)	81.6

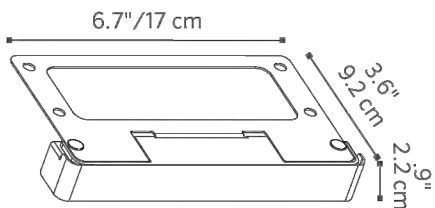

Learn more about FX Luminaire wall lights. Visit: fxl.com

760.744.5240



LF: Wall Light

FACTORY INSTALLED OPTIONS: Order 1 + 2 (optional) + 3 + 4

Step	Description	Code
1	FIXTURE	LF
2	OPTIONAL ZD	ZD (Refer to the Luxor page in the Lighting Control section)
3	LAMP	1LED (50,000 avg. life hours)
4	FINISH	AB*, AT*, CU, BS, SS, WG, FW, AL, BZ, DG, WI, VF, SB, FB

EXAMPLE: LF-ZD-1LED-SS = LF - ZD Option - 1LED Board - Stainless Steel Finish

PHOTOMETRICS:



Beam angle is calculated using LM-79 method for SSL luminaires.
Beam angle is defined as two times the vertical angle at which the intensity is 50% of the maximum.

METALS

AB	Antique Bronze* (On Copper)
AB	Antique Bronze* (On Brass)
AT	Antique Tumbled* (On Copper)
AT	Antique Tumbled* (On Brass)
CU	Copper
BS	Natural Brass
SS	Stainless Steel

POWDER COAT

WG	White Gloss
FW	Flat White
AL	Almond
BZ	Bronze Metallic
DG	Desert Granite
WI	Weathered Iron
VF	Verde Speckle
SB	Sedona Brown
FB	Flat Black

The LF includes a 1LED board, choice of faceplate finish, 9 ft lead wire.



FXLuminaire.


Low Voltage Light Fixture - "D"
LF-ZD-1LED-BZ



With Luxor controlling an LED landscape lighting system, lights don't simply turn on and off. They come alive. Luxor offers both zoning and dimming capabilities that provide virtually limitless design possibilities.

LUXOR: Lighting Controller

MODELS:	150 or 300 Watt
FINISHES:	Stainless Steel or Matte Gray Powder Coat
DEPTH:	5" / 12.7 cm
WIDTH:	8" / 20.3cm
HEIGHT:	13" / 33 cm

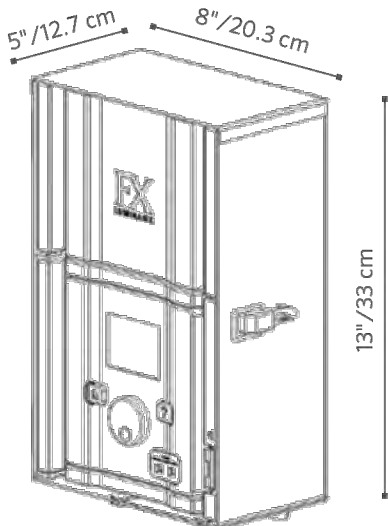

■ Learn more about FX Luminaire Lighting Controllers. Visit: fxl.com

760.744.5240



LUXOR: Lighting Controller

FACTORY INSTALLED OPTIONS: Order 1 + 2 + 3

Step	Description	Code
1	TRANSFORMER	LZD
2	SIZE	150, 300
3	FINISH	SS, M

EXAMPLE: LZD-150-M = Luxor Transformer -150W - Matte Gray Finish

FIELD INSTALLED OPTIONS: Order individually

Description	Code
Wi-Fi module add-on with antenna	FXWIFIMOD
Light Assignment Module for iOS & Android	LAM
Luxor Faceplate Mount	LUXORFPMNT

EXAMPLE: LAM = Light Assignment Module

FEATURES:

- Up to 250 independently adjustable lighting groups can be created
- Compatible with FX LED ZD lights only
- All groups can be turned on independently and dimmed from 1-100%
- Utilizes FX Luxor Communication Technology to connect lights to the controller
- User interface includes a full color LCD display for easy setup, maintenance and adjusting of groups
- Uses event based scheduling, which allows a single group of lights to change dimming percentages throughout the night
- Fully removable facepack, uses a RJ-11 cable that is extendable up to 1000'
- Simple two-wire configuration for easy installation and adjusting
- Fixture addressing takes place on the front of the facepack for easy access
- No matter where a light is within a system, it can communicate with the transformer to receive its schedule, intensity, and group
- Astronomical Timing Function with Map Placement
- Available in 150 & 300 Watts
- Stainless Steel or Matte Gray powder coated cabinet finishes

METALS

SS = Stainless Steel

POWDER COAT

M = Paintable Matte Gray

The Luxor is available in 150 or 300 watt options, choice of stainless steel or matte gray powder coat and a 3' power cord.

WI-FI-OPTIONS



Smartphone with Luxor Wi-Fi App to wirelessly adjust lighting at any time

Smartphone with Light Assignment Module (LAM) which wirelessly assigns fixtures to groups using ActivAssign™ technology





FXLuminaire.

Low Voltage Light Transformer

LZD300-M With WIFI Antenna


LZD150-M With WIFI Antenna

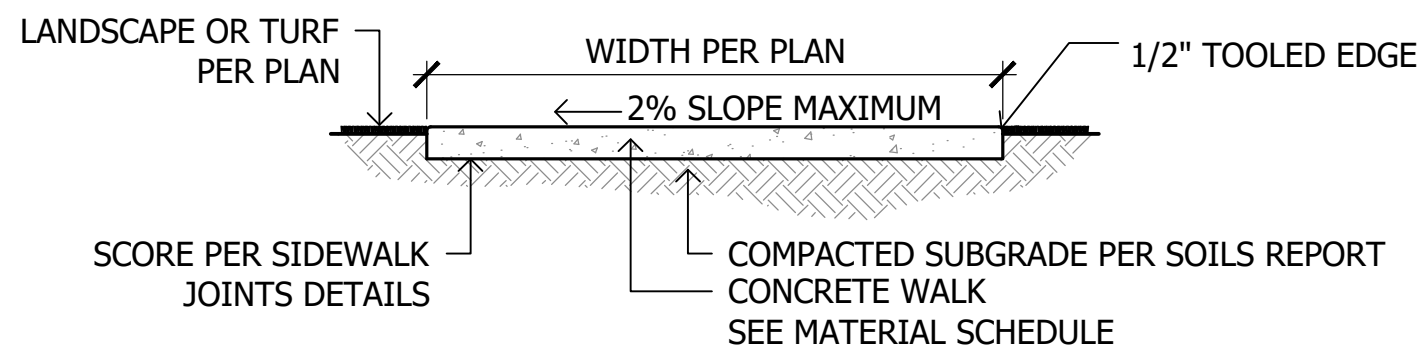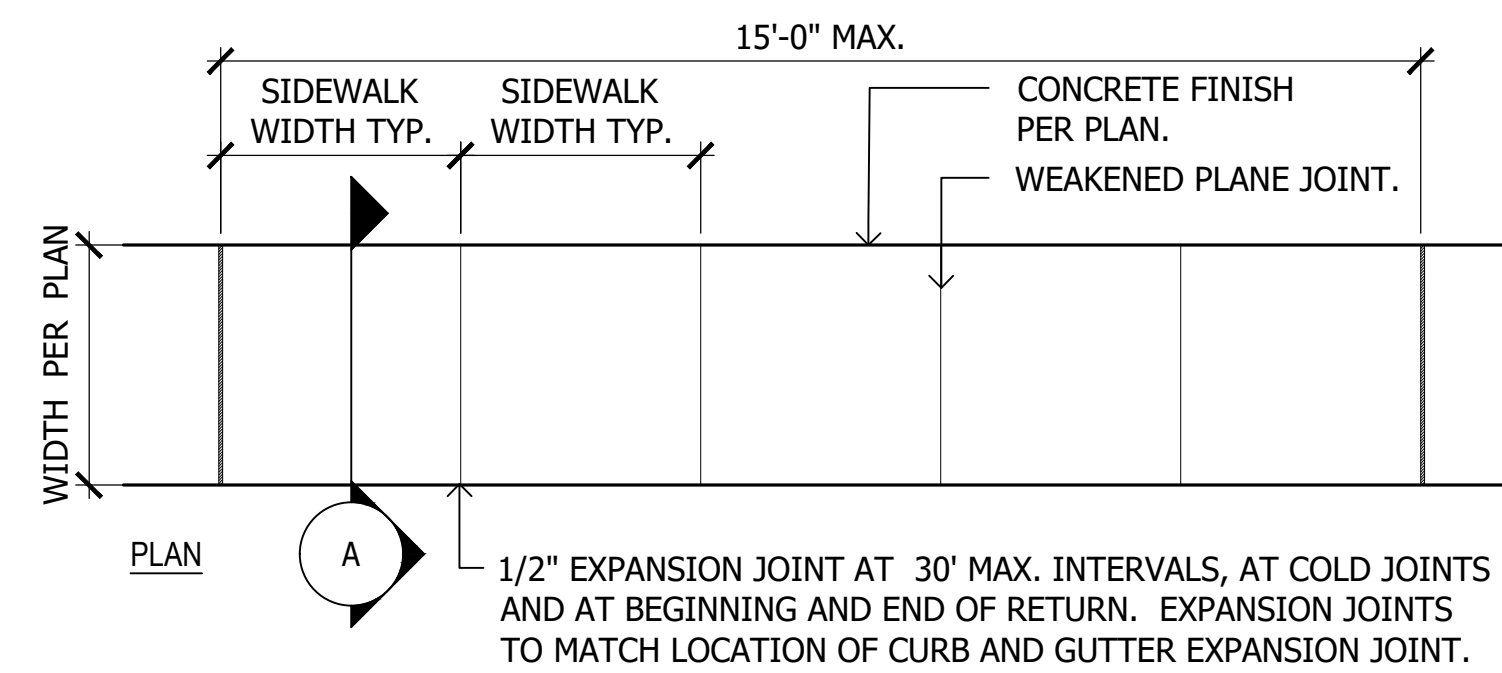

- NOTES:
- LONGITUDINAL WEAKENED PLANE JOINT REQUIRED AT MIDPOINT OF SIDEWALK 10' OR WIDER.

1 Concrete Sidewalk

SCALE: 1/2"=1'-0"

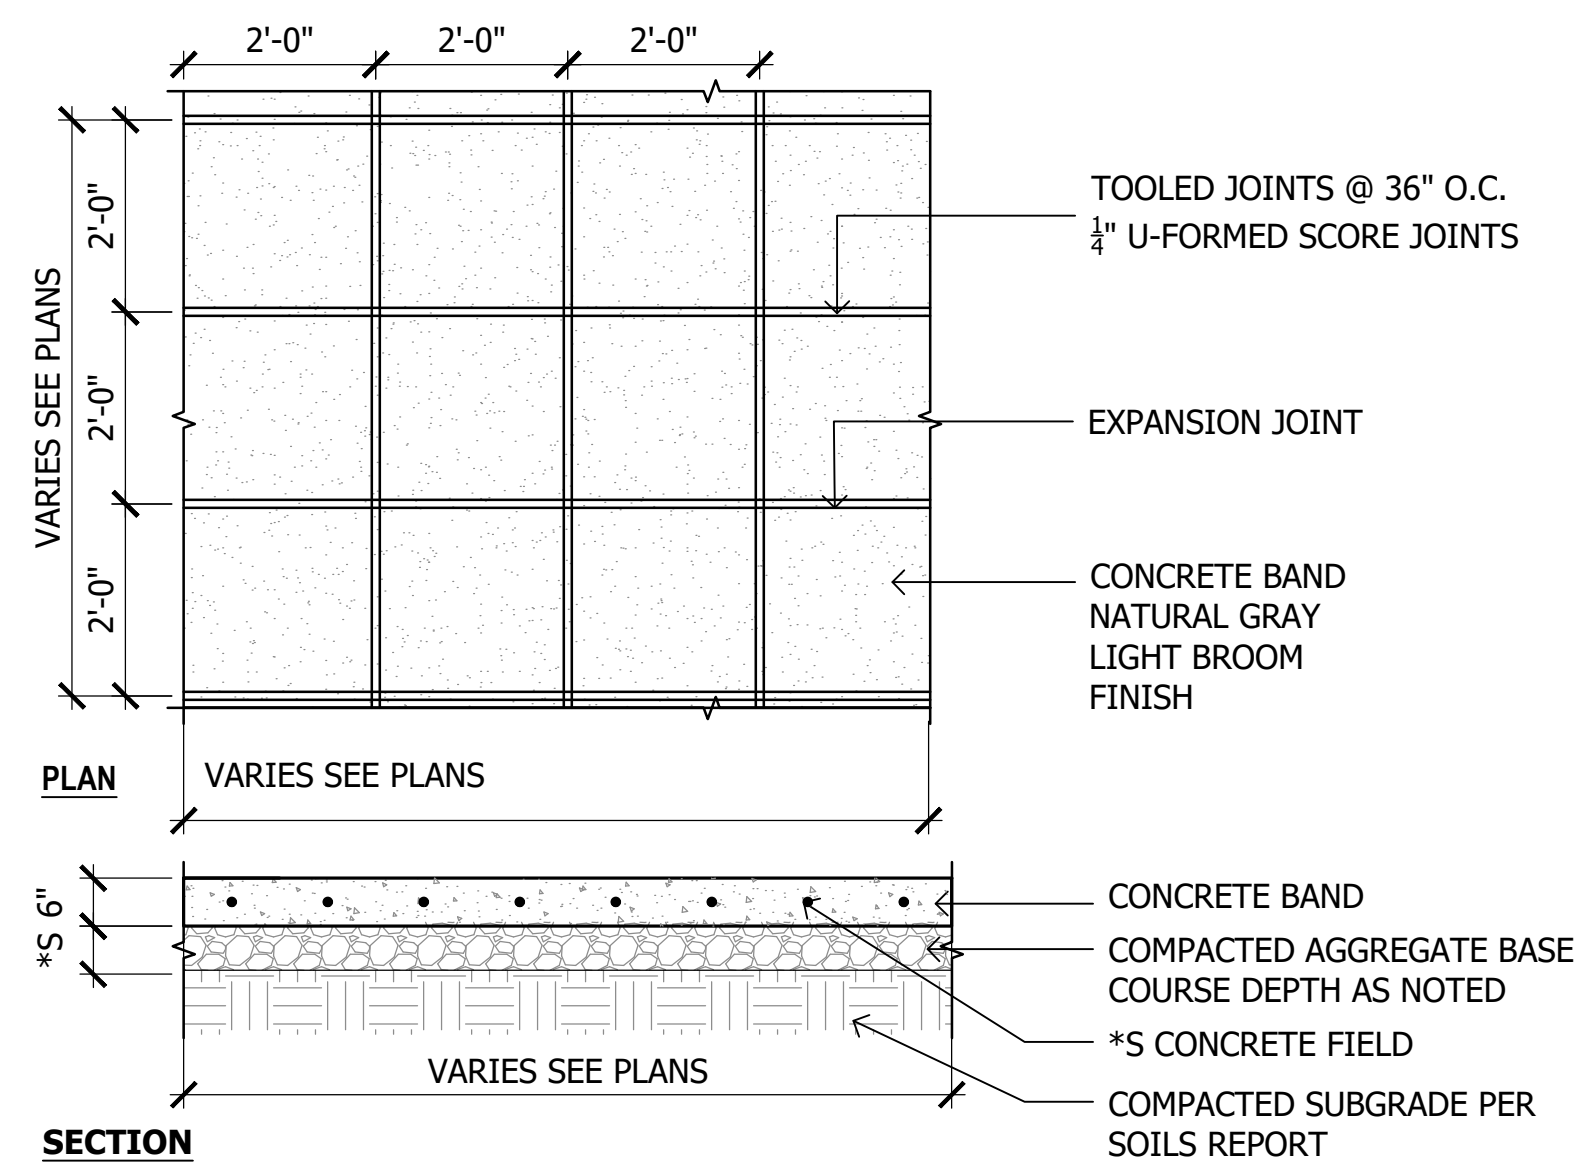


NOTE:

*PREPARE SUBGRADE, ASPHALT, AND A.B.C. PER SOILS REPORT

6 2'x2' Scored Concrete

SCALE: 1/2"=1'-0"

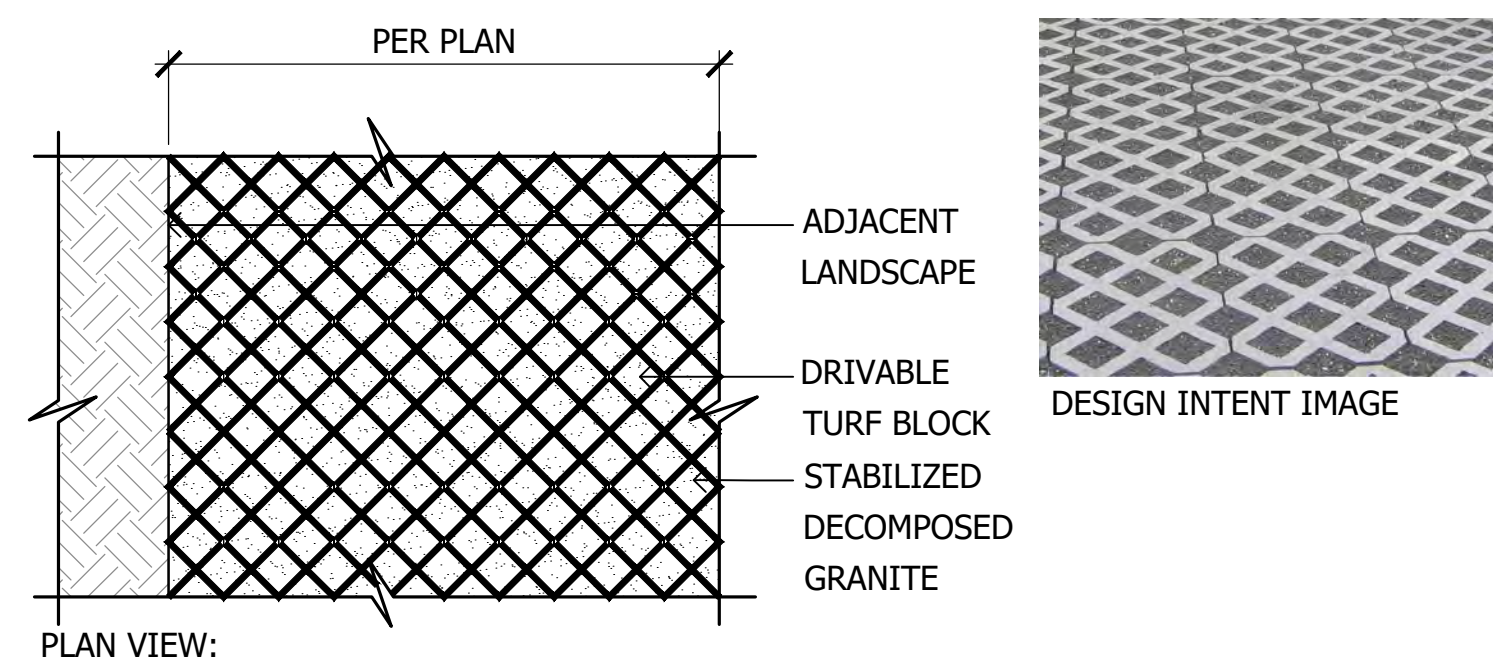

10 Drivable Granite Paver

SCALE: 3/4"=1'-0"

NOTE:

UNLESS OTHERWISE NOTED OR DIMENSIONED USE THE FOLLOWING DATA FOR EXPANSION & CONTROL JOINT LOCATIONS.

(4'-0" WIDE WALK - C.J. @ 4'-0" O.C. & E.J. @ 12' O.C.)

(5'-0" WIDE WALK - C.J. @ 5'-0" O.C. & E.J. @ 15' O.C.)

(6'-0" WIDE WALK - C.J. @ 6'-0" O.C. & E.J. @ 18' O.C.)

(8'-0" WIDE WALK - C.J. @ 8'-0" O.C. & E.J. @ 16' O.C.)


(12'-0" WIDE WALK - C.J. @ 12'-0" O.C. & E.J. @ 24' O.C.)

NOTES:

- MINIMUM 28 DAY COMPRESSIVE STRENGTH OF CONCRETE (F'C) SHALL BE 4500 PSI W/ A MAXIMUM WATER / CEMENT RATIO OF .45 (SPECIAL INSPECTION NOT REQUIRED)
- USE TYPE V PORTLAND CEMENT CONFORMING TO ASTM C150.


2 Construction Joints

SCALE: 1"=1'-0"

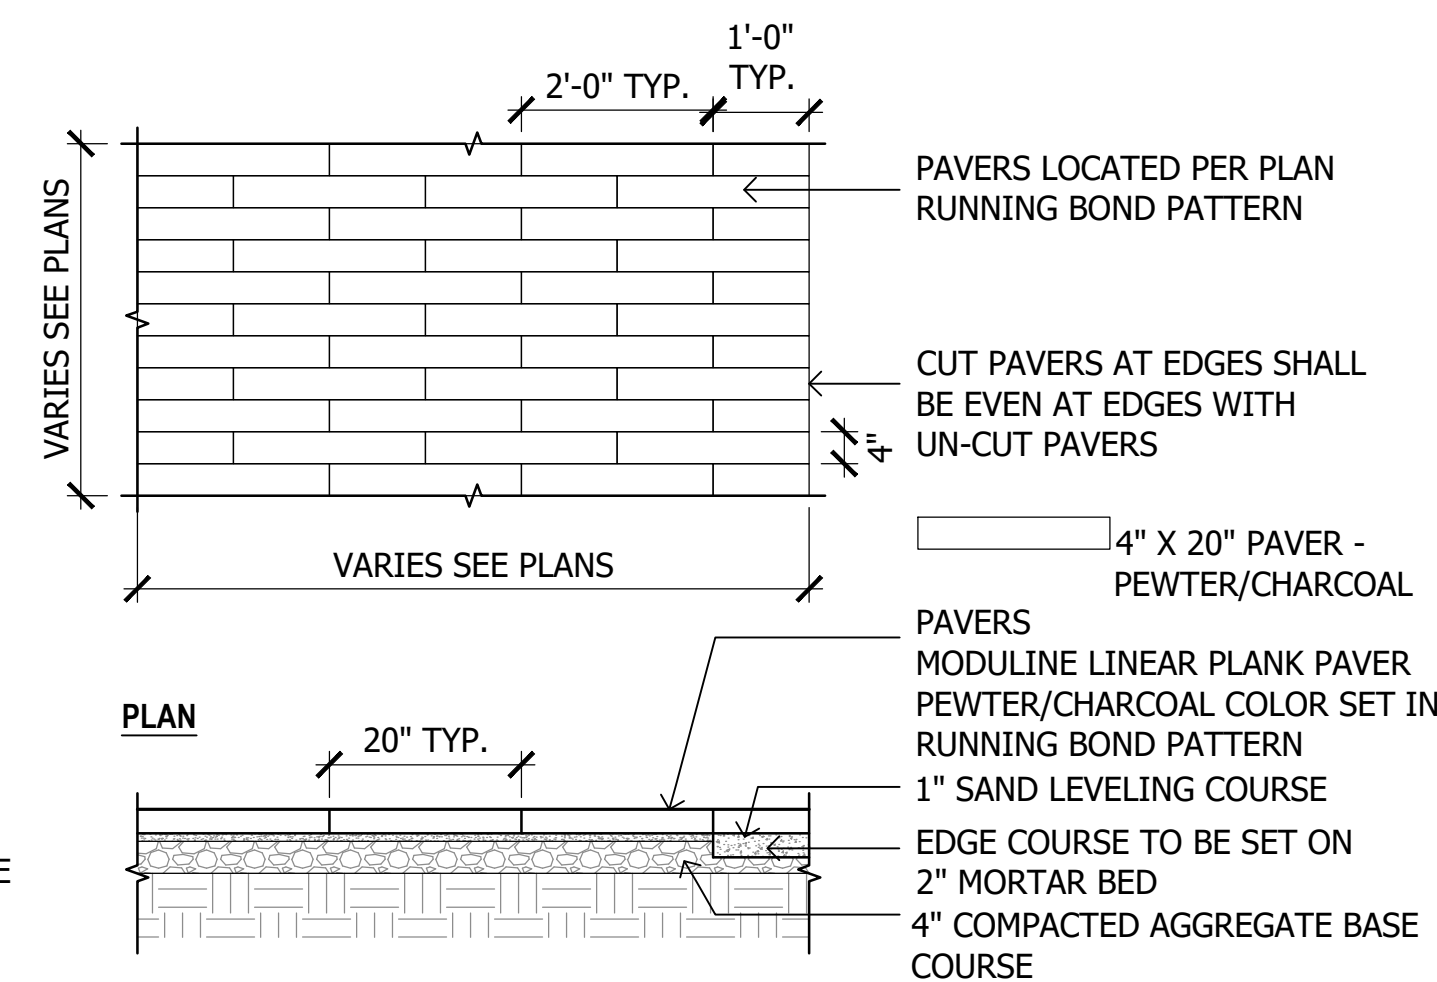


7 Linear Pavers

SCALE: 1/2"=1'-0"

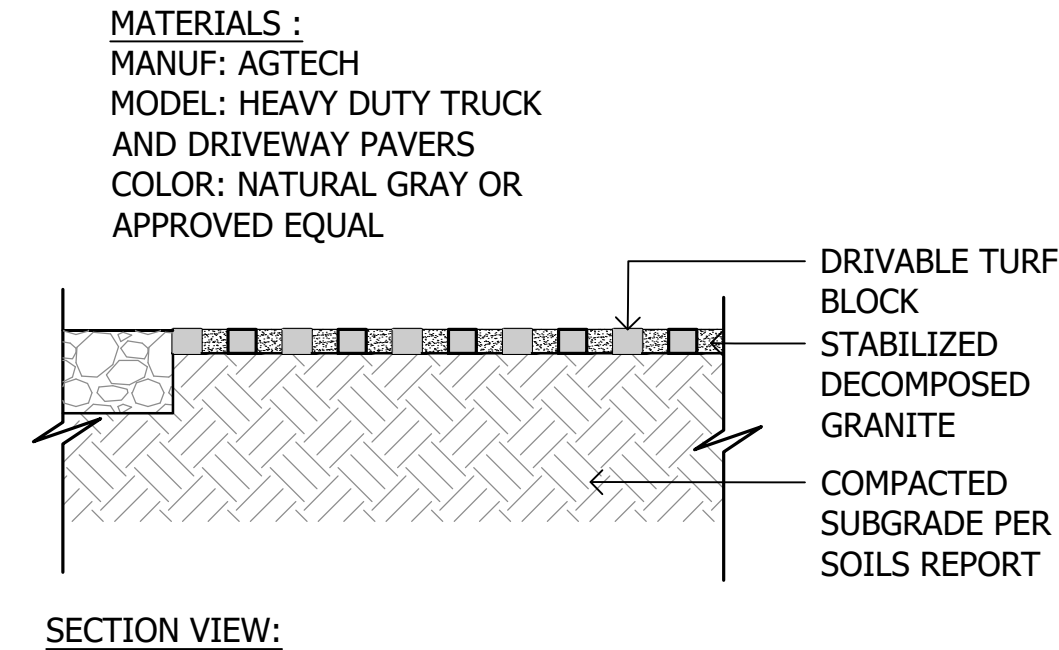

11 Artificial Turf at Grade

SCALE: 1"=1'-0"

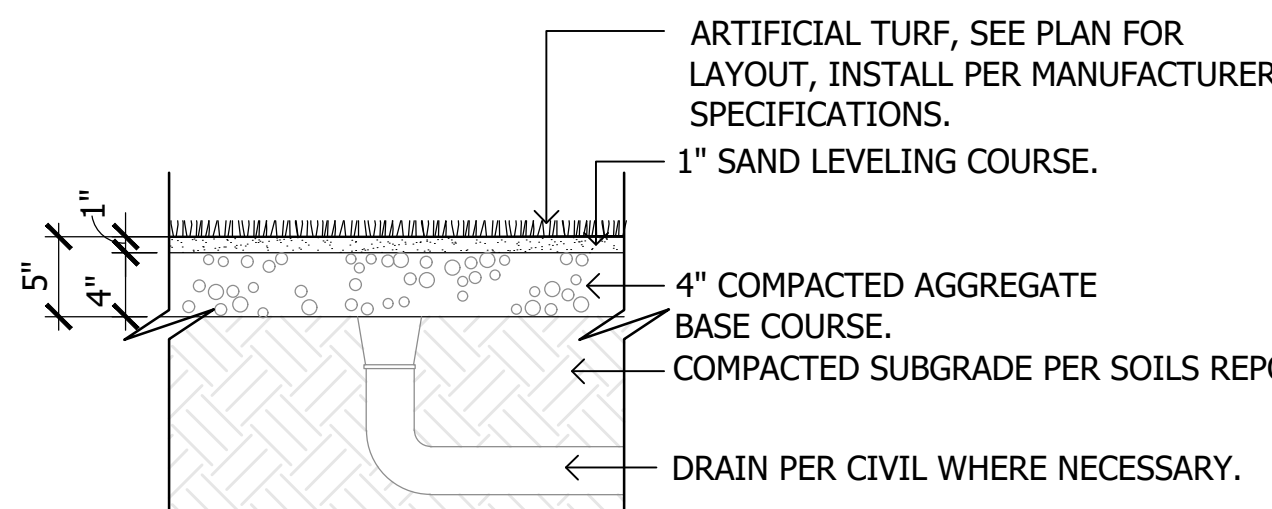

ARTIFICIAL TURF TYPICAL:

MANUF: SYNTHETIC TURF

MODEL: SOFTLAWN GARDEN RYE


WEB: <http://www.synthetic-turf.com>

PHONE: 1-800-405-7455

OR APPROVED EQUAL

3 Concrete Slab

SCALE: 1/2"=1'-0"

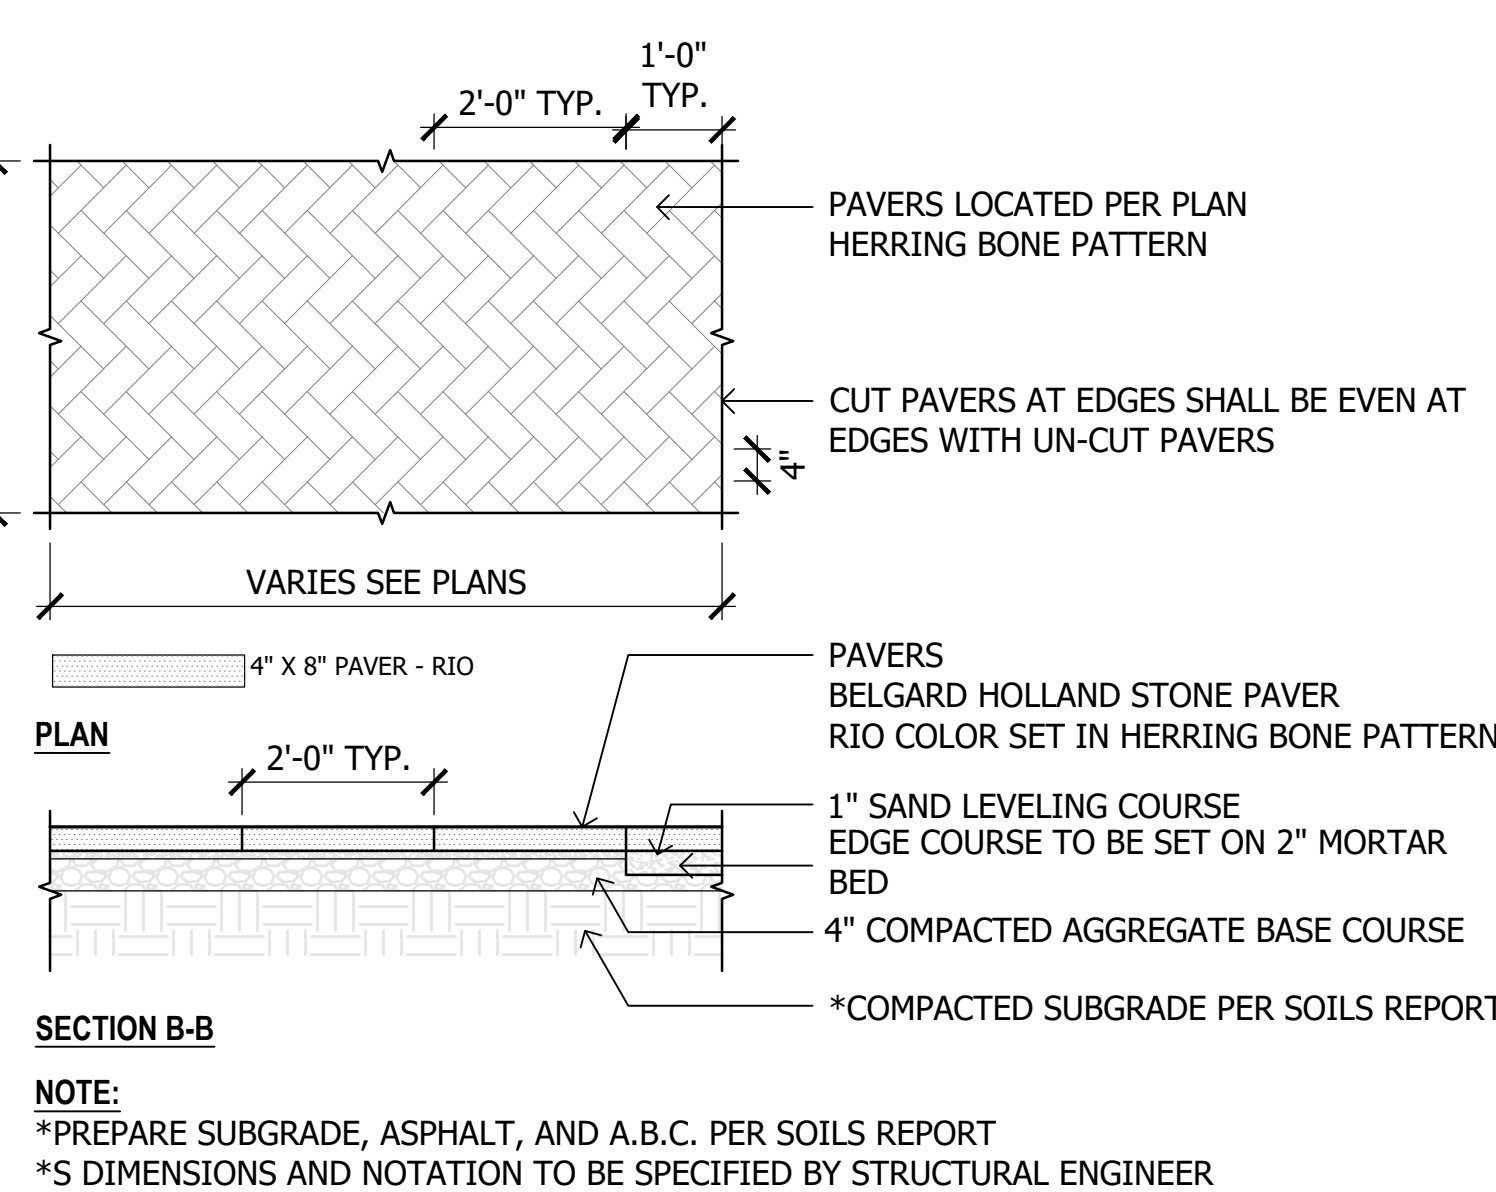


8 Herring Bone Pavers

SCALE: NTS

5 Exposed Aggregate Concrete

SCALE: 1/2"=1'-0"

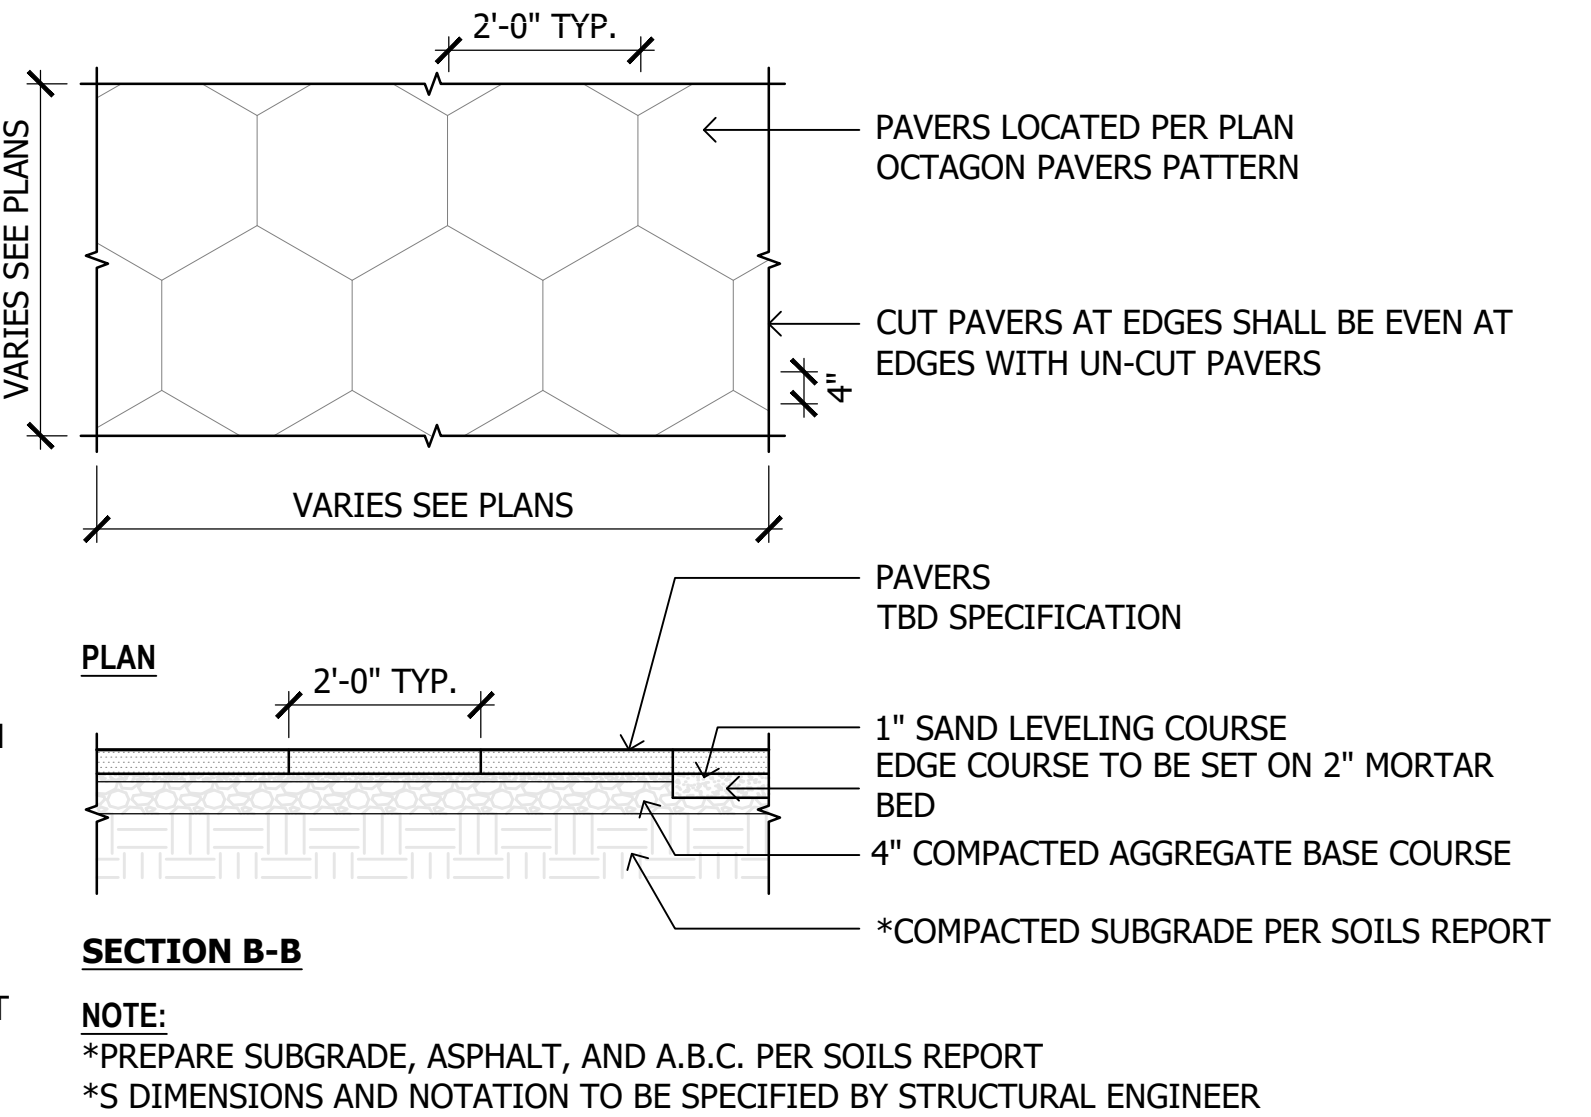


9 Octagon Pavers

SCALE: 1/2"=1'-0"

- GENERAL NOTES:
- *S DIMENSIONS PER STRUCTURAL ENGINEER.
 - *M DIMENSIONS PER MANUFACTURER SPECIFICATIONS.
 - INSTALL PER MANUFACTURER SPECIFICATIONS.
 - SEE MATERIALS LEGEND ON SHEET LA0.4 FOR MODEL AND COLOR.


MANUF: TILE TECH PAVER SYSTEM
TYPE: PORCELAIN PAVERS
SIZE: 24"x24"
PATTERN: TRAVERTINE SERIES PAVERS & CEMENT SERIES
POOL DECK COLOR: TRAVERTINE PEARL
POOL COPING COLOR: CEMENTO CEMENT

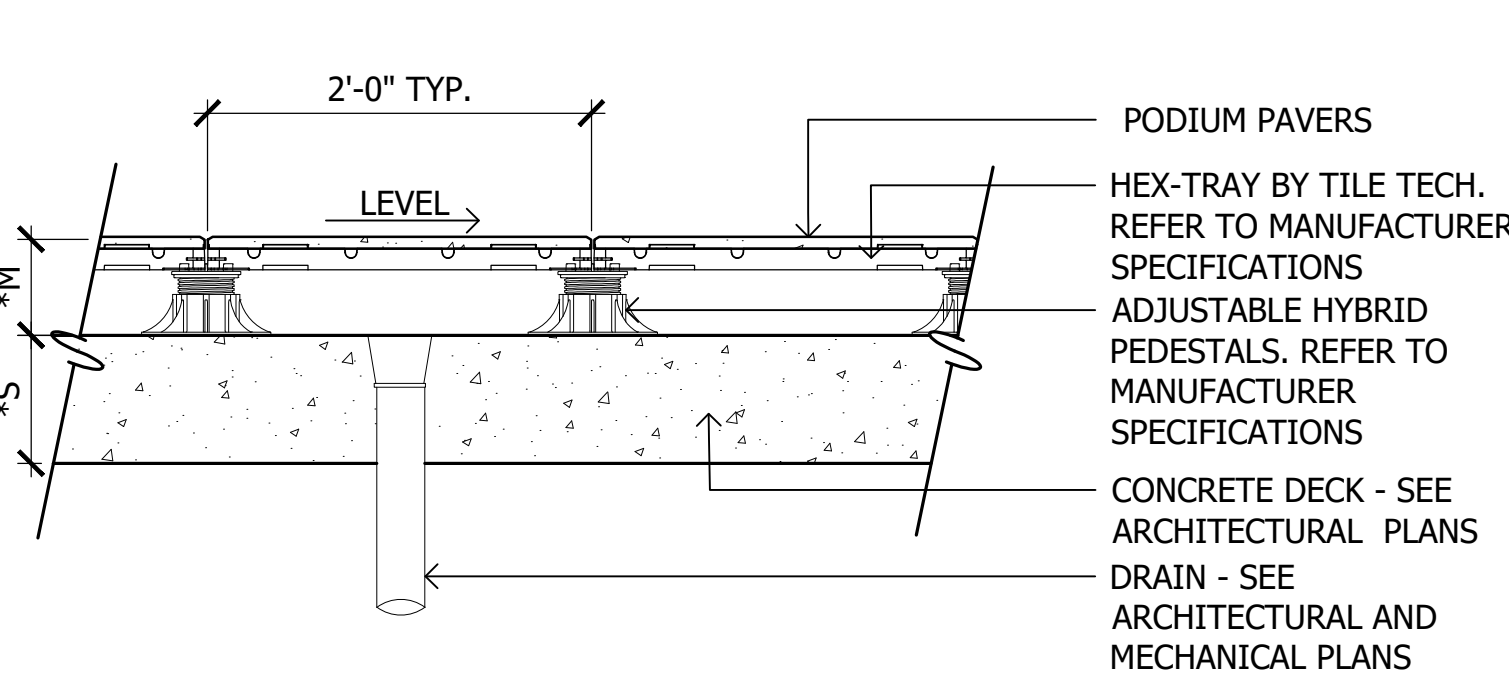

1 Podium Pavers

SCALE: 1"=1'-0"


- GENERAL NOTES:
- *S DIMENSIONS PER STRUCTURAL ENGINEER.
 - *M DIMENSIONS PER MANUFACTURER SPECIFICATIONS.
 - INSTALL PER MANUFACTURER SPECIFICATIONS.
 - SEE MATERIALS LEGEND ON SHEET LA0.4 FOR MODEL AND COLOR.

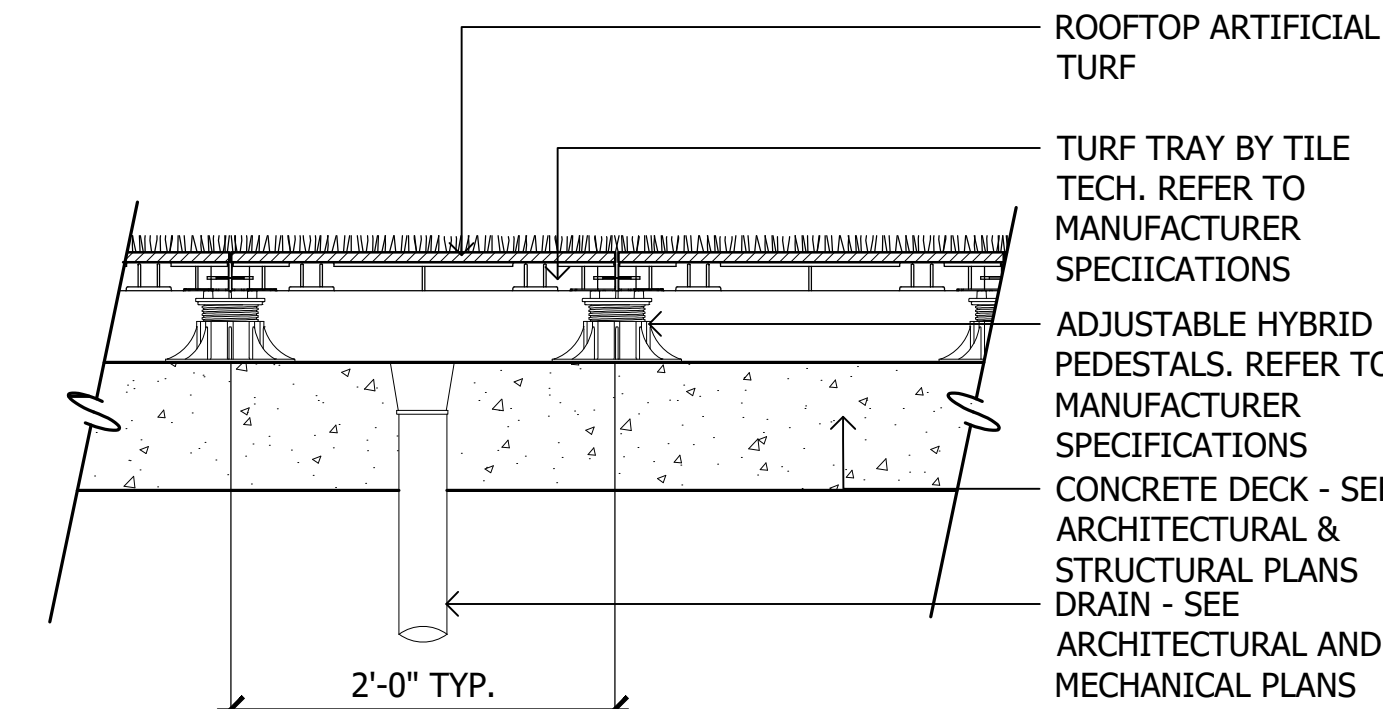

2 Podium Artificial Turf

SCALE: 1"=1'-0"


- COPING
MANUF: TILETECH PAVER SYSTEM
TYPE: PORCELAIN PAVERS
SIZE: 24" SQ.
PATTERN: STONE SERIES
COLOR: TERRAZO GRAY OR APPROVED
EQUAL
- WATERLINE TILE
NOBLE TILE SUPPLY
6" x 6"
NSSC 641 - LIGHT BLUE

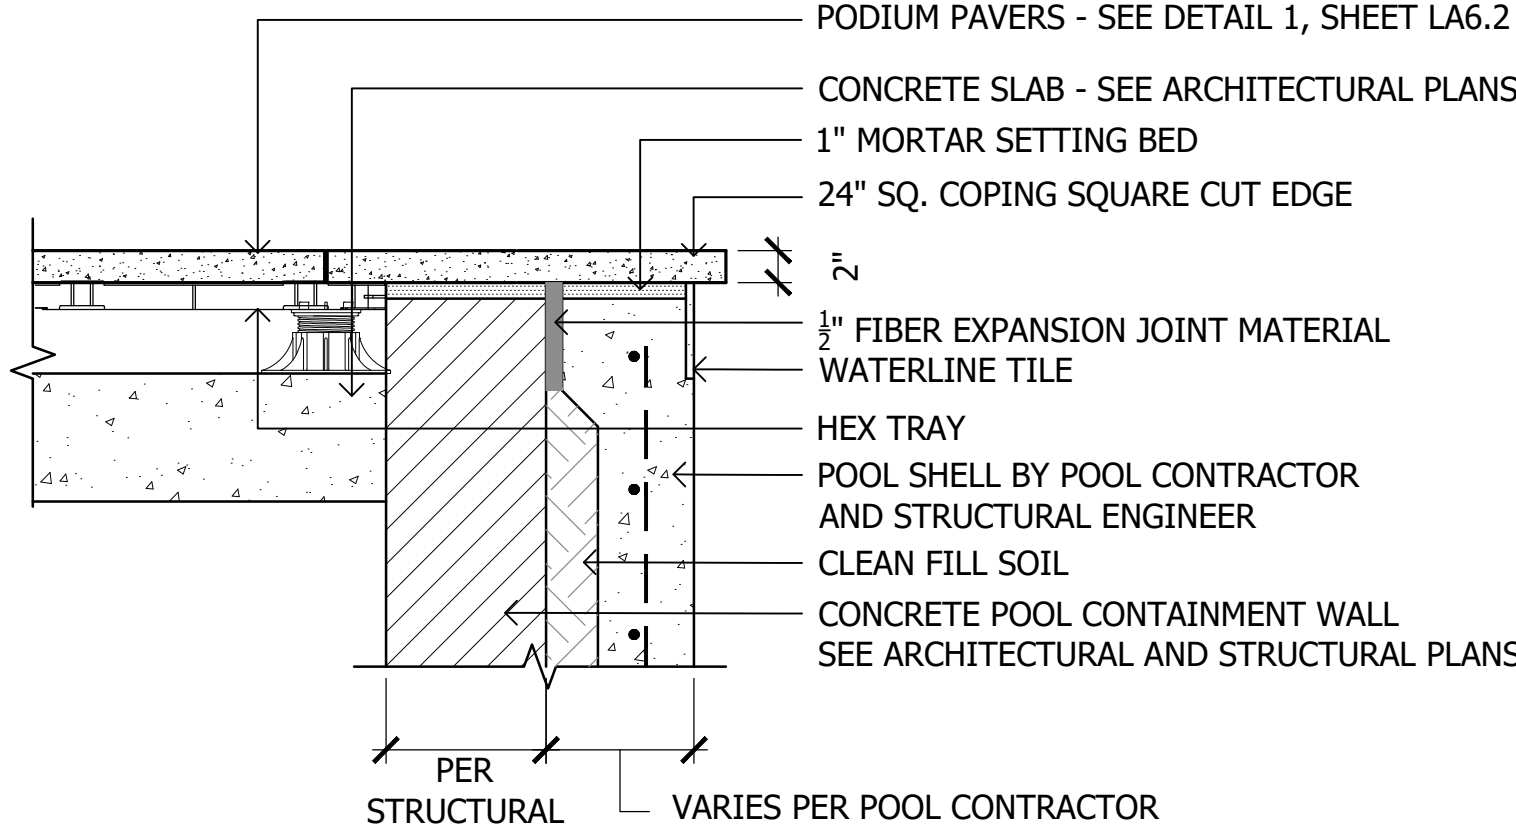

3 Pool & Spa Coping


SCALE: 1"=1'-0"

- GENERAL NOTES:
- INSTALL PER MANUFACTURER SPECIFICATIONS.
 - SEE MATERIALS LEGEND ON SHEET LA0.4 FOR MODEL AND COLOR.
 - WHERE POTS INSTALLED OVER PODIUM PEDESTAL SYSTEM, A STRUCTURAL HEX BACKING IS REQUIRED.
 - REFER TO SHEETS LA2.1-LA2.8 FOR LOCATIONS.
 - POT SIZE VARIES PER PLAN

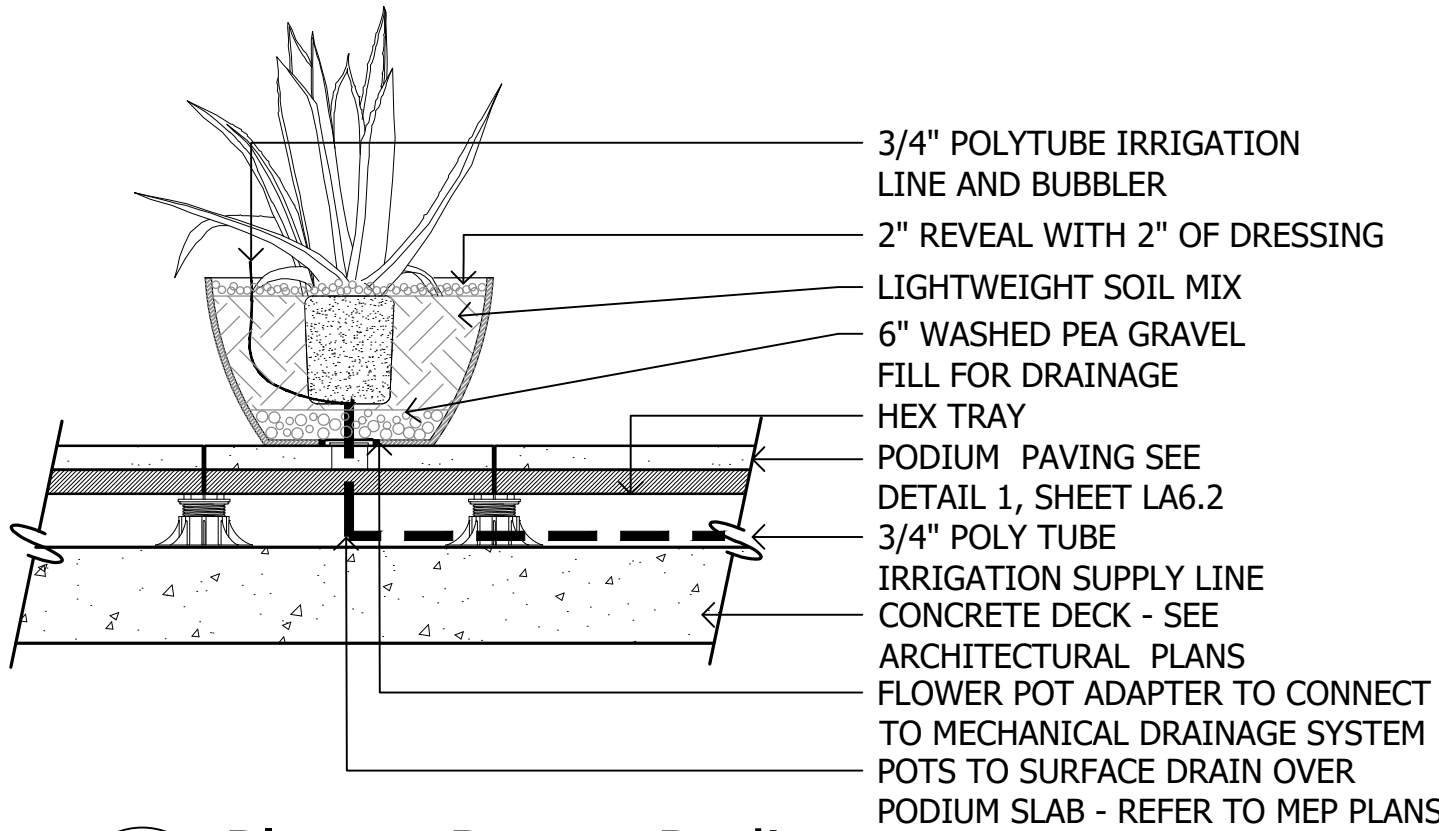


4 Planter Pot on Podium

SCALE: 3/4"=1'-0"

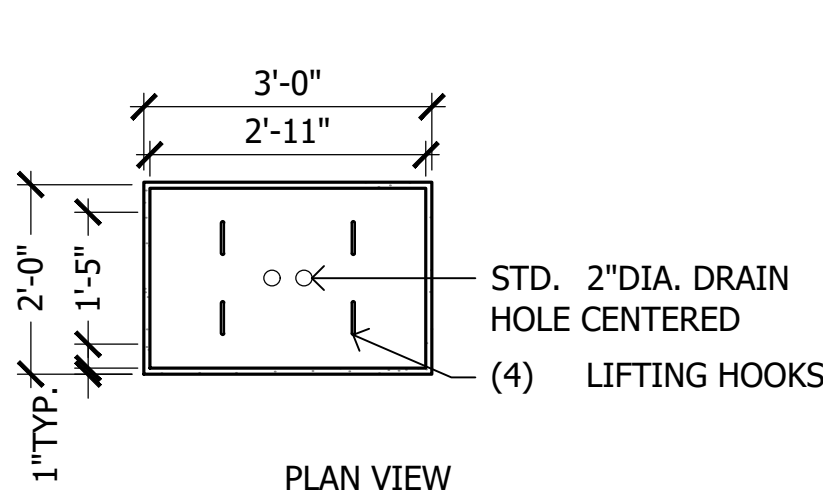


- GENERAL NOTES:
- INSTALL PER MANUFACTURER SPECIFICATIONS.
 - SEE MATERIALS LEGEND ON SHEET LA0.4 FOR MODEL AND COLOR.

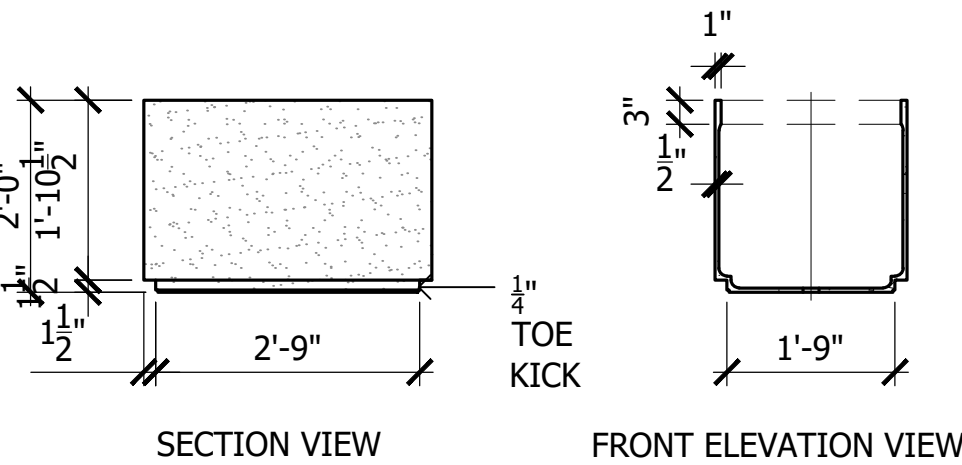


5 24"X36" Rectangular Planter

SCALE: N.T.S

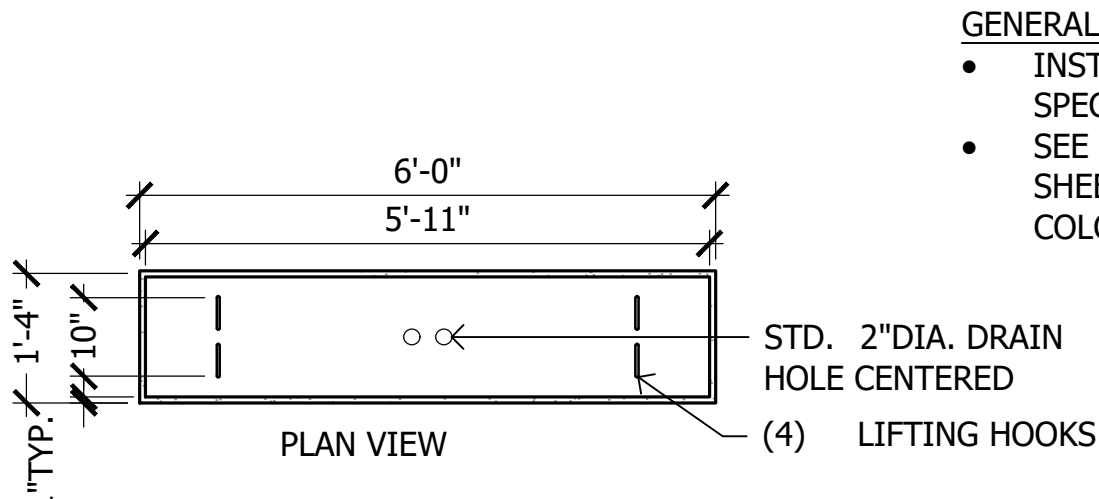


- GENERAL NOTES:
- INSTALL PER MANUFACTURER SPECIFICATIONS.
 - SEE MATERIALS LEGEND ON SHEET LA0.4 FOR MODEL AND COLOR.

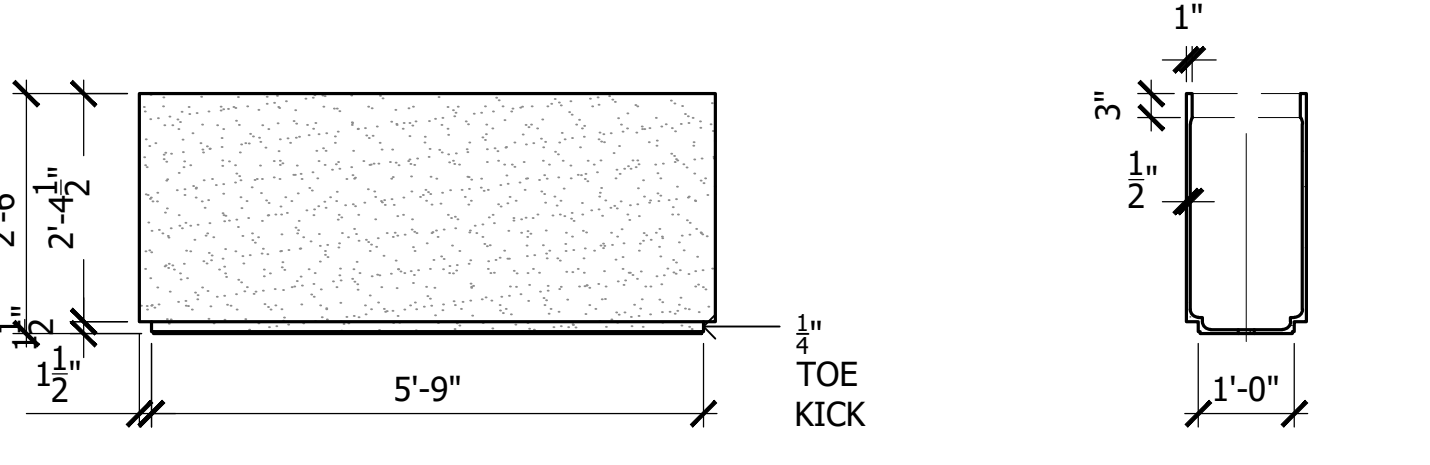


6 15"X72" Rectangular Planter

SCALE: N.T.S


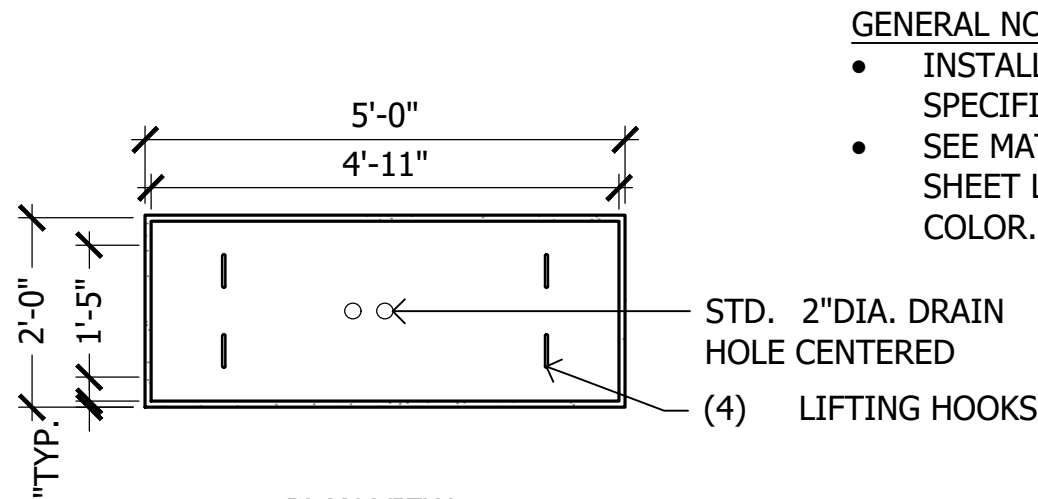


- GENERAL NOTES:
- INSTALL PER MANUFACTURER SPECIFICATIONS.
 - SEE MATERIALS LEGEND ON SHEET LA0.4 FOR MODEL AND COLOR.


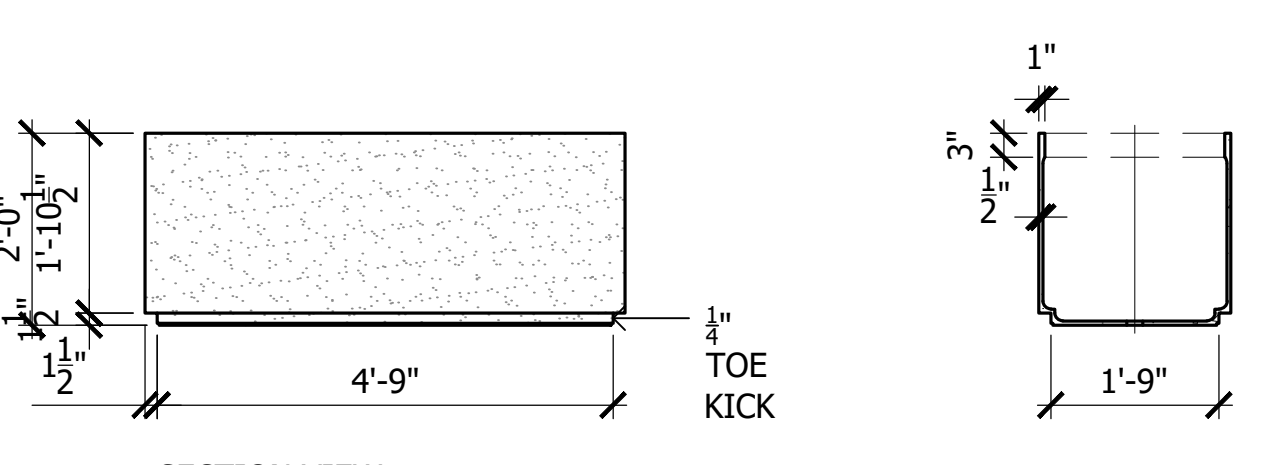


7 24"X60" Rectangular Planter

SCALE: N.T.S

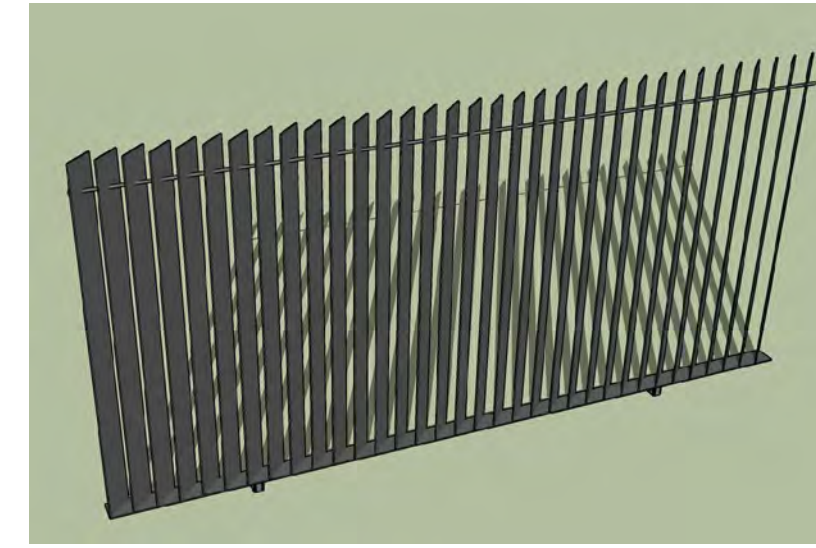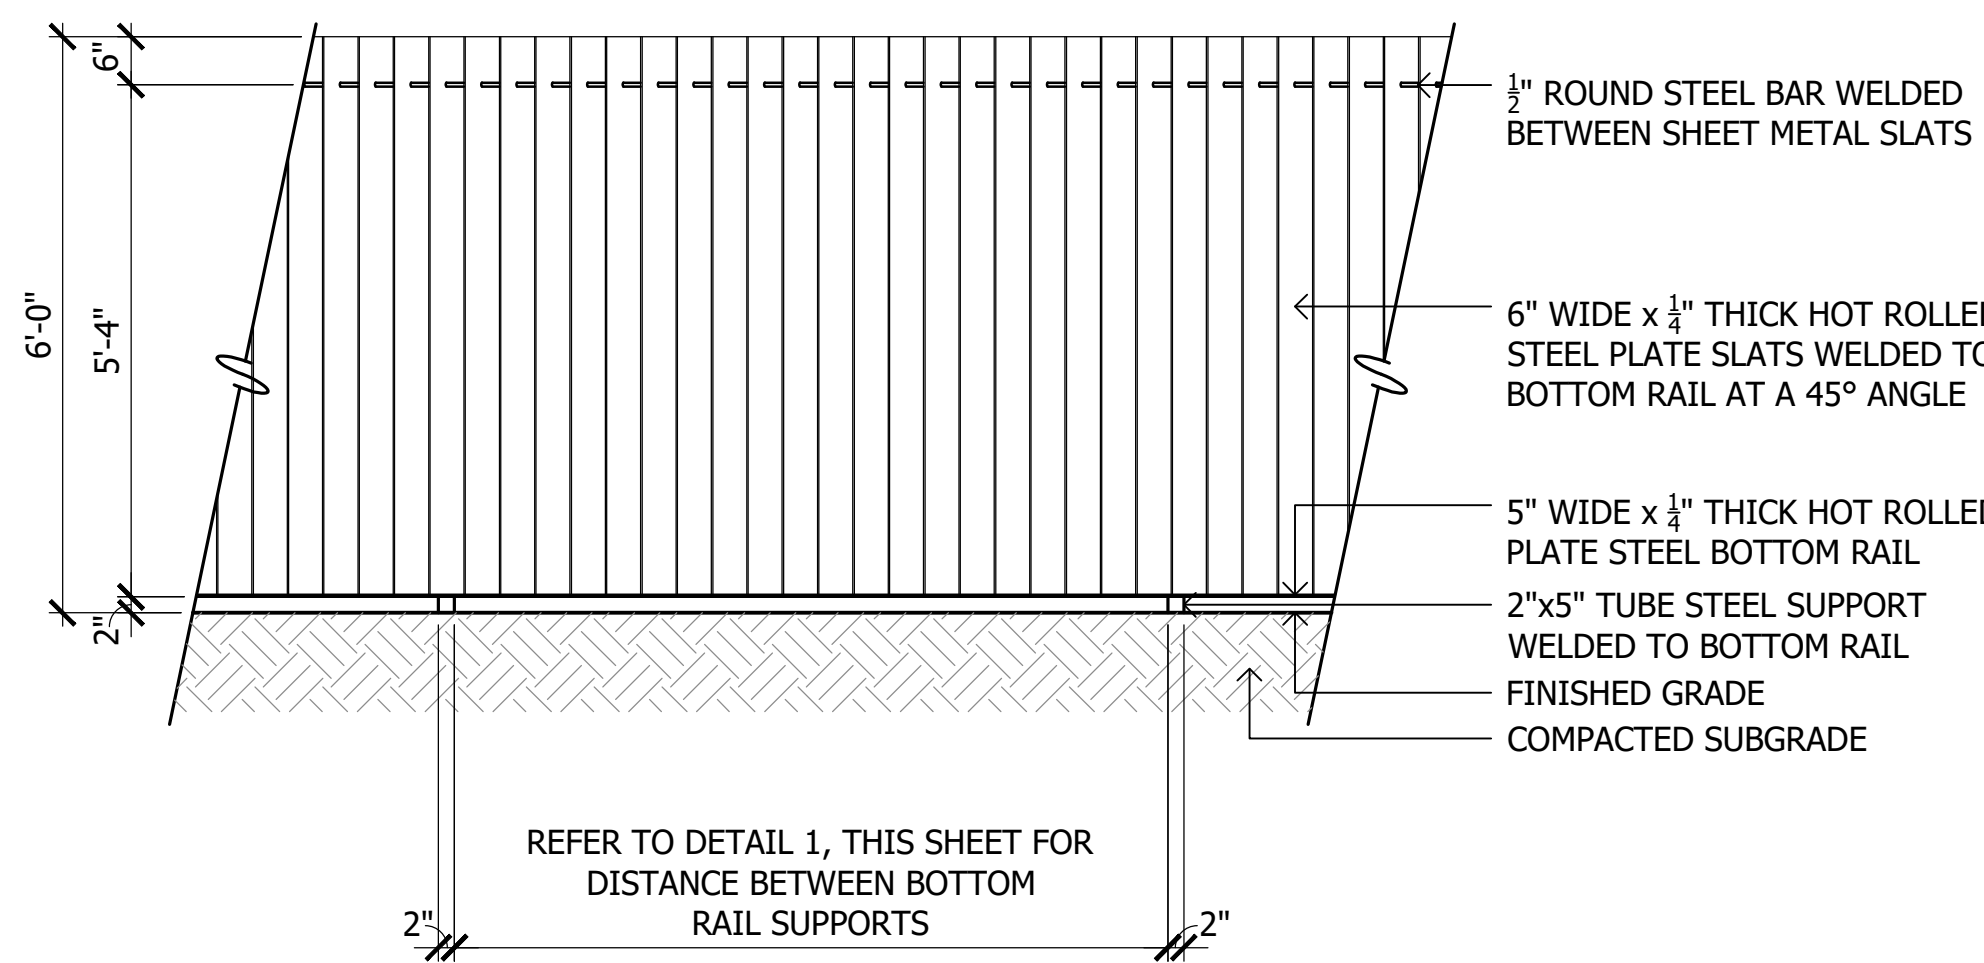

CHARACTER IMAGE

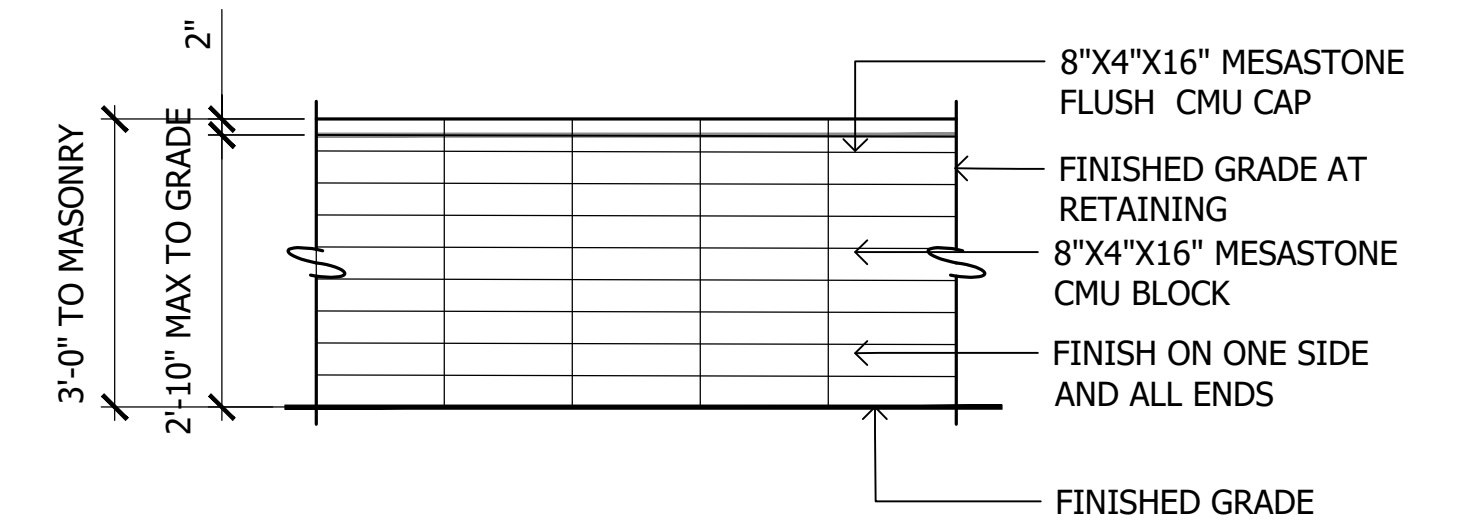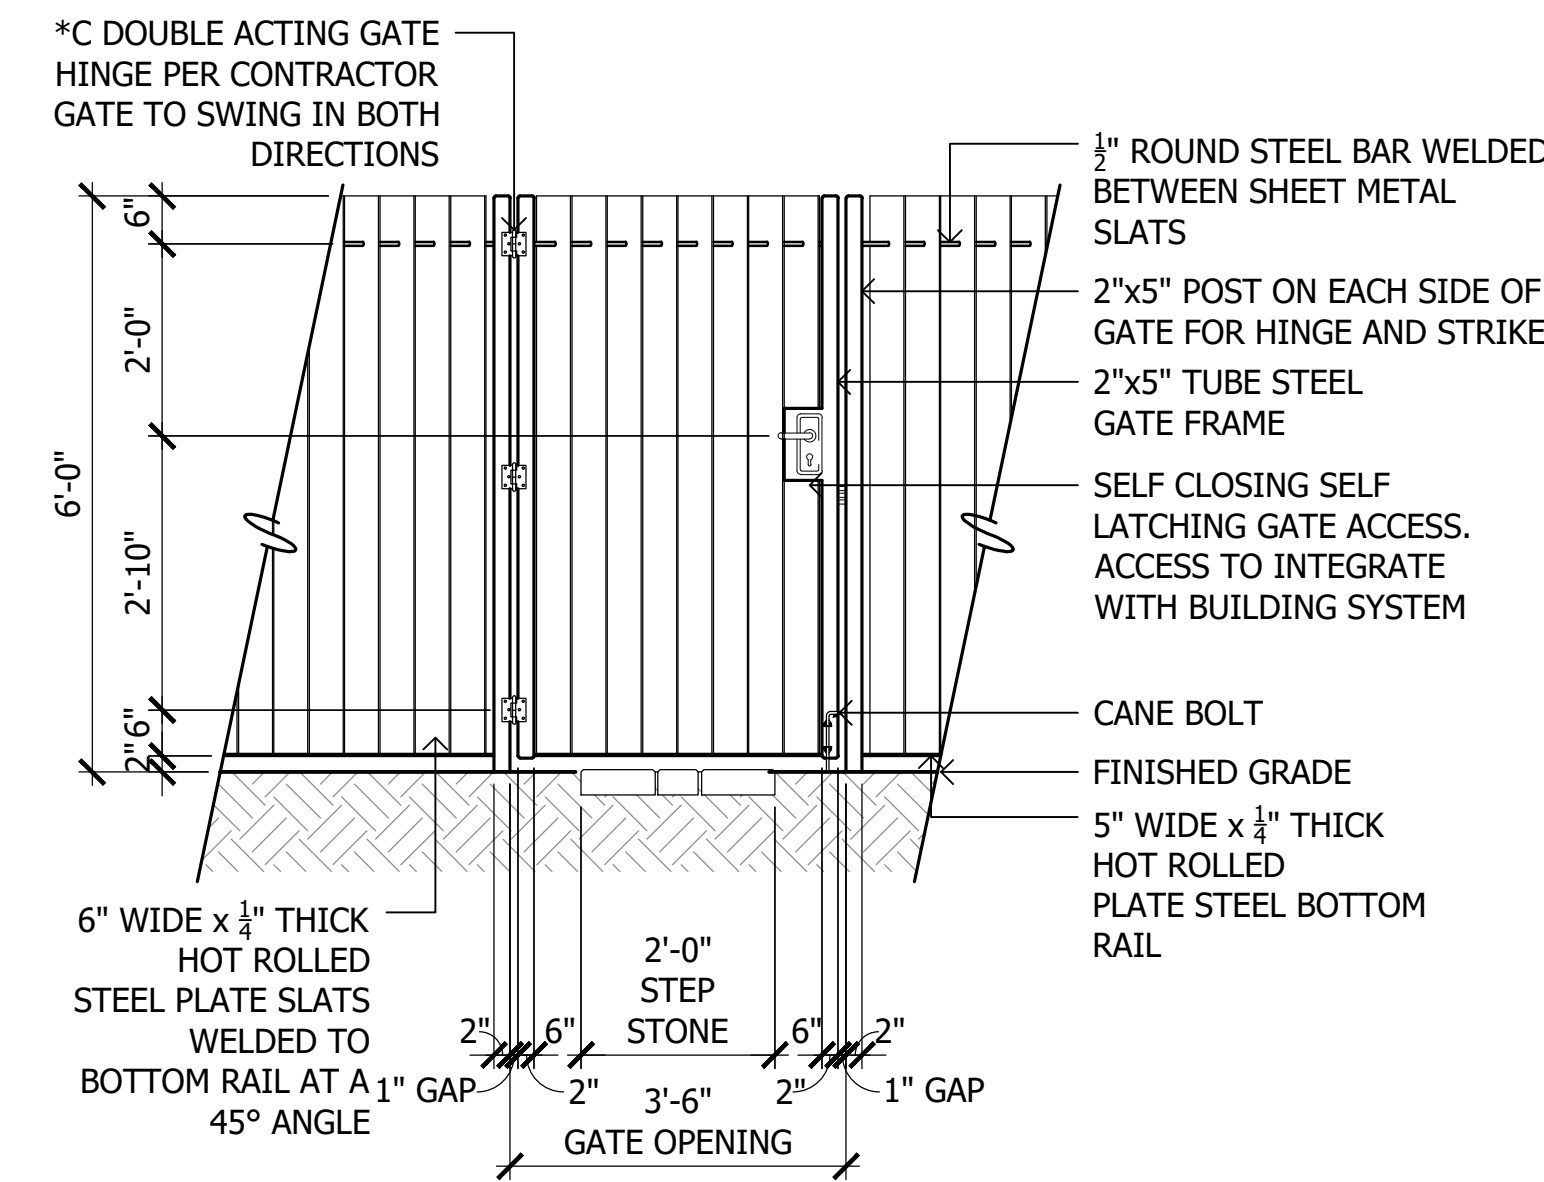

1 Slat Fence




SCALE: 1/2"=1'-0"

2 Slat Fence Gate

SCALE: 1/2"=1'-0"

3 Low Retaining Wall at Grade

SCALE: 1/2"=1'-0"

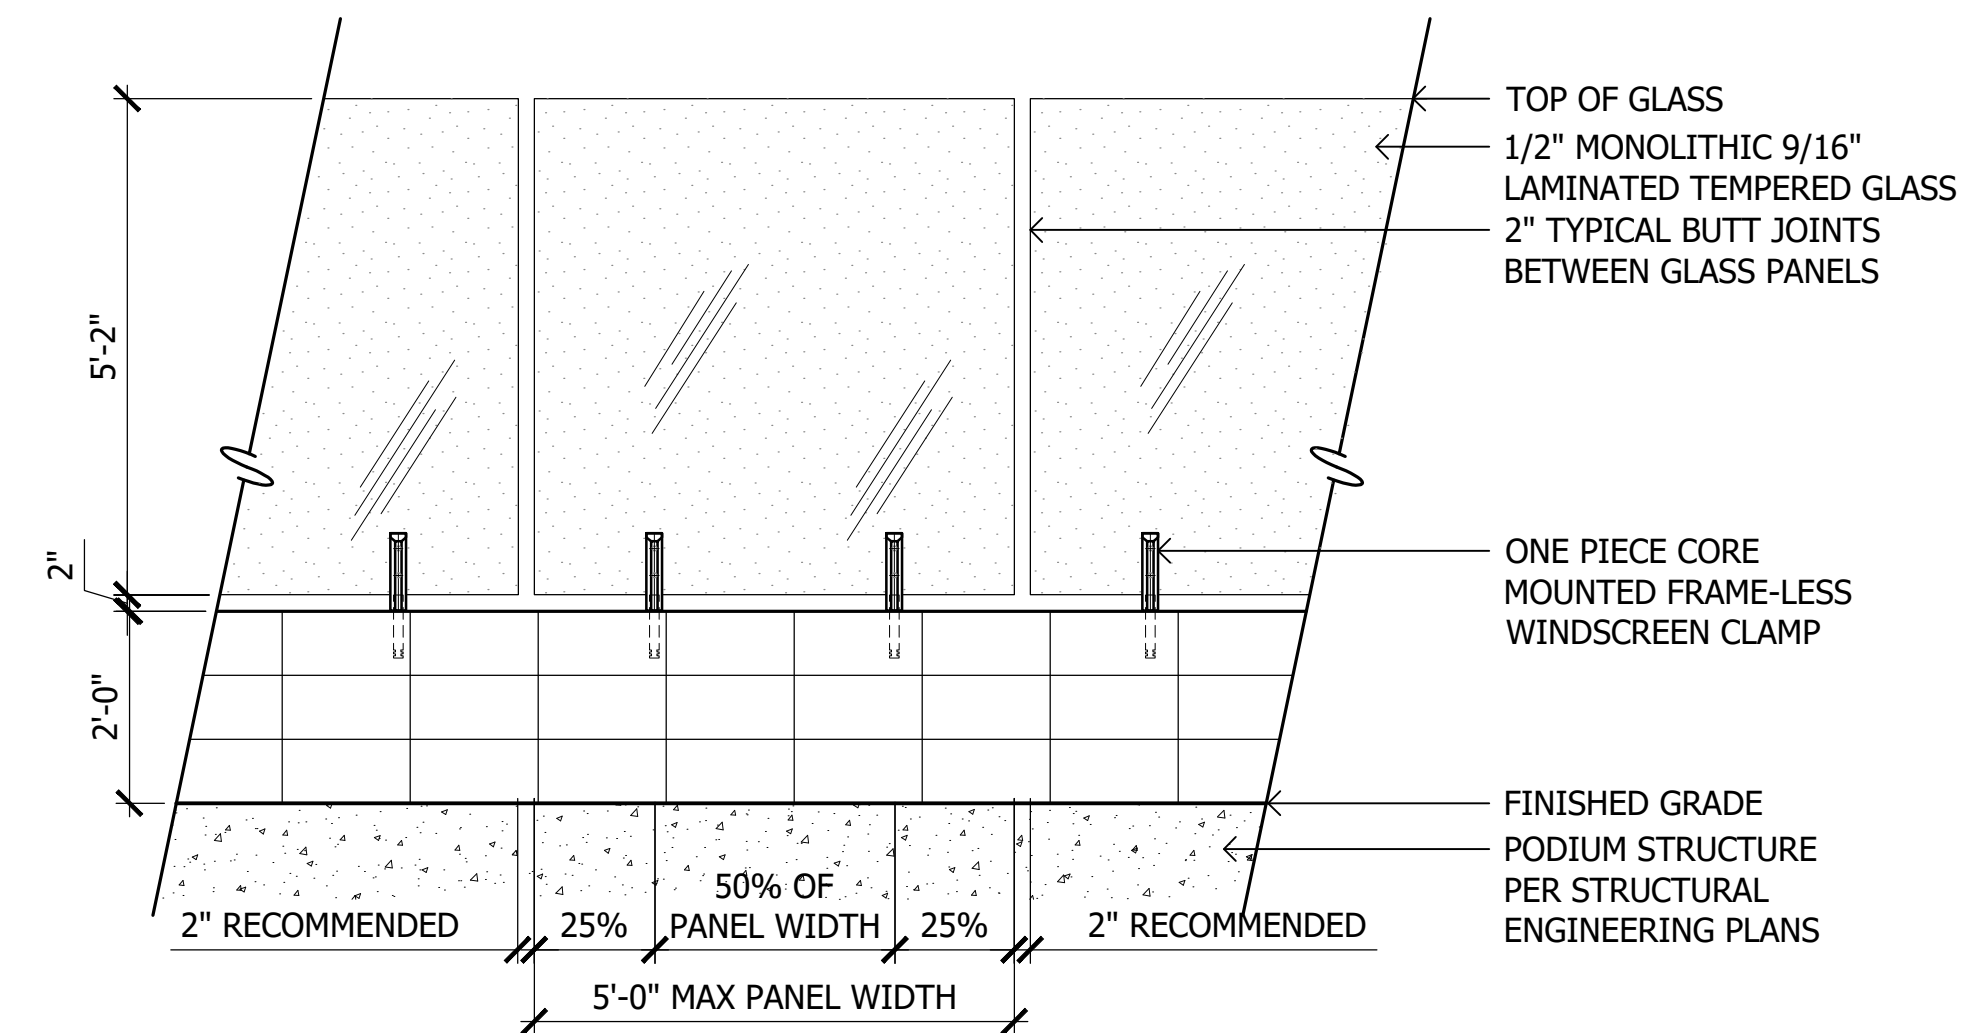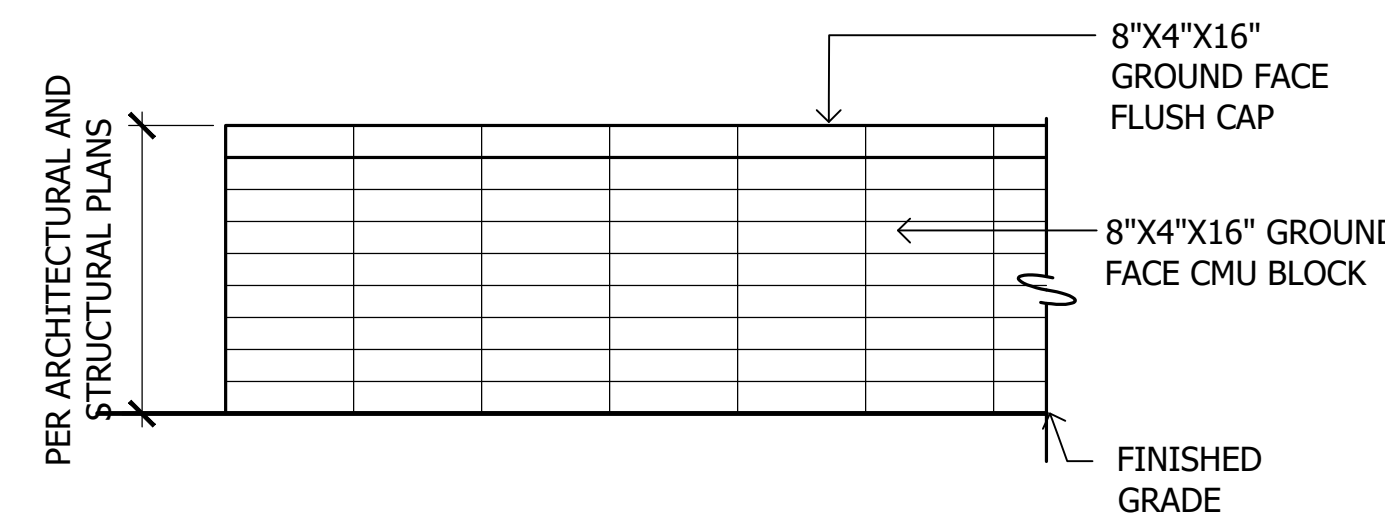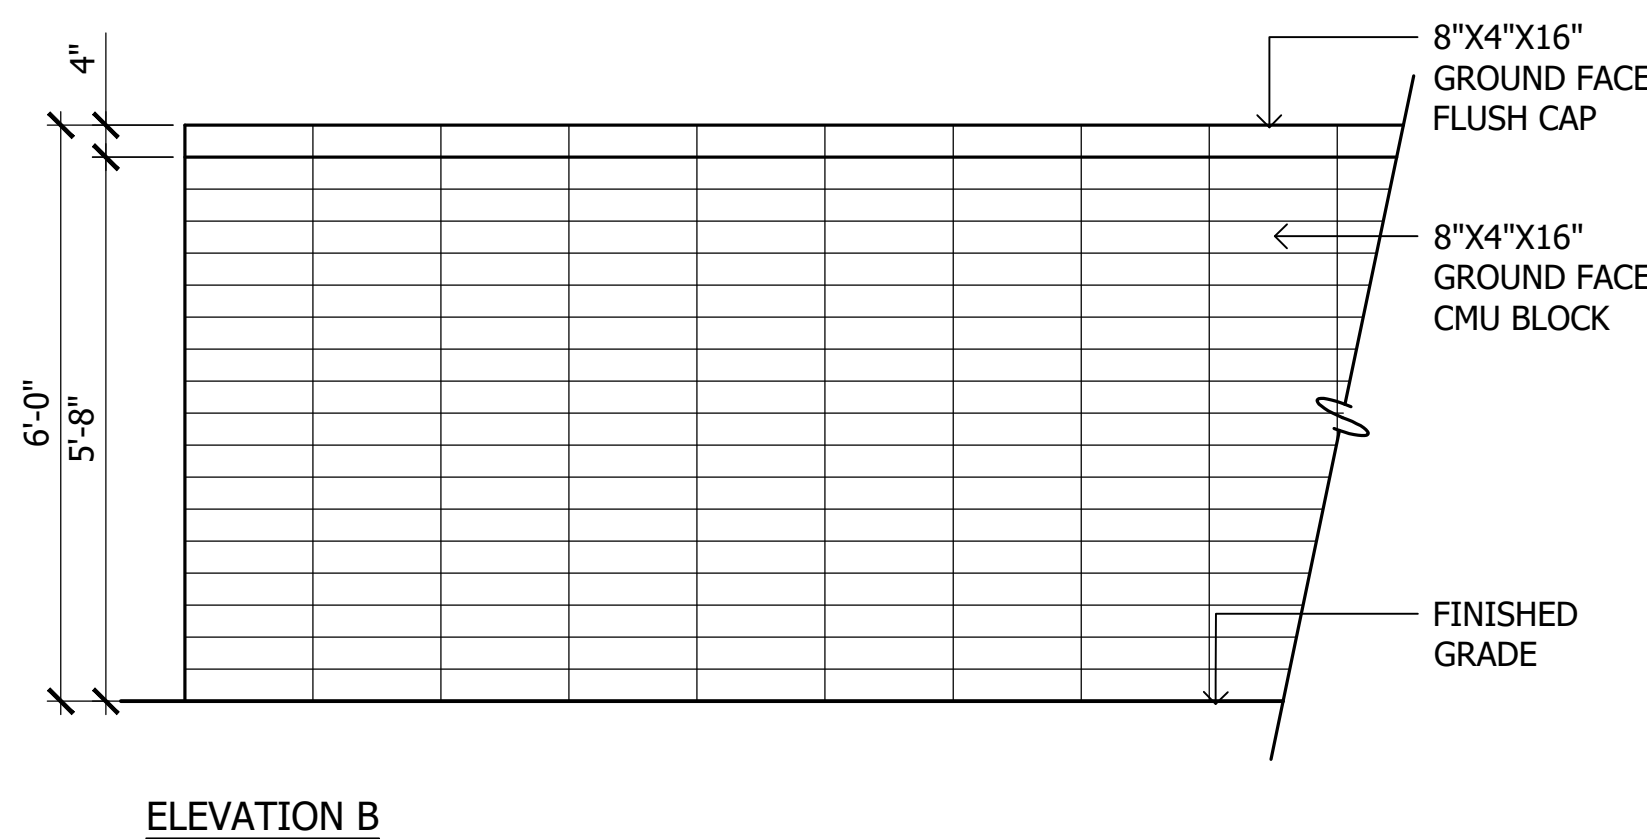

4 Decorative Screen Wall




SCALE: 1/2"=1'-0"

5 Unit Patio Wall

SCALE: 1/2"=1'-0"

6 Glass Pool Barrier

SCALE: 1/2"=1'-0"

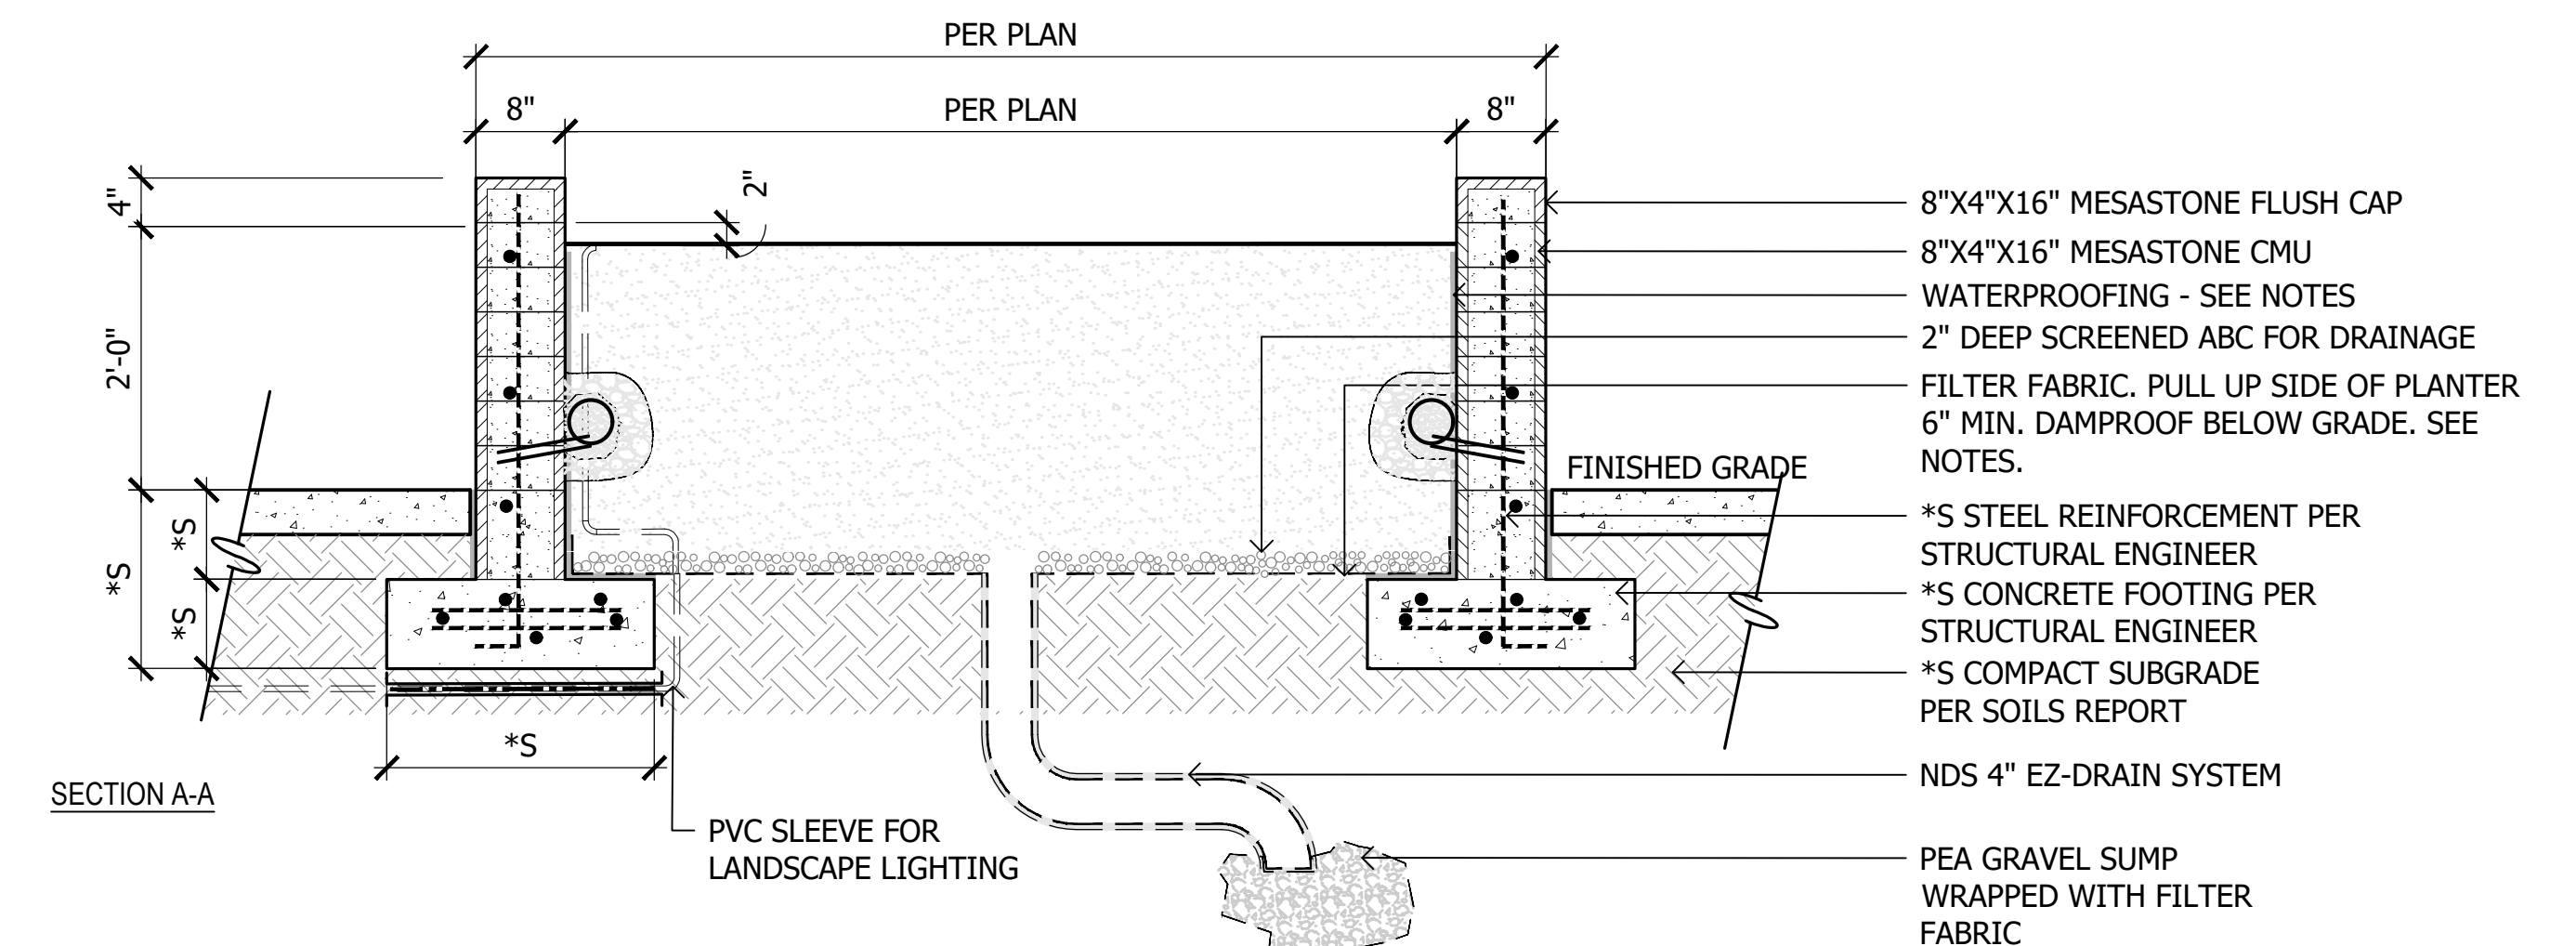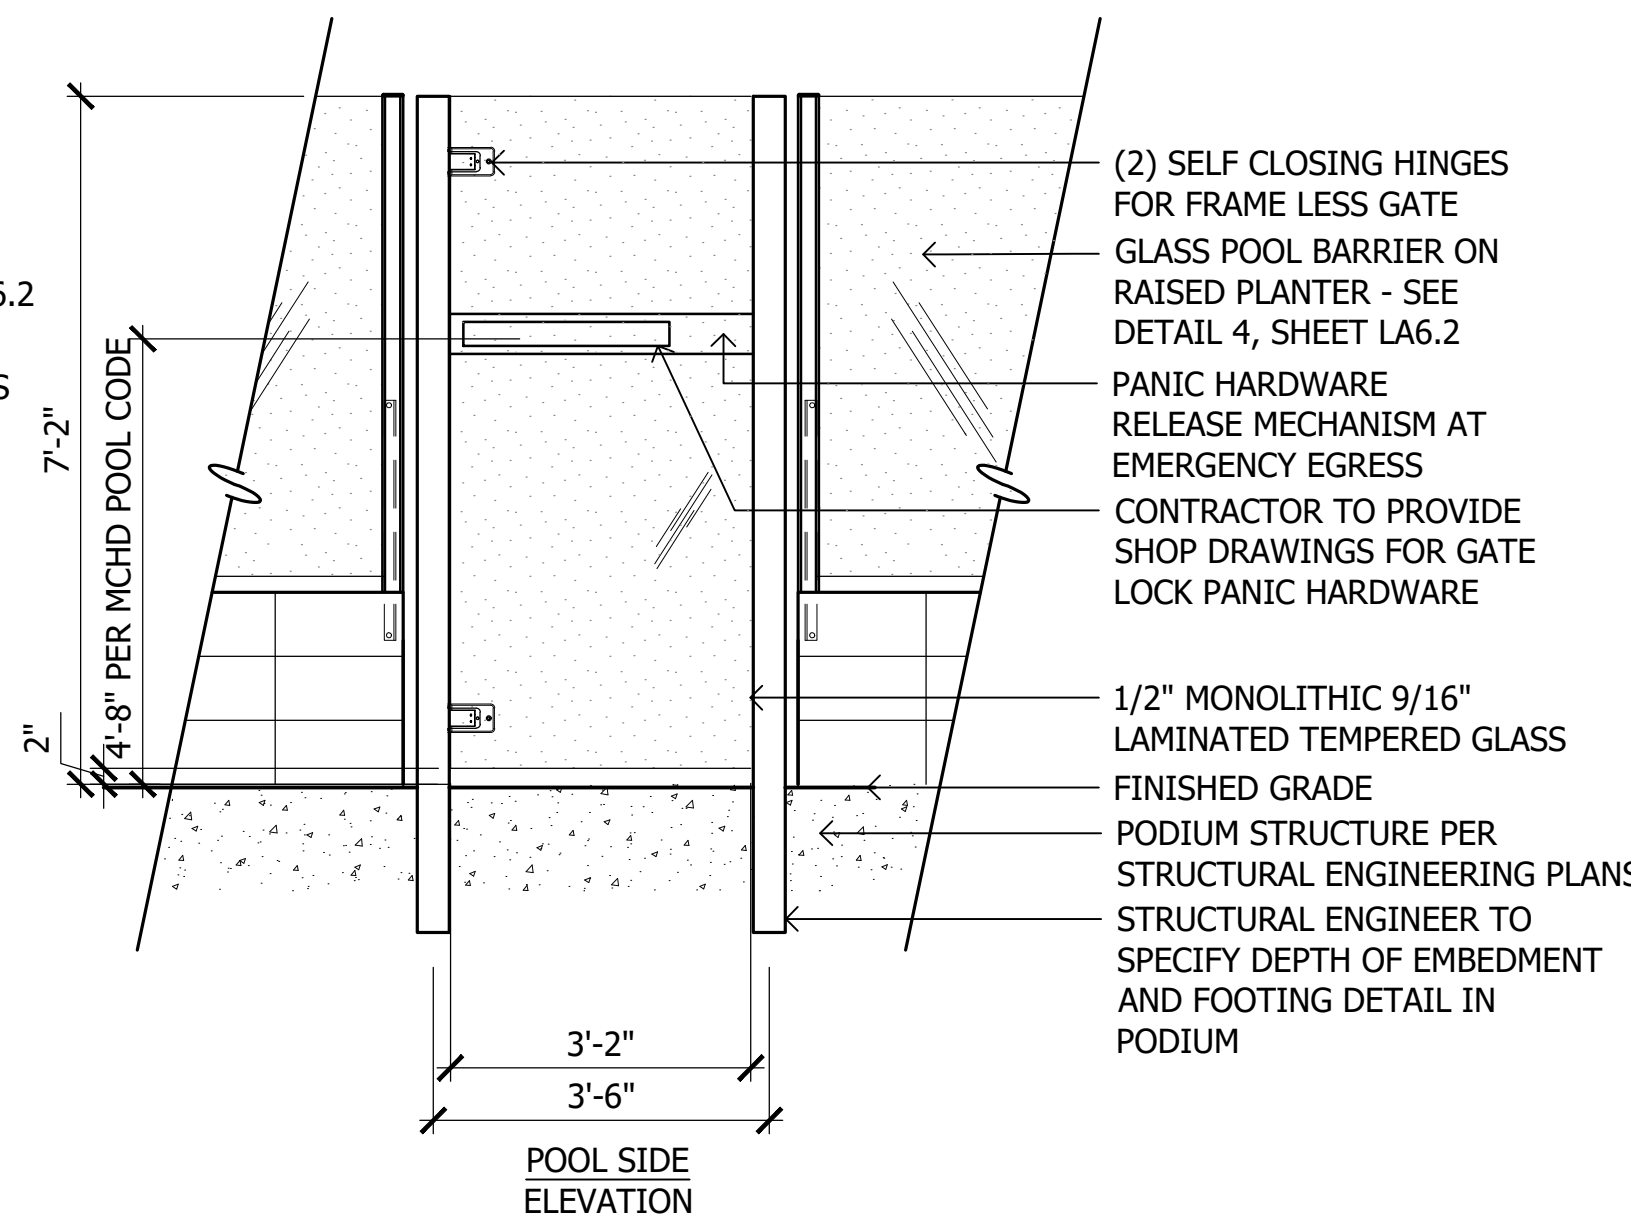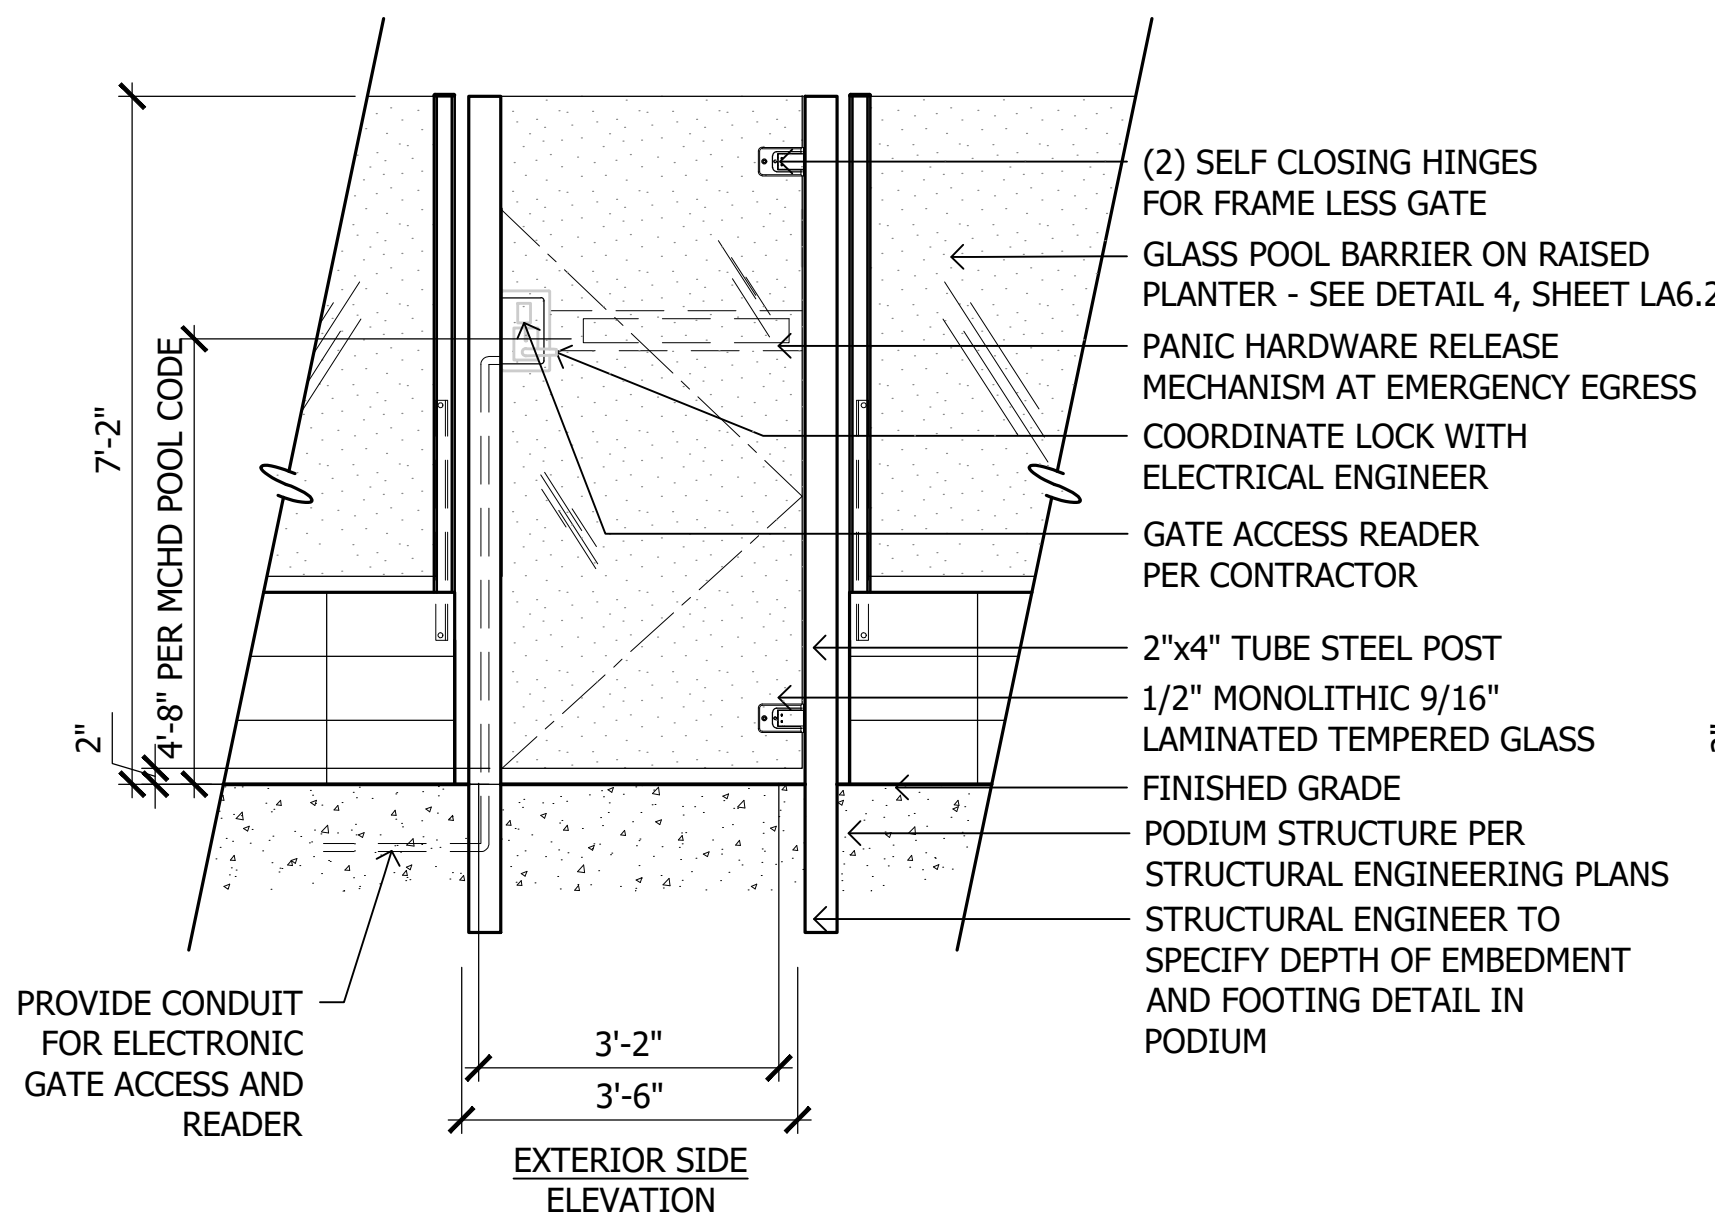


7 Glass Pool Gate on Podium

SCALE: 1/2"=1'-0"


8 Raised Planter at Grade

SCALE: 3/4"=1'-0"

- REFER TO MATERIALS LEGEND, SHEET LA0.4 FOR COLORS AND FINISHES.
- INSTALLATION TO BE COMPLETED IN ACCORDANCE WITH MANUFACTURER'S SPECIFICATIONS.
- DO NOT SCALE DRAWINGS.
- ALL STEEL COMPONENTS TO BE POWDER COATED AND ALL WELDS TO BE GROUND SMOOTH.
- CONTRACTOR TO SUBMIT SAMPLES TO LANDSCAPE ARCHITECT FOR APPROVAL PRIOR TO CONSTRUCTION.
- CONTRACTOR TO SUBMIT ALL MATERIALS AND SHOP DRAWINGS TO LANDSCAPE ARCHITECT/CLIENT FOR REVIEW PRIOR TO CONSTRUCTION.

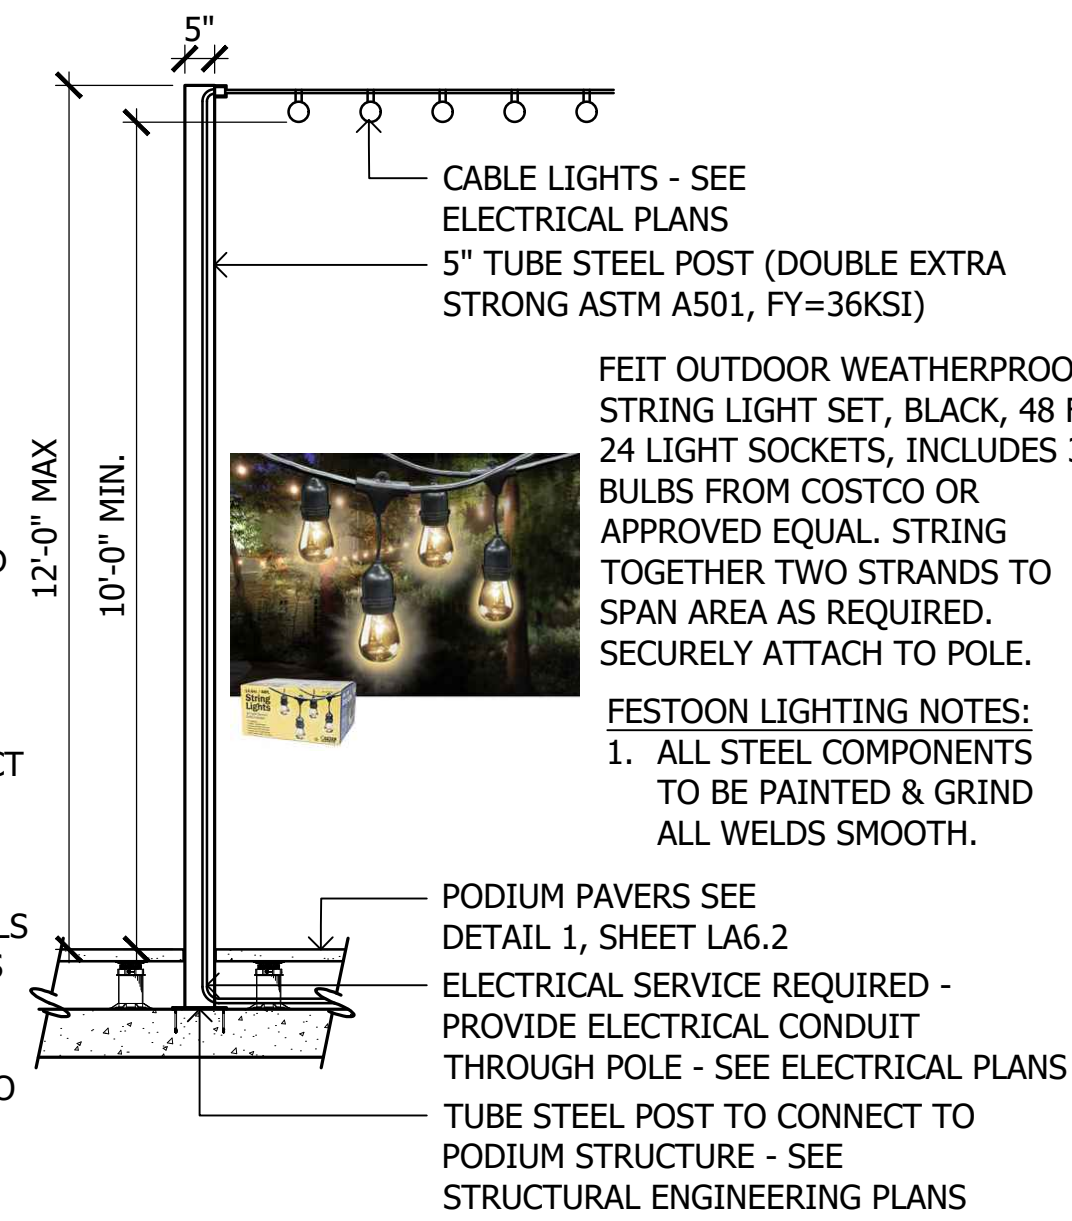


SCALE: 3/8"=1'-0"

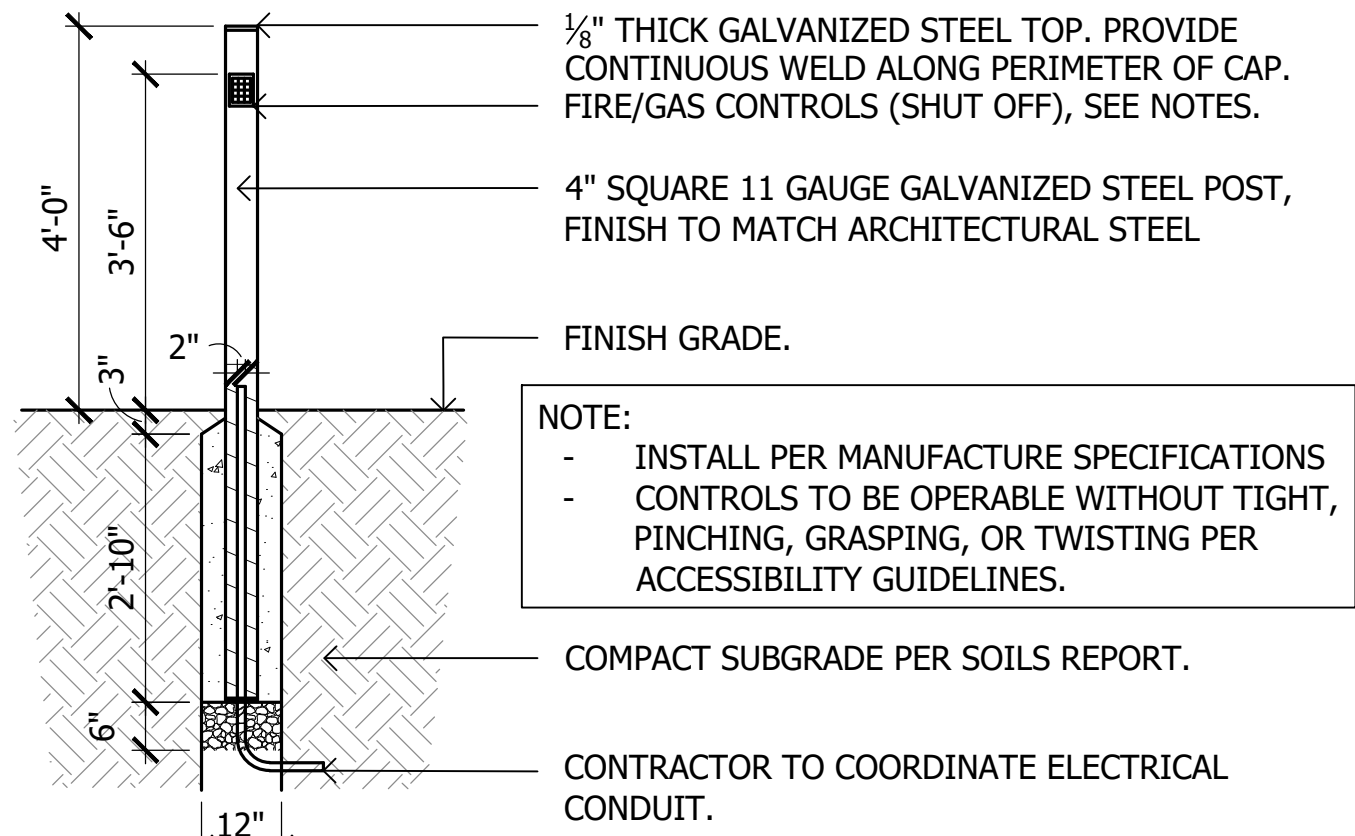


- CONTRACTOR TO SUBMIT ALL MATERIALS & SHOP DRAWINGS TO LANDSCAPE ARCHITECT FOR REVIEW PRIOR TO CONSTRUCTION.
- CONTRACTOR TO PROVIDE SKYTECH 1.5 HOUR TIMER SKY-TM-3 ON ALL FIRE FEATURES. CONTRACTOR OR MECHANICAL ENGINEER TO PROVIDE SPECIFICATIONS ON GAS LINES, GAS CONNECTIONS, TIMERS, EMERGENCY SHUT OFFS (VALVES), KEY PAD OPERATORS, OR ANY NECESSARY EQUIPMENT OR PARTS TO SAFELY FUNCTION GAS COMPONENTS, INSTALL PER LOCAL CODES.

SCALE: 1/2"=1'-0"

- REFER TO MATERIALS LEGEND, SHEET LA0.4 FOR COLORS AND FINISHES.
- INSTALLATION TO BE COMPLETED IN ACCORDANCE WITH MANUFACTURER'S

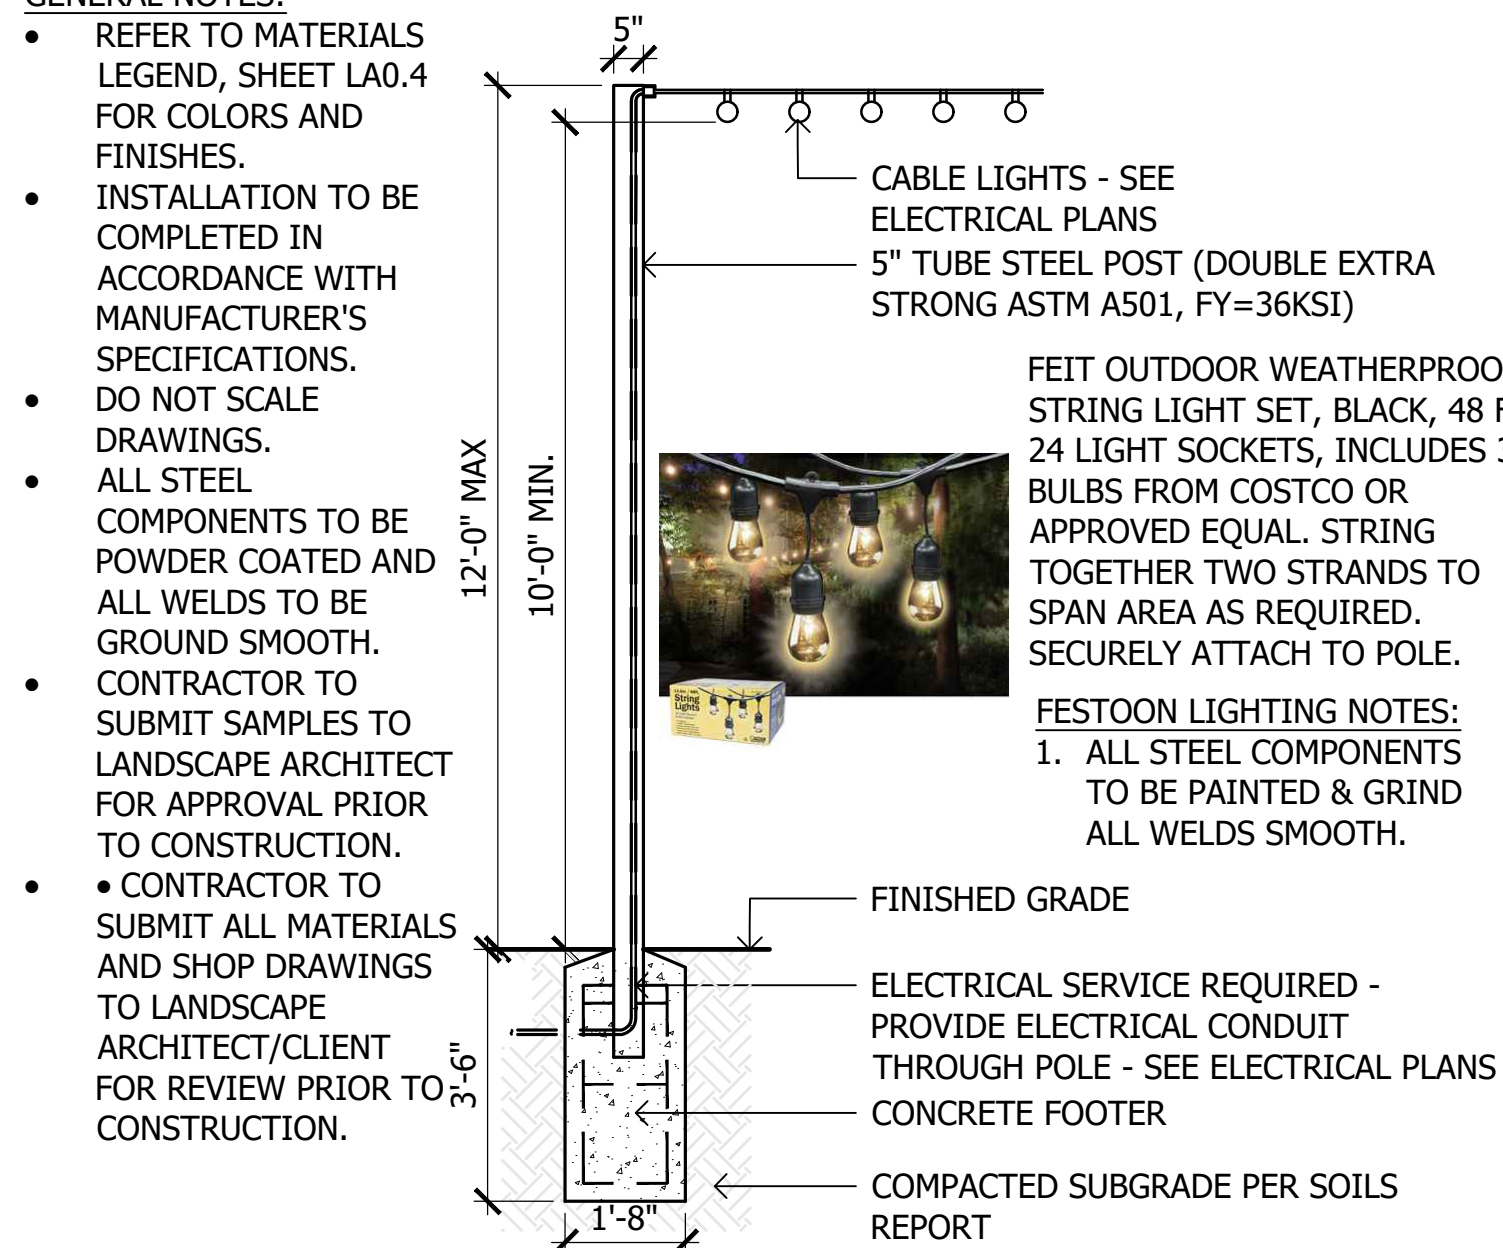


SCALE: 3/8"=1'-0"

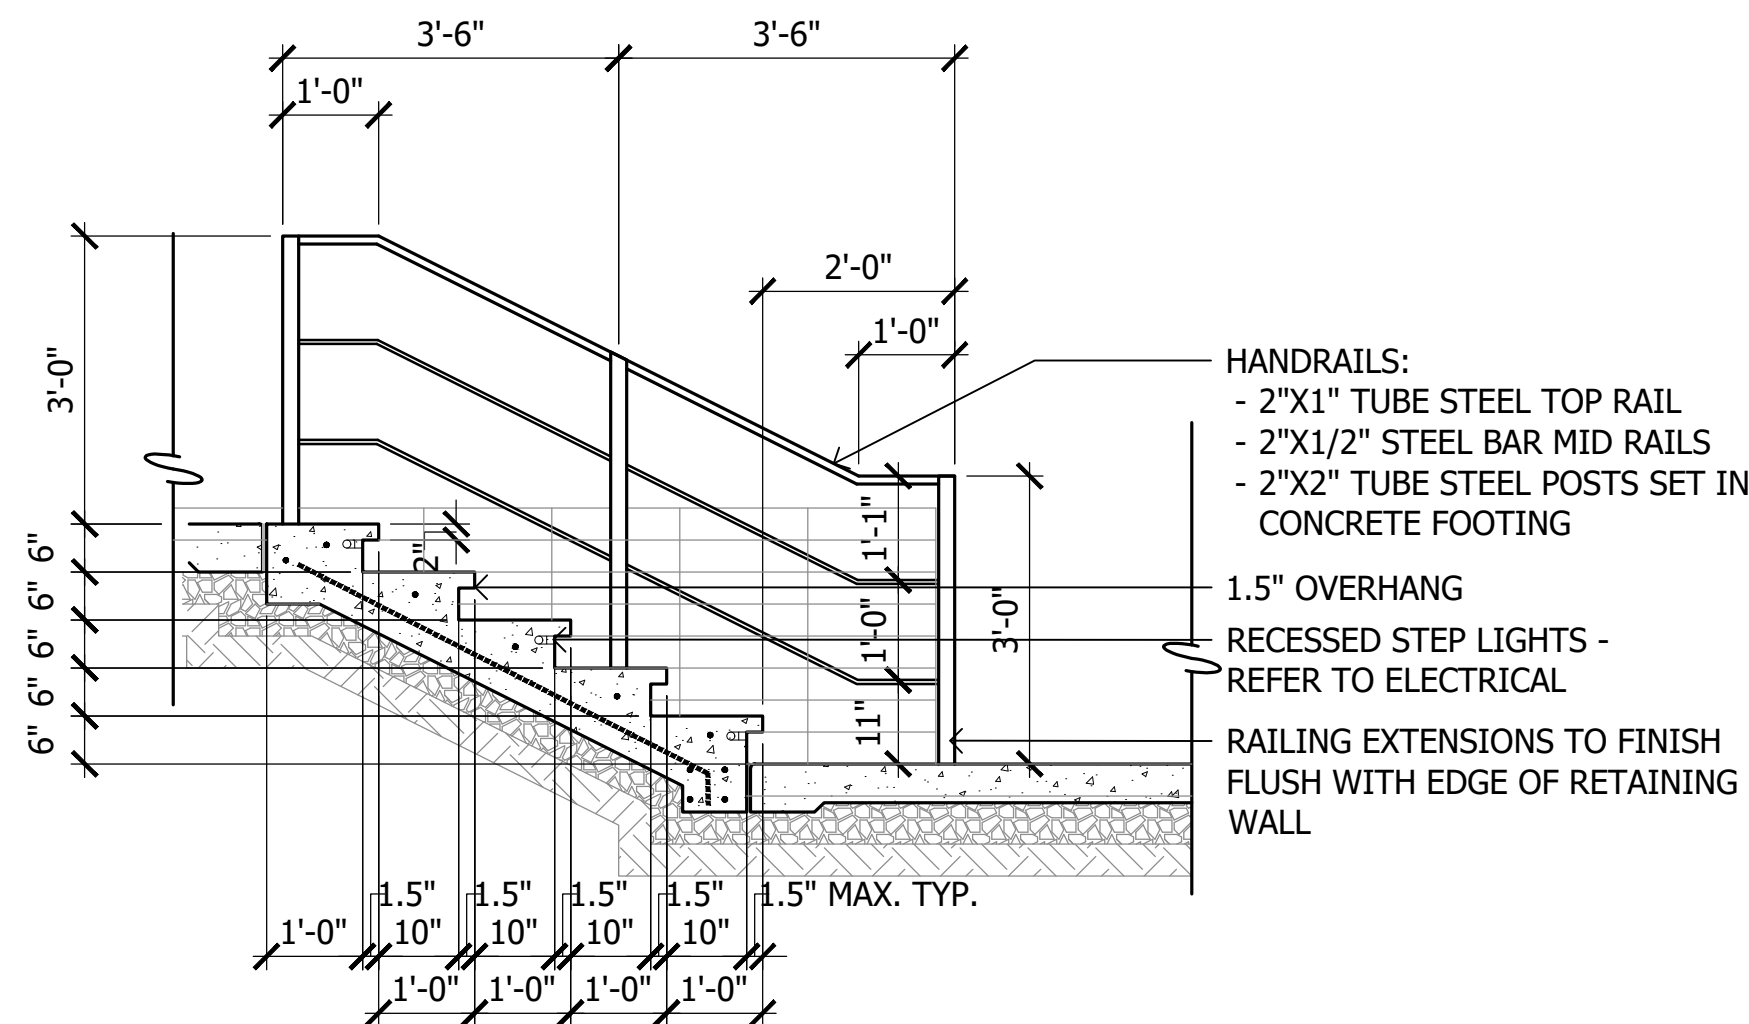


SCALE: 1/2"=1'-0"



LYRA FIRE BOWL
MATERIALS: BLACK SAND
TRAVERTINE,
BURNER: NATURAL GAS
65,000 BTU/HOUR ETL LISTED,
ELECTRONIC IGNITION AT
SWITCH
DIMENSIONS: 42"L X 24"W X 15"
H
WWW.ELDORADOSTONE.COM

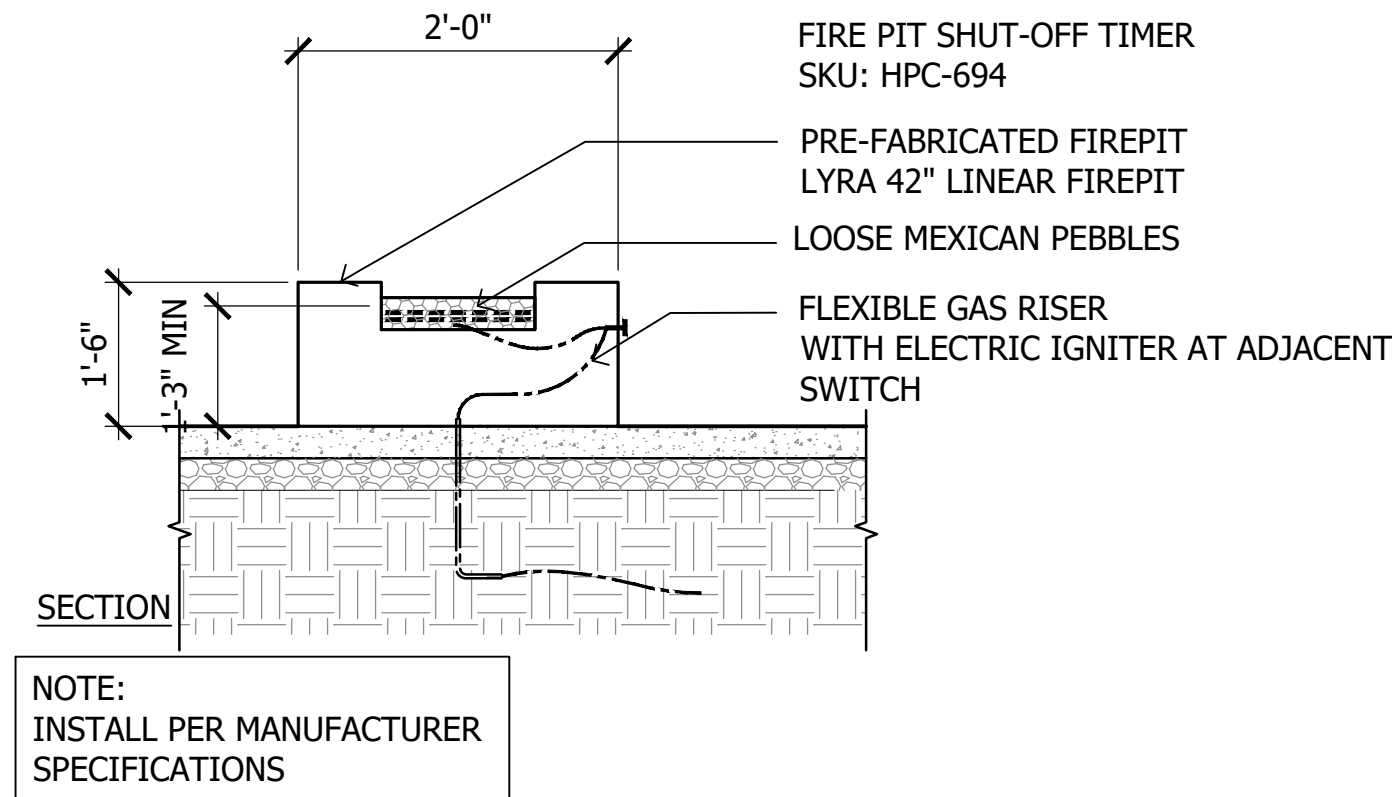

SCALE: 1/2"=1'-0"

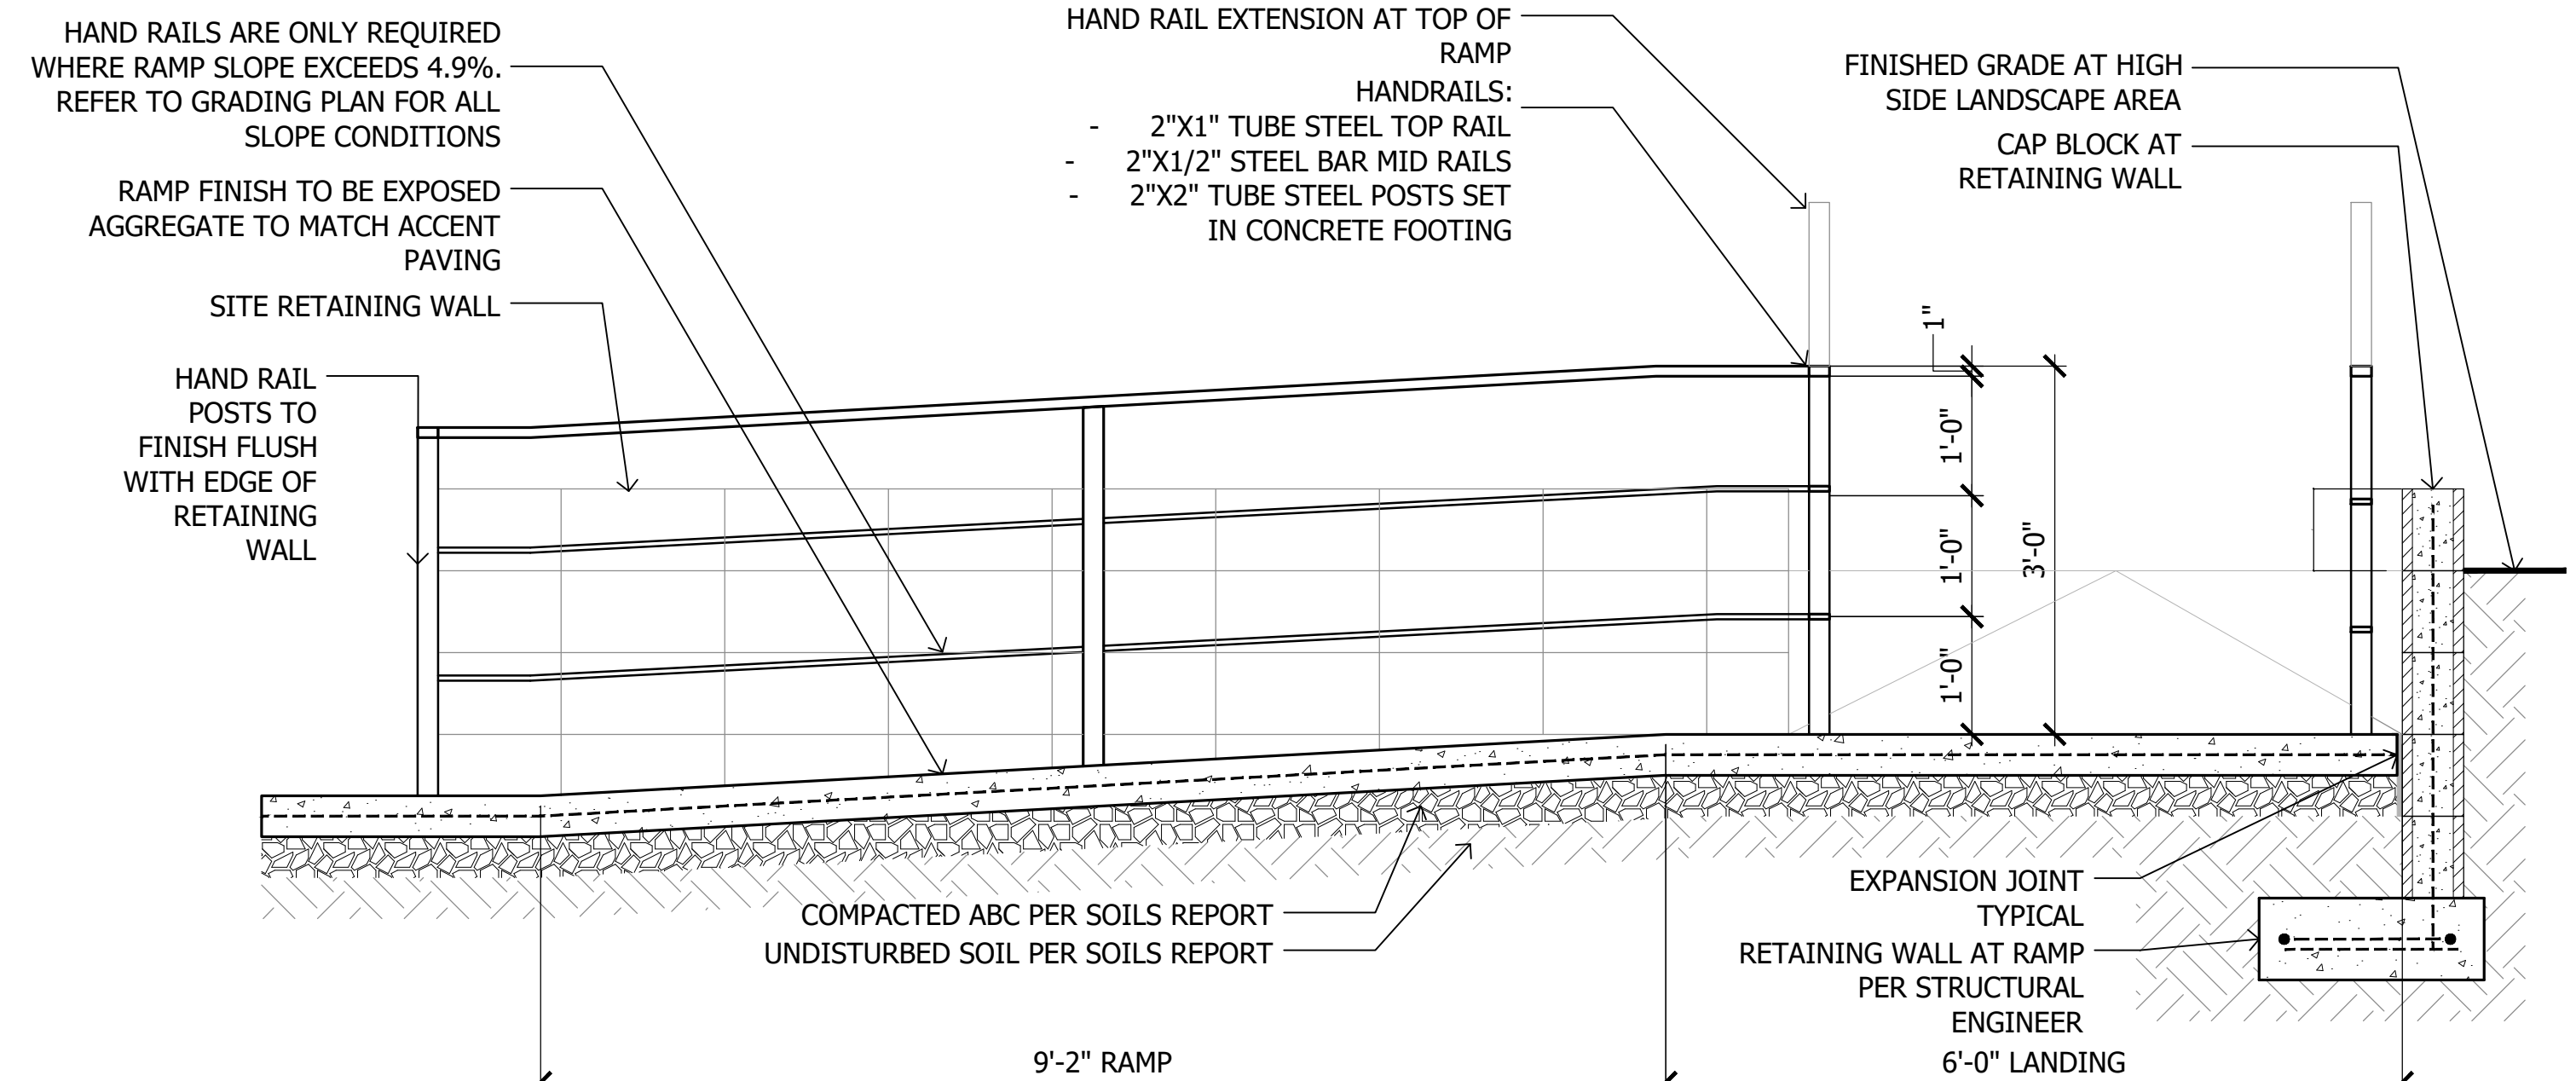

SCALE: 3/4"=1'-0"



TRASH RECEPTACLE:
MANUF: LANDSCAPE FORMS
MODEL: PARC-VUE
PV64-01 W/ URN SHAPED-LINER
431 LAWNDALe AVENUE
KALAMAZOO, MI 49048
PHONE: (269) 381-0396
FAX: (269) 381-3455
OR APPROVED EQUAL



CHARACTER IMAGE



CHARACTER IMAGE



CHARACTER IMAGE



CHARACTER IMAGE

- 1 11'X13' Cantilever Shade Structure at Wood Deck
SCALE: 1/2"=1'-0"

- 2 18'x36' Shade Structure at Public Plaza
SCALE: 1/2"=1'-0"


- 3 Decorative Metal Fins
SCALE: 1/2"=1'-0"



CHARACTER IMAGE



CHARACTER IMAGE

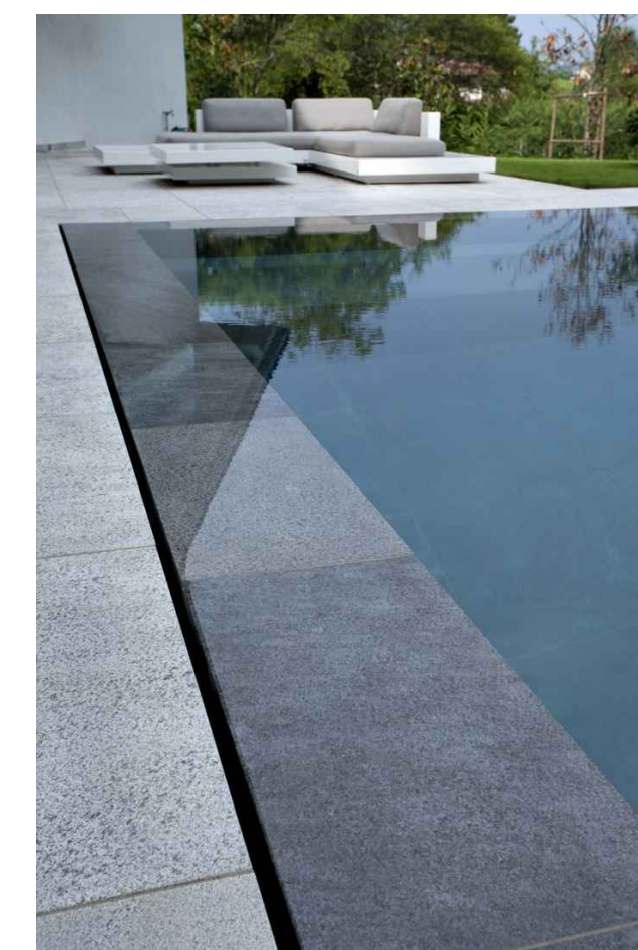

CHARACTER IMAGE



CHARACTER IMAGE

- 4 Outdoor Fireplace
SCALE: 1/2"=1'-0"

- 5 Rim Flow Pool
SCALE: 1/2"=1'-0"

- 6 Raised Spa
SCALE: 1/2"=1'-0"




CHARACTER IMAGE



CHARACTER IMAGE



CHARACTER IMAGE

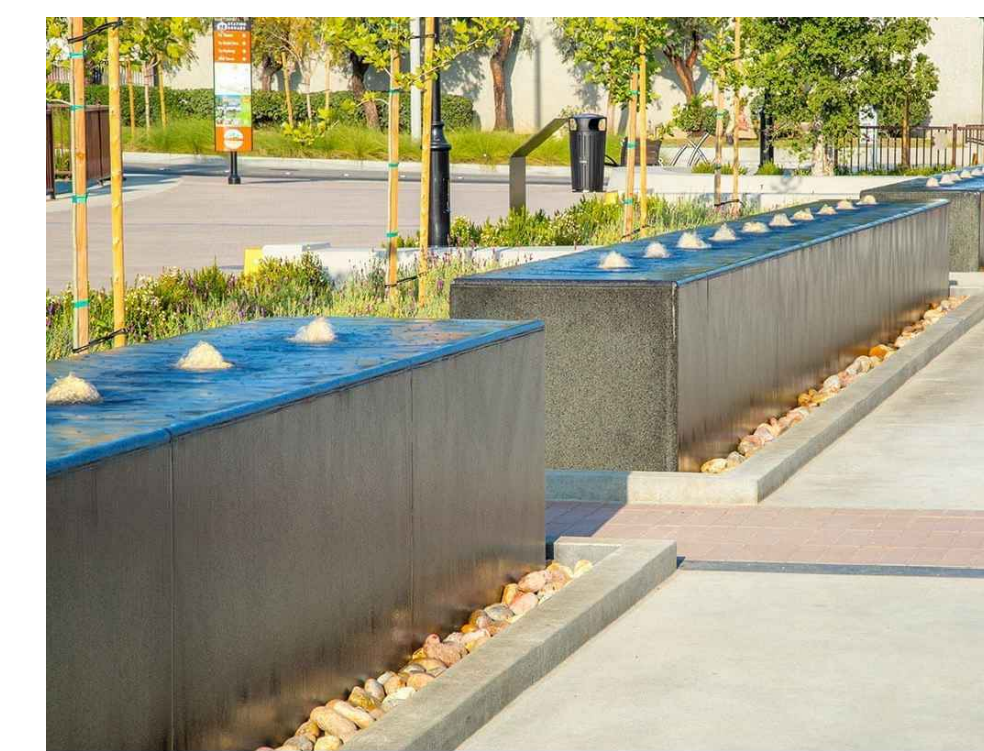

- 7 Wheel Chair Lift at Podium
SCALE: 1/2"=1'-0"

- 8 Steel Header Planter
SCALE: 1/2"=1'-0"

- 9 Water Feature at Courtyard A
SCALE: 1/2"=1'-0"

- 10 Water Feature at Courtyard B
SCALE: 1/2"=1'-0"



CHARACTER IMAGE

1 Decorative Screen Wall at Grade
SCALE: 1/2"=1'-0"



CHARACTER IMAGE

2 Rectangular Concrete Bench
SCALE: 1/2"=1'-0"



CHARACTER IMAGE

3 Round Concrete Bench
SCALE: 1/2"=1'-0"



CHARACTER IMAGE



CHARACTER IMAGE

4 Negative Edge Water Feature
SCALE: 1/2"=1'-0"



CHARACTER IMAGE

5 Pool Table at Outdoor Corridor
SCALE: 1/2"=1'-0"



CHARACTER IMAGE

6 Outdoor Kitchen
SCALE: 1/2"=1'-0"



CHARACTER IMAGE

7 Ping pong Table at Outdoor Kitchen
SCALE: 1/2"=1'-0"