

1			
LIST OF ABBREVIATIONS			
AB	ANCHOR BOLT	LT	LIGHT
ACOUST	ACOUSTICAL	MH	MAN HOLE
A/C	AIR CONDITION	MATL	MATERIAL
ALUM	ALUMINUM	MFR	MANUFACTURE
ANOD	ANODIZED	MAX	MAXIMUM
ARCH	ARCHITECT	MECH	MECHANICAL
ASPH	ASPHALT	MET	METAL
®	AT	MEZZ	MEZZANINE
D	BD	MIN	MINIMUM
	BLKG	MTD	MOUNTED
	BLDG	MULL	MULLION
	BM	NG	NATURAL GRADE
	BOT	NOM	NOMINAL
C	BRK	NIC	NOT IN CONTRACT
	CI	NO #	NUMBER
	CB	NTS	NOT TO SCALE
	CLG		
	CEM		
B	CL	OBS	OBSCUR
	CHNL	OC	ON CENTER
	CLF	OPNG	OPENING
	CT	OPP	OPPOSITE
	CLR	OAL	OVERALL LENGTH
A	CO	OD	OUTSIDE DIAMETER
	COL	OFD	OVERFLOW DRAIN
	CONC	OFCl	OWNER FURNISHED CONTR
	CONSTR	INSTALLED	
	CONTR	PR	PAIR
	CJ	PTN	PARTITION
	CONT	d	PENNY (NAIL SIZE)
	CTR	PERP	PERPENDICULAR
	CMU	PLAST	PLASTER
		PL	PLATE
	DB	PLI	PLIES
	DEG	PLAM	PLASTIC LAMINATE
	DET	PLMB	PLUMBING
	DIA	PLYWD	PLYWOOD
	DIM	PT	POINT
	DN	LB	POUNDS
	DS	PSI	LBS PER SQUARE IN
	DWG	PSF	LBS PER SQUARE FT
		PVC	POLYVINYL CHLORIDE
	EA	QT	QUARRY TILE
	ELEC		
	ELEV		
	EQ	RAD	RADIUS
	EQUIP	REF	REFRIGERATOR
	EXH	REQD	REQUIRED
	EXP	REV	REVISION
	EJ	RF	ROOF
	EXIST	R	RISER
	EXT	RD	ROOF DRAIN
	EIFS	RM	ROOM
		ROW	RIGHT OF WAY
	FT	SCHED	SCHEDULE
	FIN	SECT	SECTION
	FG	SEL	SELECT
	FIXT	SHT	SHEET
	FLR	SIM	SIMILAR
	FD	SS	STAINLESS STEEL
	FEC	SLDG	SLIDING
	FS	SPEC	SPECIFICATION
	FND	SQ	SQUARE
	FLUOR	STD	STANDARD
	FOS	STL	STEEL
	FTG	STRUCT	STRUCTURAL
	FUR	SUSP	SUSPENDED
	FV		
	GA	TEL	TELEPHONE
	GALV	THK	THICK
	GC	T&G	TONGUE & GROOVE
	GL	TBC	TOP BACK OF CURB
	GFRC	TOF	TOP OF FOOTING
	GFRC	TOW	TOP OF WALL
	GRD	T	TREAD
	GRND	TYP	TYPICAL
	GYP BD		
	HDR	UNO	UNLESS NOTED OTHERWISE
	HDW	UR	URINAL
	HDWD		
	HGT	VERT	VERTICAL
	HM	VG	VERTICAL GRAIN
	HORIZ	VEST	VESTIBULE
	HB	VCT	VINYL COMPOSITE TILE
	HW	VNR	VENEER
	IN	WC	WATER CLOSET
	ID	WH	WATER HEATER
	INSUL	WP	WEATHER PROOF
	INT	WF	WIDE FLANGE
	INV	WMN'S	WOMEN'S
	JAN	W/O	WITH
	JST	WD	WITH OUT
	JT	WDW	WOOD WINDOW
		WR	WATER RESISTANT
		WWR	WELDED WIRE REINFORCEMENT
	LAM		
	LAV		

2


DRAWING SYMBOL LEGEND

	<u>INTERIOR ELEVATIONS</u> SHEET NUMBER DETAIL NUMBER
	<u>DETAIL REFERENCE</u> DETAIL NUMBER SHEET NUMBER
	<u>EXTERIOR ELEVATION REFERENCE</u> DETAIL NUMBER SHEET NUMBER
	<u>WALL SECTION REFERENCE</u> DETAIL NUMBER SHEET NUMBER
	<u>ROOM DESIGNATION (FLOOR PLAN)</u> ROOM NAME ROOM NUMBER
	<u>ROOM DESIGNATION (RCP)</u> ROOM NUMBER CEILING HEIGHT ABOVE FF
	<u>ELEVATION SYMBOL</u> ELEVATION DESCRIPTION ELEVATION ABOVE DATUM
	<u>WALL TYPE DESIGNATION</u> WALL TYPE
	<u>DOOR DESIGNATION</u> DOOR NUMBER
	<u>WINDOW DESIGNATION</u> WINDOW TYPE
	<u>KEYED NOTE DESIGNATION</u> KEY NOTE NUMBER
	<u>GLASS TYPE DESIGNATION</u> GLASS TYPE
	<u>REVISION DESIGNATION</u> REVISION NUMBER

WALL TYPES

TYPE W1		FIRE TEST HEIGHT HEAD TYPE BASE TYPE NONE TO 6" ABOVE CEILING A4/G001 A3/G001 FACE A: 5/8" GYPSUM BOARD STRUCTURE: 3 5/8" STEEL STUDS @ 16" O.C. FACE B: 5/8" GYPSUM BOARD SEE FINISH SCHEDULE FOR MATERIAL FINISH INSULATION: 3 1/2" SOUND BATTS SHOWN 5" NOMINAL ON FLOOR PLAN
--	--	---

Solano Studios expressly reserves its common law copyright & other property rights in these plans. All designs, information, data, plans, drawings and specifications are the property of Solano Studios and may not be used for any other purpose without written consent of Solano Studios as well as its registered professionals. No liability is assumed for deviations from these documents. SOLANO STUDIOS HAS NO LIABILITY, EXPRESSED OR IMPLIED, OR GUARANTEE ANY AND ALL ENGINEERING SYSTEM PERFORMANCE OR OPERATION SINCE SOLANO STUDIOS IS NOT THE MANUFACTURER(S), MATERIAL SUPPLIER(S), INSTALLING CONTRACTOR(S), OR AUTHORITIES HAVING JURISDICTION. SOLANO STUDIOS PROFESSIONAL LIABILITY, EXPRESSED OR IMPLIED, ENDS UPON A/JU APPROVED THE WORKING DRAWINGS FOR CONSTRUCTION. SOLANO STUDIOS DOES NOT WARRANT THAT THE FUNCTIONS CONTAINED IN LAYOUTS, DESIGN OR LIMITED CONSTRUCTION ADMINISTRATION WILL MEET CLIENT REQUIREMENTS OR THE OPERATION OF CLIENT SYSTEMS) DUE TO SITE SURVEY EXISTING CONDITION OR CLIENT CRITERIA MODIFICATIONS. CLIENT ACKNOWLEDGE THAT HE/SHE HAVE READ THESE WORKING DRAWINGS PRIOR A/JU SUBMITTAL, UNDERSTAND IT AND AGREE TO BE BOUND BY SOLANO STUDIOS TERMS AND CONDITIONS.

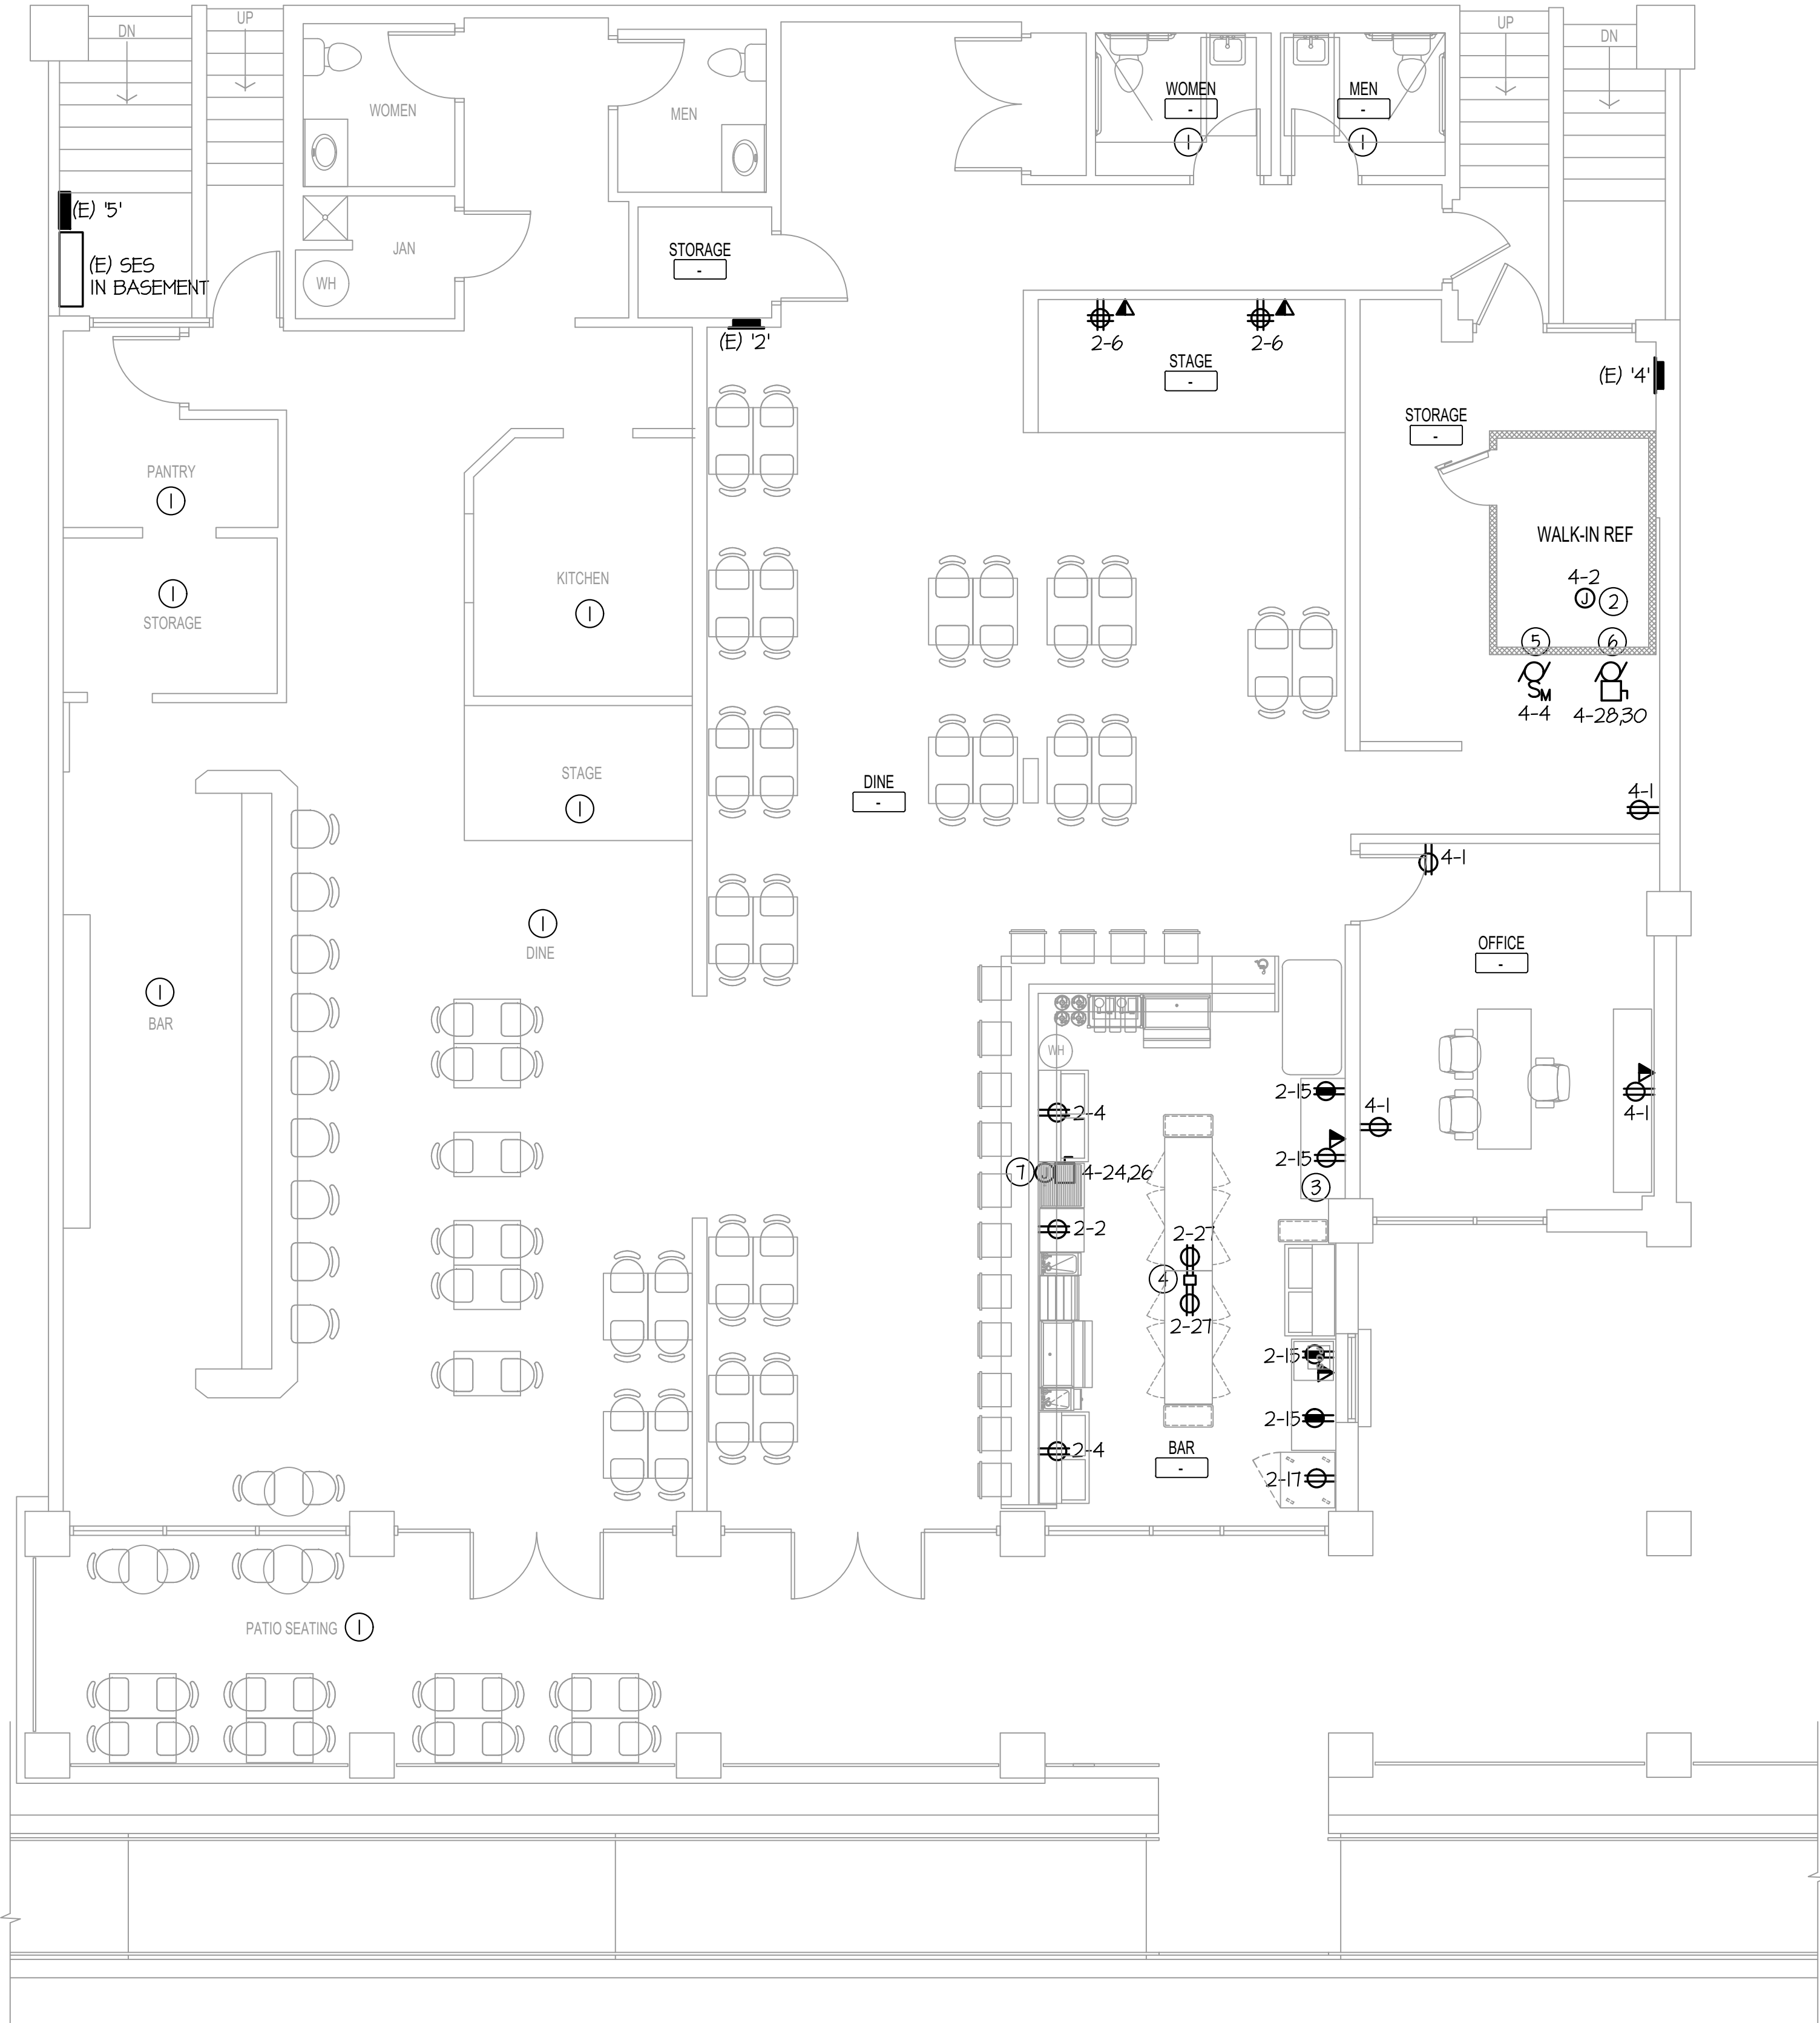

POWER PLAN
SCALE: 3/16"=1'-0"

NOTE: ALL LIGHTING IS EXISTING TO REMAIN AND NOT IN SCOPE

NOTE: ALL HVAC EQUIPMENT IS EXISTING TO REMAIN AND NOT IN SCOPE

GENERAL NOTES

1. ALL BAR AREA RECEPTACLES SHALL BE GFCI TYPE. RECEPTACLES LOCATED BEHIND EQUIPMENT SHALL BE GFI CIRCUIT BREAKERS.
2. PROVIDE CONDUIT SEALS AT ALL WALK-IN PENETRATIONS
3. ELECTRICAL CONTRACTOR SHALL FIELD VERIFY ALL CONNECTION REQUIREMENTS (HP, AMPS, VOLTAGE, PHASE, MOUNTING HEIGHT, AND DISCONNECTING MEANS) FOR ALL EQUIPMENT SUPPLIED BY OTHERS

KEYNOTES:

- ① THIS ROOM IS EXISTING TO REMAIN, NO WORK.
- ② WP J-BOX FOR CONNECTION TO UNIT PROVIDE WALK-IN LIGHTS. CONNECT TO UNIT PROVIDED SWITCH PER MANUFACTURER REQUIREMENTS.
- ③ RECEPTACLE AND TELE/DATA DEVICE HIGH FOR TV. VERIFY LOCATION AND MOUNTING HEIGHT PRIOR TO ROUGH-IN.
- ④ POWER POLE WITH (2) GFCI DUPLEX RECEPTACLES FOR REFRIGERATOR POWER. VERIFY LOCATION PRIOR TO ROUGH-IN.
- ⑤ WALK-IN EVAP.
1/2HP-120V-1Ø
PROVIDE WP MANUAL SWITCH AT UNIT.
- ⑥ WALK-IN COMPRESSOR
1HP-208V-1Ø
PROVIDE 30A/2P WP DISC. SWITCH FUSED PER UNIT NAMEPLATE.
- ⑦ WATER HEATER: 4.5 KW-208V-1Ø
PROVIDE 30A/2P NON FUSED DISC SWITCH AT UNIT. WIRE SIZE TO BE 2#10, 1#10 GND., 1/2" C.

ds3

design studio 3 architecture
2315 e. washington st.
phoenix, arizona 85034
v:602.770.0655
www.ds3architecture.com

Contractor

**OLD TOWN TAVERN
& RESTAURANT**
7330 E. MAIN ST., SUITE 105
SCOTTSDALE, AZ 85251

©2025 Design Studio 3 Architecture, LLC
Drawings, written material, and design concepts shall not be used or reproduced in whole or part in any form or format without prior written consent of Design Studio 3 Architecture, LLC. Do not scale drawings. Use given dimensions only. If not shown, verify correct dimensions with the Architect. Contractor shall check and verify all dimensions and conditions at job site.

SEAL

PROJECT NO. 25004

DRAWN BY:

CHECKED BY:

ISSUED:

NO.	DATE	DESCRIPTION

SHEET NAME

POWER PLAN

3/28/2025


SHEET NUMBER

E1.0



Solano Studios, Inc.
13802 N. Scottsdale Rd.
Suite 151-3
Scottsdale, AZ 85254-3403
(602) 390-0634
travis@solanostudios.com

SS PROJECT #: 25-027
DATE: 03/20/2025
SCALE: AS NOTED

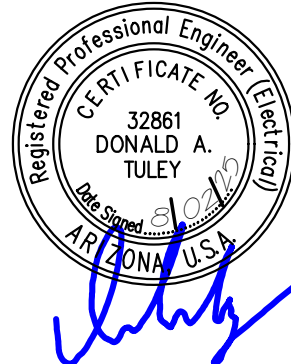

PERMIT DRAWING