


Jun 25, 2025 - 11:05AM
X:\2024-000 VIP\2024-065 - UMC Housing\ELEC\E2.0 DRB.dwg E2.0
JP

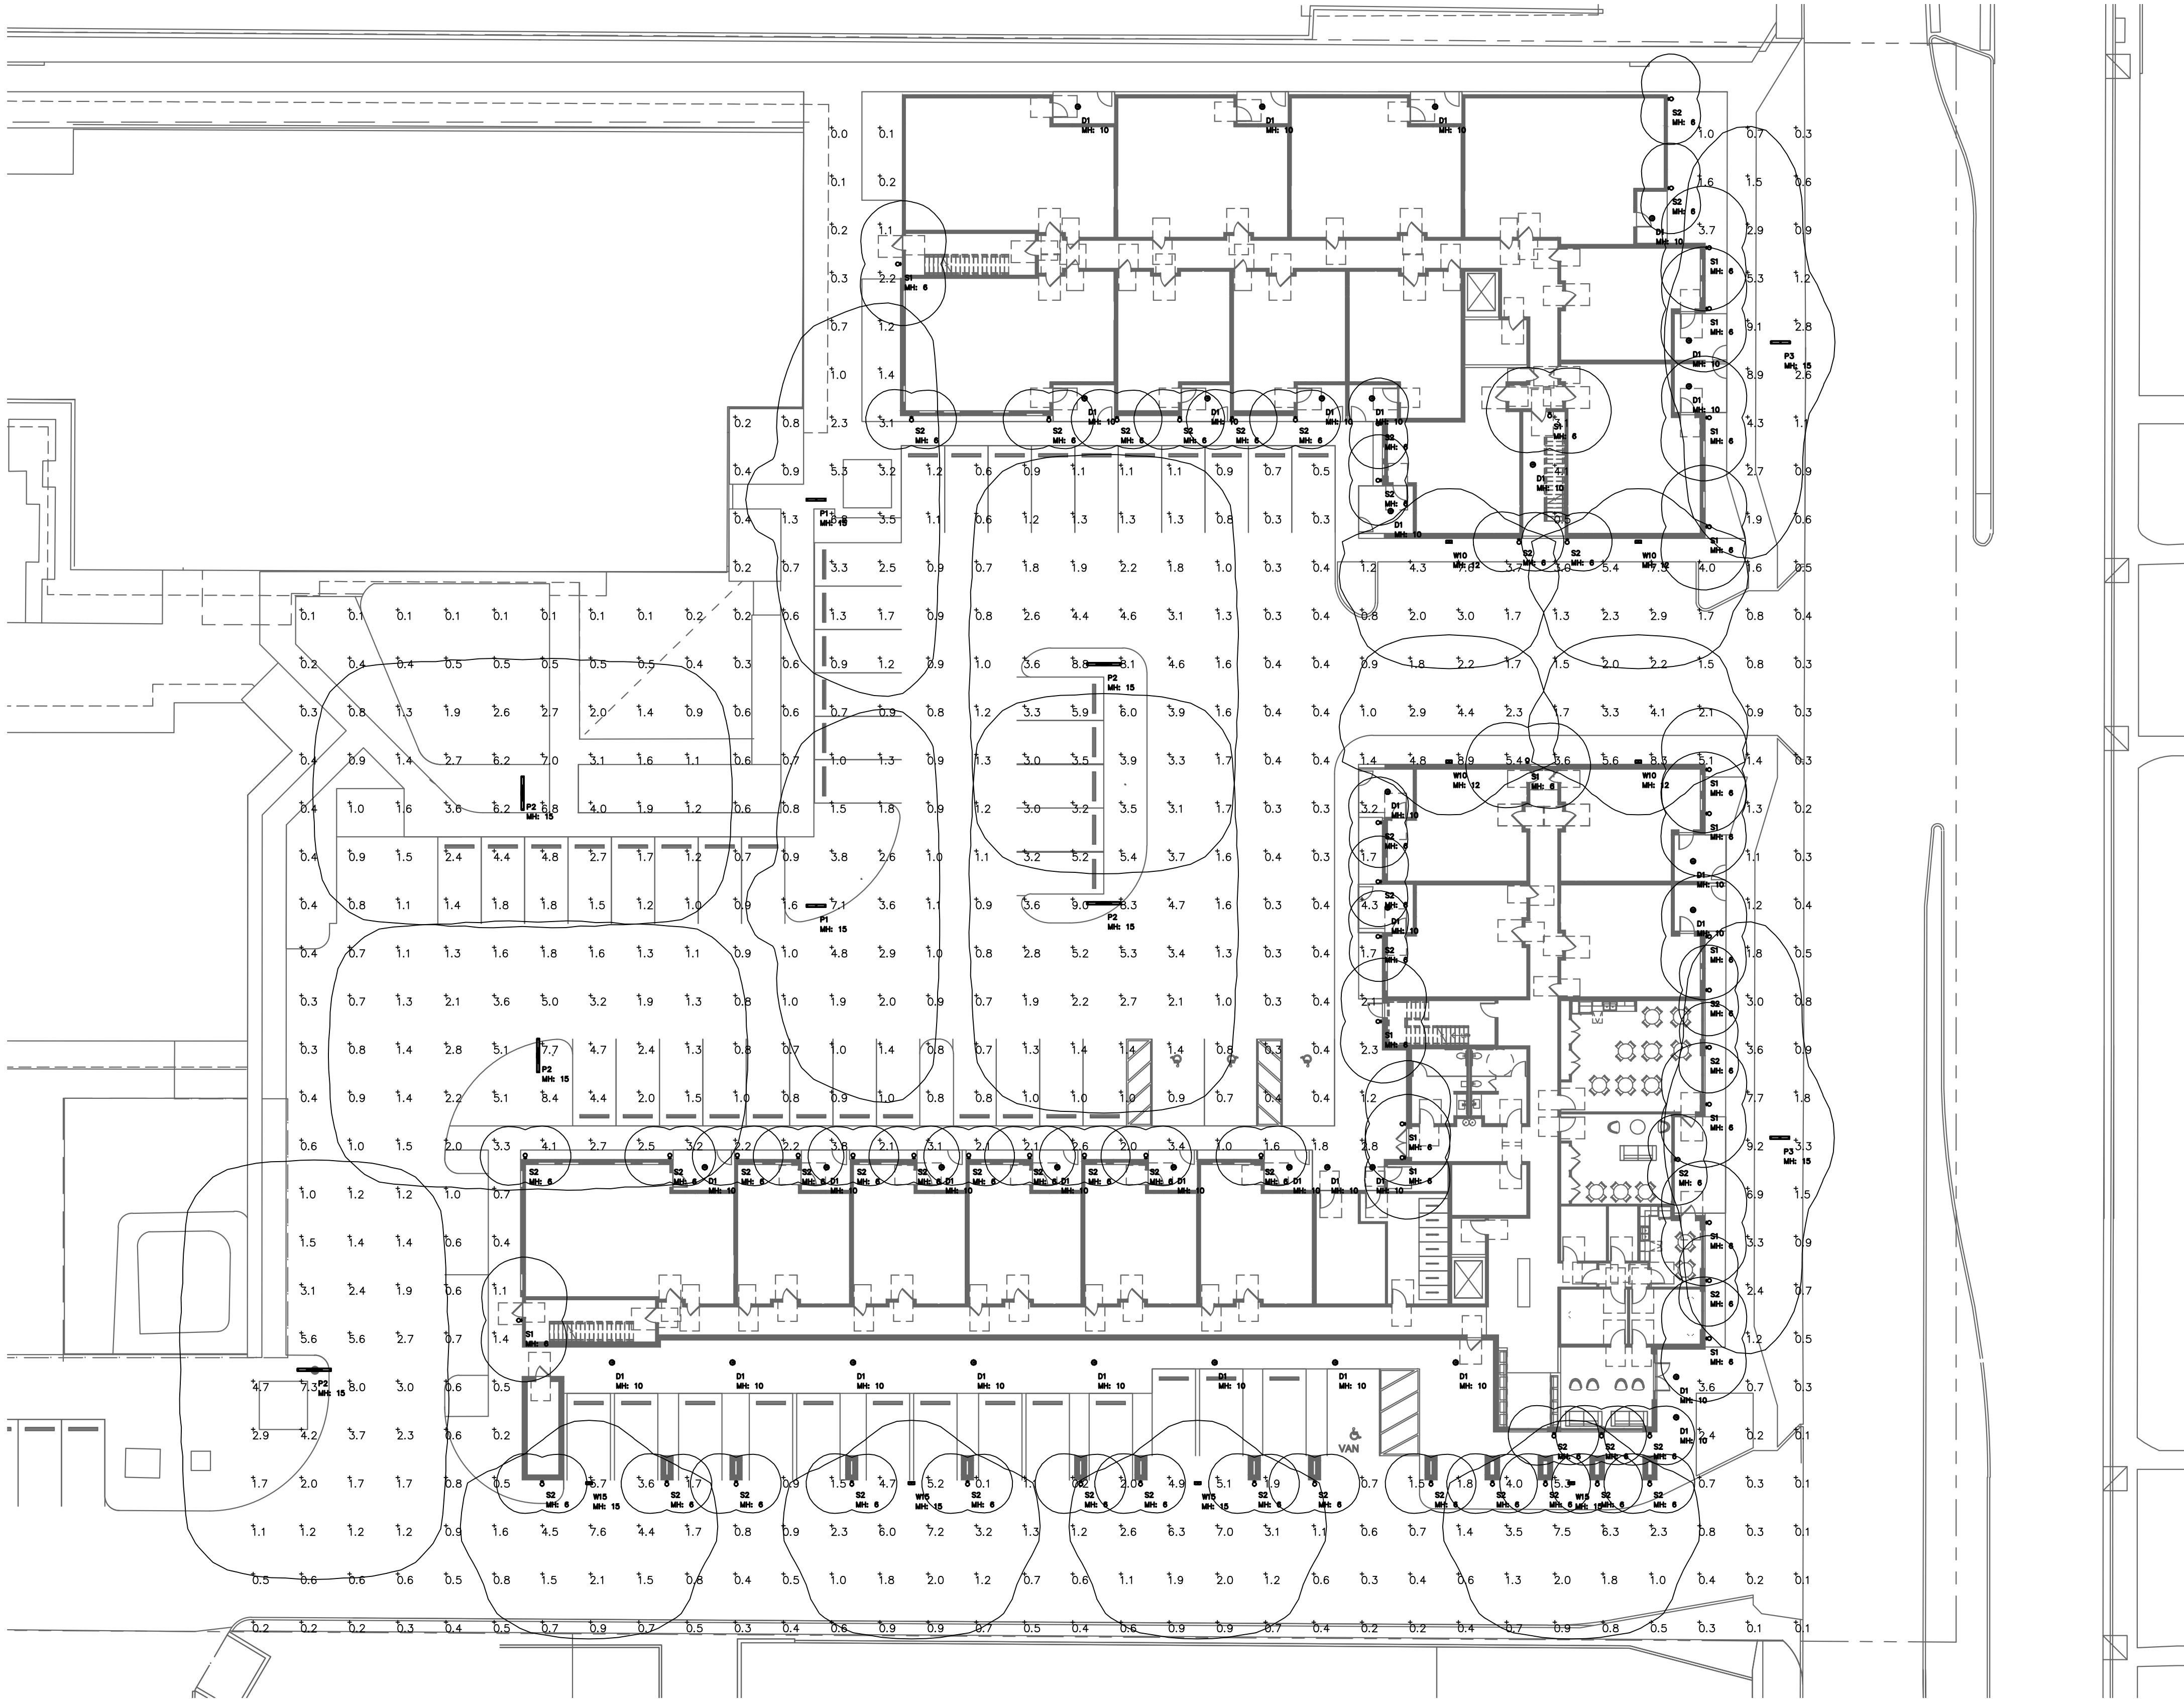

ELECTRICAL PHOTOMETRIC PLAN - OVERALL SITE

SCALE: 1" = 20' - 0"

NORTH



Luminaire Schedule									
Symbol	Qty	Label	Arrangement	Description	LLF	Luminaire Lumens	Luminaire Watts	Total Watts	Mounting Height
	34	D1	Single	DALS RGR2HP-15W-3000K	0.950	1130	14.1332	480.529	10
	2	P1	Single	LSI-IND LAL4-40-06L-3-30K8	0.950	5652	48	96	15
	5	P2	Back-Back	LSI-IND LAL4-40-06L-3-30K8	0.950	5652	48	480	15
	2	P3	Single	LSI-IND LAL4-40-06L-2-30K8	0.950	5757	48	96	15
	17	S1	Single	DALS SWS48-CC	0.950	1902	41.6	582.4	6
	47	S2	Single	DALS SWS24-CC	0.950	889	19.11	898.17	6
	4	W10	Single	LSI-IND XLCW-FT-LED-SS-NW	0.950	3379	39.6	158.4	12
	4	W15	Single	LSI-IND XLCW-FT-LED-HO-NW-UE	0.950	4621	54.4	217.6	15

Calculation Summary						
Label	CalcType	Units	Avg	Max	Min	Avg/Min
Site	Illuminance	Fc	1.87	9.1	0.0	N.A.

Rev. Date: Description:

△ -
△ -
△ -
△ -
△ -
△ -

SCOTTSDALE UMC MULTI-FAMILY

DRB SUBMISSION #840-PA-2024

SCOTTSDALE, AZ 24065

ELECTRICAL PHOTOMETRIC PLAN - OVERALL SITE



NP ENGINEERING INC.
4115 N. 15TH AVE.
PHOENIX, AZ 85015
PH: (602) 265-1559 FAX: (602) 265-1605

This drawing is an instrument of service. It is the property of NP ENGINEERING, INC. The contents or any accompanying specifications shall not be altered or reproduced without the written permission of NP ENGINEERING, INC.
Copyright © 2025, by NP ENGINEERING, INC.

NP Proj. No: 24-065
Project Manager: RP
Drawn by: NPE
Date: 06-27-25

E2.0

Sheet

of