


Jun 25, 2025 - 11:04AM
X:\2024-000\VIP\2024-065 - UMC Housing\ELEC\E1.0 DRB.dwg E1.0
JPY

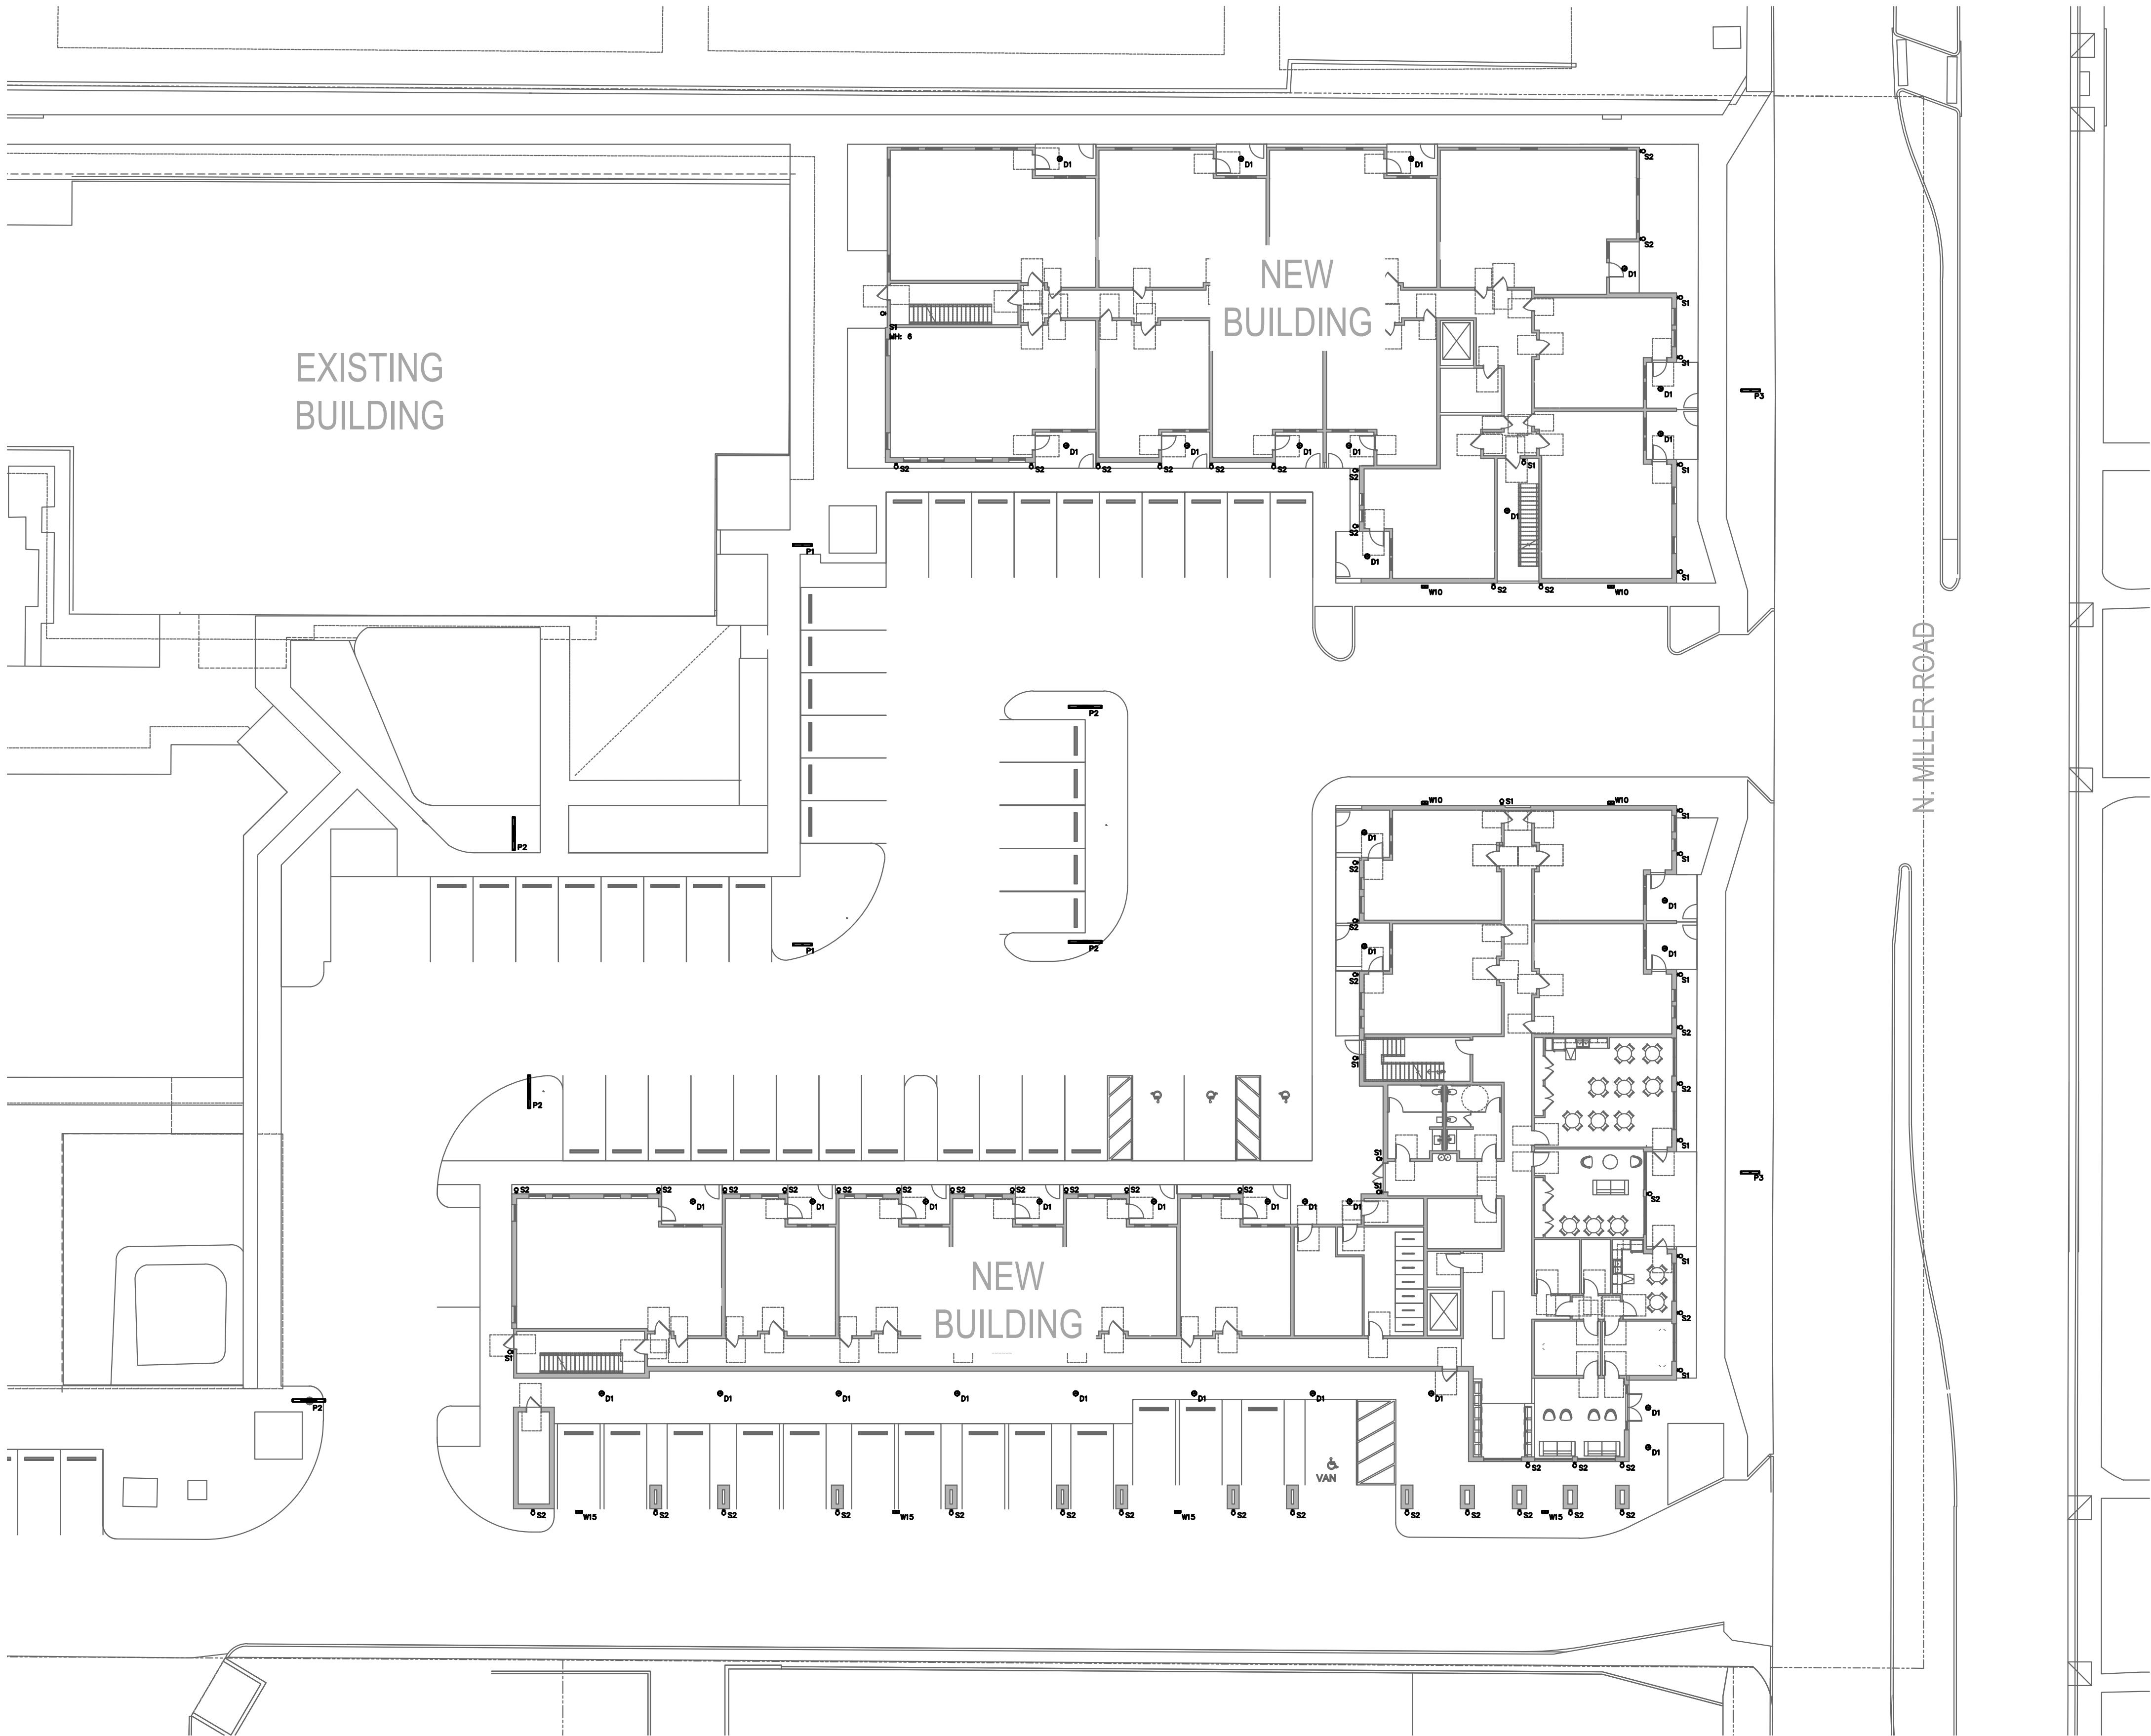

ELECTRICAL LIGHTING PLAN - OVERALL SITE

SCALE: 1" = 20' - 0"



Rev.	Date:	Description:
△	-	
△	-	
△	-	
△	-	
△	-	

SCOTTSDALE UMC MULTI-FAMILY

DRB SUBMISSION #840-PA-2024

SCOTTSDALE, AZ 24065

ELECTRICAL LIGHTING PLAN - OVERALL SITE



NP ENGINEERING INC.
4115 N. 15TH AVE.
PHOENIX, AZ 85015

PH: (602) 265-1559 FAX: (602) 265-1605

This drawing is an instrument of service. It is the property of NP ENGINEERING, INC.
The contents or any accompanying specifications shall not be altered or reproduced
without the written permission of NP ENGINEERING, INC.
Copyright © 2025, by NP ENGINEERING, INC.

NP Proj. No: 24-065
Project Manager: RP
Drawn by: NPE
Date: 06-27-25

E1.0

Sheet of