


KEYED NOTES

1 REFER TO ENLARGED POOL AREA LIGHTING PLAN, THIS SHEET FOR ADDITIONAL INFORMATION.

All concepts, designs and data indicated on these drawings are the sole property of the Hawkins Design Group Inc., and shall not be used for any other purpose other than originally intended without written permission of the engineer.

HAWKINS DESIGN GROUP INC.
ELECTRICAL CONSULTING ENGINEERS
140 WEST HARVELL ROAD
GILBERT, ARIZONA 85235
PH. 480.815.9000 FAX. 480.815.9001
EMAIL: email@hawkinsdg.com

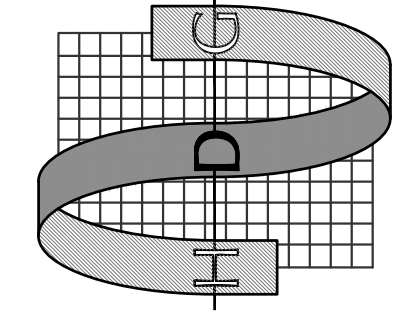


Project Name and Address:
HEADWATERS RESIDENTIAL HEALTH CARE FACILITY
100th St. & FLW Blvd.
Scottsdale, AZ

Revision / Issue
Date
No.


Seal:
PRELIMINARY NOT FOR CONSTRUCTION
Expires: XX/XX/XX

Project Number:
22475
Project Designer / Contact:
TODD ZIERES

Sheet:
21.cc

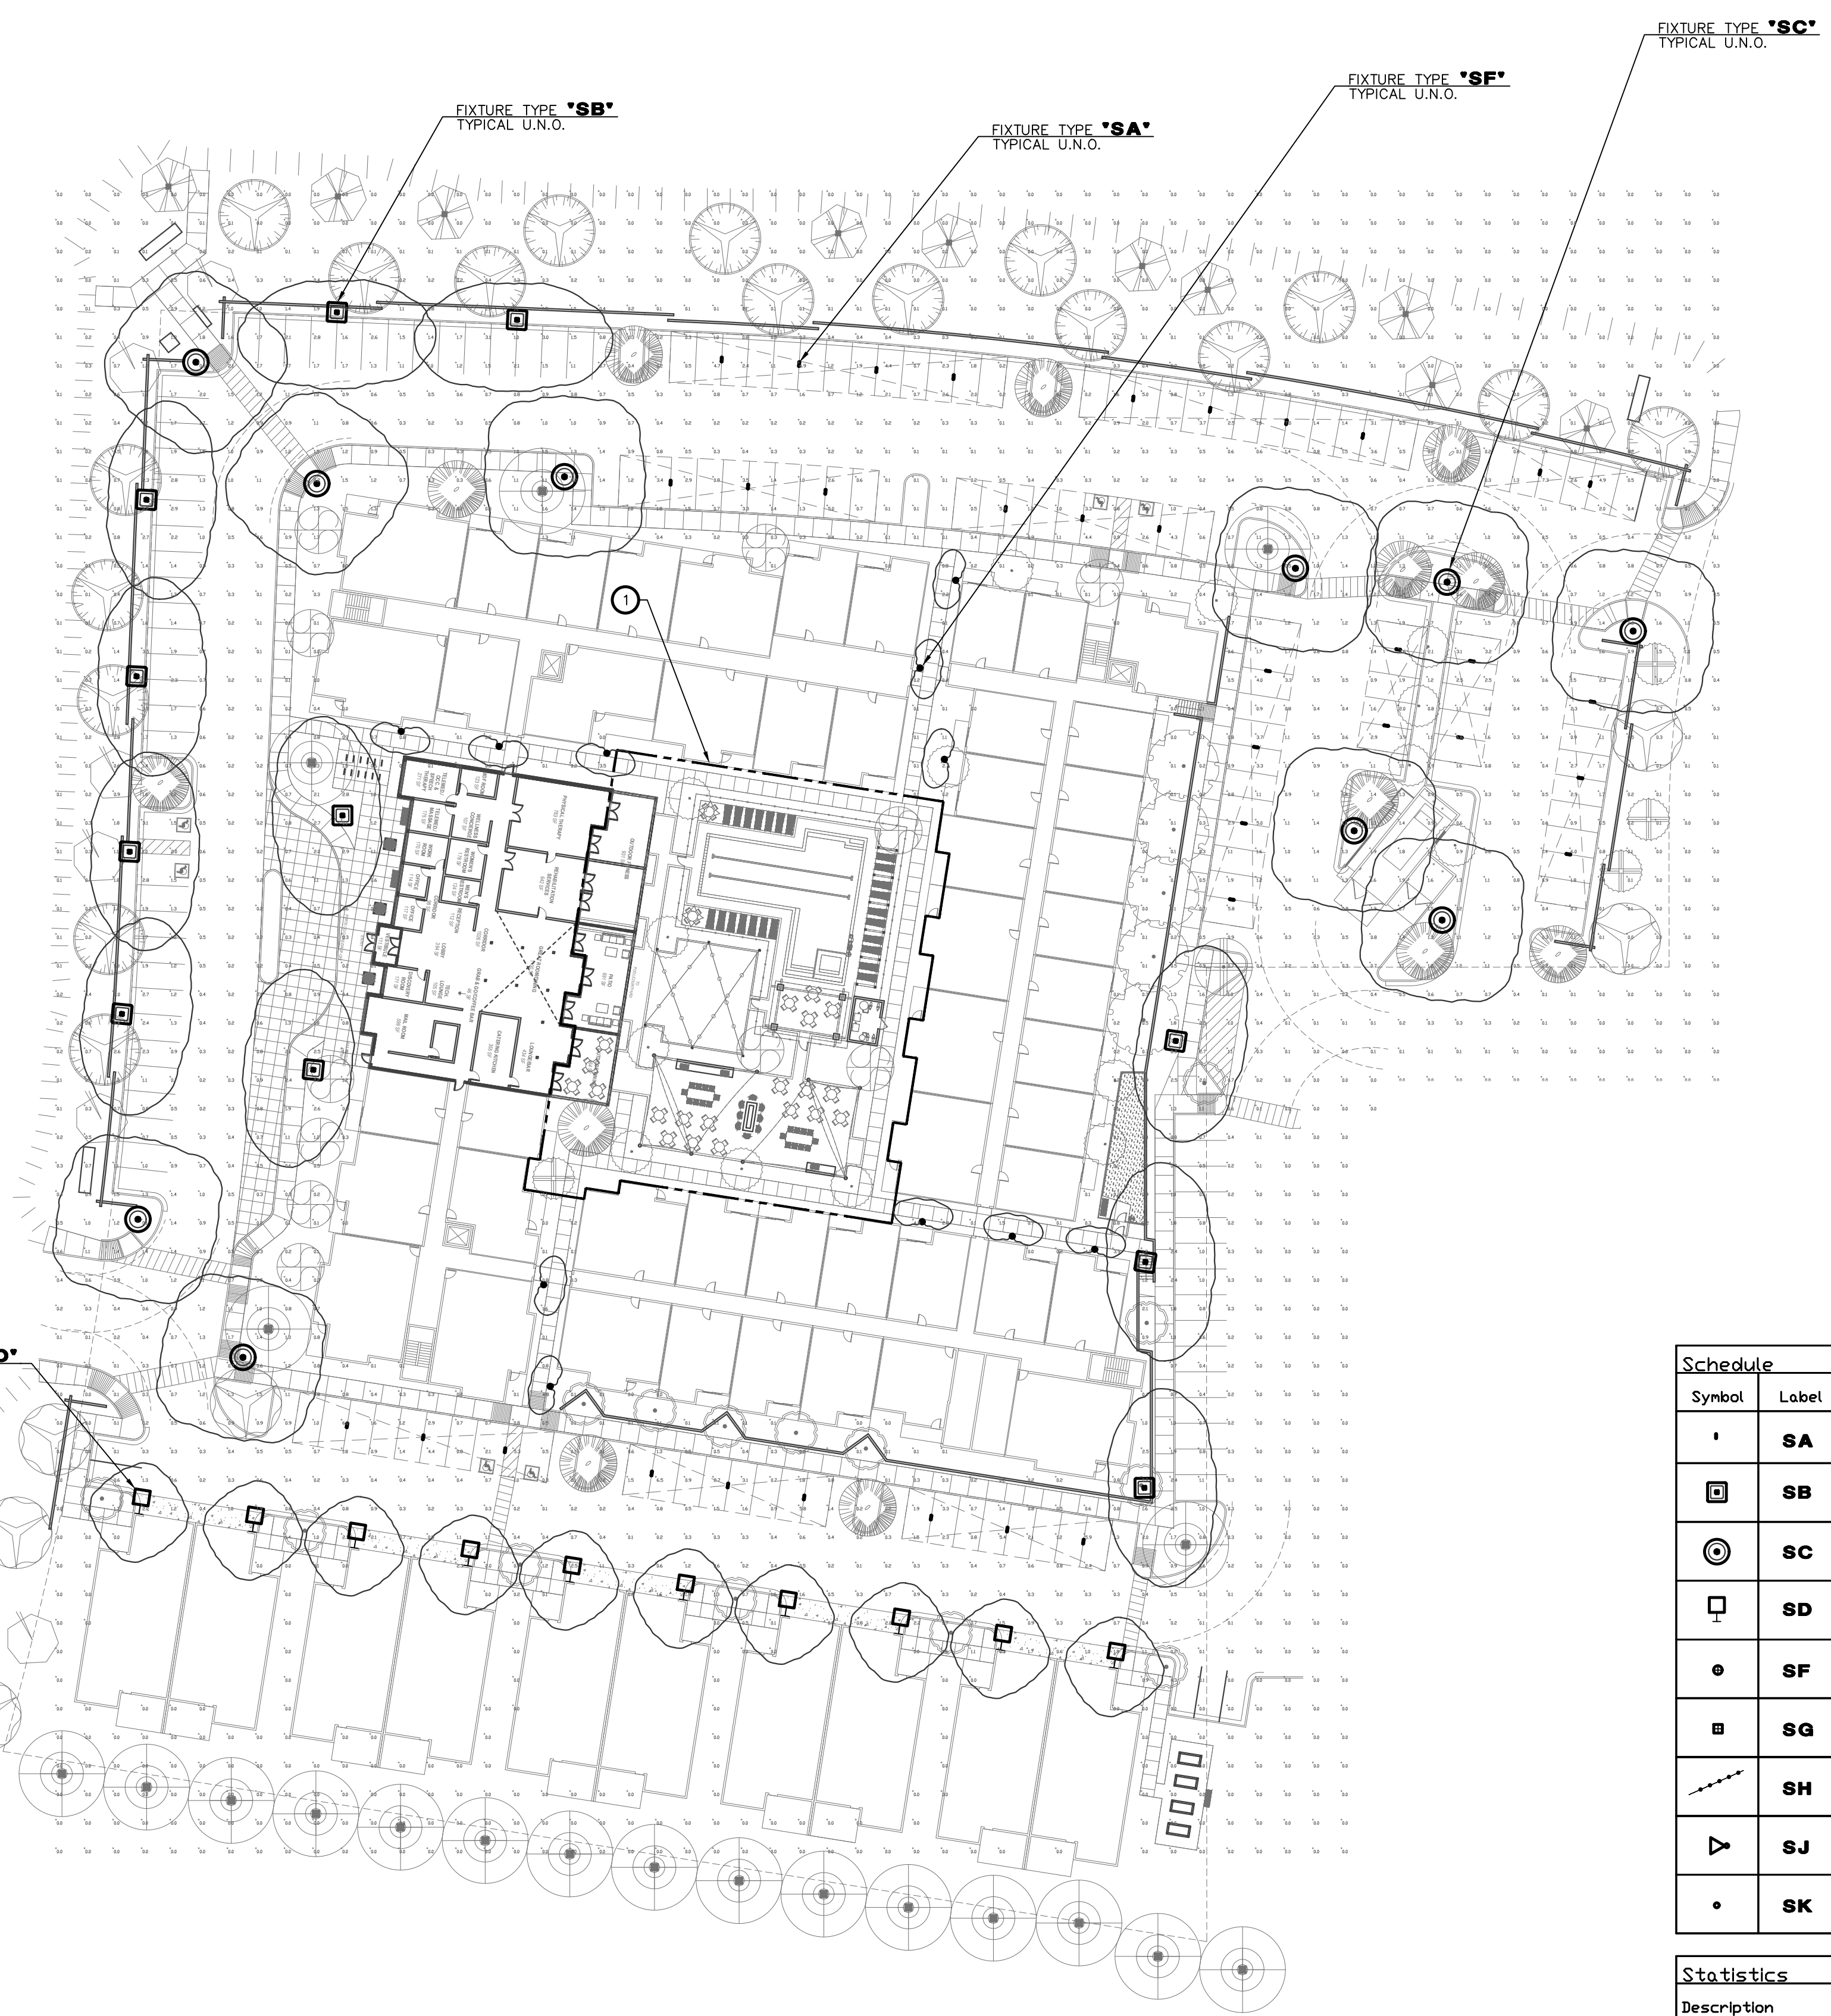

EXTERIOR LIGHTING SITE PLAN
SCALE: 1" = 40'-0"

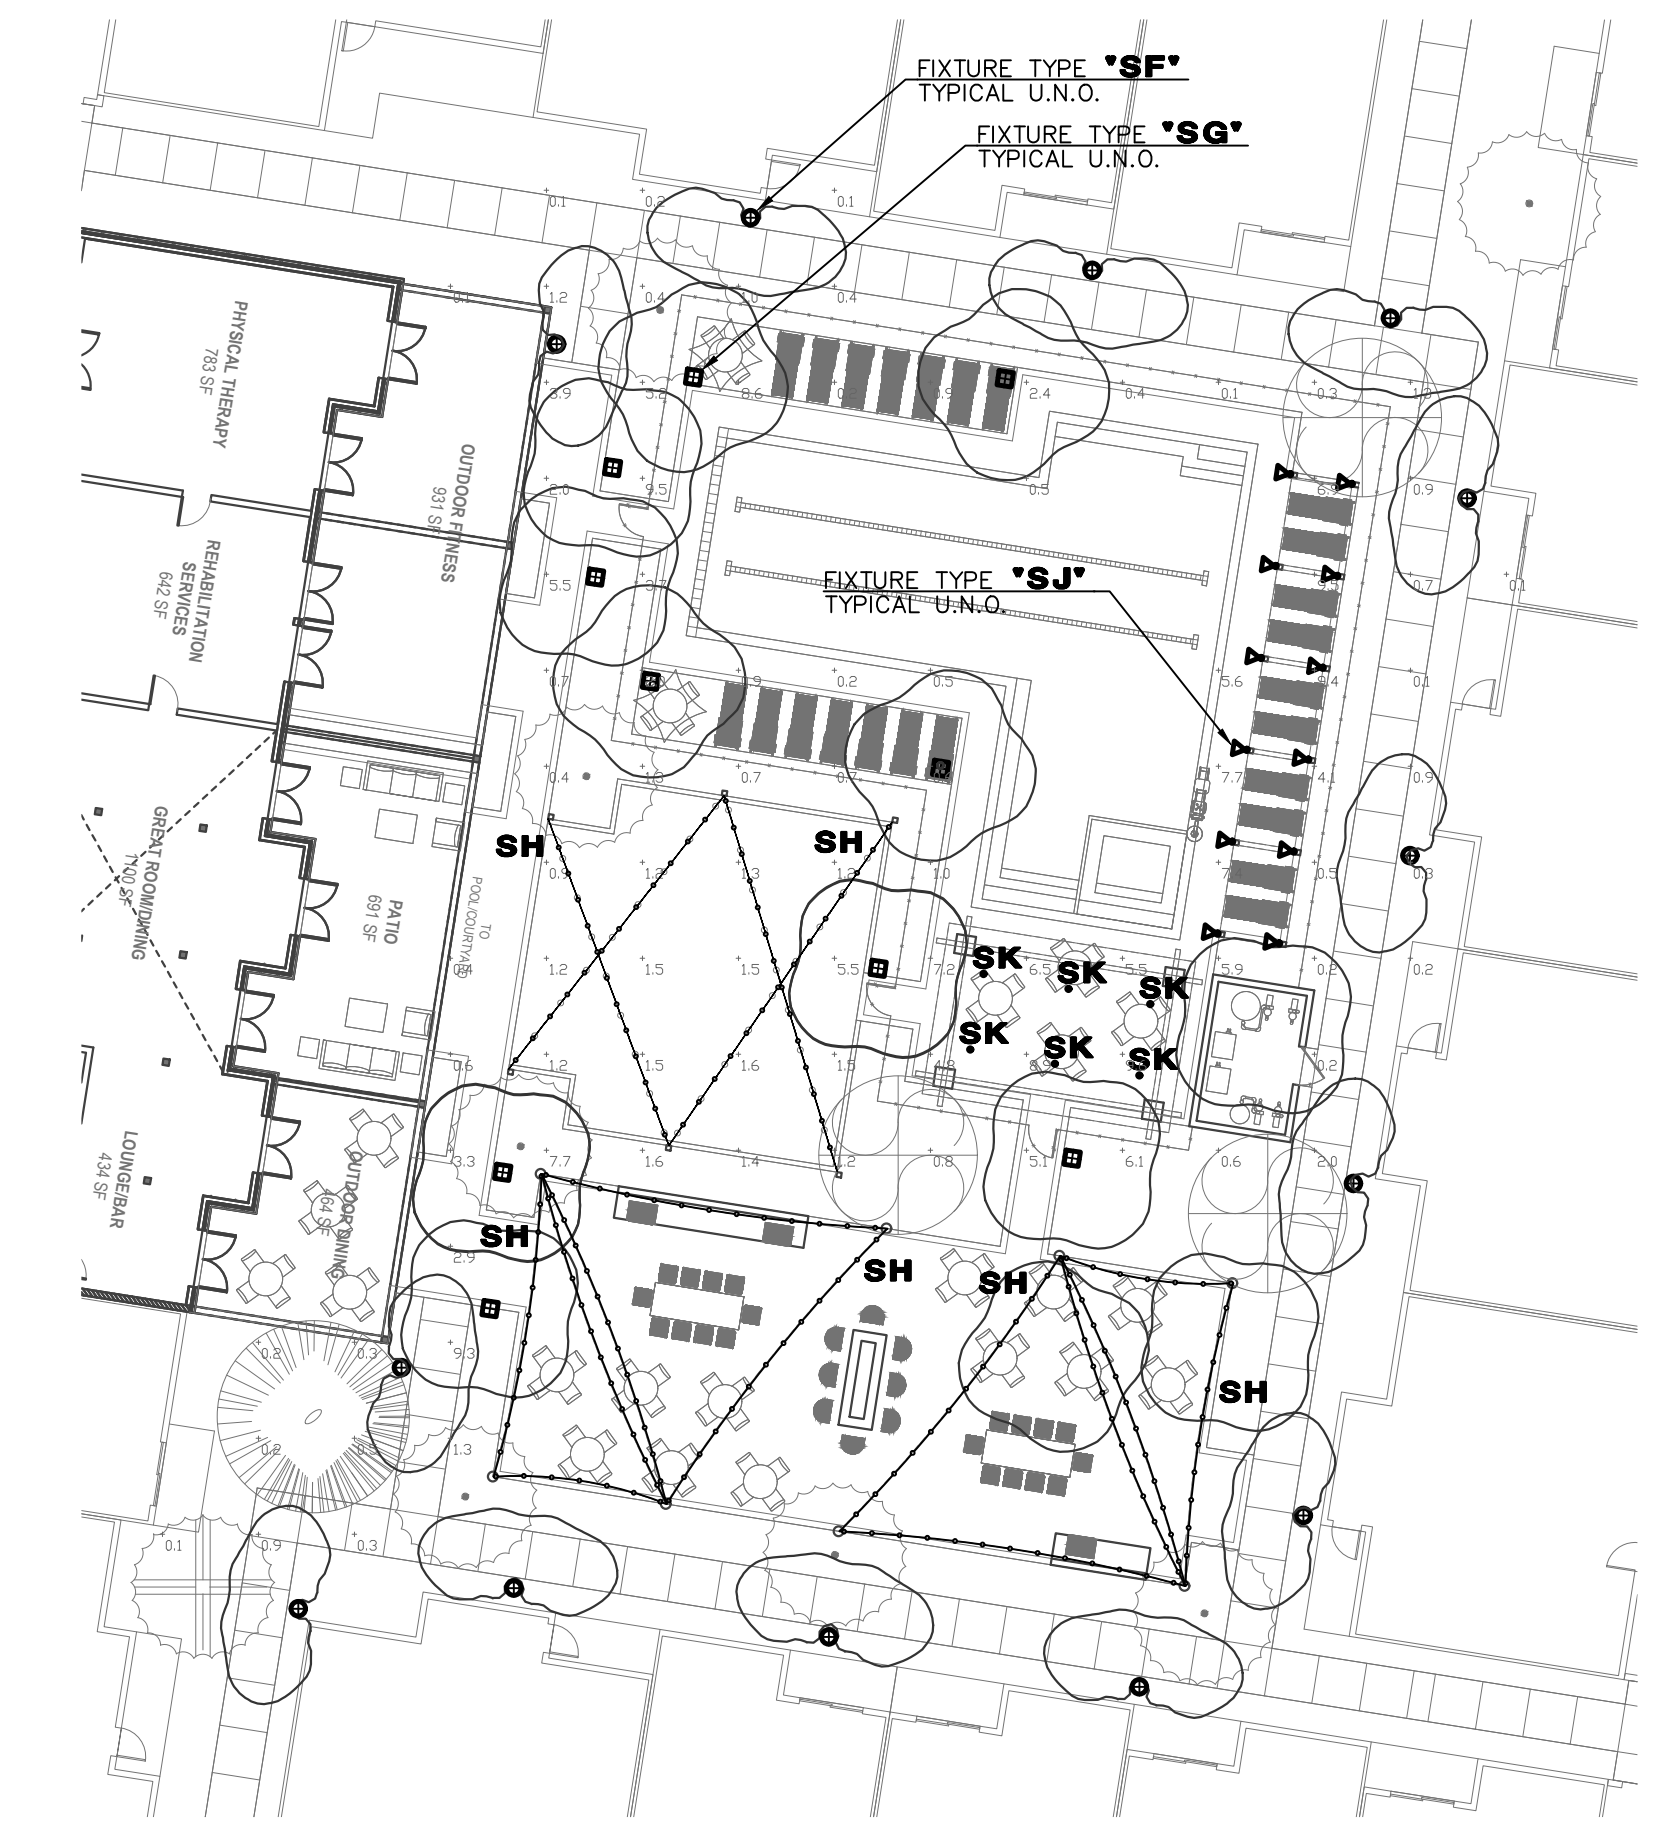

ENLARGED POOL AREA LIGHTING PLAN
SCALE: 1" = 20'-0"

Schedule									
Symbol	Label	QTY	Manufacturer	Catalog	Description	Number Lamps	Lamp Output	LLF	Input Power
SA	SA	36	Luminaire LED	VPF4 2FT 15W 30K DP	Luminaire LED Vandal Resistant Luminaire. Cat No:VPF4 2FT 15W 3000K CP	1	2303	0.95	15
SB	SB	11	ANP LIGHTING	LA072-1-WH-P046LD4D T3 30K (FINISH)/ SSS POLE AT 12"	POST TOP LUMINAIRE SIZE: 16"L X 16"W X 25"H.	1	3617	0.95	46.67
SC	SC	10	ANP LIGHTING	LA072-1-WH-P046LD4D T5 30K (FINISH)/ SSS POLE AT 12"	POST TOP LUMINAIRE SIZE: 16"L X 16"W X 25"H.	1	3939	0.95	46.67
SD	SD	10	ANP LIGHTING	LA071-3-WH-M016LDD W 30K WMS133 (FINISH)	PENDANT MOUNT WALL LIGHT	1	3939	0.95	16
SF	SF	24	Selux Corporation	IBL-4-2Q90MU-30-(FINISH)-UNV-LP-DM	LED BOLLARD PATH	1	798	0.95	14.1
SG	SG	10	SELUX Corporation	IBL-4-4QS-30-(FINISH)-UNV-LP-DM	Cast gray aluminum housing, clear plastic enclosure	1	2101	0.95	27.19
SH	SH	317	TOKISTAR	EXBK 18 UBLW G19 F7 EX-MDA-BK TRANSFORMER AS REQUIRED	LED FESTOON "STRING" LIGHTING	1	50	0.95	1.8
SJ	SJ	12	HK LIGHTING GROUP	ZXL161-CPV-WM A UNV 5 57 010 (FINISH)	Almable LED wall mount	1	869	0.95	5
SK	SK	6	ALW	CRM6/WL 07 83 30 80DF N V10 L (FINISH)	CDRE Wet Location cylinder downlight.	1	705	0.95	5.6

Statistics						
Description	Symbol	Avg	Max	Min	Max/Min	Avg/Min
FC DN SITE AT GRADE ±		0.7 f.c.	9.6 f.c.	0.0 f.c.	N/A	N/A

PRELIMINARY NOT FOR CONSTRUCTION

DESIGN CODES
IECC, 2015 NEC, 2014

ELECTRICAL CONTRACTOR SHALL NOTIFY DESIGNER/ENGINEER PRIOR TO ANY DEVIATION FROM THIS SET OF ELECTRICAL DESIGN PLANS. ANY CHANGES TO THE DESIGN, IF APPROVED BY ENGINEER, WILL REQUIRE REVISIONS TO PLANS AND POSSIBLE ADDITIONAL SERVICE FEE.

IF DRAWING IS NOT PLOTTED AT 24 X 36 THEY ARE NOT FULL SIZE