


# GRAYHAWK RESIDENCES AT CAVASSON


7701 E. LEGACY BOULEVARD  
SCOTTSDALE, AZ 85255



WorldHQ@ORBArch.com

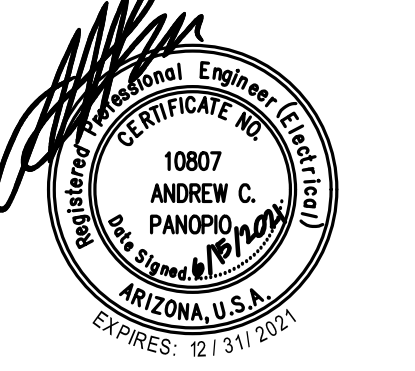


**NP** ENGINEERING INC.  
4115 N. 15TH AVE  
PHOENIX, AZ 85015  
(602) 265-1558  
PROJECT NO. 2020-158

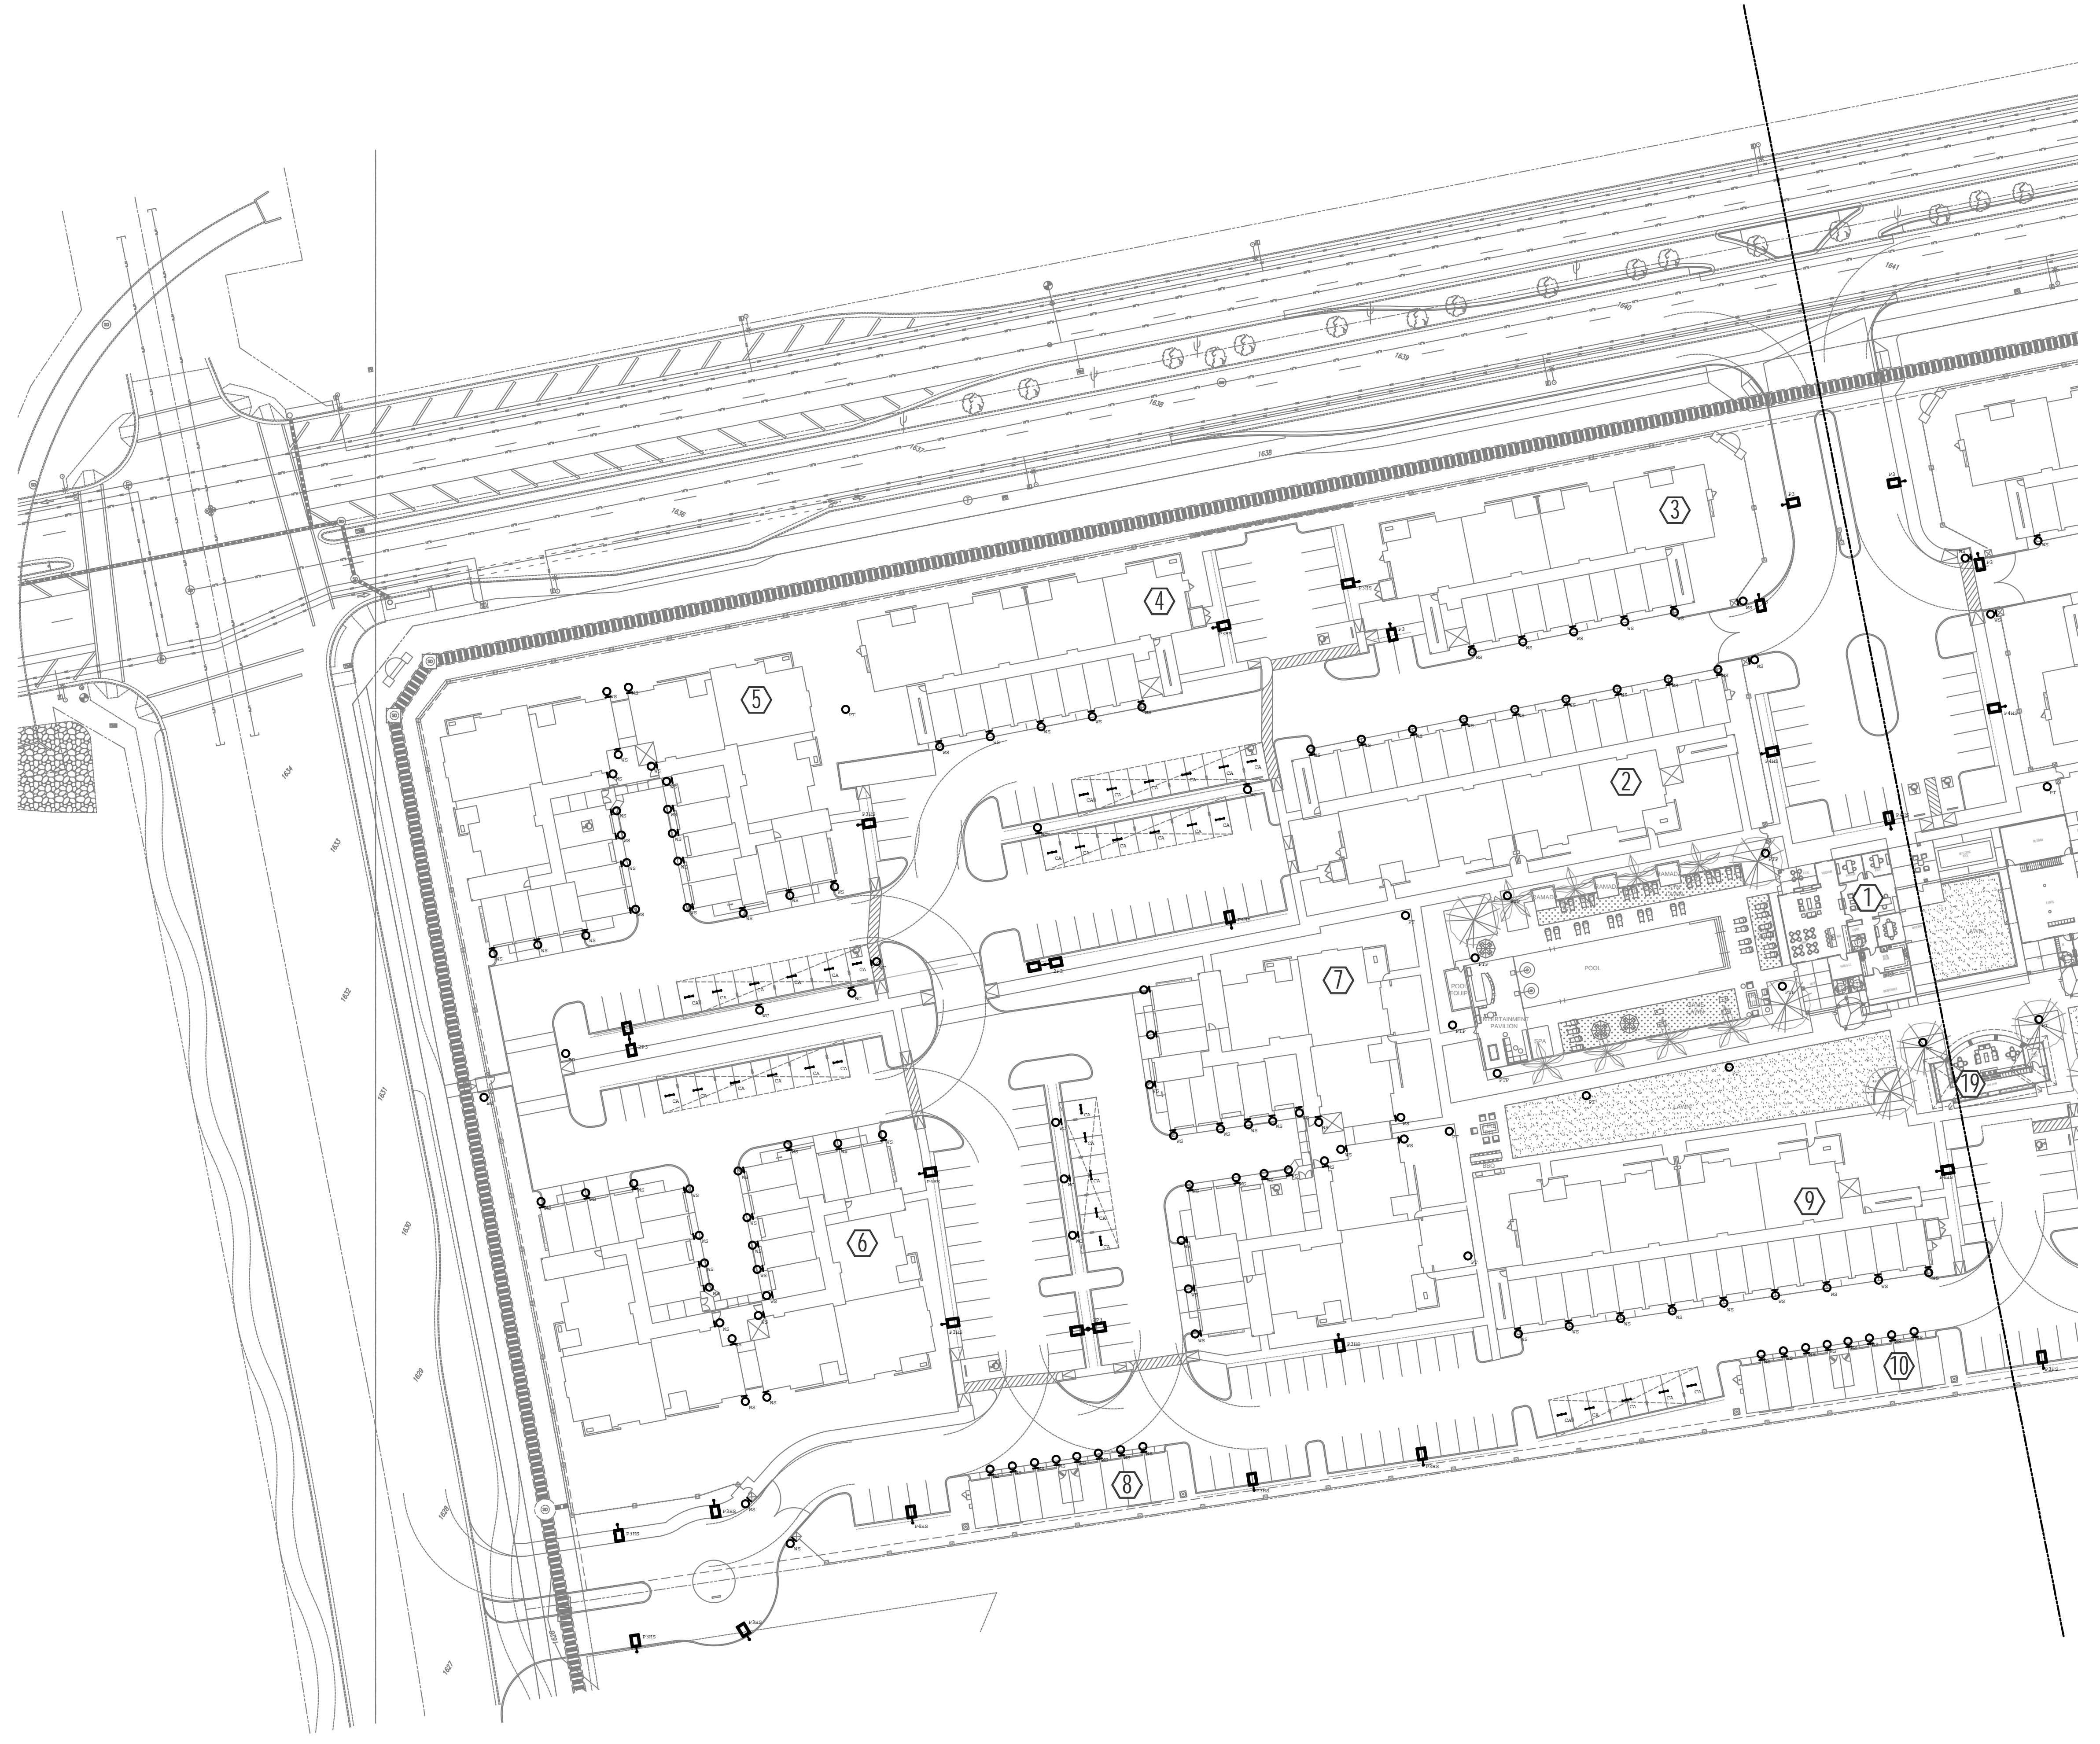

## ELECTRICAL SITE LIGHTING PLAN

0' 20' 40' 80'  
SCALE: 1" = 40'-0"

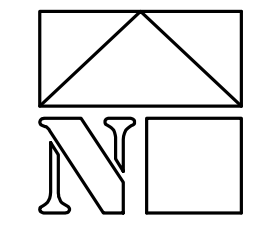

### REVISIONS

|  |  |
|--|--|
|  |  |
|  |  |
### DRB SUBMITTAL

DATE: JUNE 16, 2021 ORB # 20-204

# E1.1A



ELECTRICAL SITE  
LIGHTING PLAN



FILE: W:\2021-100 DWGS\2021-158 - Cavasson Residences\ELEC\2021-158-E1.dwg USER: jfy DATE: Jun 15 2021 TIME: 05:34 pm



### ELECTRICAL SITE LIGHTING PLAN

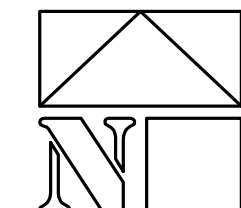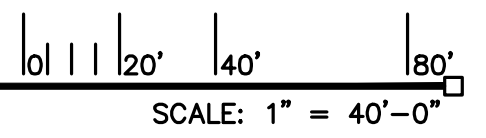


## GRAYHAWK RESIDENCES AT CAVASSON

7701 E. LEGACY BOULEVARD  
SCOTTSDALE, AZ 85255



WorldHQ@ORBArch.com

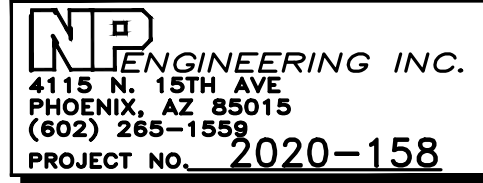

### REVISIONS

|  |  |
|--|--|
|  |  |
|  |  |
### DRB SUBMITTAL

DATE: JUNE 16, 2021 ORB # 20-204

## E1.1B

ELECTRICAL SITE  
LIGHTING PLAN